

FRONT ELEVATION



REAR ELEVATION

1122 Bales Rd.

Kahle Design & Build	
Defiance, Oh	Phone 437-4805
Scale: Var. 1/8"	Date 01/19/02
Mr. & Mrs. M. Lanzetta	
Location: Chelsea Condominium	






RIGHT ELEVATION 4" Vinyl Siding



4" Vinyl Siding 5 1/2" Box Window 6" Wood Siding


LEFT ELEVATION

<i>Kahle Design &amp; Build</i>	
Defiance, Oh	Phone 437-4805
Scale: 1/8"=1'-0"	Date 01/19/02
Chelsea Condominium	
Location: Bales Rd. Napoleon	

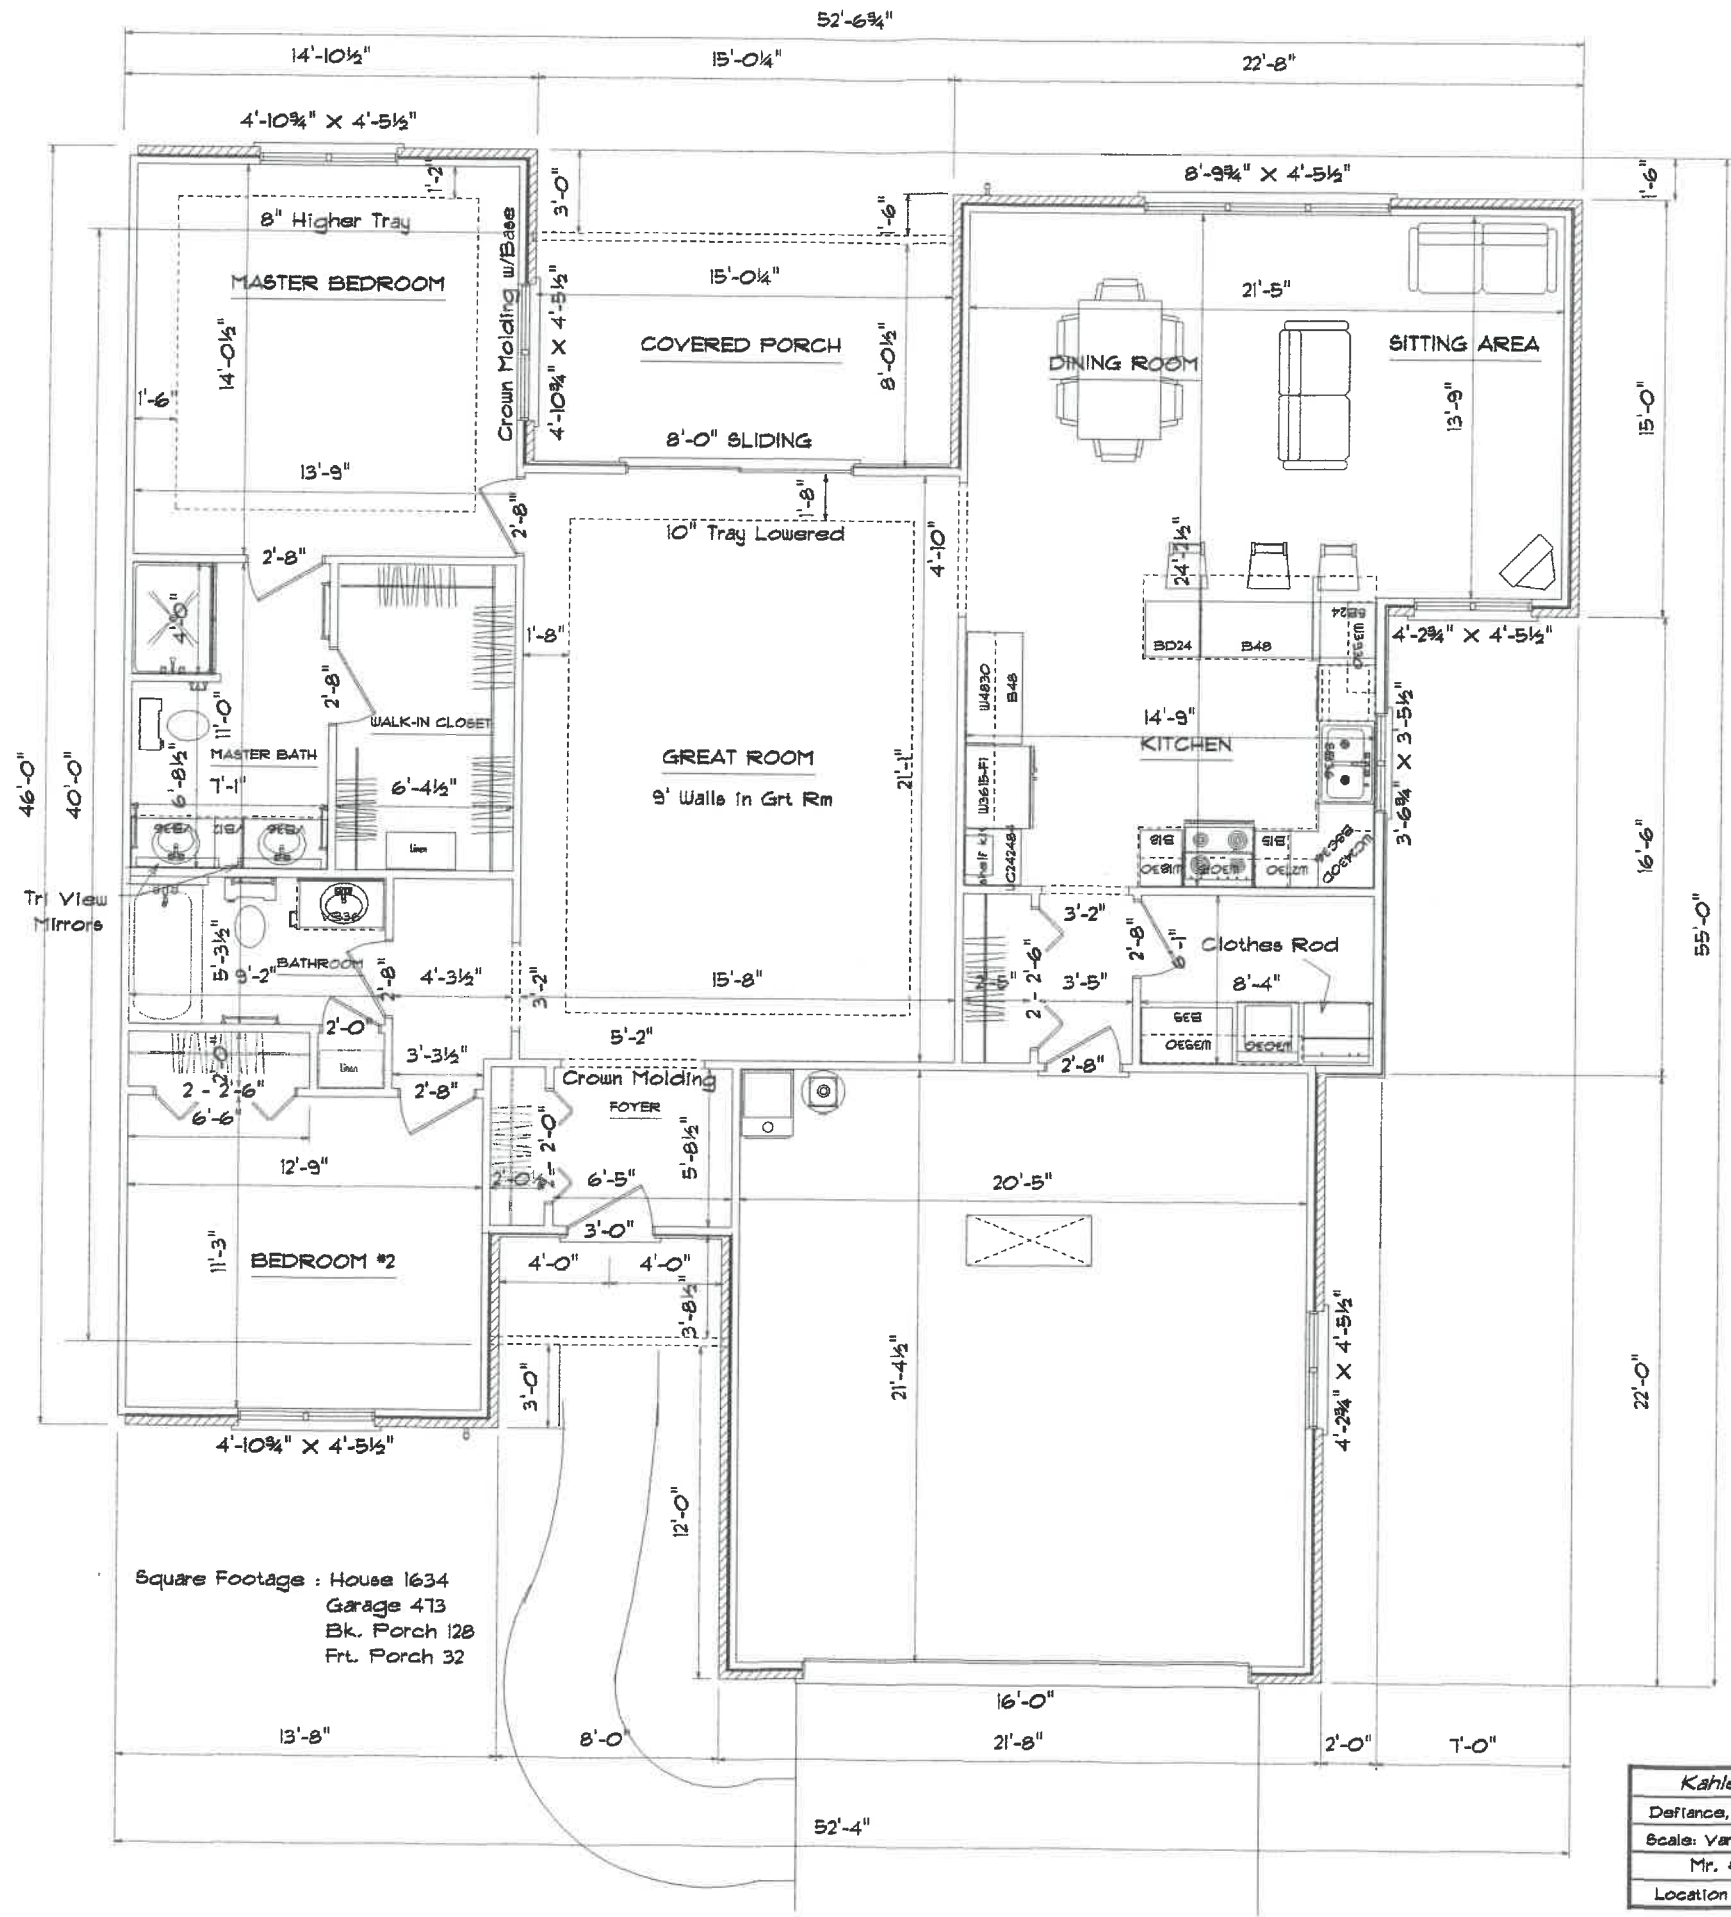

Square Footage : House 1634  
 Garage 473  
 Bk. Porch 128  
 Frt. Porch 32

<b>Kahle Design &amp; Build</b>	
Defiance, Oh	Phone 437-4805
Scale: Var.'@'0"	Date 01/12/02
Mr. & Mrs. Marvin Lanzer	
Location : Bales Rd. Napoleon	

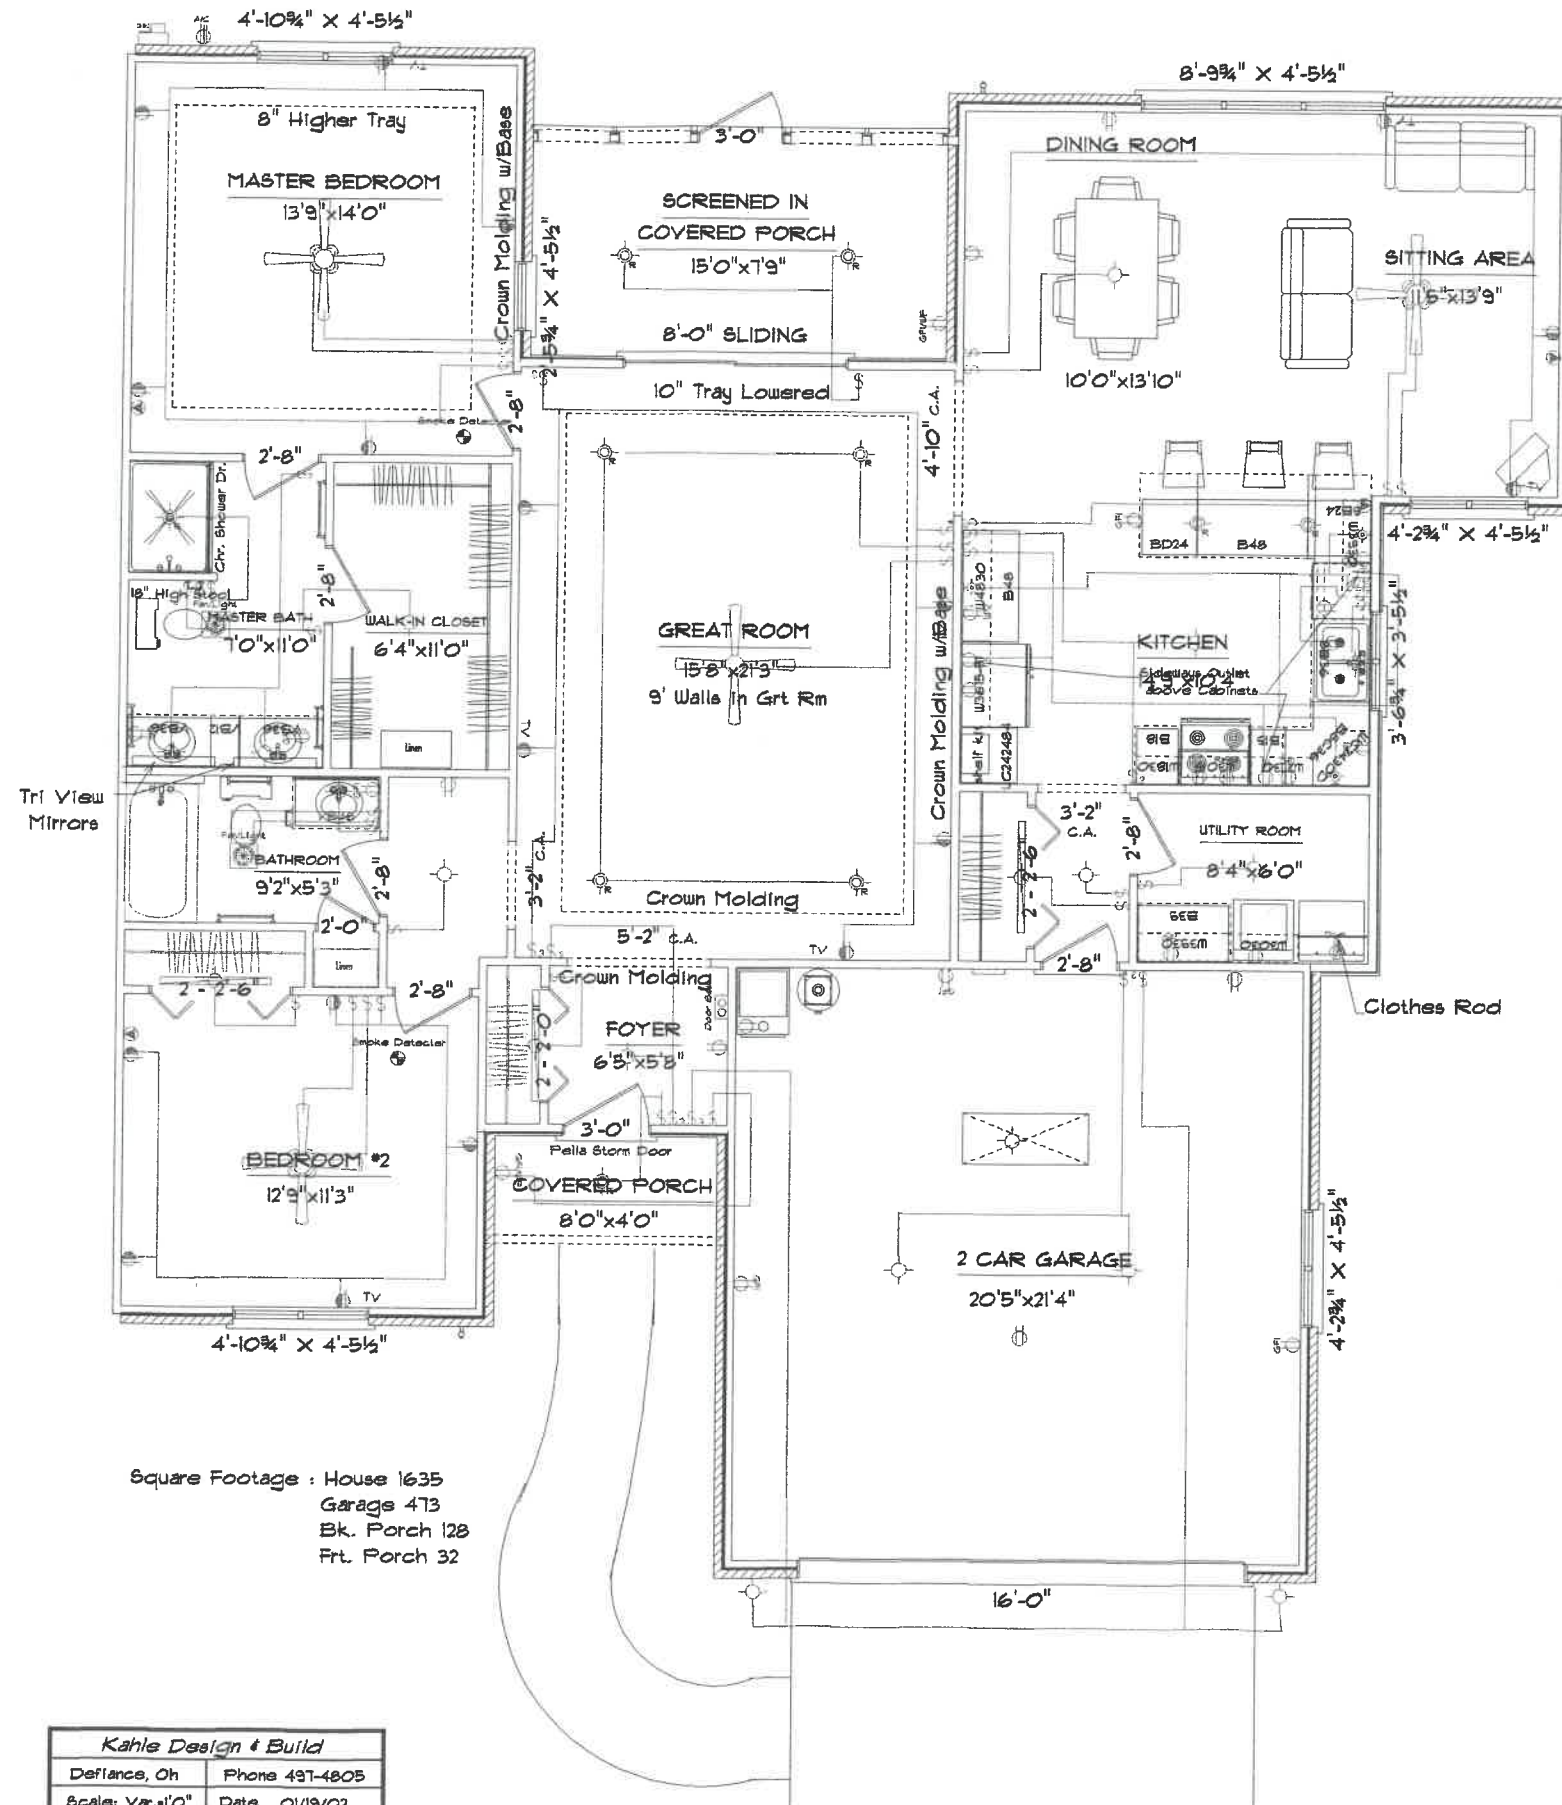


Square Footage : House 1635  
 Garage 473  
 Bk. Porch 128  
 Frt. Porch 32

Kahle Design & Build	
Defiance, Oh	Phone 497-4805
Scale: Var. 1/8"	Date 01/19/02
Mr. & Mrs. Marvin Lanzer	
Location: Bales Rd. Napoleon	

ELECTRICAL PLAN




102'-11 1/2"

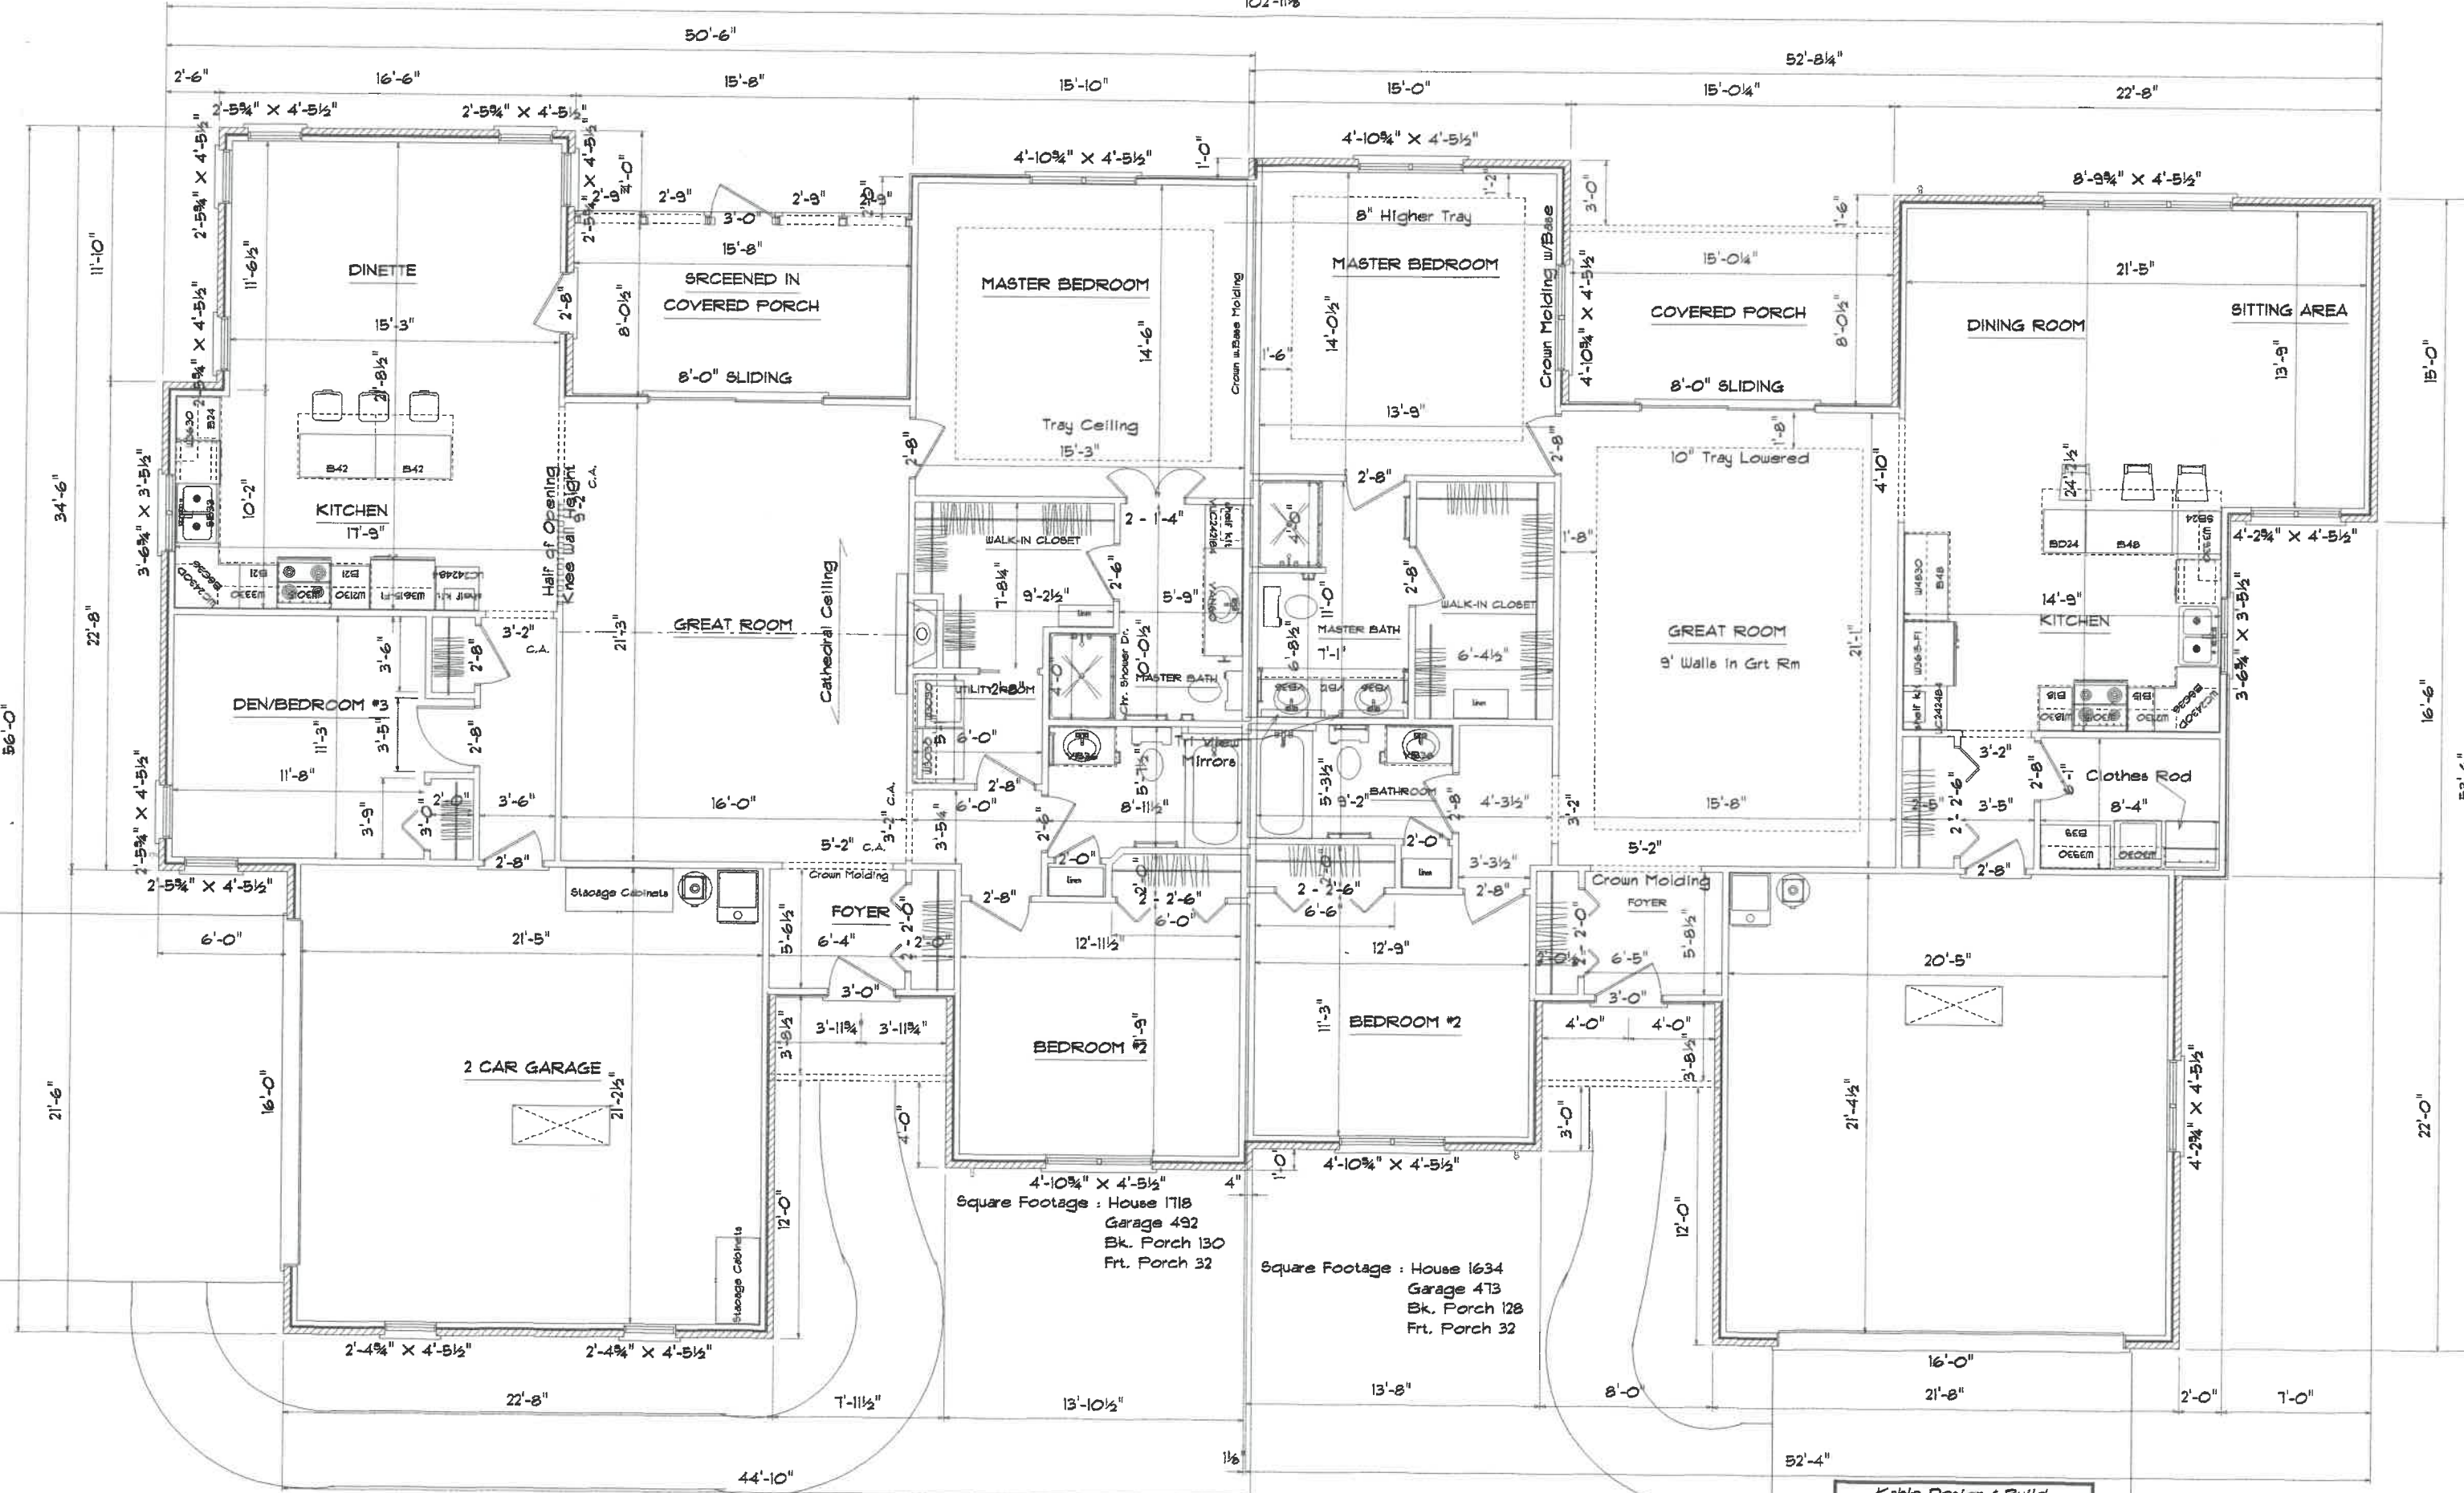

Square Footage : House 1718  
 Garage 492  
 Bk. Porch 130  
 Frt. Porch 32

Square Footage : House 1634  
 Garage 473  
 Bk. Porch 128  
 Frt. Porch 32


Kahle Design & Build	
Defiance, Oh	Phone 497-4805
Scale: Var. 1/8"	Date 01/12/02
Mr. & Mrs. Marvin Lanzer	
Location : Bates Rd. Napoleon	

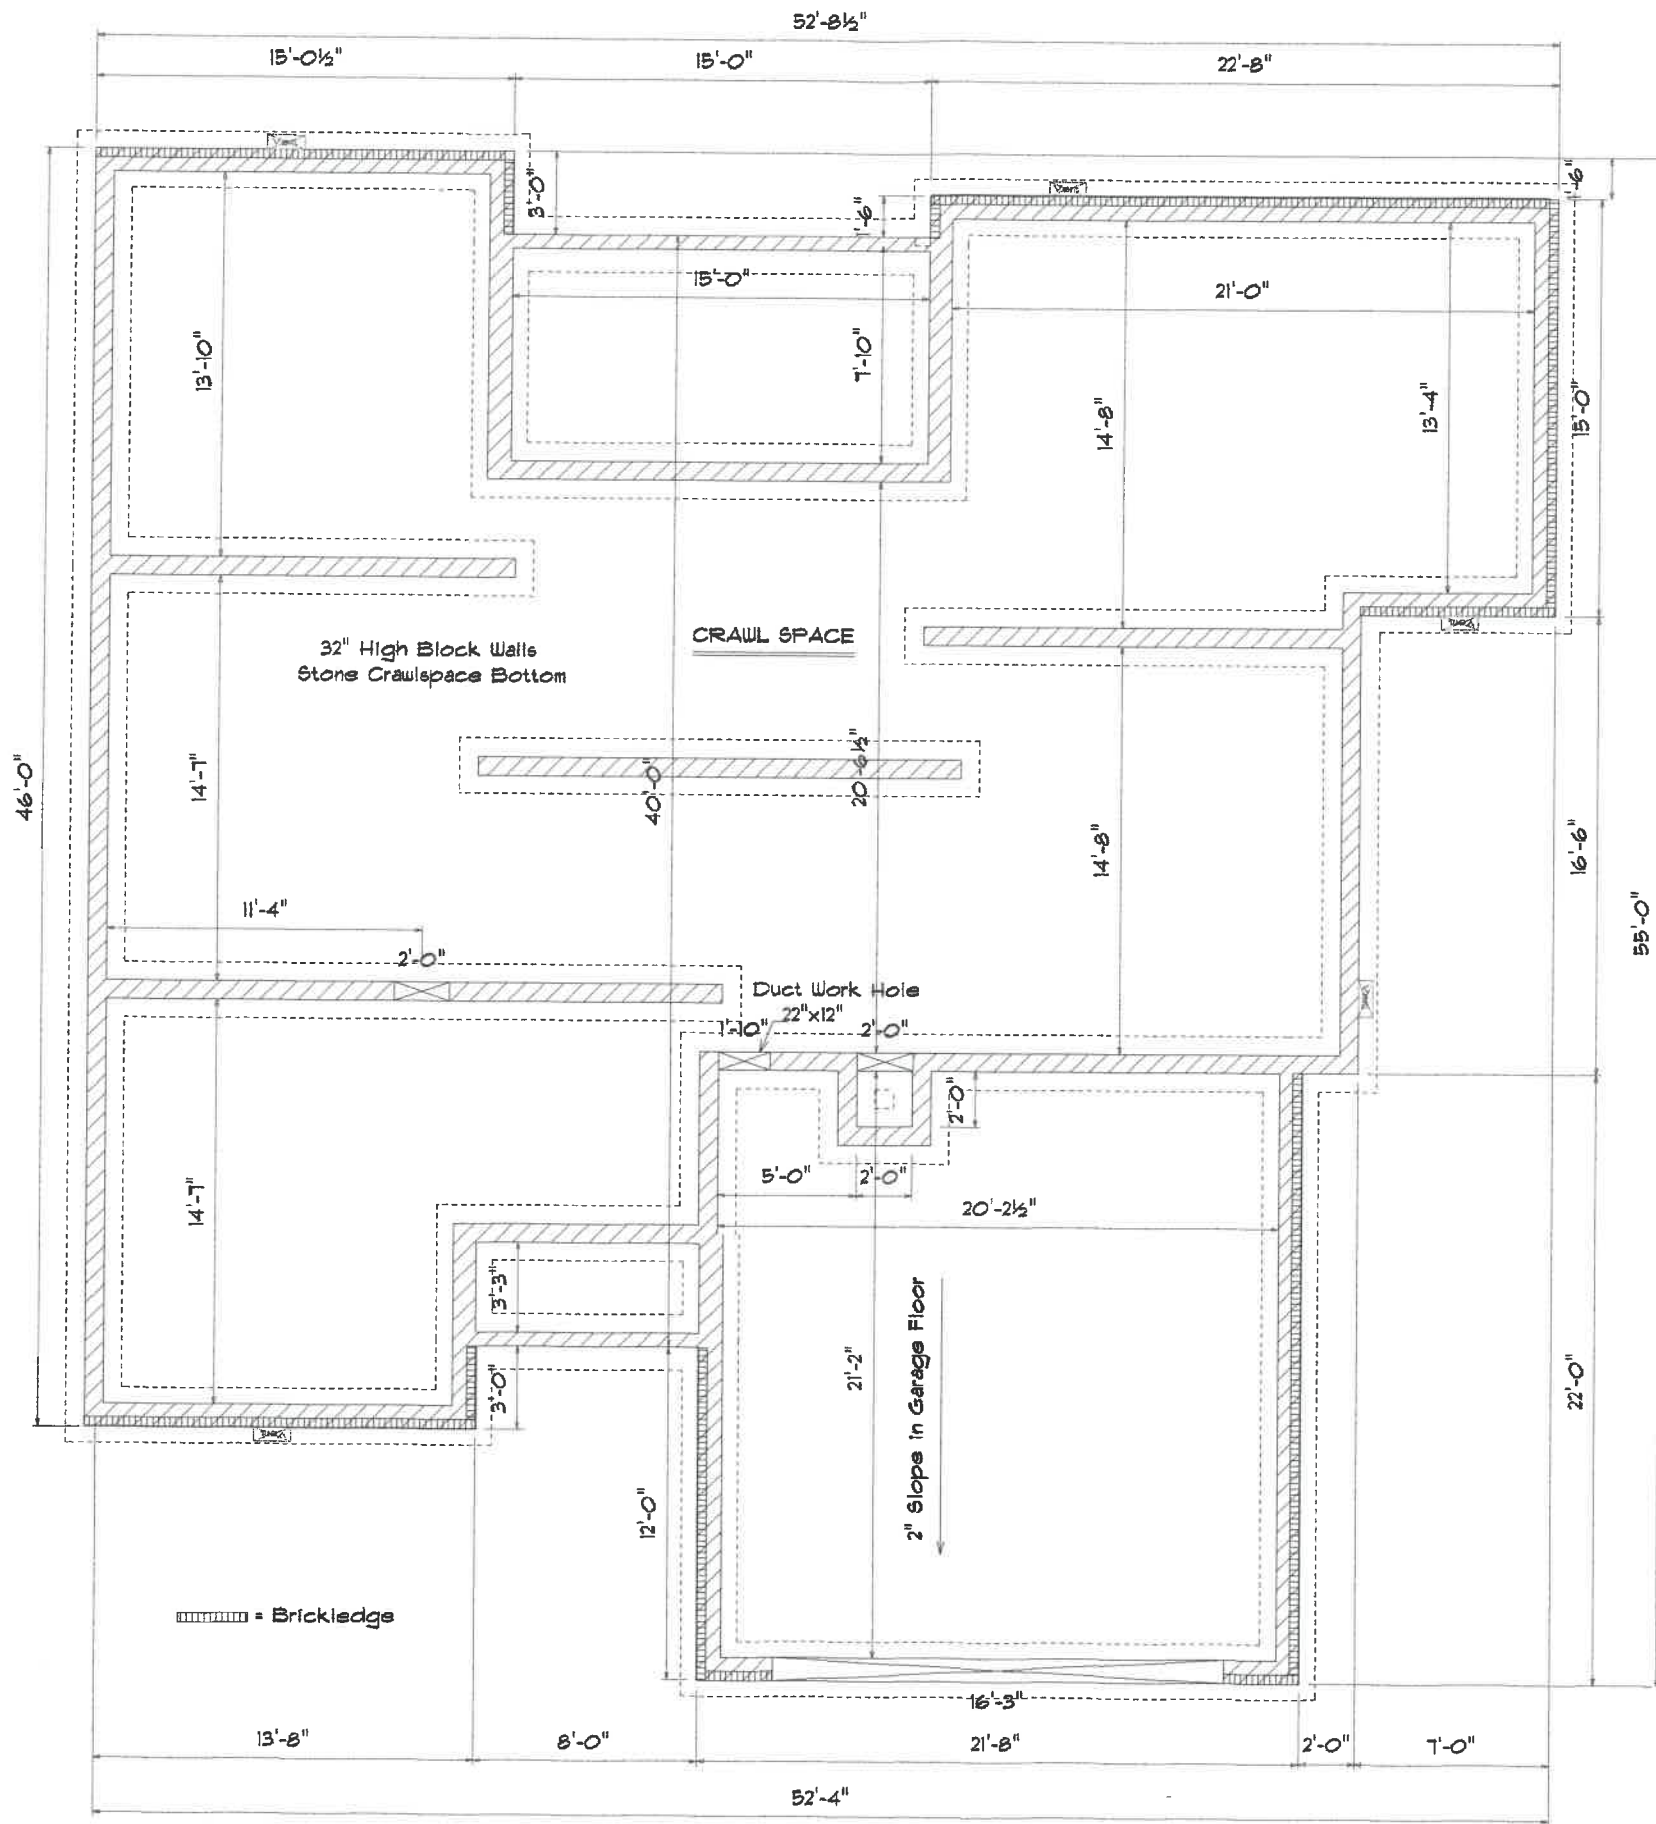

**FOUNDATION PLAN**


Kahle Design & Build	
Defiance, Oh	Phone 497-4805
Scale: Var. 1/4" = 1'-0"	Date: 01/12/02
Mr. & Mrs. Marvin Lanzer	
Location: Bales Rd. Napoleon	



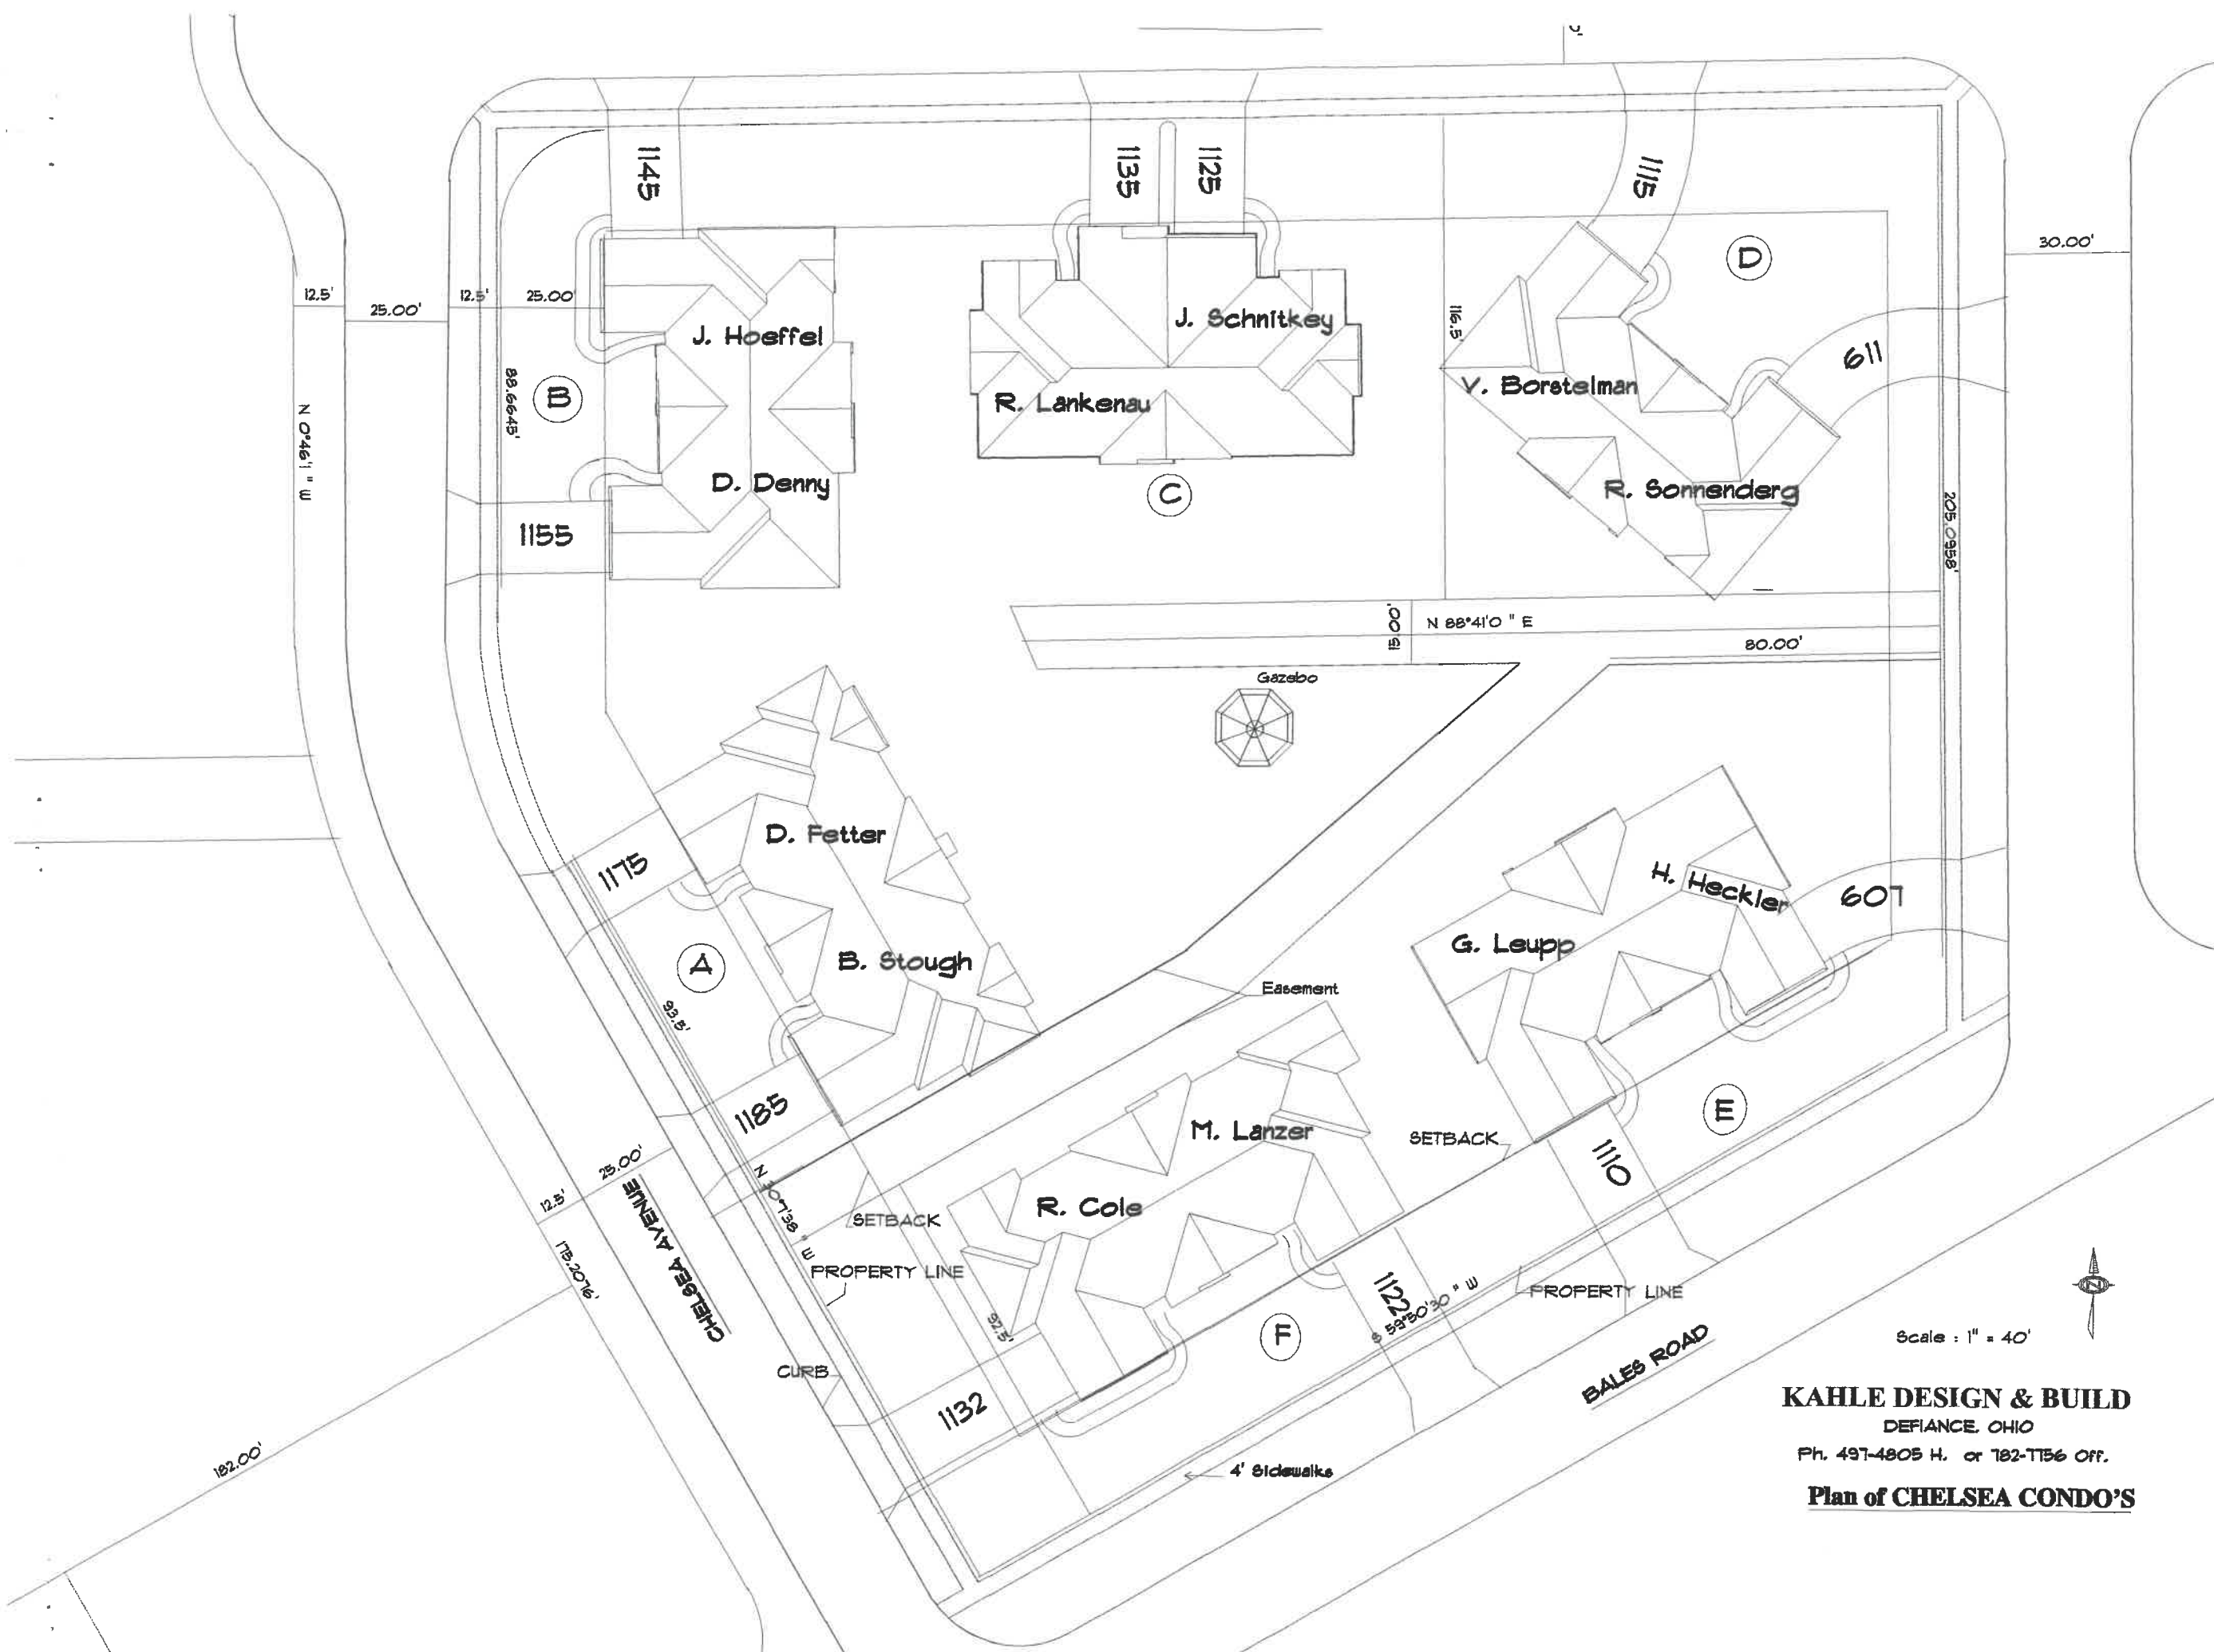

Scale : 1" = 40'

**KAHLE DESIGN & BUILD**  
 DEFIANCE, OHIO  
 Ph. 497-4805 H. or 782-7756 Off.  
**Plan of CHELSEA CONDO'S**

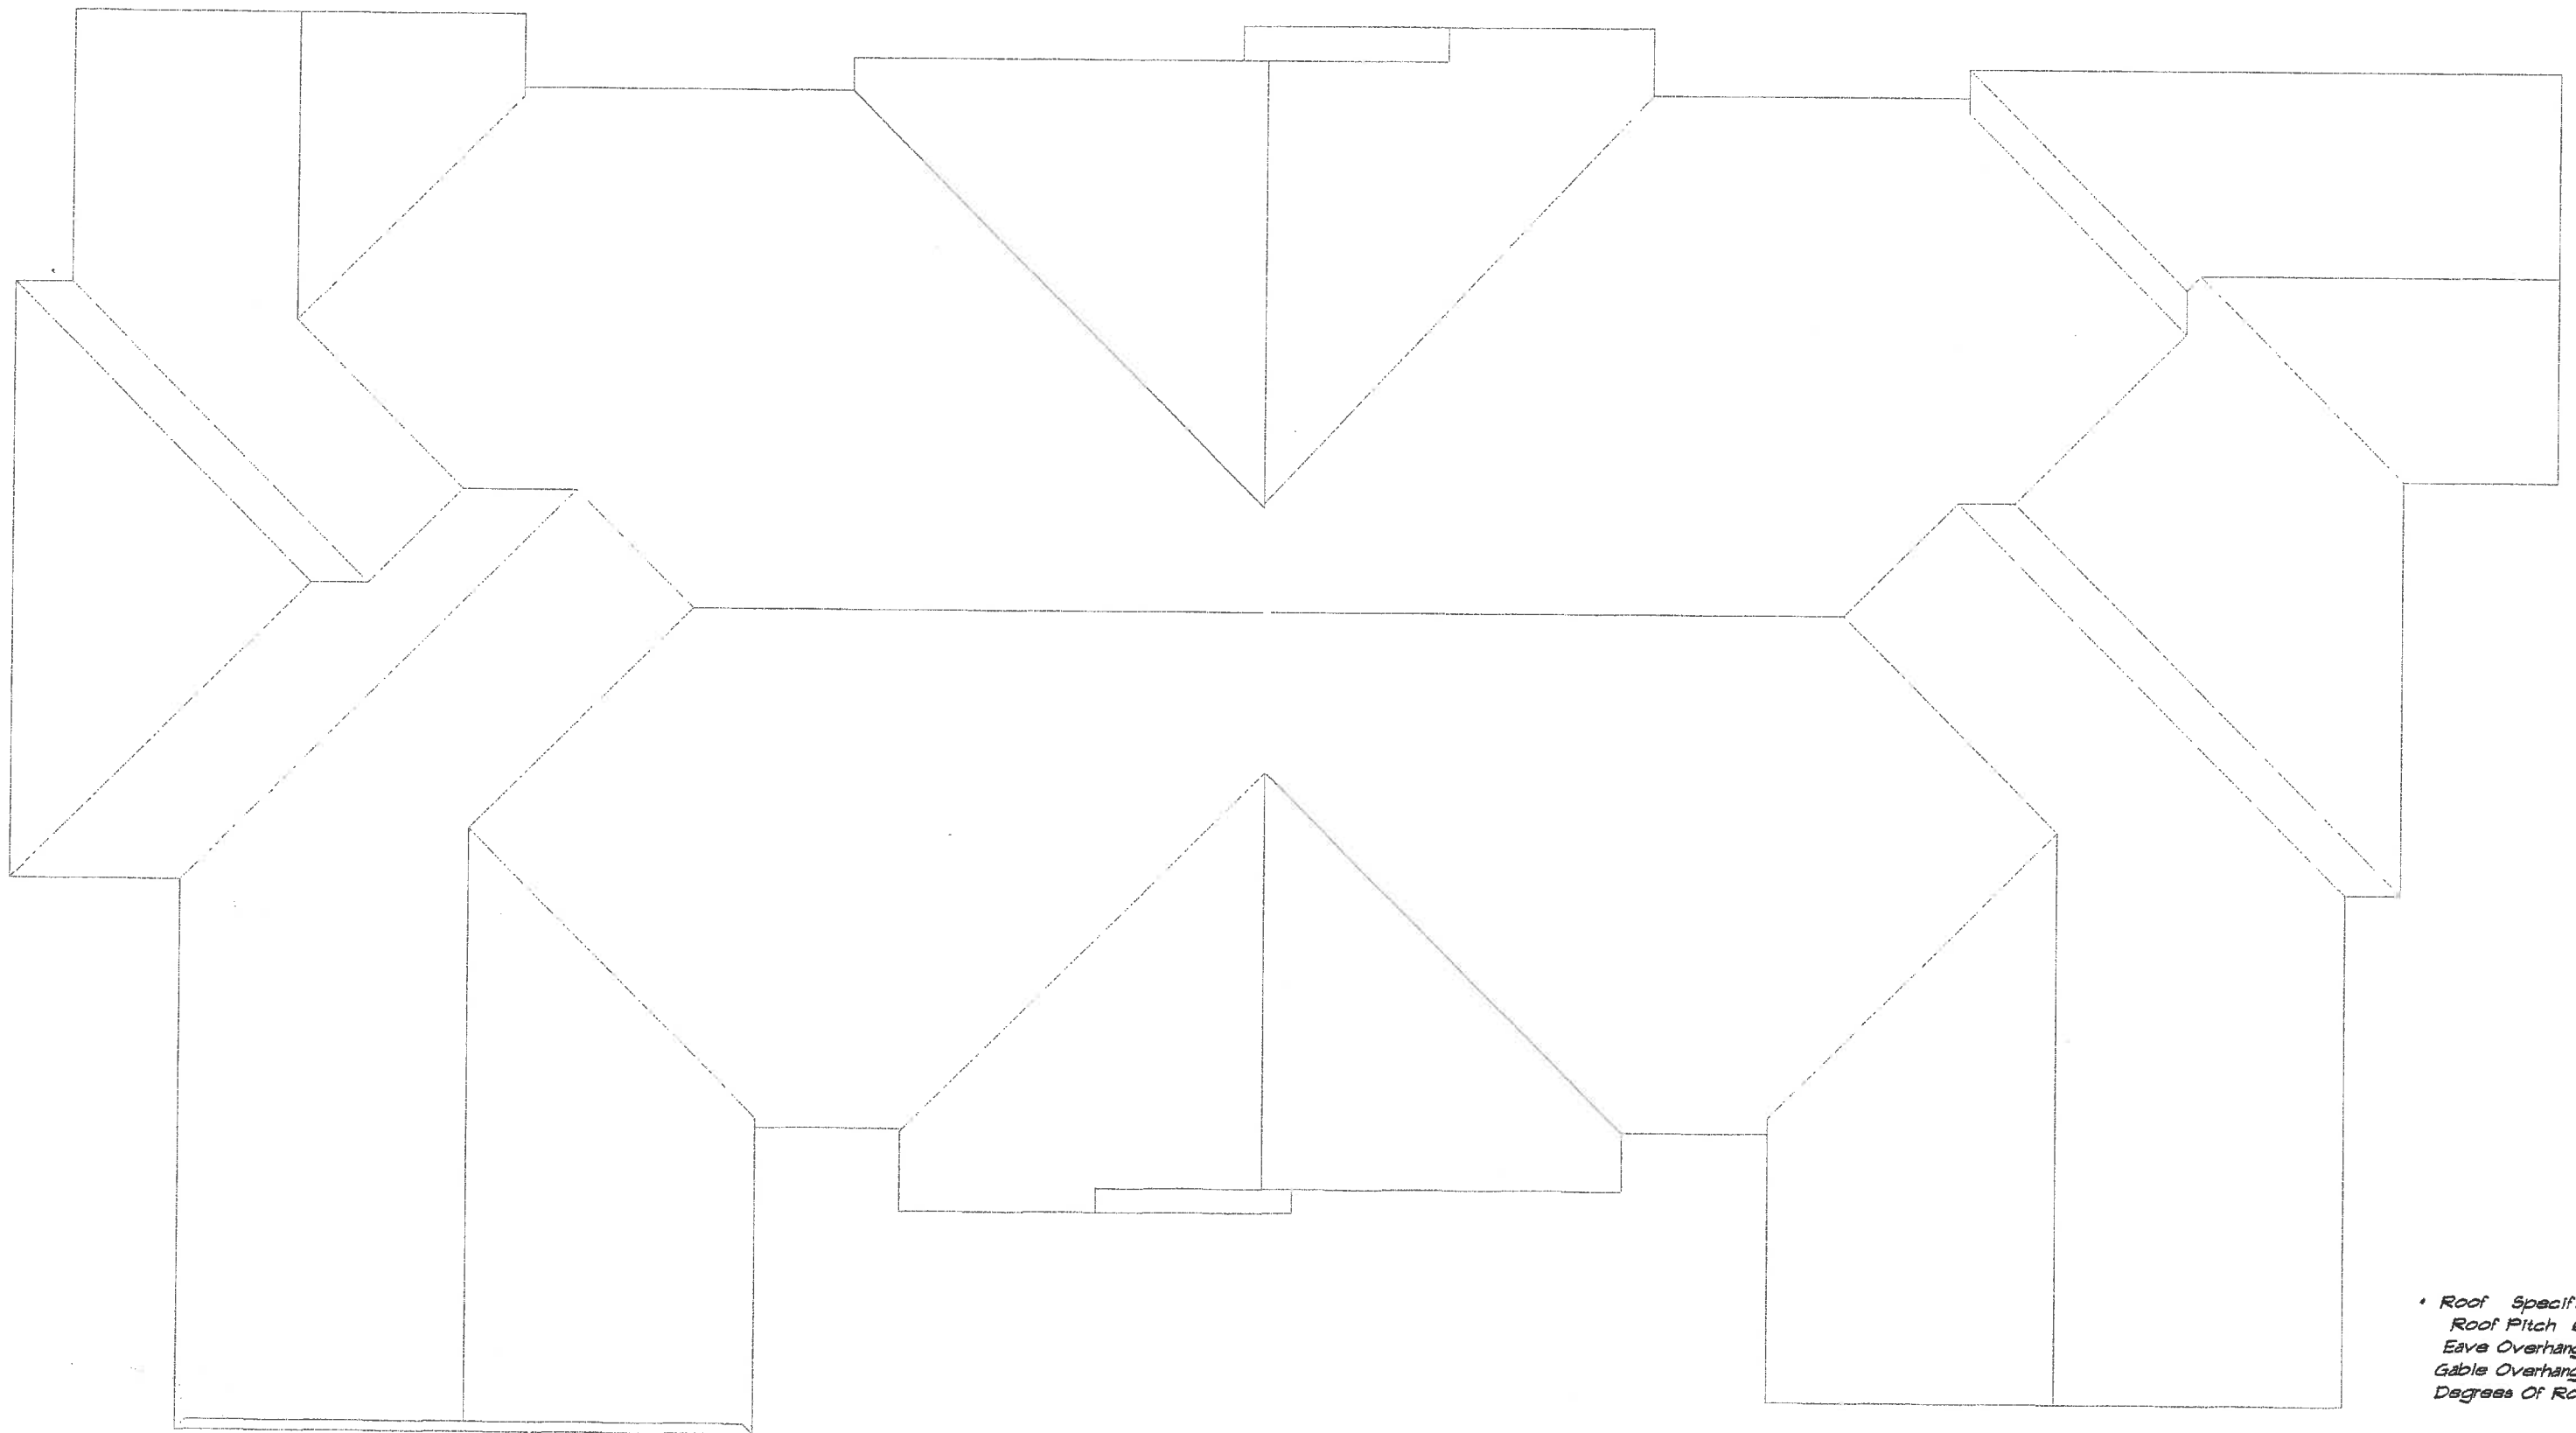

• Roof Specification •  
Roof Pitch 6/12  
Eave Overhang 18"  
Gable Overhang 8"  
Degrees Of Roof 26.5