




FRONT ELEVATION

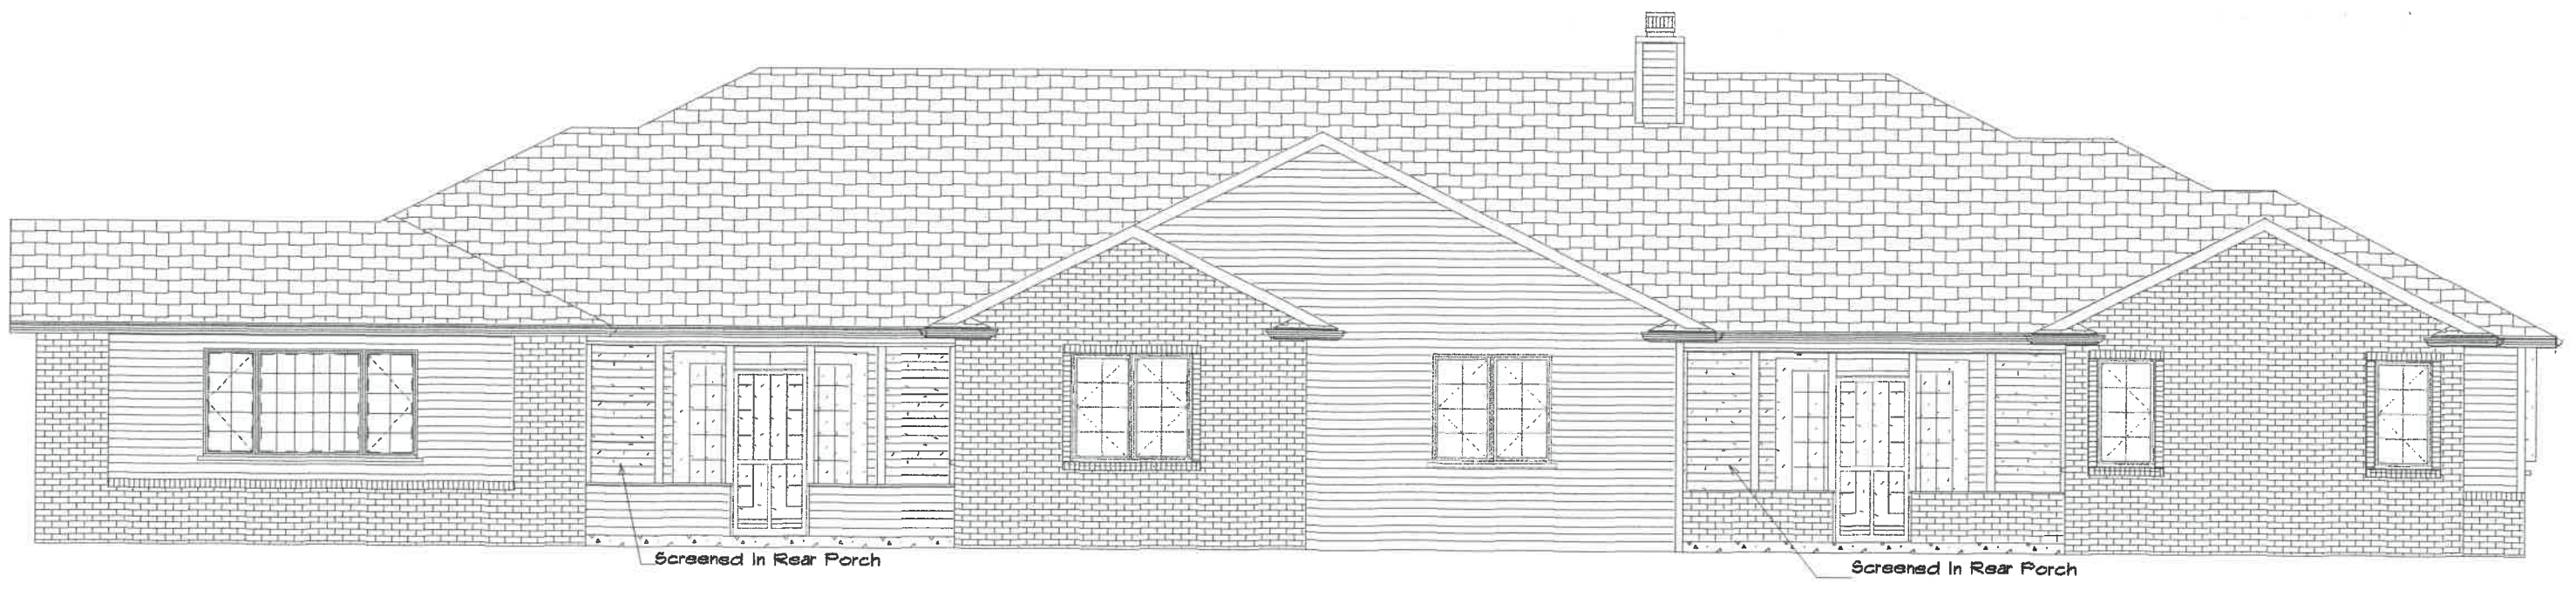

REAR ELEVATION

1132 Boles Rd

| | |
|-------------------------------|----------------|
| Kahle Design & Build | |
| Defiance, Oh | Phone 437-4805 |
| Scale: Var: 1/8" | Date 01/19/02 |
| Ms. Ross Marie Cole | |
| Location: Chelsea Condominium | |




RIGHT ELEVATION 4" Vinyl Siding



4" Vinyl Siding 5 1/2" Box Window 6" Wood Siding


LEFT ELEVATION

| | |
|---------------------------------|----------------|
| <i>Kahle Design & Build</i> | |
| Defiance, Oh | Phone 437-4805 |
| Scale: Var. 1/8" | Date 01/19/02 |
| Chelsea Condominium | |
| Location: Sales Rd. Napoleon | |

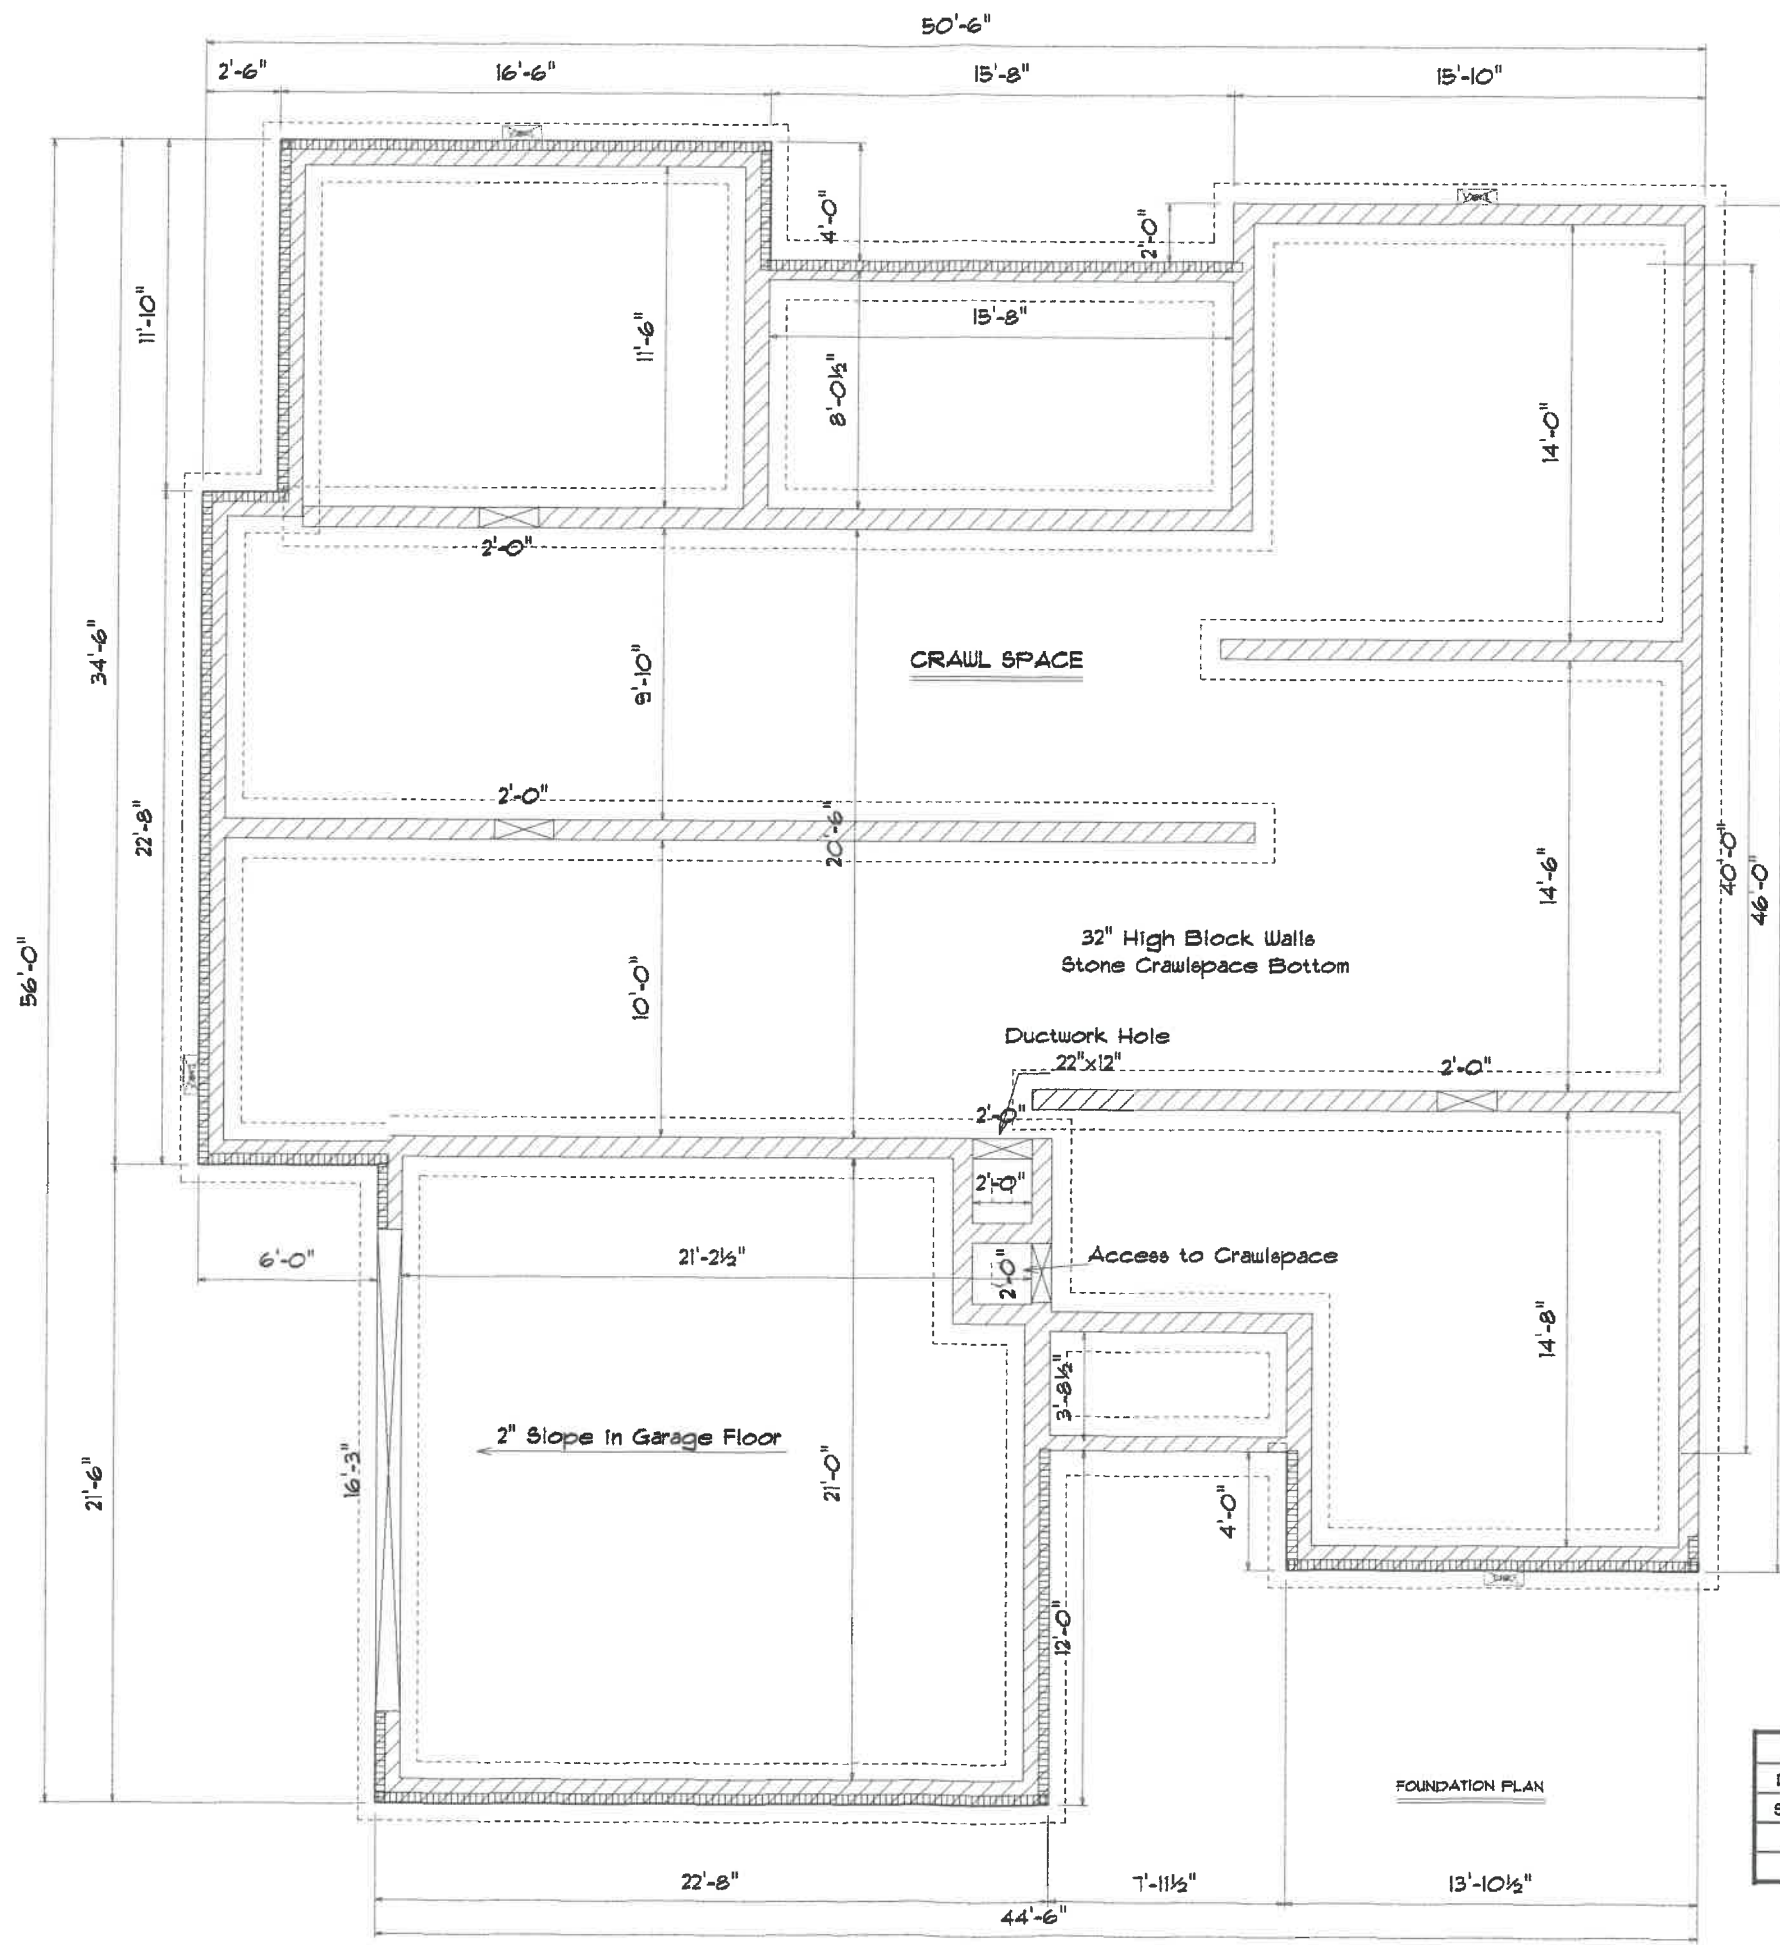


▤ = Brickledge

| | |
|------------------------------|----------------|
| Kahle Design & Build | |
| Defiance, Oh | Phone 497-4805 |
| Scale: Var. 1/8" = 1'-0" | Date 01/19/02 |
| Ms. R. Cole | |
| Location: Bales Rd. Napoleon | |

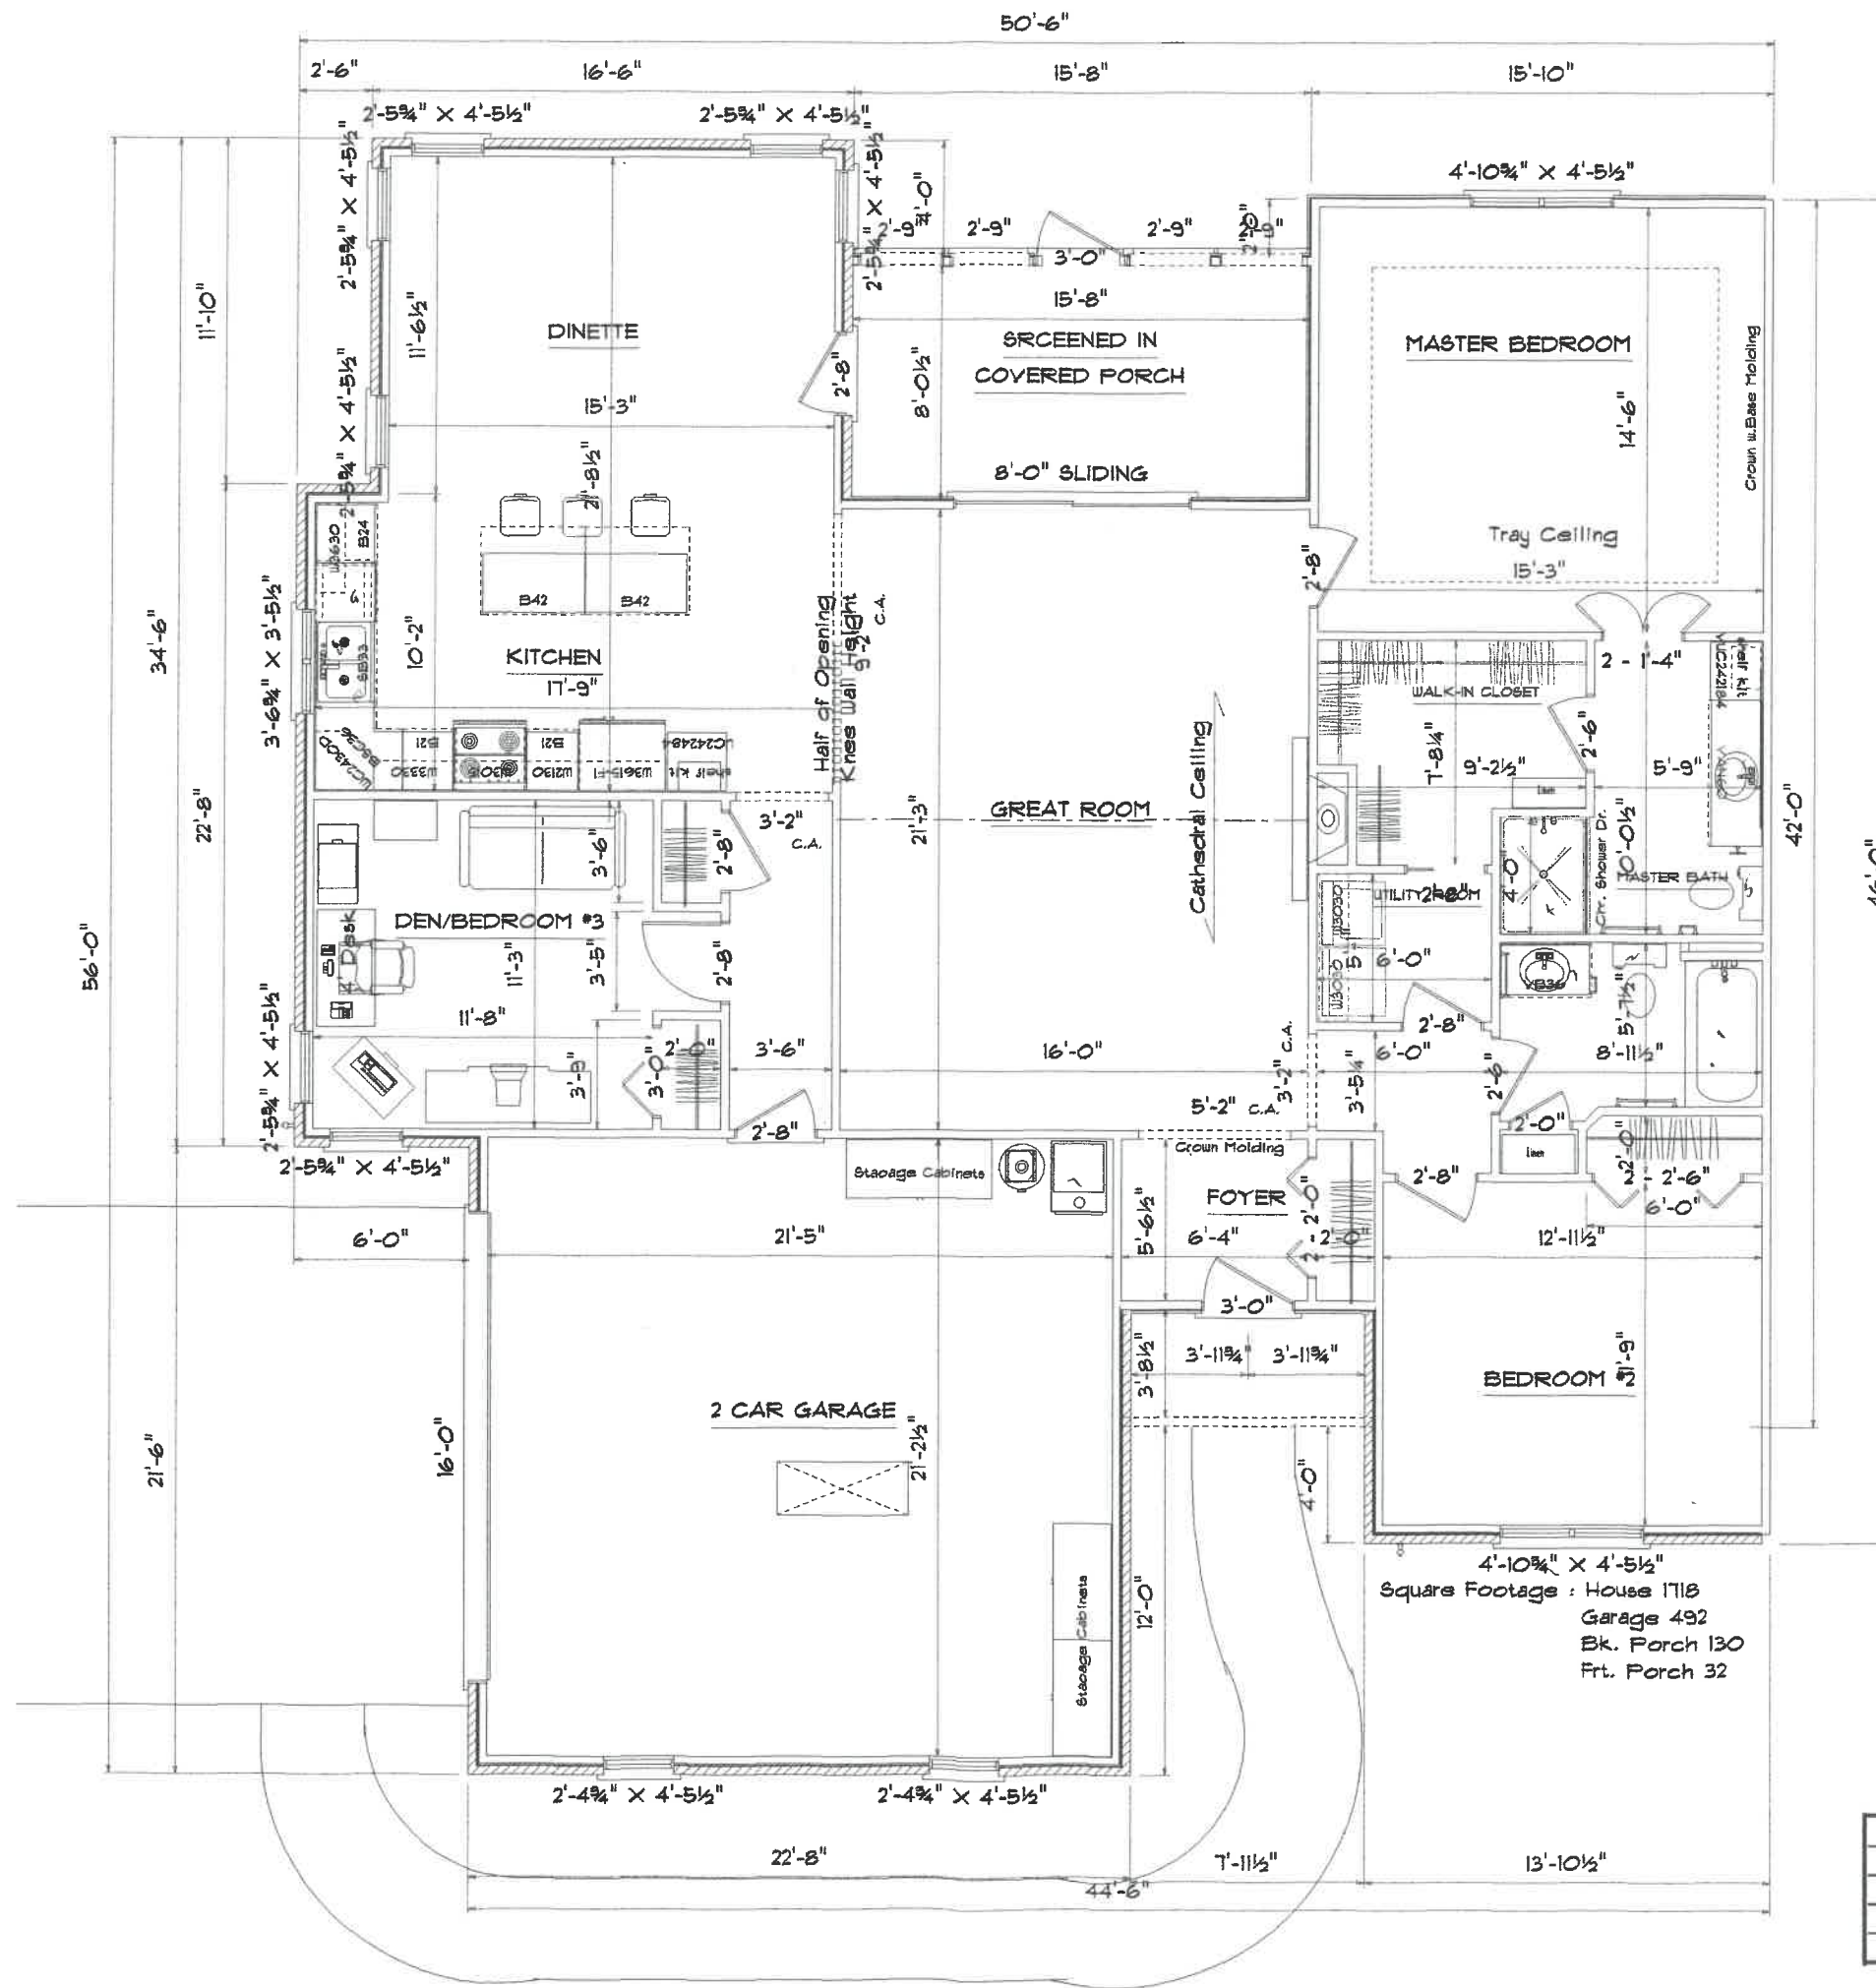

4'-10 1/4" X 4'-5 1/2"
 Square Footage : House 1718
 Garage 492
 Bk. Porch 130
 Frt. Porch 32


| | |
|-------------------------------|----------------|
| Kahle Design & Build | |
| Defiance, Oh | Phone 497-4805 |
| Scale: Var. 1/8" = 1'-0" | Date 01/18/02 |
| Ms. Cole Condominium | |
| Location : Bales Rd. Napoleon | |

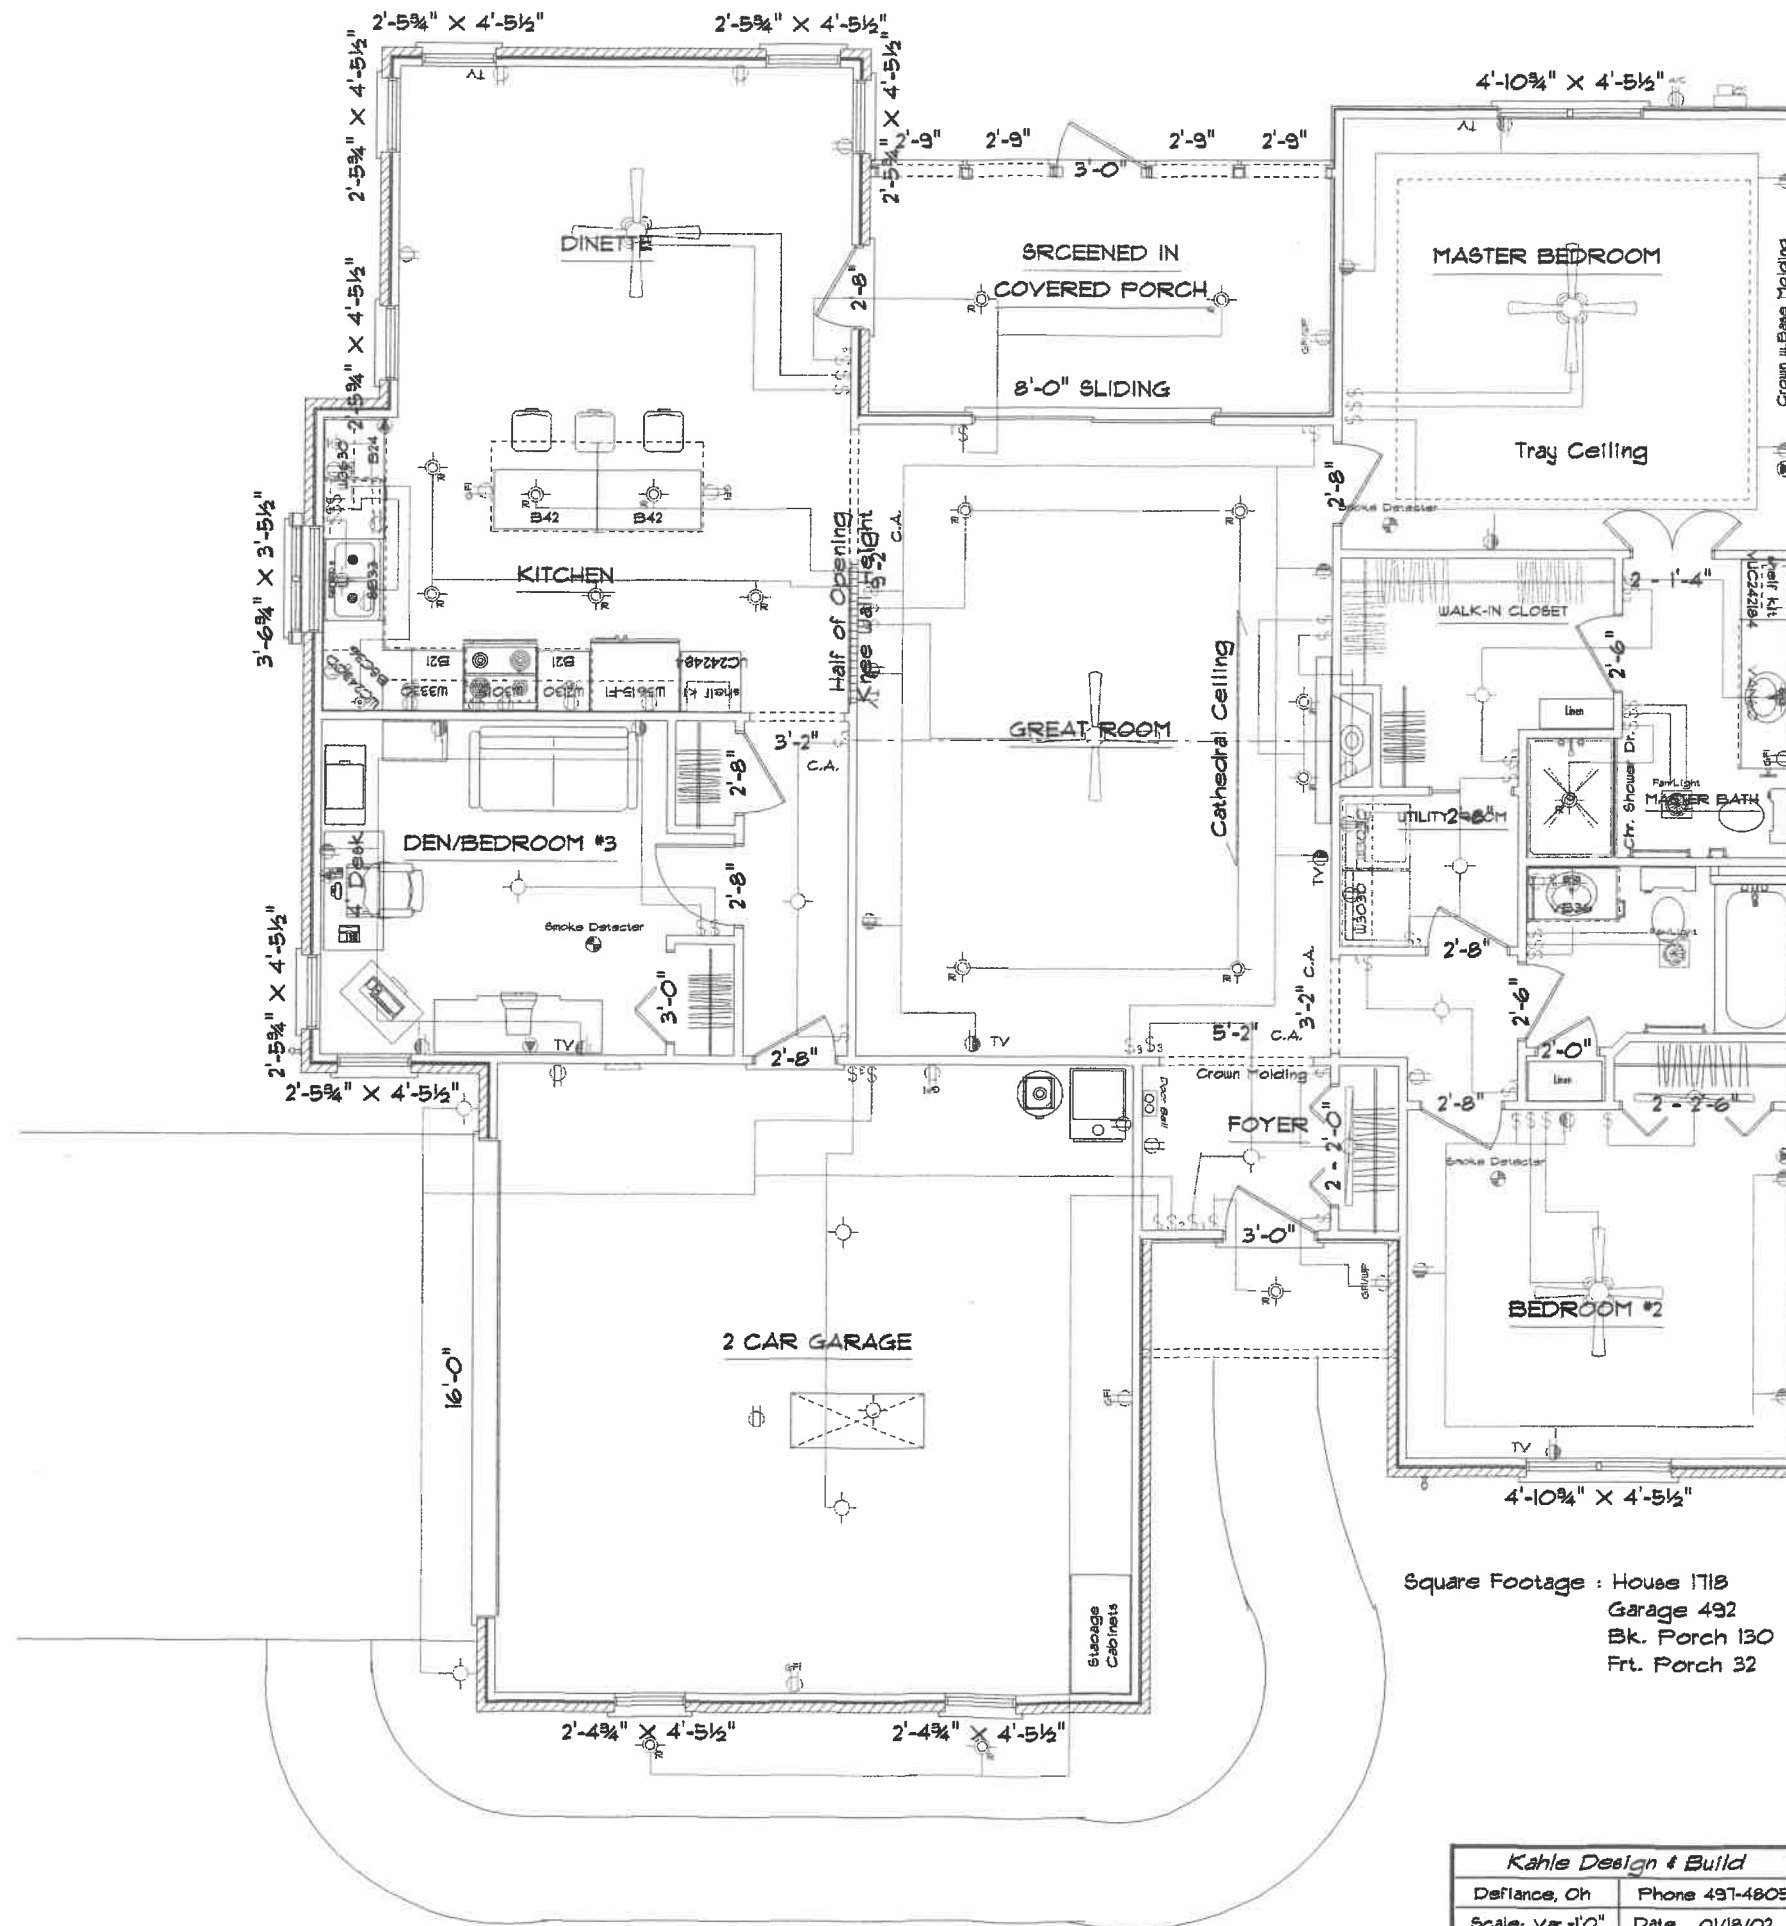

Square Footage : House 1718
 Garage 492
 Bk. Porch 130
 Frt. Porch 32

| | |
|-------------------------------|----------------|
| Kahle Design & Build | |
| Defiance, Oh | Phone 497-4805 |
| Scale: Var. 1/8" | Date 01/18/02 |
| Ms. Cole Condominium | |
| Location : Bales Rd. Napoleon | |


ELECTRICAL PLAN

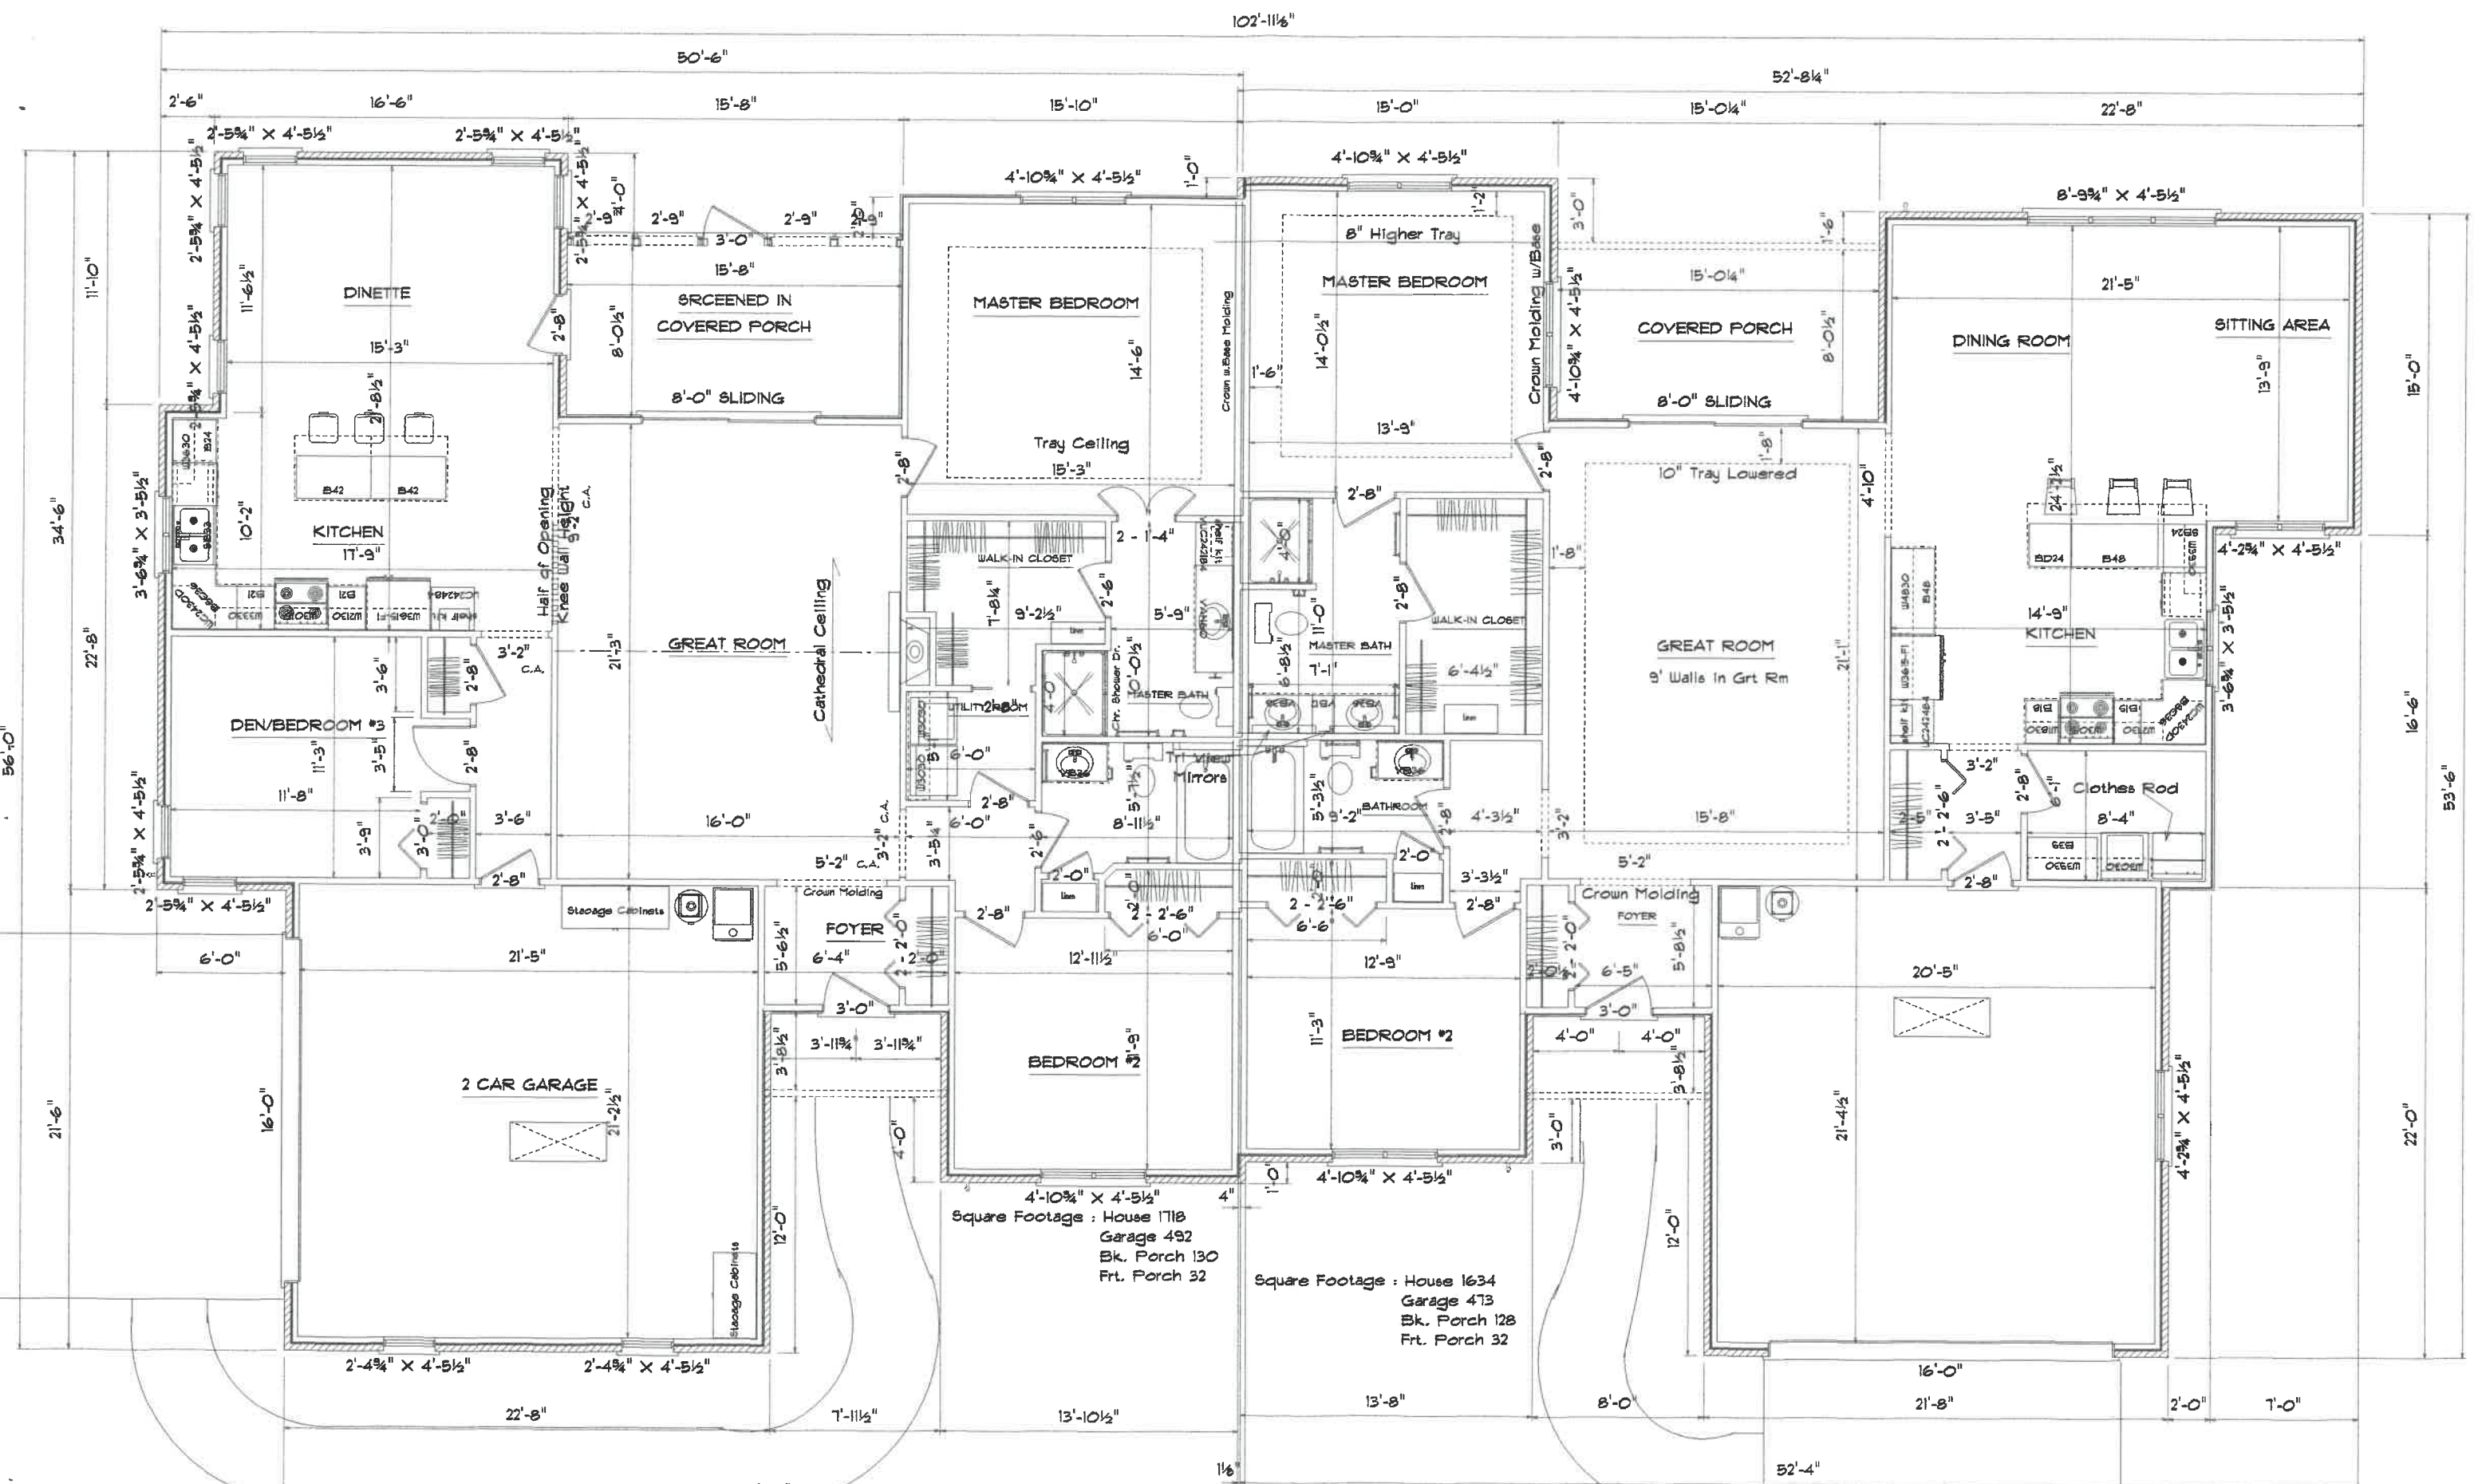

Square Footage : House 1718
 Garage 492
 Bk. Porch 130
 Frt. Porch 32

Square Footage : House 1634
 Garage 473
 Bk. Porch 128
 Frt. Porch 32

Kahle Design & Build
 Defiance, Oh Phone 487-4805
 Scale: Var. 1/8" = 1'-0" Date 01/12/02
 Ms. Rosemarie Cole
 Location : Bates Rd. Napoleon

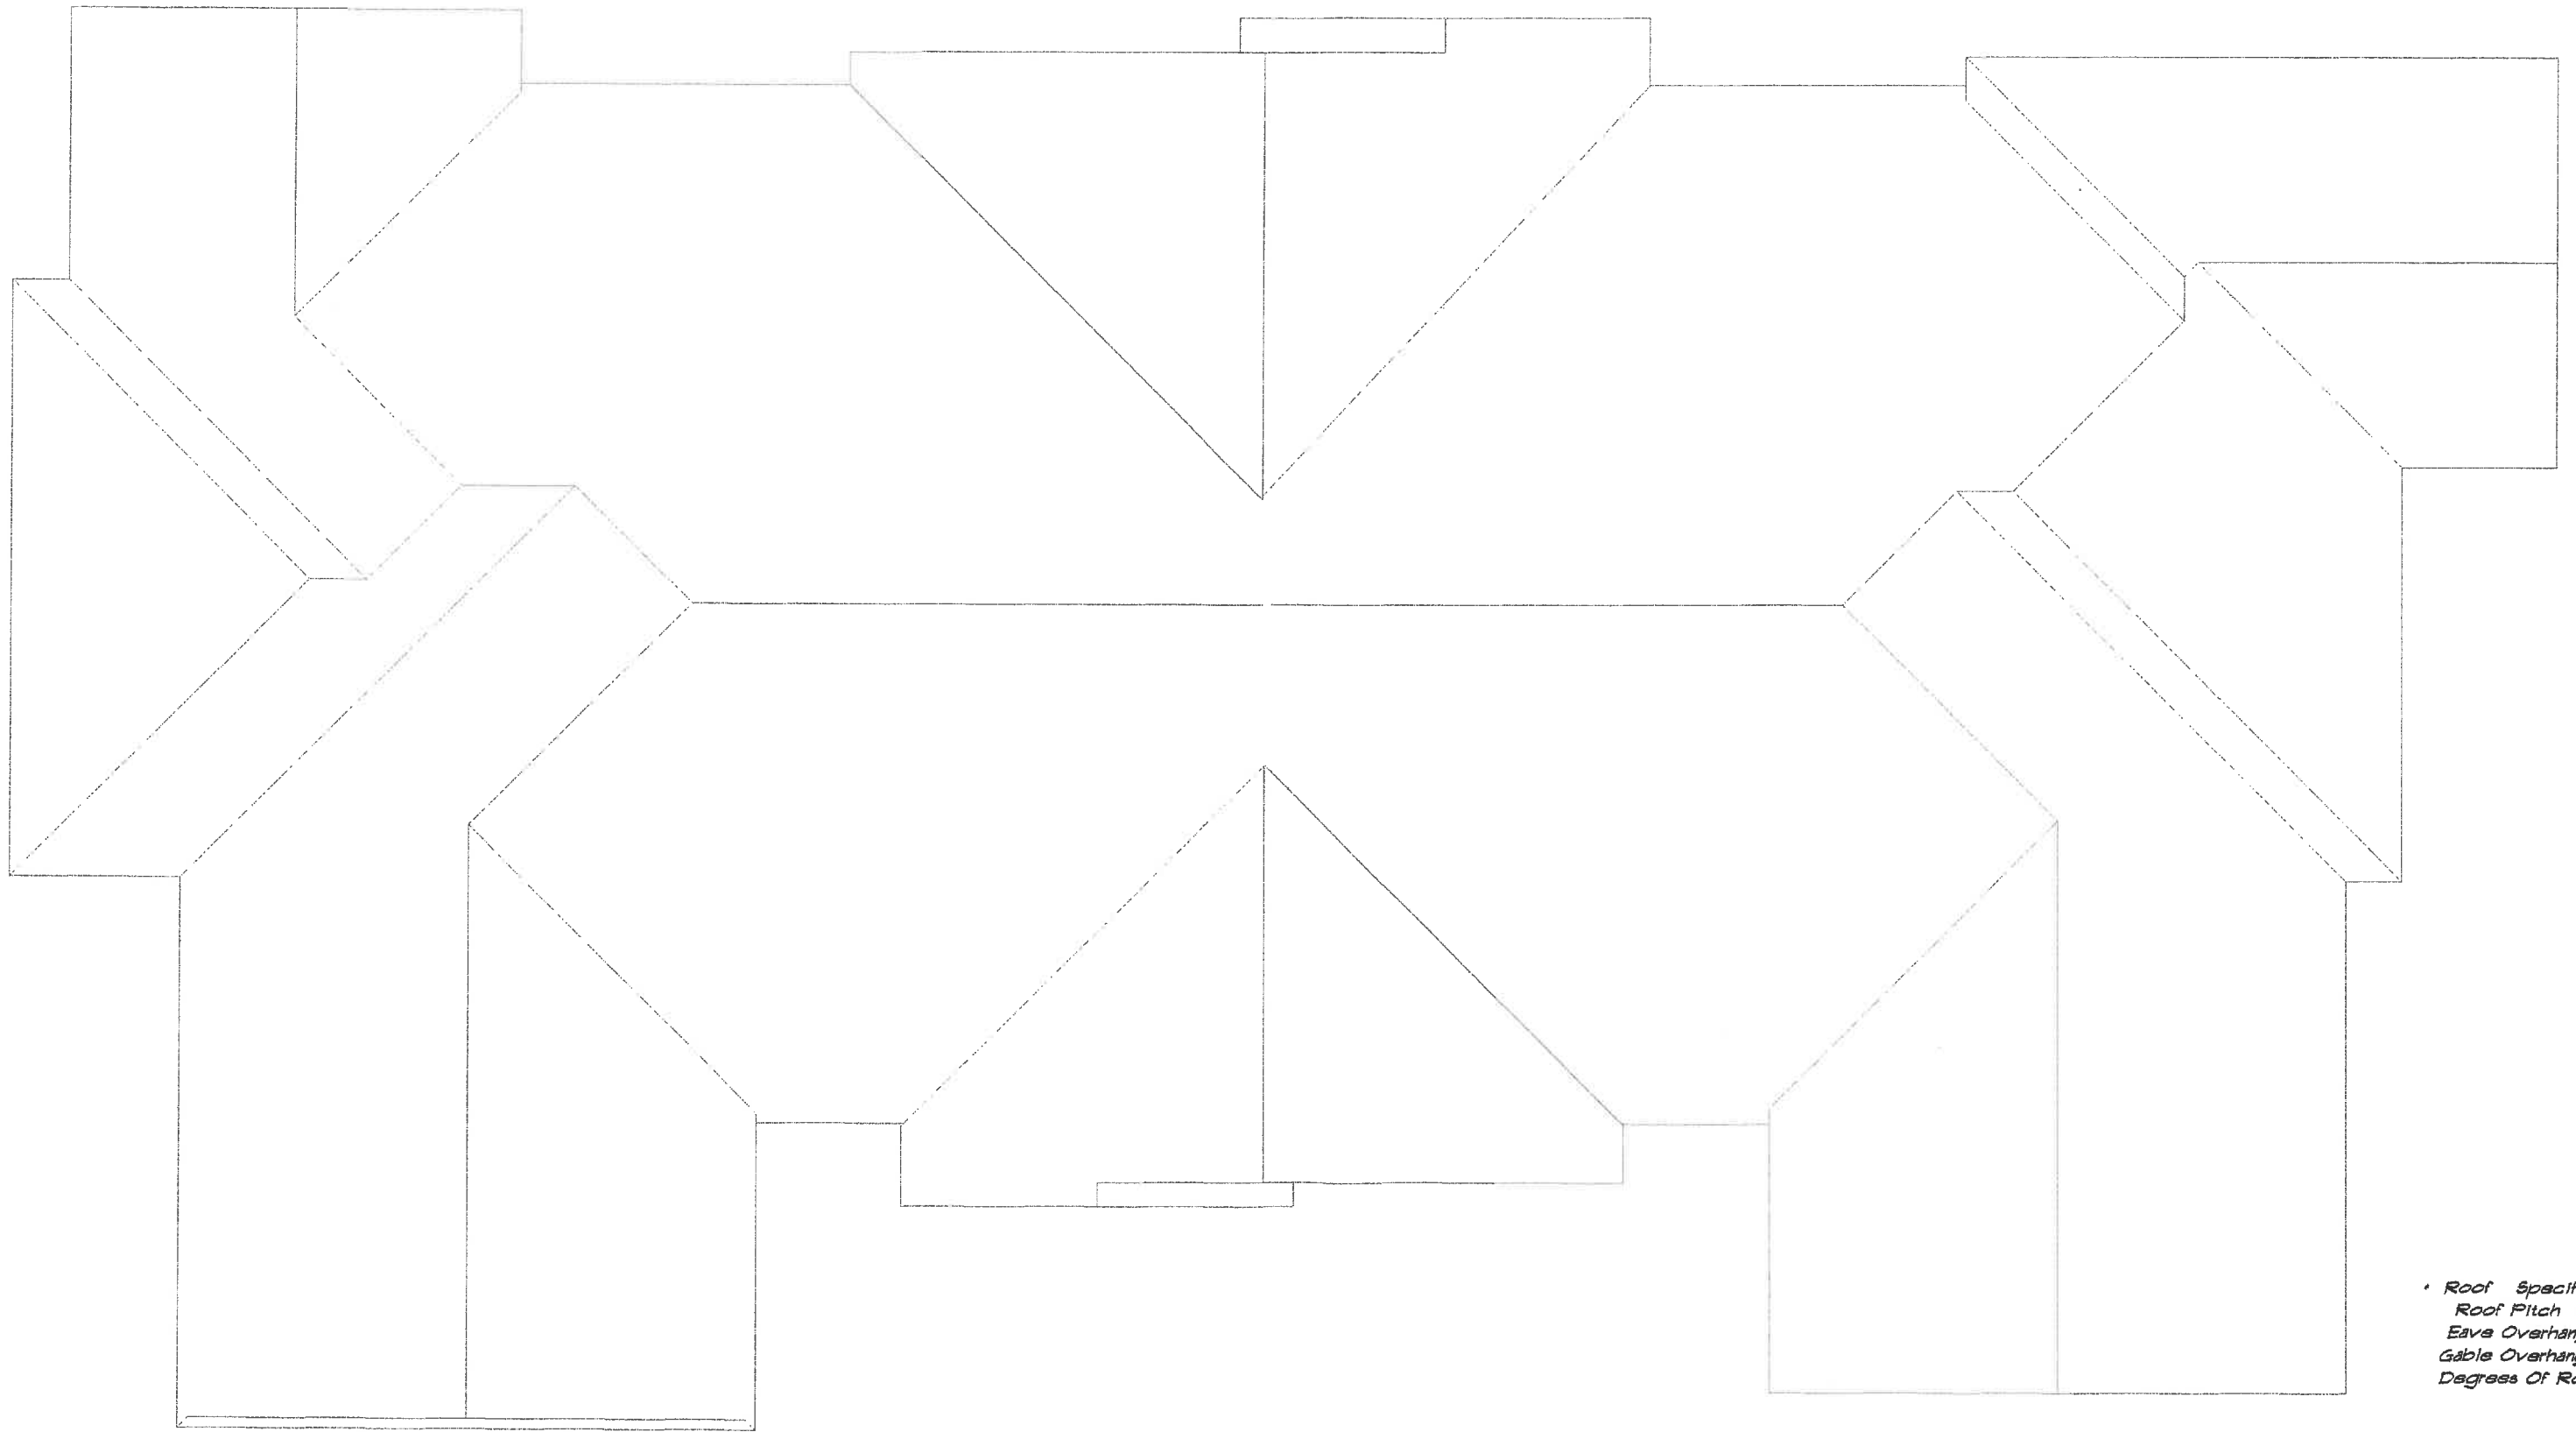

• Roof Specification •
Roof Pitch 6/12
Eave Overhang 16"
Gable Overhang 8"
Degree Of Roof 26.5



Scale : 1" = 40'

KAHLE DESIGN & BUILD
 DEFIANCE, OHIO
 Ph. 437-4803 H. or 782-7156 Off.
Plan of CHELSEA CONDO'S