


FLOOR PLAN

Square Footage : Main Floor 2010
 Garage 524
 Front Porch 30
 Rear Porch 130

1142 Bales. Rd.

Kahle Design & Build	
Defiance, Oh	Phone 437-4803
Scale: Var. 1/8"	Date 12-23-03
Mr. & Mrs. Gary Barnath	
Location : Chisess Ave., Napoleon	

FOUNDATION PLAN

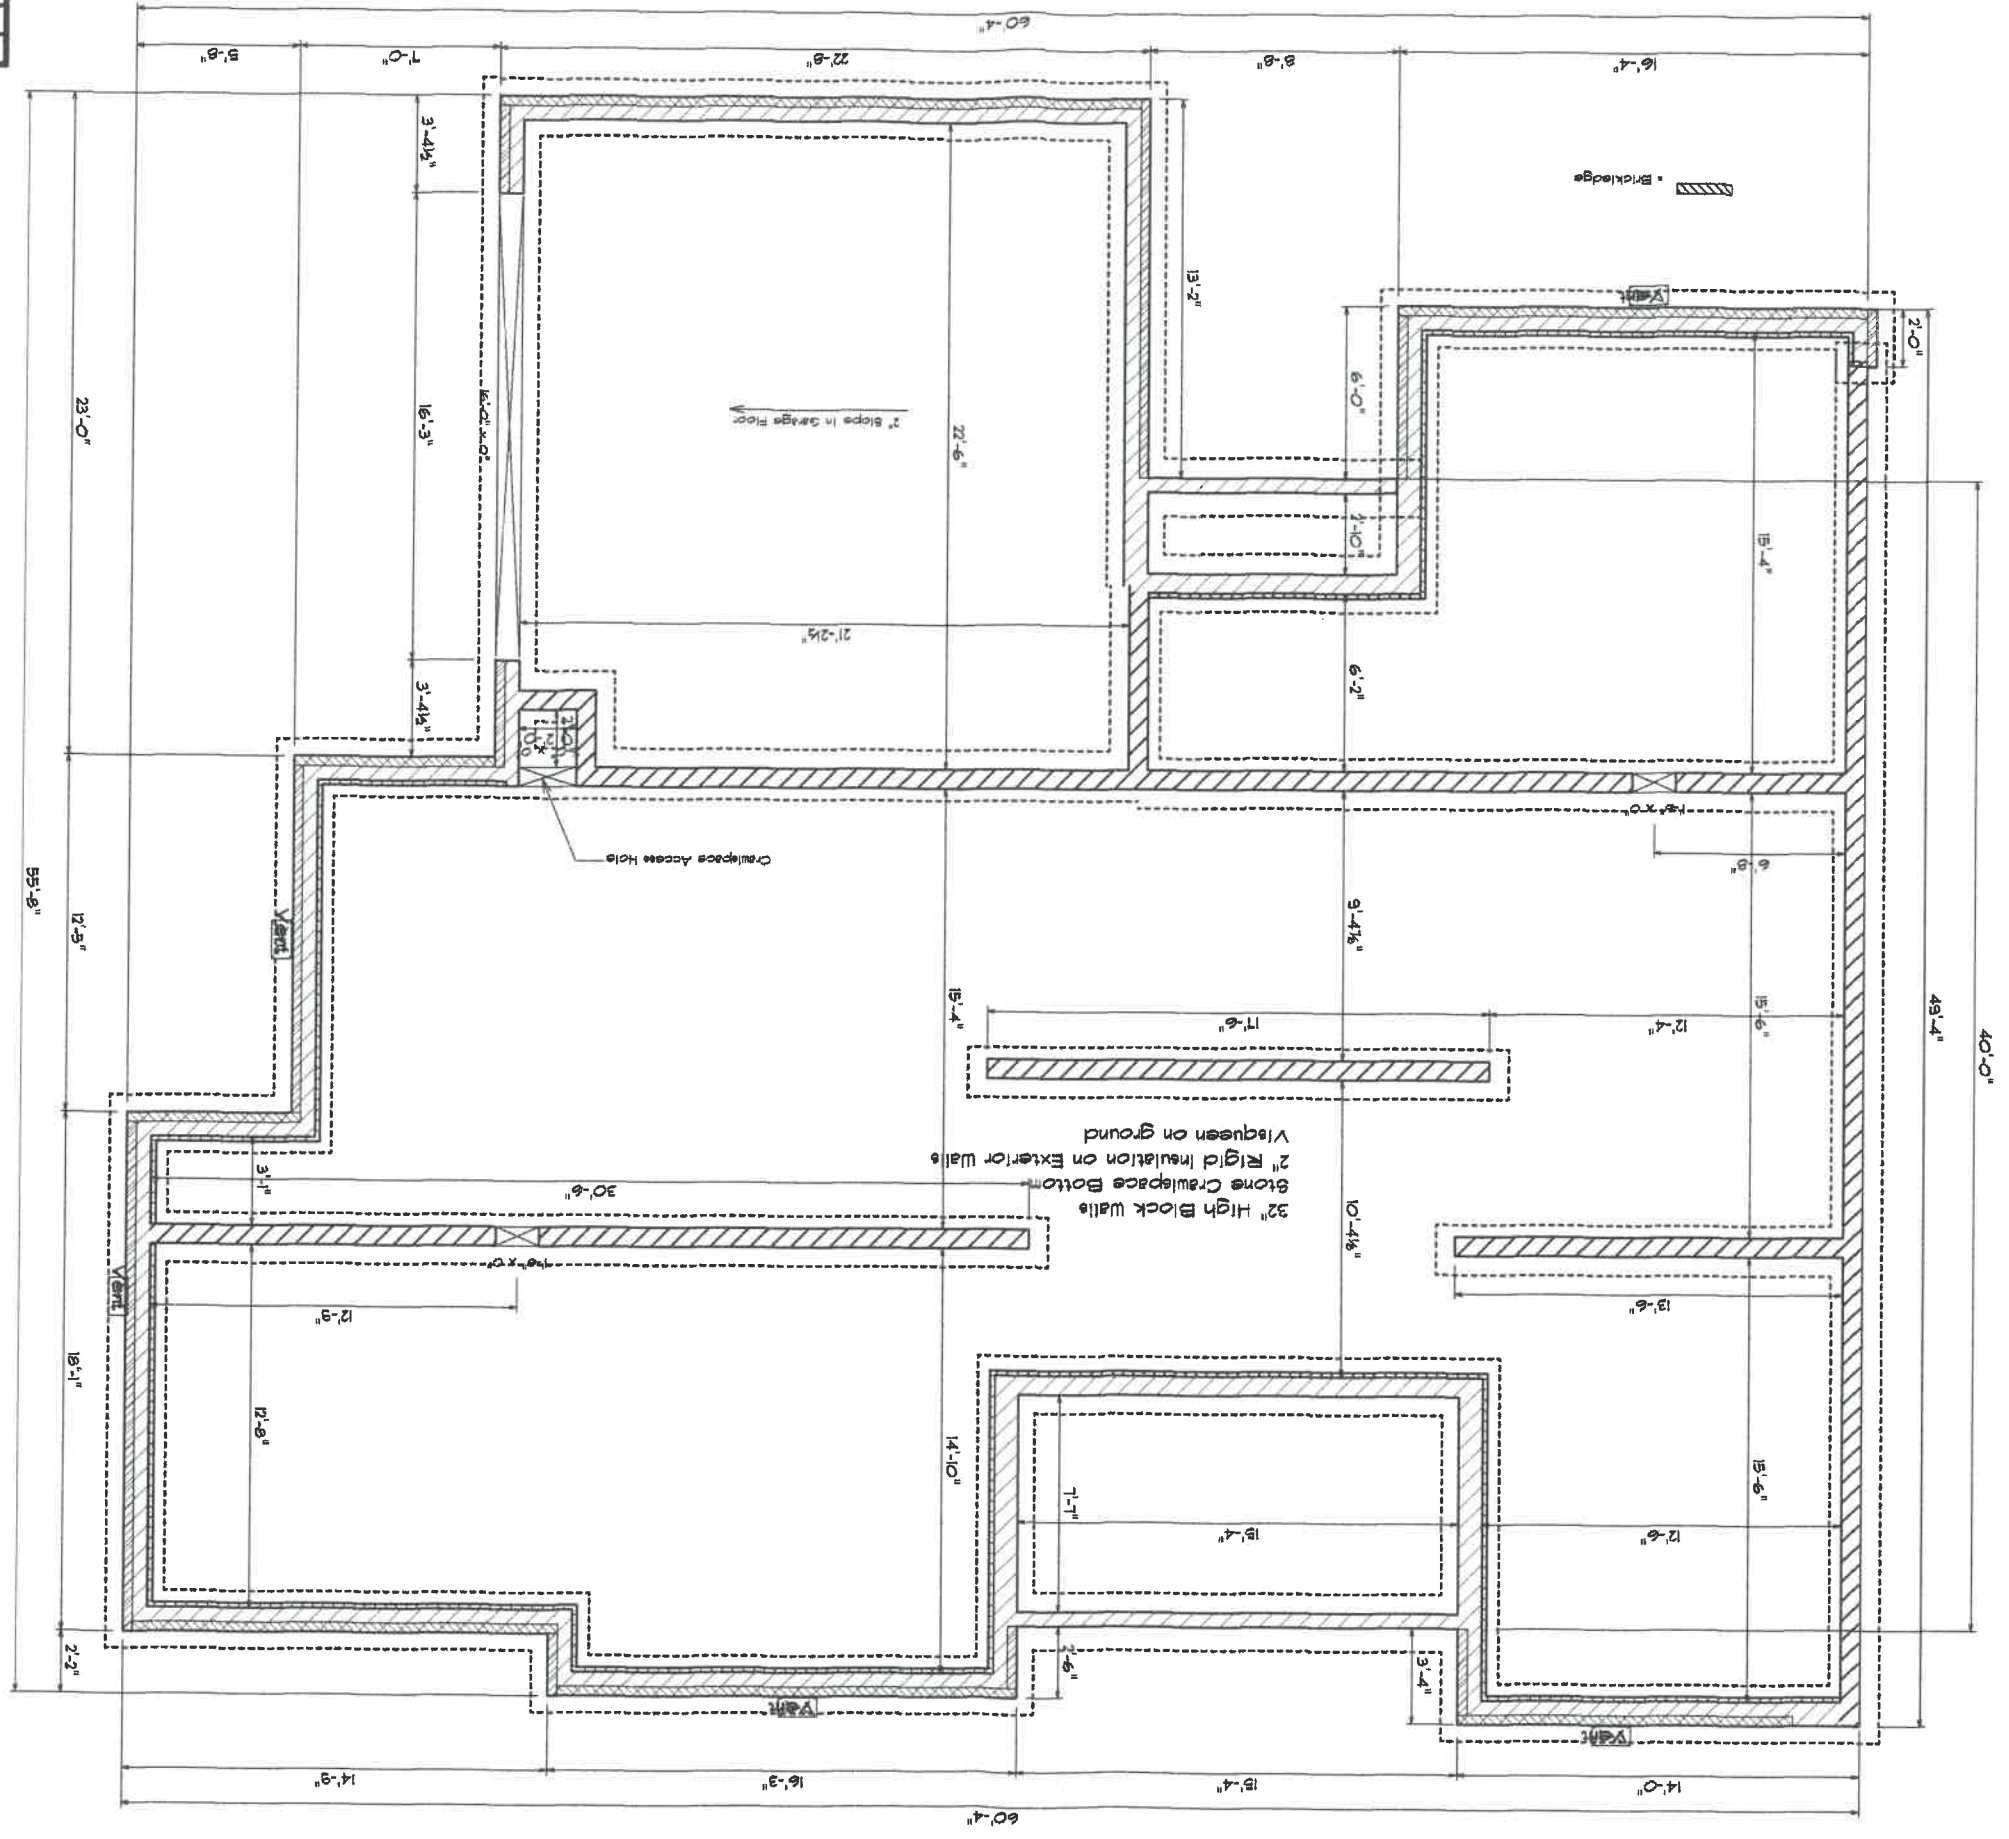


Location: Chelsea Ave., Napoleon	
Mr. & Mrs. Gary Bernath	
Scale: Var. 1/8"	Date: 12-23-03
Office: Defiance, Oh	Phone: 491-4805
Kahle Design & Build	


Bernath


Kahle Design & Build	
Phone 437-4805	Date 12-23-03
Mr. & Mrs. Gary Bernath	
Location: Chelsea Ave., Napoleon	

1142 Bales Rd.

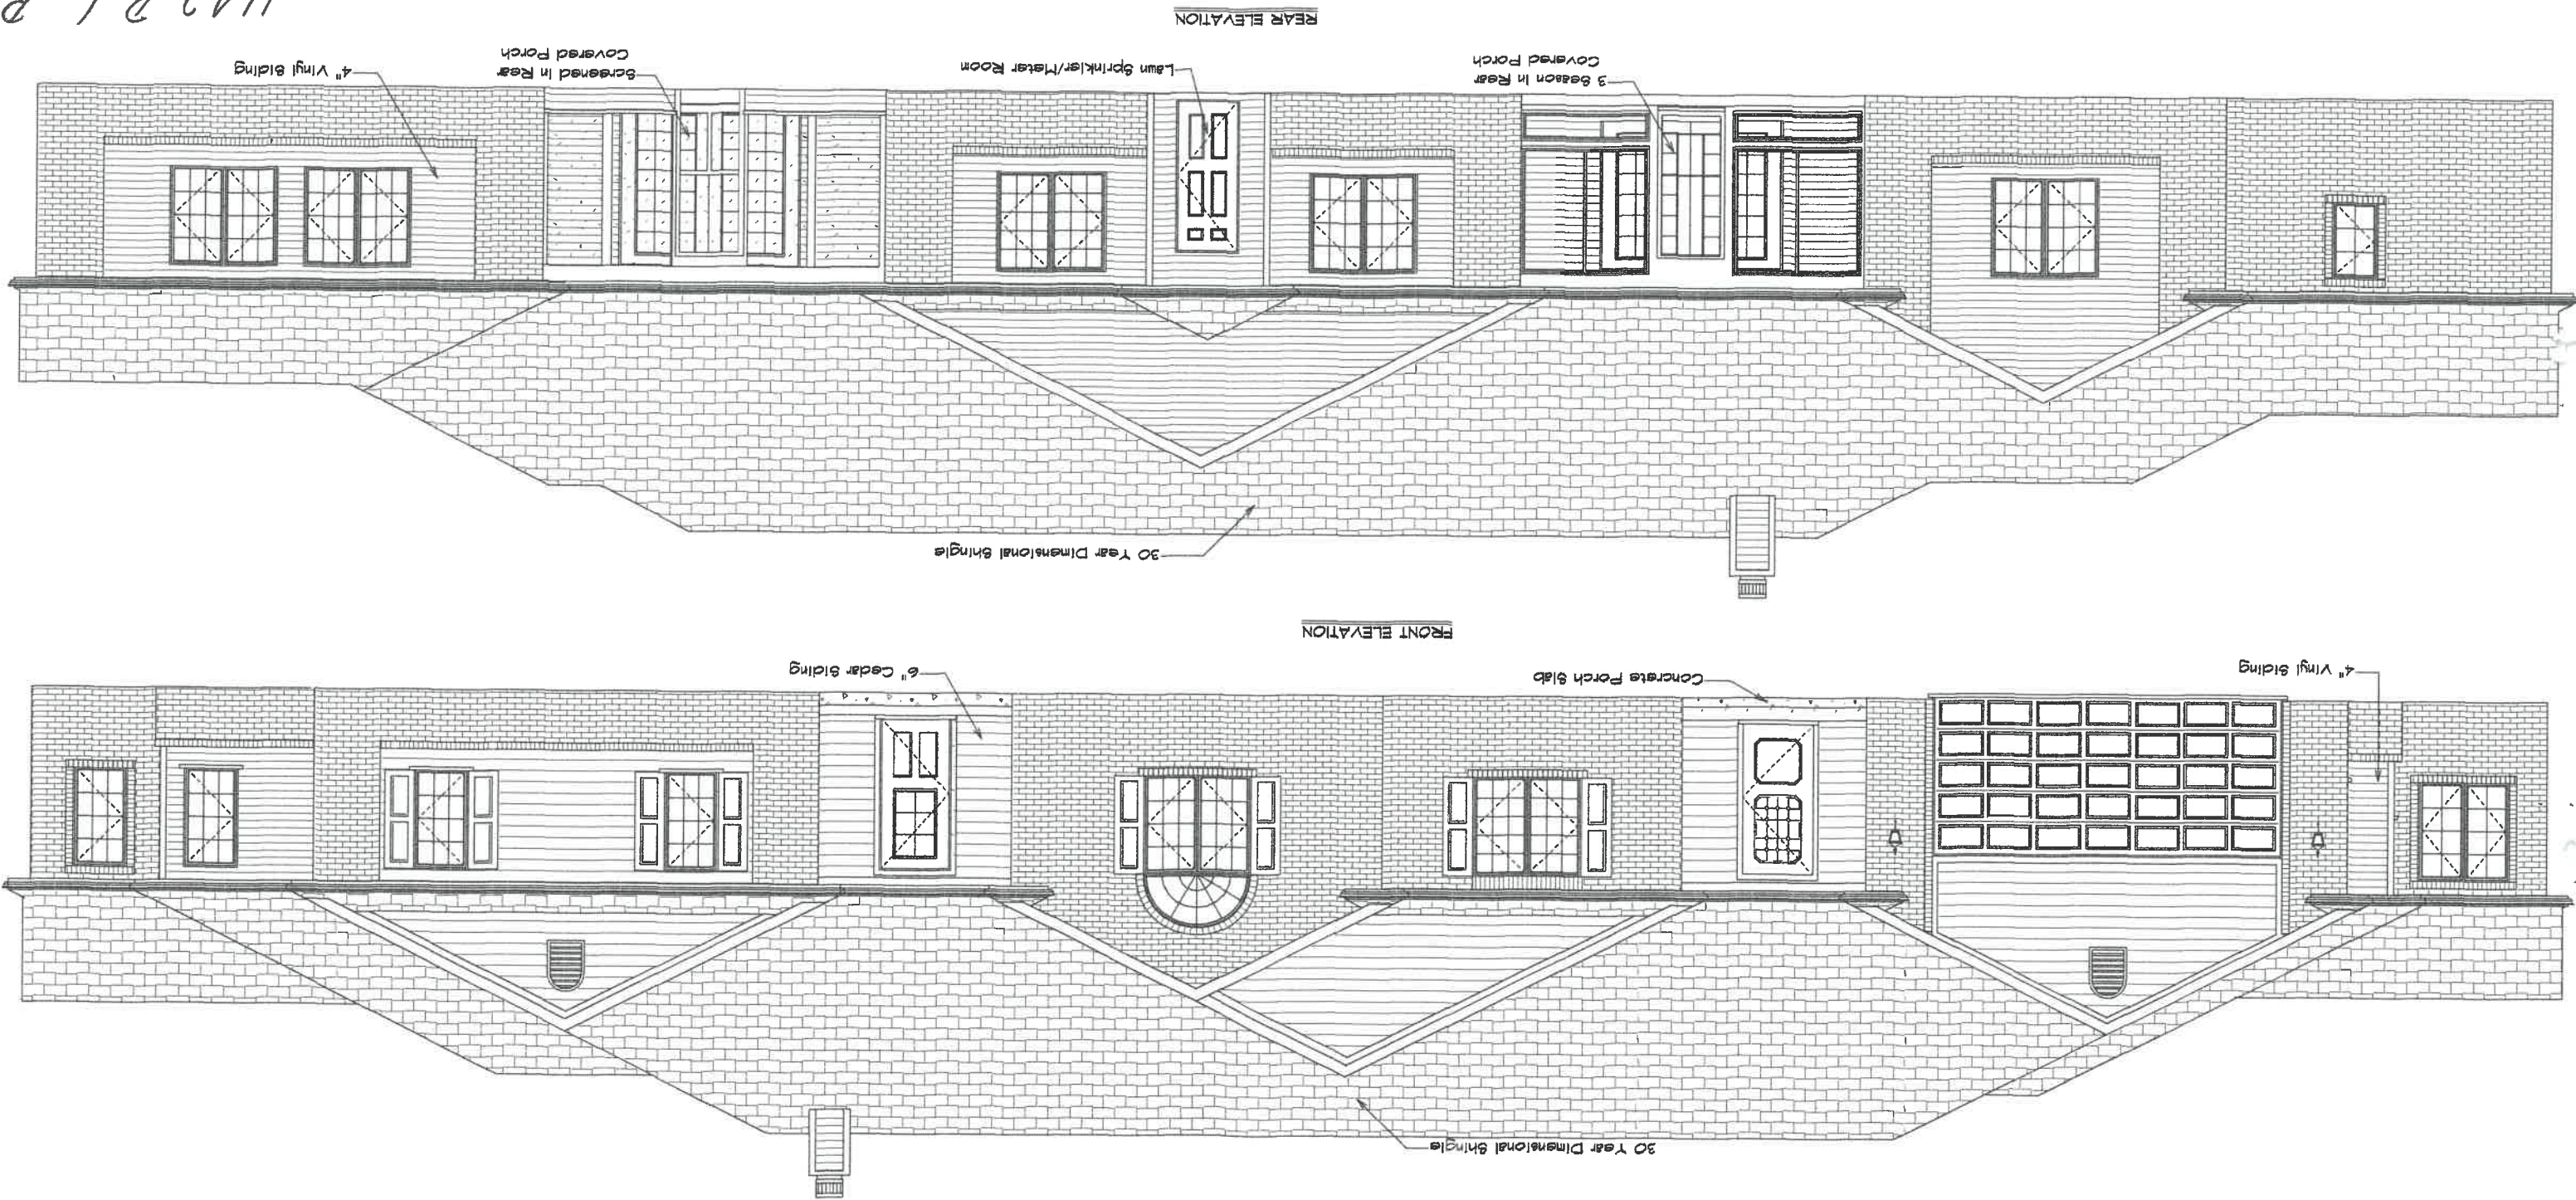

Kahle Design & Build	
Defiance, OH	Phone 437-4805
Scale: 1/8" = 1'-0"	Date: 12-23-03
Mr. & Mrs. Gary Barnath	
Location: Chelsea Ave., Napoleon	

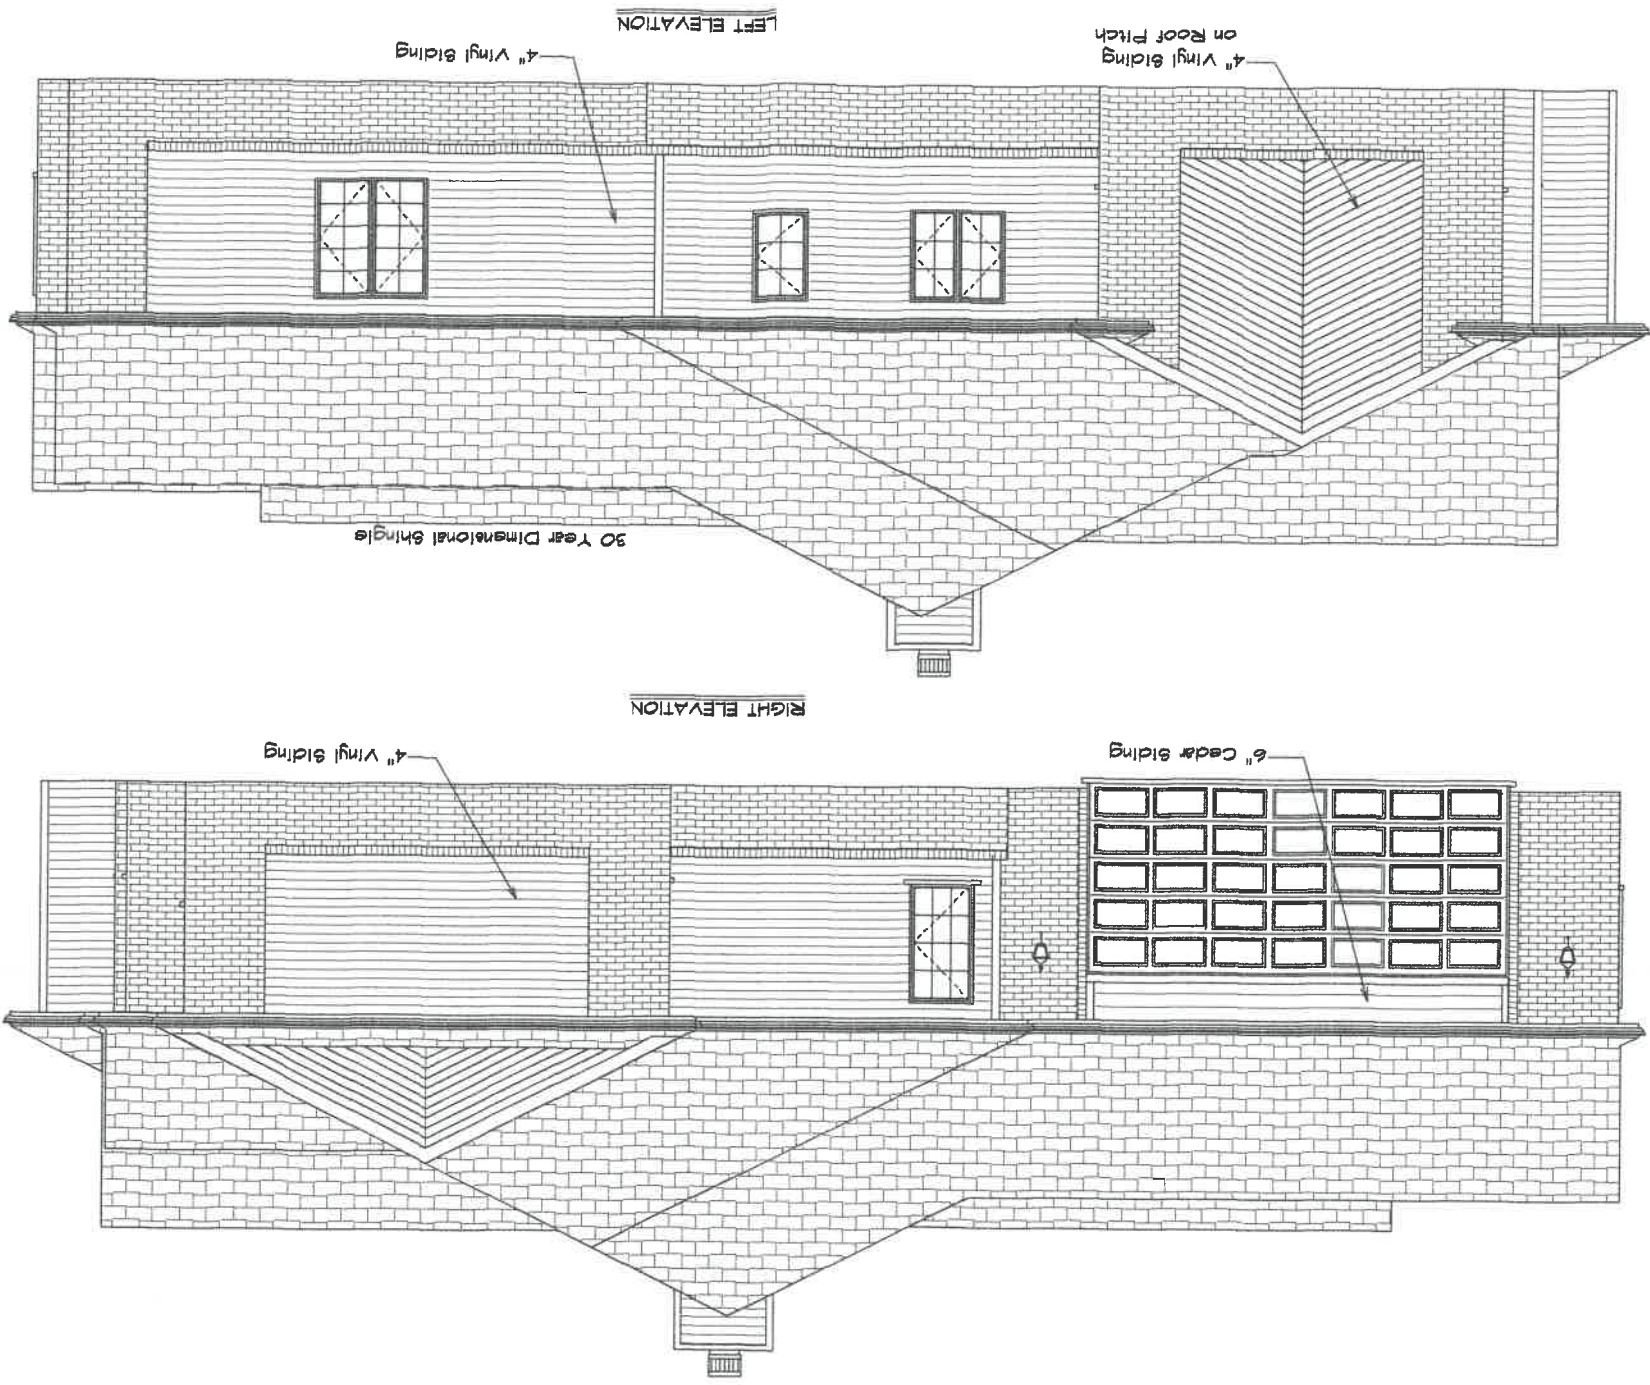


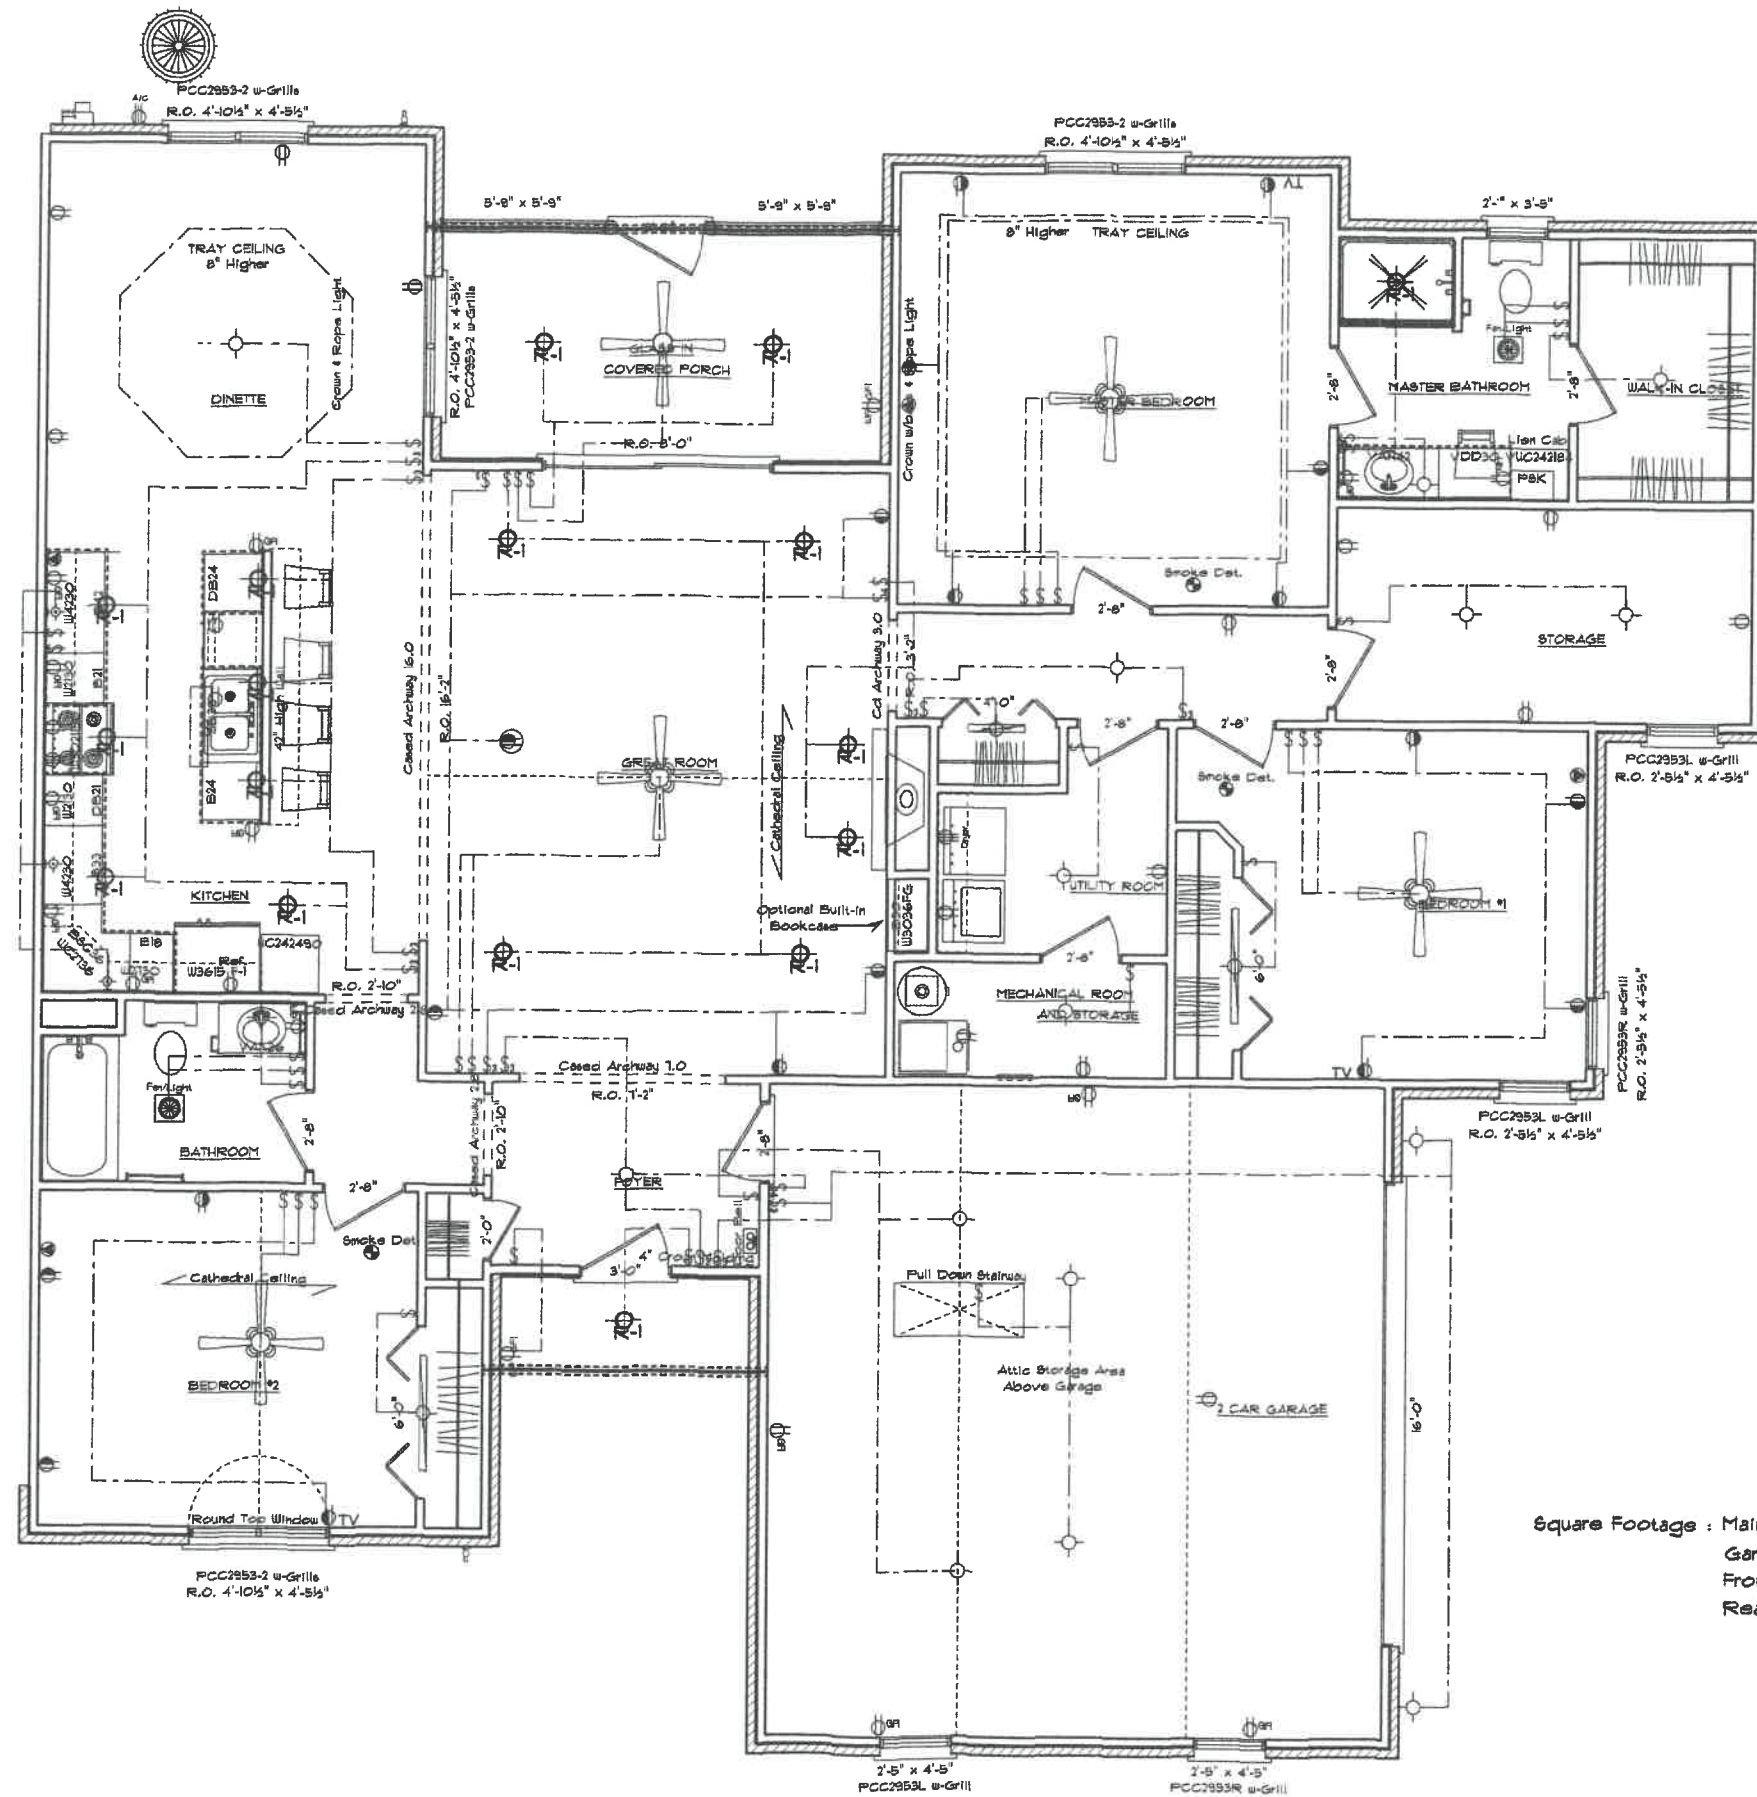

Square Footage : Main Floor 2010
 Garage 524
 Front Porch 30
 Rear Porch 130

ELECTRICAL PLAN

Kahle Design & Build	
Defiance, Oh	Phone 487-4805
Scale: Var. 1/8" = 1'-0"	Date 12-23-03
Mr. & Mrs. Gary Bernath	
Location : Chelsea Ave., Napoleon	

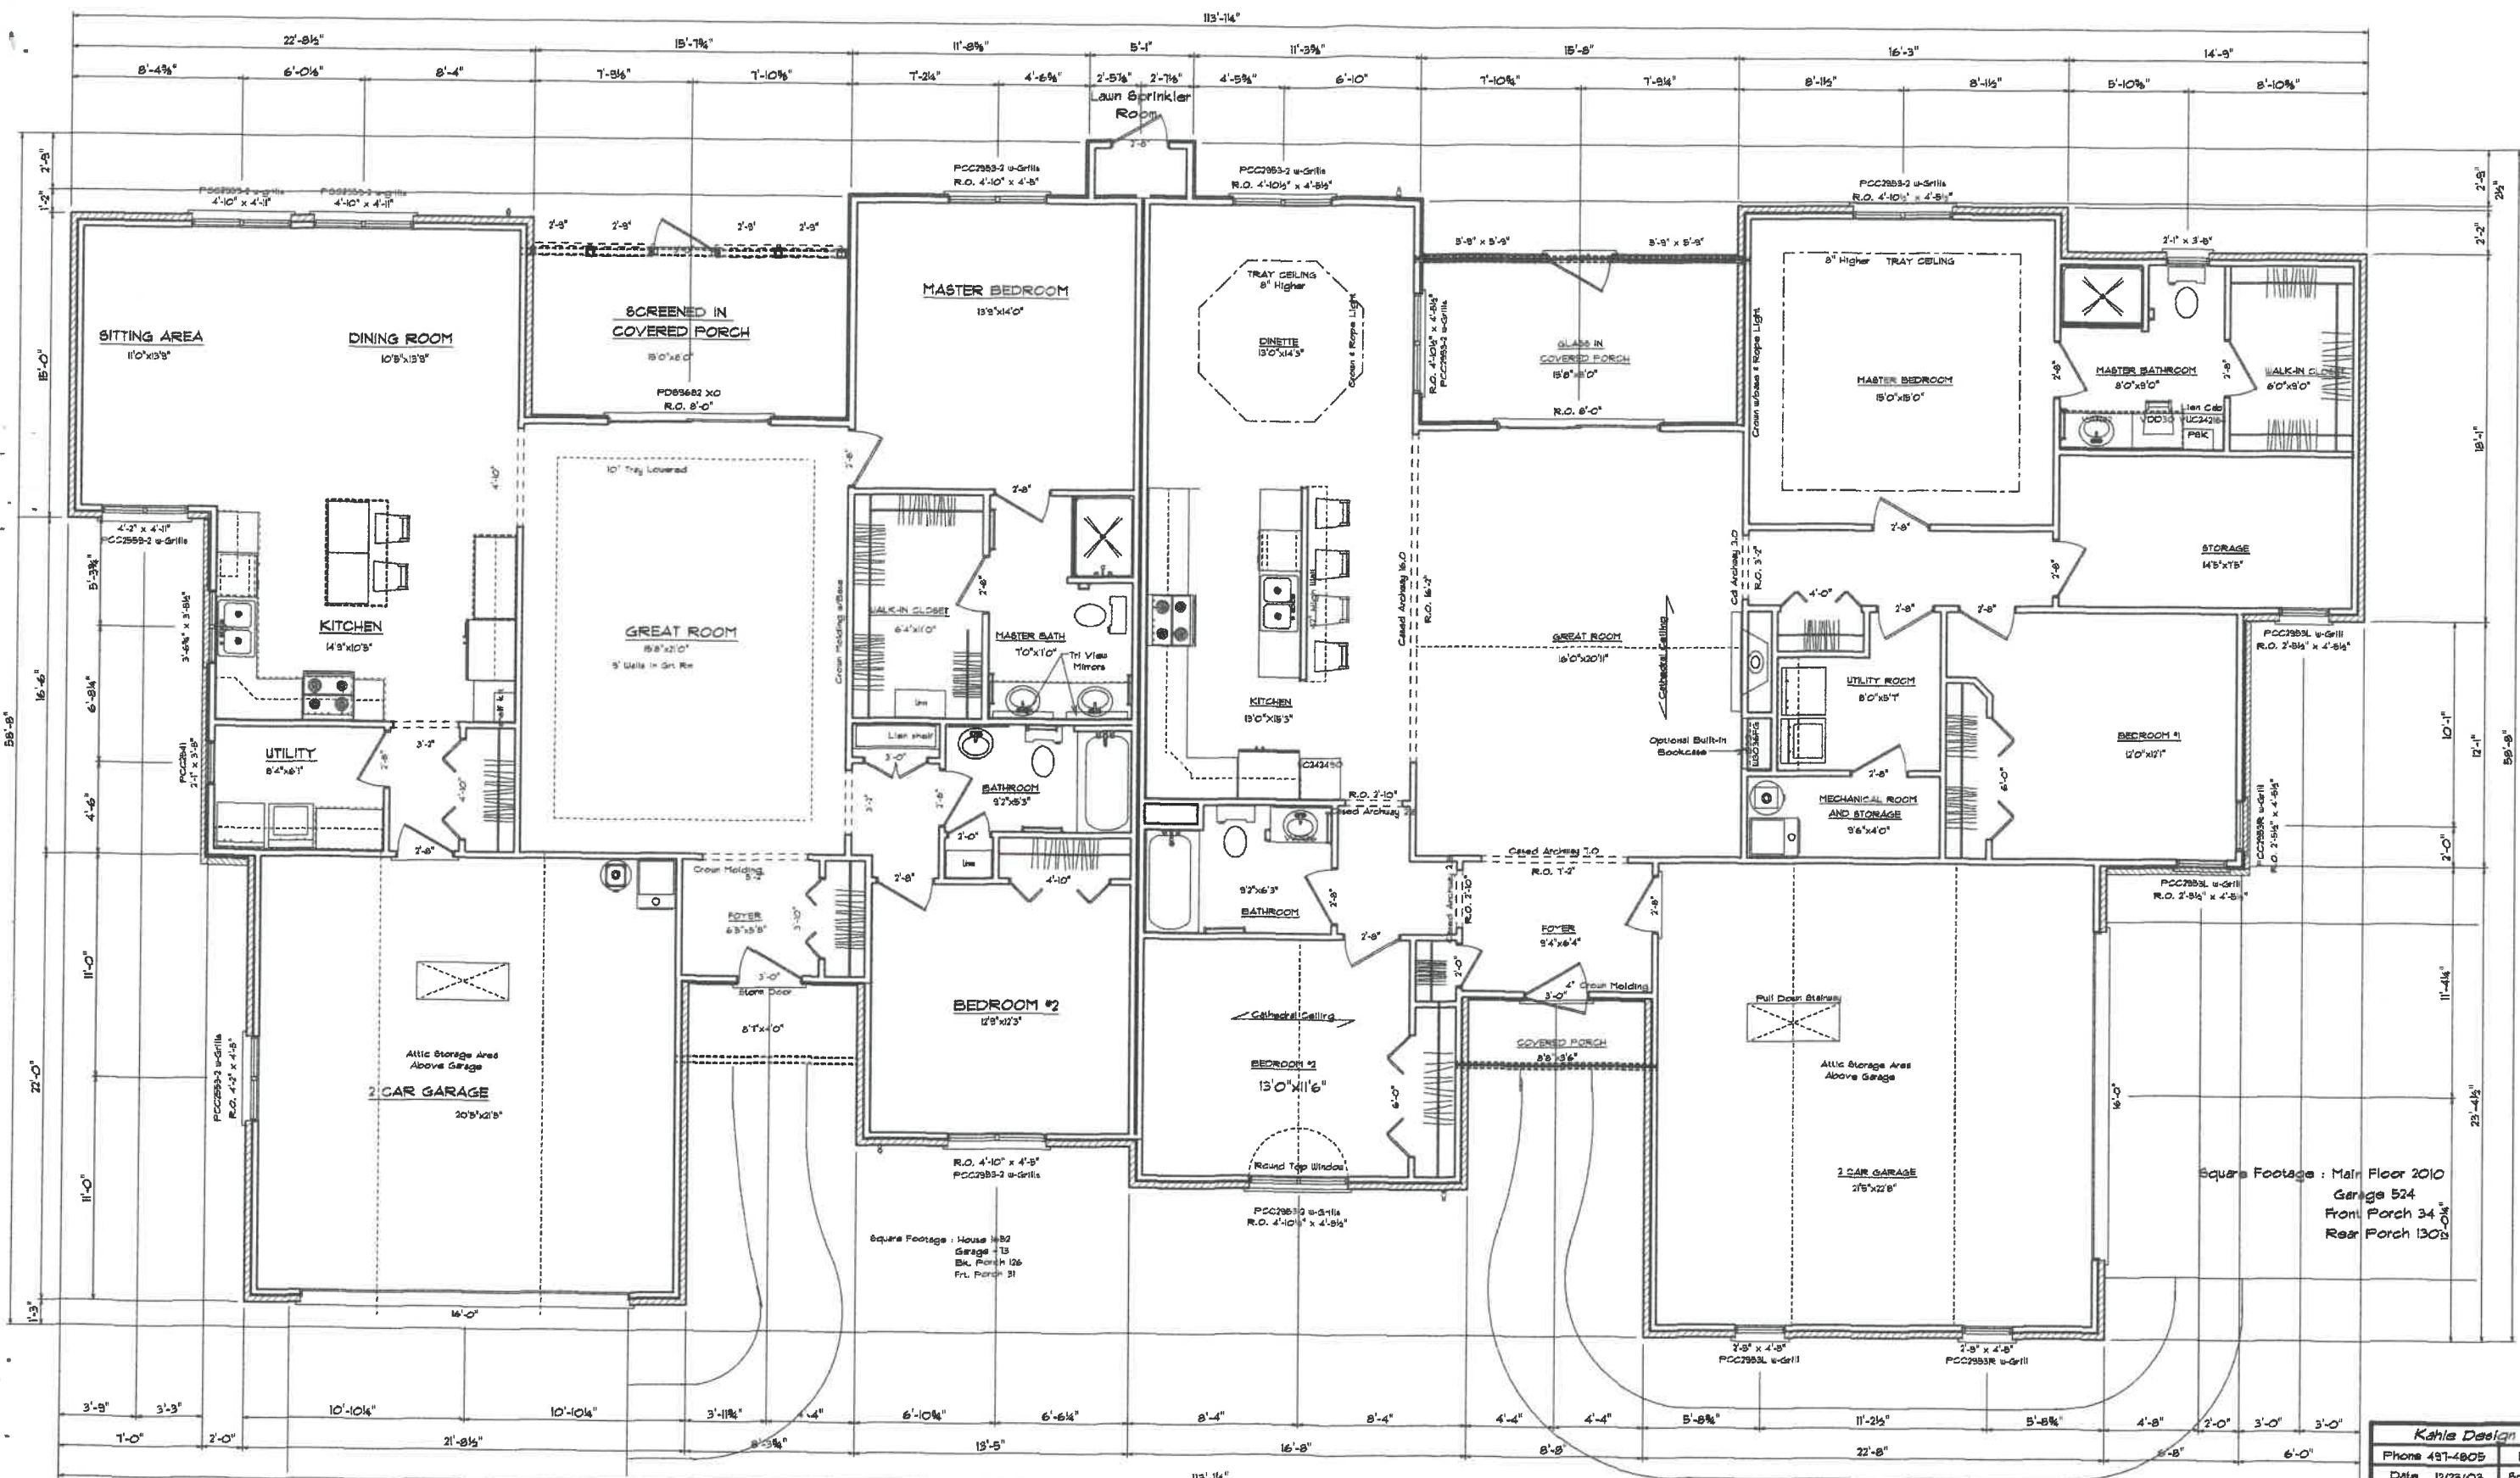

Square Footage : House 482
 Garage 13
 Blk. Porch 126
 Frt. Porch 31

Square Footage : Main Floor 2010
 Garage 524
 Front Porch 34
 Rear Porch 130

Kahle Design & Build
 Phone 497-4805 Defiance, Oh
 Date 12/23/03 Scale: Var.'10"
 Mr. & Mrs. Robert Long
 Location : 1152 Bates Rd., Napoleon

