

Vent-A-Ridge



6" Exposed Cedar Lap Siding
on Front of House

Quion Corners on Front
of House

FRONT ELEVATION

Footer insp - 9-1-04

1172 Bales Rd.

Kahle Design & Build	
Defiance, Oh	Phone 437-4805
Scale: Var. 1/8"	Date 2-24-04
Mr. & Mrs. D. Bockelman	
Location: Bales Rd., Napoleon	



Right Elevation

4" Vinyl Siding



Sun Room

4" Vinyl Siding


LEFT ELEVATION



4" vinyl siding


REAR ELEVATION

Sun Room

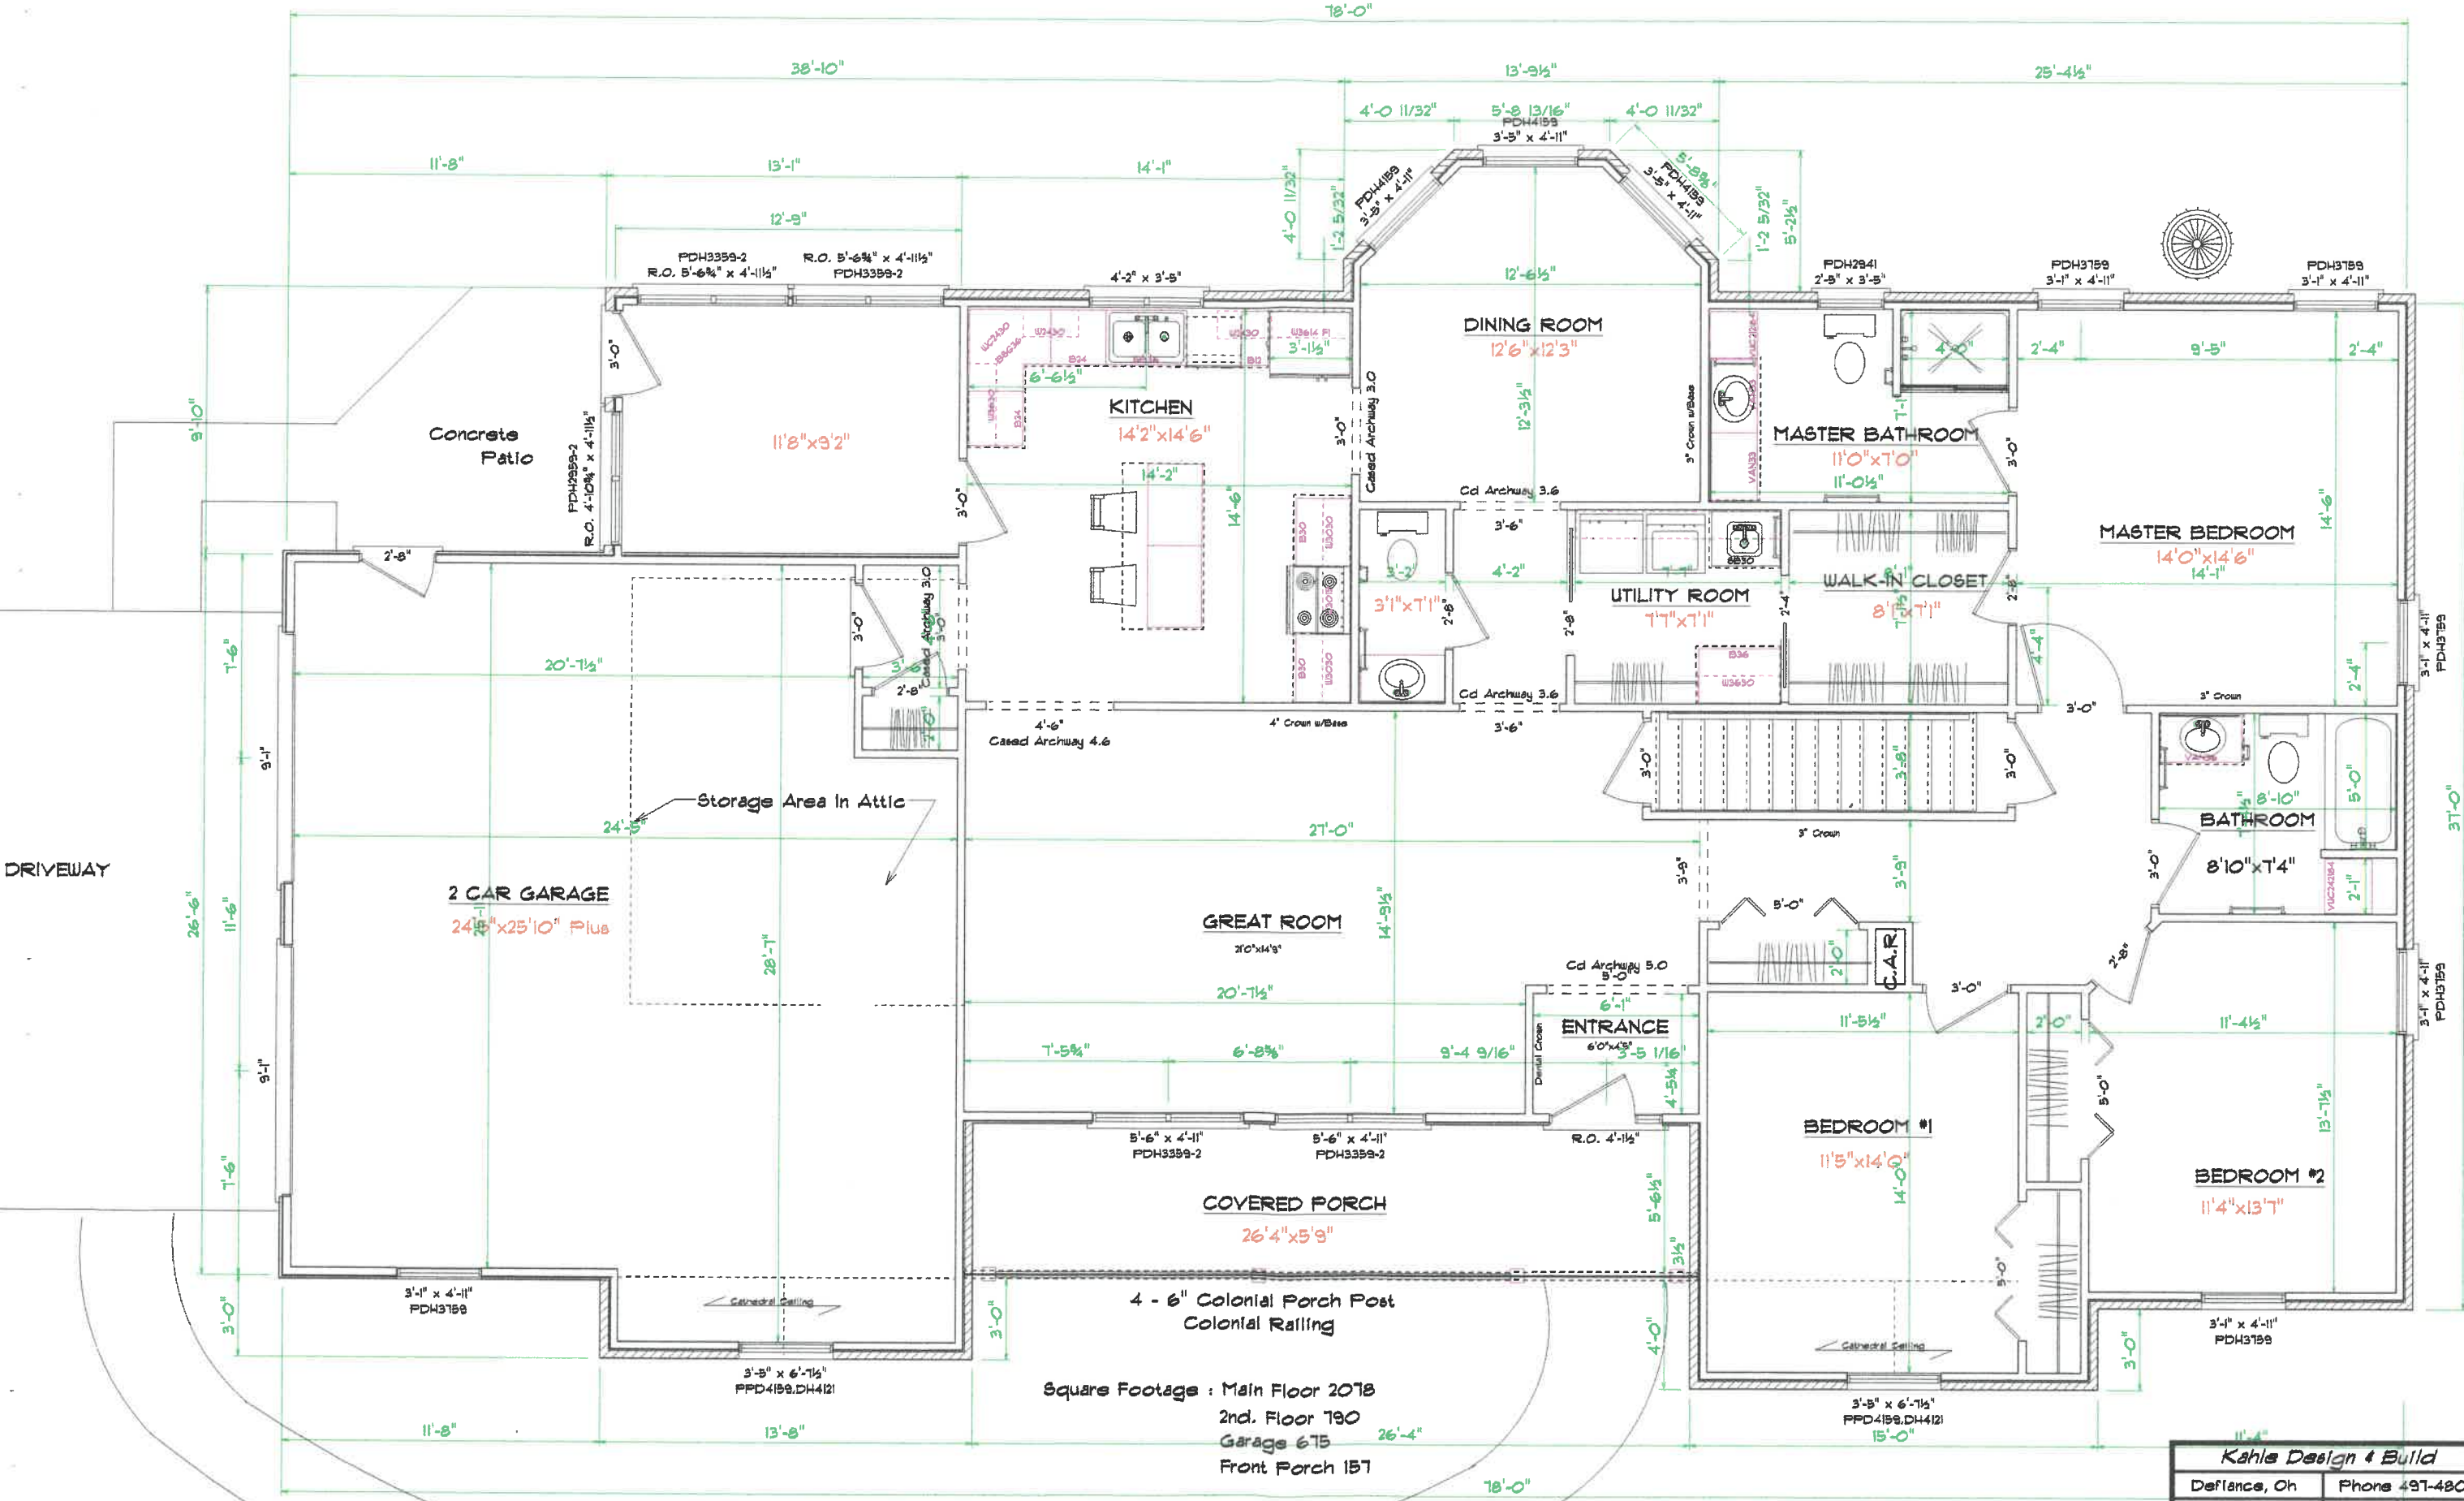


Square Footage : Main Floor 2078
 2nd. Floor 790
 Garage 675
 Front Porch 157

Kahle Design & Build	
Defiance, Oh	Phone 497-4805
Scale: Var. 1/8"	Date 2-24-04
Mr. & Mrs. D. Bockelman	
Location : Sales Rd., Napoleon	

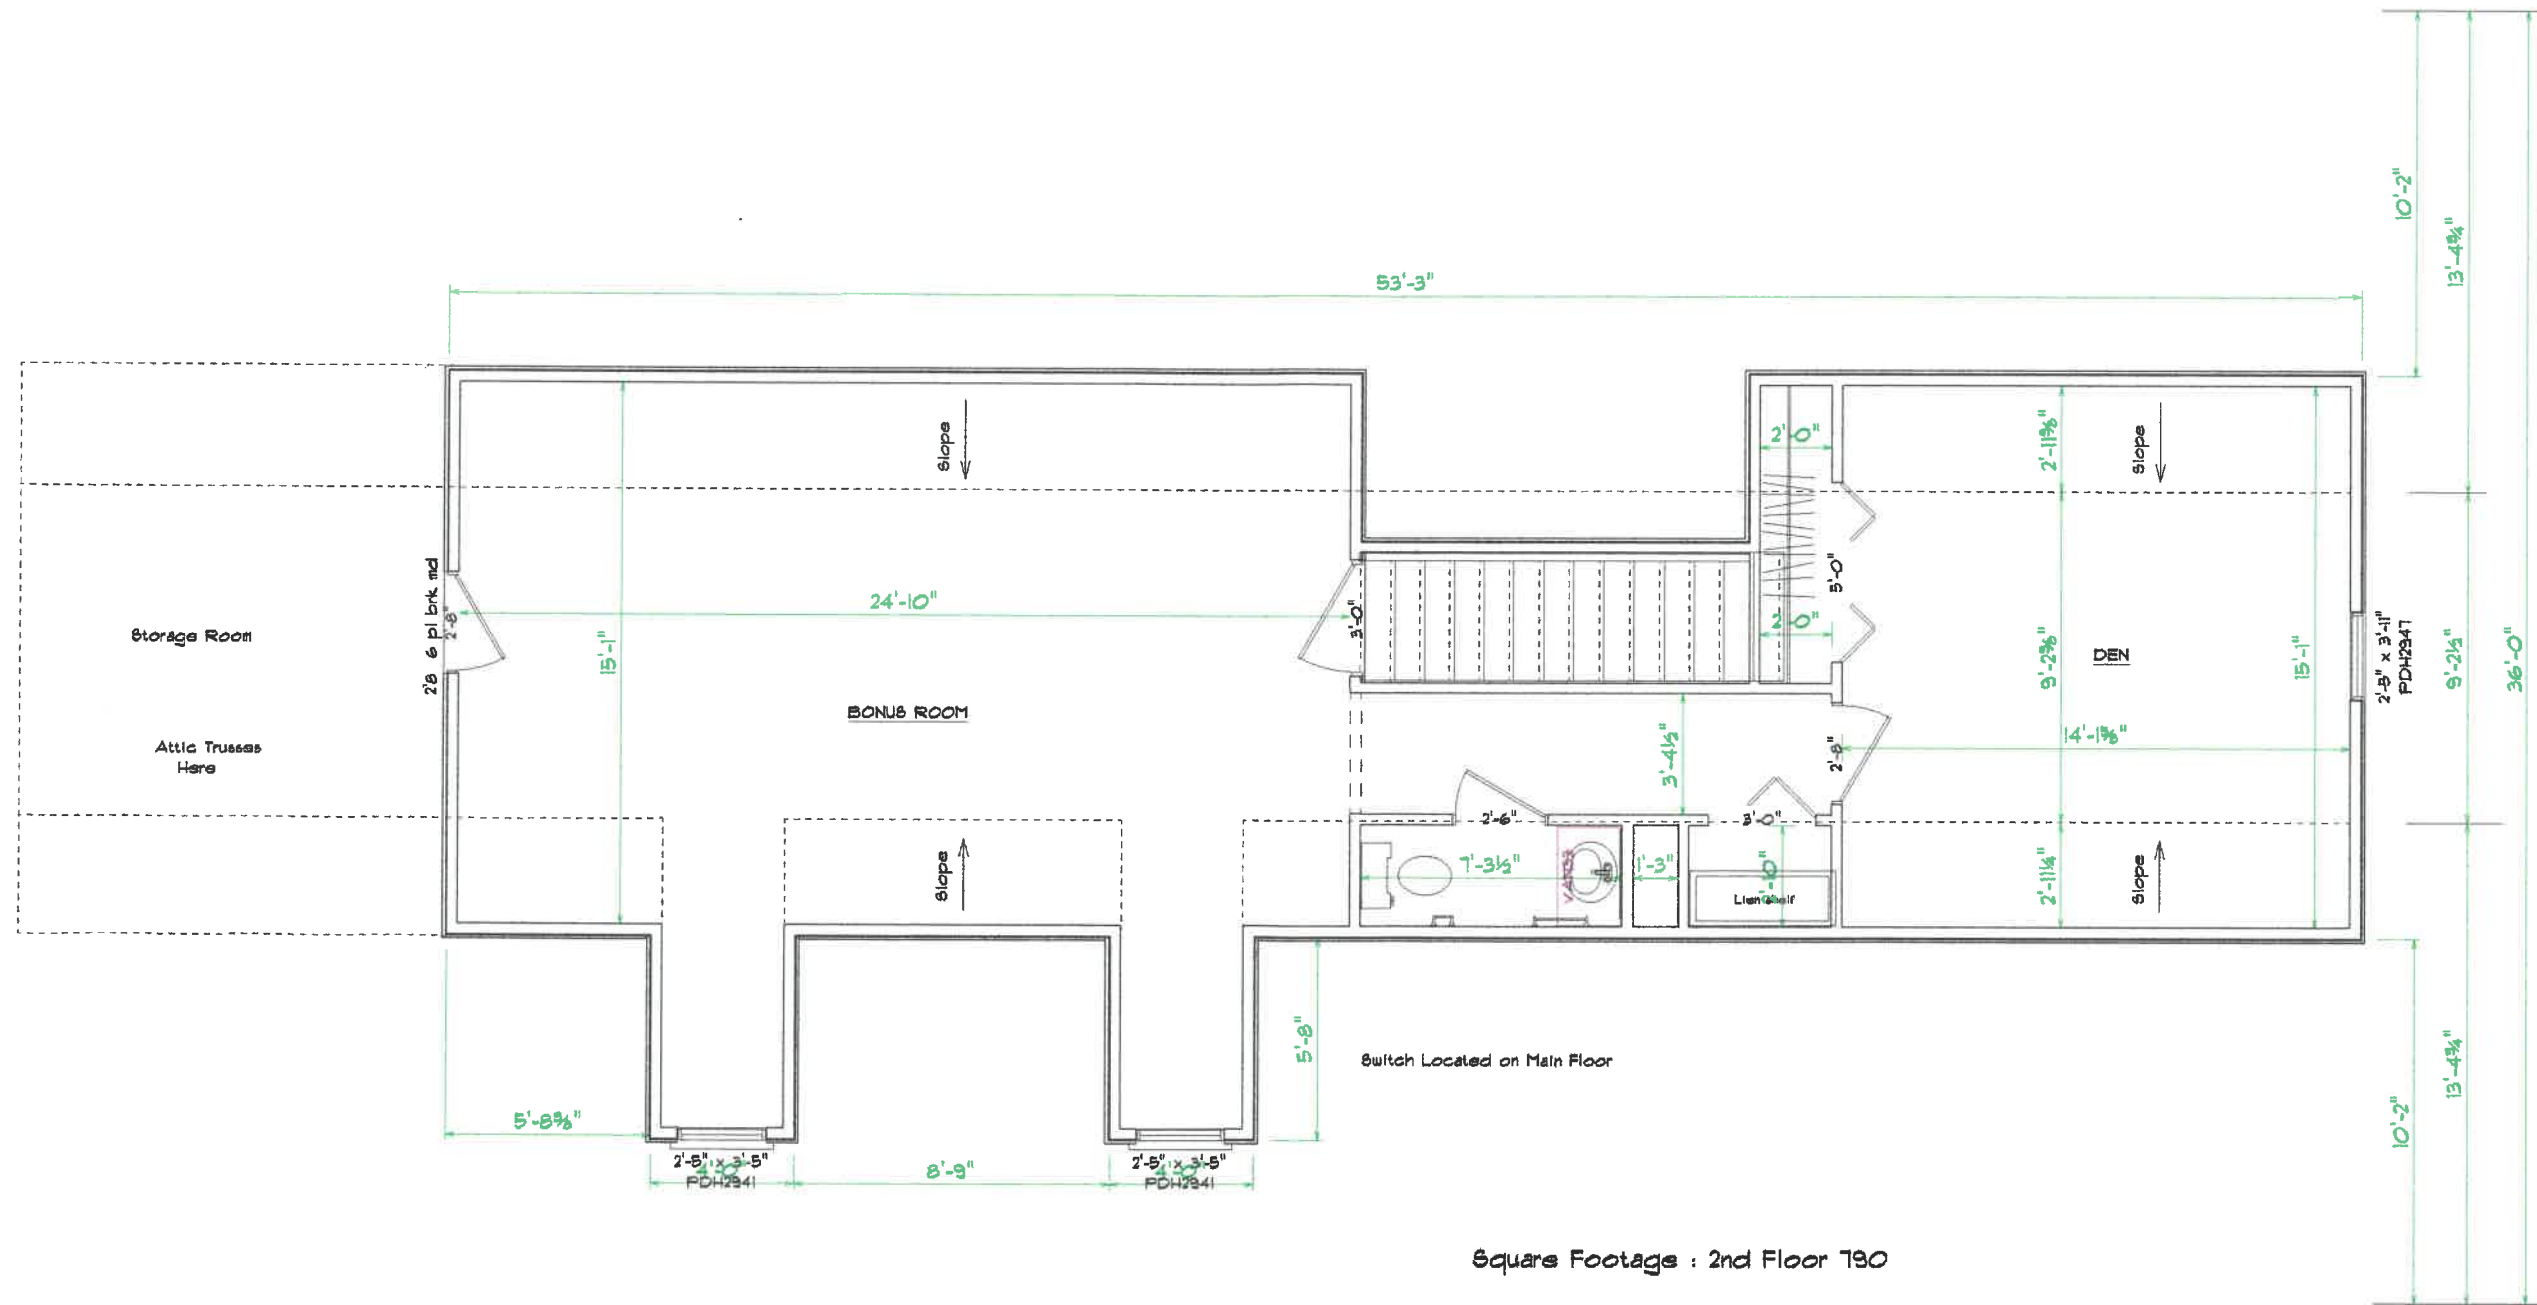


Square Footage : 2nd Floor 790

2ND FLOOR PLAN

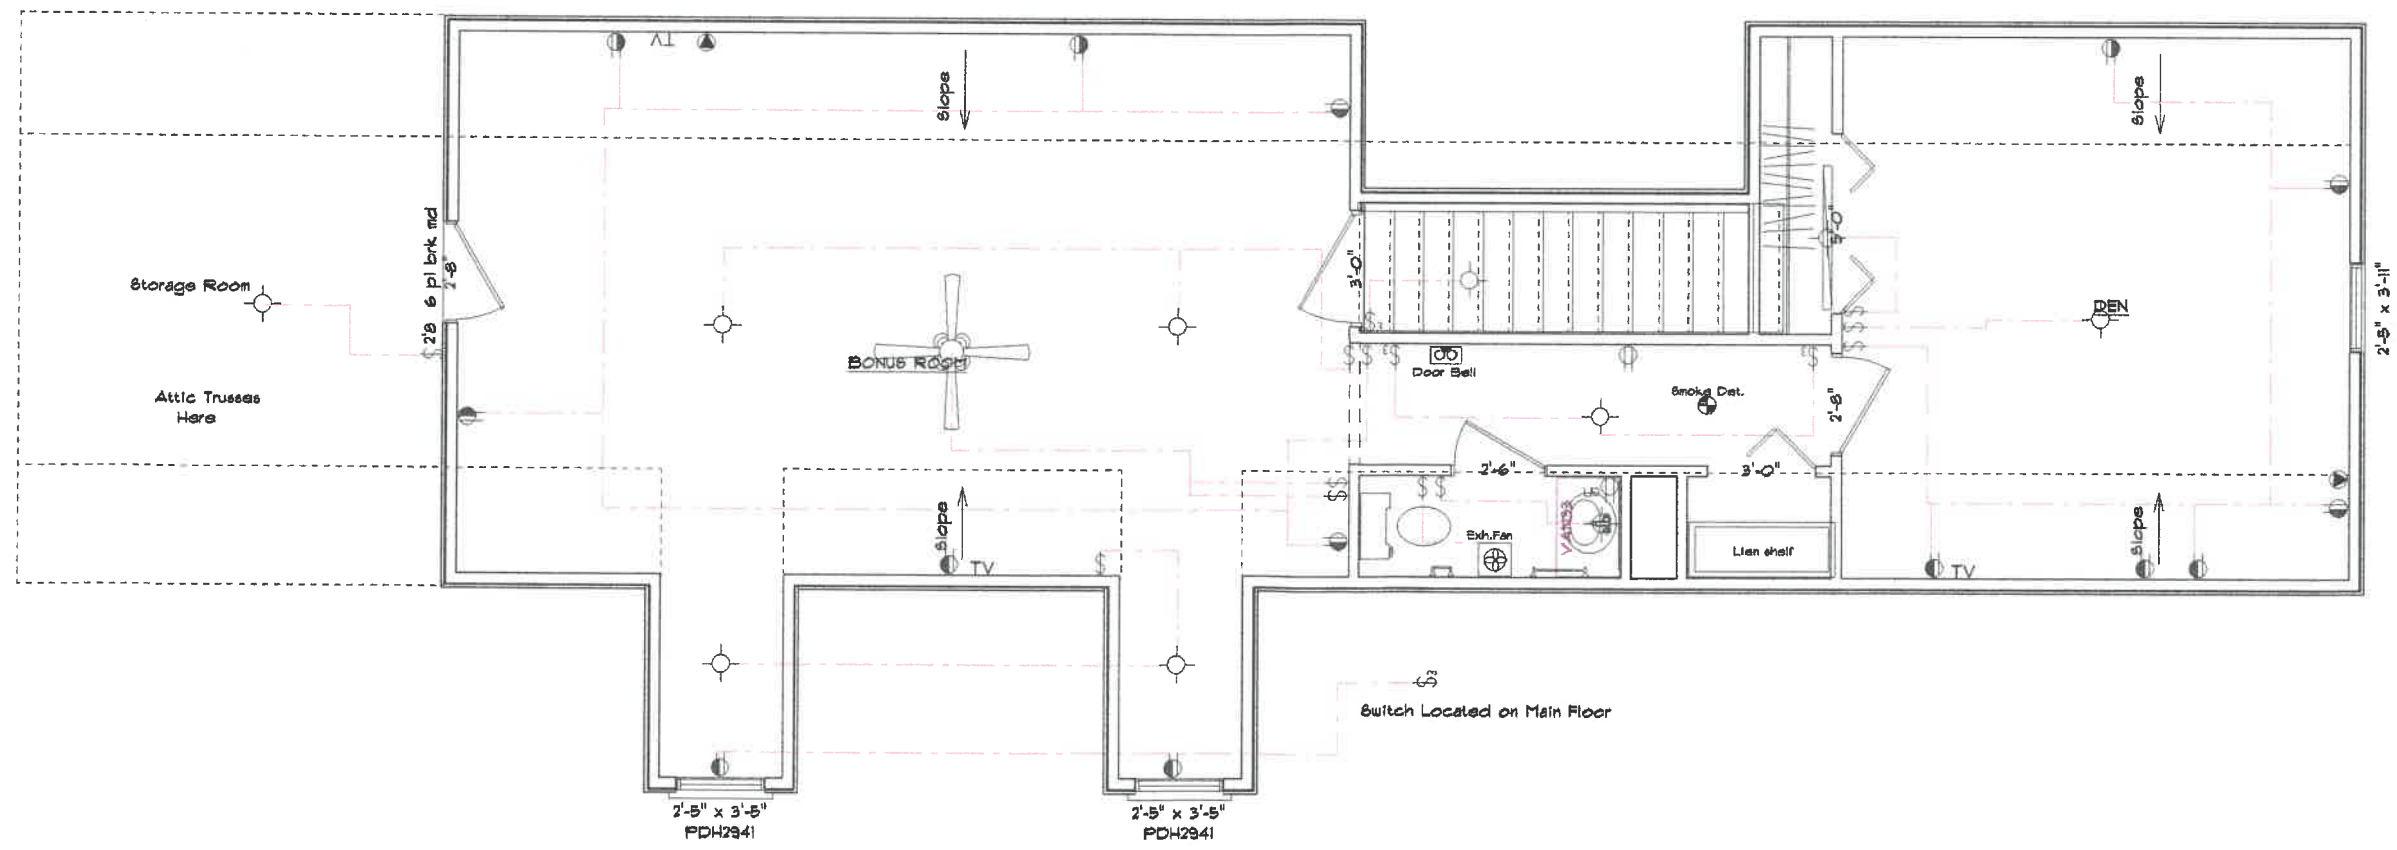

Square Footage : 2nd Floor 730

2ND FLOOR ELECTRICAL PLAN

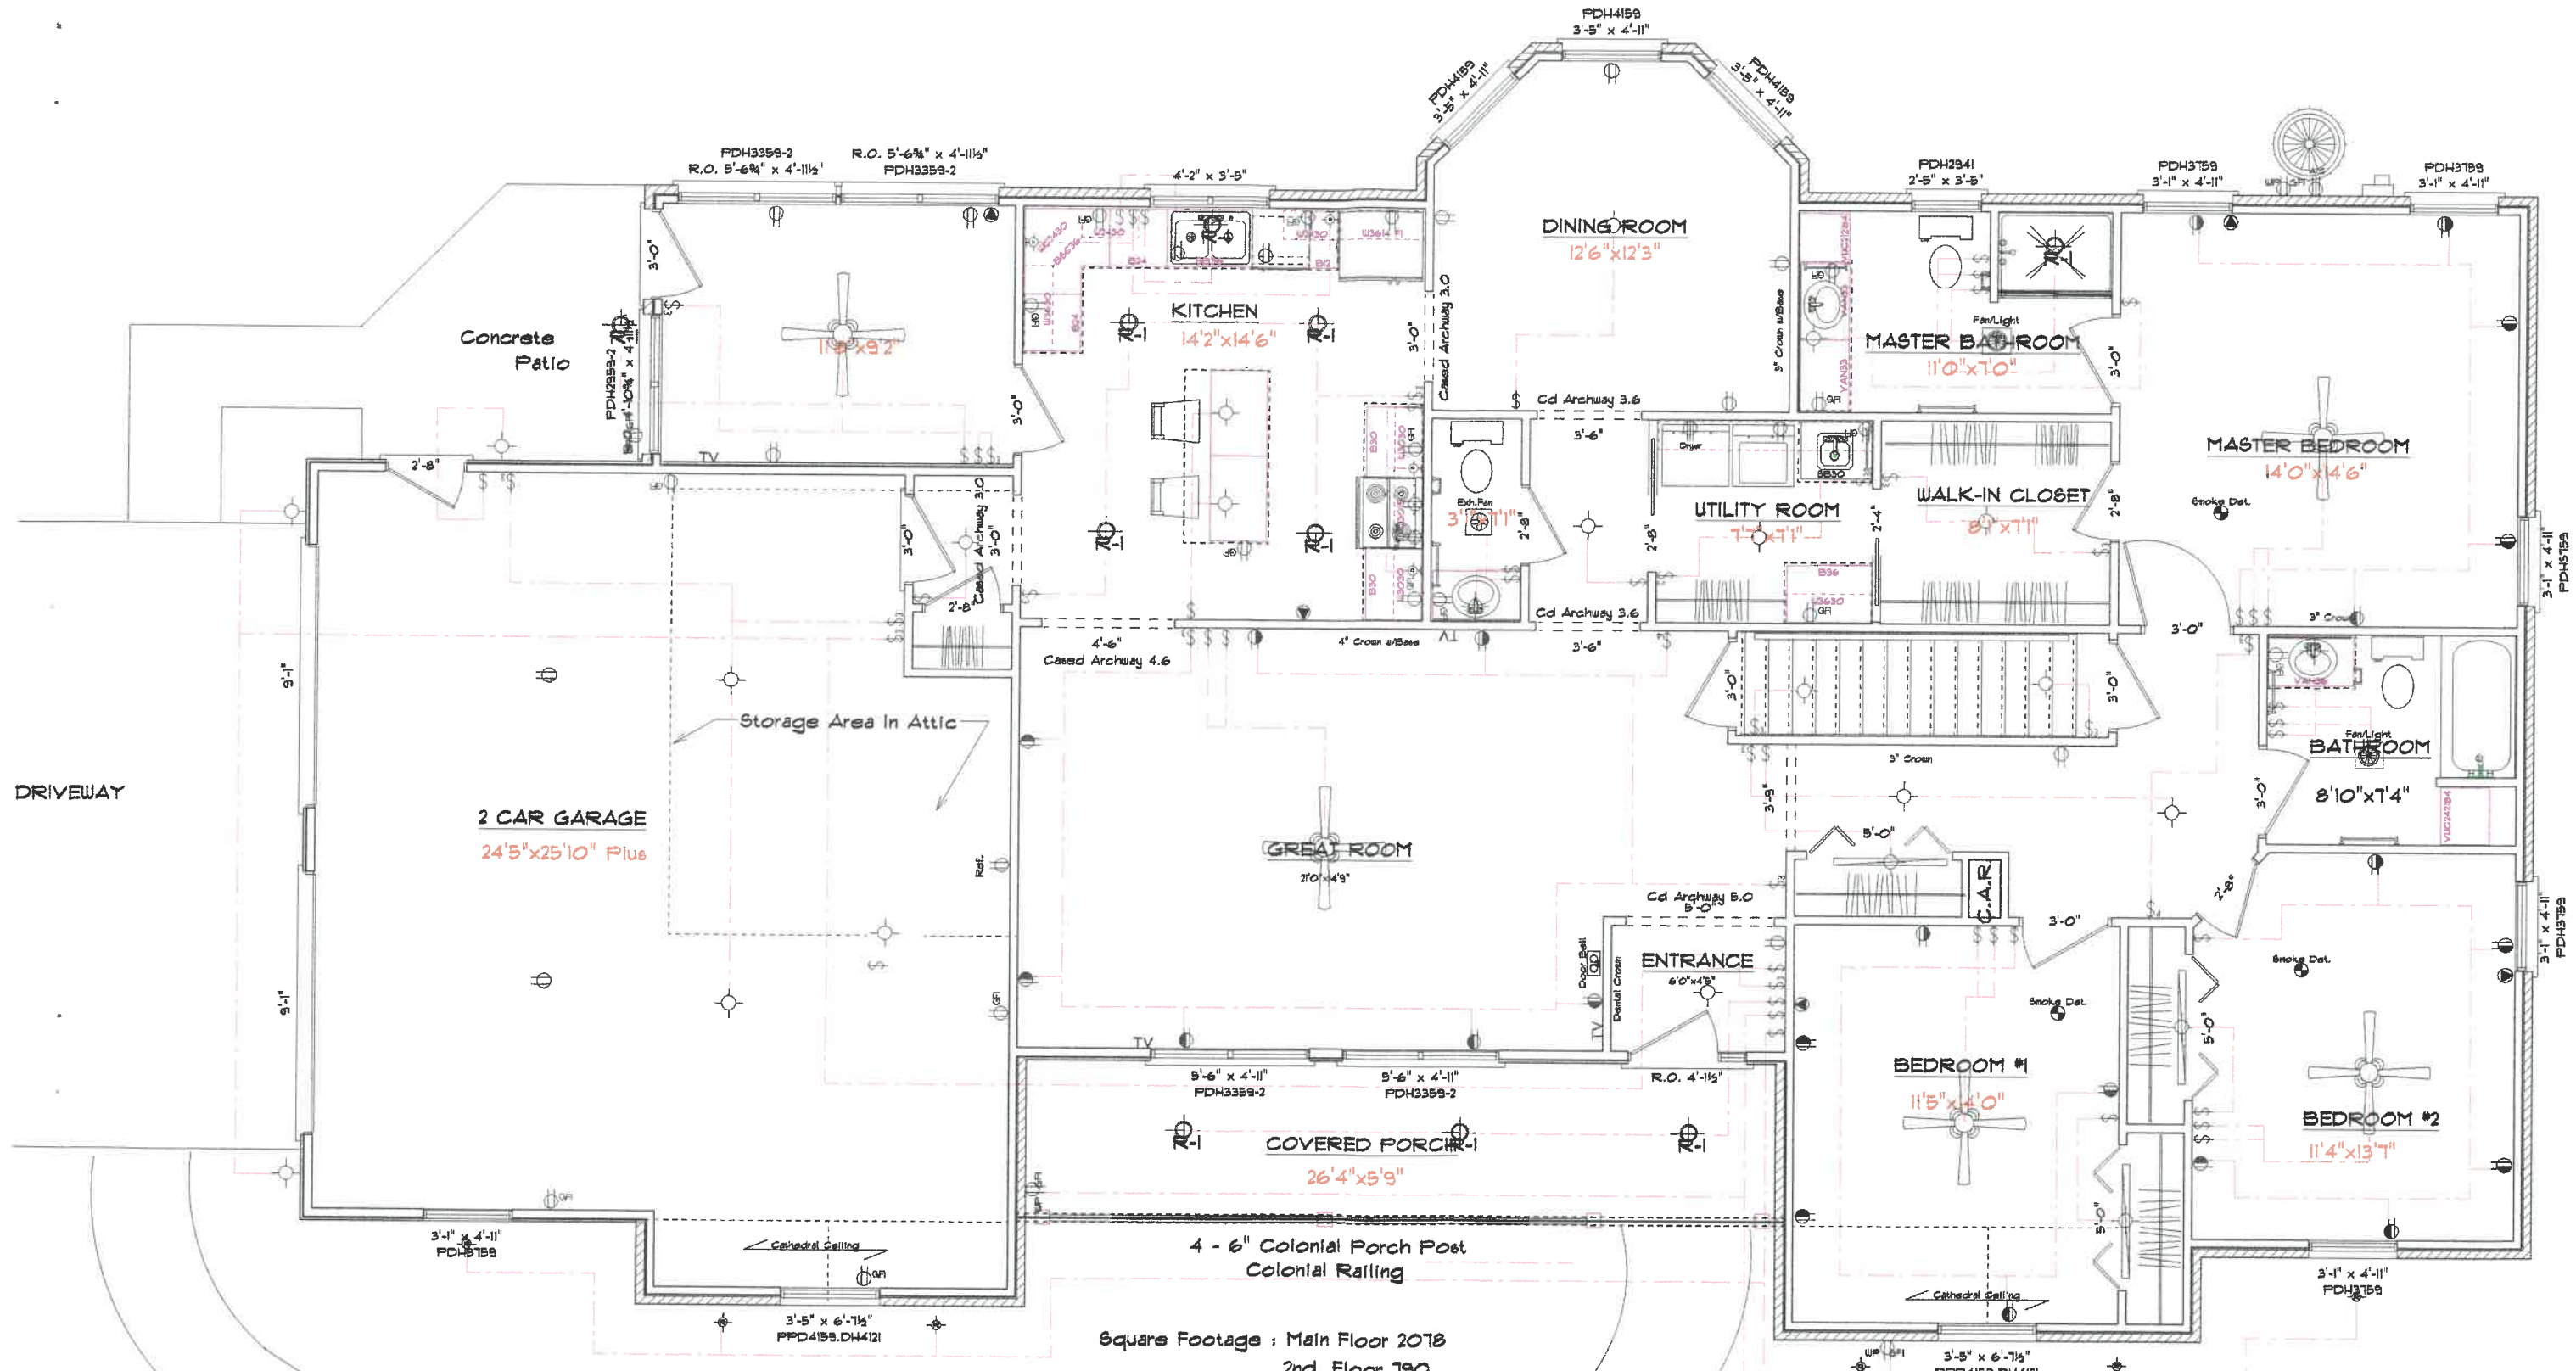


Squares Footage : Main Floor 2018
 2nd. Floor 190
 Garage 675
 Front Porch 157

Kahle Design & Build	
Defiance, Oh	Phone 497-4805
Scale: Var. 1/8" = 1'-0"	Date 2-24-04
Mr. & Mrs. D. Bockelman	
Location : Bales Rd., Napoleon	

ELECTRICAL PLAN

BRIARHEATH AVE.

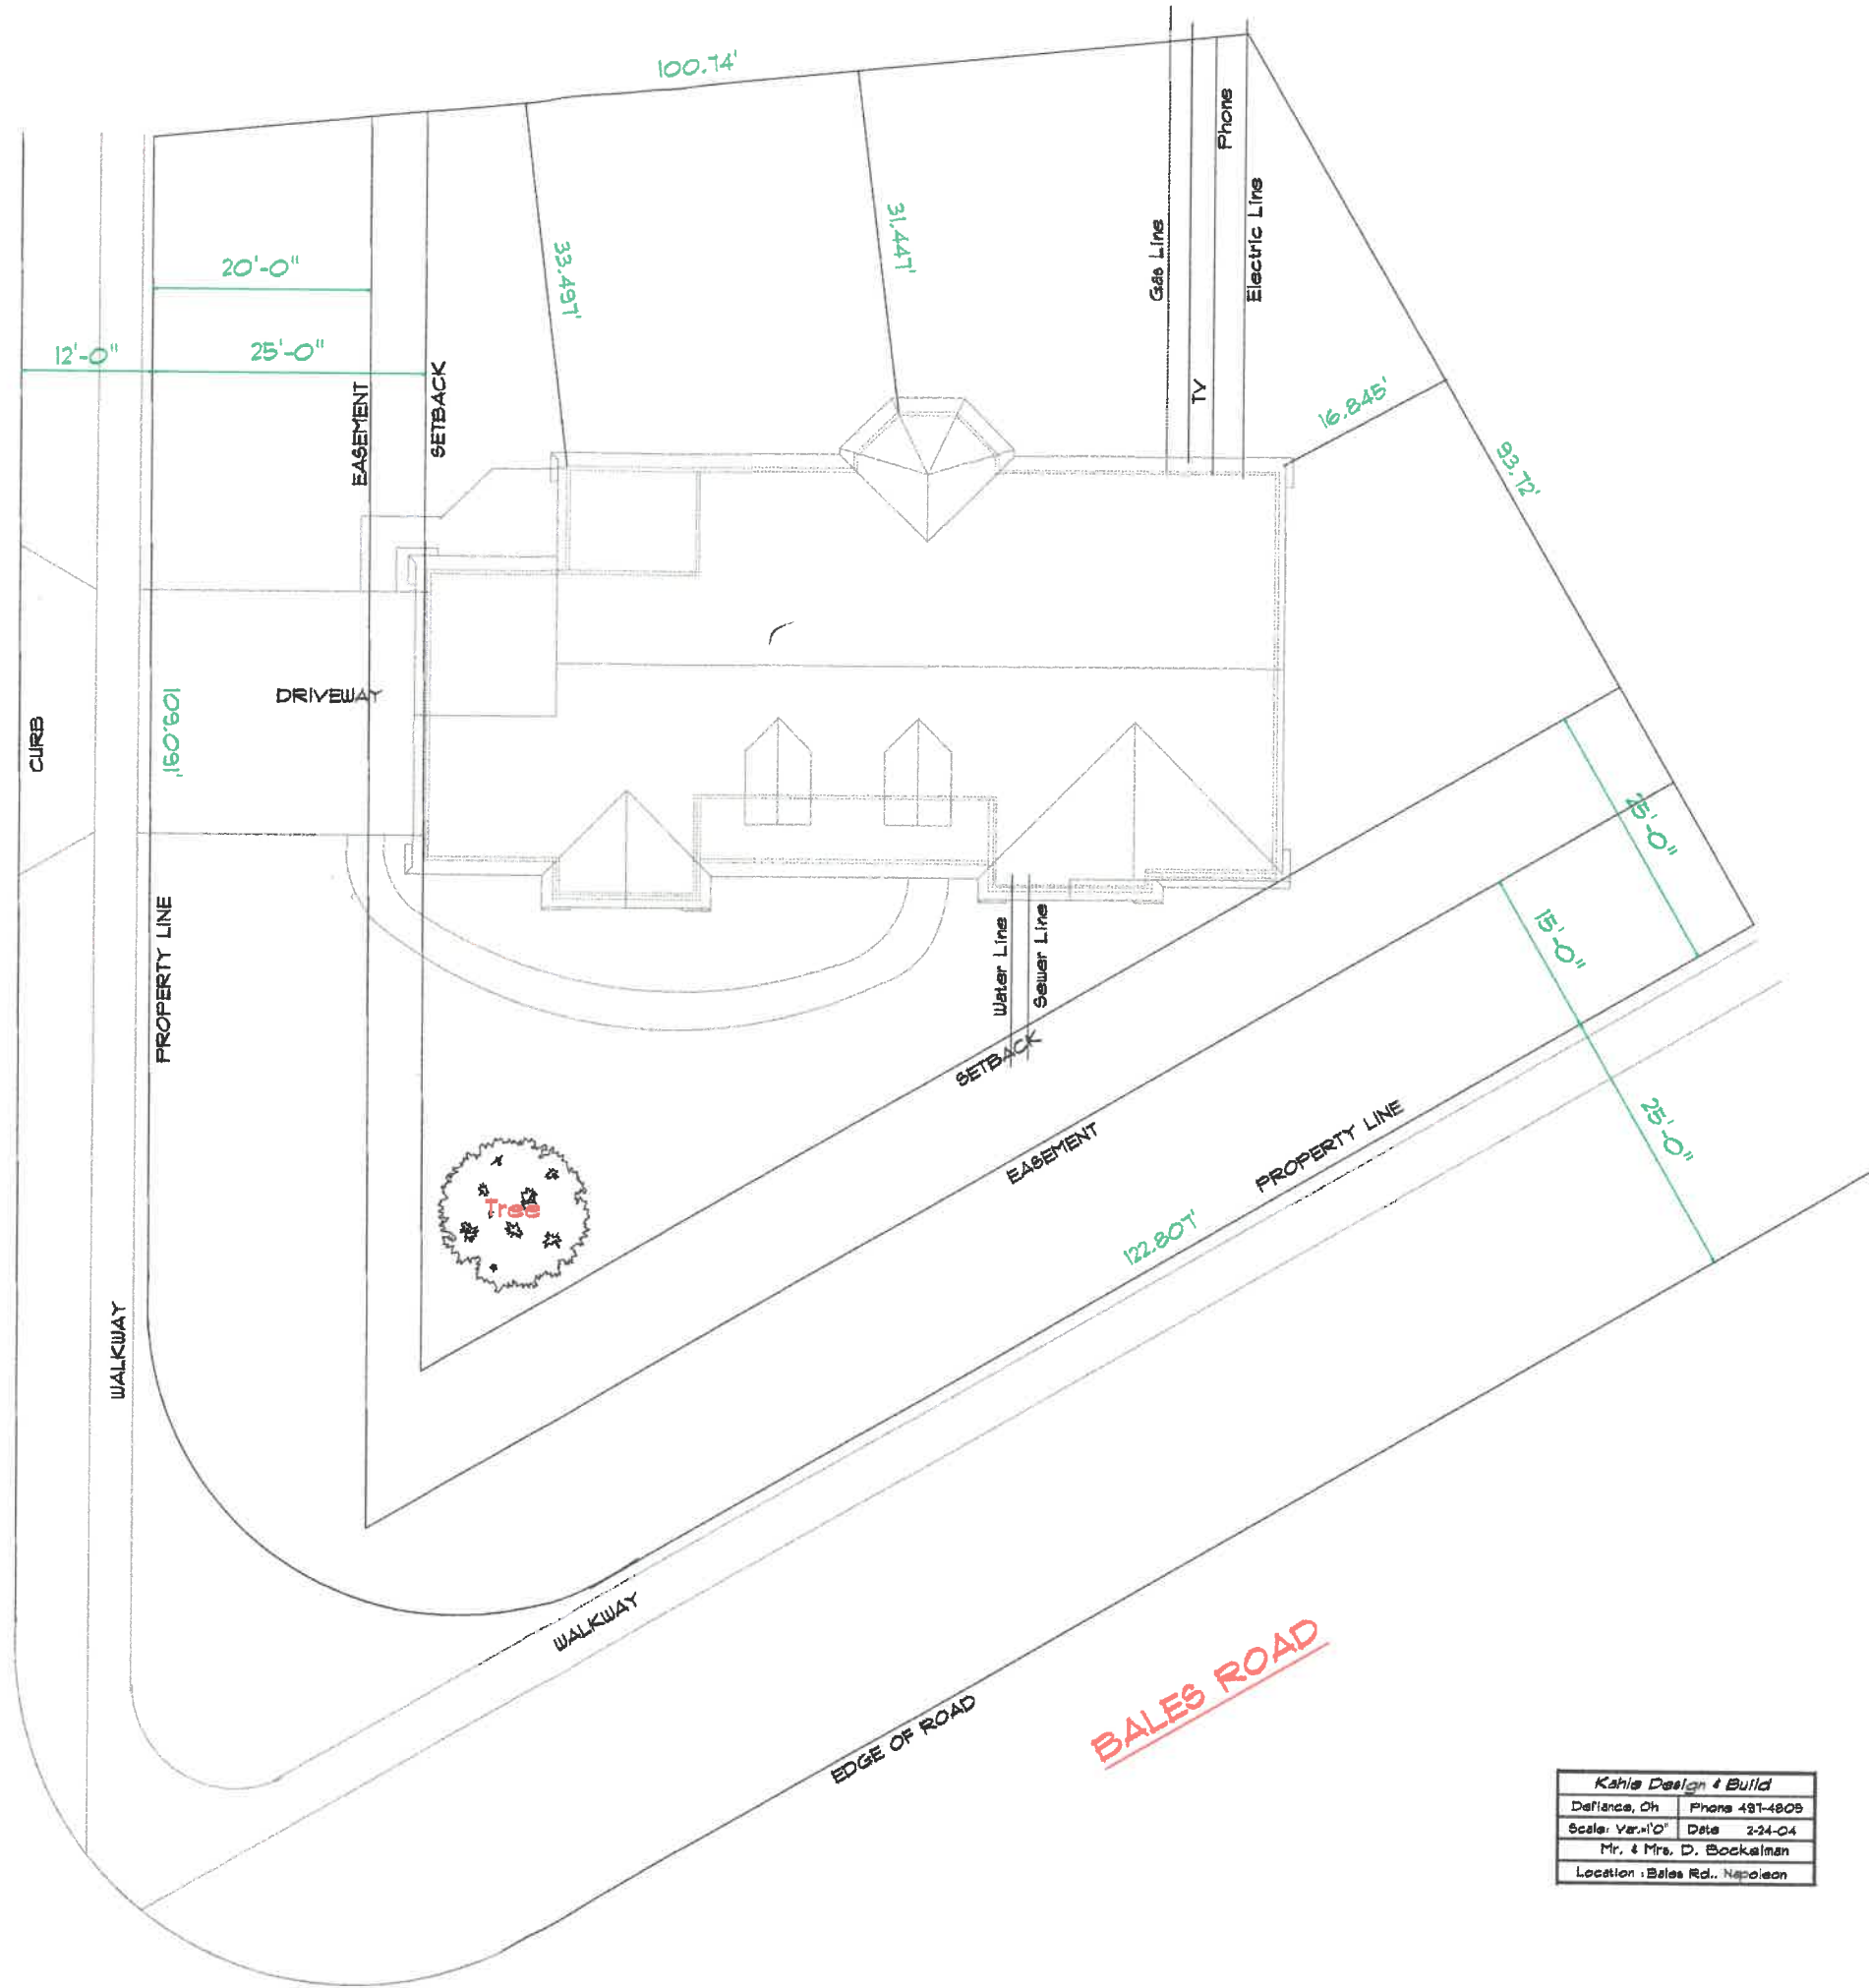


BALES ROAD

Kahle Design & Build	
Defiance, Oh	Phone 481-4805
Scale: Var.'0"	Date: 2-24-04
Mr. & Mrs. D. Bockelman	
Location: Bales Rd., Napoleon	

J.R.K.
9-28-04

BRIARHEATH AVE.

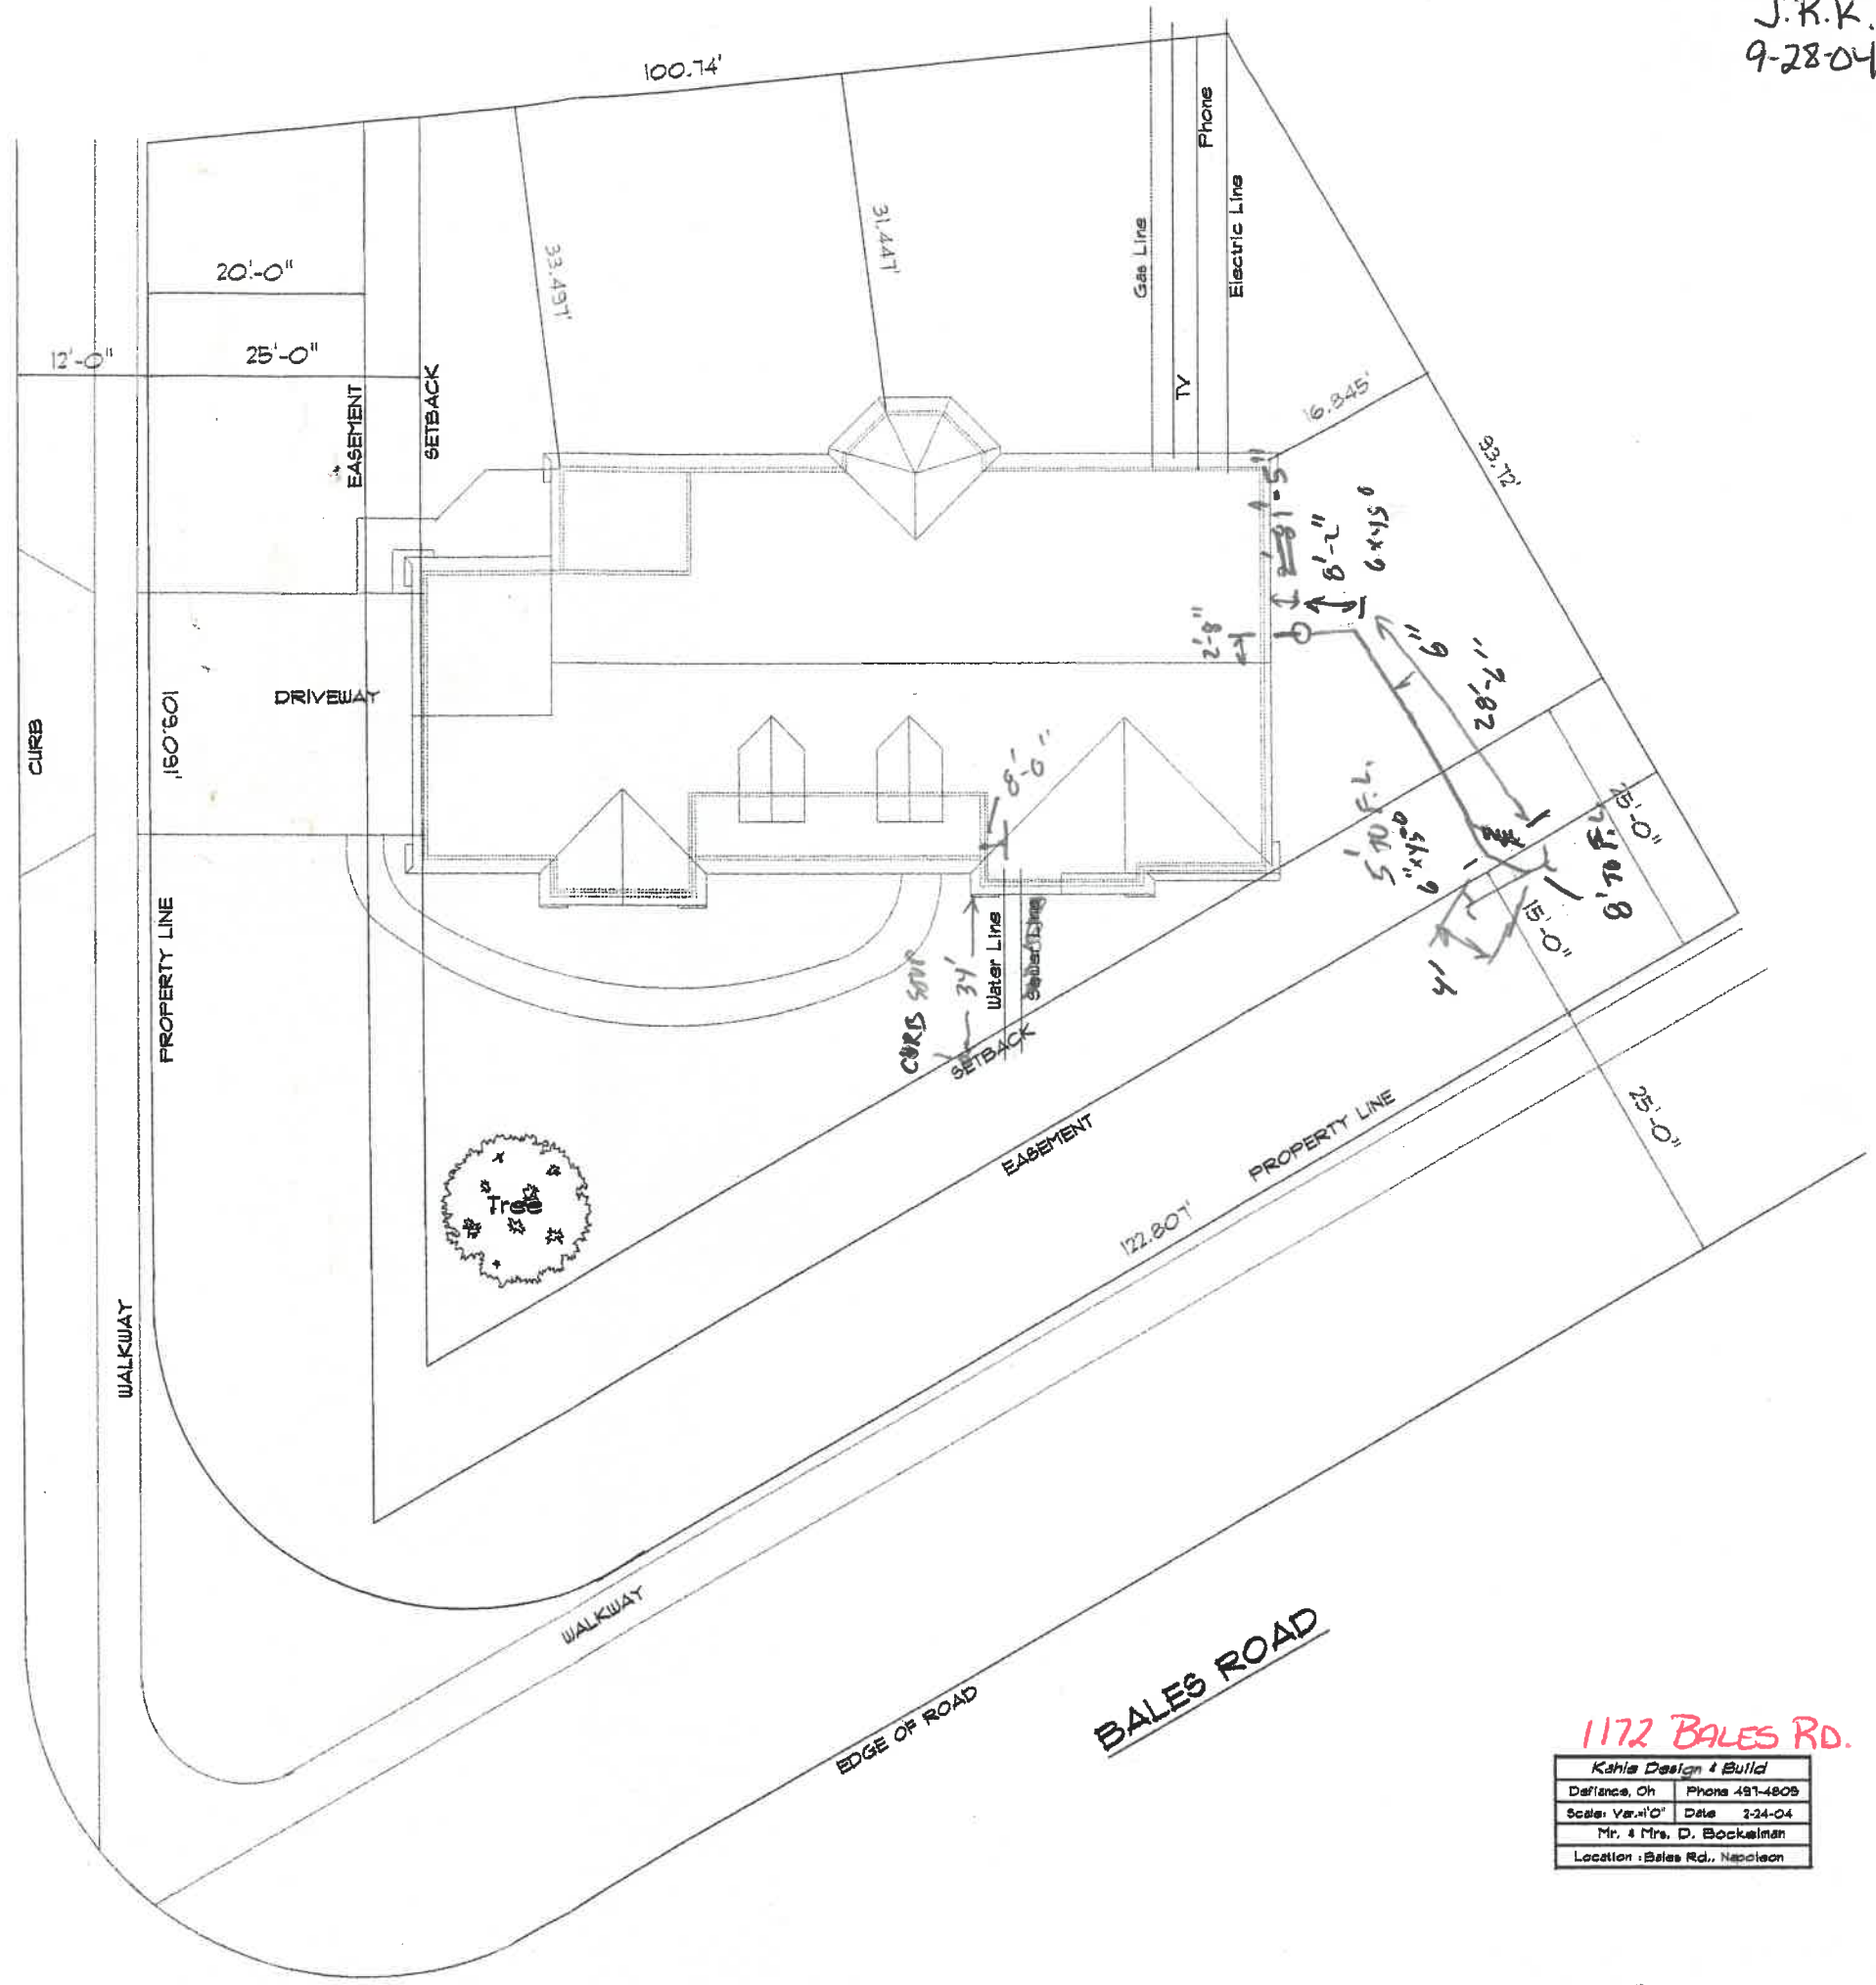

BALES ROAD

1172 BALES RD.

Kahle Design & Build	
Dallence, Oh	Phone 487-4805
Scale: Var.'0'	Date: 2-24-04
Mr. & Mrs. D. Bockelman	
Location: Bales Rd., Napoleon	