
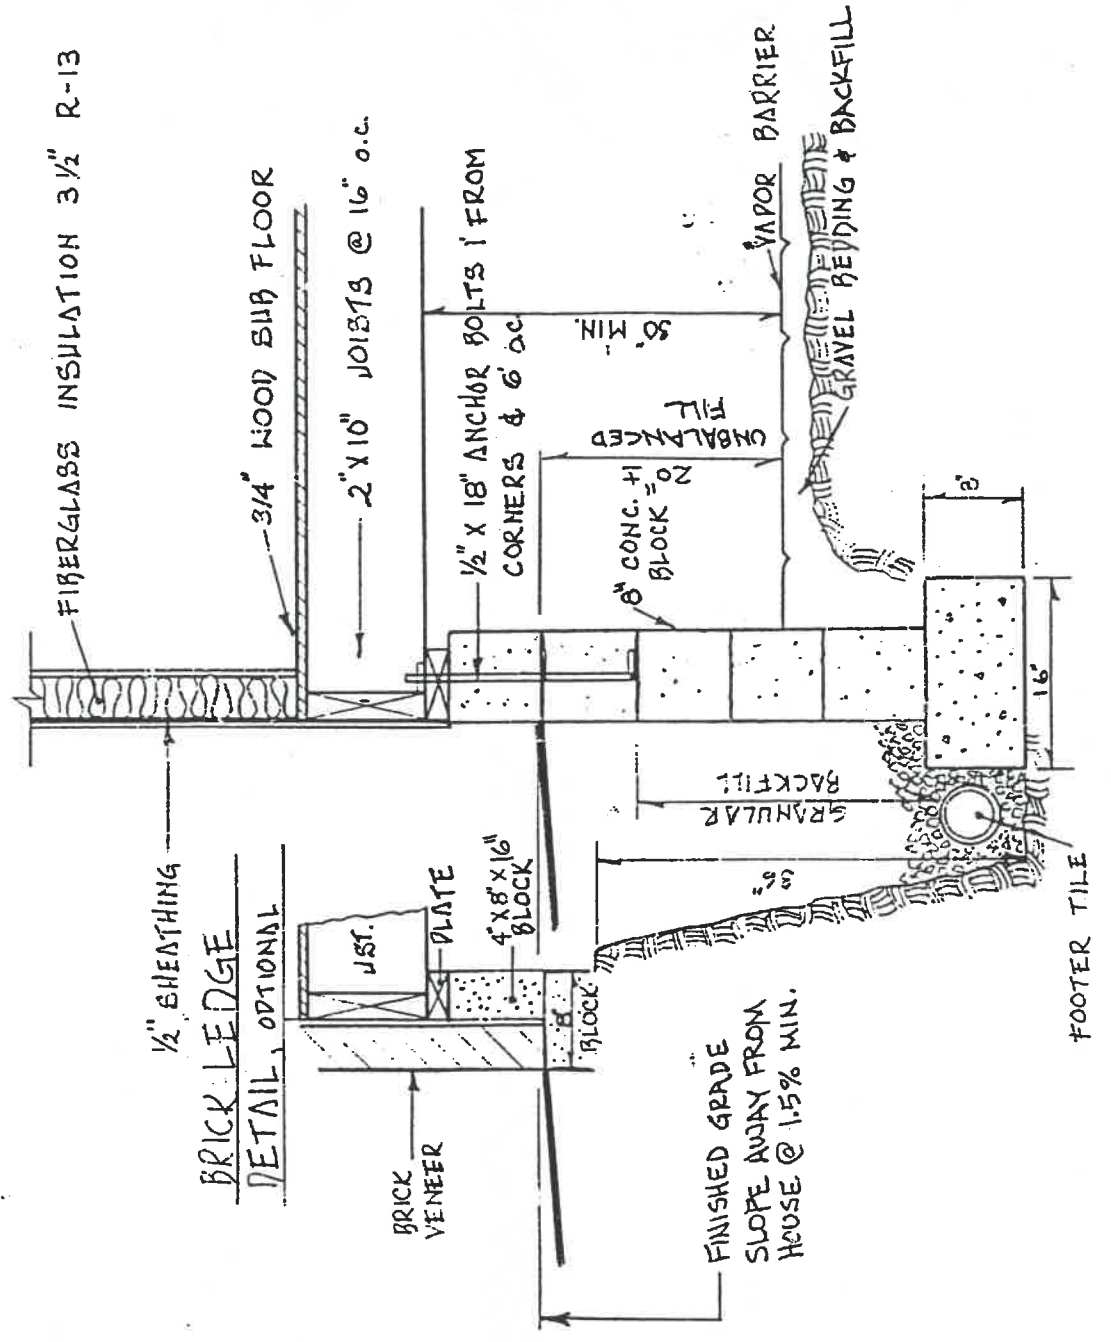


568  
Becker

NOTE: RIDGE BOARD SHALL BE  
1 SIZE LARGER THAN RAFTER.  
& NOT LESS THAN CUT END  
OF RAFTER.

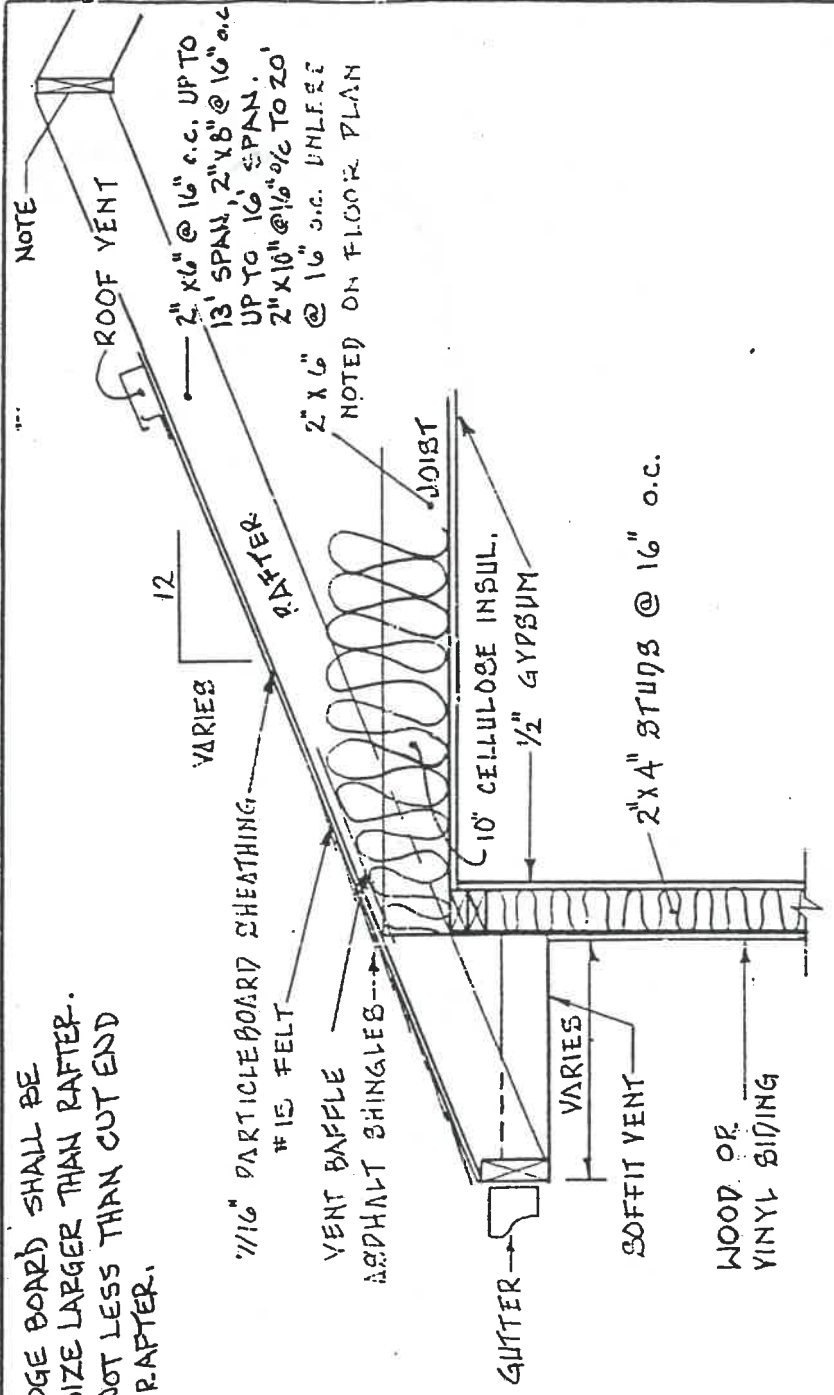


TYPICAL CROSS-SECTION  
9/4" = 1'-0"

R.D. 5

AUG, 1986


# TYPICAL SECTION


1/2" = 1'-0"

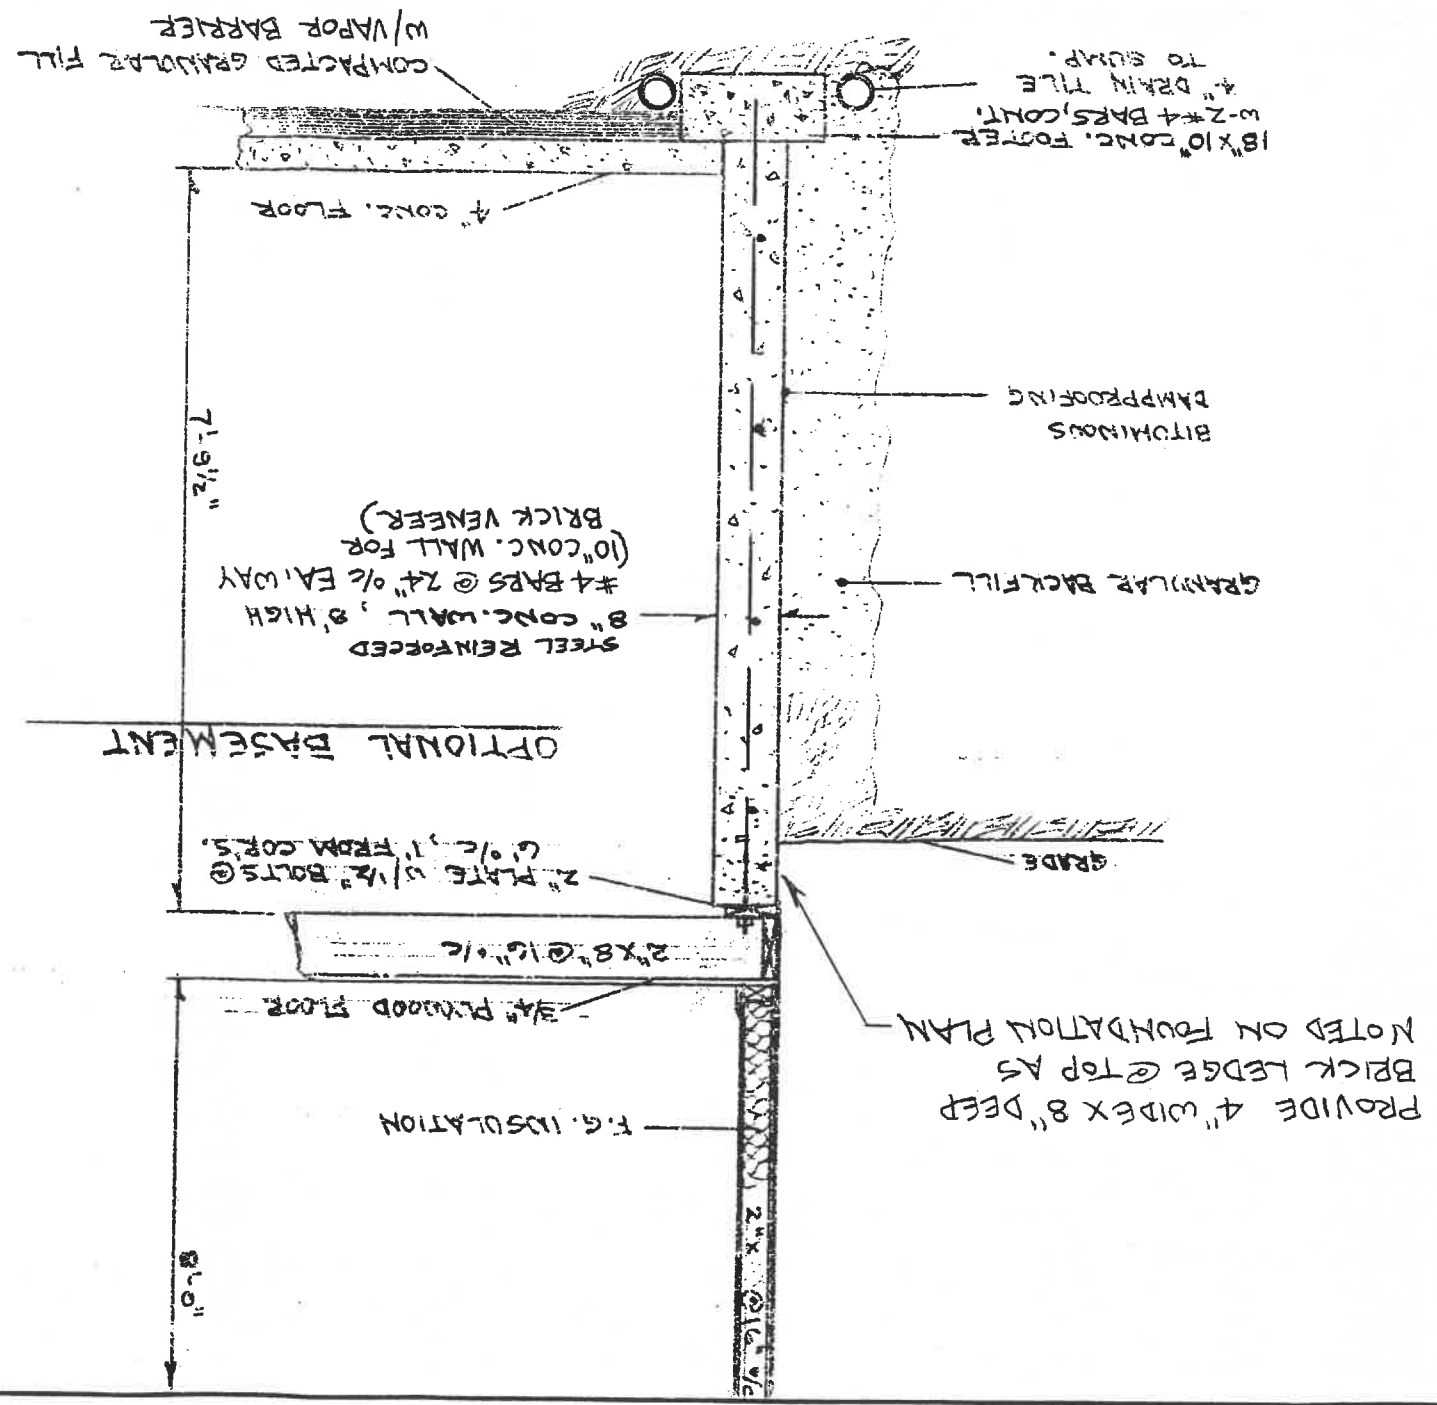

OPTIONAL BASEMENT

PROVIDE 4" WIDE X 8" DEEP BRICK LEDGE @ TOP AS NOTED ON FOUNDATION PLAN

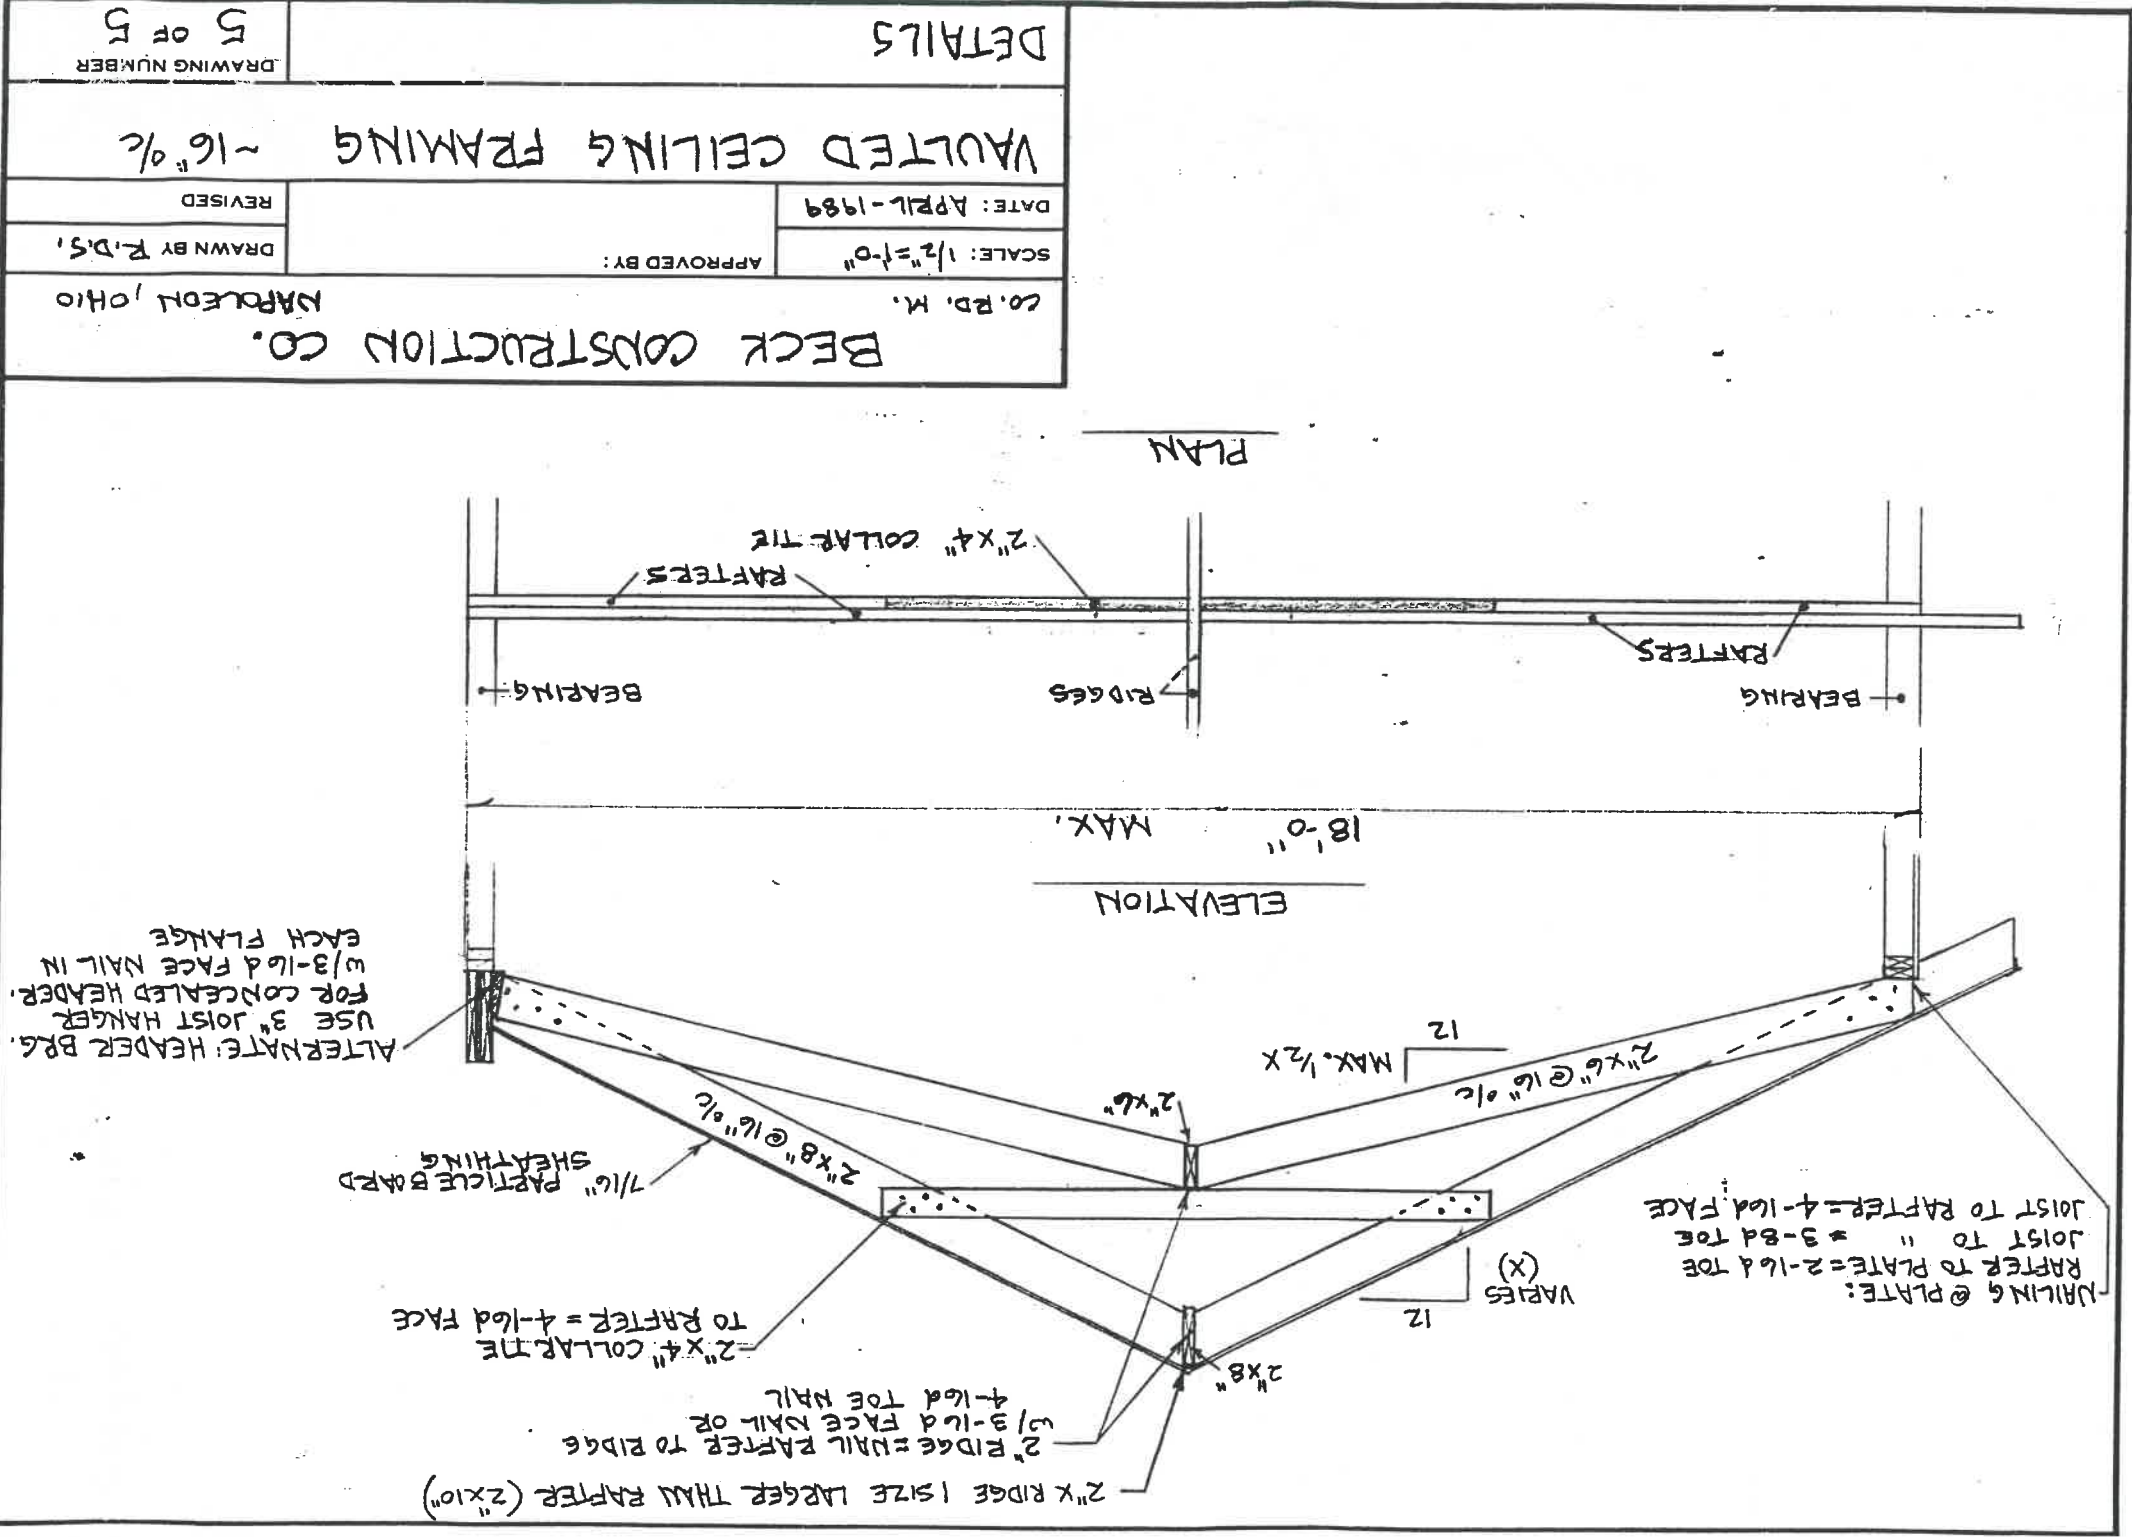

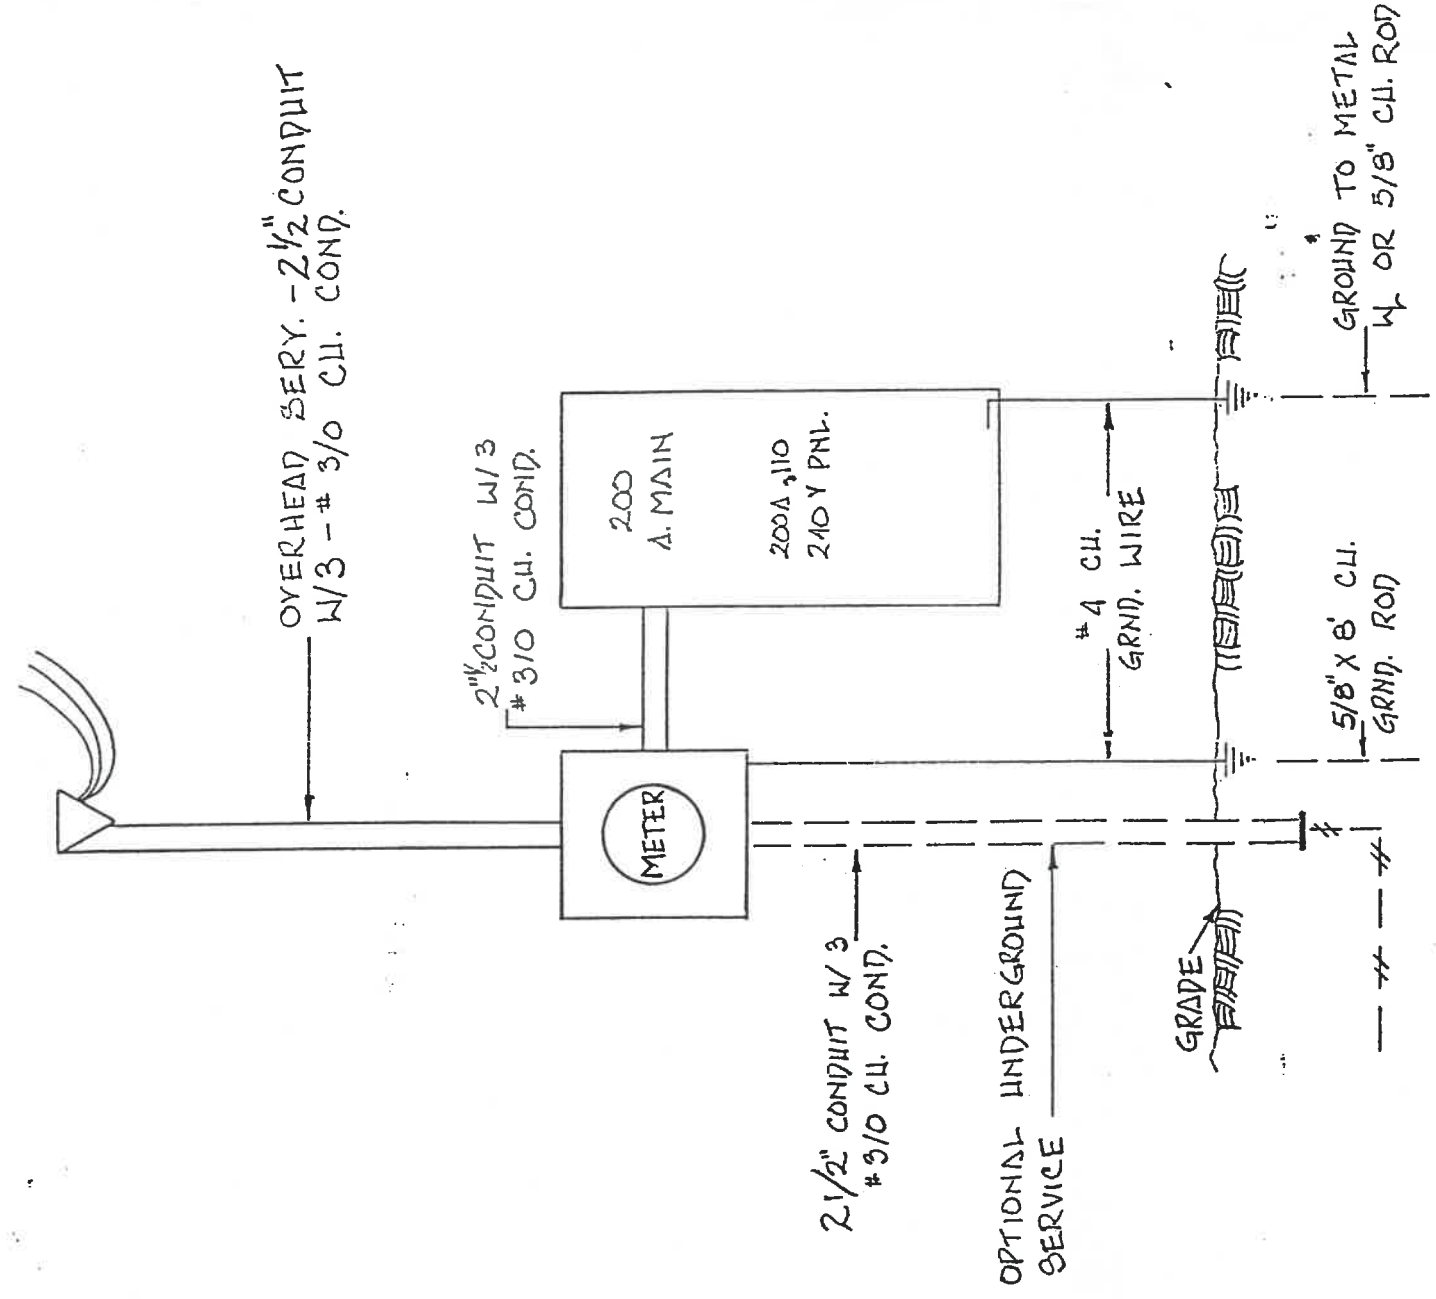

ELECTRICAL RISER DIAGRAM

NO SCALE