




FRONT ELEVATION
1/4"=1'-0"

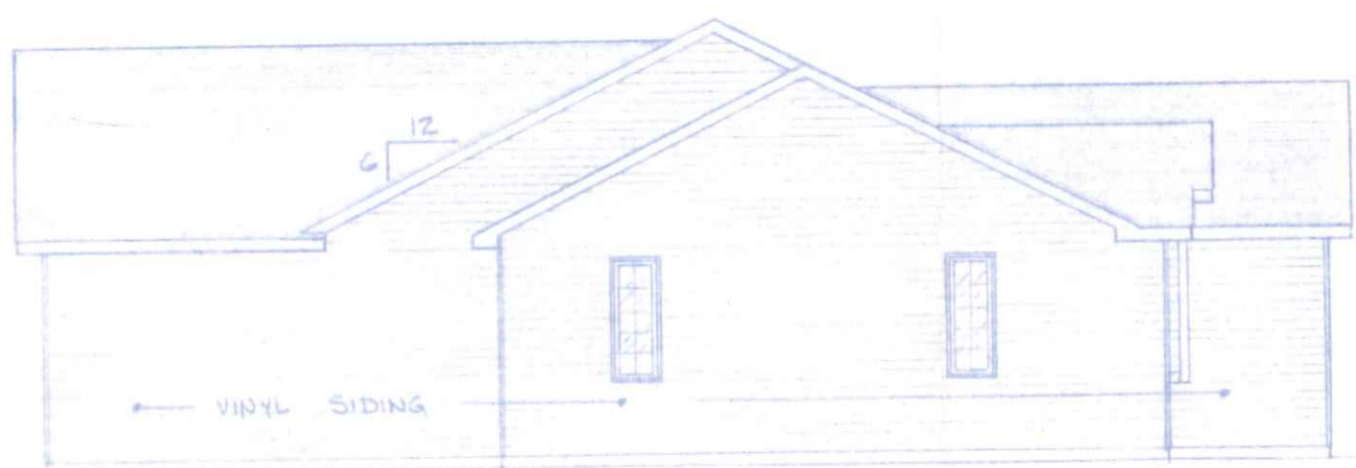

LEFT SIDE ELEVATION
1/8"=1'-0"

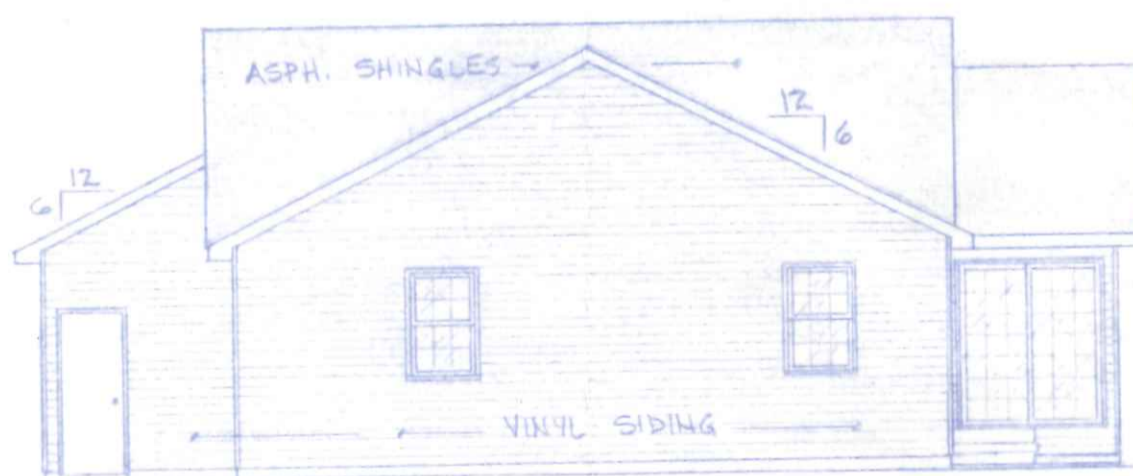


REAR ELEVATION
1/8"=1'-0"

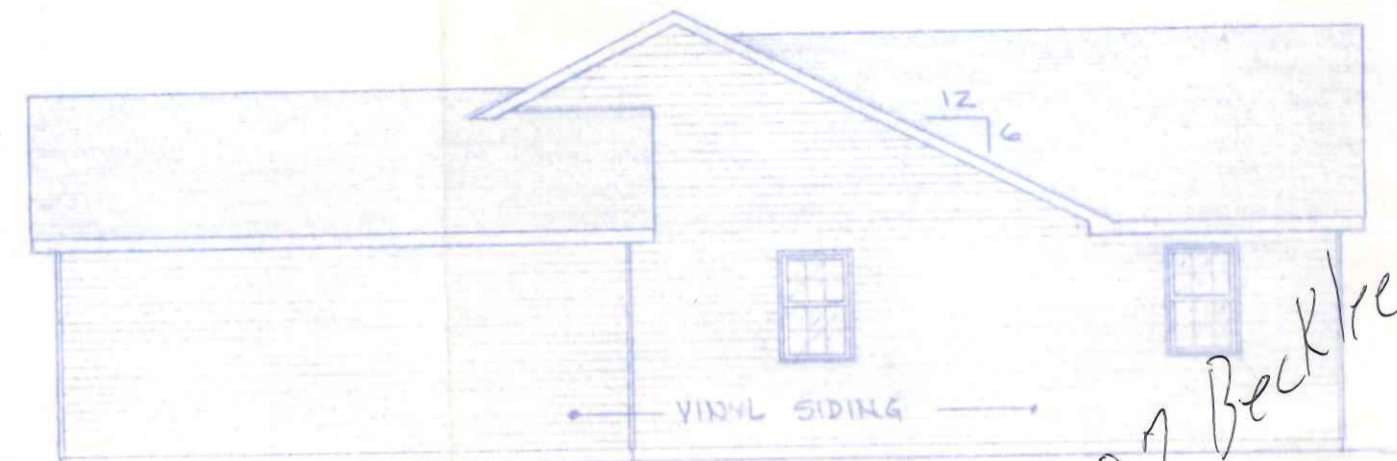

RIGHT SIDE ELEVATION
1/8"=1'-0"

587 Beck/ke

BECK CONSTRUCTION CO. CO. RD. M. NAPOLEON, OHIO		
SCALE NOTED	APPROVED BY:	DRAWN BY R.D.S.
DATE MAR. '85		REVISED
EXTERIOR ELEVATIONS		
PLAN. NO. 236	DRAWING NUMBER 1 OF 4	

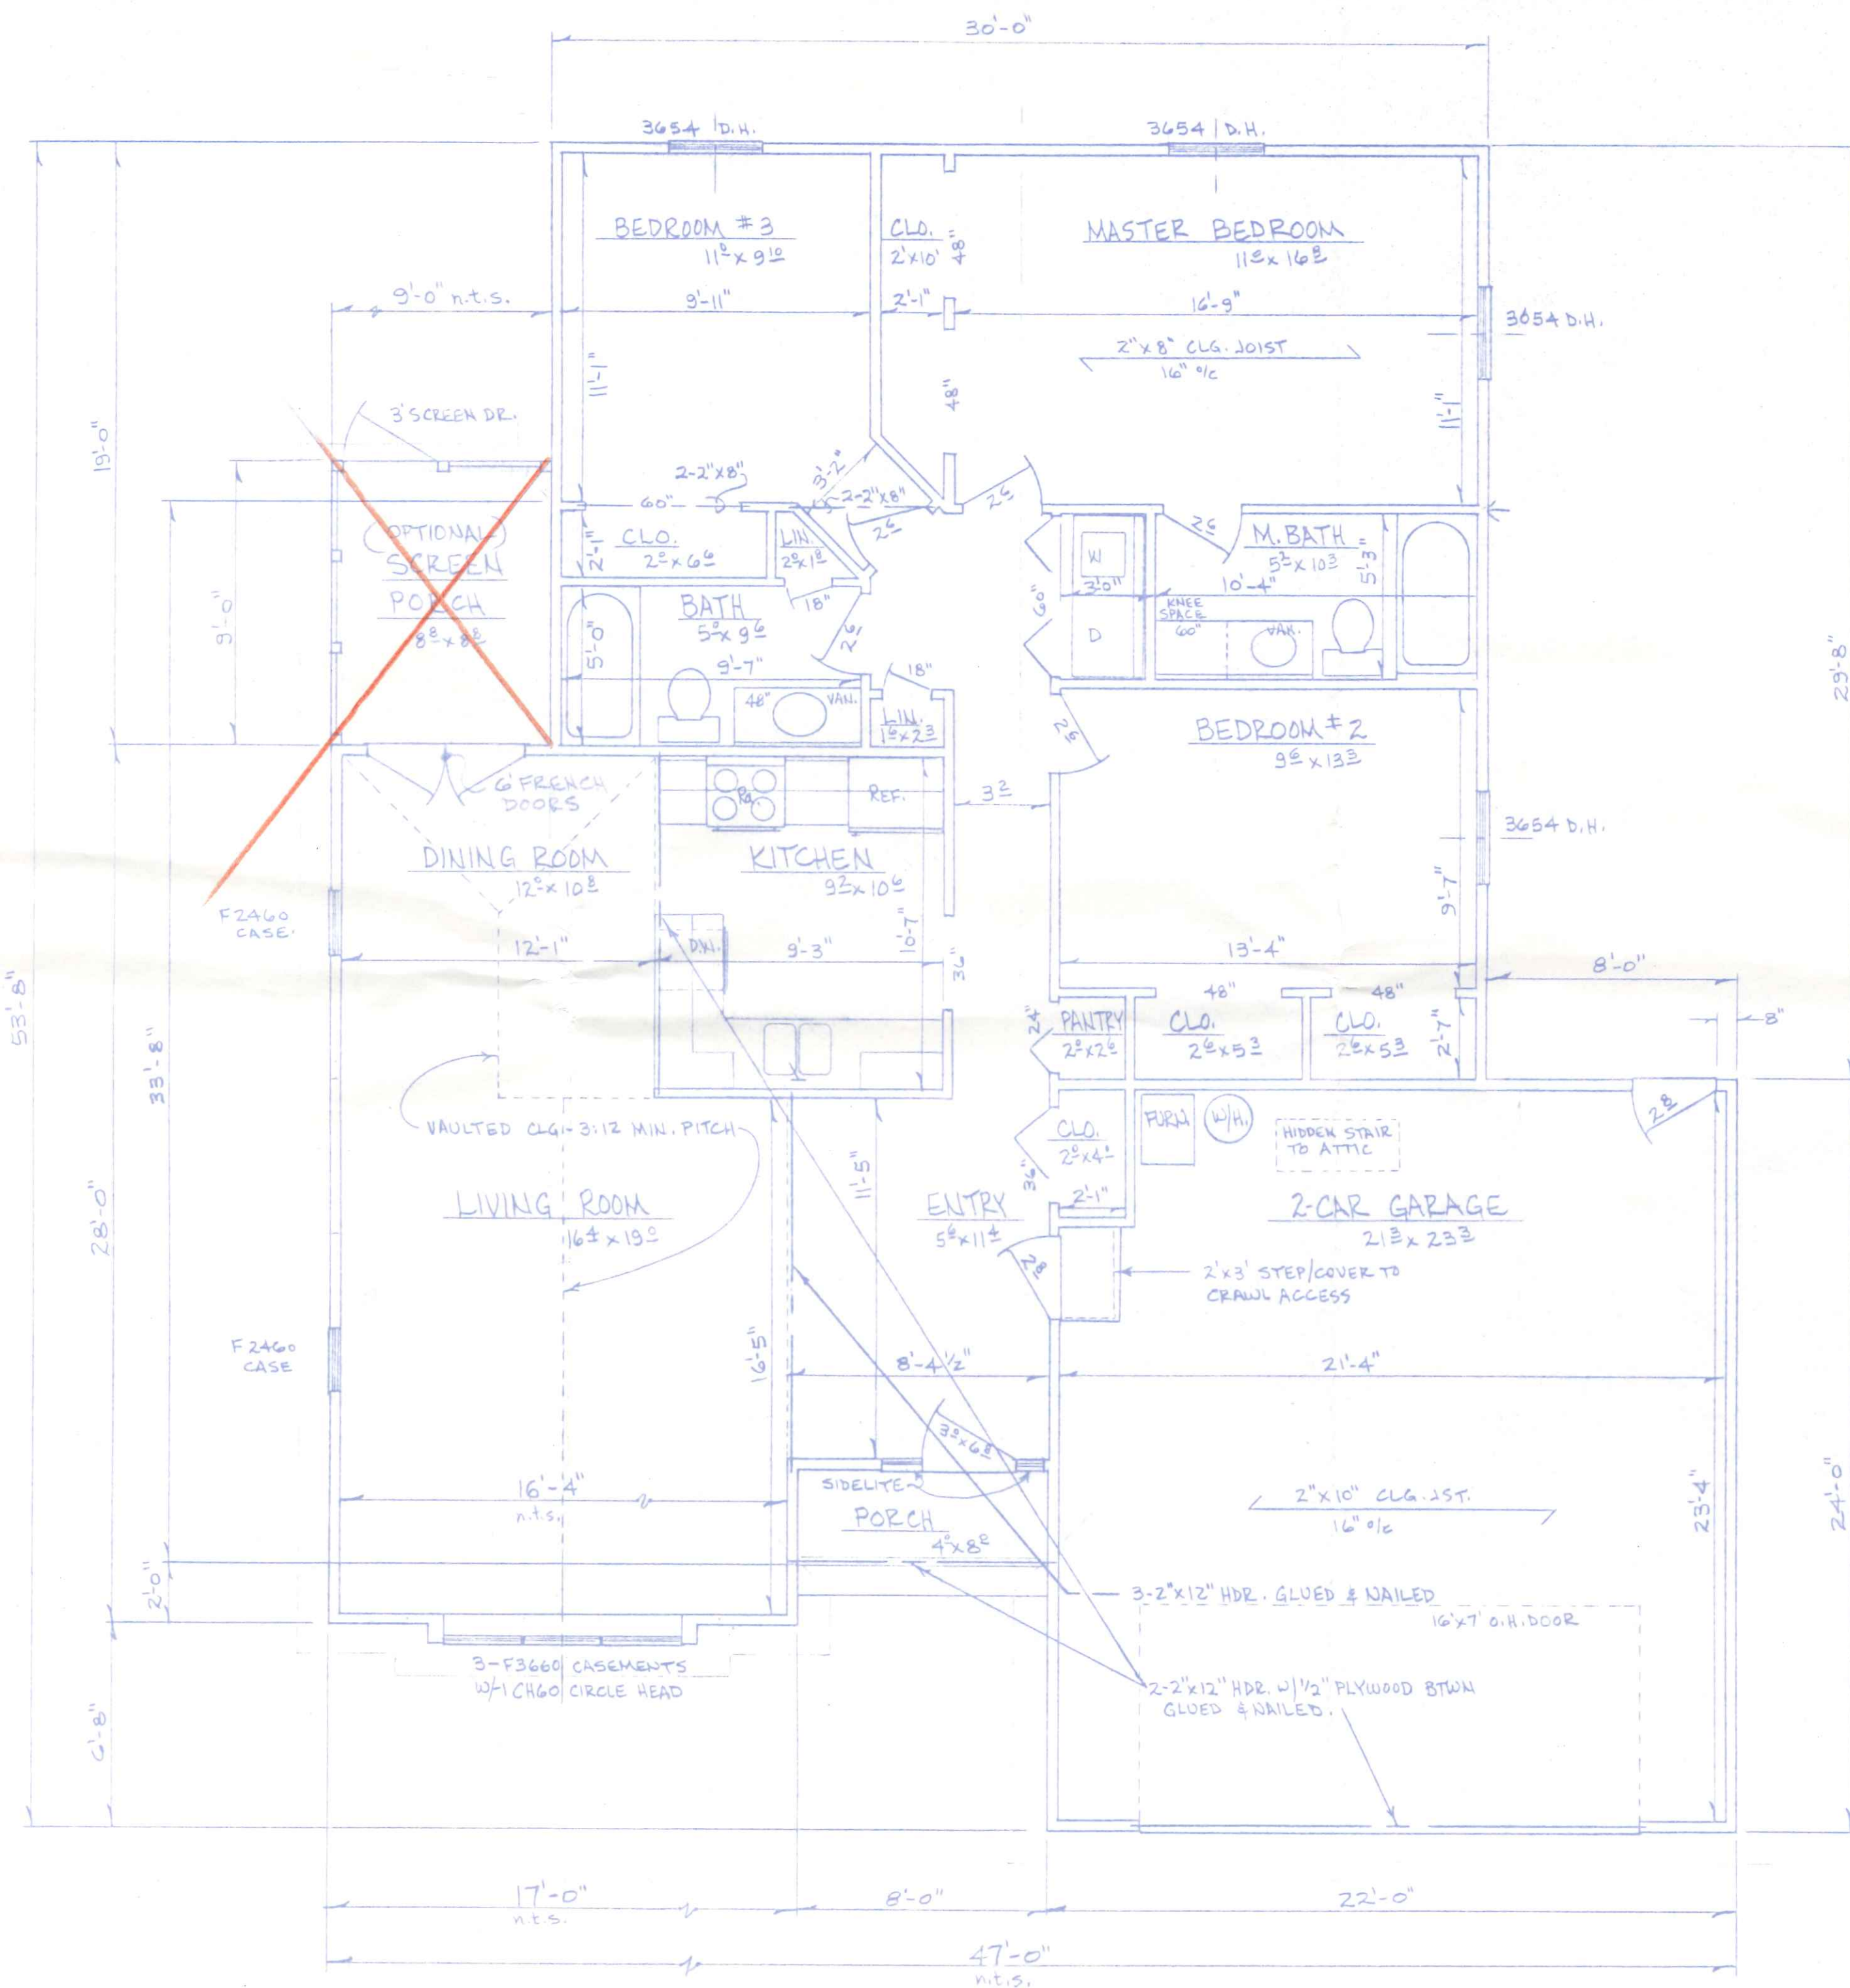

- NOTES:**
1. INTERIOR DIMENSIONS TAKEN TO STUD LINE, EXTERIOR DIMENSIONS TO OUTSIDE OF FOUNDATION.
 2. INTERIOR DOOR HEADERS TO BE MIN. 2-2"x6", EXTERIOR OPENING HEADERS TO BE MIN. 2-2"x6" FOR OPENINGS UP TO 4' WIDE, 2-2"x8" UP TO 8'0", & AS OTHERWISE NOTED.
 3. FRAMING LUMBER TO BE MIN. #2 S.P.F. KILN DRIED.

GROSS LIVING AREA = 1398.2 SQ. FT.
 " GARAGE " = 509.0 " "
 " PORCHES " = 113.0 " "

BECK CONSTRUCTION CO.		
CO. P.D. M.	NAPOLEON, OHIO	
SCALE: 1/4" = 1'-0"	APPROVED BY:	DRAWN BY R.D.S.
DATE: MAR. '89		REVISED 9-92
FLOOR PLAN		
PLAN NO. 236-C		DRAWING NUMBER 2 OF 4

LEGEND



- ⊙ CEILING LIGHT
- ⊙ WALL LIGHT
- ⊙ CEILING CIRCULATING FAN
- ⊙ CEILING LIGHT WITH CIRCULATING FAN
- ⊙ CEILING LIGHT WITH EXHAUST FAN
- ⊙ EXTERIOR FLOOR LIGHT
- ⊙ PRIMARY POWERED SMOKE DETECTOR WITH BATTERY BACKUP
- ⊙ SPECIAL OUTLET AS NOTED
- ⊙ 120V - 20A DUPLEX RECEPTACLE
- ⊙ 120V - 20A DUPLEX RECEPTACLE SWITCHED
- ⊙ 120V - 20A DUPLEX RECEPTACLE WITH G.F.C.I. PROTECTION
- ⊙ 240V APPLIANCE OUTLET
- ⊙ 120V - 20A LIGHT SWITCH
- ⊙ 120V - 20A FAN SWITCH
- ⊙ 120V - 20A 3 WAY LIGHT SWITCH

- NOTES
- 1) See Foundation Plan for Basement Electrical
 - 2) Min. 20A. CIR., #12 Wire
 - 3) All Work and Material shall be as per National Electric Code




GROSS LIVING AREA = 1398.2 SQ. FT
 " GARAGE " = 509.0 " "

BECK CONSTRUCTION CO.	
CO. P.D. M.	NAPOLÉON, OHIO
SCALE: 1/4" = 1'-0"	APPROVED BY:
DATE: MAR, '89	DRAWN BY P.D.S.
FLOOR PLAN - ELECTRIC & HEATING	
PLAN NO. 236	DRAWING NUMBER 3 OF 4

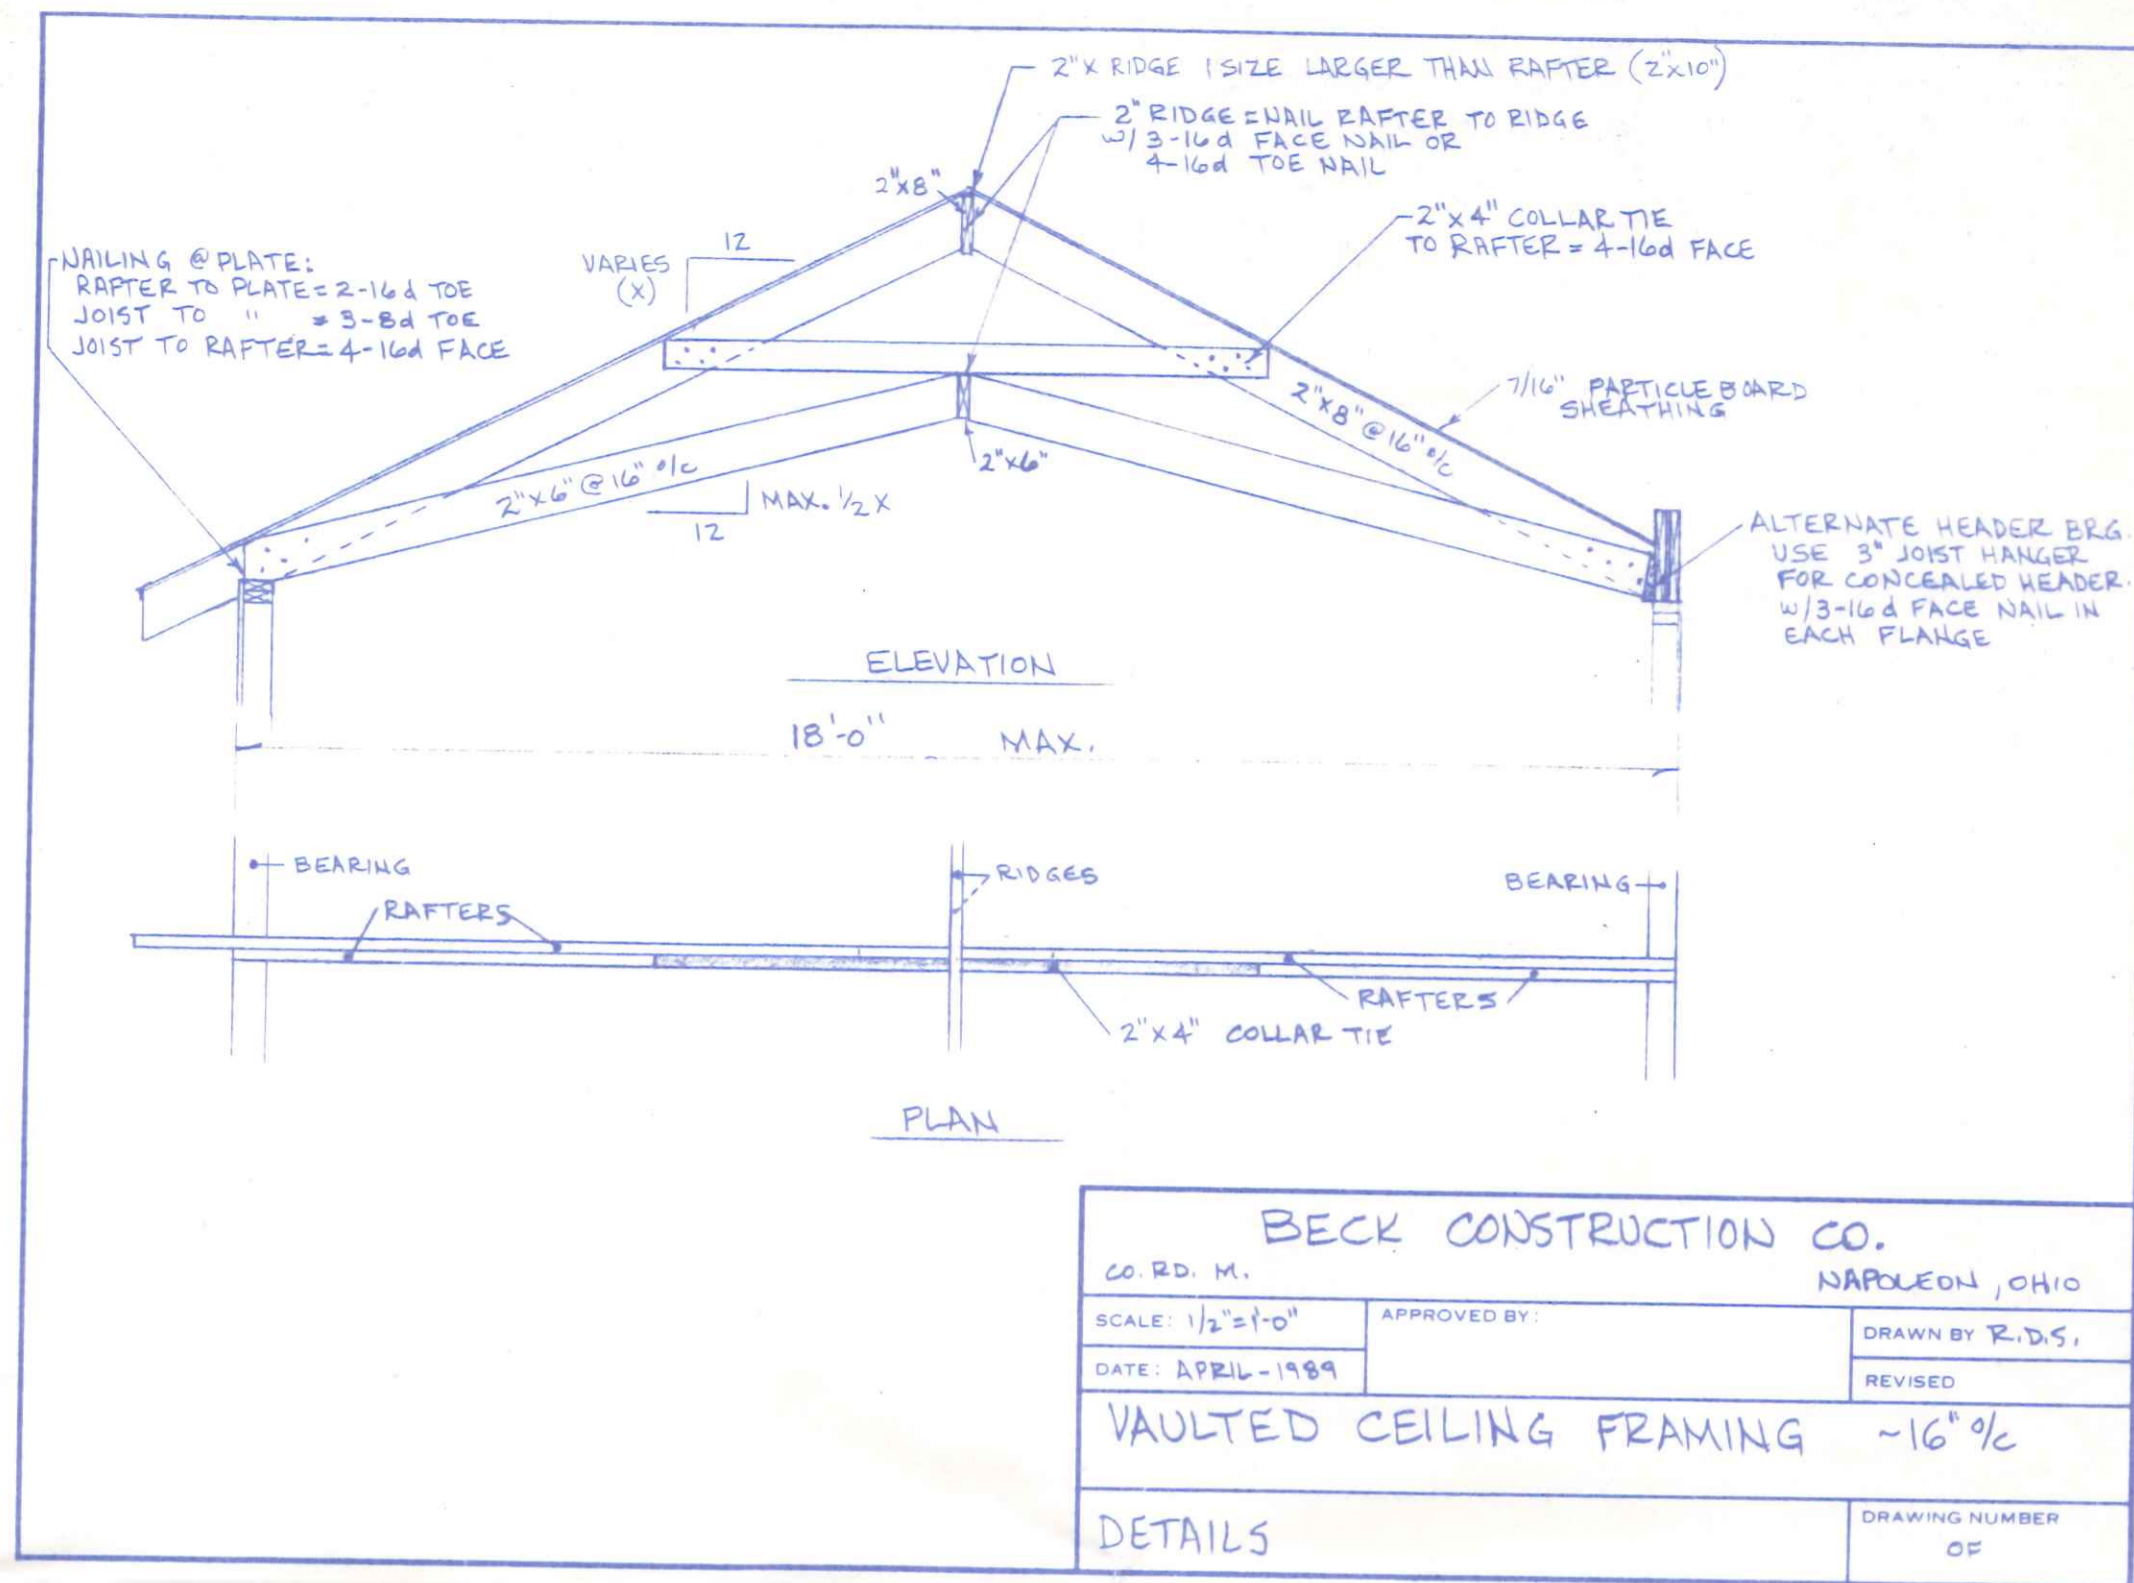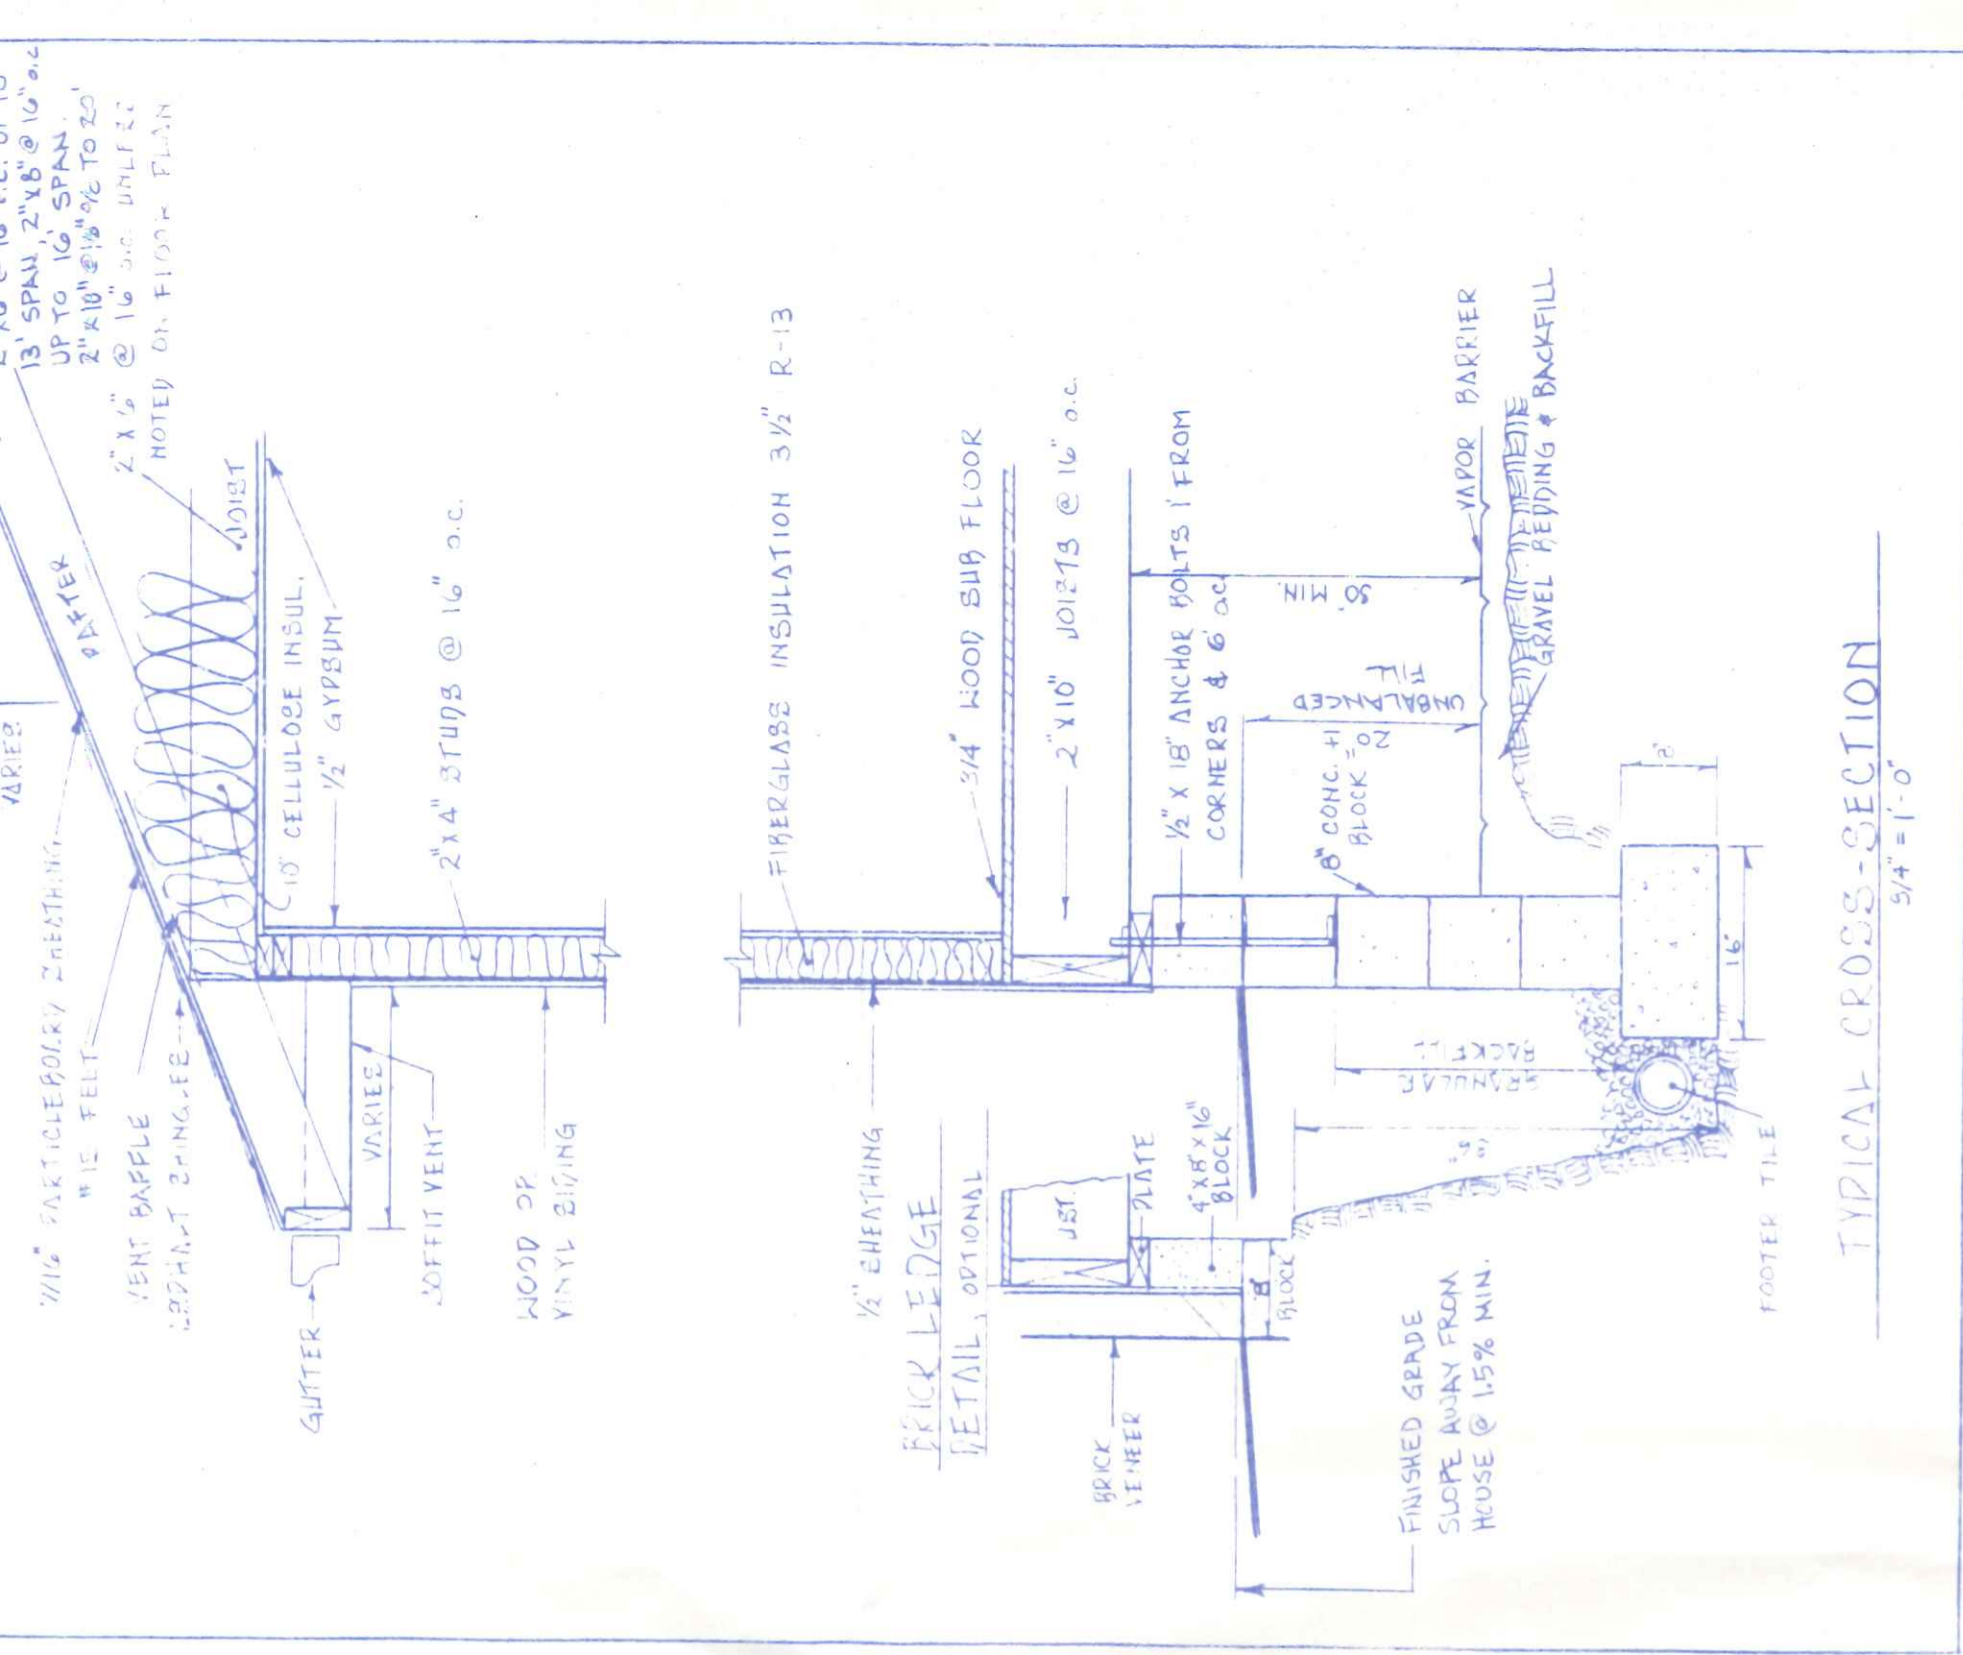

BECK CONSTRUCTION CO.		CO. RD. M.	NAPOLEON, OHIO
SCALE: 1/2" = 1'-0"	APPROVED BY:	DRAWN BY R.D.S.	
DATE: APRIL-1989		REVISED	
VAULTED CEILING FRAMING - 16" o.c.		DRAWING NUMBER	
DETAILS		OF	

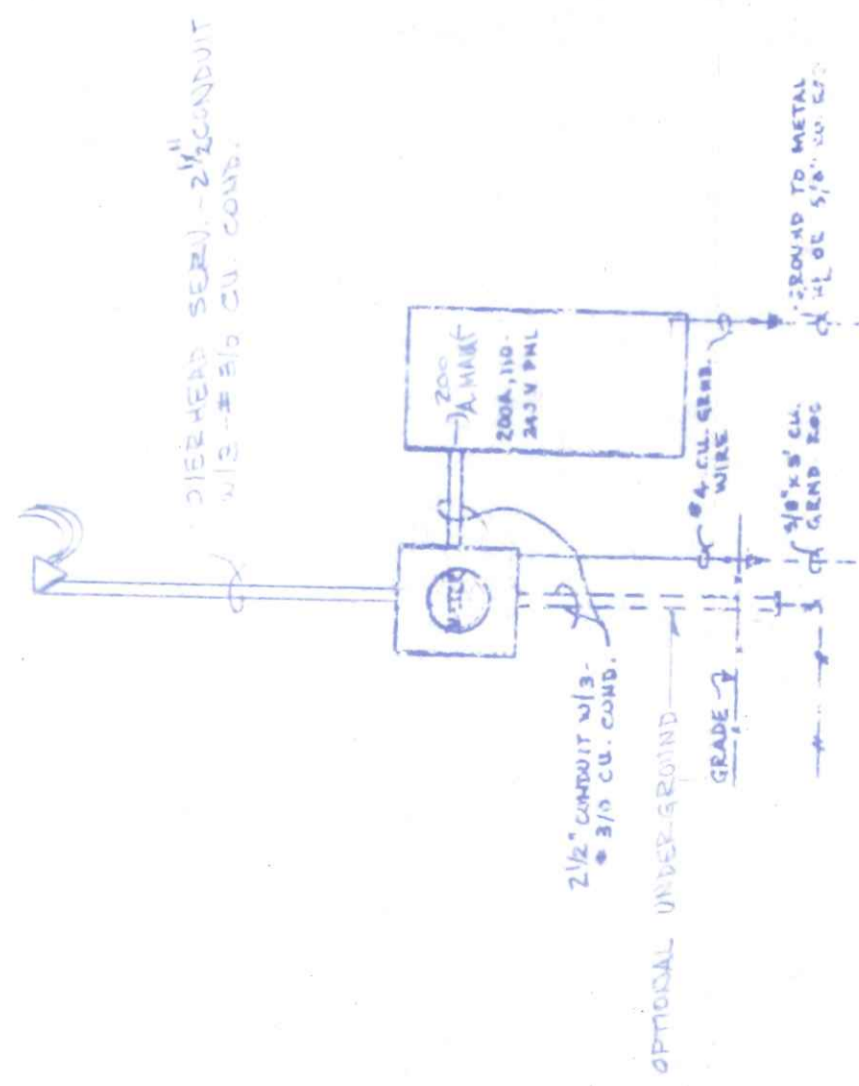

ELECTRICAL RISER DIAGRAM
NO SCALE

