



130 Capri




BECK CONSTRUCTION CO.		
CO. RD. M.	NAPOLEON, OHIO	
SCALE: NOTED	APPROVED BY:	DRAWN BY E.D.S./D.S.
DATE: JULY, 1990		REVISED
EXTERIOR ELEVATIONS		
PLAN NO. 251	DRAWING NUMBER 1 OF 4	

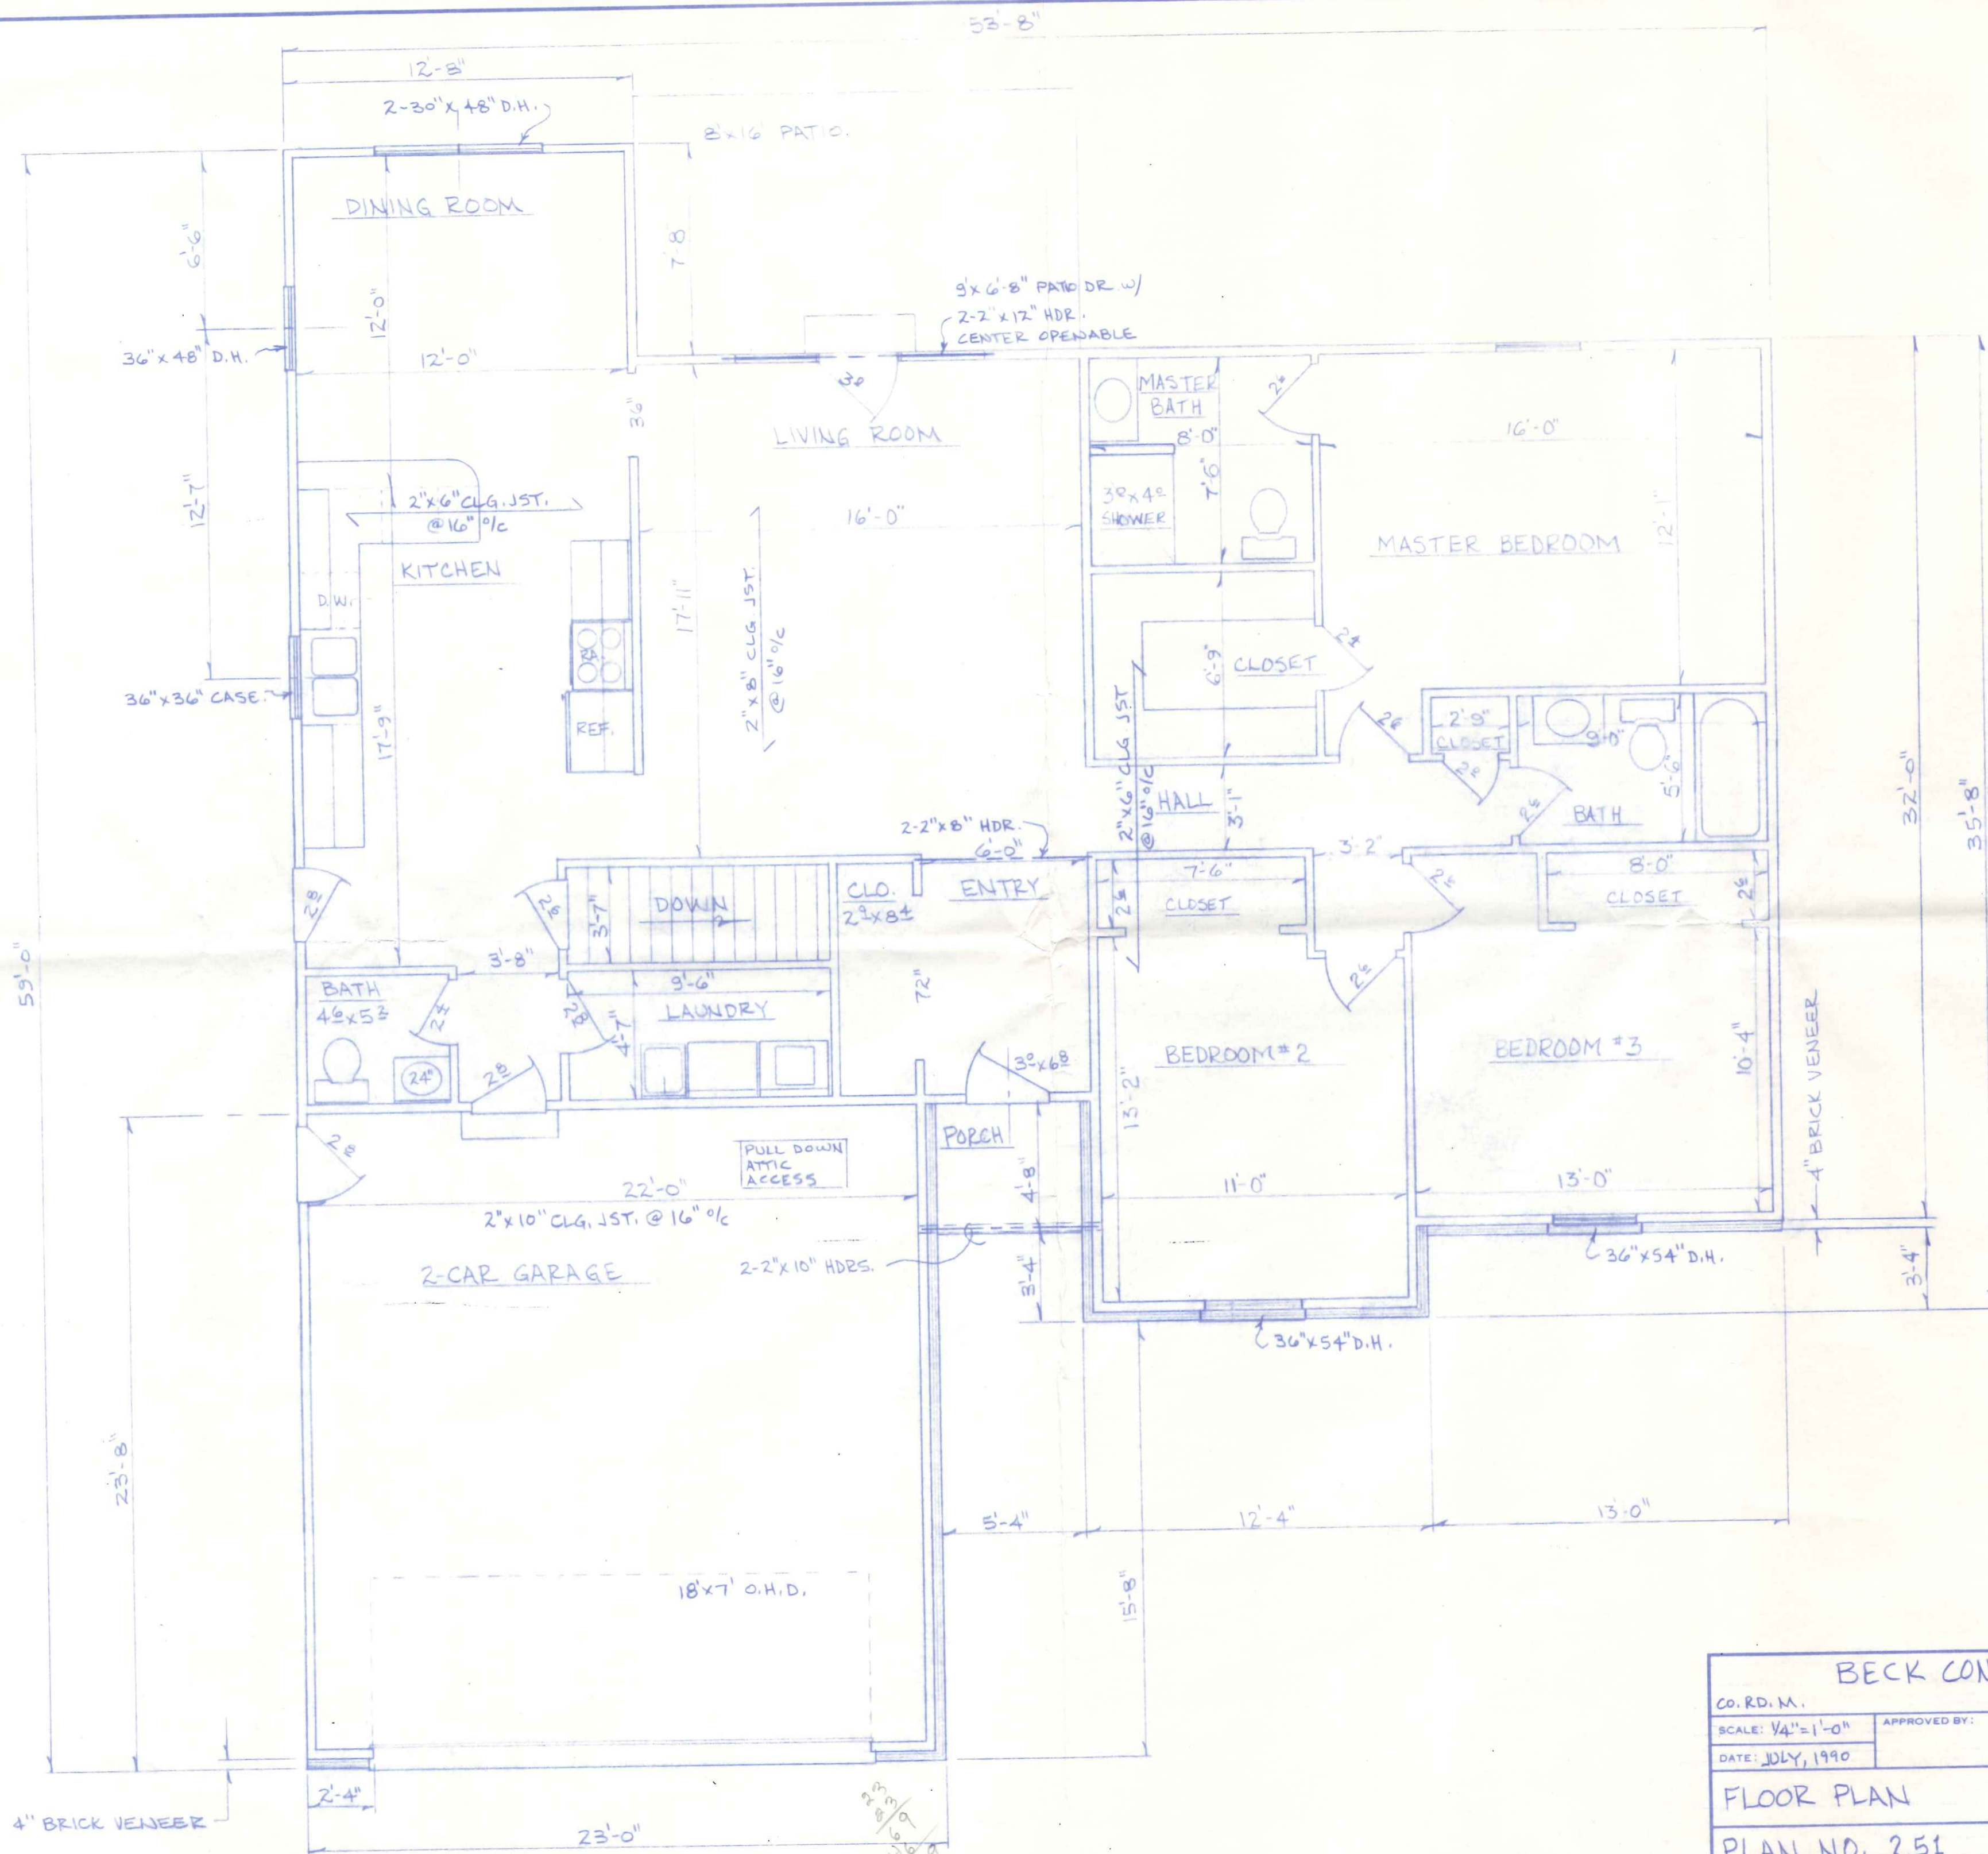

BECK CONSTRUCTION CO.		NAPOLEON, OHIO	
CO. RD. M.	APPROVED BY:	DRAWN BY R.D.S./D.S.	
SCALE: 1/4" = 1'-0"	DATE: JULY, 1990	REVISED	
FLOOR PLAN		DRAWING NUMBER	
PLAN NO. 251		2 OF 4	

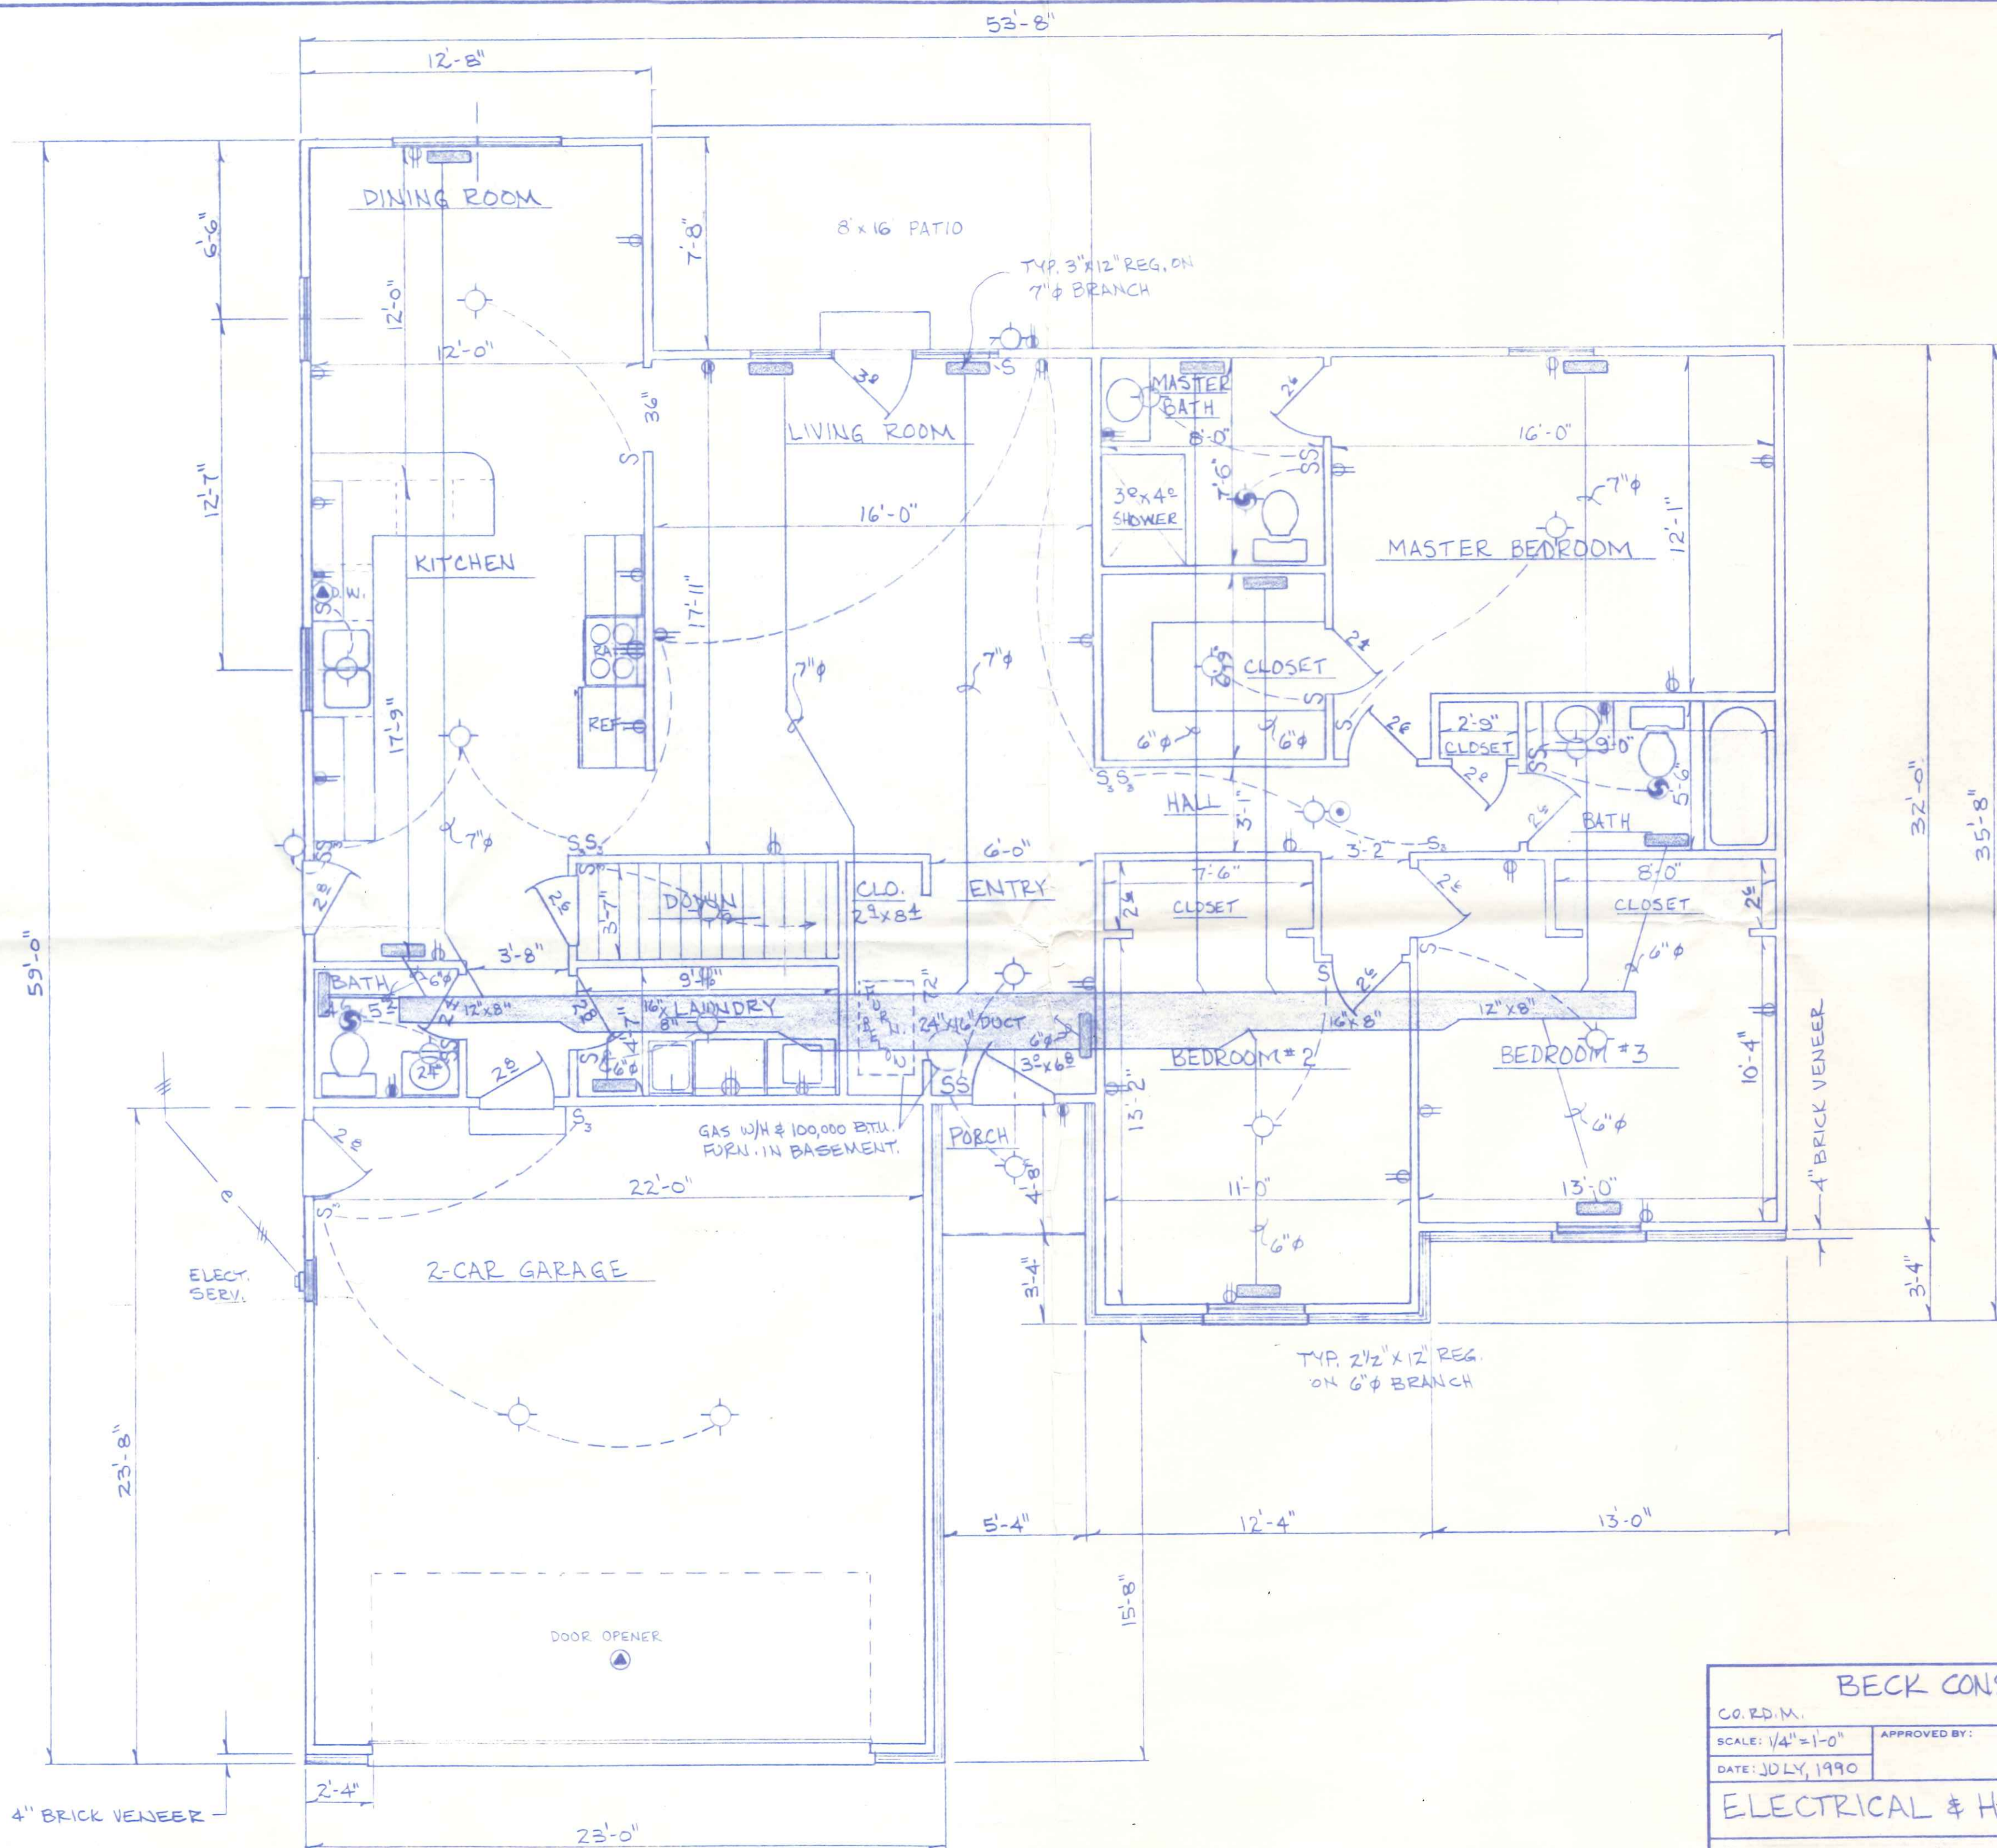

BECK CONSTRUCTION CO.	
CO. P.D.M.	NAPOLÉON, OHIO.
SCALE: 1/4" = 1'-0"	APPROVED BY:
DATE: JULY, 1990	DRAWN BY: R.D.S.
ELECTRICAL & HEATING LAYOUT	
PLAN NO. 251	DRAWING NUMBER 3 OF 4

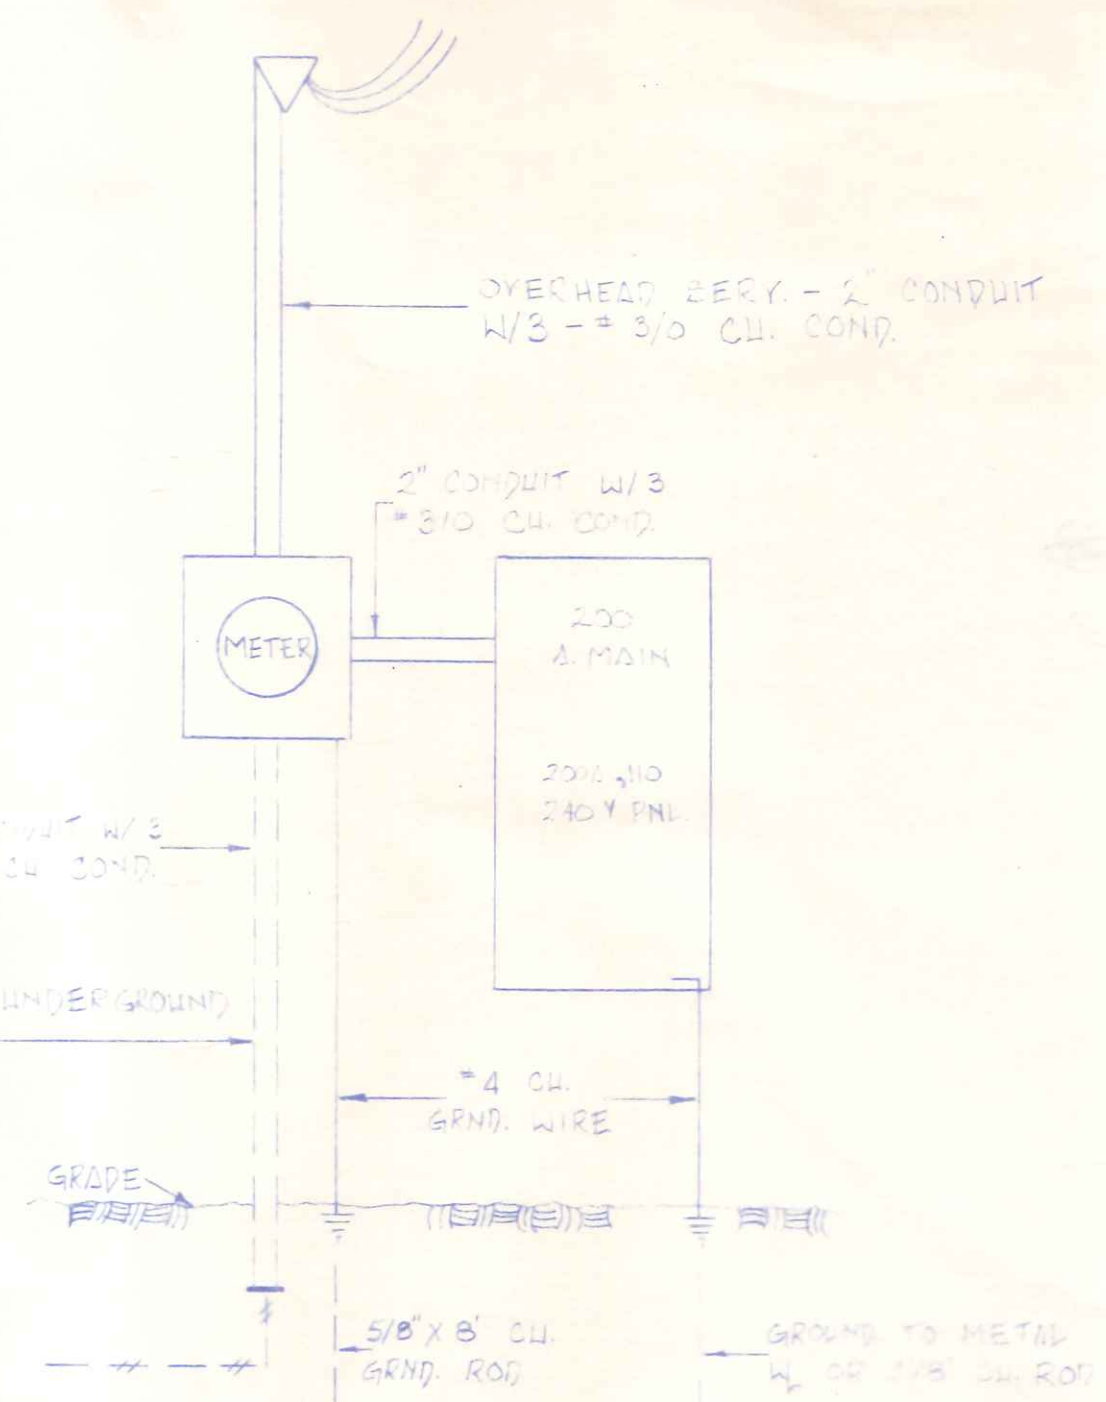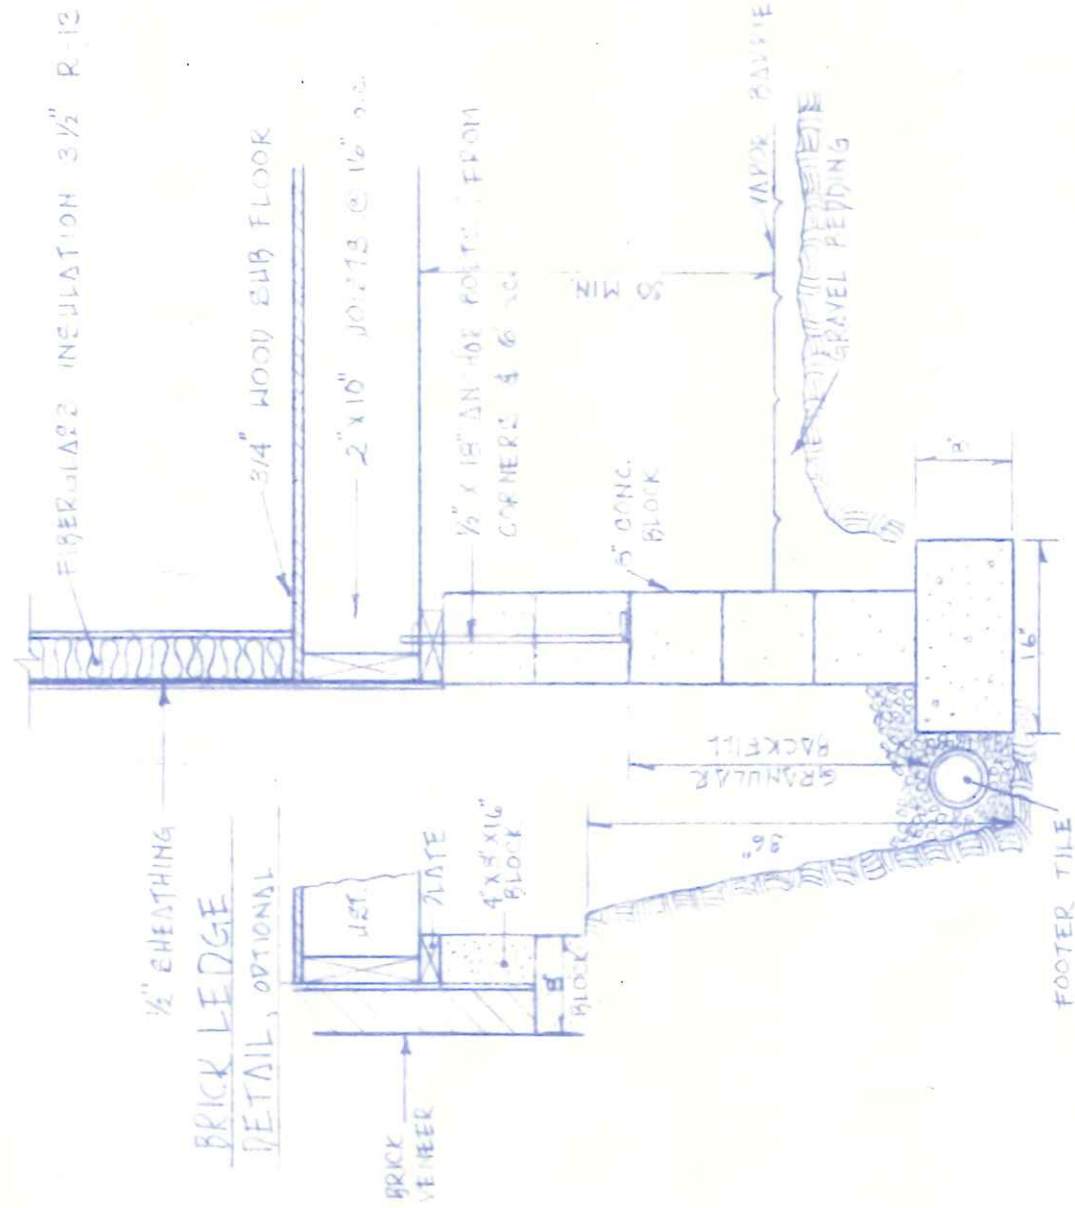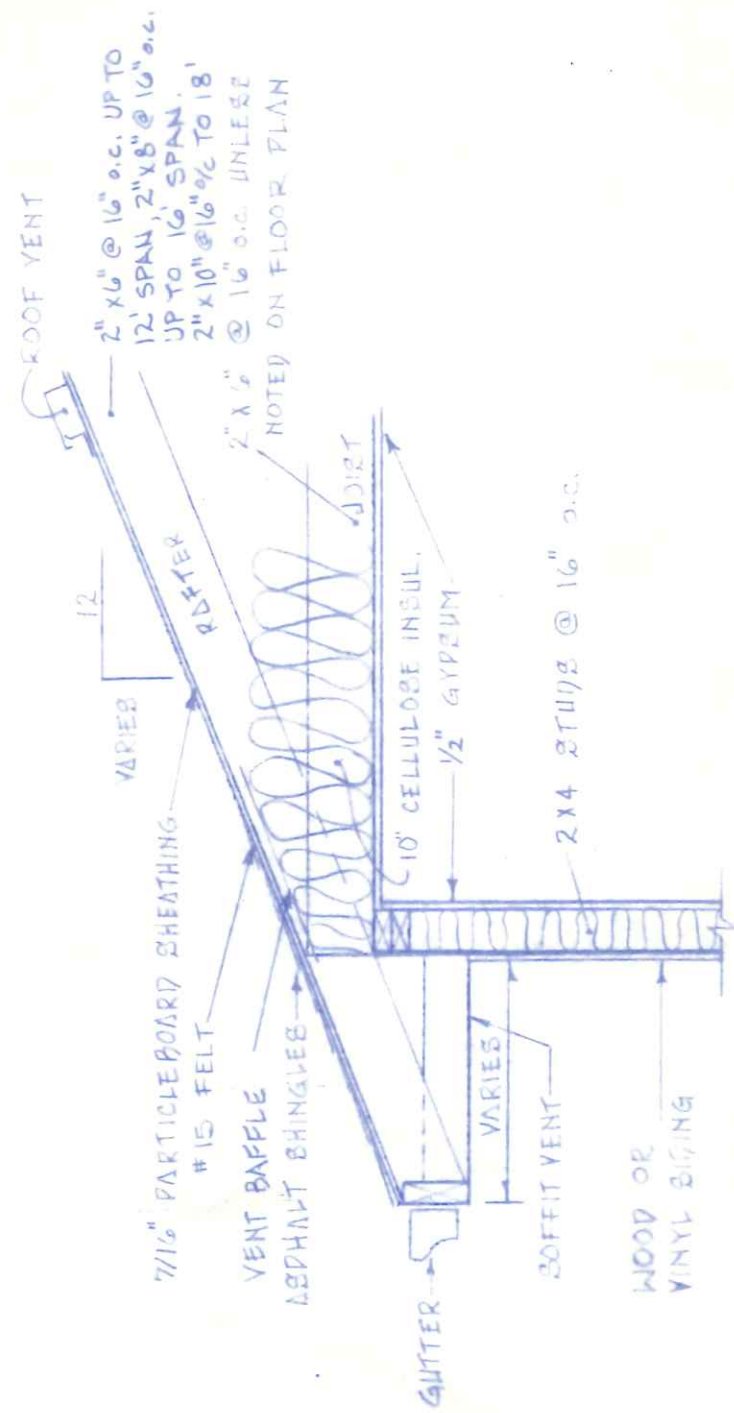

ELECTRICAL RISER DIAGRAM
NO SCALE

