




FRONT ELEVATION

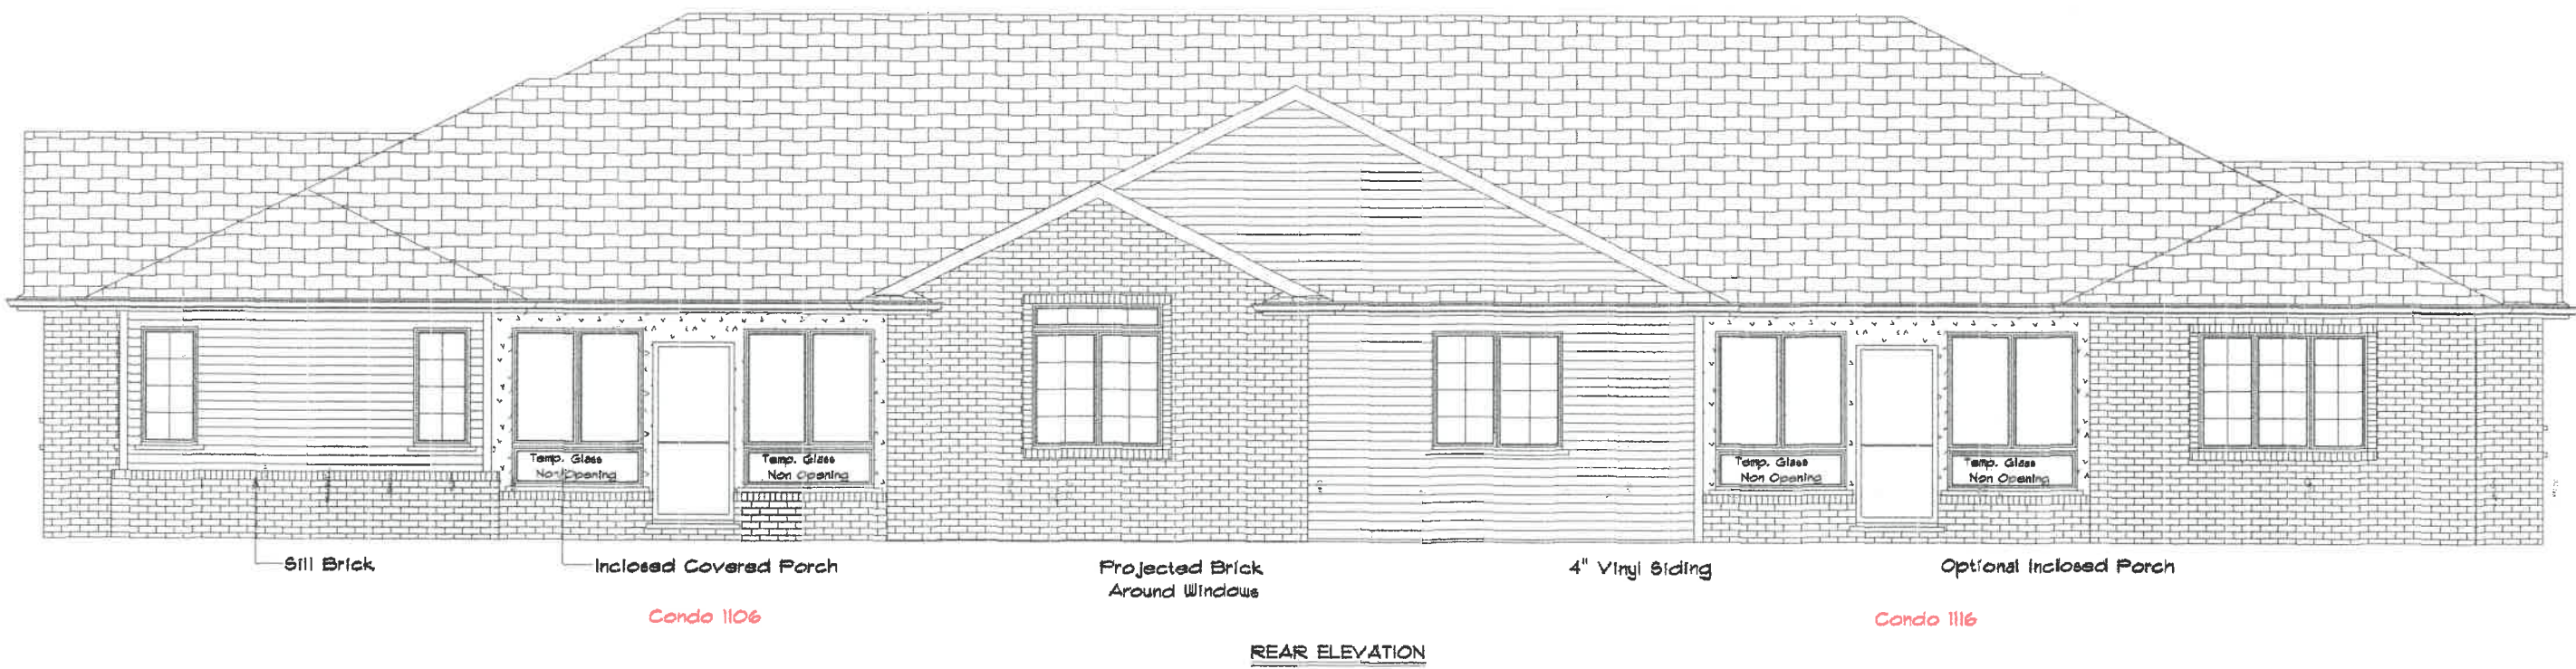


REAR ELEVATION

Note: This drawing and its reproductions are the property of Kahle Design & Build, Ltd. And may not be reproduced, published or used in any way without written permission from Kahle Design & Build, Ltd. Building dimensions may vary from prints. In the interest of safety, all construction should conform to applicable building codes, ordinances, specifications, standards, design, appliance features and, without prior notice, all materials and illustrations are subject to change without notice and are not necessarily to scale. Square footages are approximate. Plans are drawn by Dave Kahle.


Kahle Design & Build

For:	Ms. Beverly Koenig
Location:	1106 Chelsea Ave., Nap.
Scale:	Var. 1/8"
Date:	11-2-07
Phone:	437-4805
	Defiance, Oh

KDB

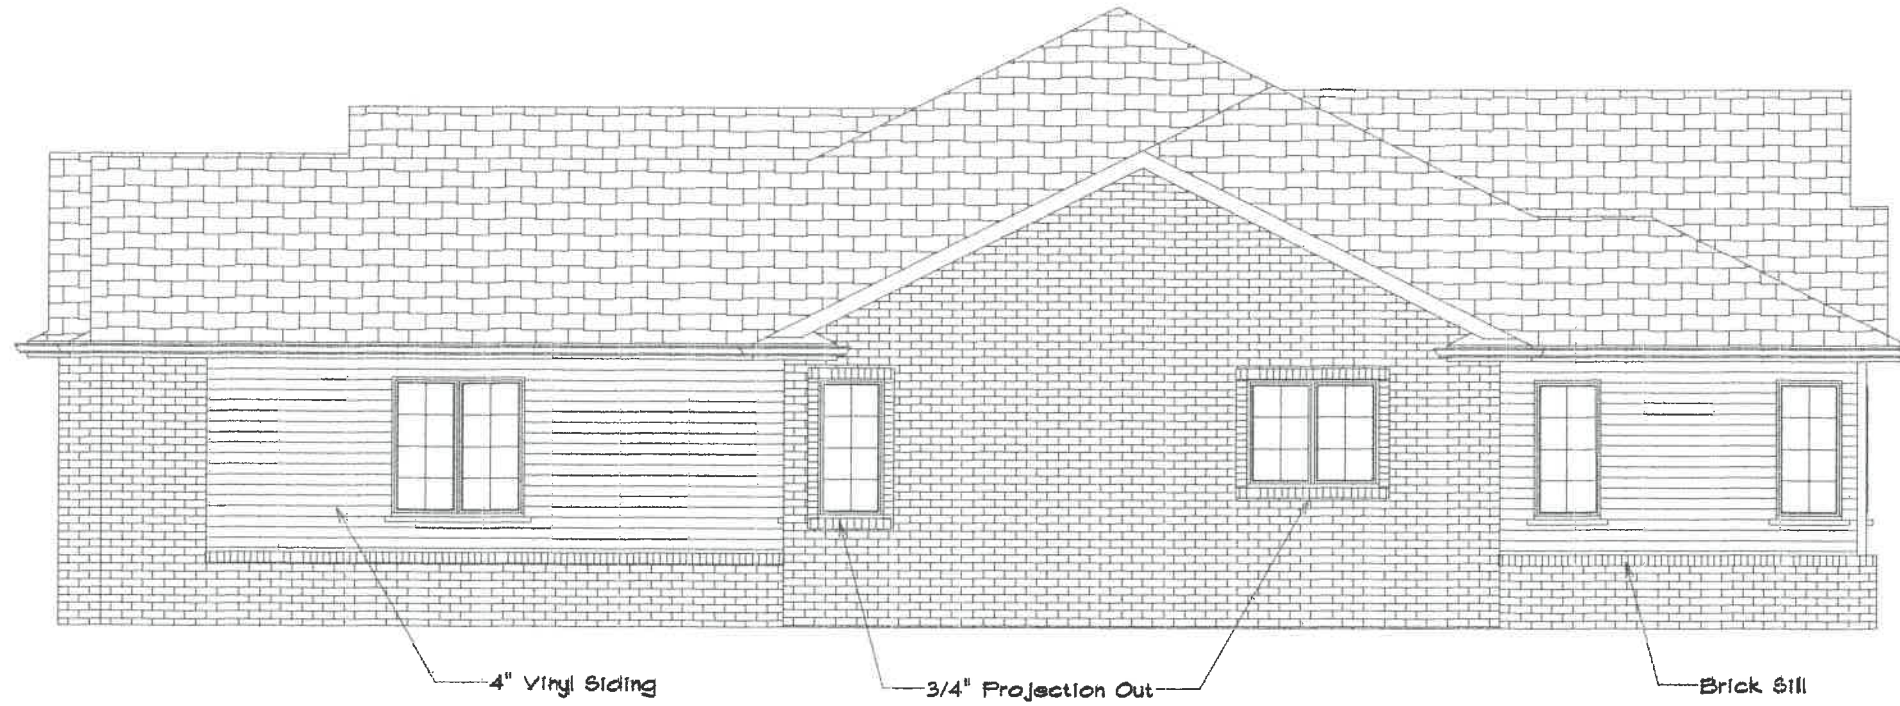

RIGHT ELEVATION
Condo 1106

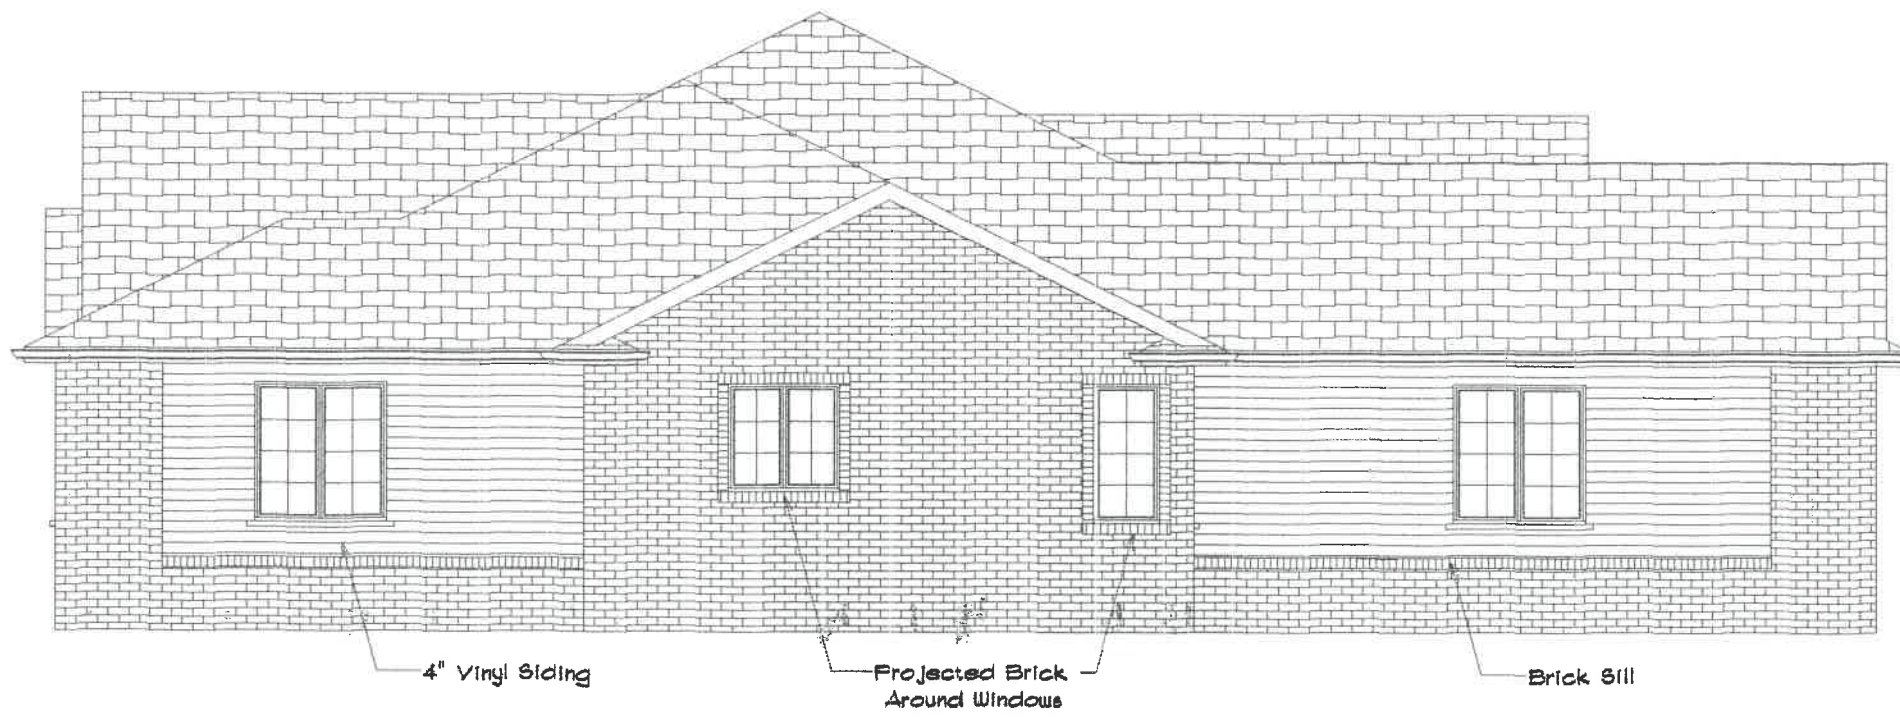


LEFT ELEVATION
Condo 1116

Note: This drawing and its reproductions are the property of Kahle Design & Build, LLC. All rights reserved. No part of this drawing may be reproduced, stored in a retrieval system, or transmitted in any form or by any means, electronic, mechanical, photocopying, recording, or by any information storage and retrieval system, without the prior written permission of Kahle Design & Build, LLC. Kahle Design & Build, LLC reserves the right to alter plans, specifications, materials, design, appliance features etc. without prior notice. All measurements and illustrations are actual or digital measurements and are not necessarily to scale. Square footage are approximate. Plans are drawn by Dave Kahle.

Kahle Design & Build

For :	Ms. Beverly Koenig
Location :	1106 Chelsea Ave., Nap.
Scale:	Var: 1/8"
Date	9-2-08
Defiance, Oh	Phons 419-4805



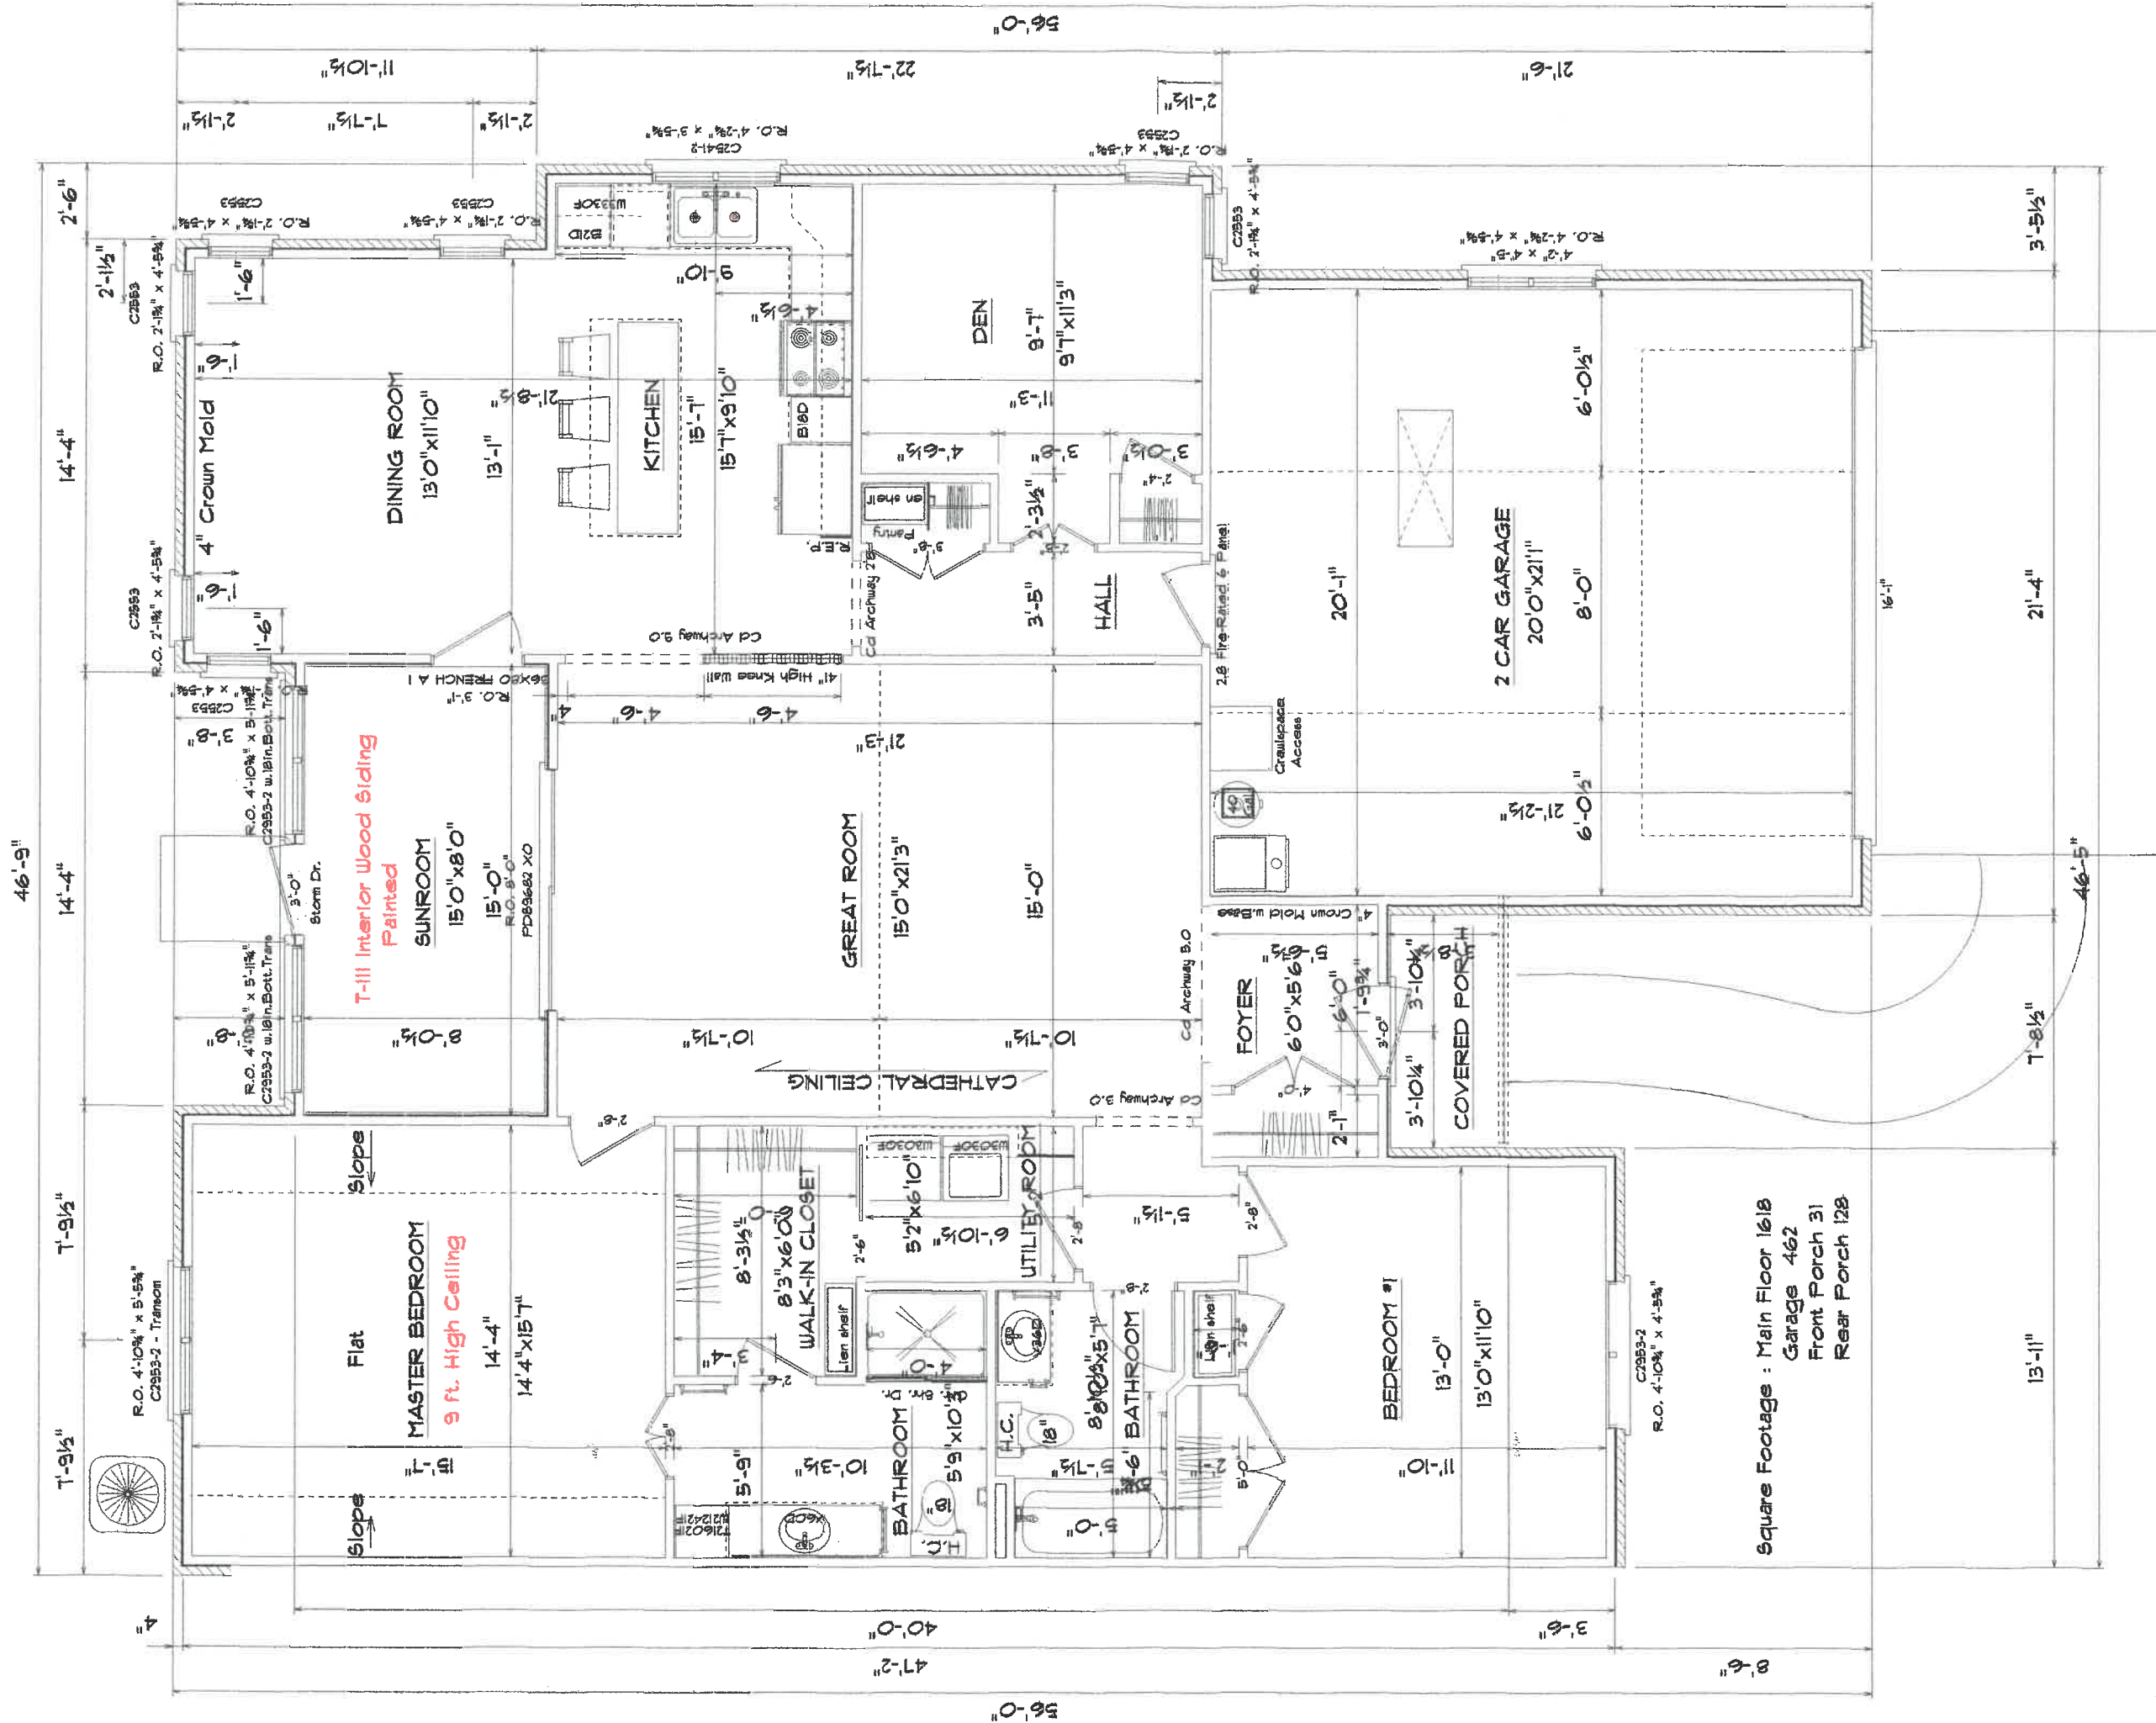

Square Footage : Main Floor 1618
 Garage 462
 Front Porch 31
 Rear Porch 128


MAIN FLOOR PLAN



For : Ms. Beverly Koenig
 Location : 1106 Chelsea Ave., Nap.
 Scale: Var. 1"0" Defiance, Oh
 Date 8-28-08
 Phone 437-4805

Kahle Design & Build

Note: This drawing and its reproductions are the properties of Kahle Design & Build Ltd. And may not be reproduced, published or used in any way without written permission from Kahle Design & Build Ltd. Building dimensions may vary from prints. In the interest of continuing product improvement Kahle Design & Build reserves the right to alter plans, specifications, materials, design, appliance features and, without prior notice. All maps, plans and illustrations are artistic or schematic conceptions and are not necessarily to scale. Square footages are approximate. Plans are drawn by Dave Kahle.

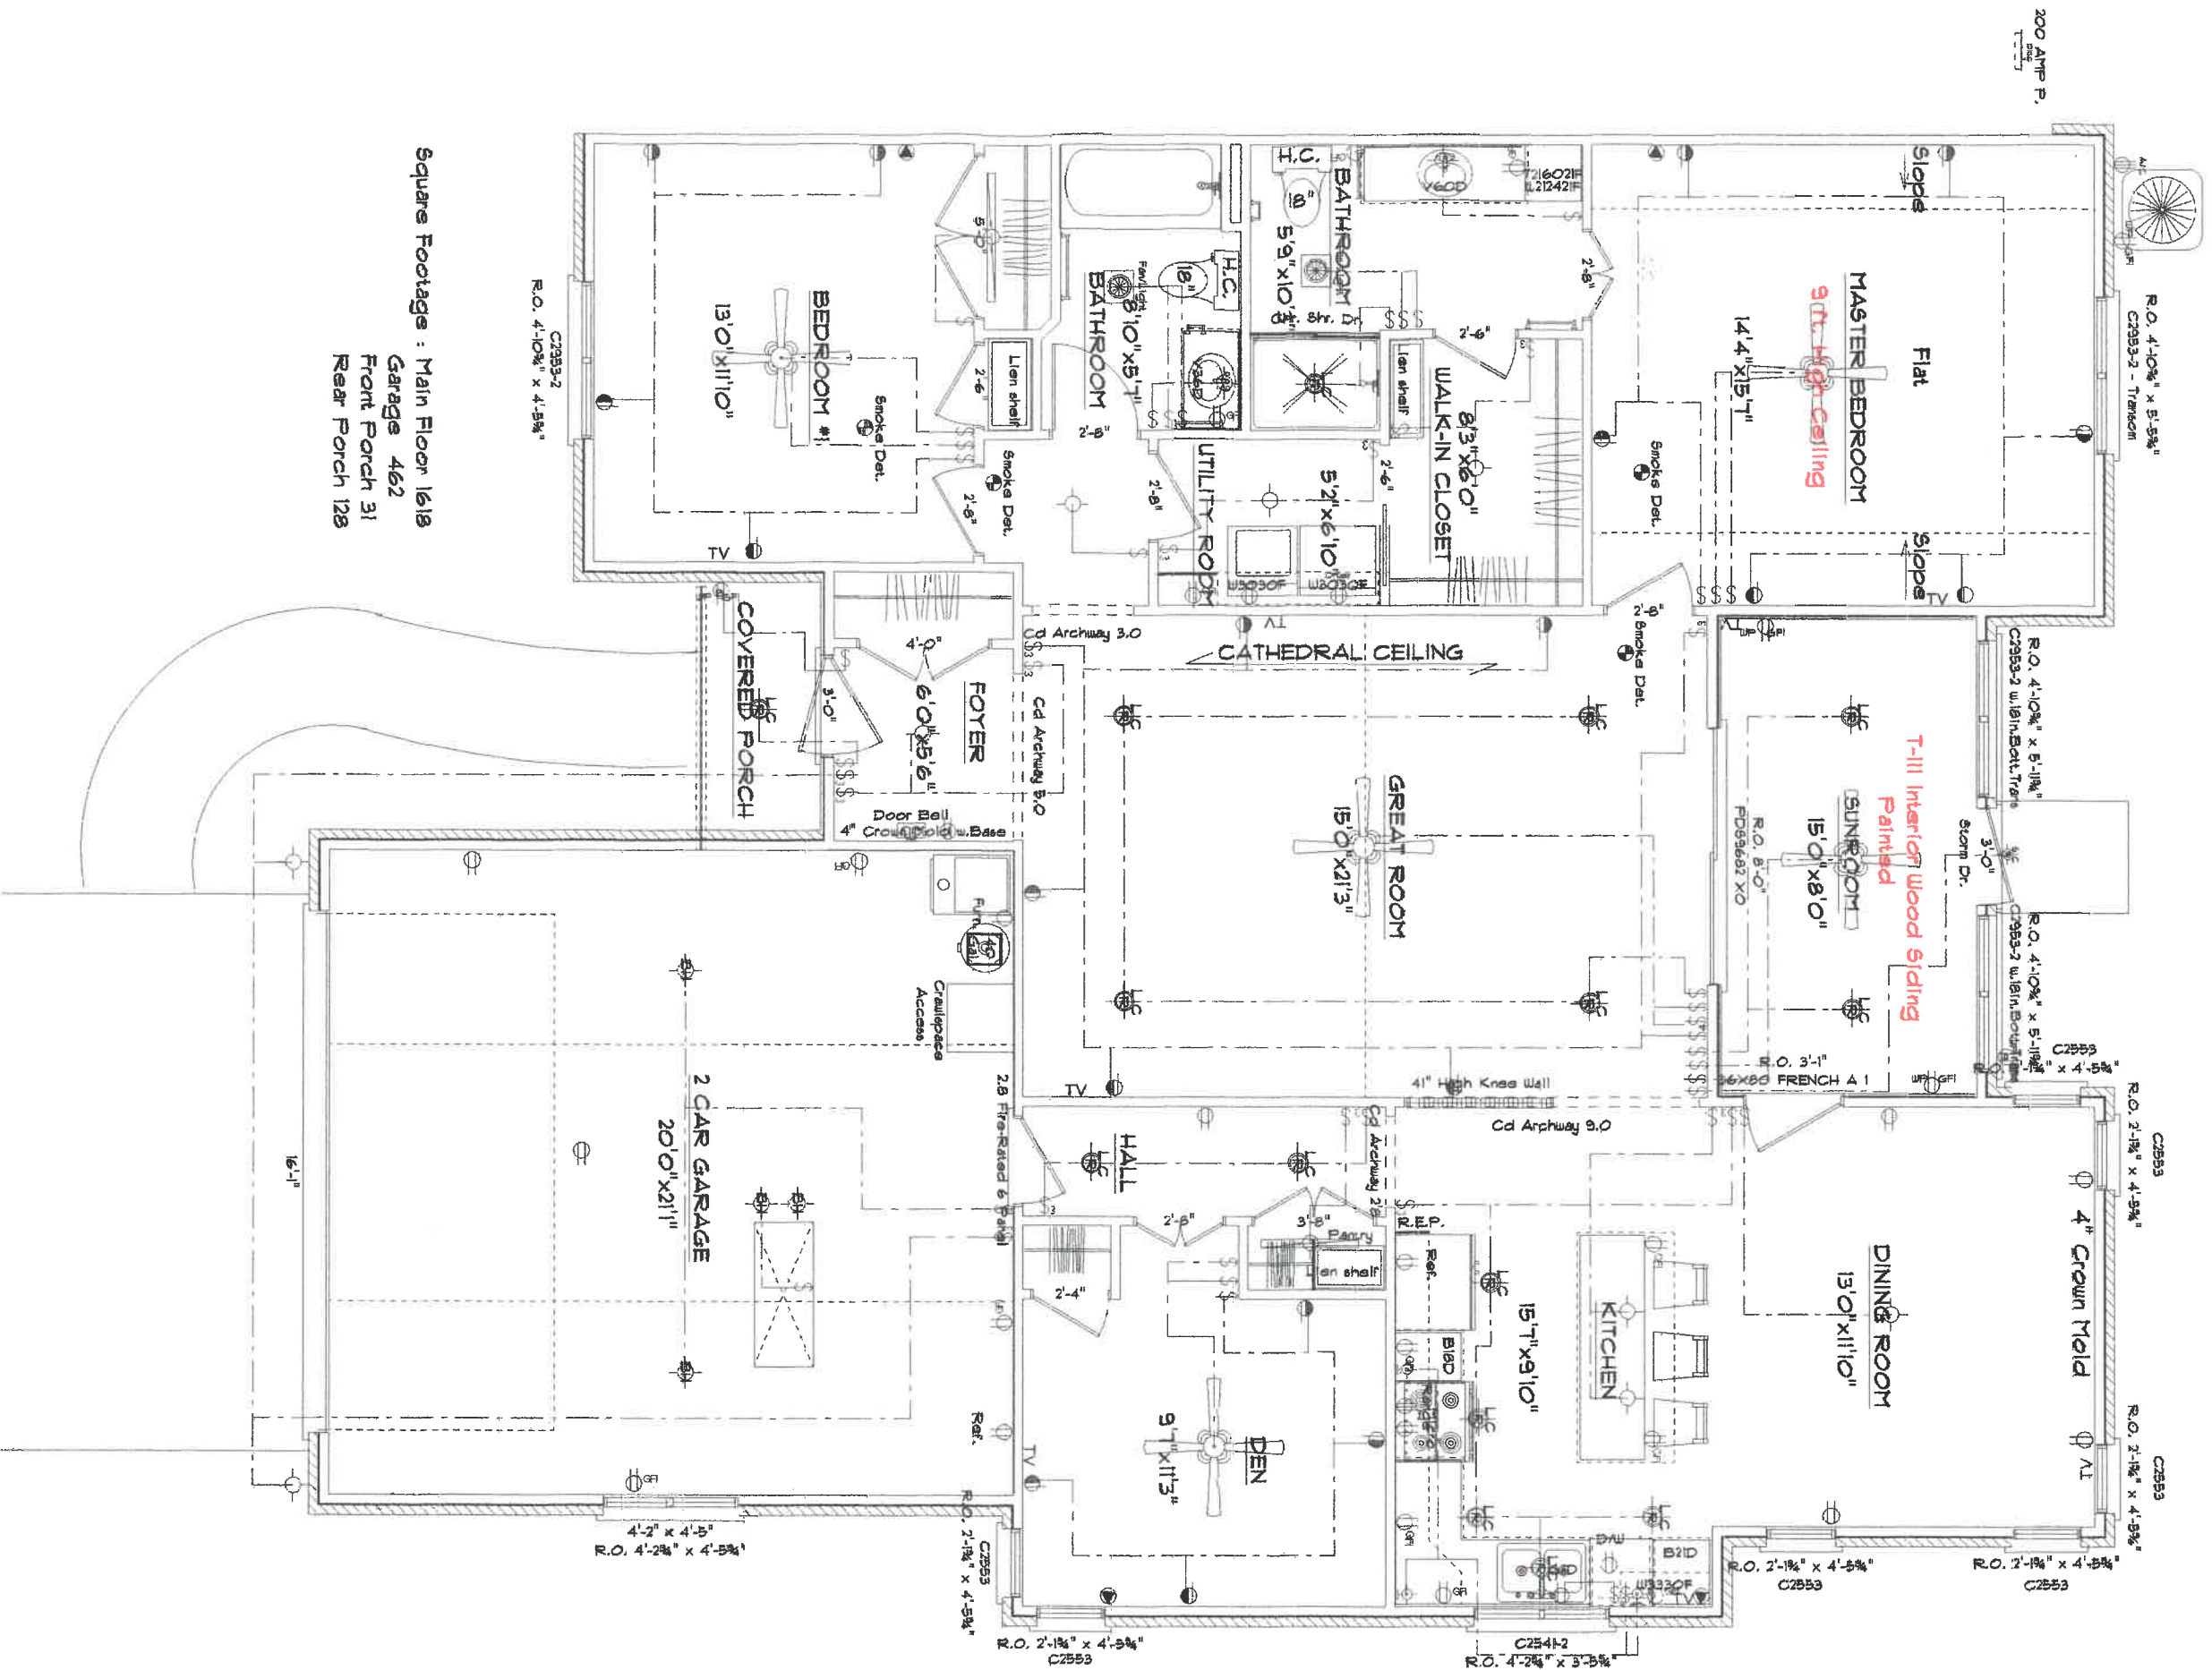

Square Footage : Main Floor 1618
 Garage 462
 Front Porch 31
 Rear Porch 128

MAIN FLOOR PLAN
 ELECTRICAL PLAN

K D B	For : Ms. Beverly Koenig	Date 8-28-08
	Location : 1106 Chaises Ave., Nap.	Defiance, Oh
Kahle Design & Build		
<p style="font-size: small;">Note : This drawing and its reproductions are the properties of Kahle Design & Build Ltd. And may not be reproduced, published or used in any way without written permission from Kahle Design & Build Ltd. Building dimensions may vary from prints. In the interest of continuing product improvement Kahle Design & Build reserves the right to alter plans, specifications, materials, designs, appliances features etc. without prior notice. All elev. plans and illustrations are artist or architect conceptions and are not necessarily to scale. Square footage are approximate. Plans are drawn by Dave Kahle.</p>		

S 90°0'0" E 182.414'

PROPERTY LINE

39'-10 3/8"

123'-6"

23'-4 1/2"

1'-6"

60'-0"

138.208'

PROPERTY LINE 138.187'

SETBACK

25'-0"

16'-0"

PROPERTY LINE

Condo 1106

Condo 1116

ROOF OVERHANG

BUILDING OUTLINE

CURB

Chelsea Ave.

28'-0"

0'

Arboretum Cultivars
Techy American

100'-2 3/8"

0'

0'

