



4" Vinyl Siding

6" Wood Siding

Address of property is 1125 Chelsea Ave.

FRONT ELEVATION



Screened In Porch

4" Vinyl Siding

REAR ELEVATION

Address of property is 1125 Chelsea Ave.

*David A. Schmitz  
James W. Schmitz*

100,000


*David R. Kalle 10/09/01*

Note :  
In the interest of continuing product improvement Kahle Design & Build reserves the right to alter plans, specifications, materials, designs, appliance features, amenities etc. without prior notice. All maps, plans, and illustrations are artist's conceptions, and are not necessarily to scale. Square footages are approximate. Plans are drawn by Dave Kahle

1125  
Chelsea  
Ave

Kahle Design & Build	
Defiance, Oh	Phone 437-4805
Scale: Var. 1/8"	Date 09/10/01
Chelsea Condo's	
Location : Bales Rd. Napoleon	



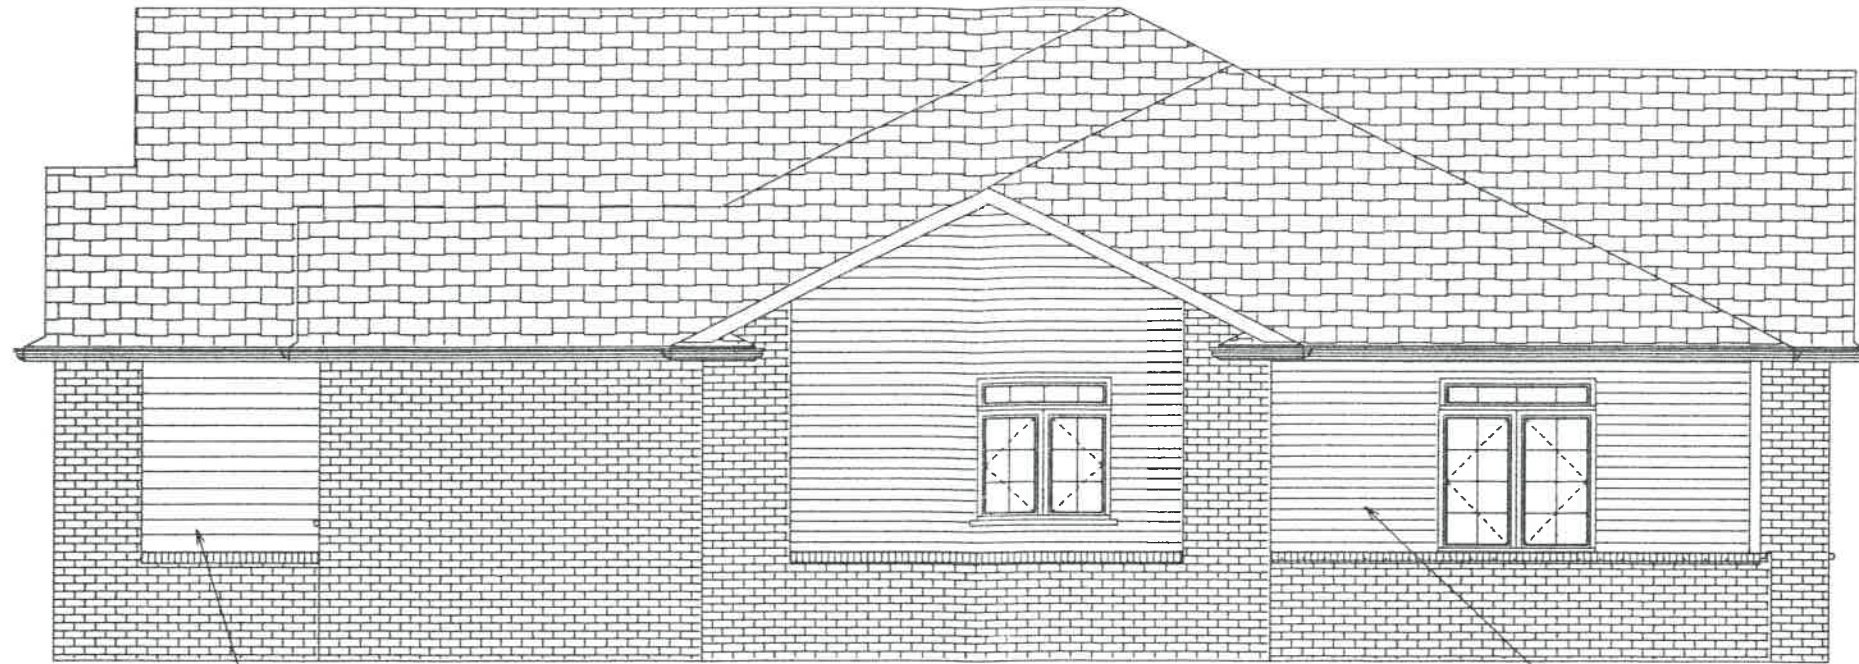


6" Wood Siding

RIGHT ELEVATION

4" Vinyl Siding

Address of property is 1135 Chelsea Ave.

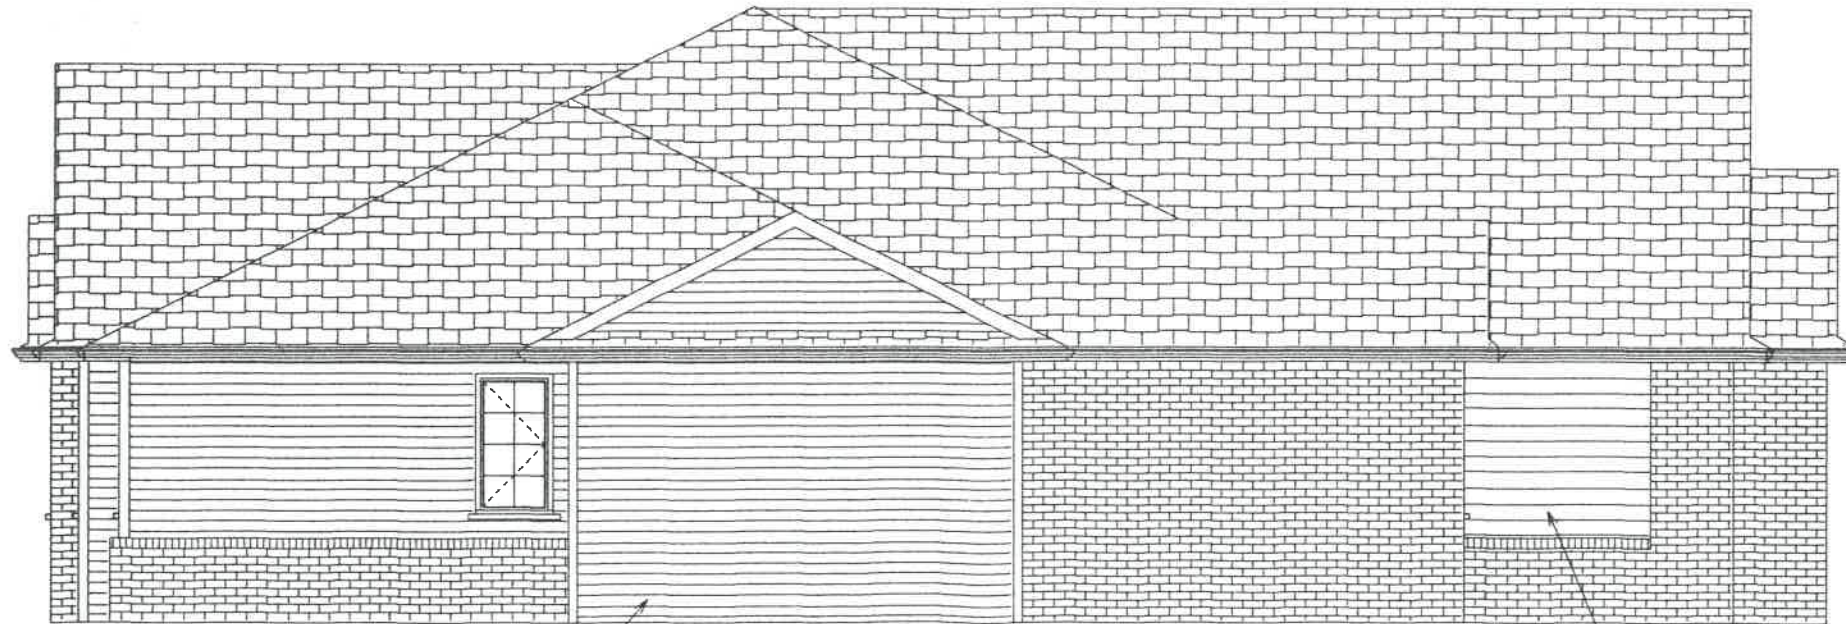


4" Vinyl Siding

LEFT ELEVATION

6" Wood Siding

Address of property is 1125 Chelsea Ave.

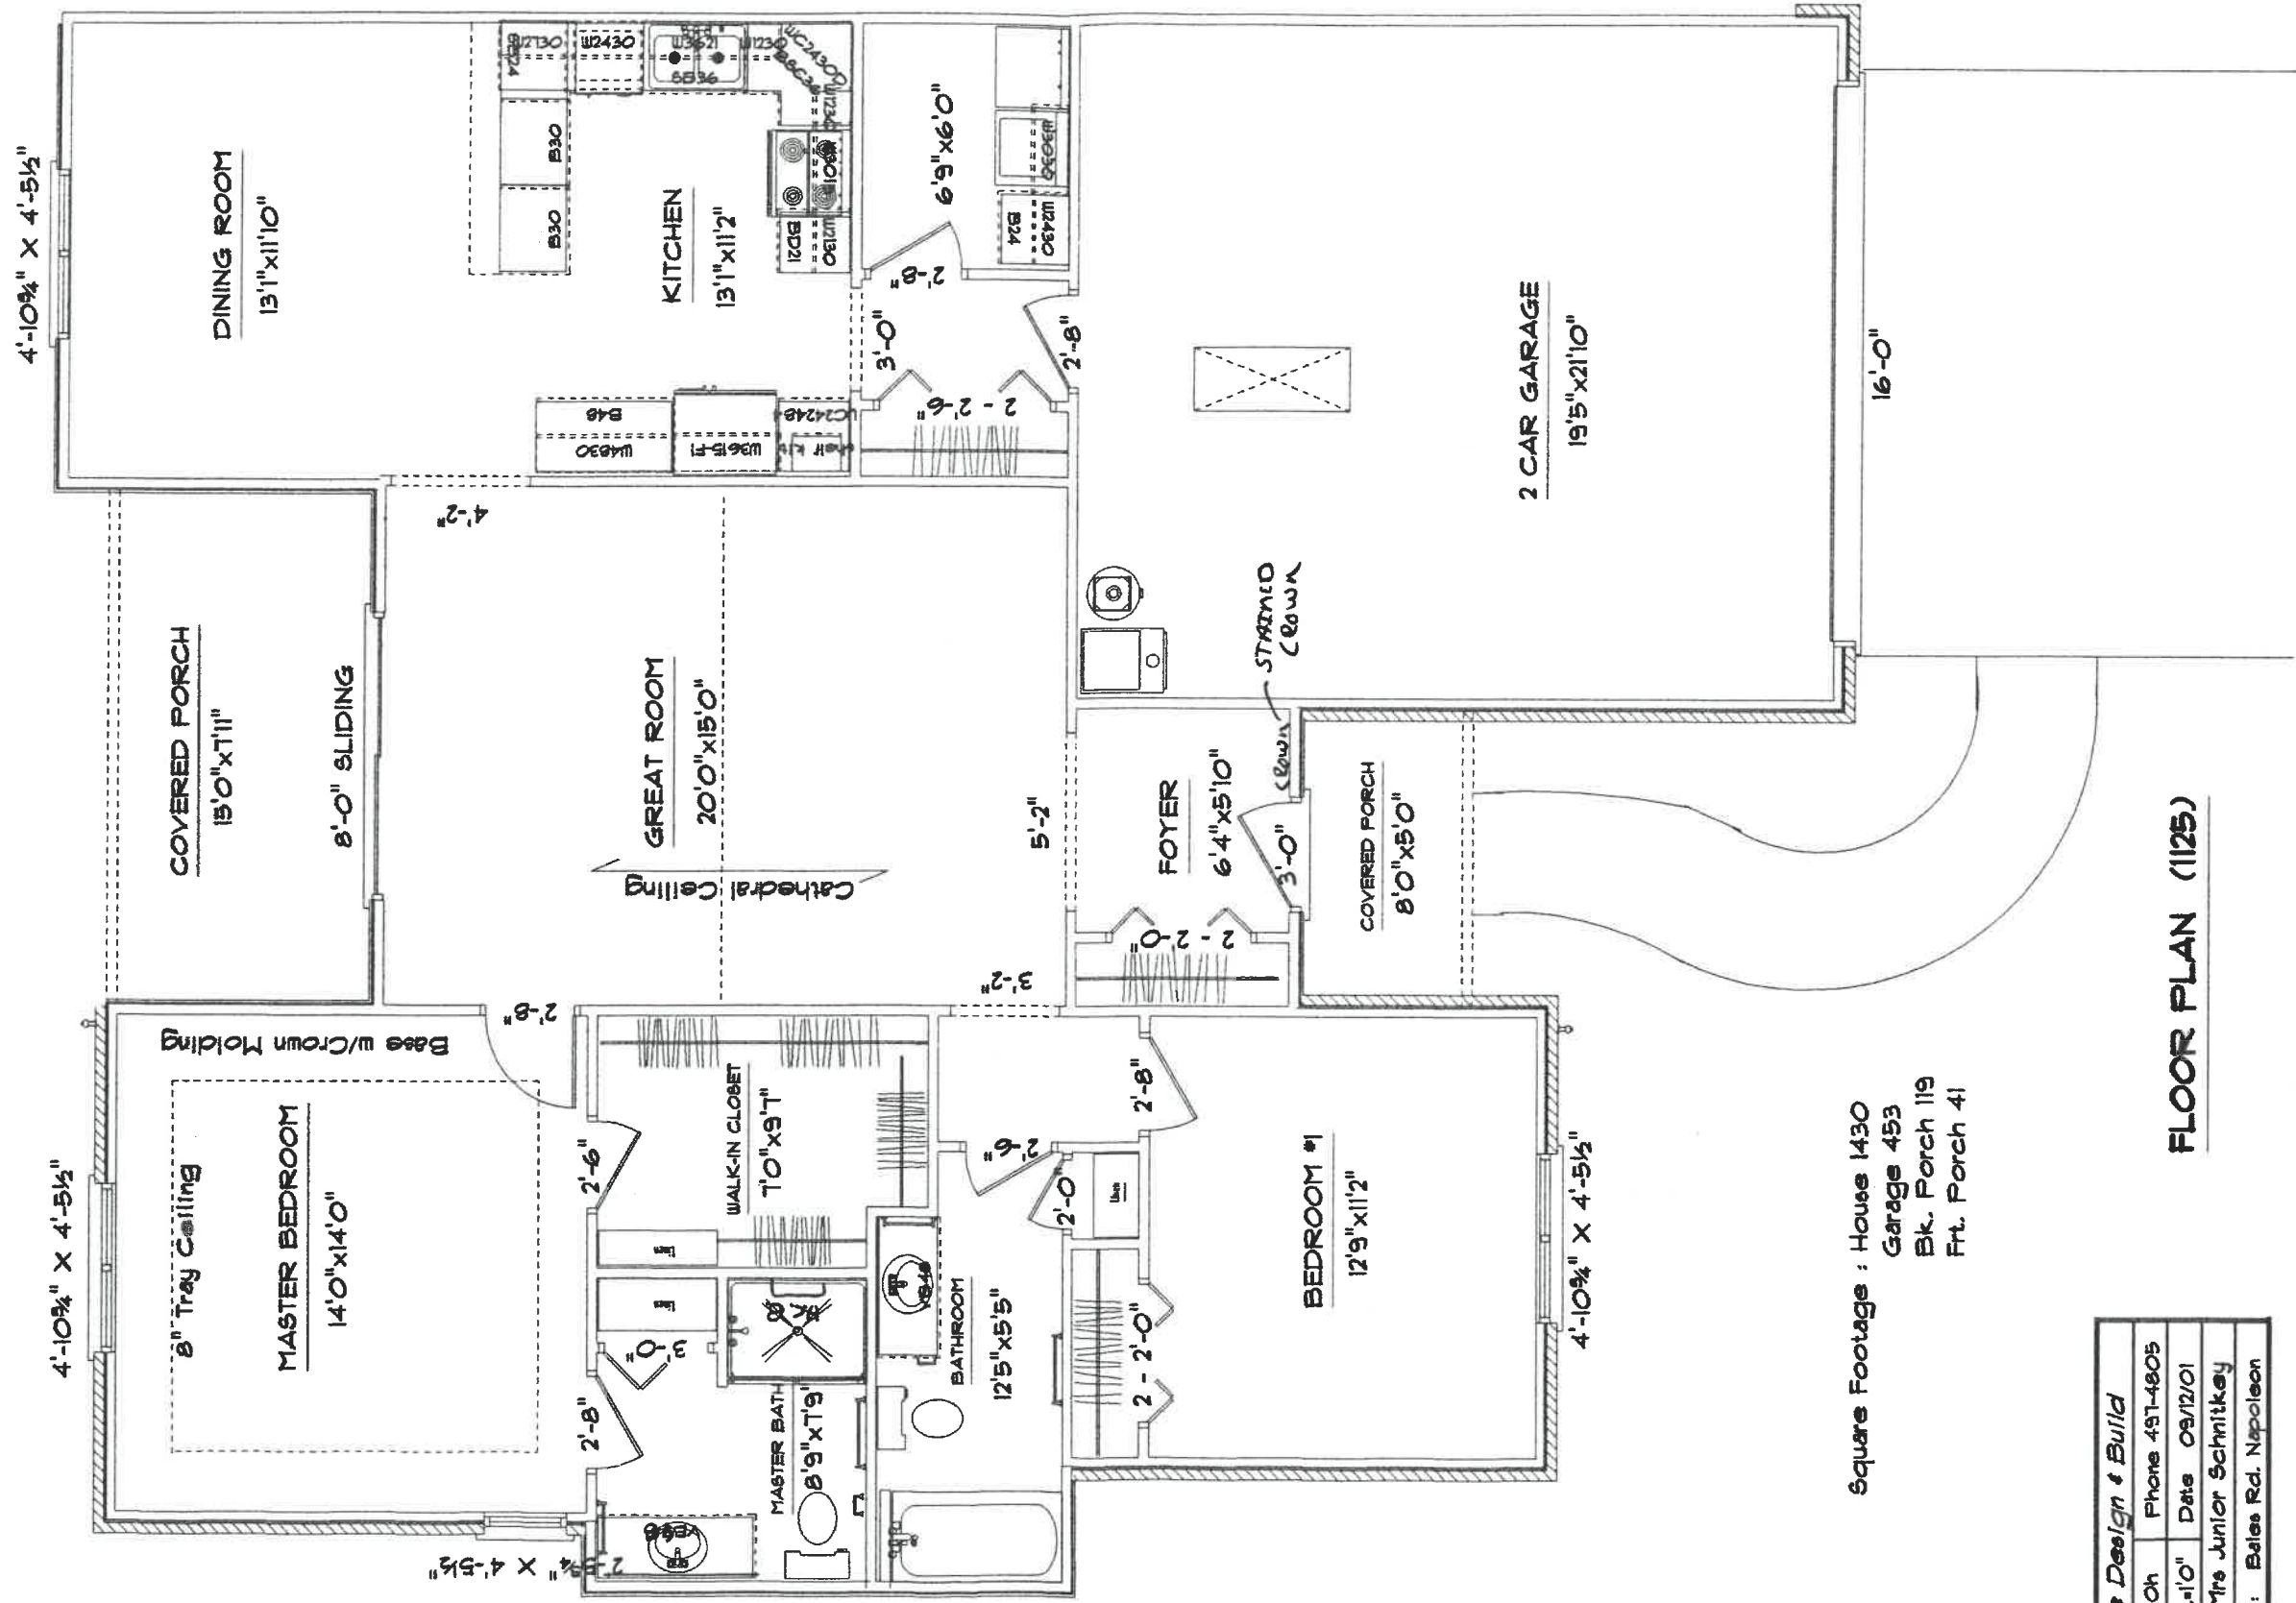


Square Footage : House 1430  
 Garage 453  
 Bk. Porch 119  
 Frt. Porch 41

**FLOOR PLAN (1125)**

<b>Kahle Design &amp; Build</b>	
Defiance, Oh	Phone 457-4805
Scale: Var.'1'0"	Date 09/12/01
Mr. & Mrs Junior Schmitkey	
Location : Bates Rd. Napoleon	




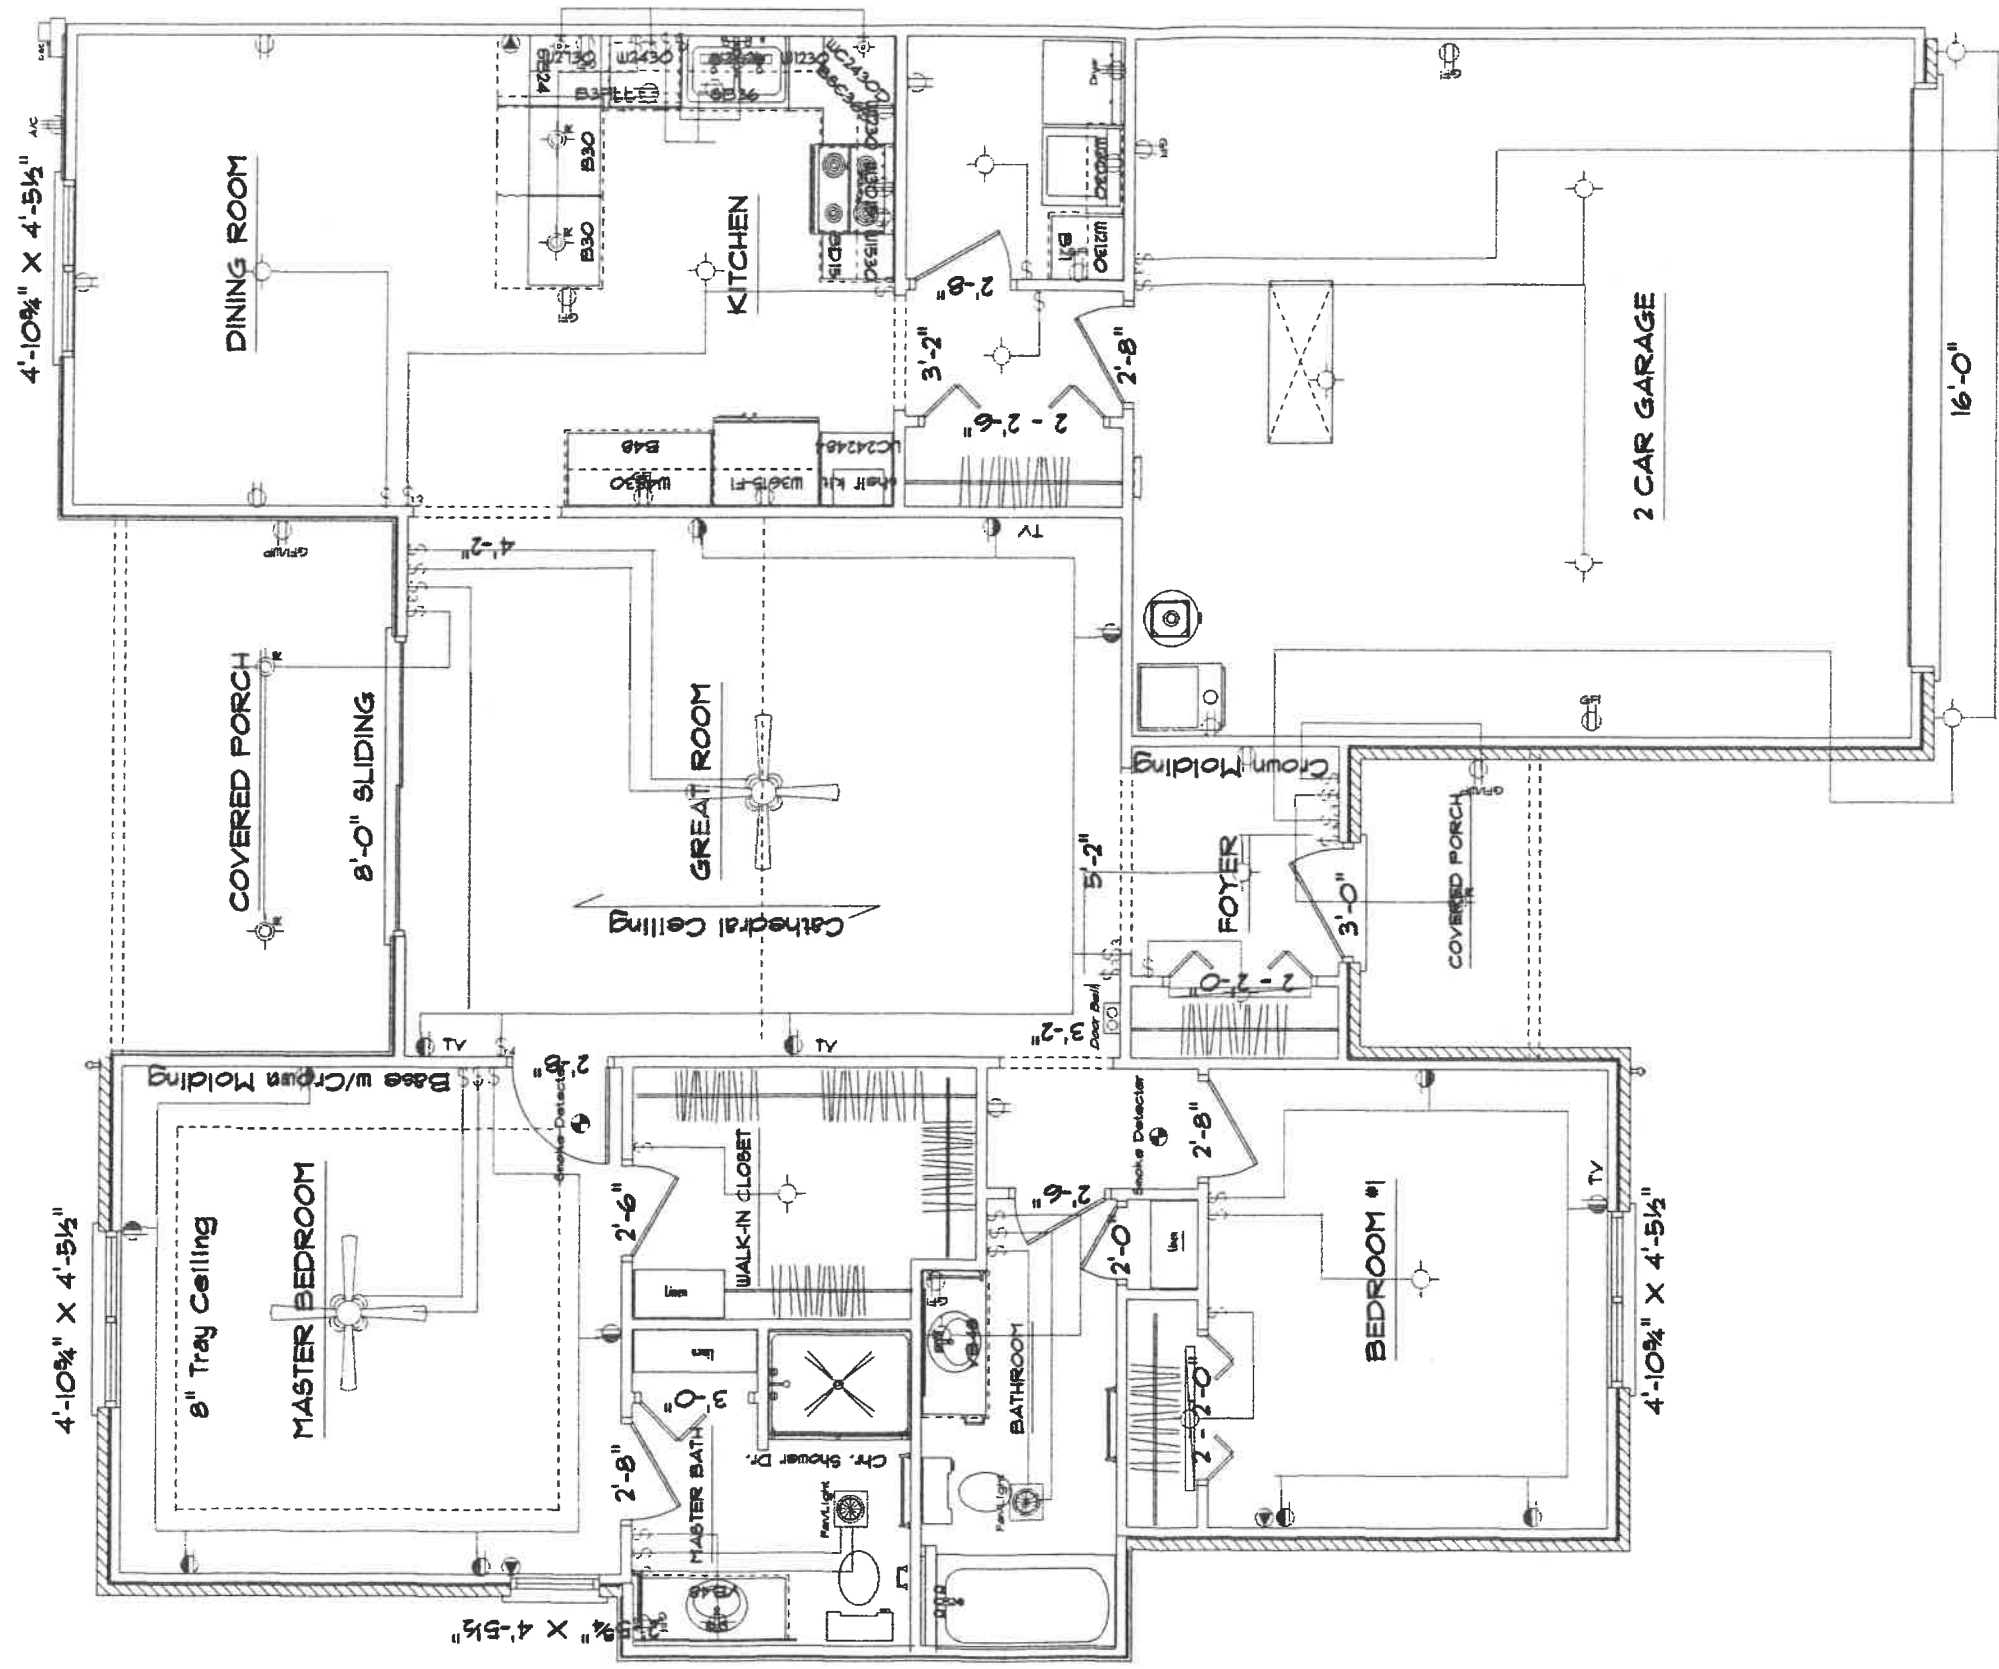

ELECTRICAL PLAN

Square Footage : House 1430  
 Garage 452  
 Bk. Porch 119  
 Ft. Porch 40


Kahle Design & Build			
Defiance, Oh	Phone 497-4805		
Scale: Var.'0"	Date 09/12/01		
Mr. & Mrs Junior Schrittky			
Location : Beales Rd. Napoleon			

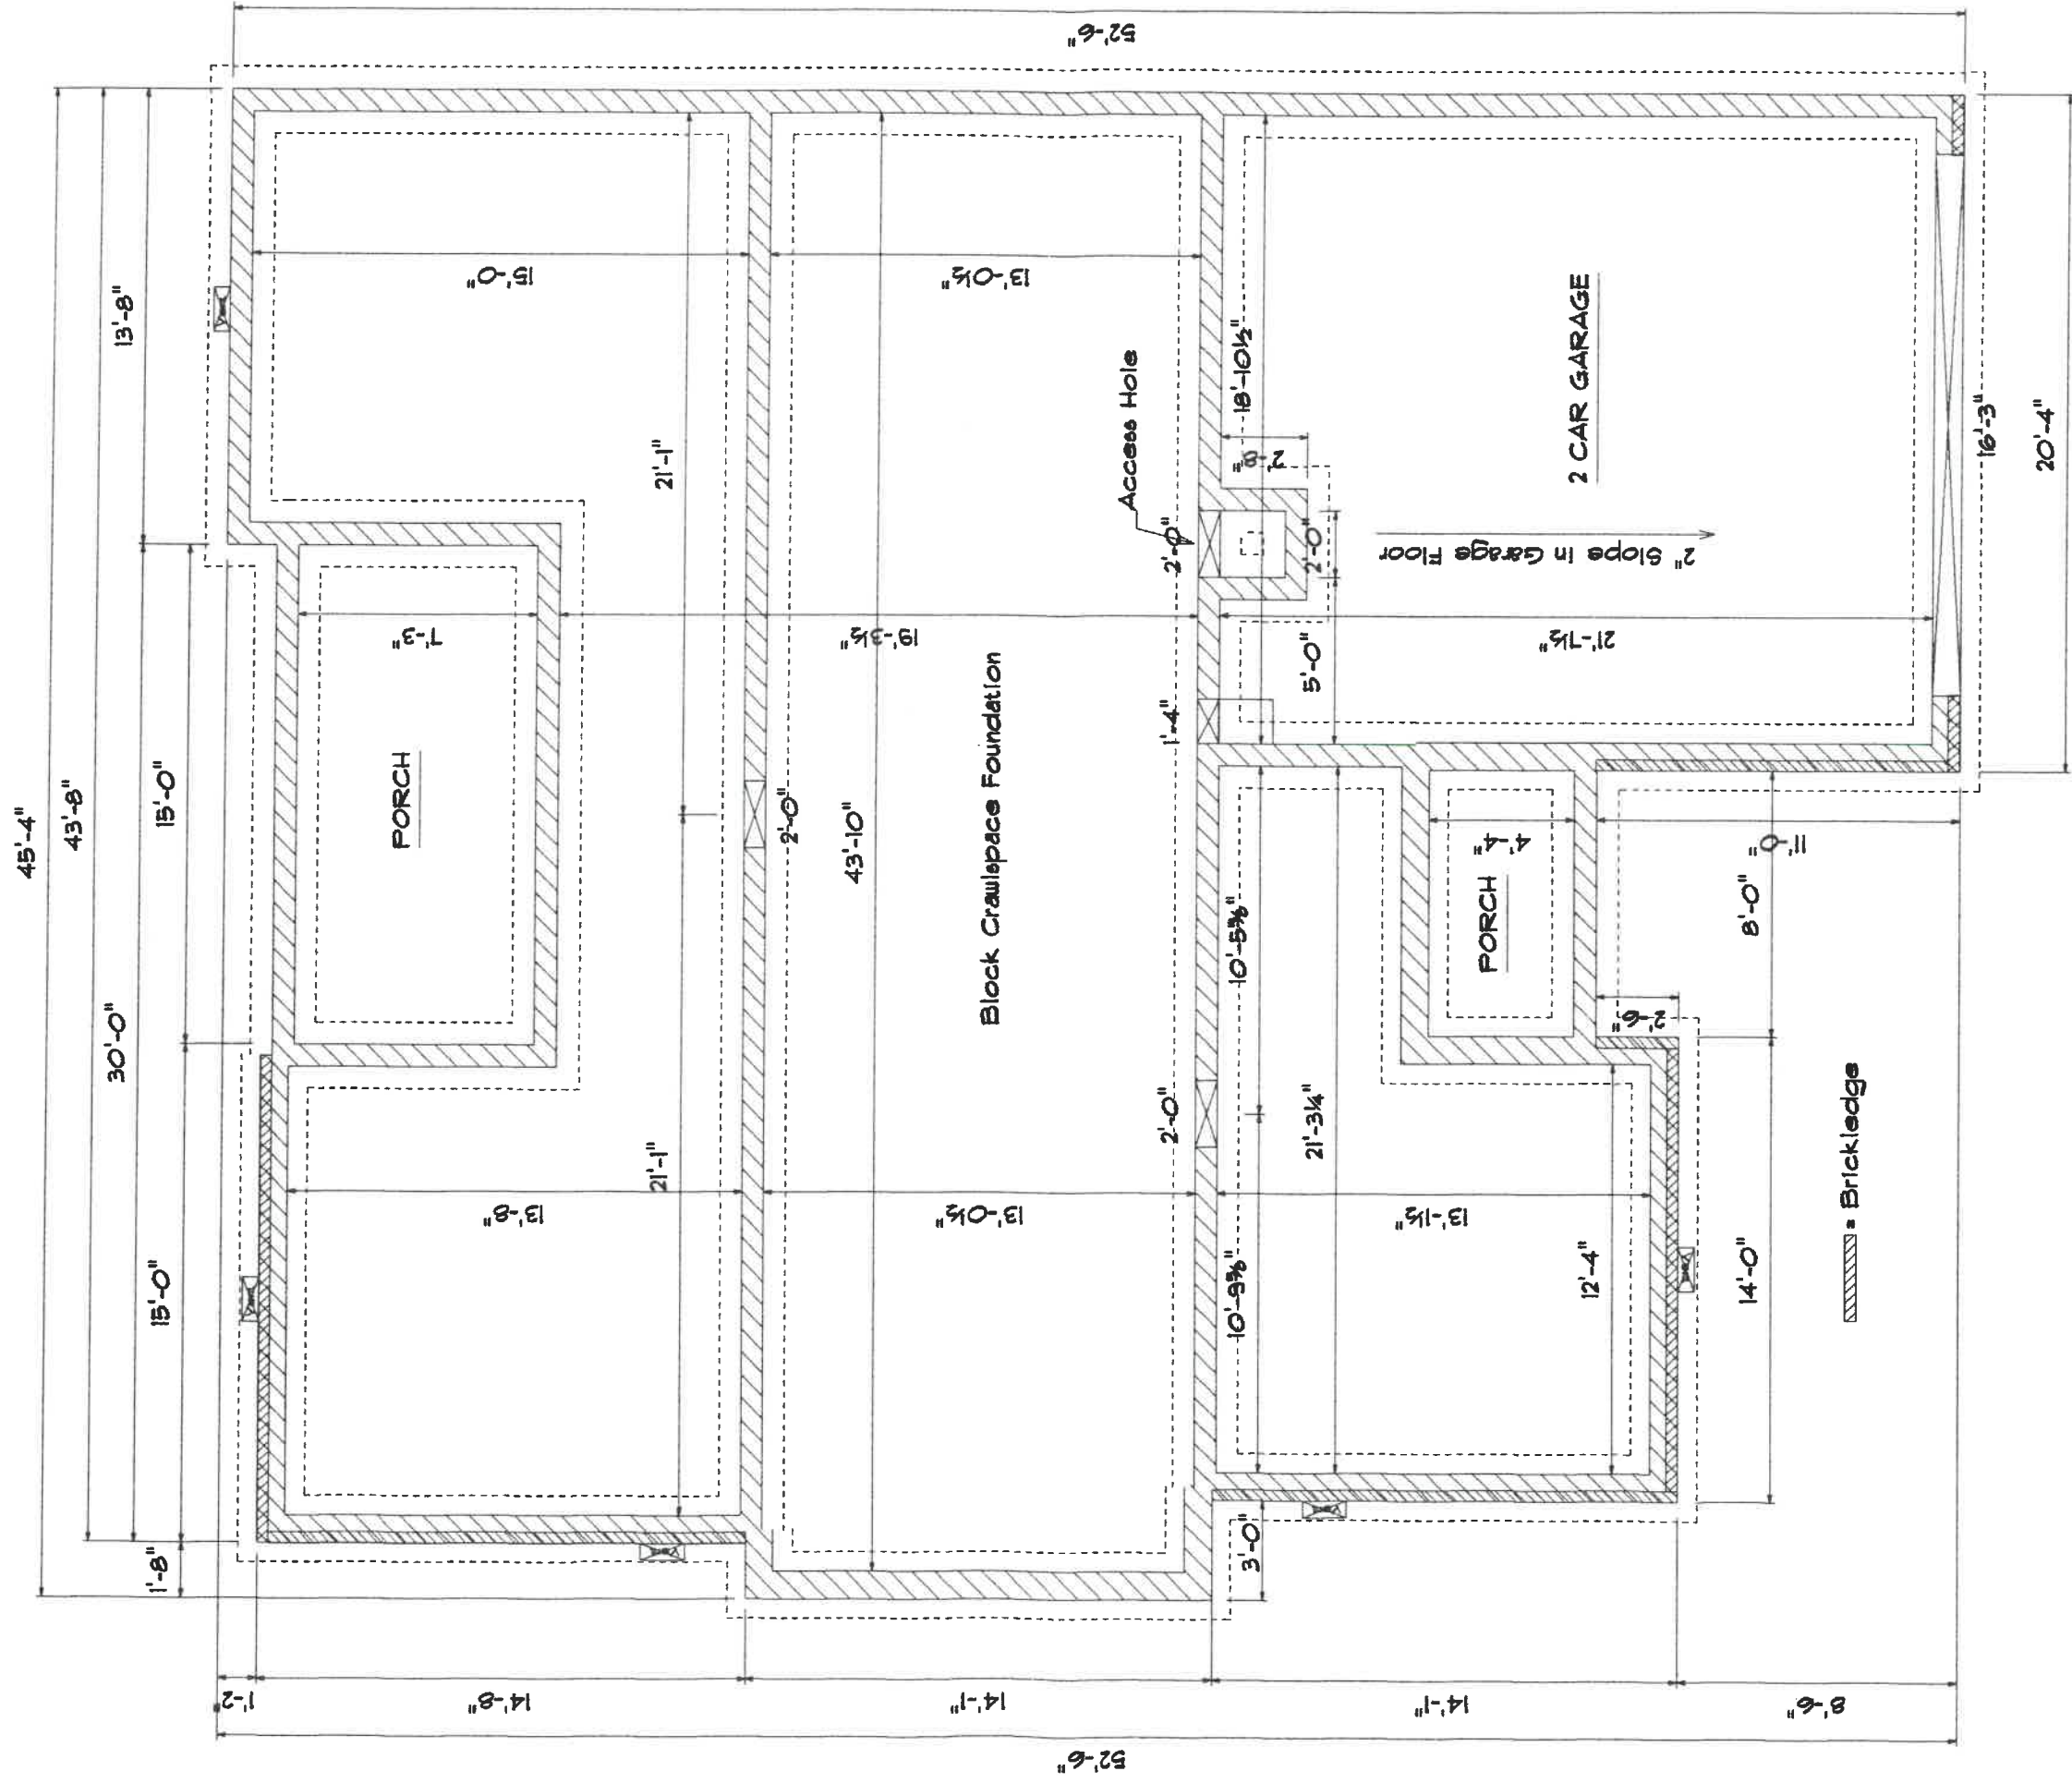

FOUNDATION PLAN

<i>Kahle Design &amp; Build</i>	
Defiance, Oh	Phone 437-4805
Scale: Var. 1/8"	Date 09/12/01
Mr. & Mrs. Junior Schmitkey	
Location: Bales Rd. Napoleon	



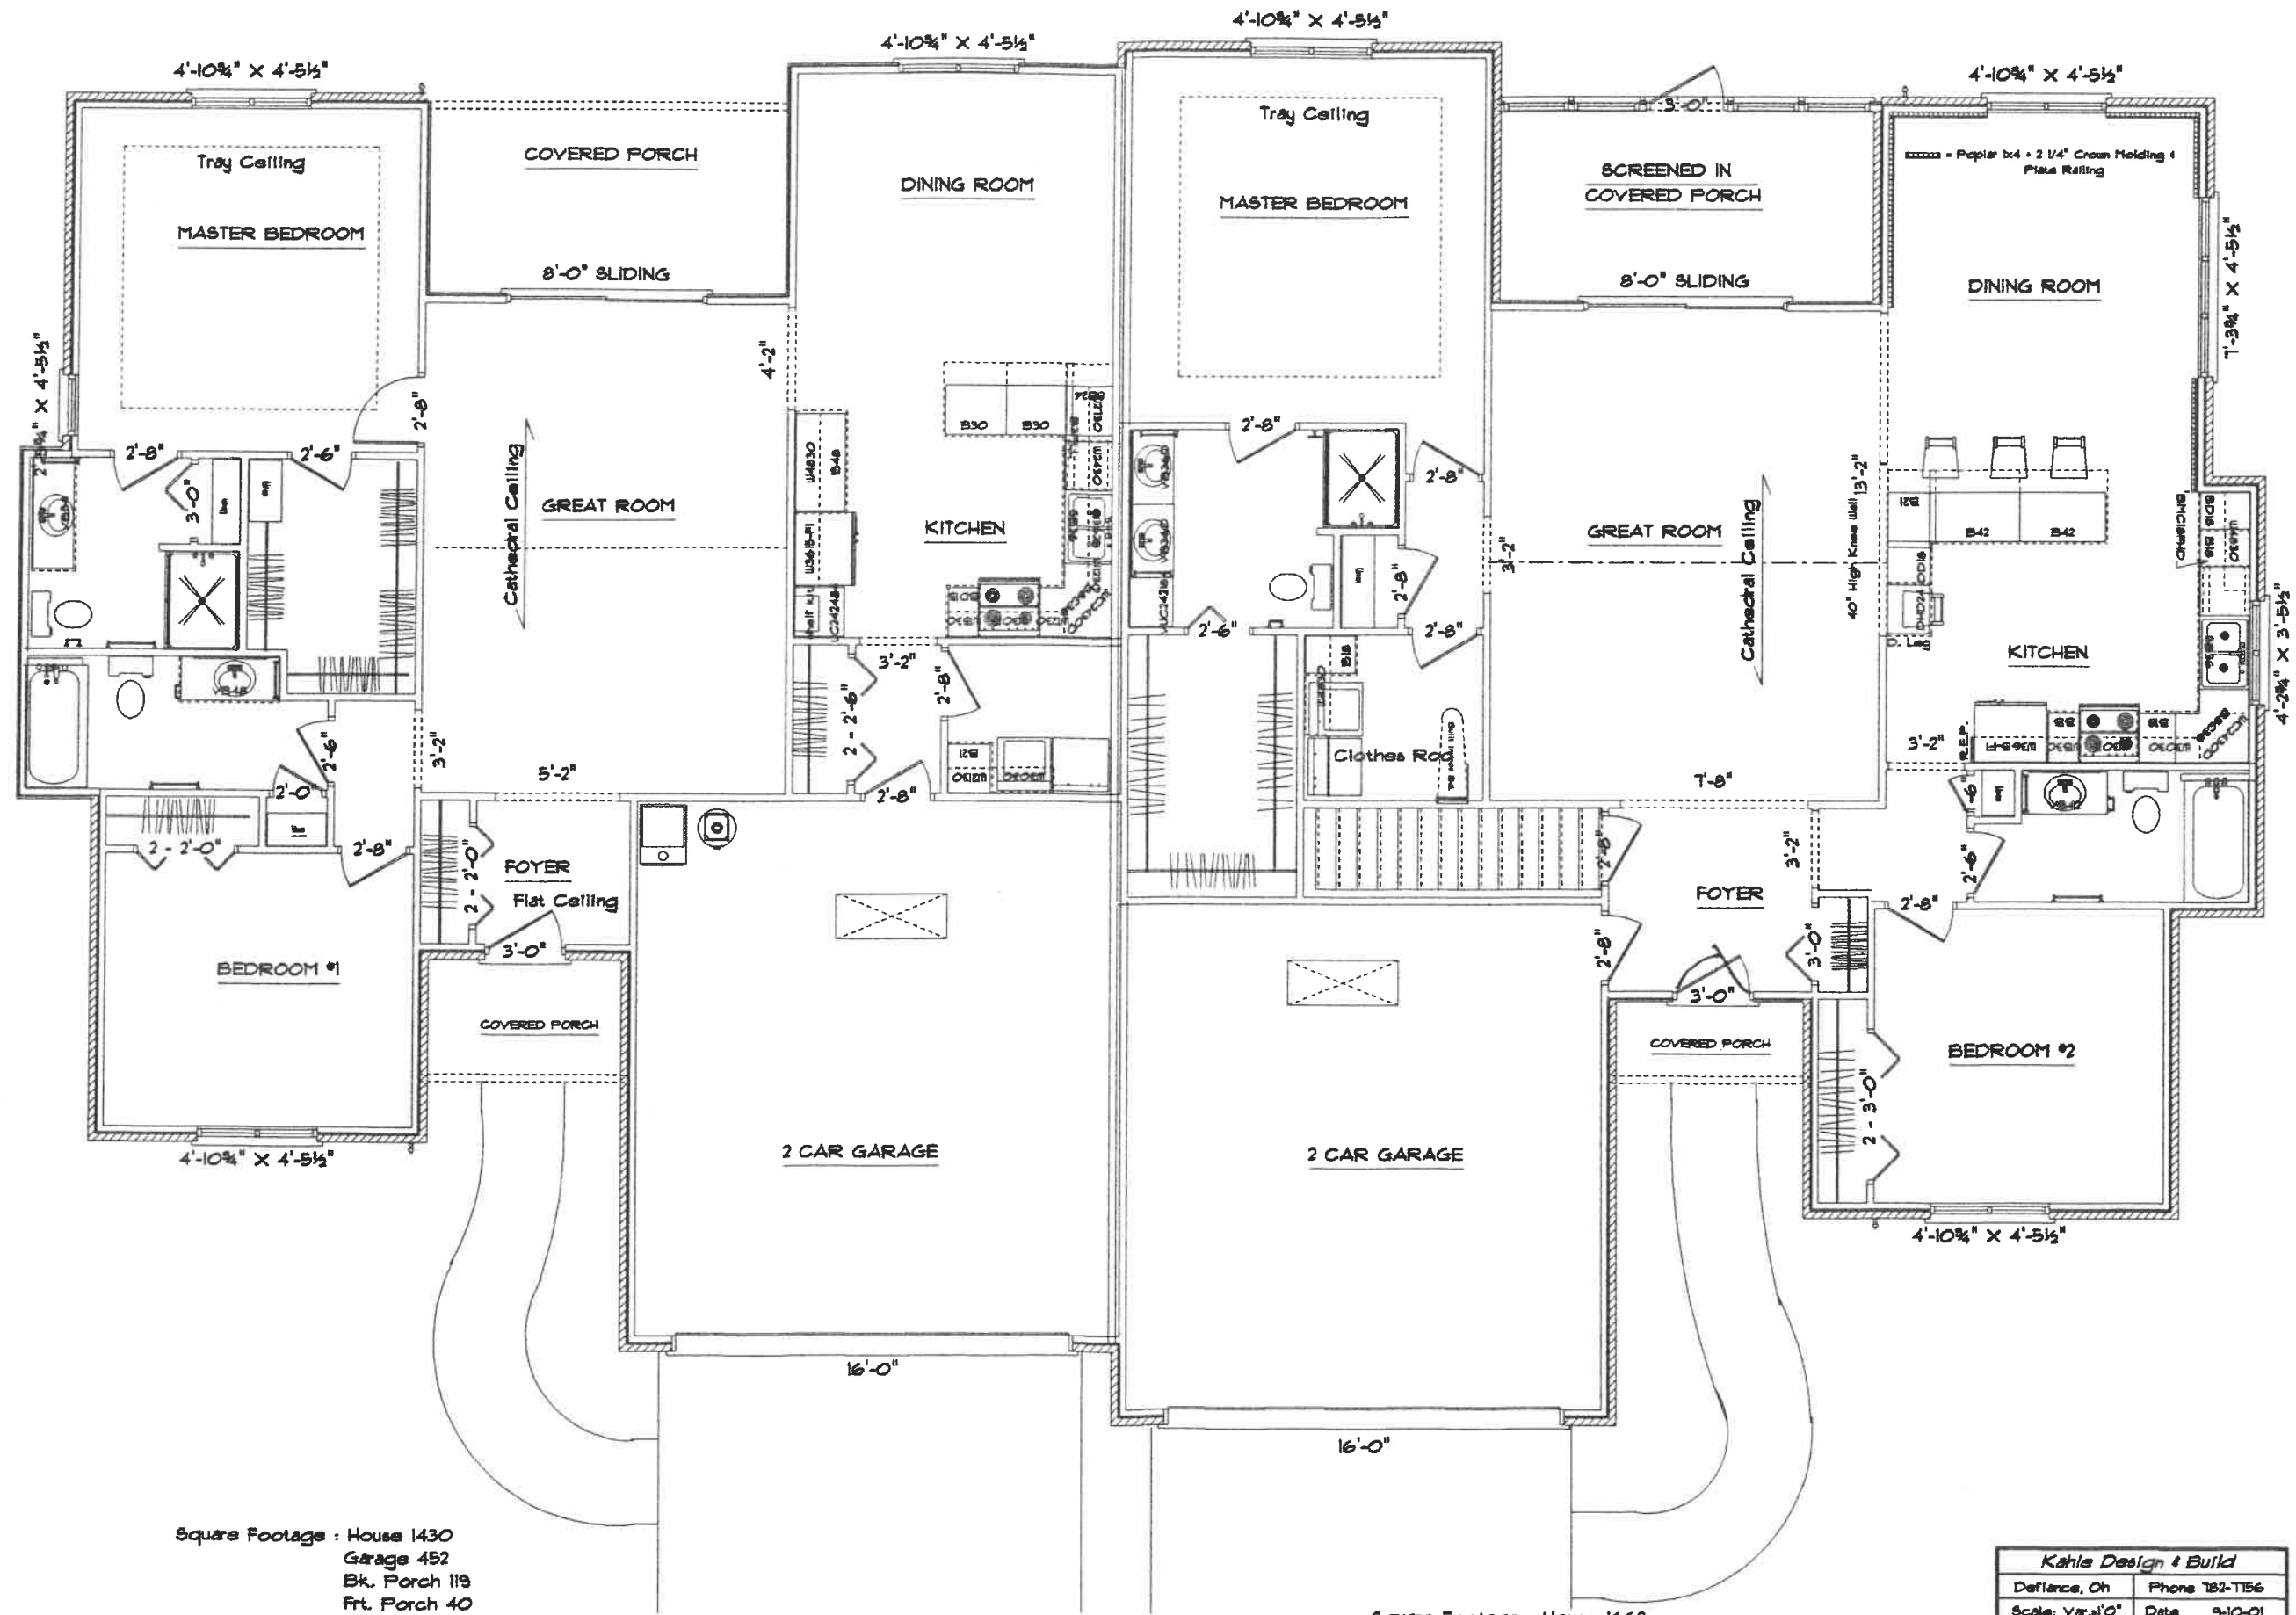


Square Footage : House 1430  
 Garage 452  
 Bk. Porch 119  
 Frt. Porch 40

Square Footage : House 1662  
 Garage 431  
 Bk. Porch 124  
 Frt. Porch 21

Kahle Design & Build	
Defiance, Oh	Phone 762-7566
Scale: Var. 1/8"	Date 9-10-01
Napoleon Condo's	
Location : Bates Rd. Napoleon	

CHELSEA AVENUE

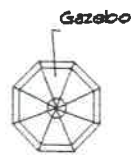

Scale : 1" = 40'

**KAHLE DESIGN & BUILD**  
DEFIANCE, OHIO

Ph. 491-4805 H. or 782-7156 Off.

**Plan of CHELSEA CONDO'S**