



FRONT ELEVATION

Address of property is 1135 Chelsea Ave.



REAR ELEVATION

Address of property is 1135 Chelsea Ave.


Note :
 In the interest of continuing product improvement Kahle Design & Build reserves the right to alter plans, specifications, materials, designs, appliance features, amenities etc. without prior notice. All maps, plans, and illustrations are artist's conceptions, and are not necessarily to scale. Square footages are approximate. Plans are drawn by Dave Kahle

Donald J. Farberman
Nancy A. Lankester

150,000

1135 Chelsea Ave
David R. Kahle 9/26/01

Kahle Design & Build	
Defiance, Oh	Phone 497-4805
Scale: Var. 1/8"	Date 09/10/01
Chelsea Condo's	
Location : Bales Rd. Napoleon	

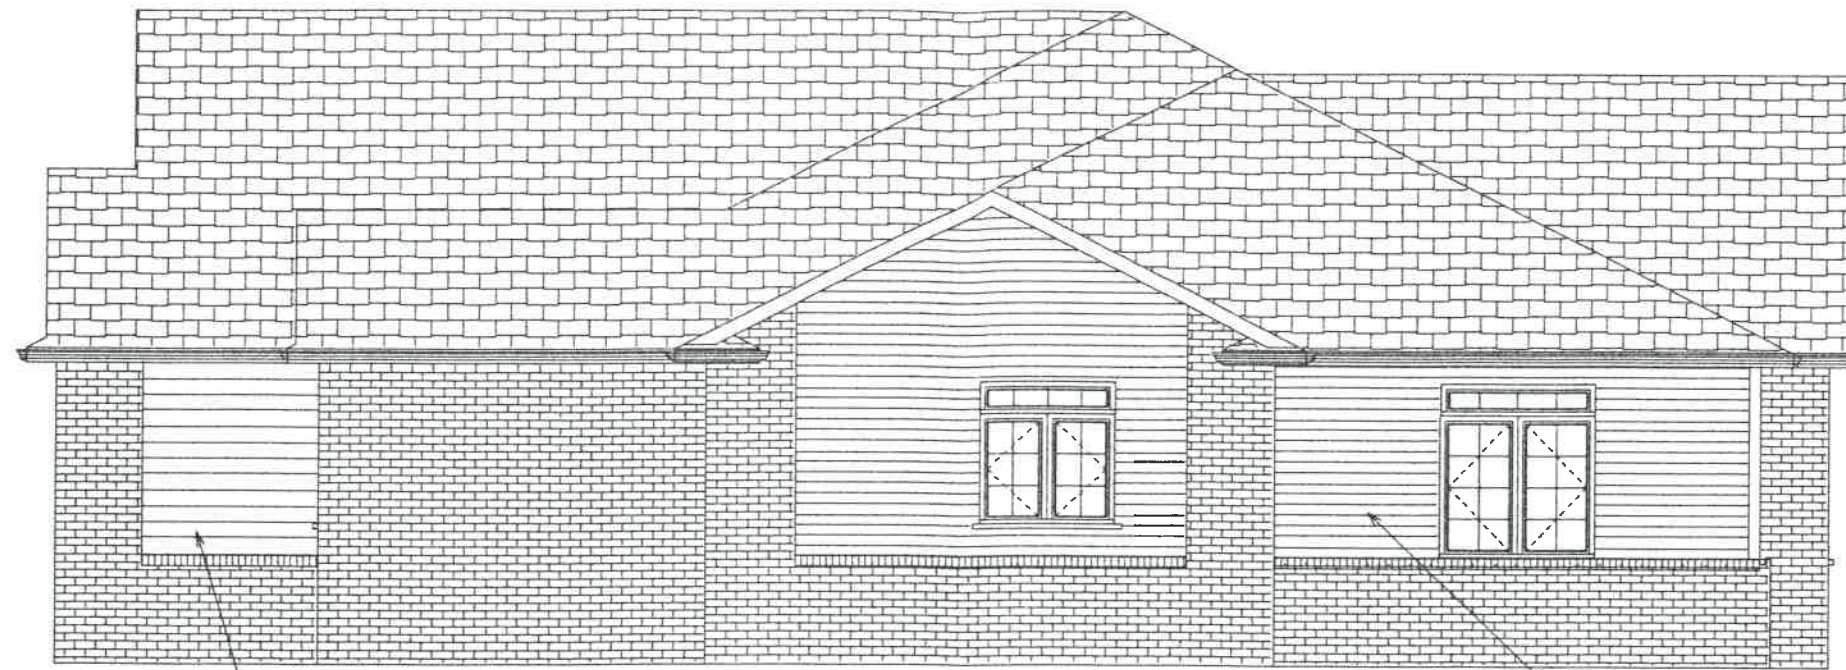


6" Wood Siding

RIGHT ELEVATION

4" Vinyl Siding

Address of property is 1135 Chelsea Ave.

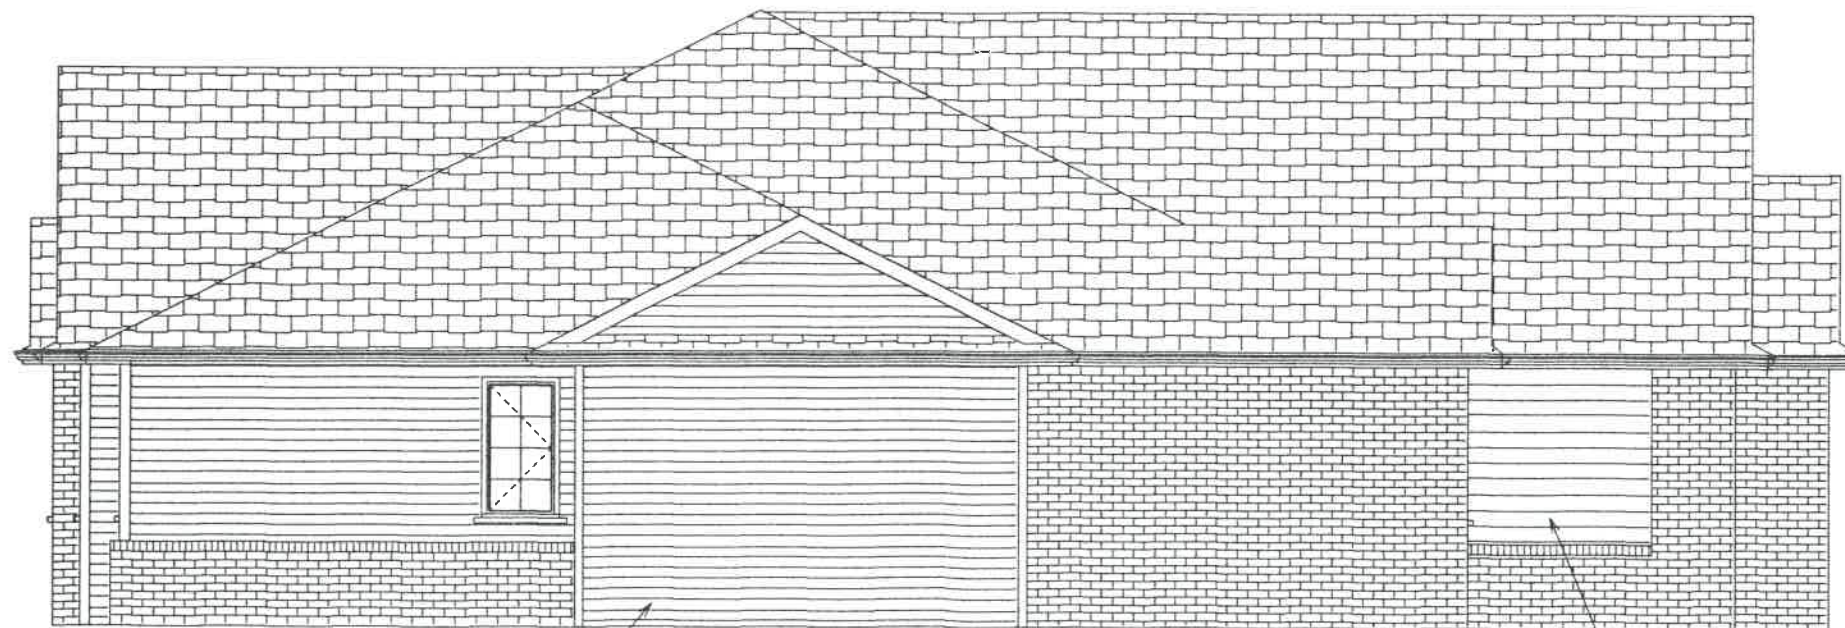


4" Vinyl Siding

LEFT ELEVATION

6" Wood Siding


Address of property is 1125 Chelsea Ave.

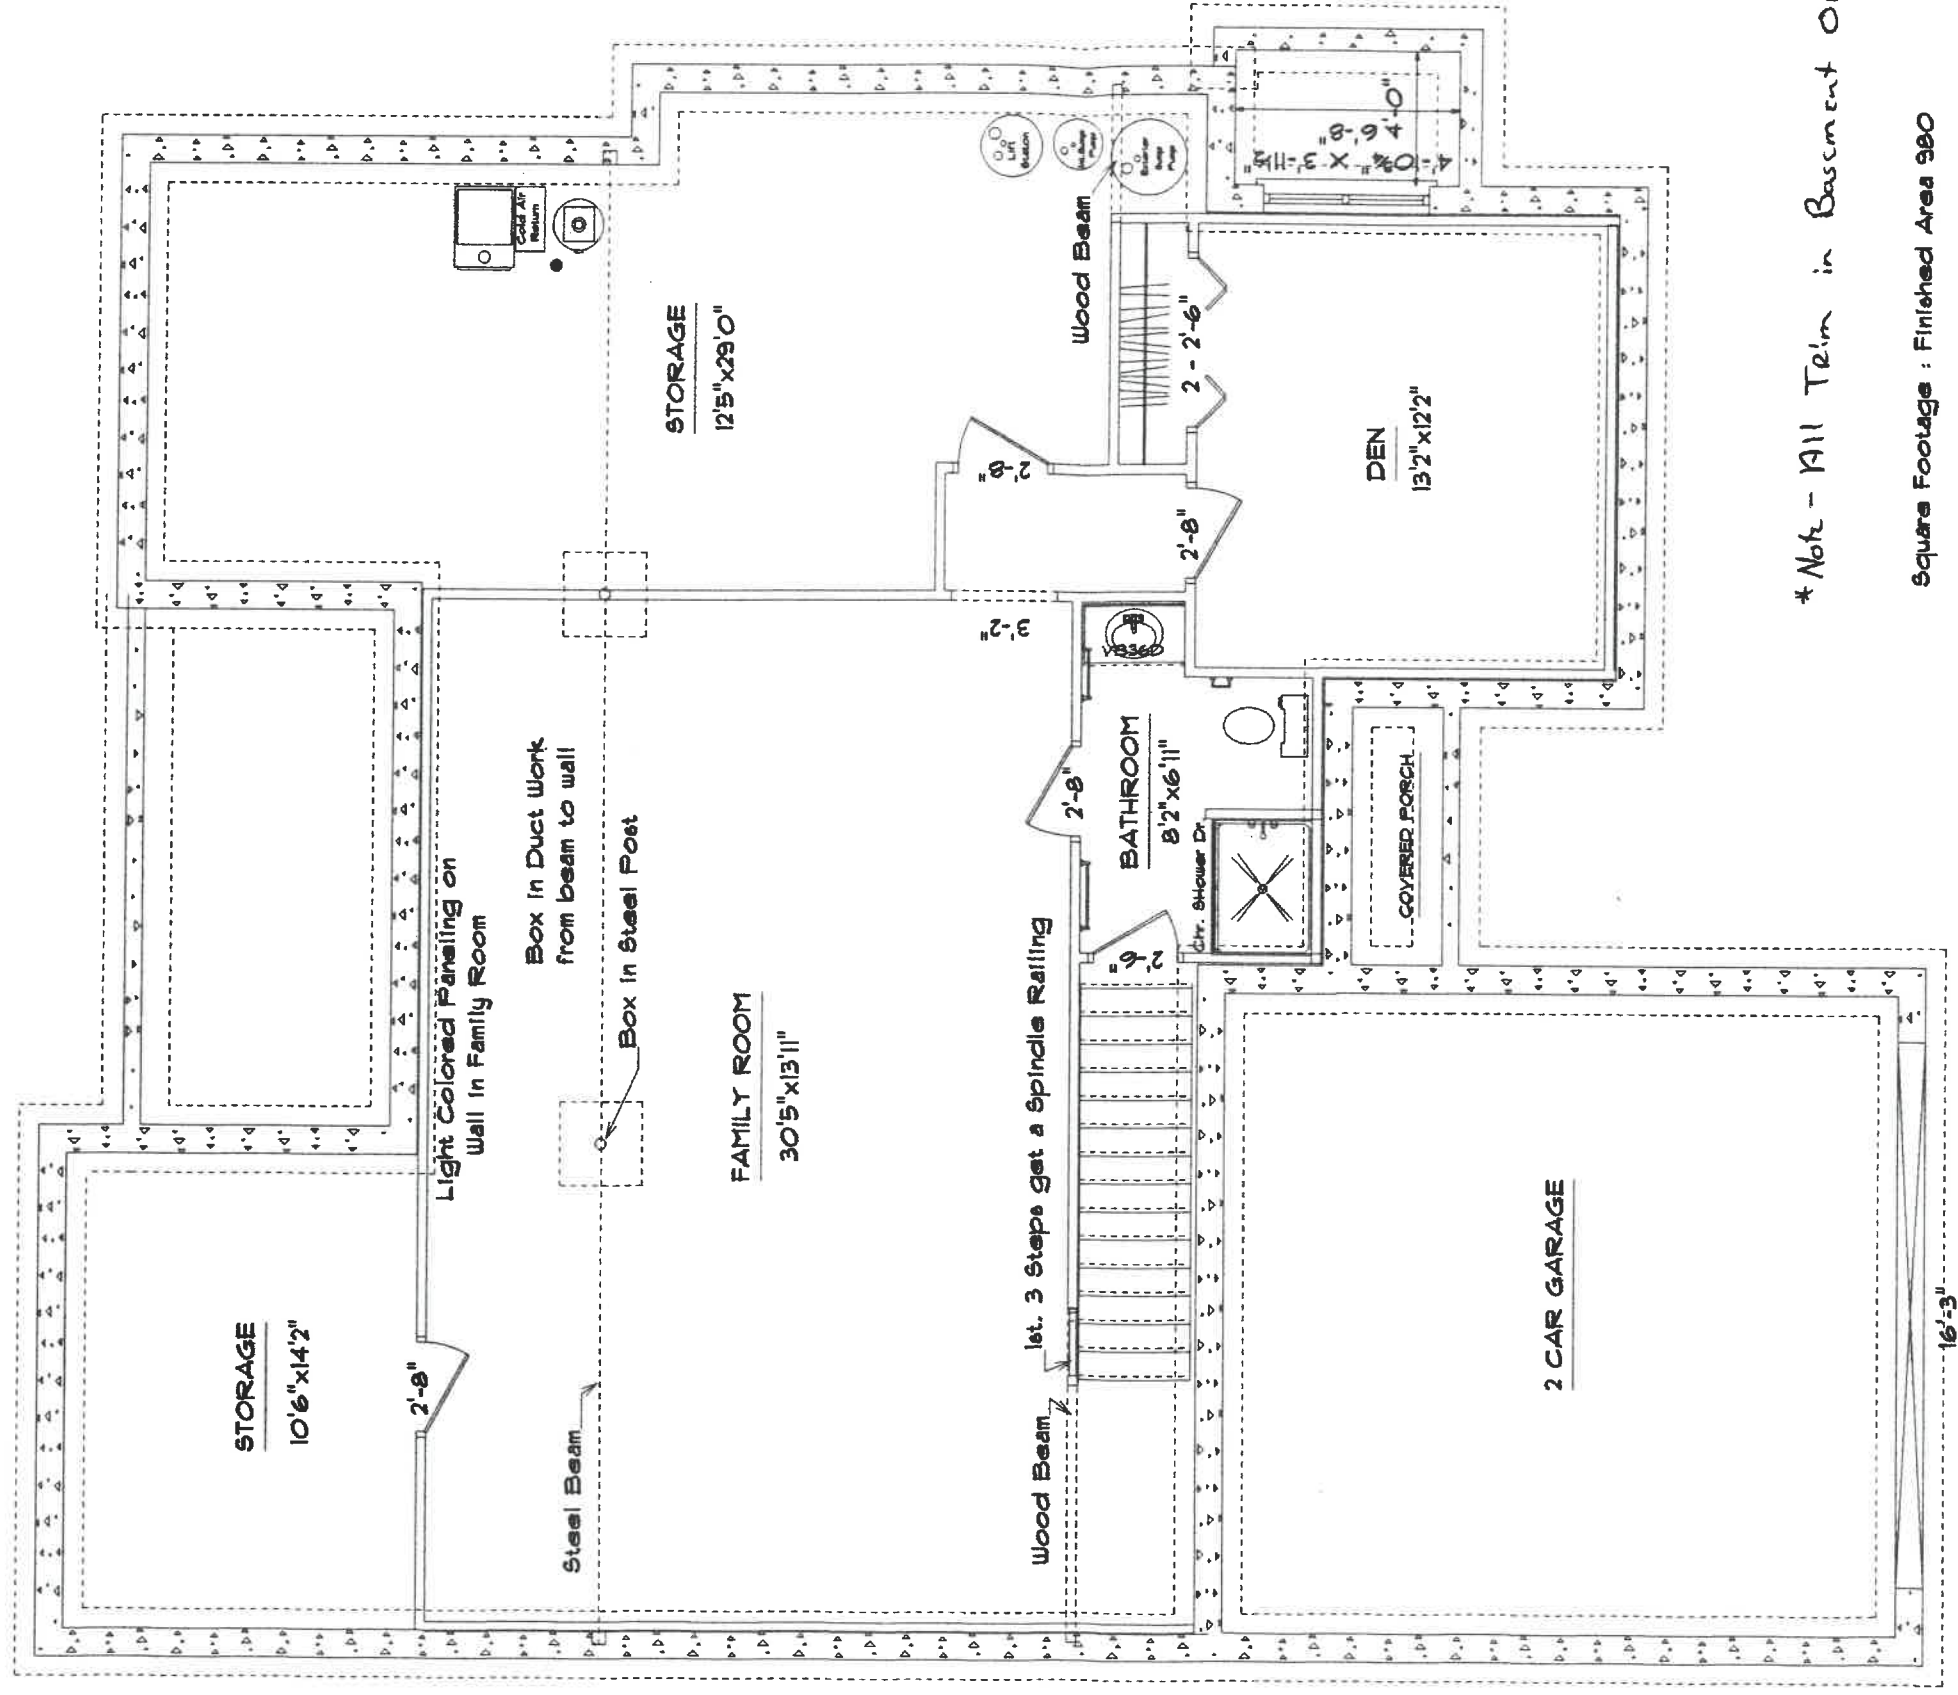

*Note - All Trim in Basement ONK

Square Footage : Finished Area 980

Chelsea Condo	
<i>Kahle Design & Build</i>	
Defiance, Oh	Phone 457-4905
Scale: 1/8"=1'0"	Date 08/25/01
Mr. & Mrs. Ron Lankenau	
Location : Chelsea Ave. Napoleon	

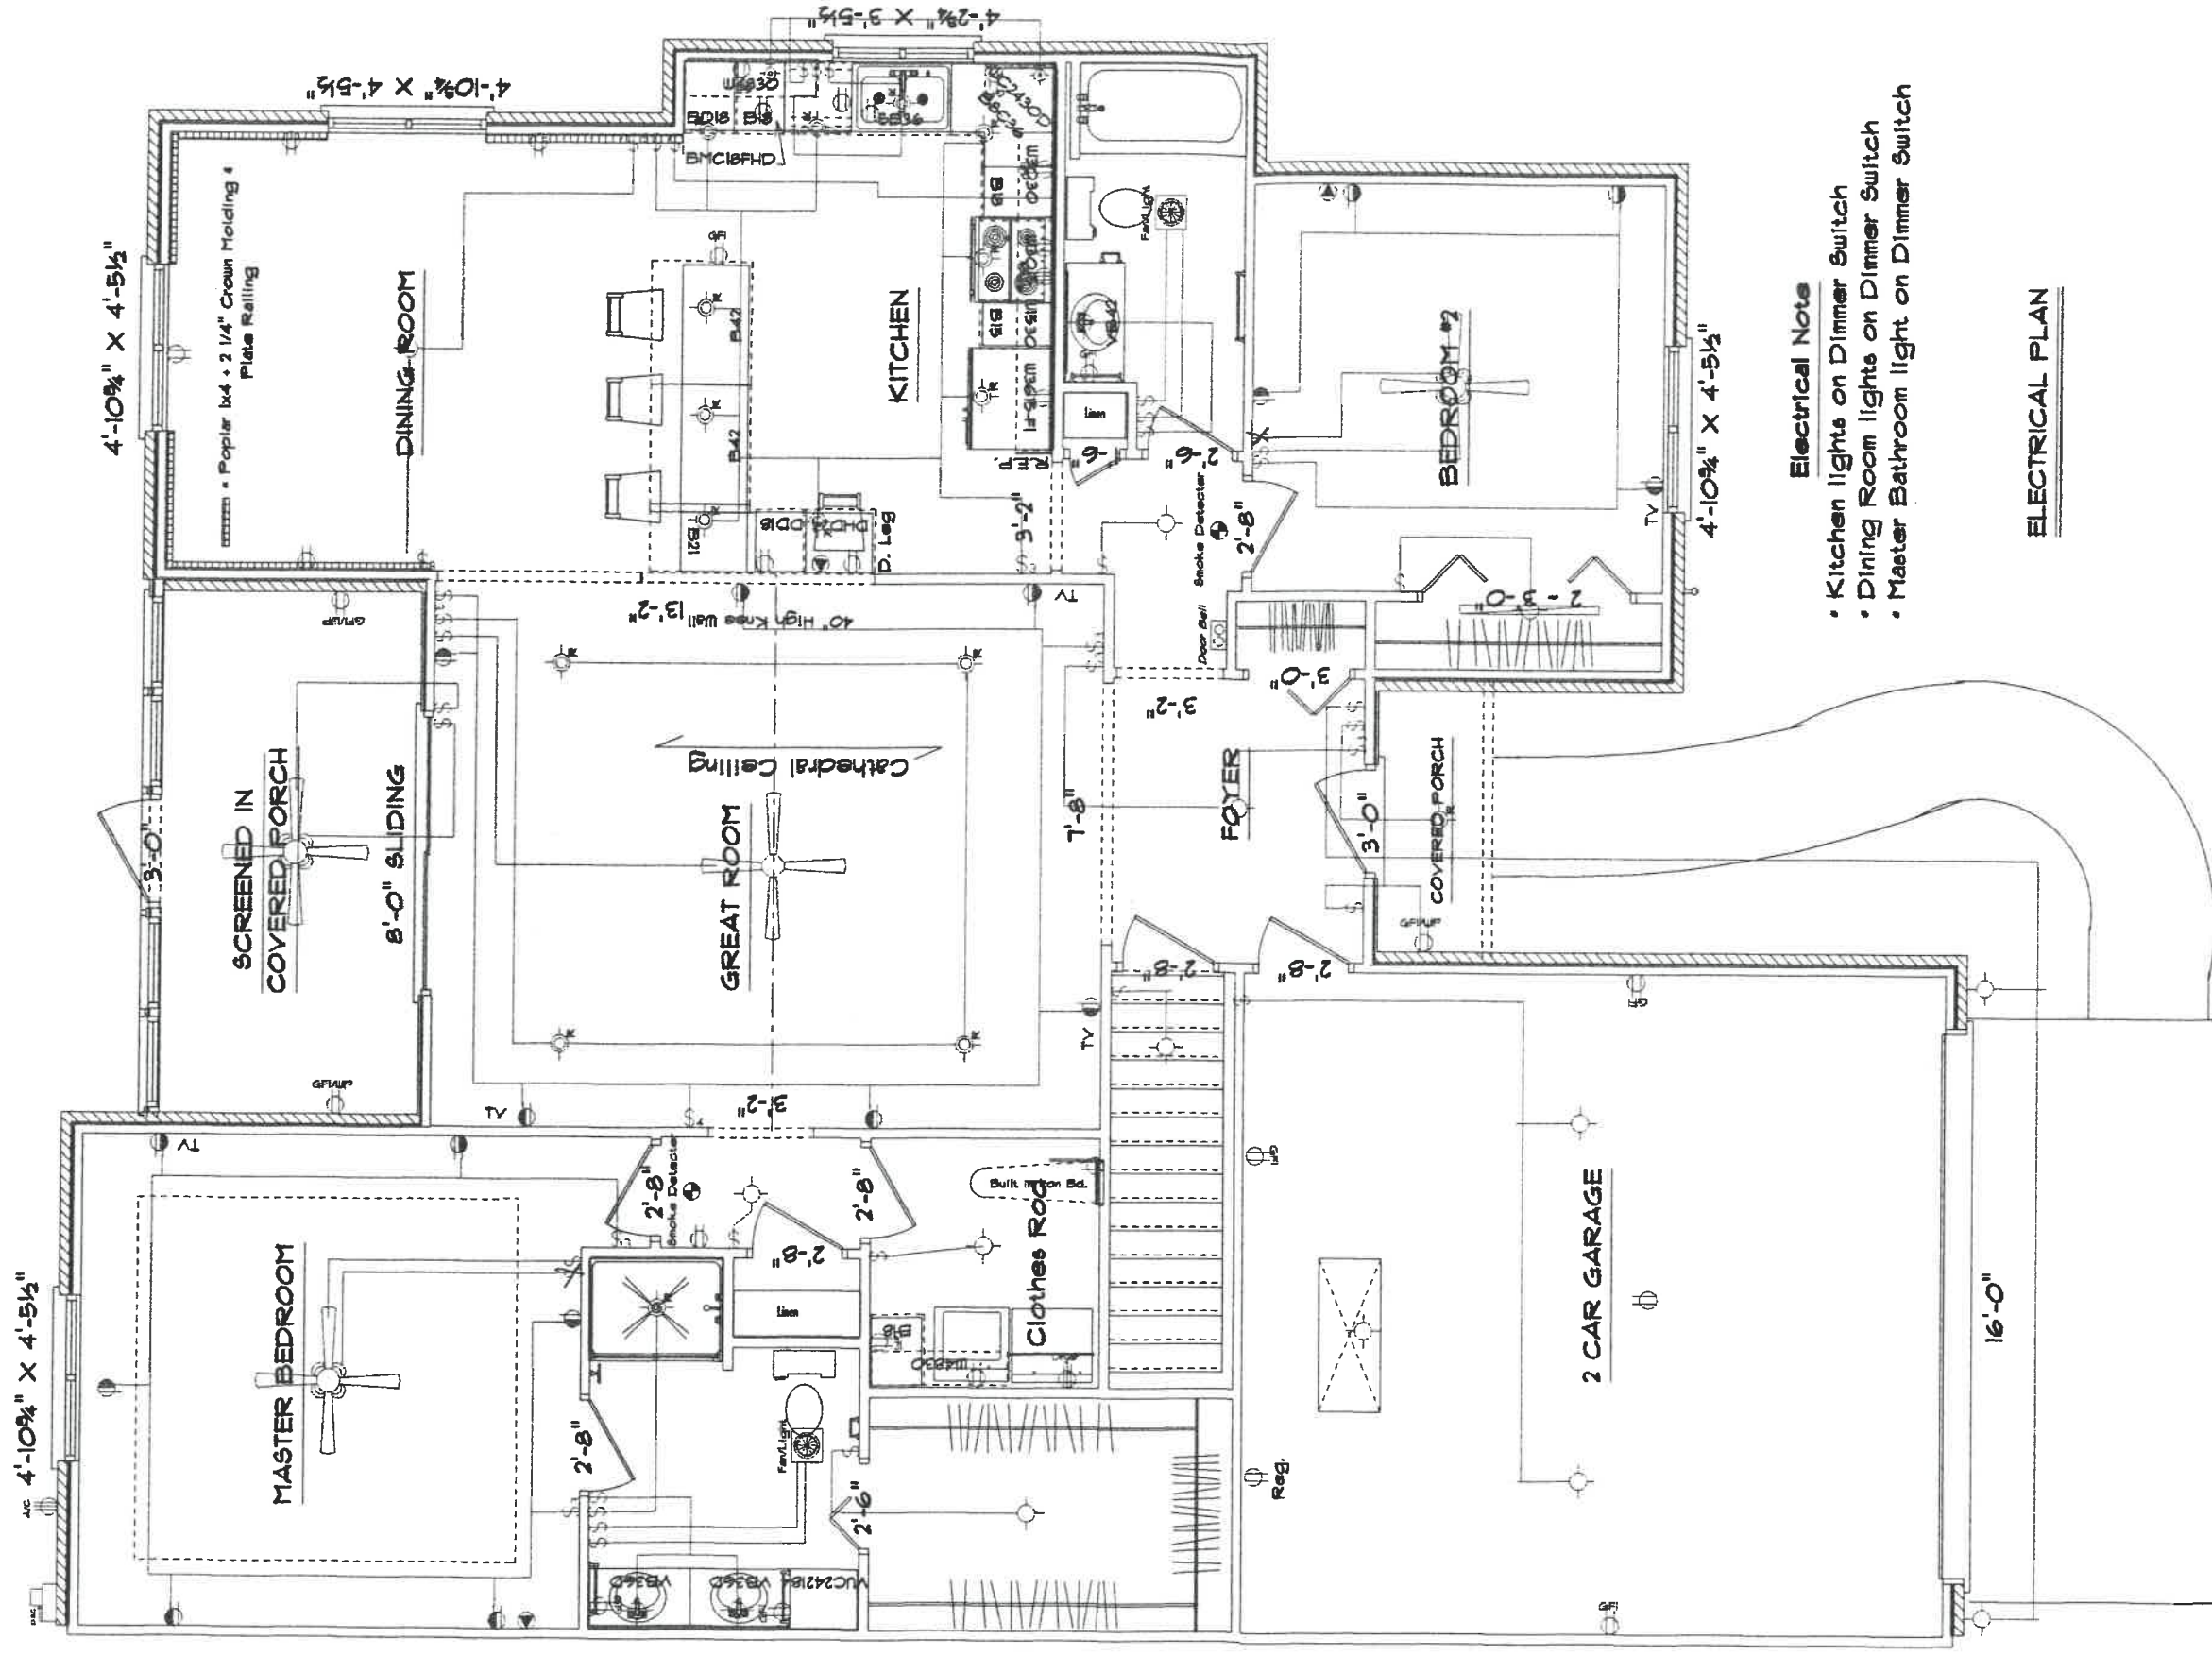


Electrical Note

- Kitchen lights on Dimmer Switch
- Dining Room lights on Dimmer Switch
- Master Bathroom light on Dimmer Switch

ELECTRICAL PLAN

Square Footage : House 1662
 Garage 431
 Bk. Porch 124
 Frt. Porch 27


Kahle Design & Build	
Defiance, Oh	Phone 497-4905
Scale: 3/16"=1'0"	Date 9-26-01
Mr. & Mrs. Ron Lankenau	
Location : Bales Rd. Napoleon	

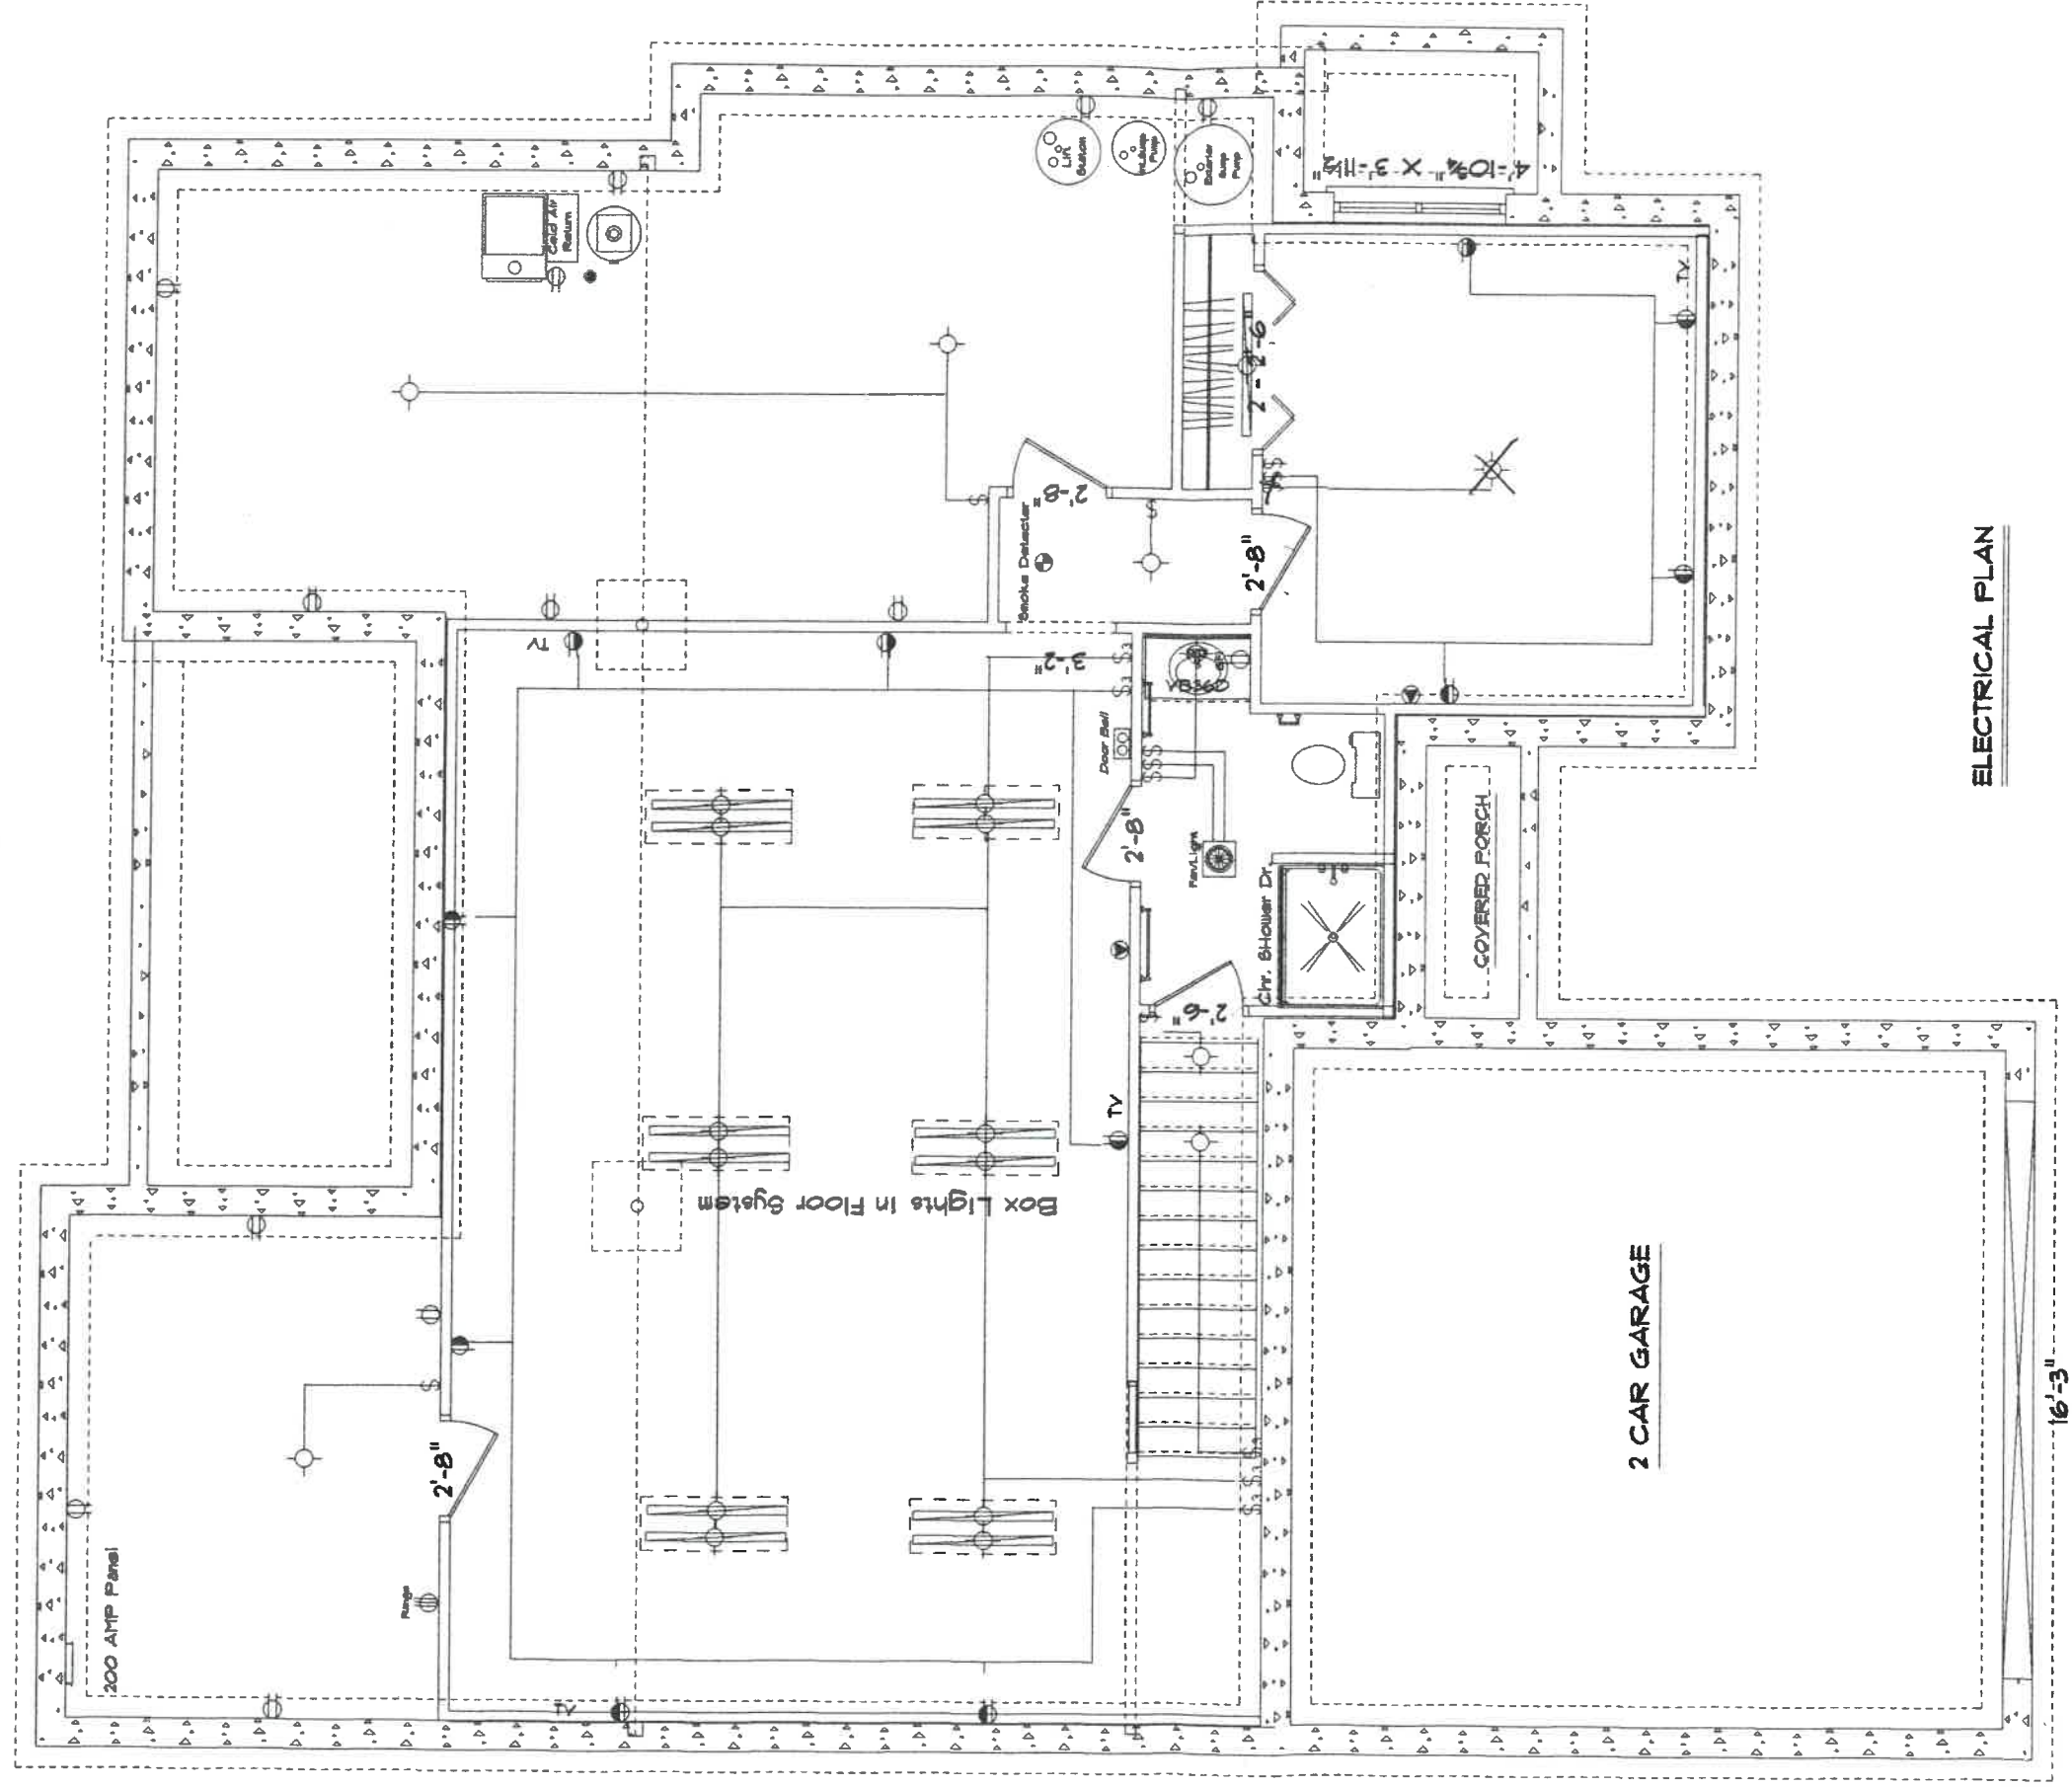

ELECTRICAL PLAN

Chelsea Condo

Kahle Design & Build	
Defiance, Oh	Phone 497-4805
Scale: Var-10"	Date: 9/26/01
Mr. & Mrs. Ron Lankenau	
Location: Chelsea Ave. Napoleon	

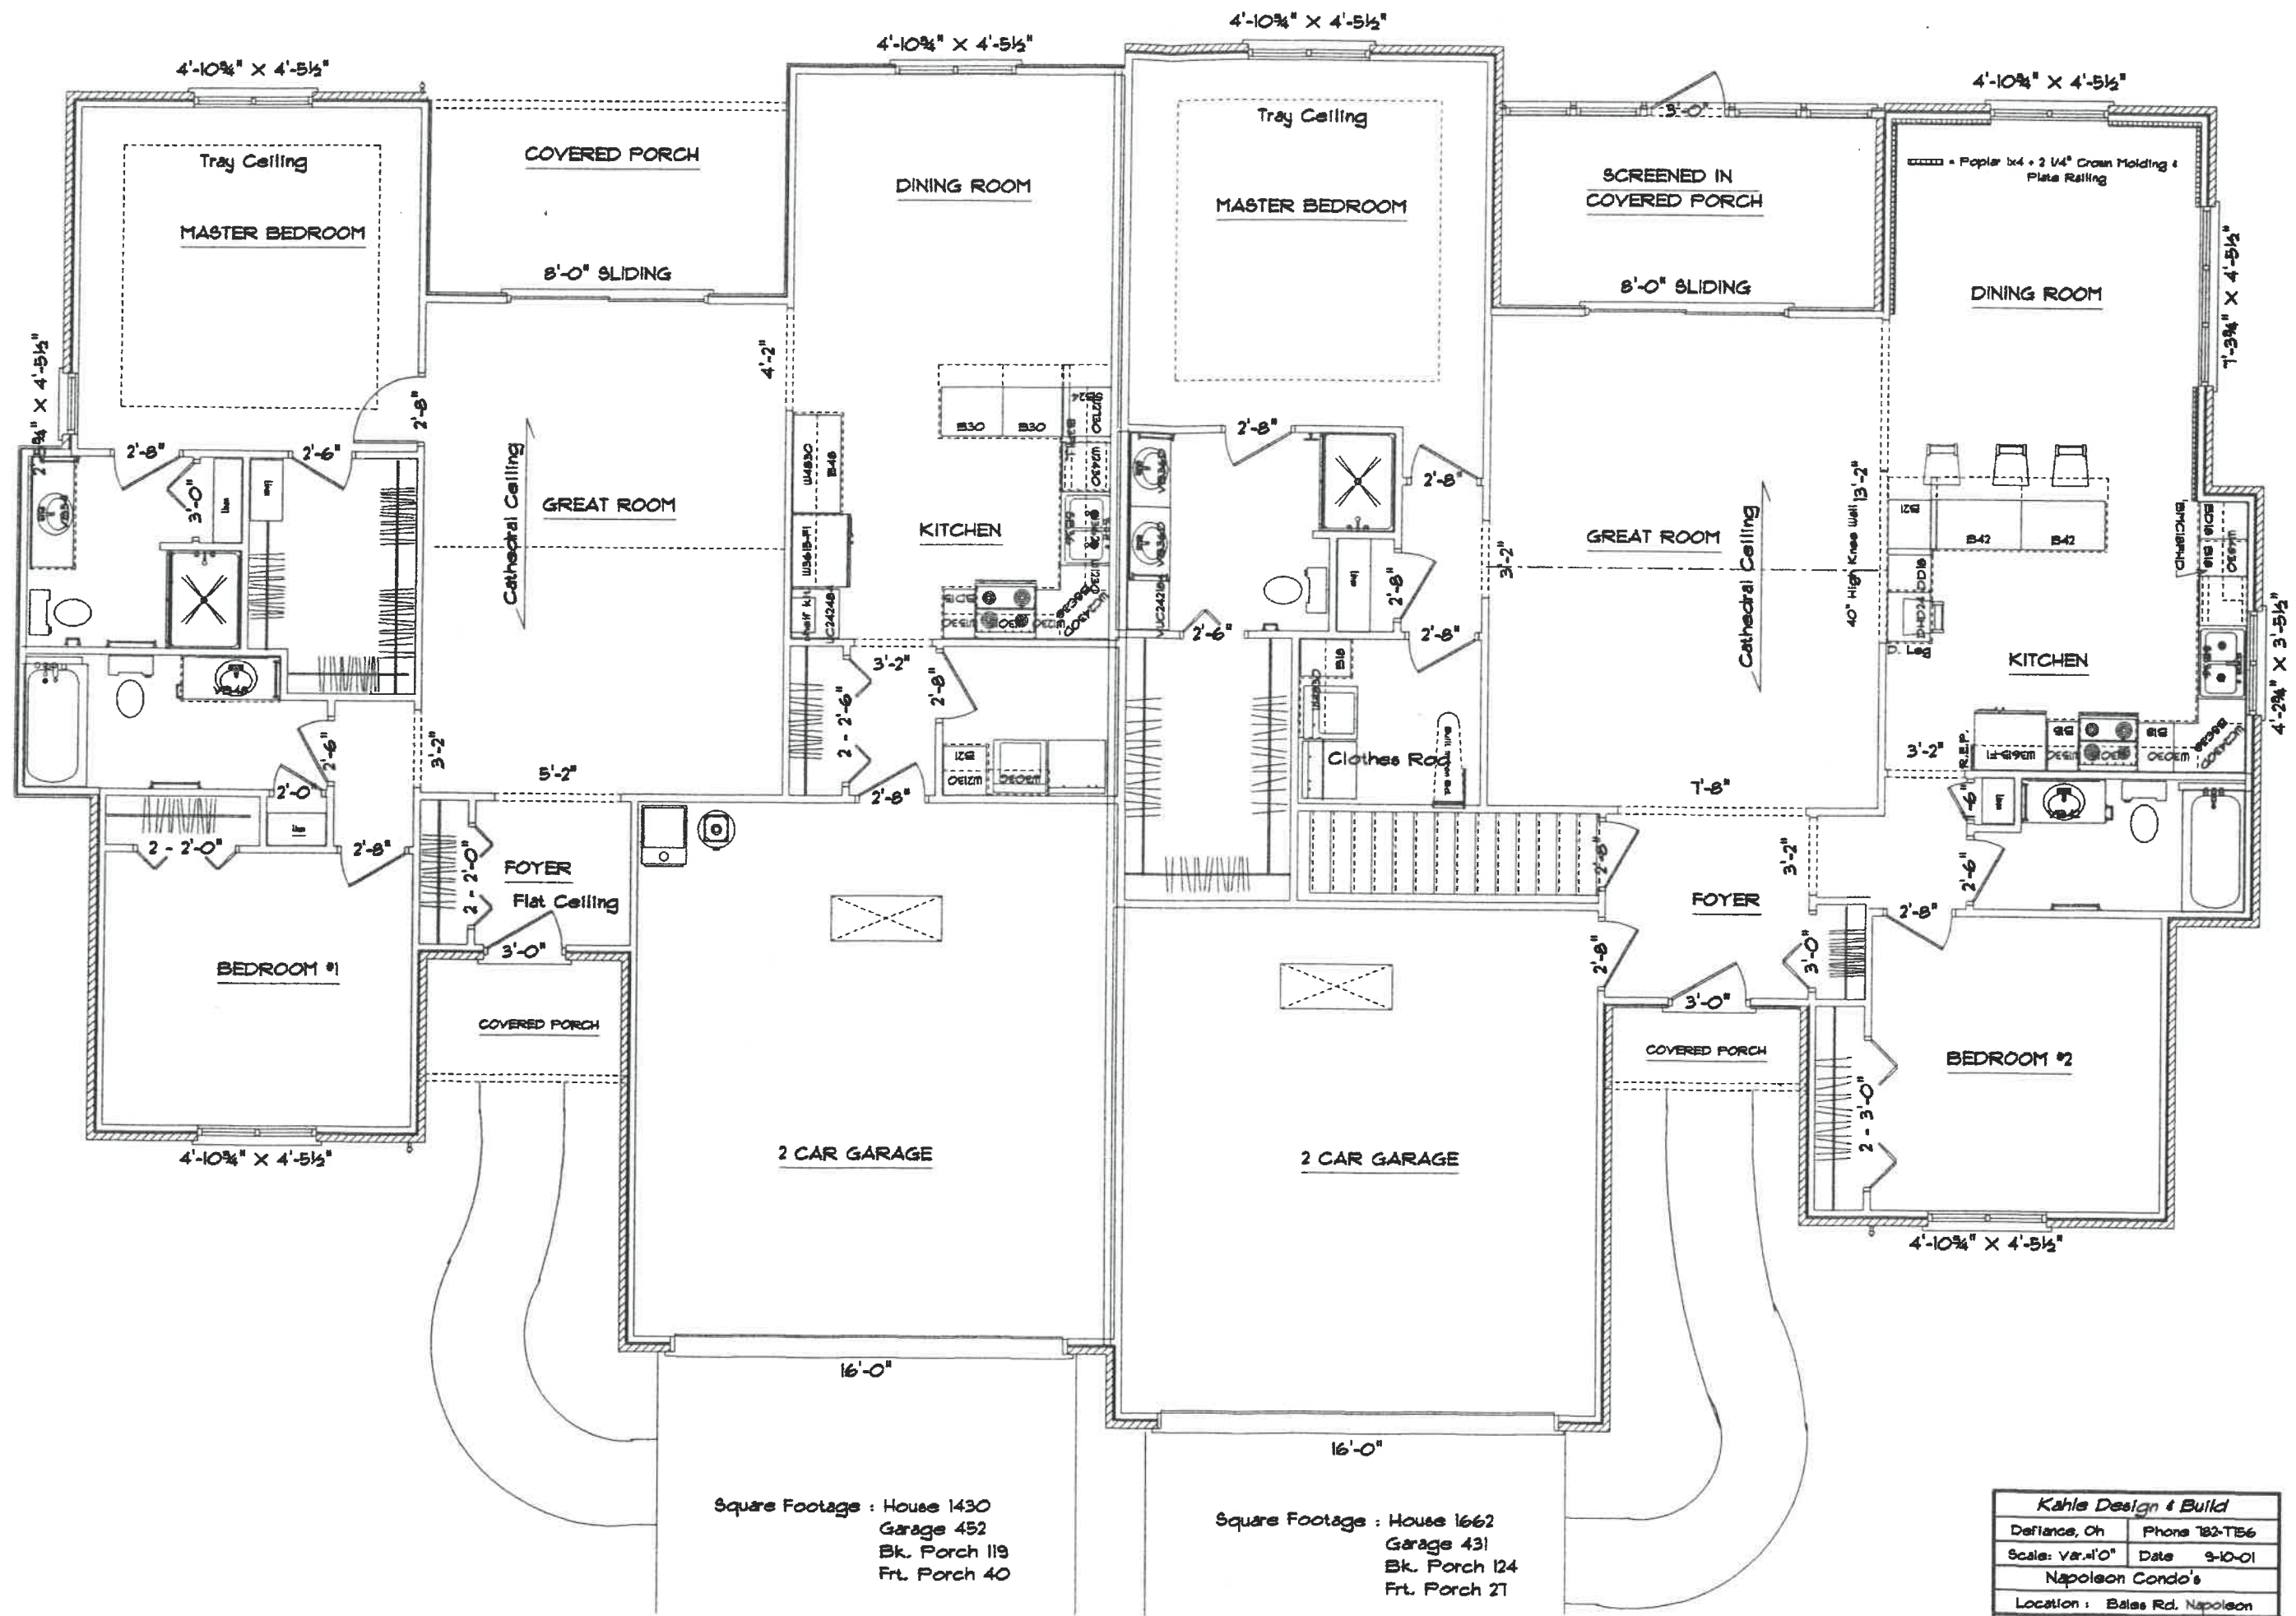


Square Footage : House 1430
 Garage 452
 Bk. Porch 119
 Frt. Porch 40

Square Footage : House 1662
 Garage 431
 Bk. Porch 124
 Frt. Porch 27

Kahle Design & Build	
Defiance, Oh	Phone 782-756
Scale: Var. 1/8"	Date 9-10-01
Napoleon Condo's	
Location : Balas Rd. Napoleon	

CHELSEA AVENUE

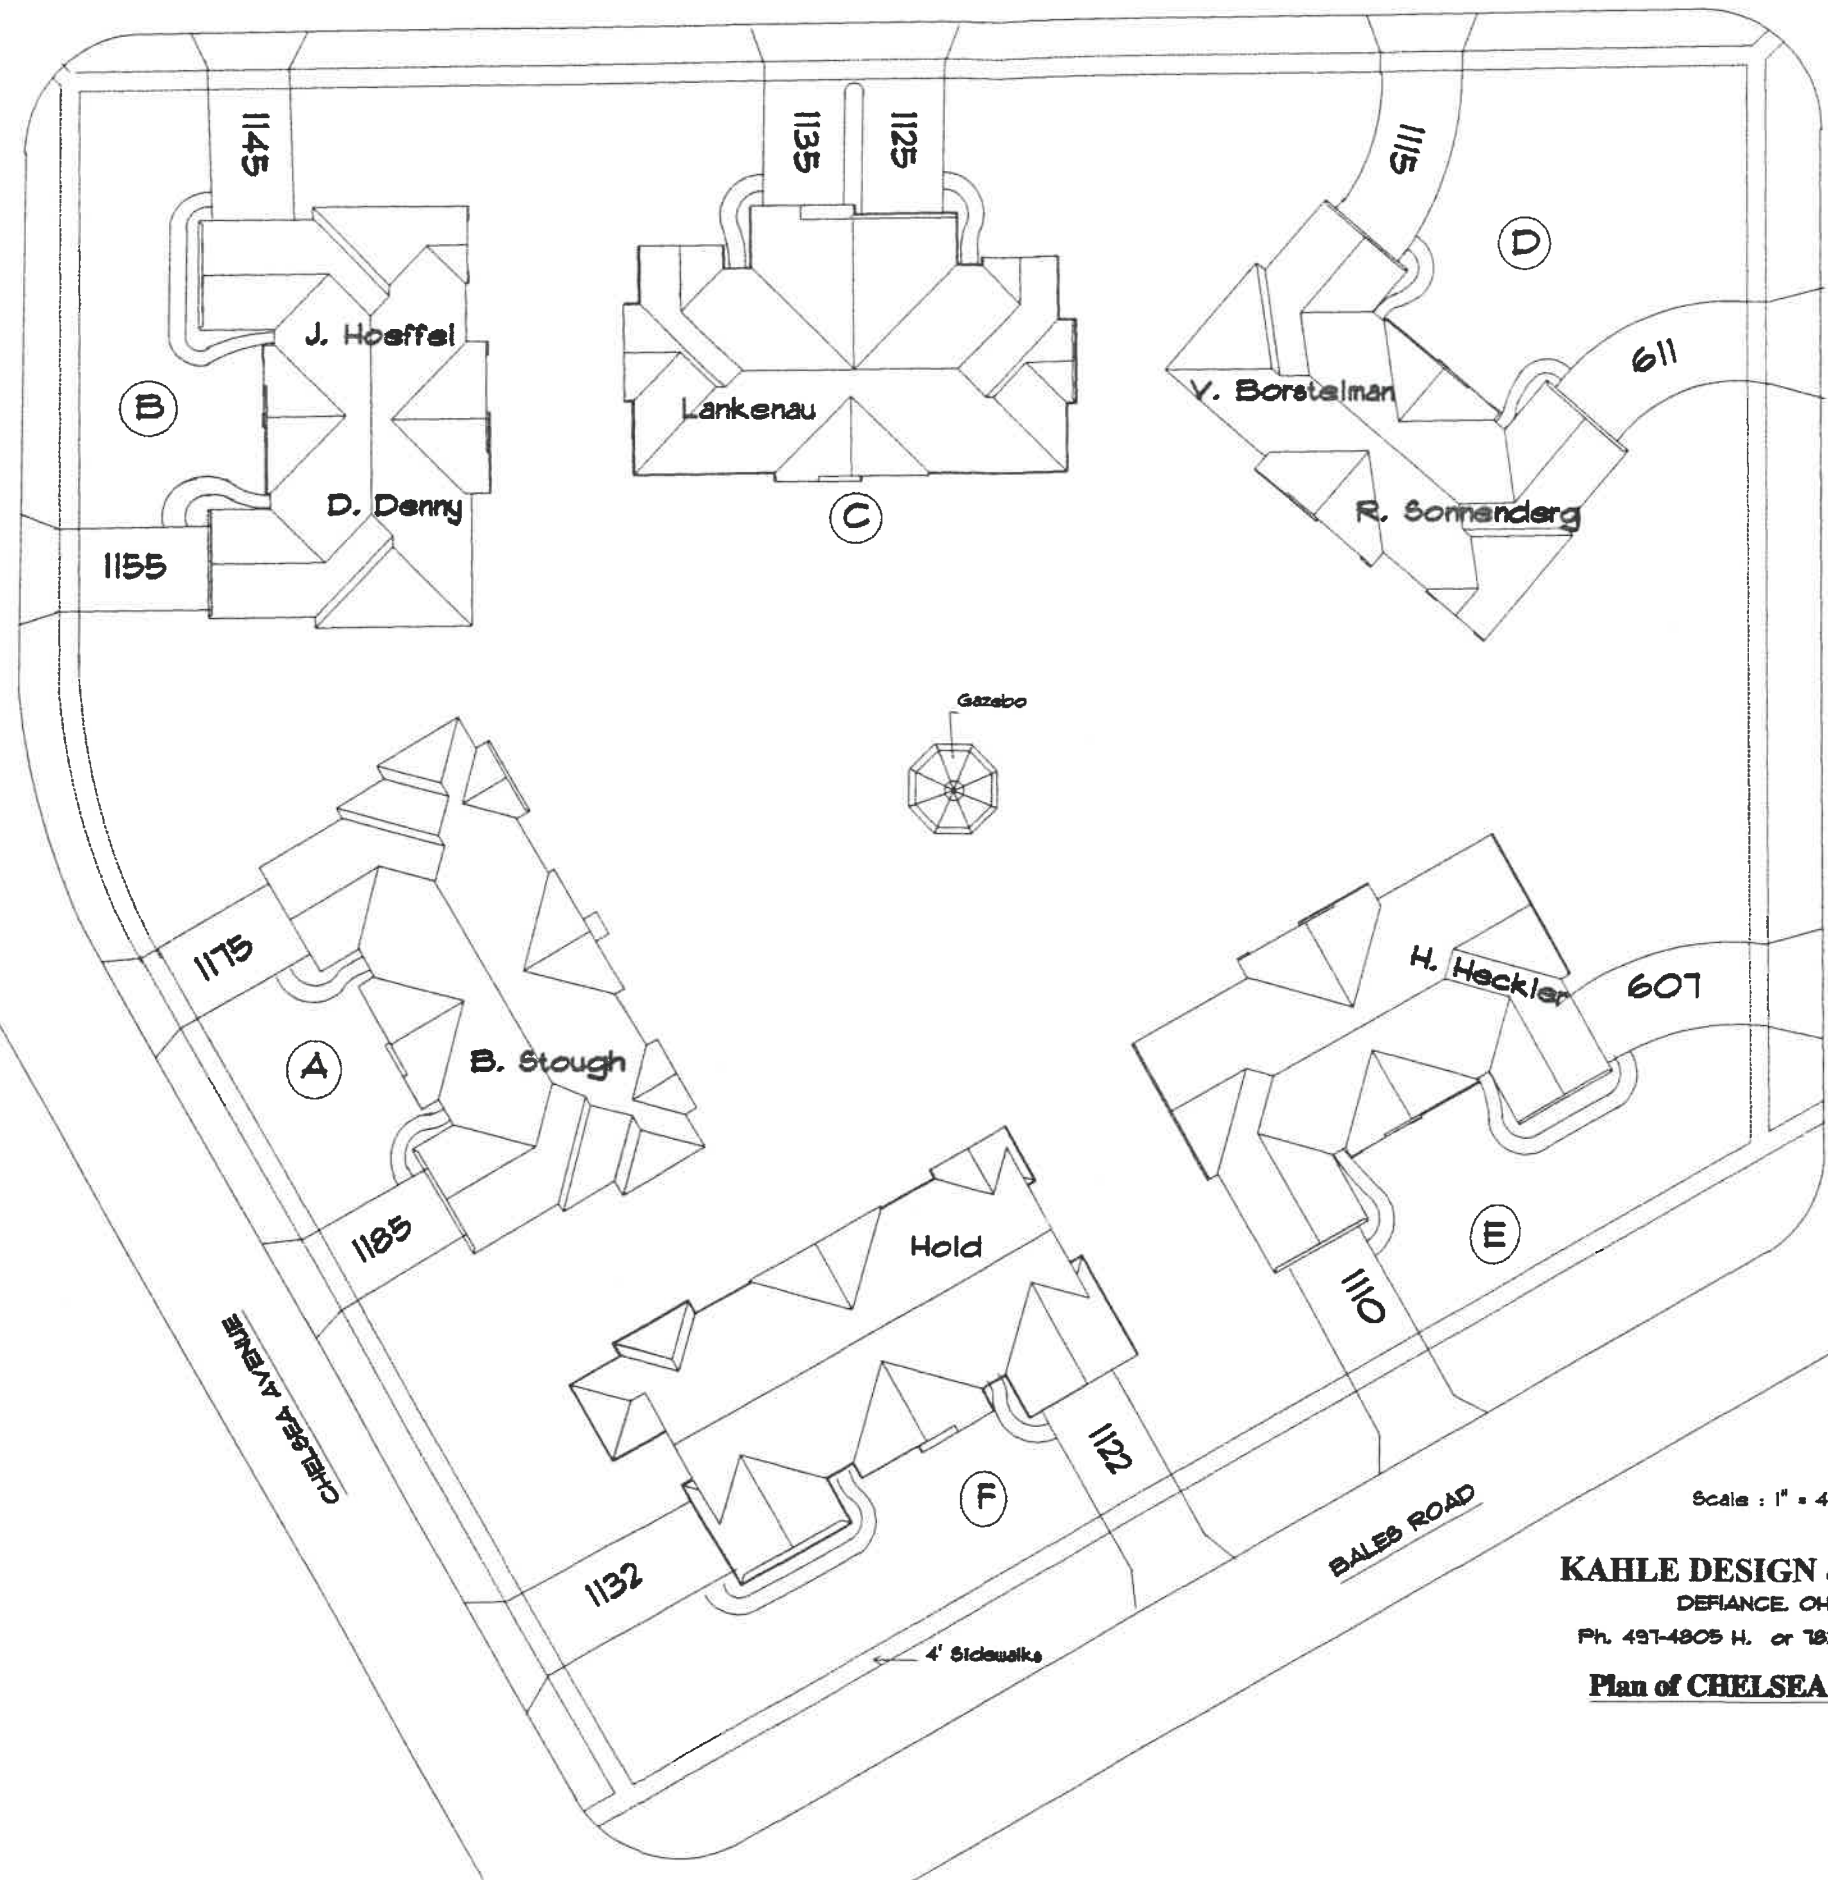

Scale : 1" = 40'

KAHLE DESIGN & BUILD
 DEFIANCE, OHIO
 Ph. 437-4805 H. or 782-TT56 Off.
Plan of CHELSEA CONDO'S

CHELSEA AVENUE

BALES ROAD

4' Sidewalk