




FRONT ELEVATION

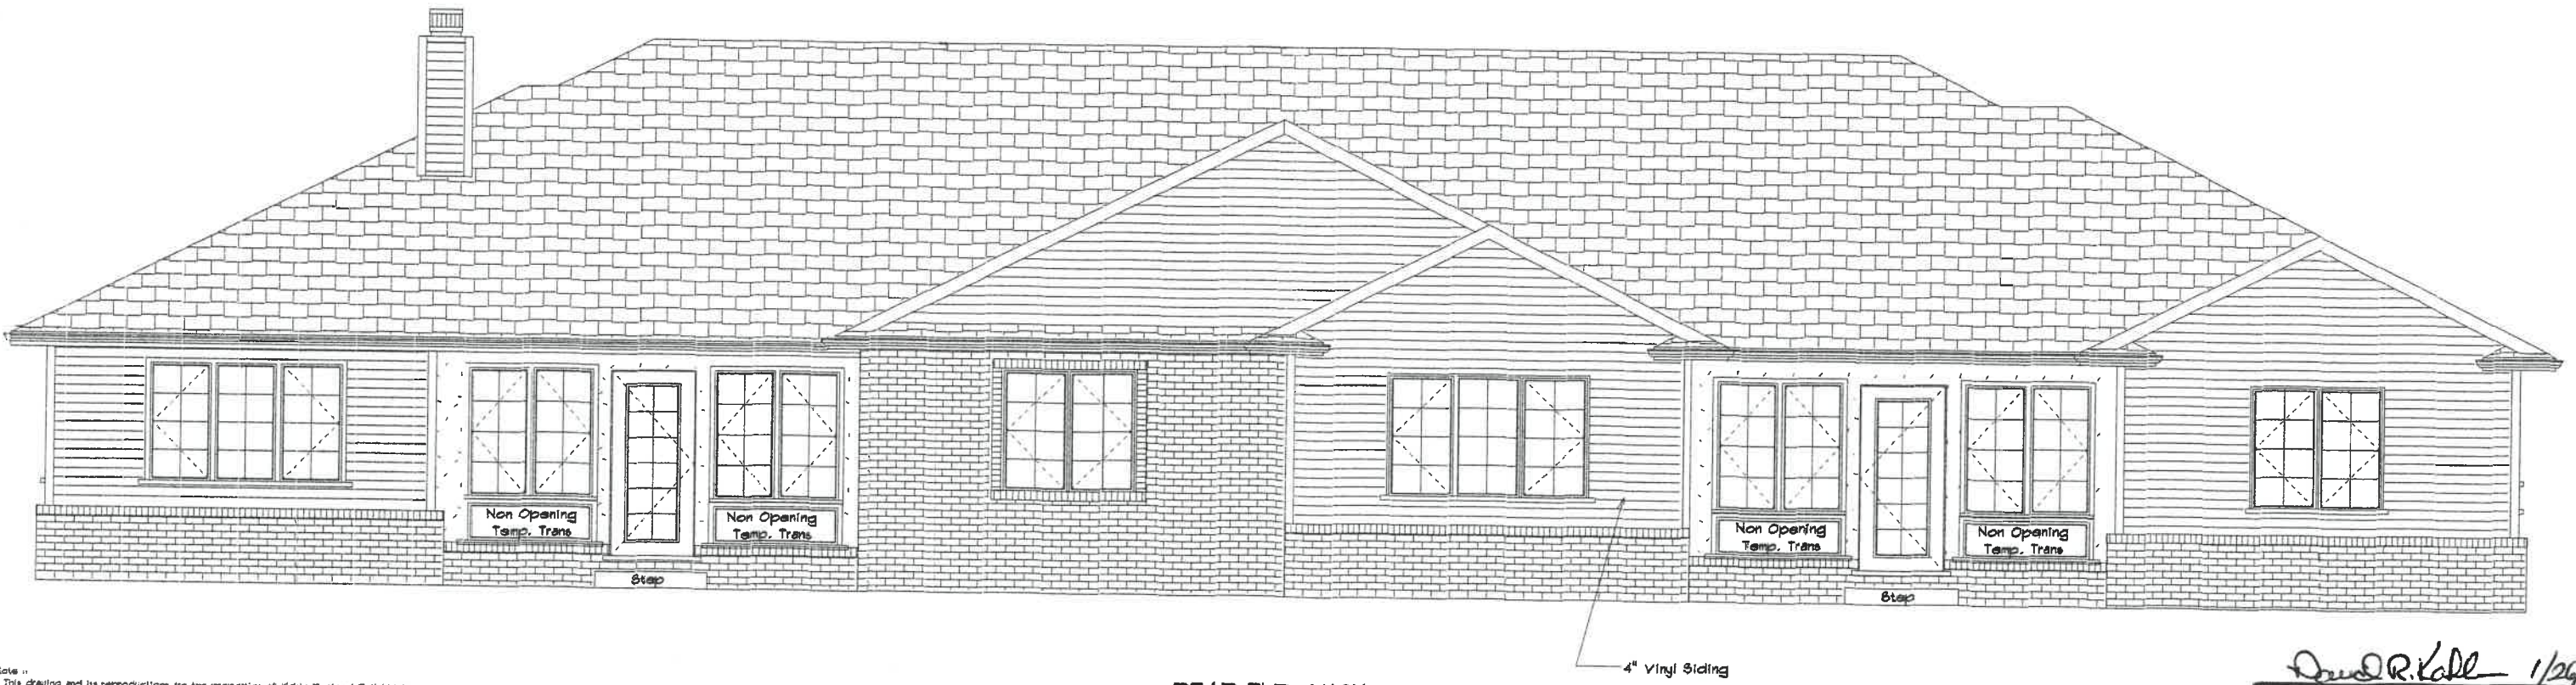

REAR ELEVATION

Note: This drawing and its reproductions are the properties of Kahle Design & Build Ltd. and may not be reproduced, published or used in any way without written permission from Kahle Design & Build Ltd. Building dimensions may vary from prints. In the interest of continuing product improvement Kahle Design & Build reserves the right to alter plans, specifications, materials, design, appliances, fixtures etc. without prior notice. All notes, plans and illustrations are artist or draftsman conceptions and are not necessarily to scale. Square footage are approximate. Plans are drawn by Dave Kahle.

1136 Chelsea


David R. Kall 1/26/06

Kahle Design & Build	
Defiance, Oh	Phone 487-4805
Scale: Var. 1/8"	Date: 1/2/06
Ms. Lois Arps	
Location: 1136 Chelsea Ave. Nap.	



Note:
 This drawing and its reproductions are the properties of Kahle Design & Build Ltd.
 And may not be reproduced, published or used in any way without written permission
 from Kahle Design & Build Ltd.. Building dimensions may vary from prints. In the interest
 of continuing product improvement, Kahle Design & Build reserves the right to alter plans,
 specifications, materials, design, appliance features etc. without prior notice. All elev, plans
 and illustrations are artists or drafters conceptions and are not necessarily to scale.
 Square footages are approximate. Plans are drawn by Dave Kahle.

<i>Kahle Design & Build</i>	
Defiance, Oh	Phone 487-4805
Scale: Var. 1/8"	Date 1/12/06
Ms. Lois Arps	
Location: 1136 Chelsea Ave. Nap.	

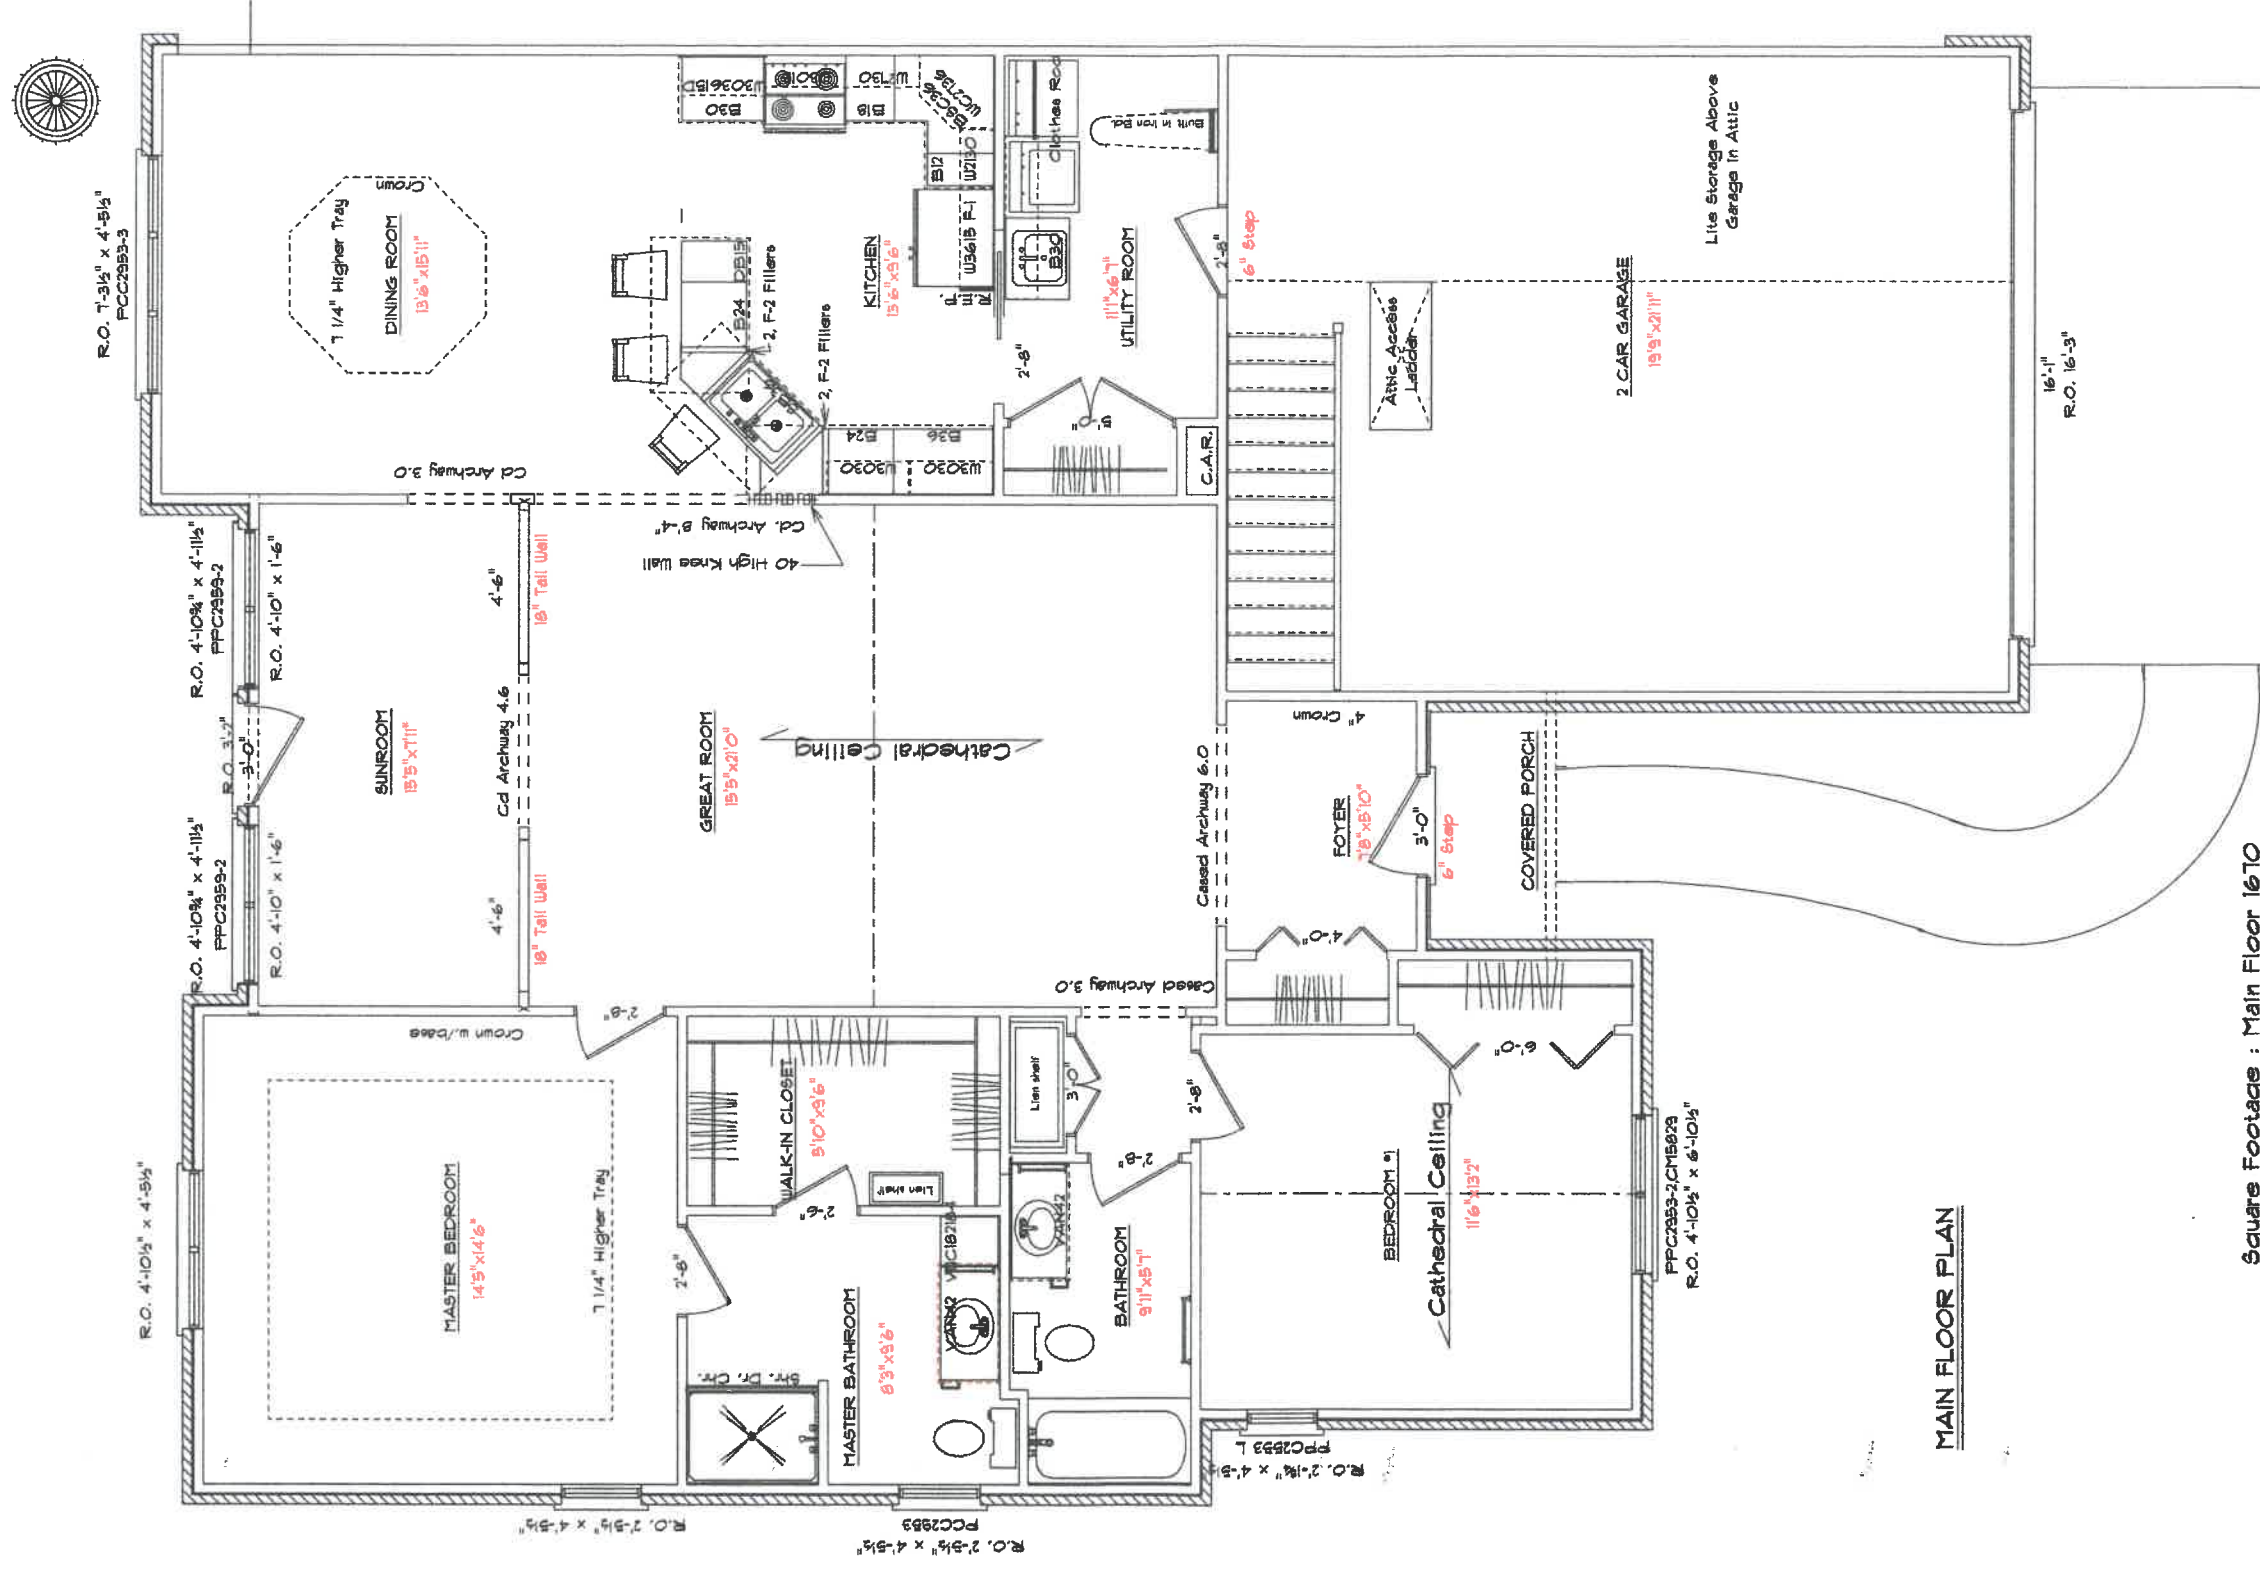


MAIN FLOOR PLAN

**Square Footage : Main Floor 1670
Garage 438
Front Porch 28**

Kahle Design & Build	
Defiance, Oh	Phone 457-4805
Scale: Var.'10"	Date 1-12-06
Ms. Lois Arps	
Location : 1136 Chelsea Ave..	

Note :
This drawing and its reproductions are the property of Kahle Design & Build, Ltd.
And may not be reproduced, published or used in any way without written permission
from Kahle Design & Build, Ltd.. Building dimensions may vary from prints. In the interest
of continuing products improvement, Kahle Design & Build reserves the right to alter plans,
and illustrations are artist or engineer conceptions and are not necessarily to scale.
Square footages are approximate. Plans are drawn by Dave Kahle.

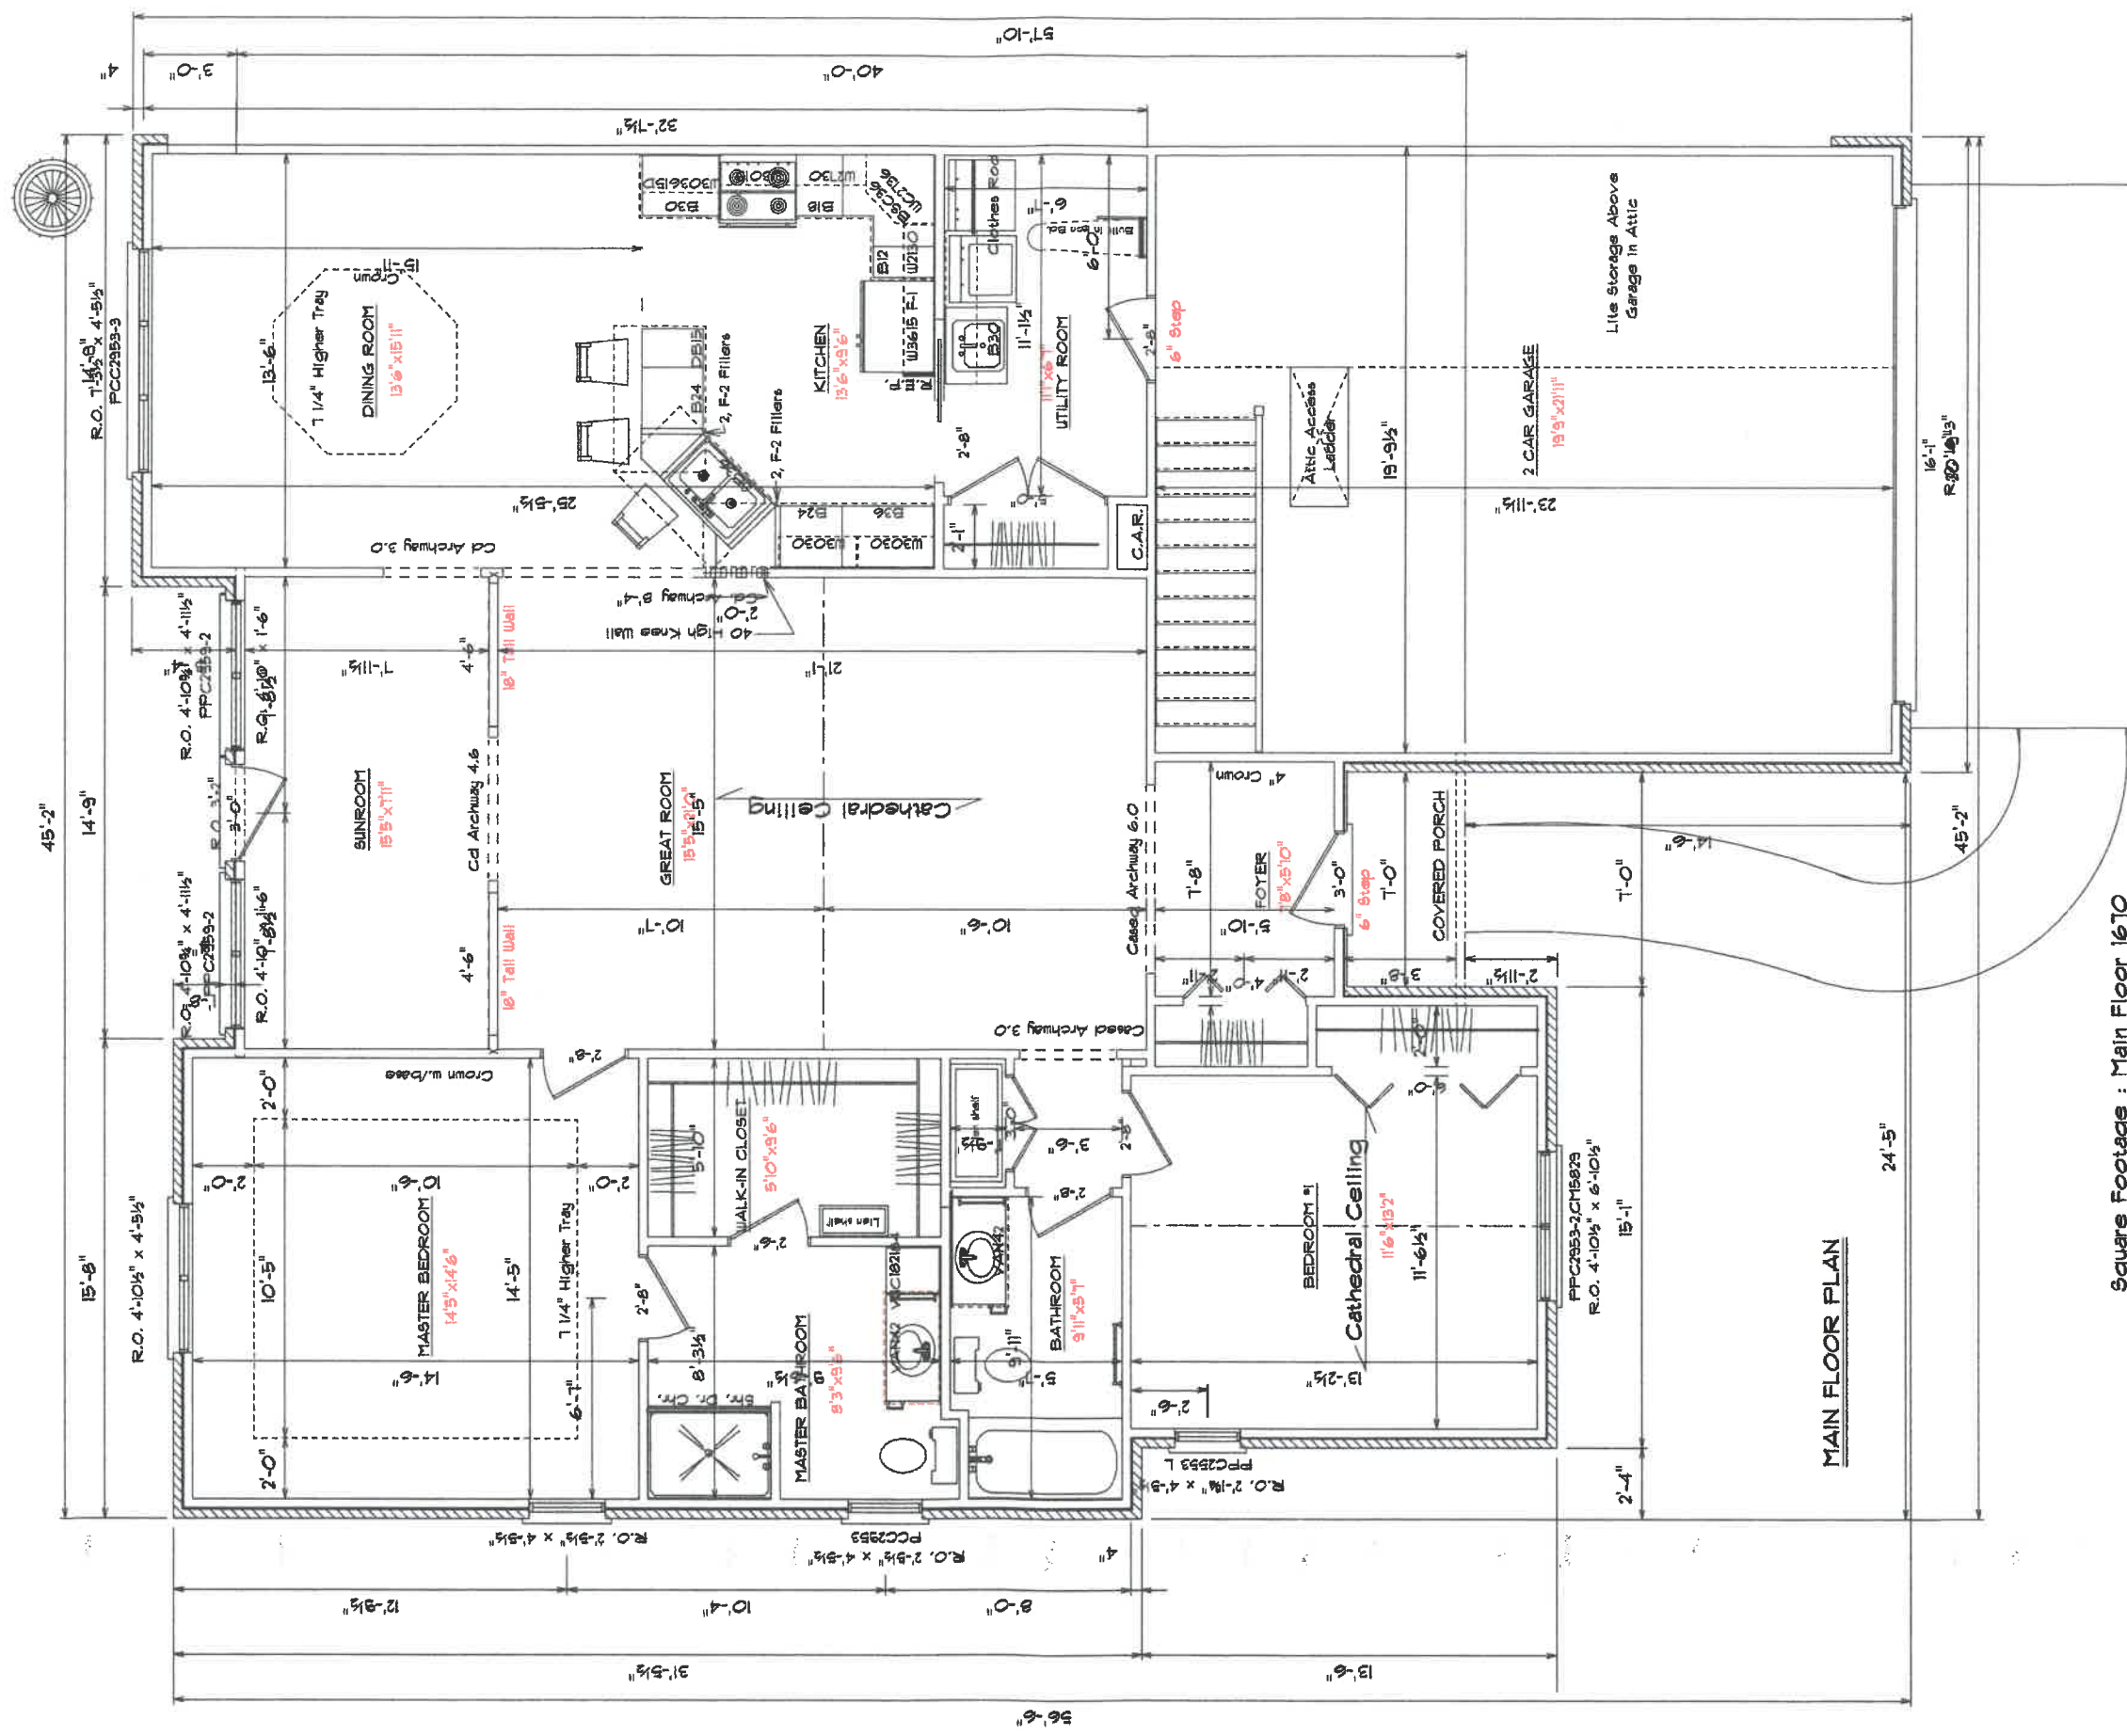


MAIN FLOOR PLAN

**Square Footage : Main Floor 1670
Garage 438
Front Porch 28**

Kahle Design & Build	
Defiance, Oh	Phone 457-4805
Scale: Var=1"=10'	Date 1-12-06
Ms. Lois Arpe	
Location : 1156 Chelsea Ave.,	


Note : Drawings and its reproductions are the properties of Kahle Design & Build Ltd. and shall not be reproduced, published or used in any way without written permission from Kahle Design & Build Ltd.. Building dimensions may vary from prints. In the interest of continuing product improvement Kahle Design & Build reserves the right to alter plans, specifications, materials, design, appliance features etc. without prior notice. All notes, plans and illustrations are artist or draftsman conceptions and are not necessarily to scale. Square footages are approximate. Plans are drawn by Dave Kahle.

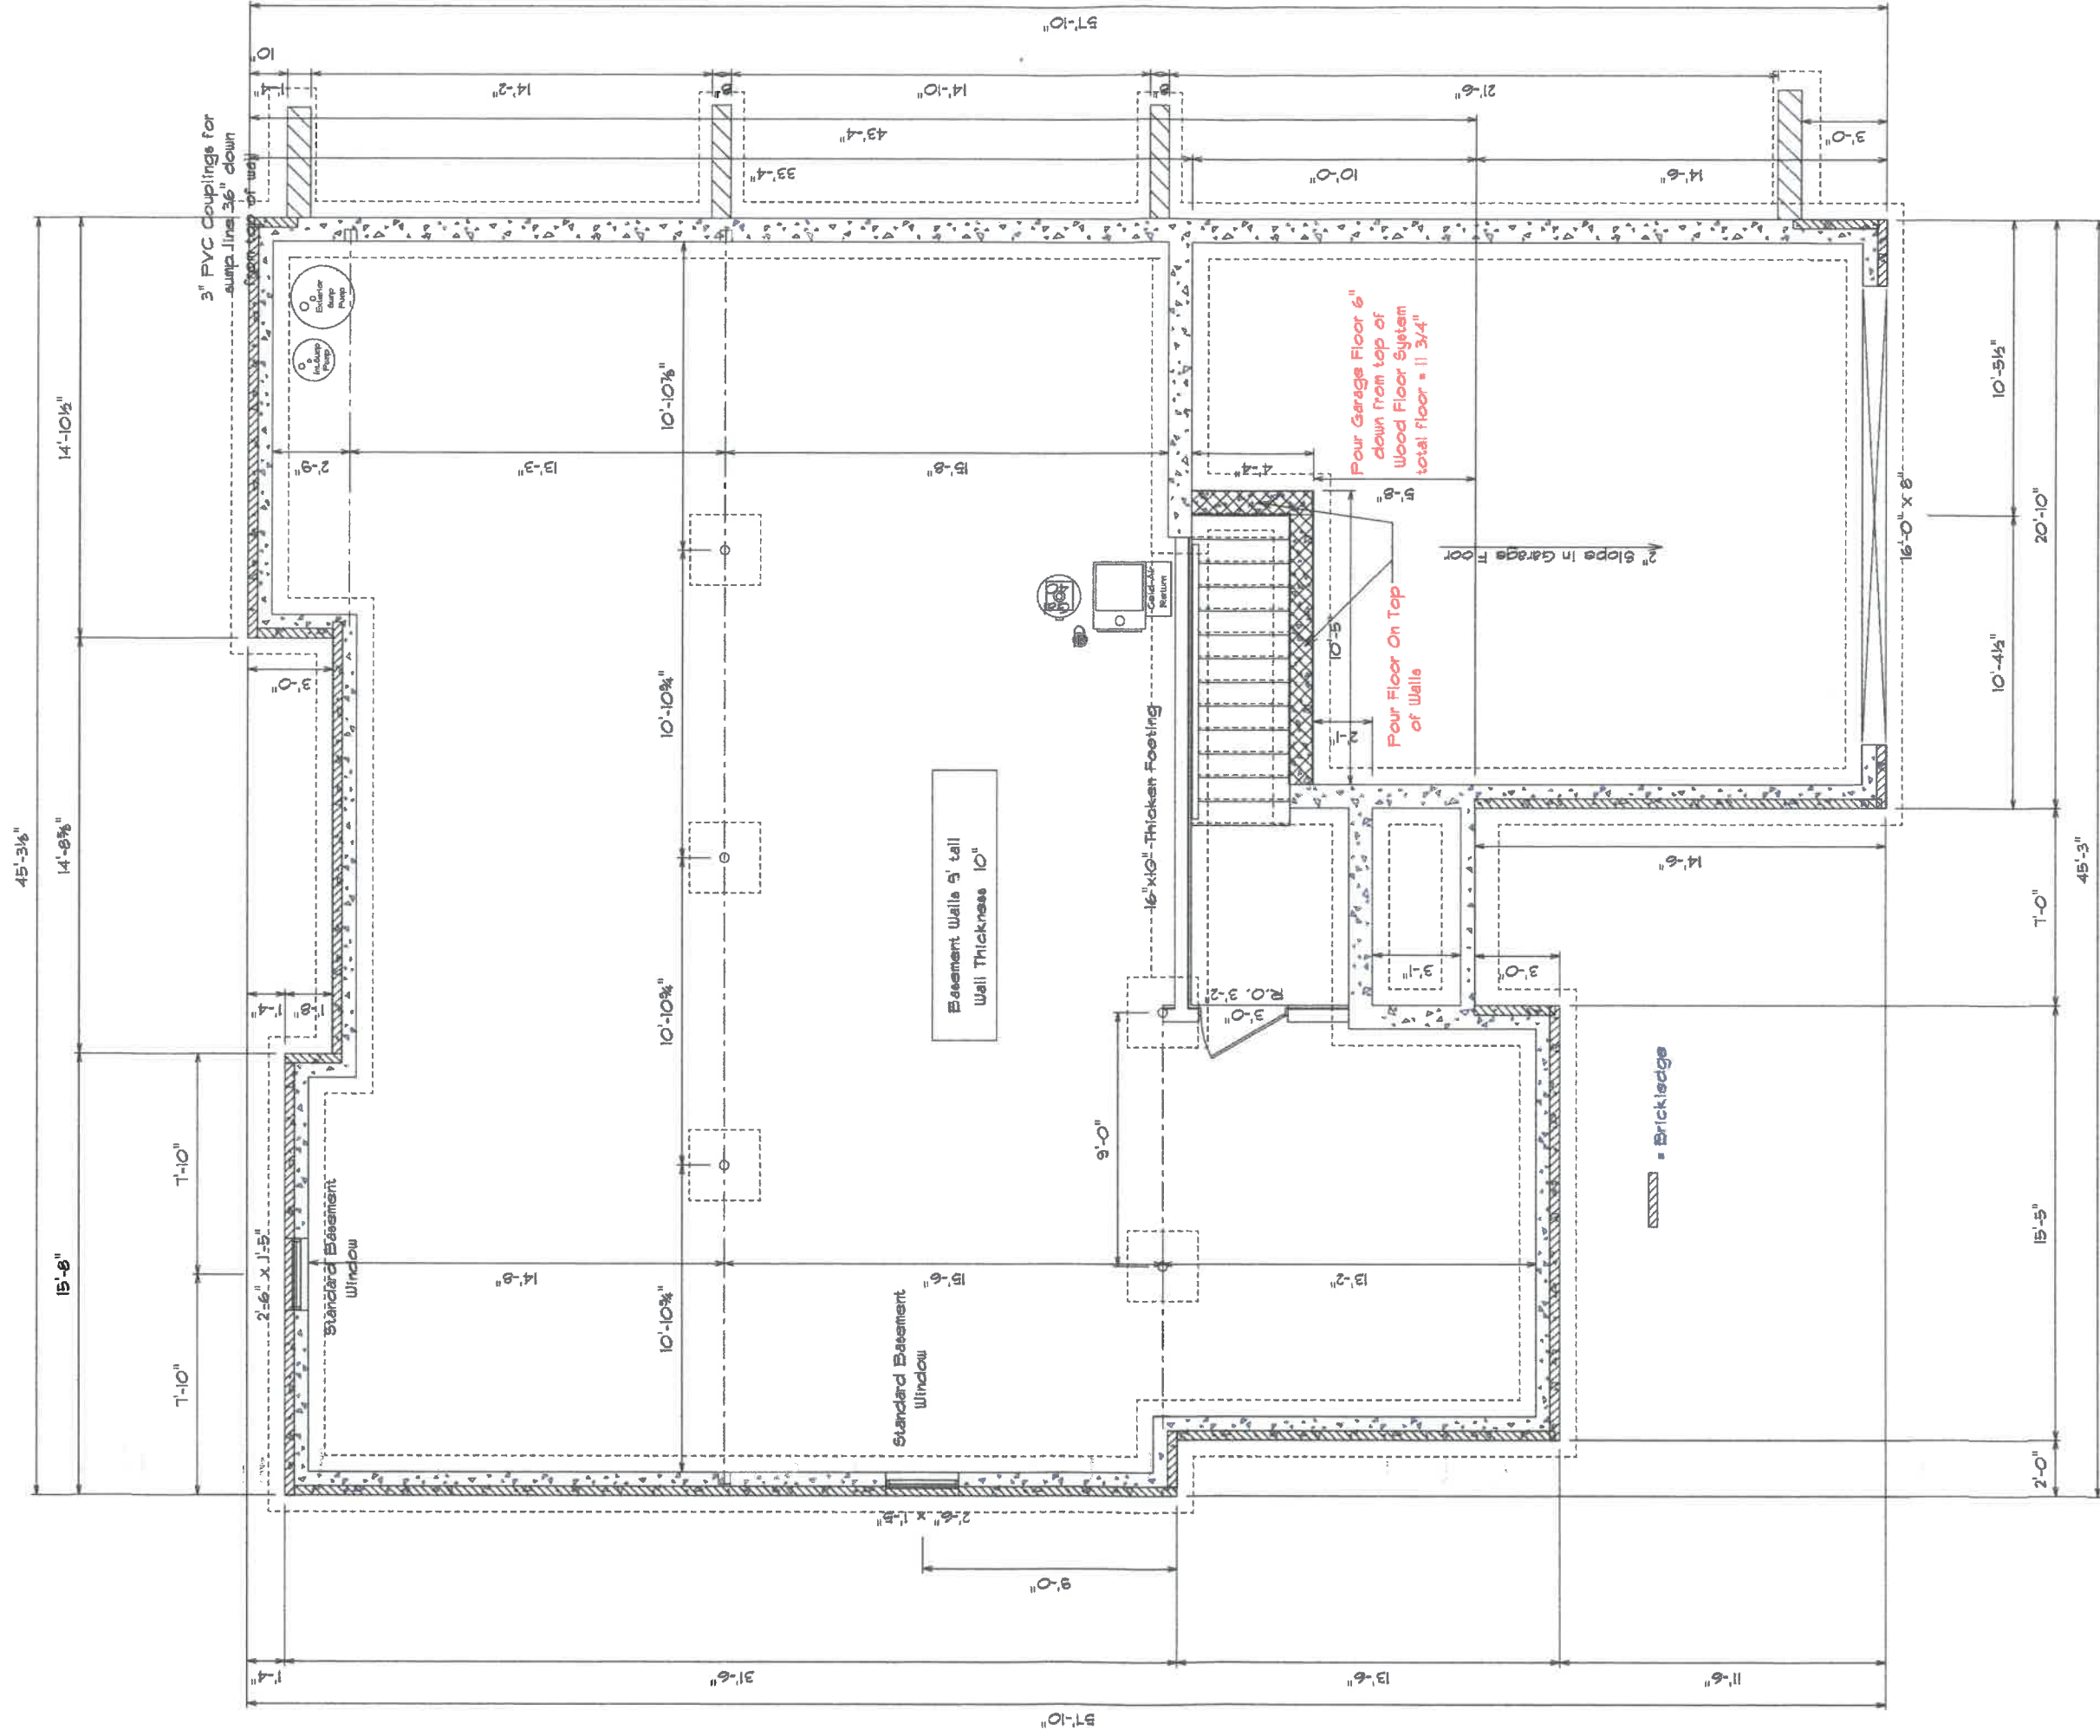

FOUNDATION PLAN

Note: This drawing and its reproductions are the property of Kahle Design & Build Ltd. They may not be reproduced, published or used in any way without written permission from Kahle Design & Build Ltd. Building dimensions may vary from prints. In the interest of continuing product improvement Kahle Design & Build reserves the right to alter plans, specifications, material, design, appliance features etc. without prior notice. All tags, plans and drawings are also subject to change without notice. Requires footings as appropriate. Plans are drawn by Dave Kahle.

Kahle Design & Build	
Defiance, Oh	Phone 497-4805
Scale: Var. 1/8" = 1'-0"	Date: 1-12-06
Me. Lois Alps	
Location: 1136 Chelsea Ays.,	

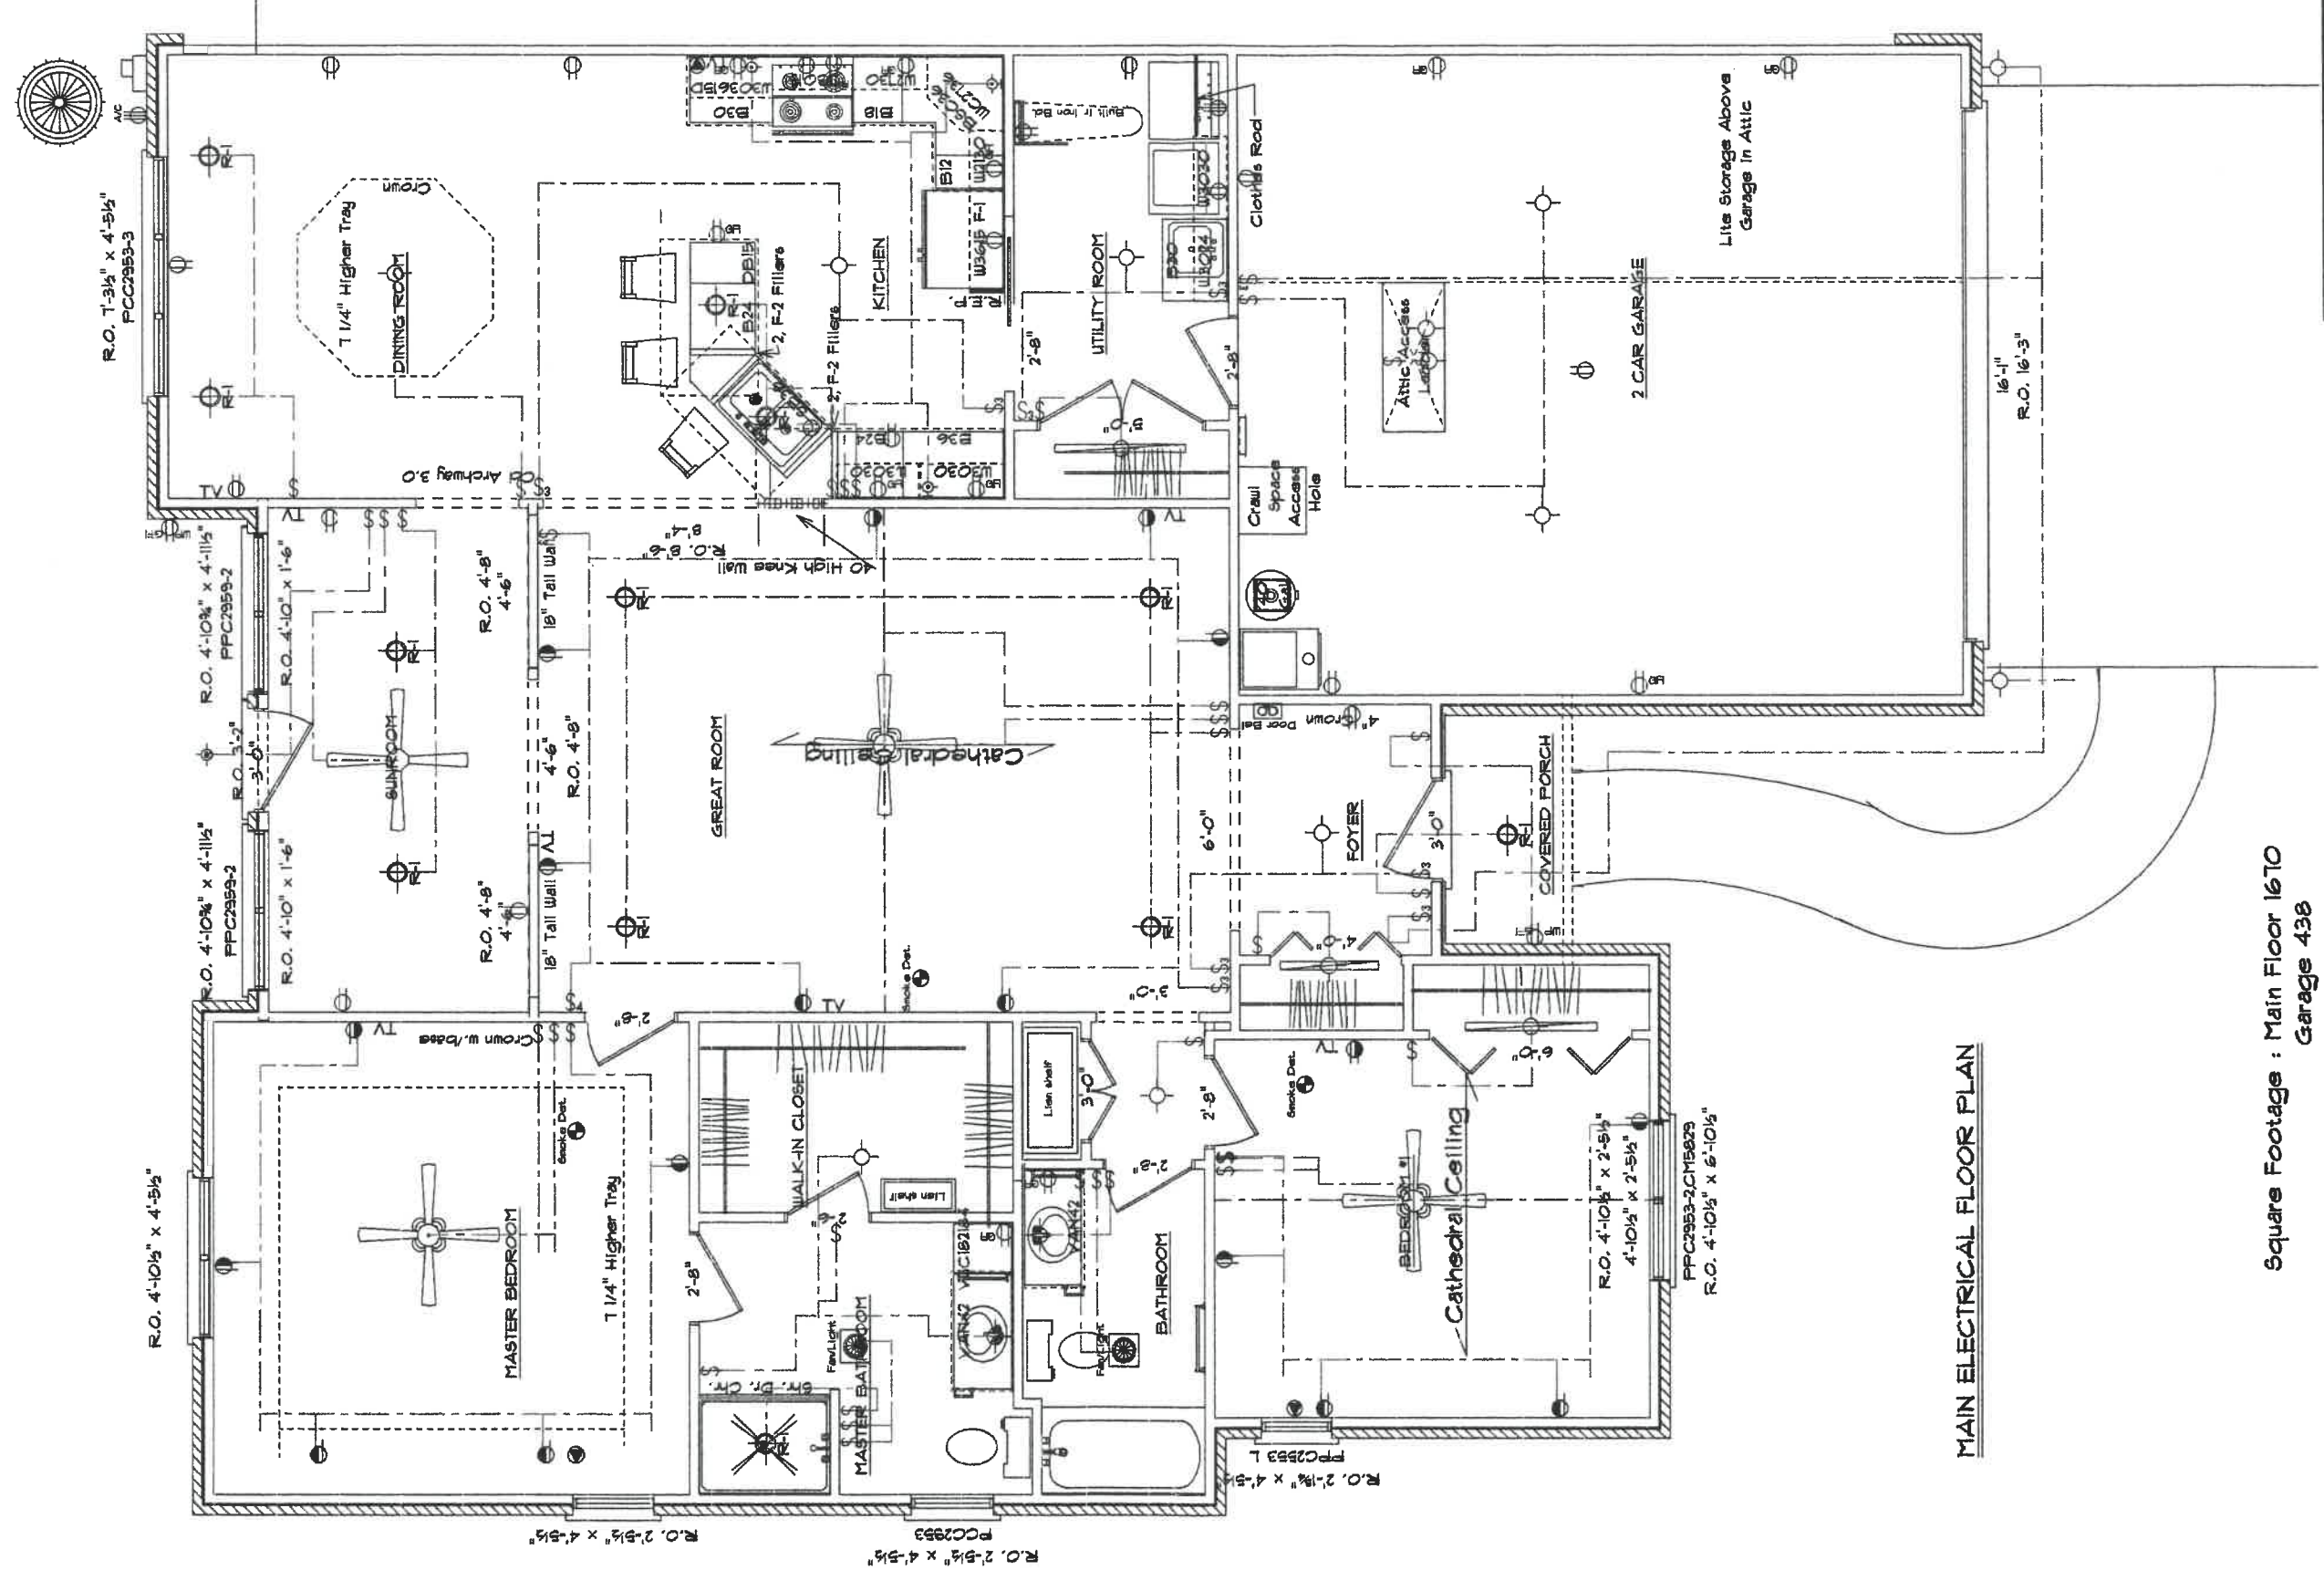


MAIN ELECTRICAL FLOOR PLAN

Square Footage : Main Floor 1610
 Garage 438
 Front Porch 28

Kahle Design & Build	
Defiance, Oh	Phone 497-4805
Scale: Var-1"=10'	Date 1-12-06
Ms. Lois Arpa	
Location : 1136 Chelsea Ave..	

Note 1:
 This drawing and its reproductions are the property of Kahle Design & Build, Ltd. and may not be reproduced, stored in a retrieval system, or transmitted in any form or by any means, electronic, mechanical, photocopying, recording, or by any information storage and retrieval system, without the prior written permission of Kahle Design & Build. Kahle Design & Build reserves the right to alter plans, specifications, materials, design, appliance features etc. without prior notice. All maps, plans and illustrations are artist or architect conceptions and are not necessarily to scale. Square footages are approximate. Plans are drawn by Dave Kahle.

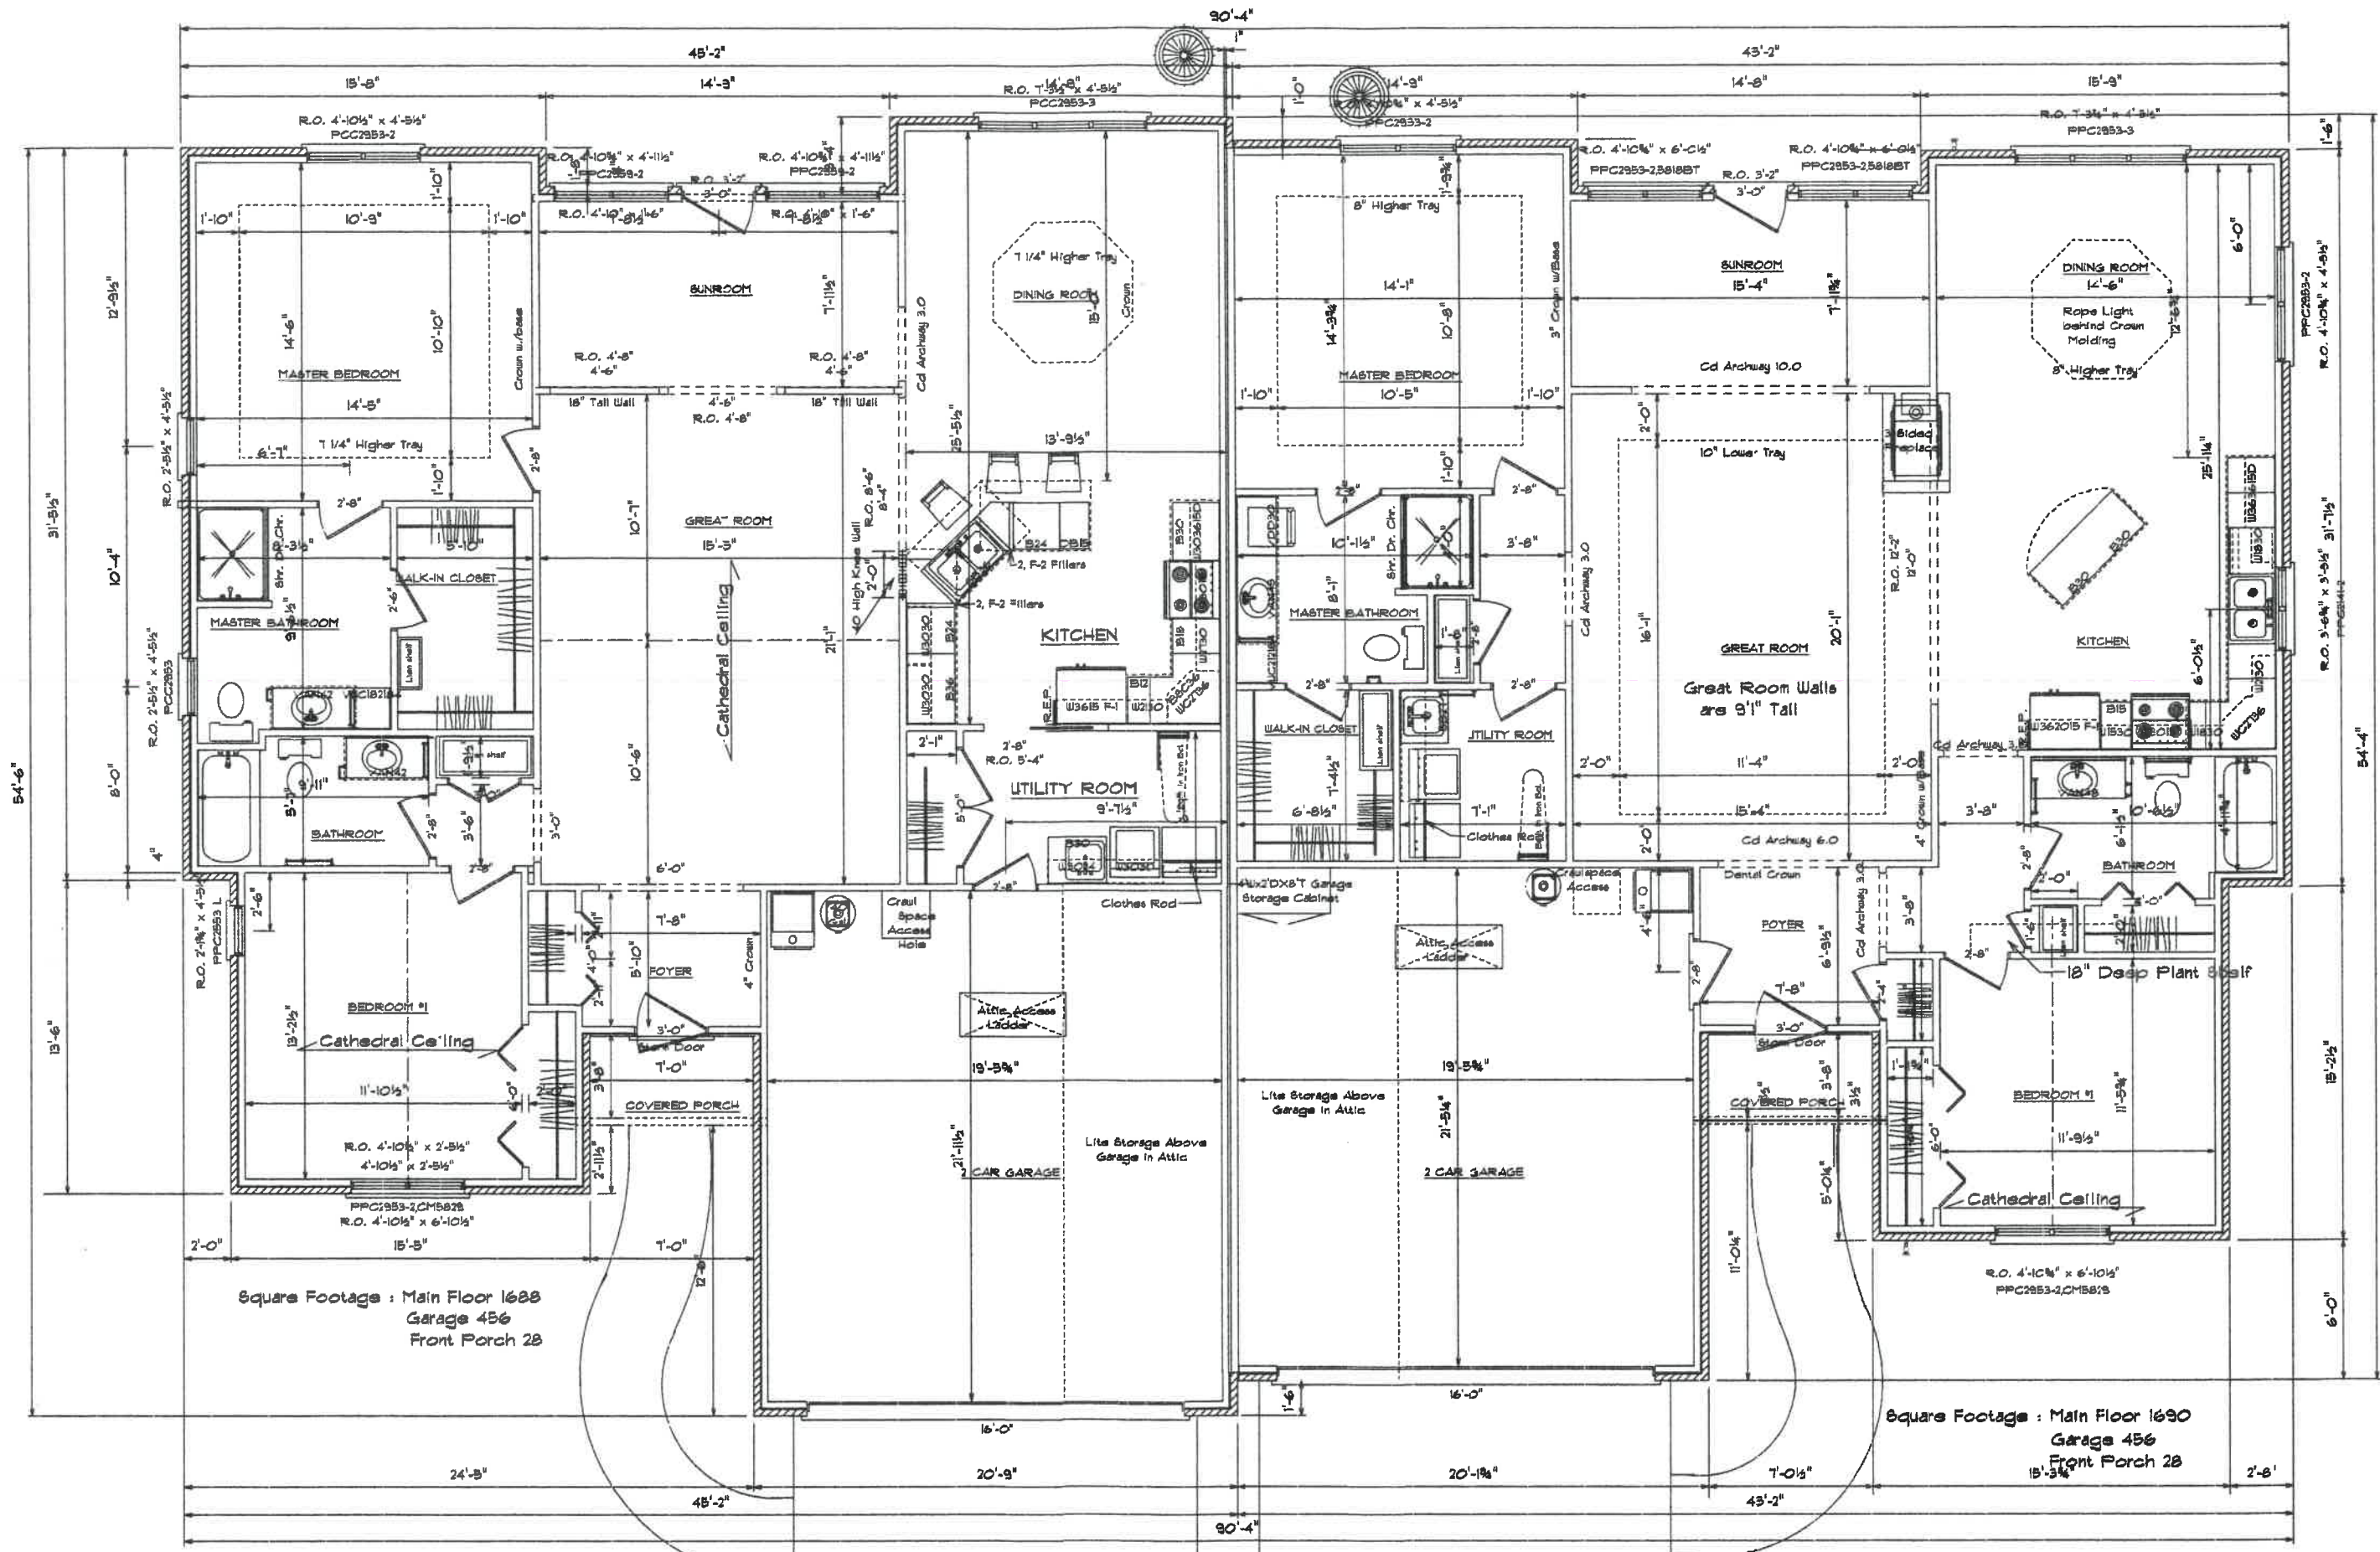


Square Footage : Main Floor 1688
Garage 456
Front Porch 28

Square Footage : Main Floor 1690
Garage 456
Front Porch 28

MAIN FLOOR PLAN

Note:
This drawing and its reproductions are the properties of Kahle Design & Build Ltd. and may not be reproduced, published or used in any way without written permission from Kahle Design & Build Ltd. Building dimensions may vary from prints in the interest of completing product improvement. Kahle Design & Build reserves the right to alter plans, specifications, materials, designs, appliances features etc. without prior notice. All signs, prices and illustrations are prices or estimated approximations and are not necessarily to scale. Square footages are approximate. Plans are drawn by Dave Kahle.

Kahle Design & Build	
Defiance, Oh	Phone 437-4808
Scale: Var. 1/8" = 1'-0"	Date 1-12-06
Ms. Lois Arpa	
Location 1136 Chelsea Ave., Napoleon	

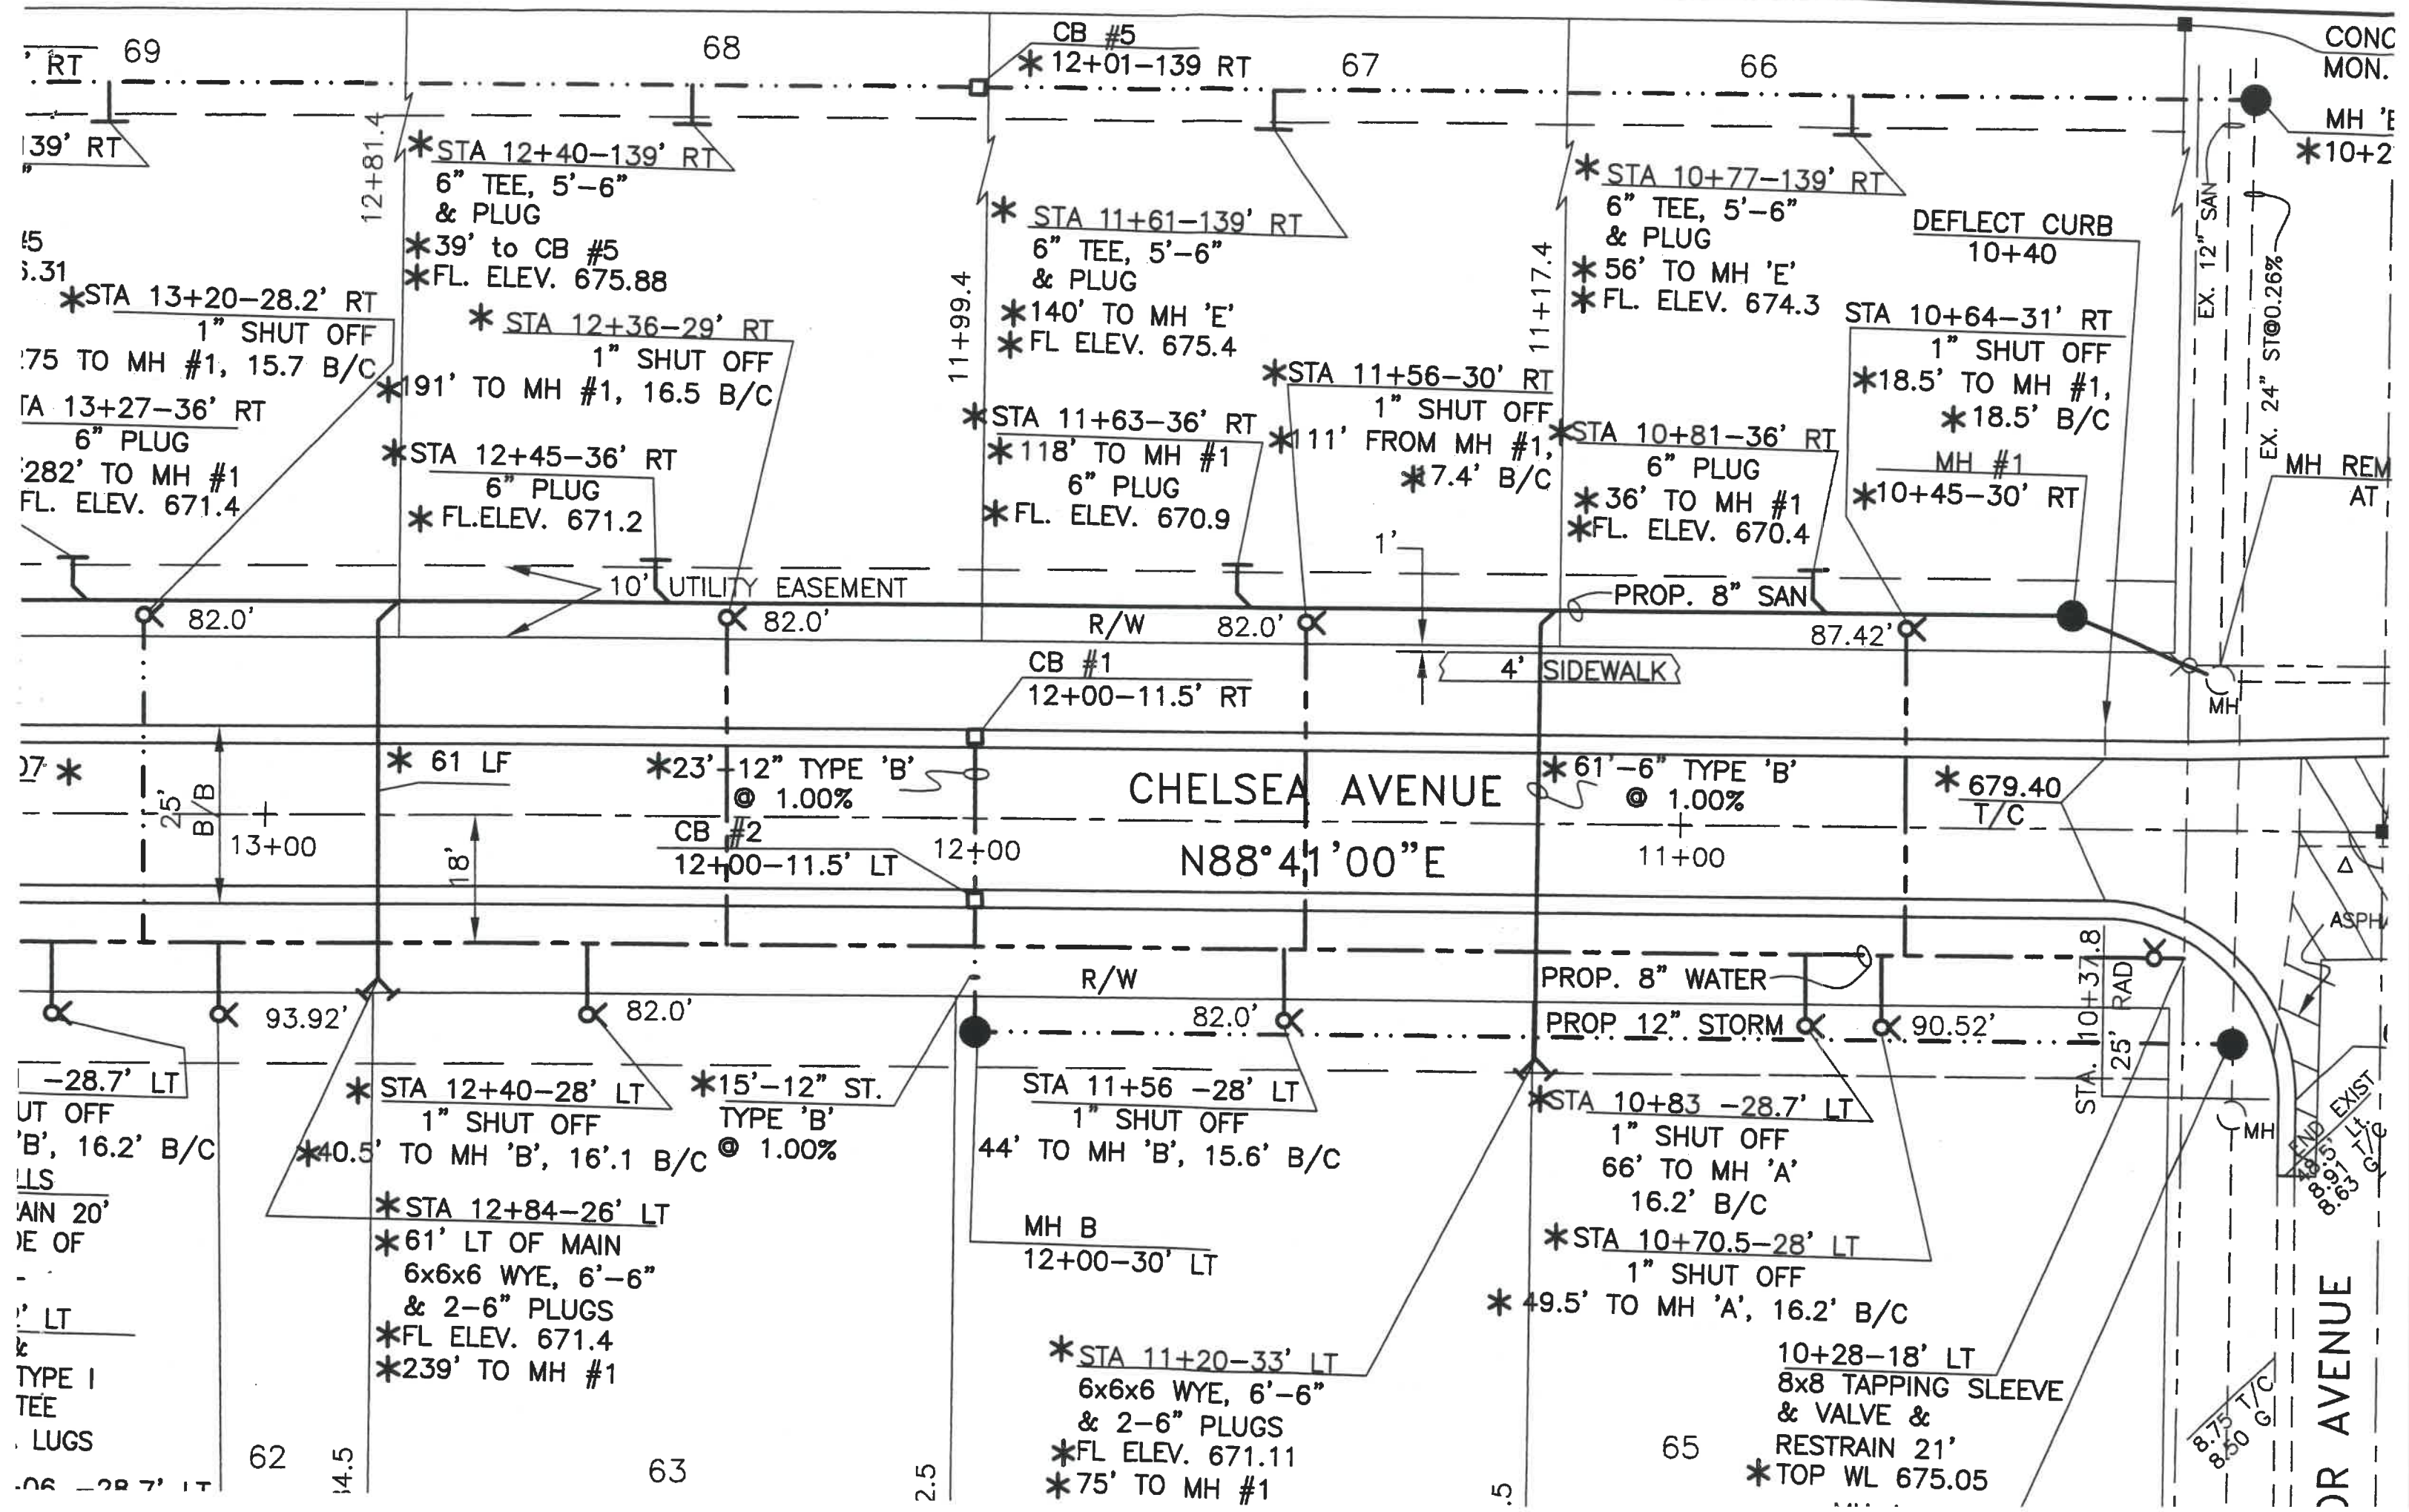

CHELSEA AVENUE

N88°41'00"E

RT 69
 39' RT
 12+81.4
 *STA 12+40-139' RT
 6" TEE, 5'-6"
 & PLUG
 *39' to CB #5
 *FL. ELEV. 675.88
 *STA 12+36-29' RT
 1" SHUT OFF
 *191' TO MH #1, 16.5 B/C
 *STA 12+45-36' RT
 6" PLUG
 *FL. ELEV. 671.2
 10' UTILITY EASEMENT
 82.0'
 82.0'
 R/W 82.0'
 CB #1
 12+00-11.5' RT
 4' SIDEWALK
 87.42'
 66
 *STA 10+77-139' RT
 6" TEE, 5'-6"
 & PLUG
 *56' TO MH 'E'
 *FL. ELEV. 674.3
 DEFLECT CURB
 10+40
 STA 10+64-31' RT
 1" SHUT OFF
 *18.5' TO MH #1,
 *18.5' B/C
 MH #1
 *10+45-30' RT
 *STA 10+81-36' RT
 6" PLUG
 *36' TO MH #1
 *FL. ELEV. 670.4
 PROP. 8" SAN
 11+17.4
 *STA 11+61-139' RT
 6" TEE, 5'-6"
 & PLUG
 *140' TO MH 'E'
 *FL. ELEV. 675.4
 *STA 11+56-30' RT
 1" SHUT OFF
 *11' FROM MH #1,
 *7.4' B/C
 *STA 11+63-36' RT
 6" PLUG
 *FL. ELEV. 670.9
 11+99.4
 1'
 11+17.4
 *STA 10+81-36' RT
 6" PLUG
 *36' TO MH #1
 *FL. ELEV. 670.4
 PROP. 8" SAN
 87.42'
 67
 *12+01-139 RT
 67
 66
 65
 1

OR AVENUE

STA. 10+37.8
 25' RAD
 8.75 T/C
 8.50 G/C


8.95' Lt
 8.63' T/C
 8.50' G/C

ASPH

MH REM AT

MH 'E

CONC MON.

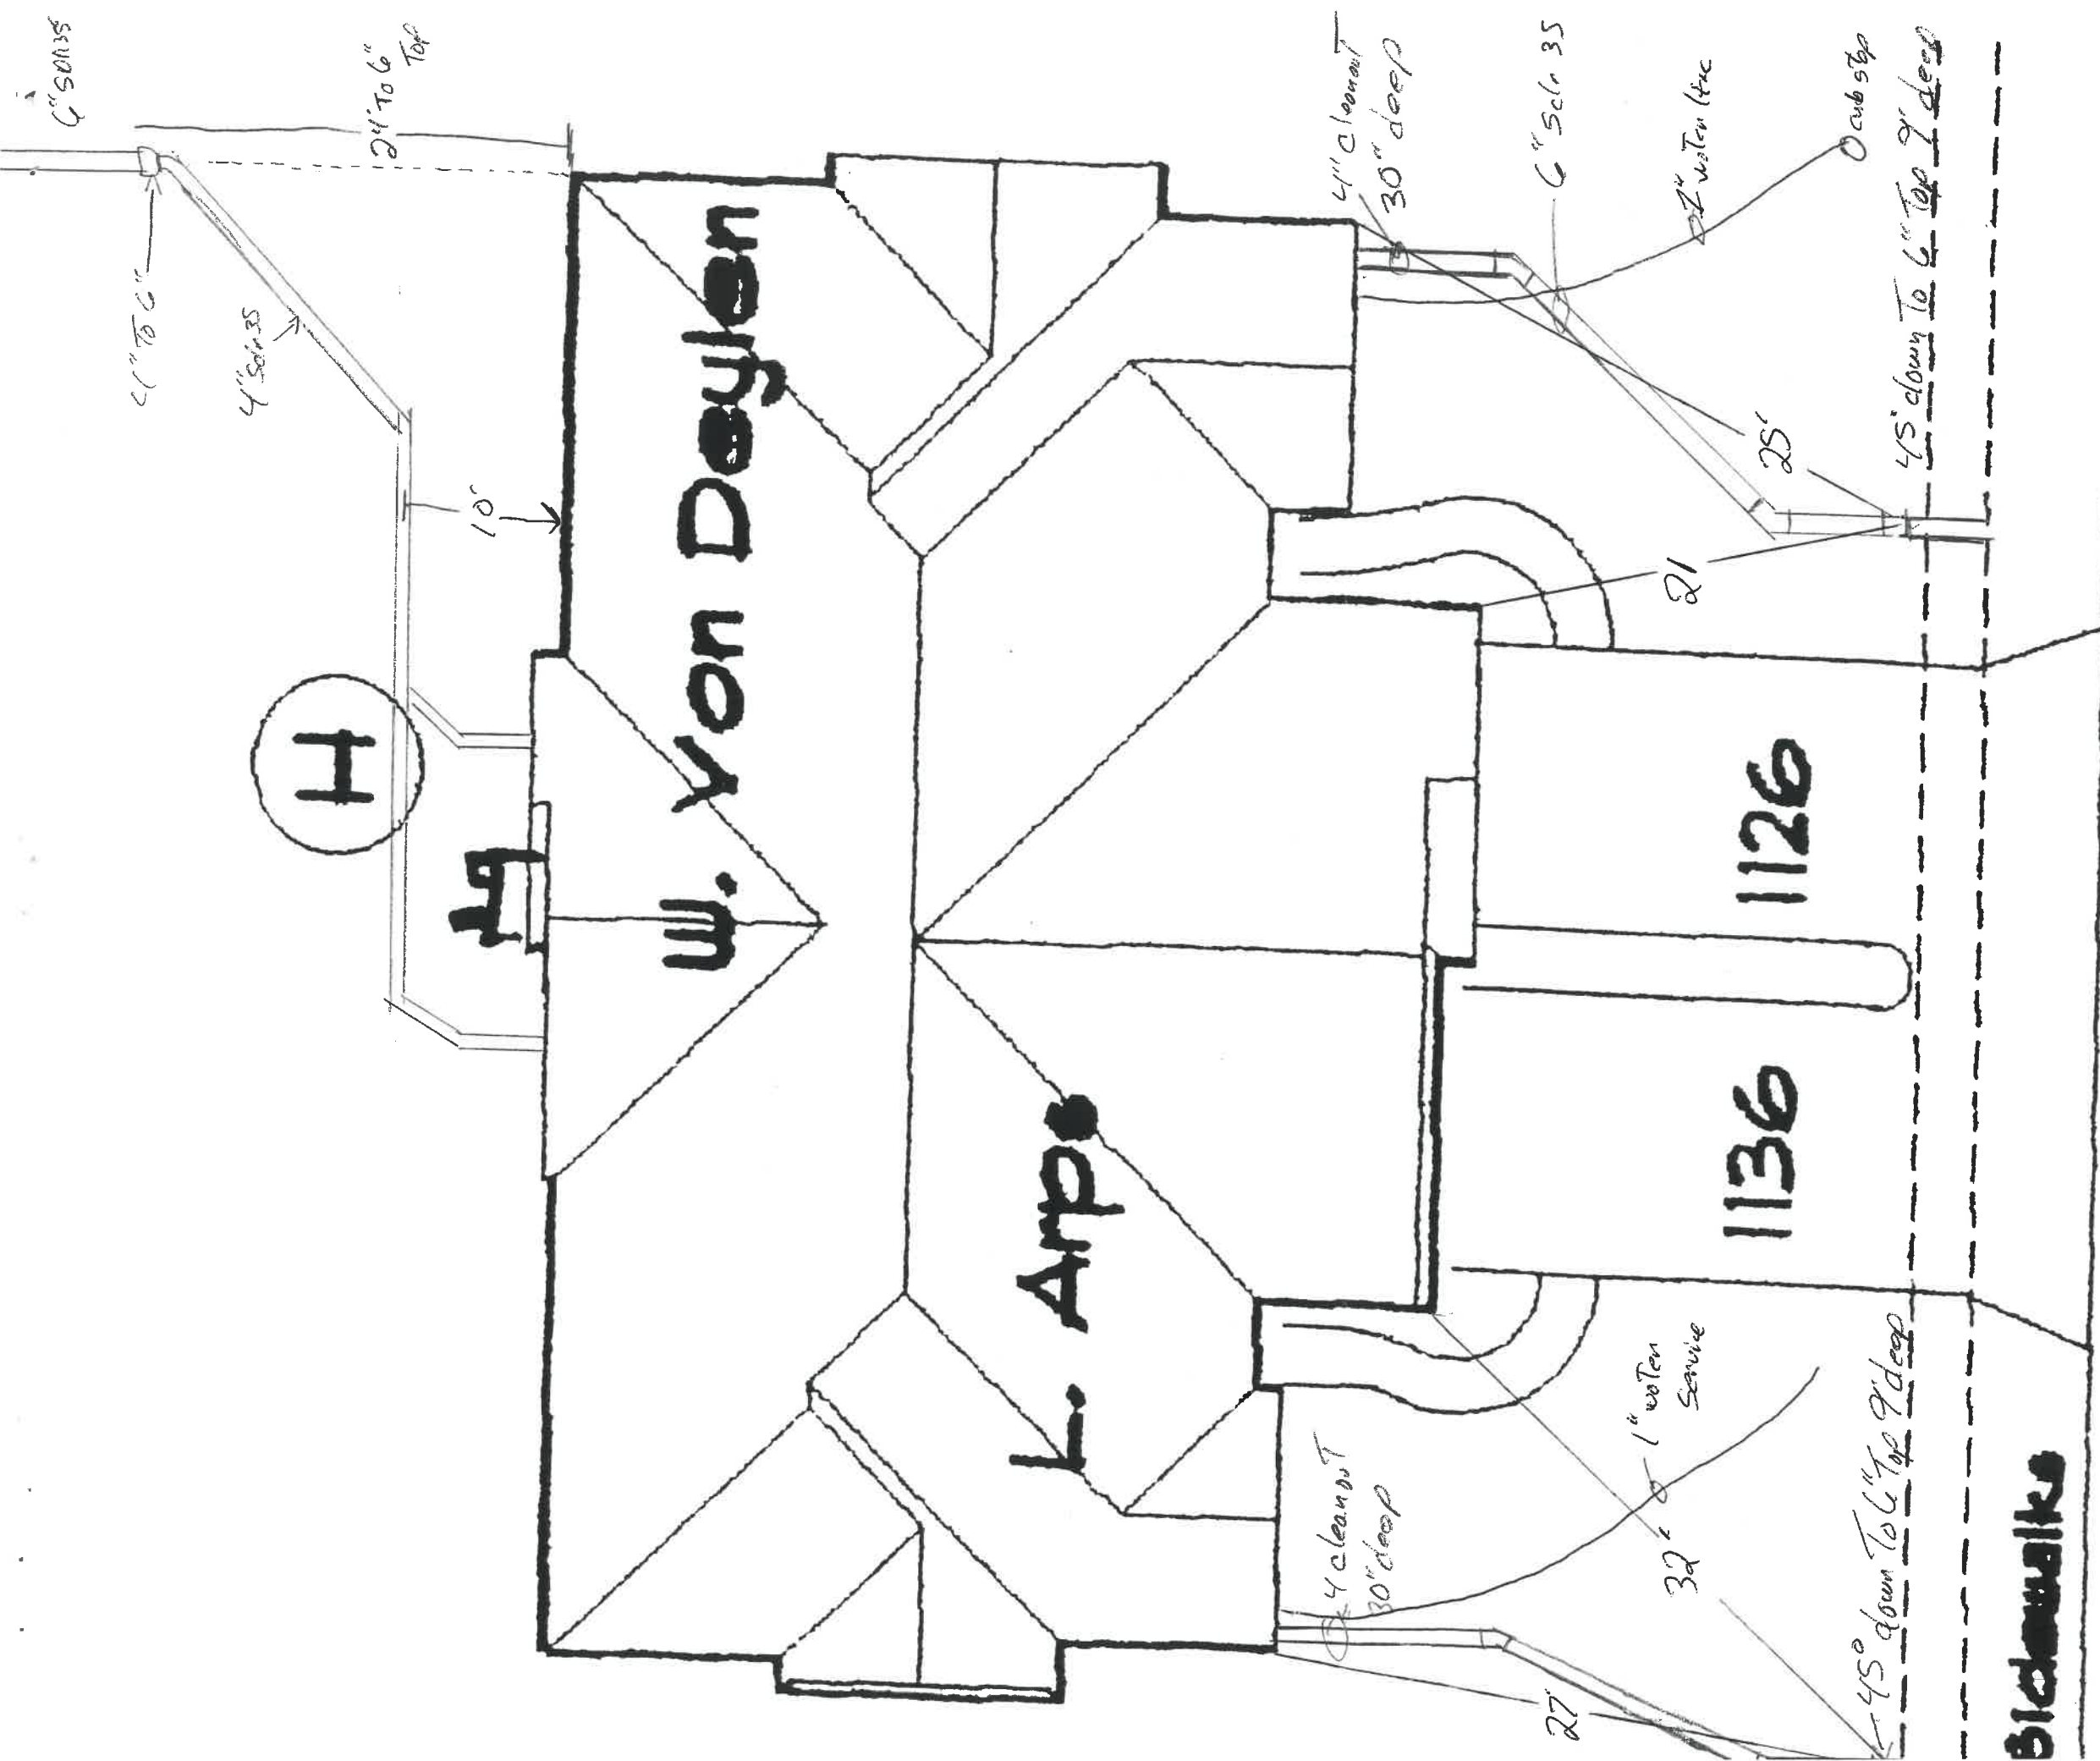

CHELSEA AVENUE

Bicknalka

