




FRONT ELEVATION

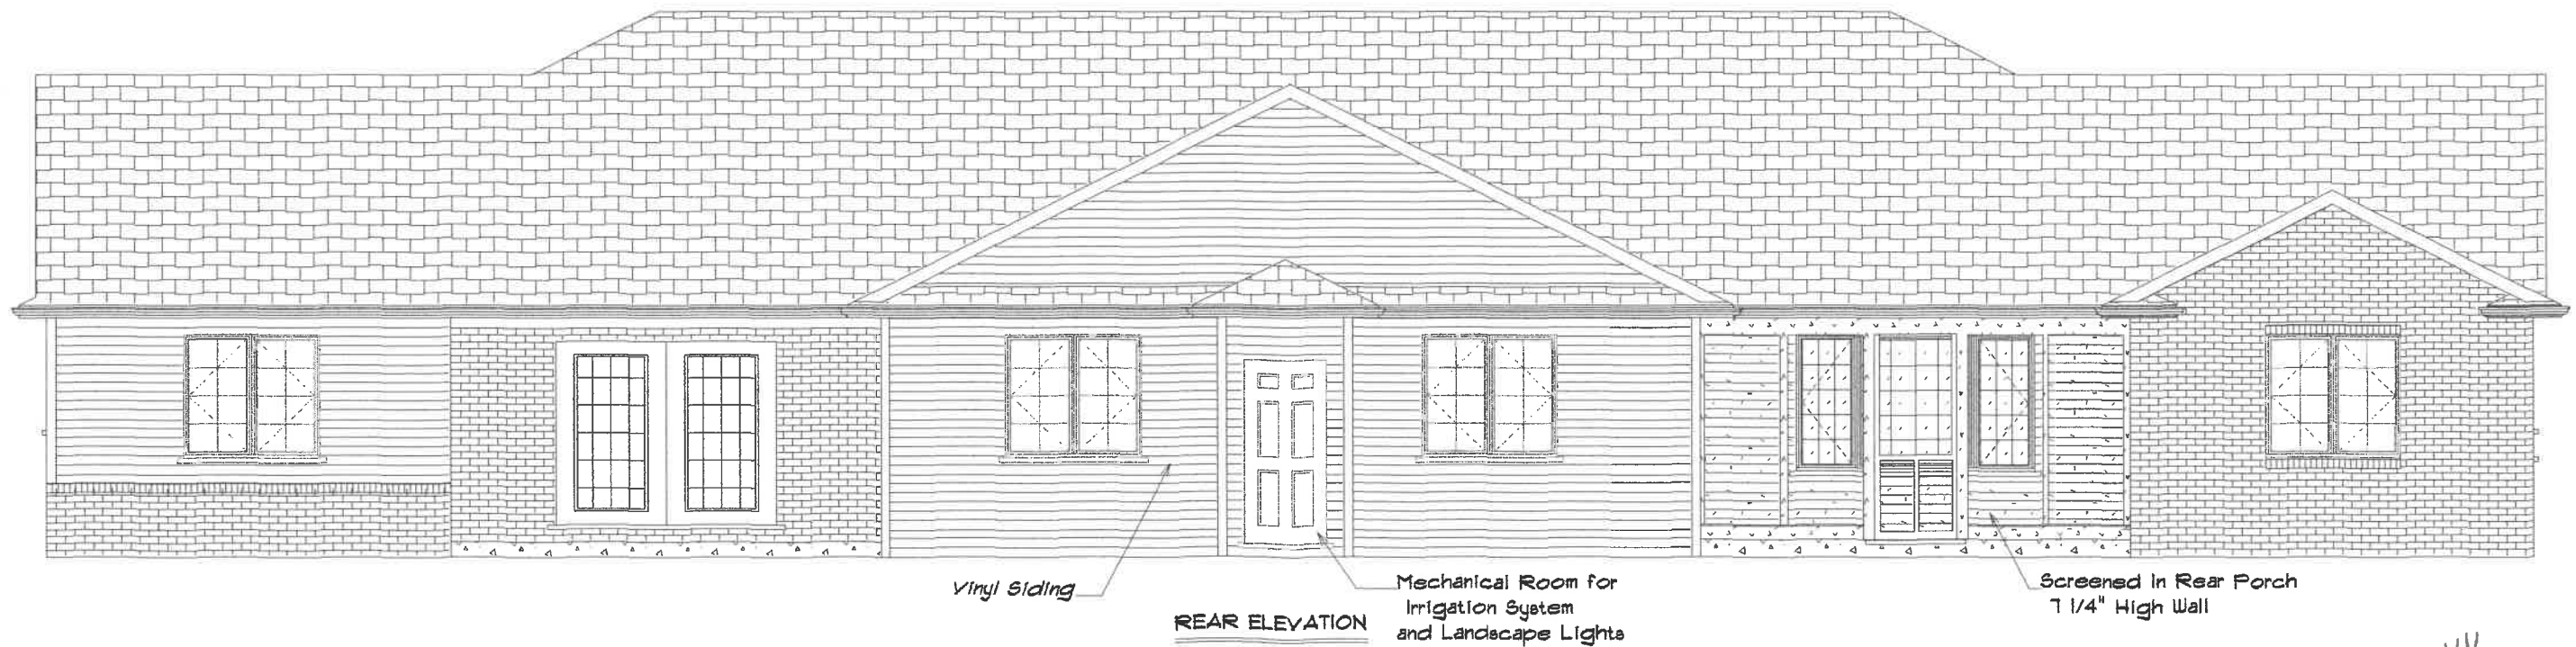

REAR ELEVATION

1146

Kahle Design & Build	
Defiance, Oh	Phone 491-4805
Scale: Var. 1/8"	Date 8/19/02
Spec 1146	
Location : Chelsea Ave. Napoleon	



Vinyl Siding


LEFT ELEVATION



4" Vinyl Siding

RIGHT ELEVATION


Kahle Design & Build	
Defiance, Oh	Phone 497-4805
Scale: Var., 1/8" = 1'-0"	Date 8/19/02
SPEC. 1146	
Location: Chelsea Ave. Napoleon	

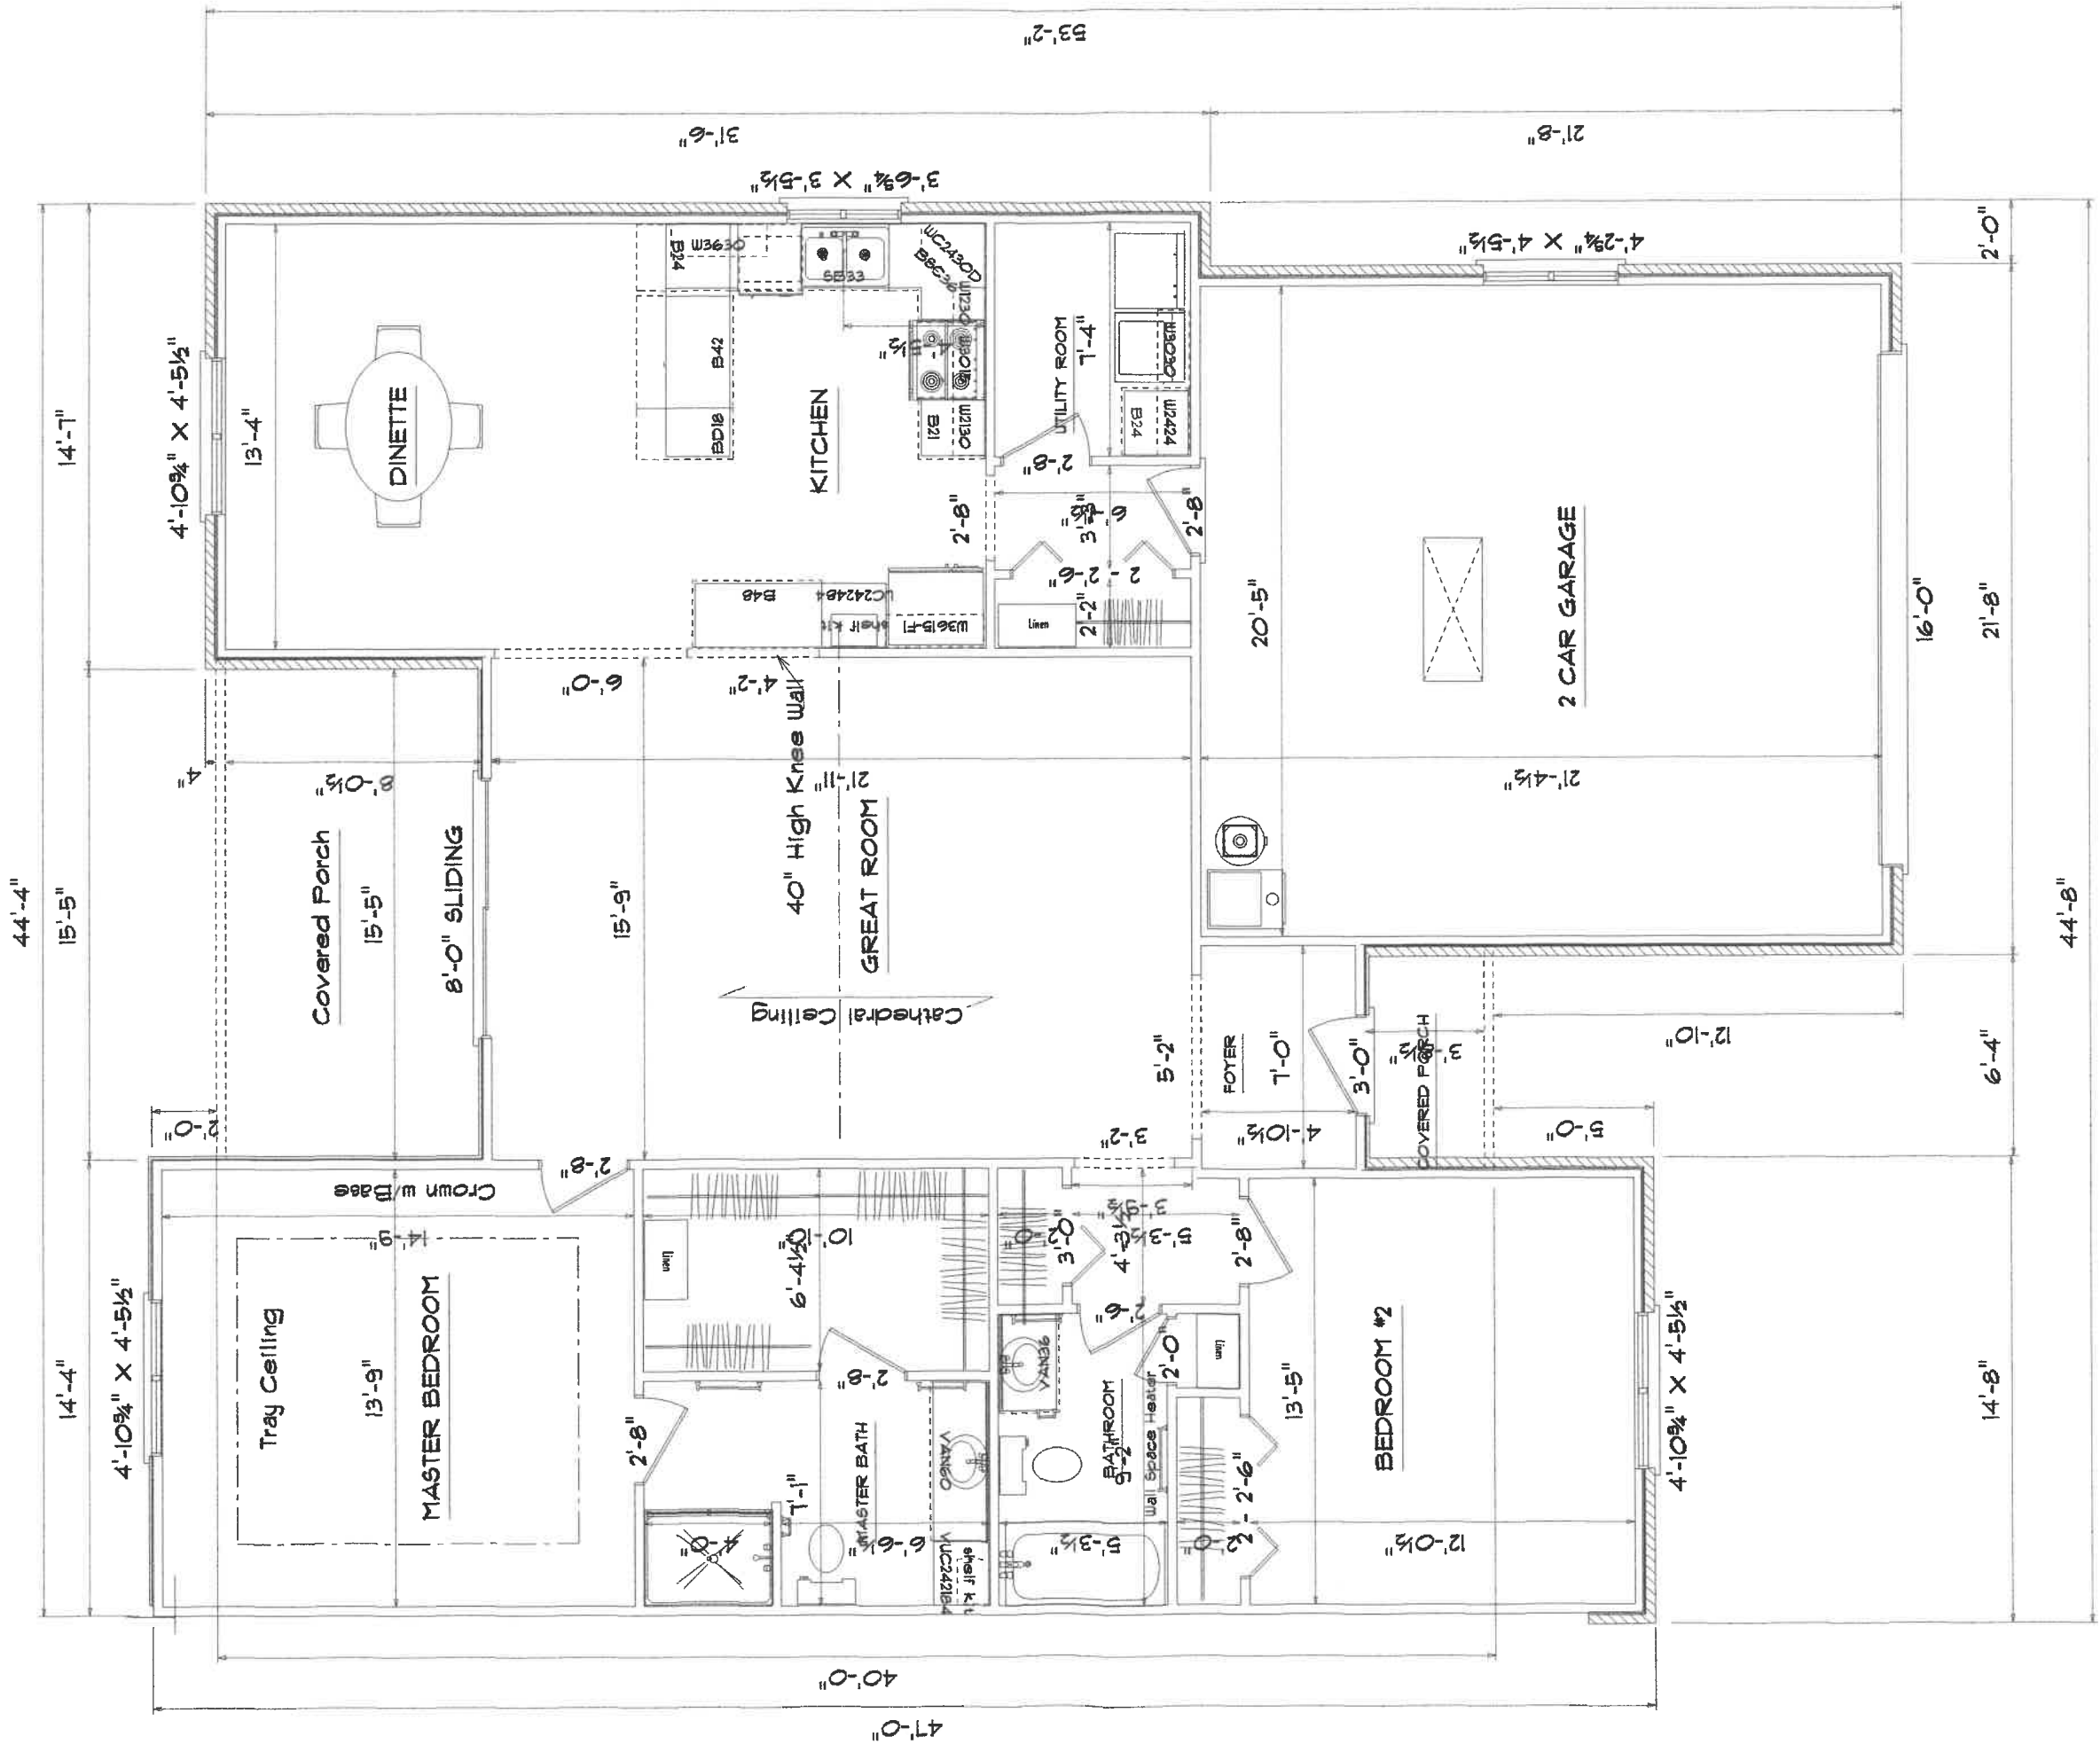


MAIN FLOOR PLAN

Square Footage : House 1515
 Garage 471
 Bk. Porch 130
 Frt. Porch 26

Kahle Design & Build			
Defiance, Oh	Phone 497-4805	Date 10/19/02	
Scale: Var.'1'0"		Spec 1146	
Location : Chelsea Ave. Napoleon			

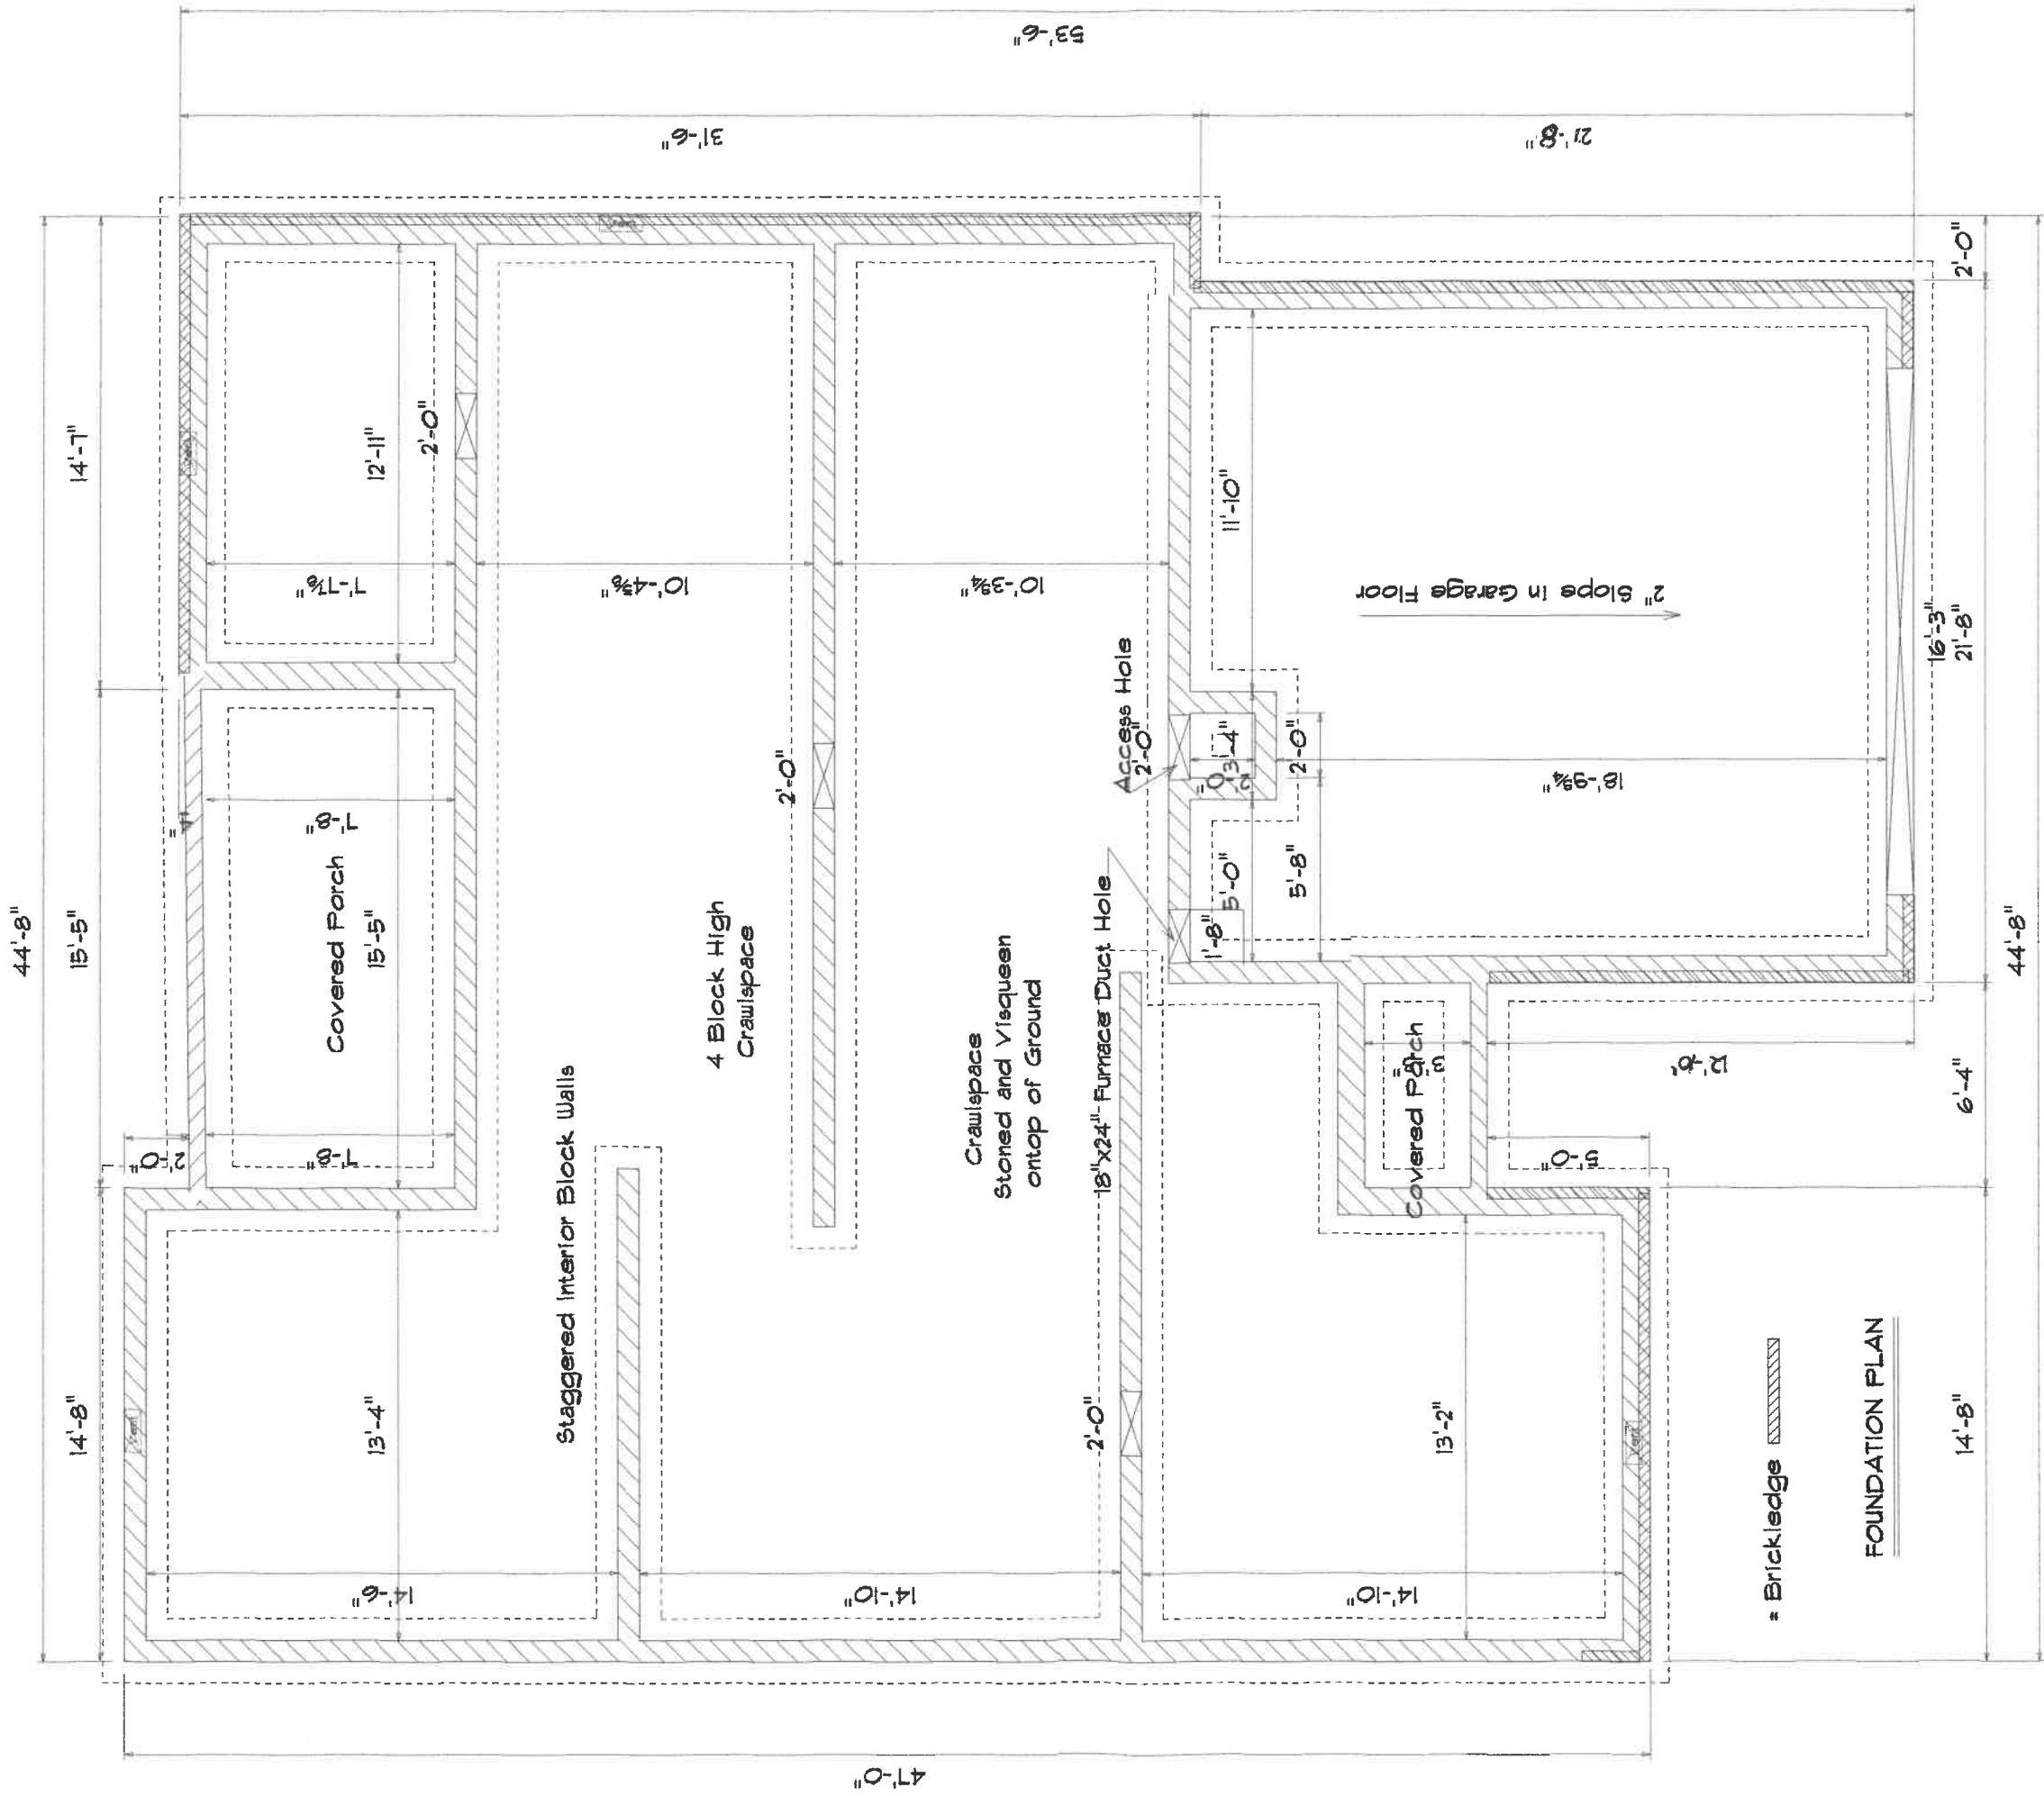

Kahle Design & Build	
Defiance, Oh	Phone 419-4805
Scale: Var.=1"=10'	Date 10/19/02
Spec 1146	
Location : Chelsea Ave. Napoleon	

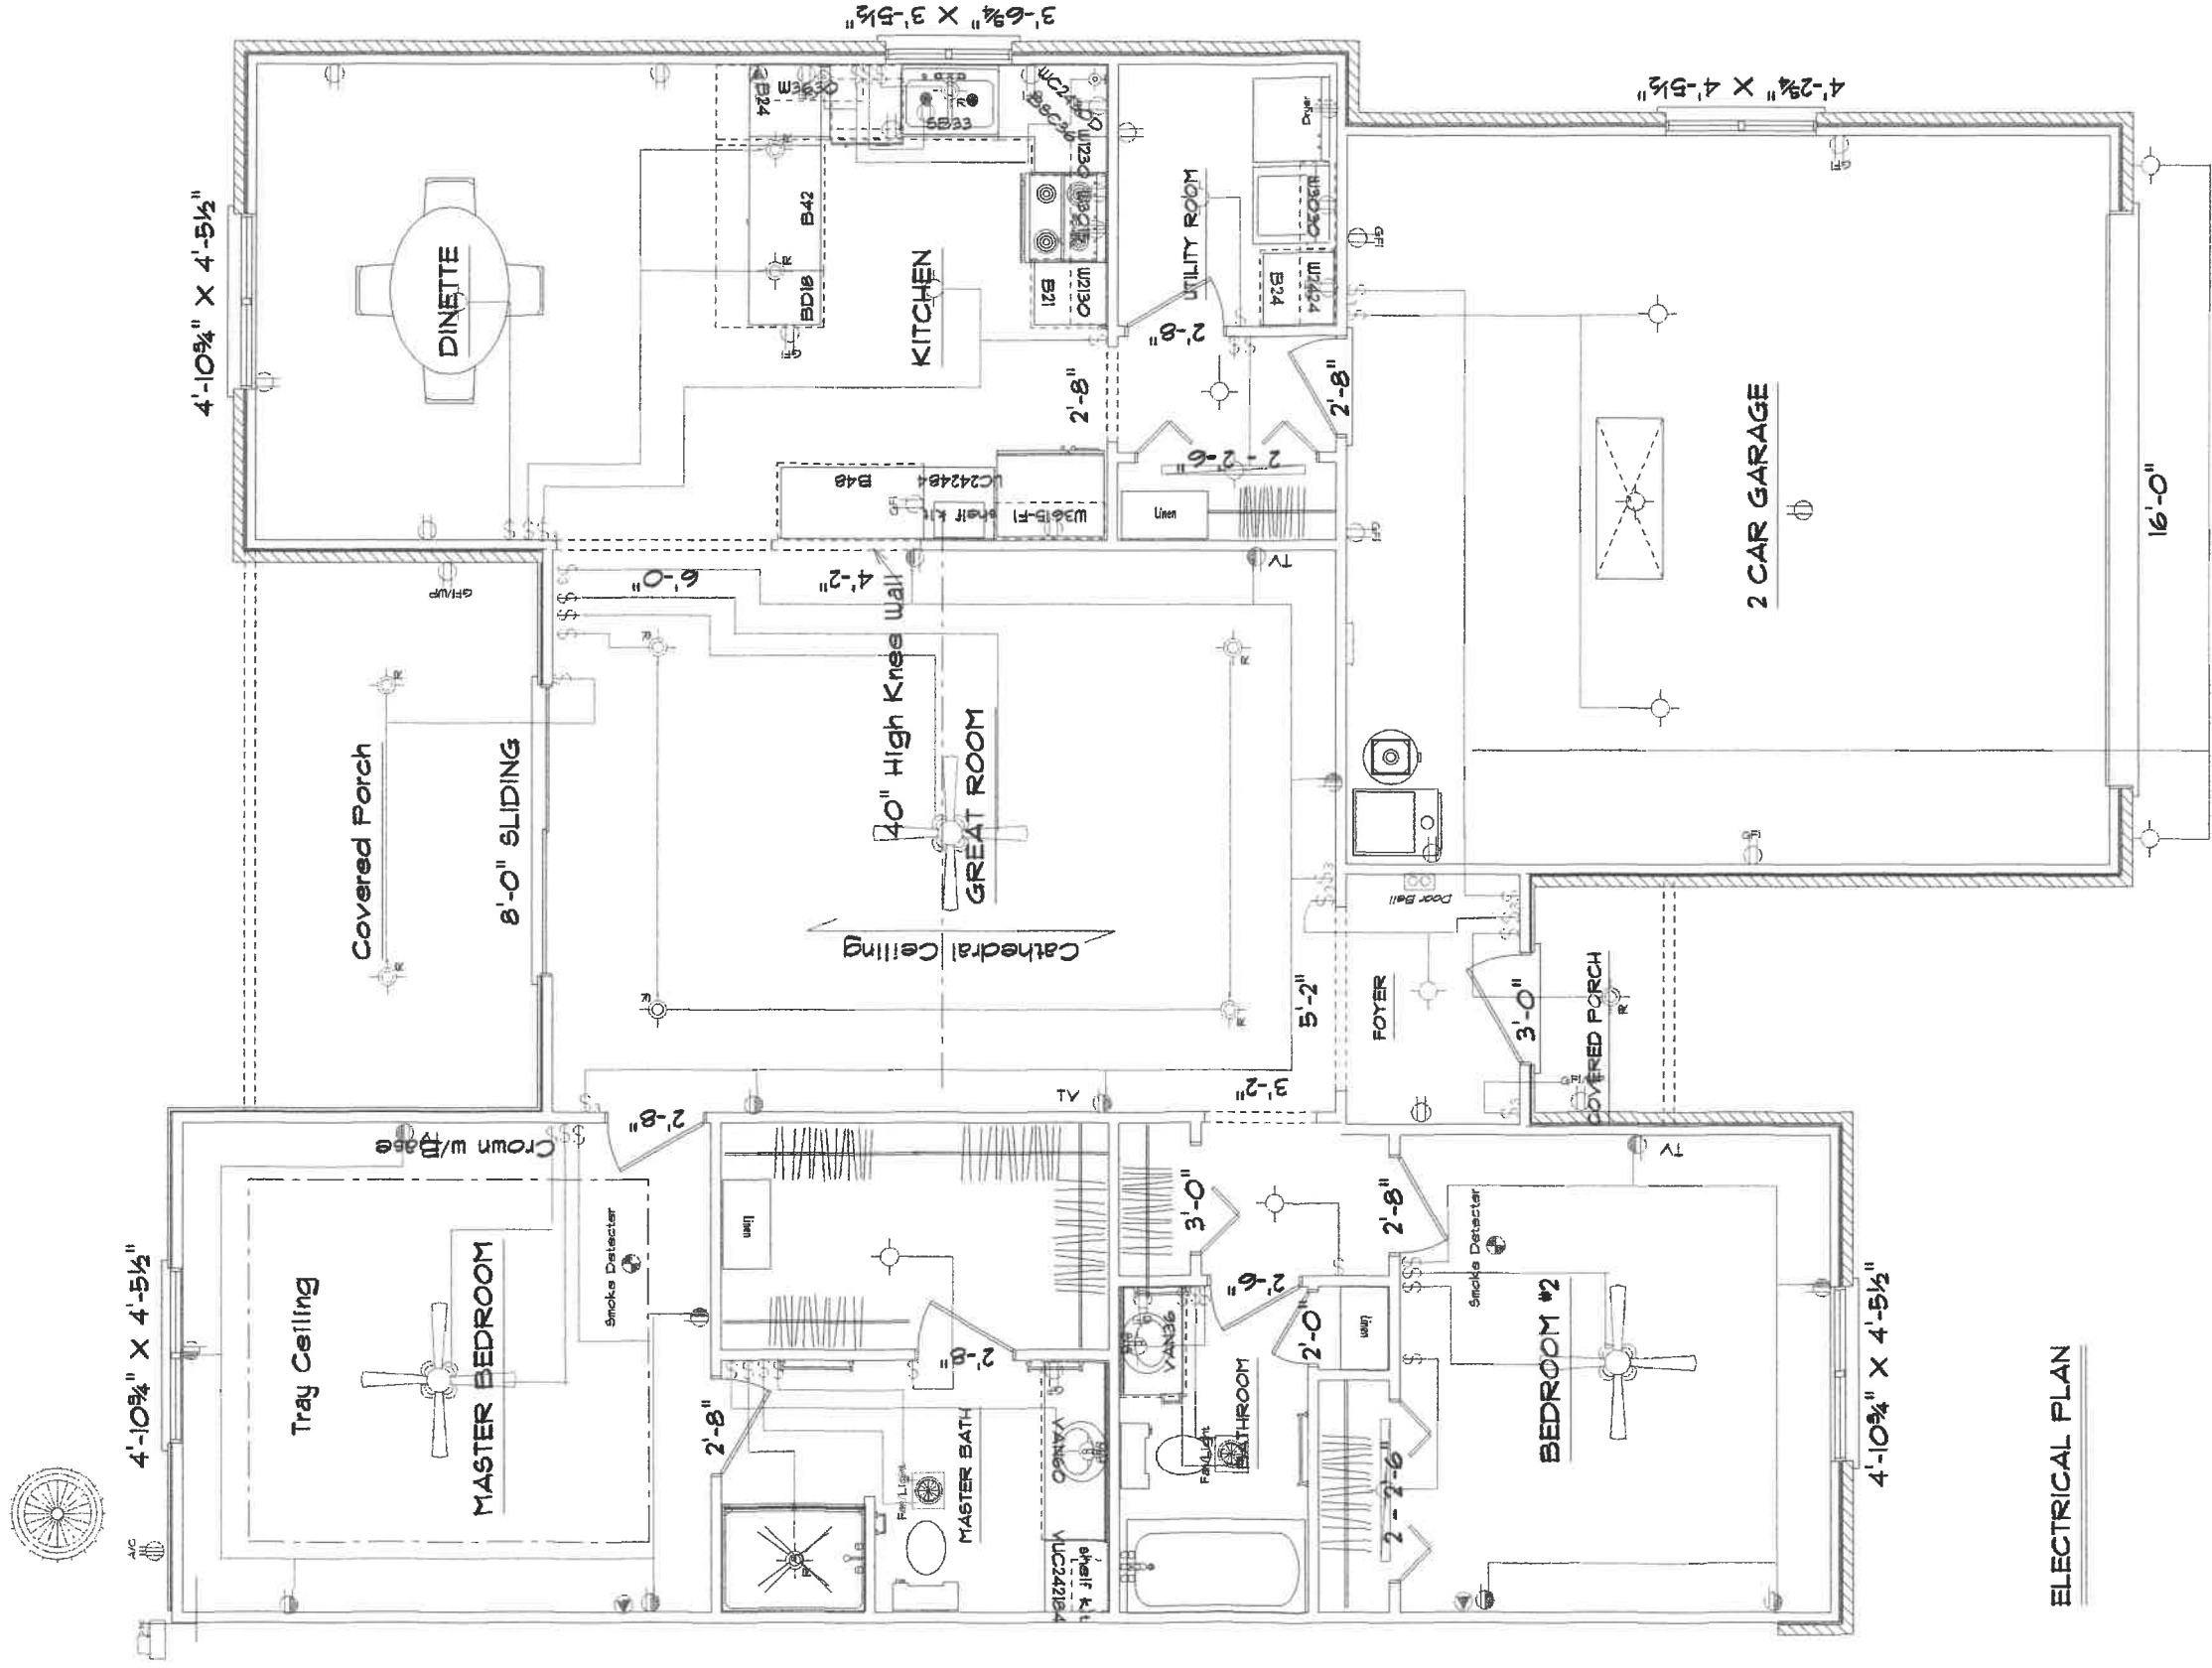

ELECTRICAL PLAN


Square Footage : House 1515
 Garage 471
 Bk. Porch 130
 Frt. Porch 26

Kahle Design & Build	
Defiance, Oh	Phone 497-4805
Scale: Var. 1/0"	Date 10/19/02
Spec 1146	
Location : Chelsea Ave. Napoleon	

PLOT PLAN

511.42'

Phase #2

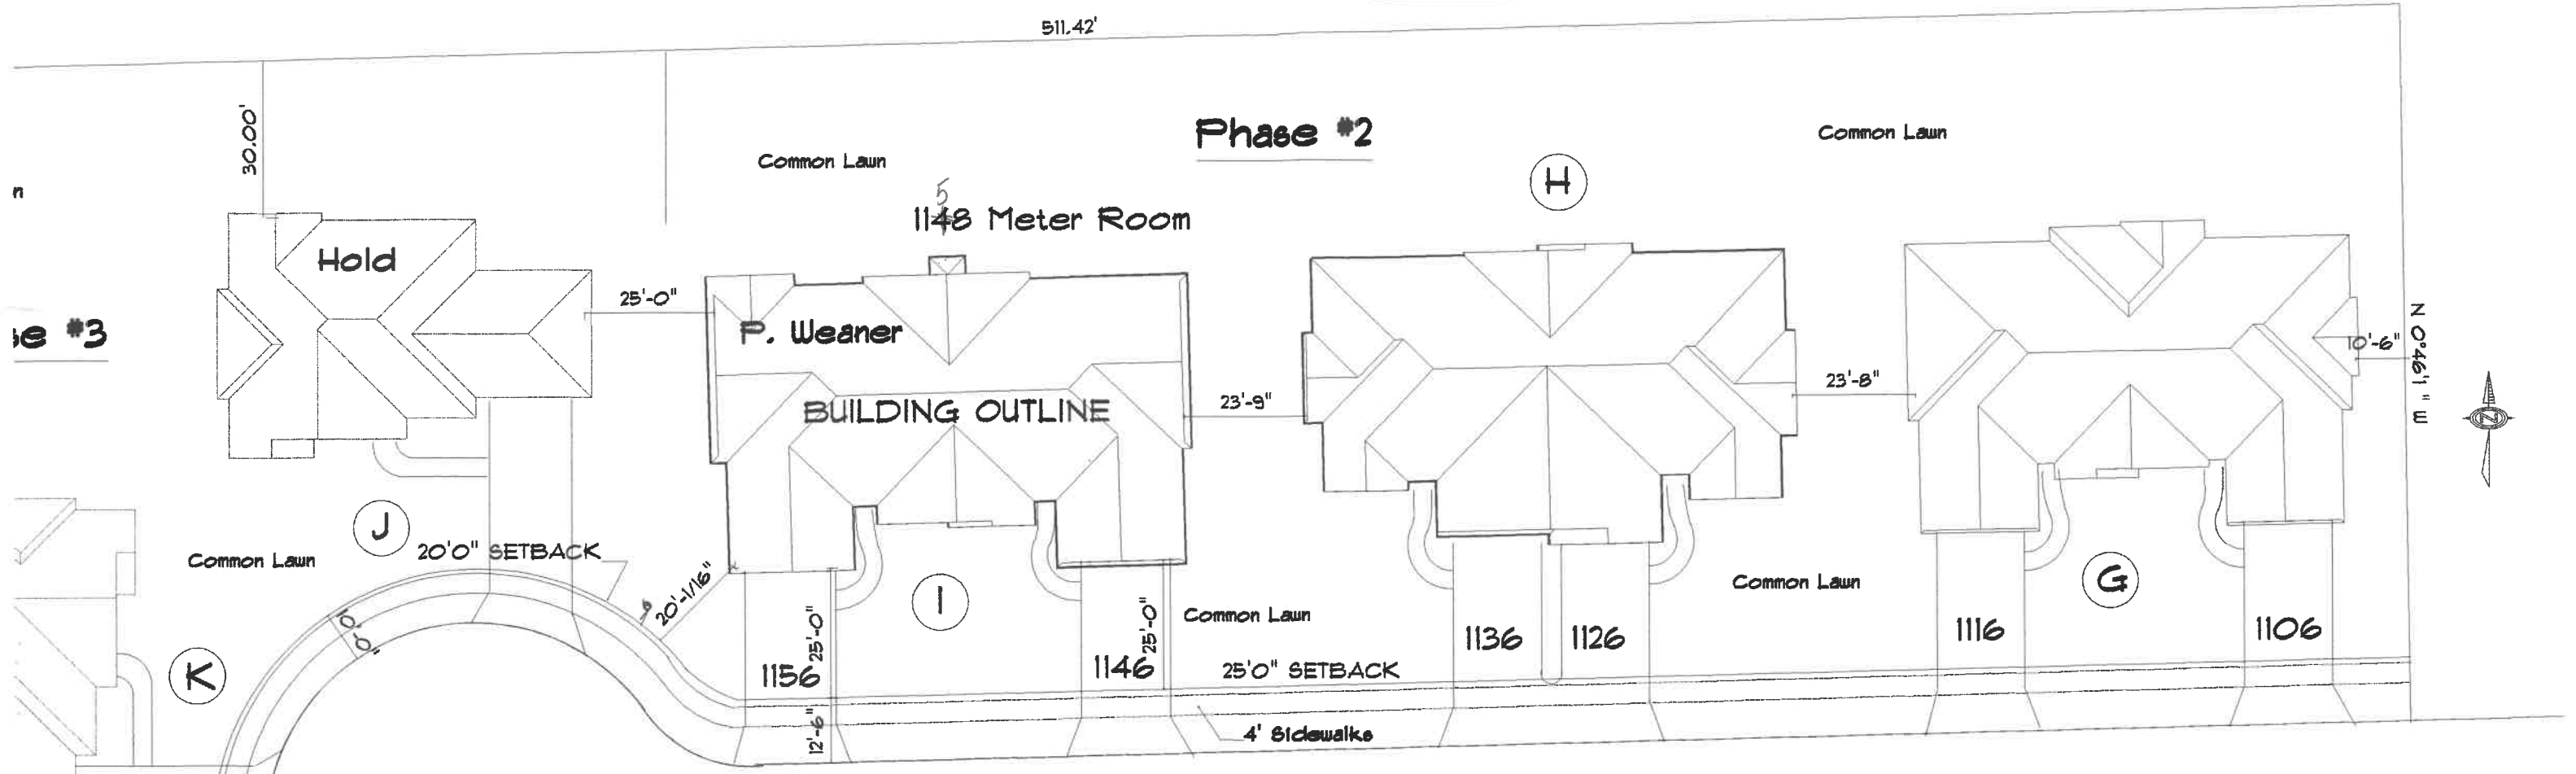

CHELSEA AVENUE

