




FRONT ELEVATION

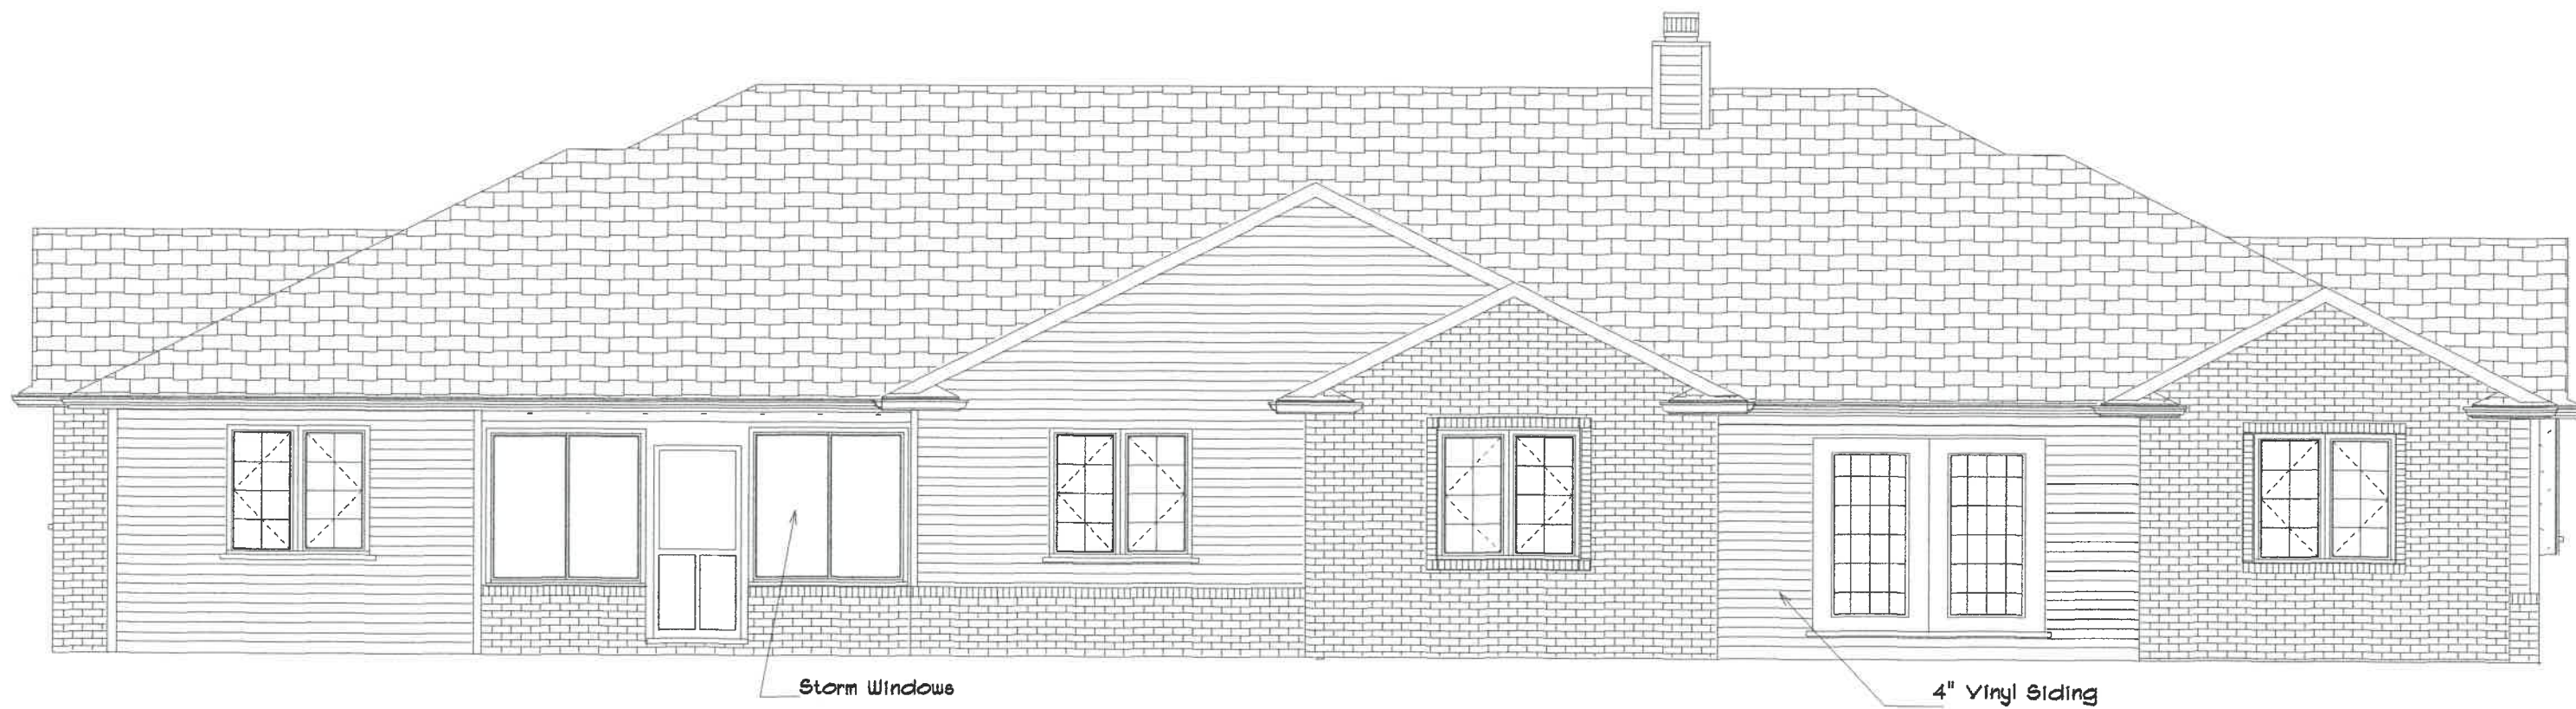

REAR ELEVATION



Kahle Design & Build	
Defiance, Oh	Ph: 497-4805
Sc: Var. 1/0"	Date 03/12/01
Mr. & Mrs. Dick Denny	
Location: Chelsea Ave. Nap.	


1155  
 PMT #630

96,000.00



Location: Chelsea Ave. Nap.	
Mr. & Mrs. Dick Brady	
Sc: Var. 1/0"	Date: 03/12/01
Defiance, Oh Ph: 497-4805	
Kahle Design & Build	

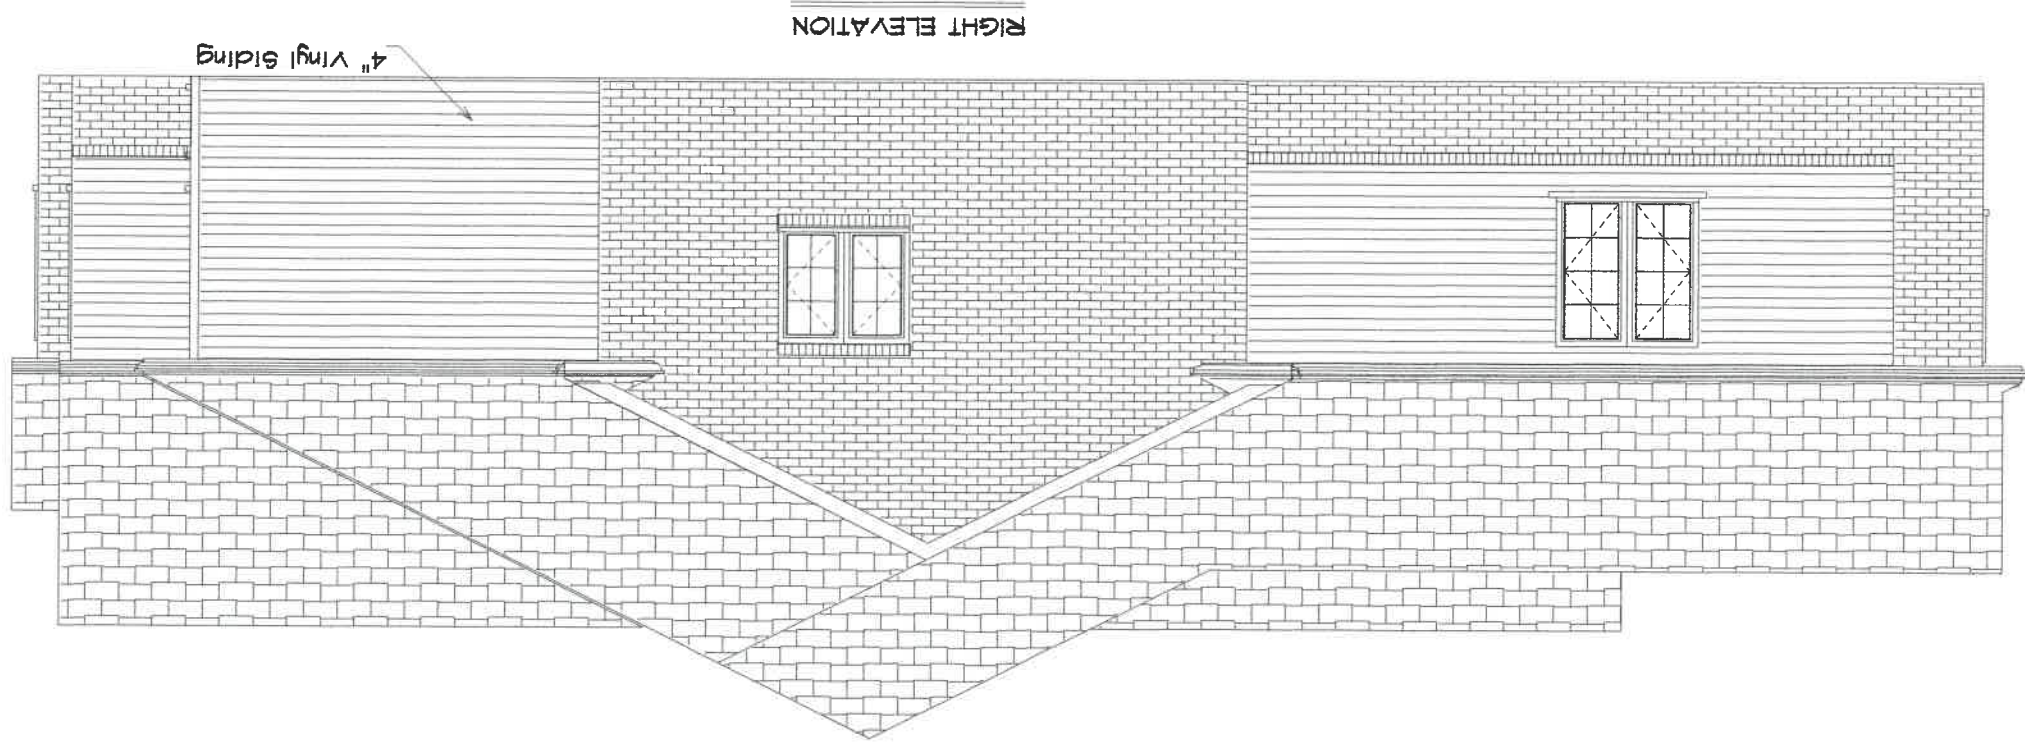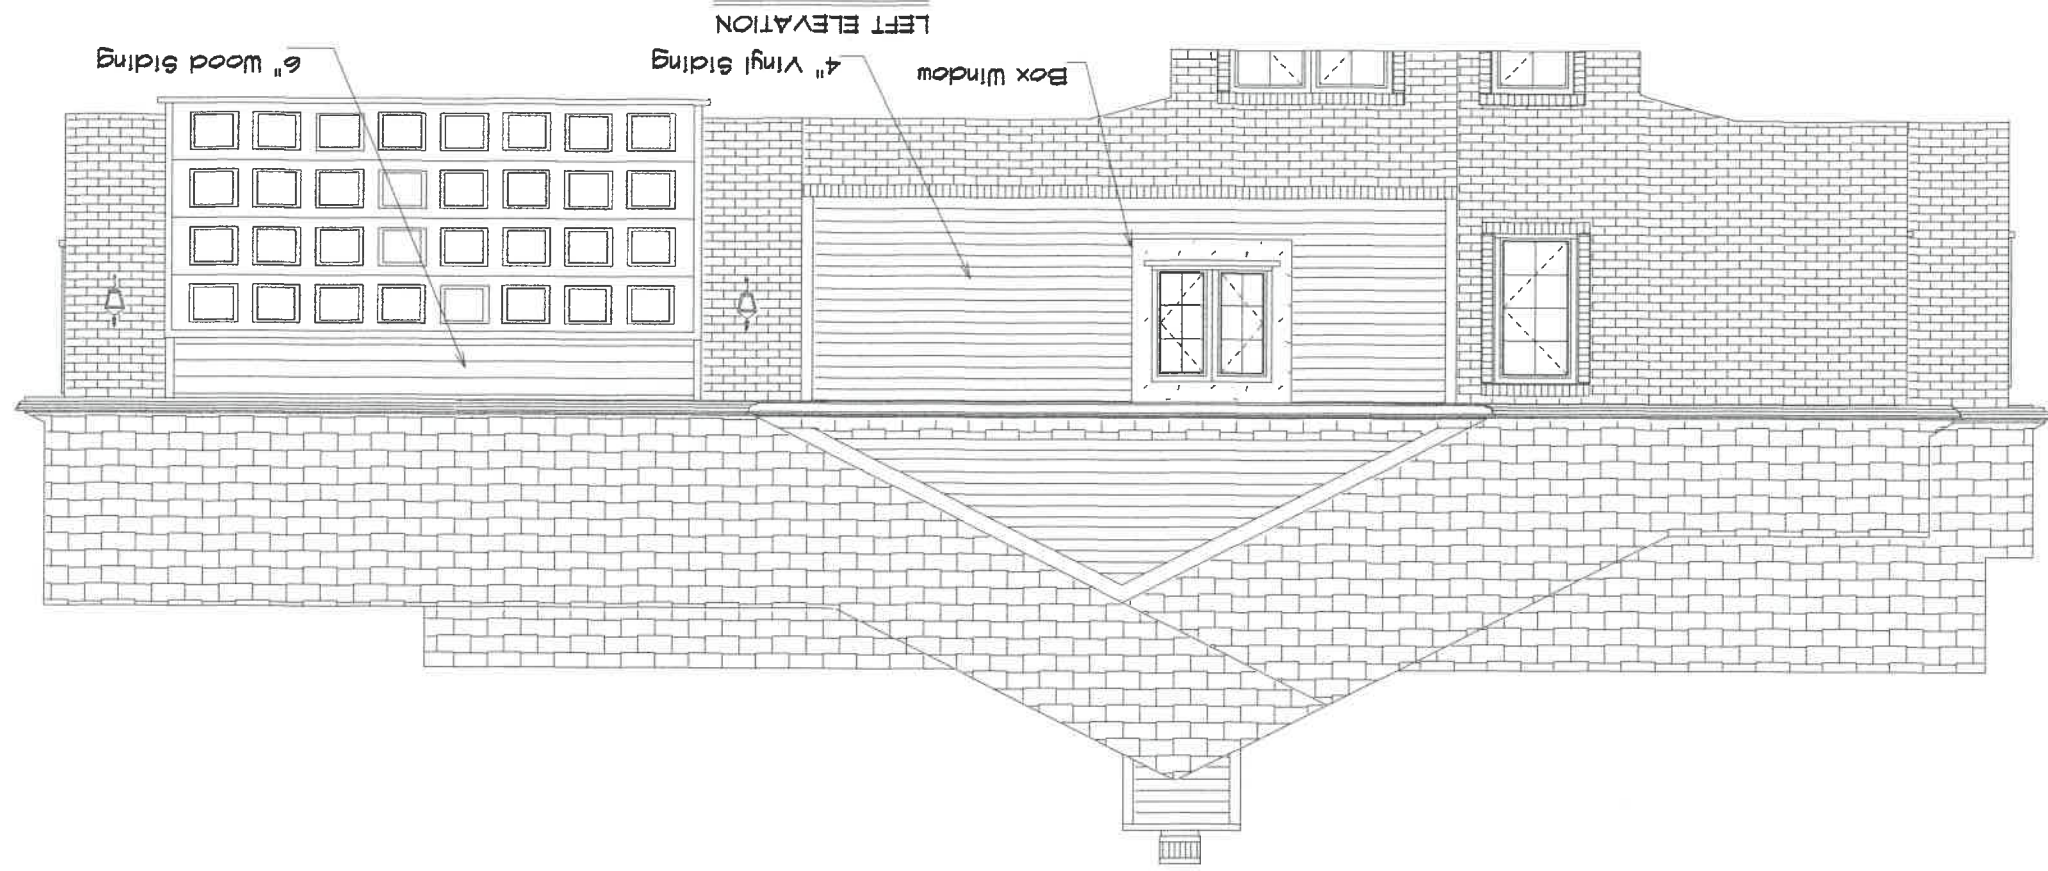


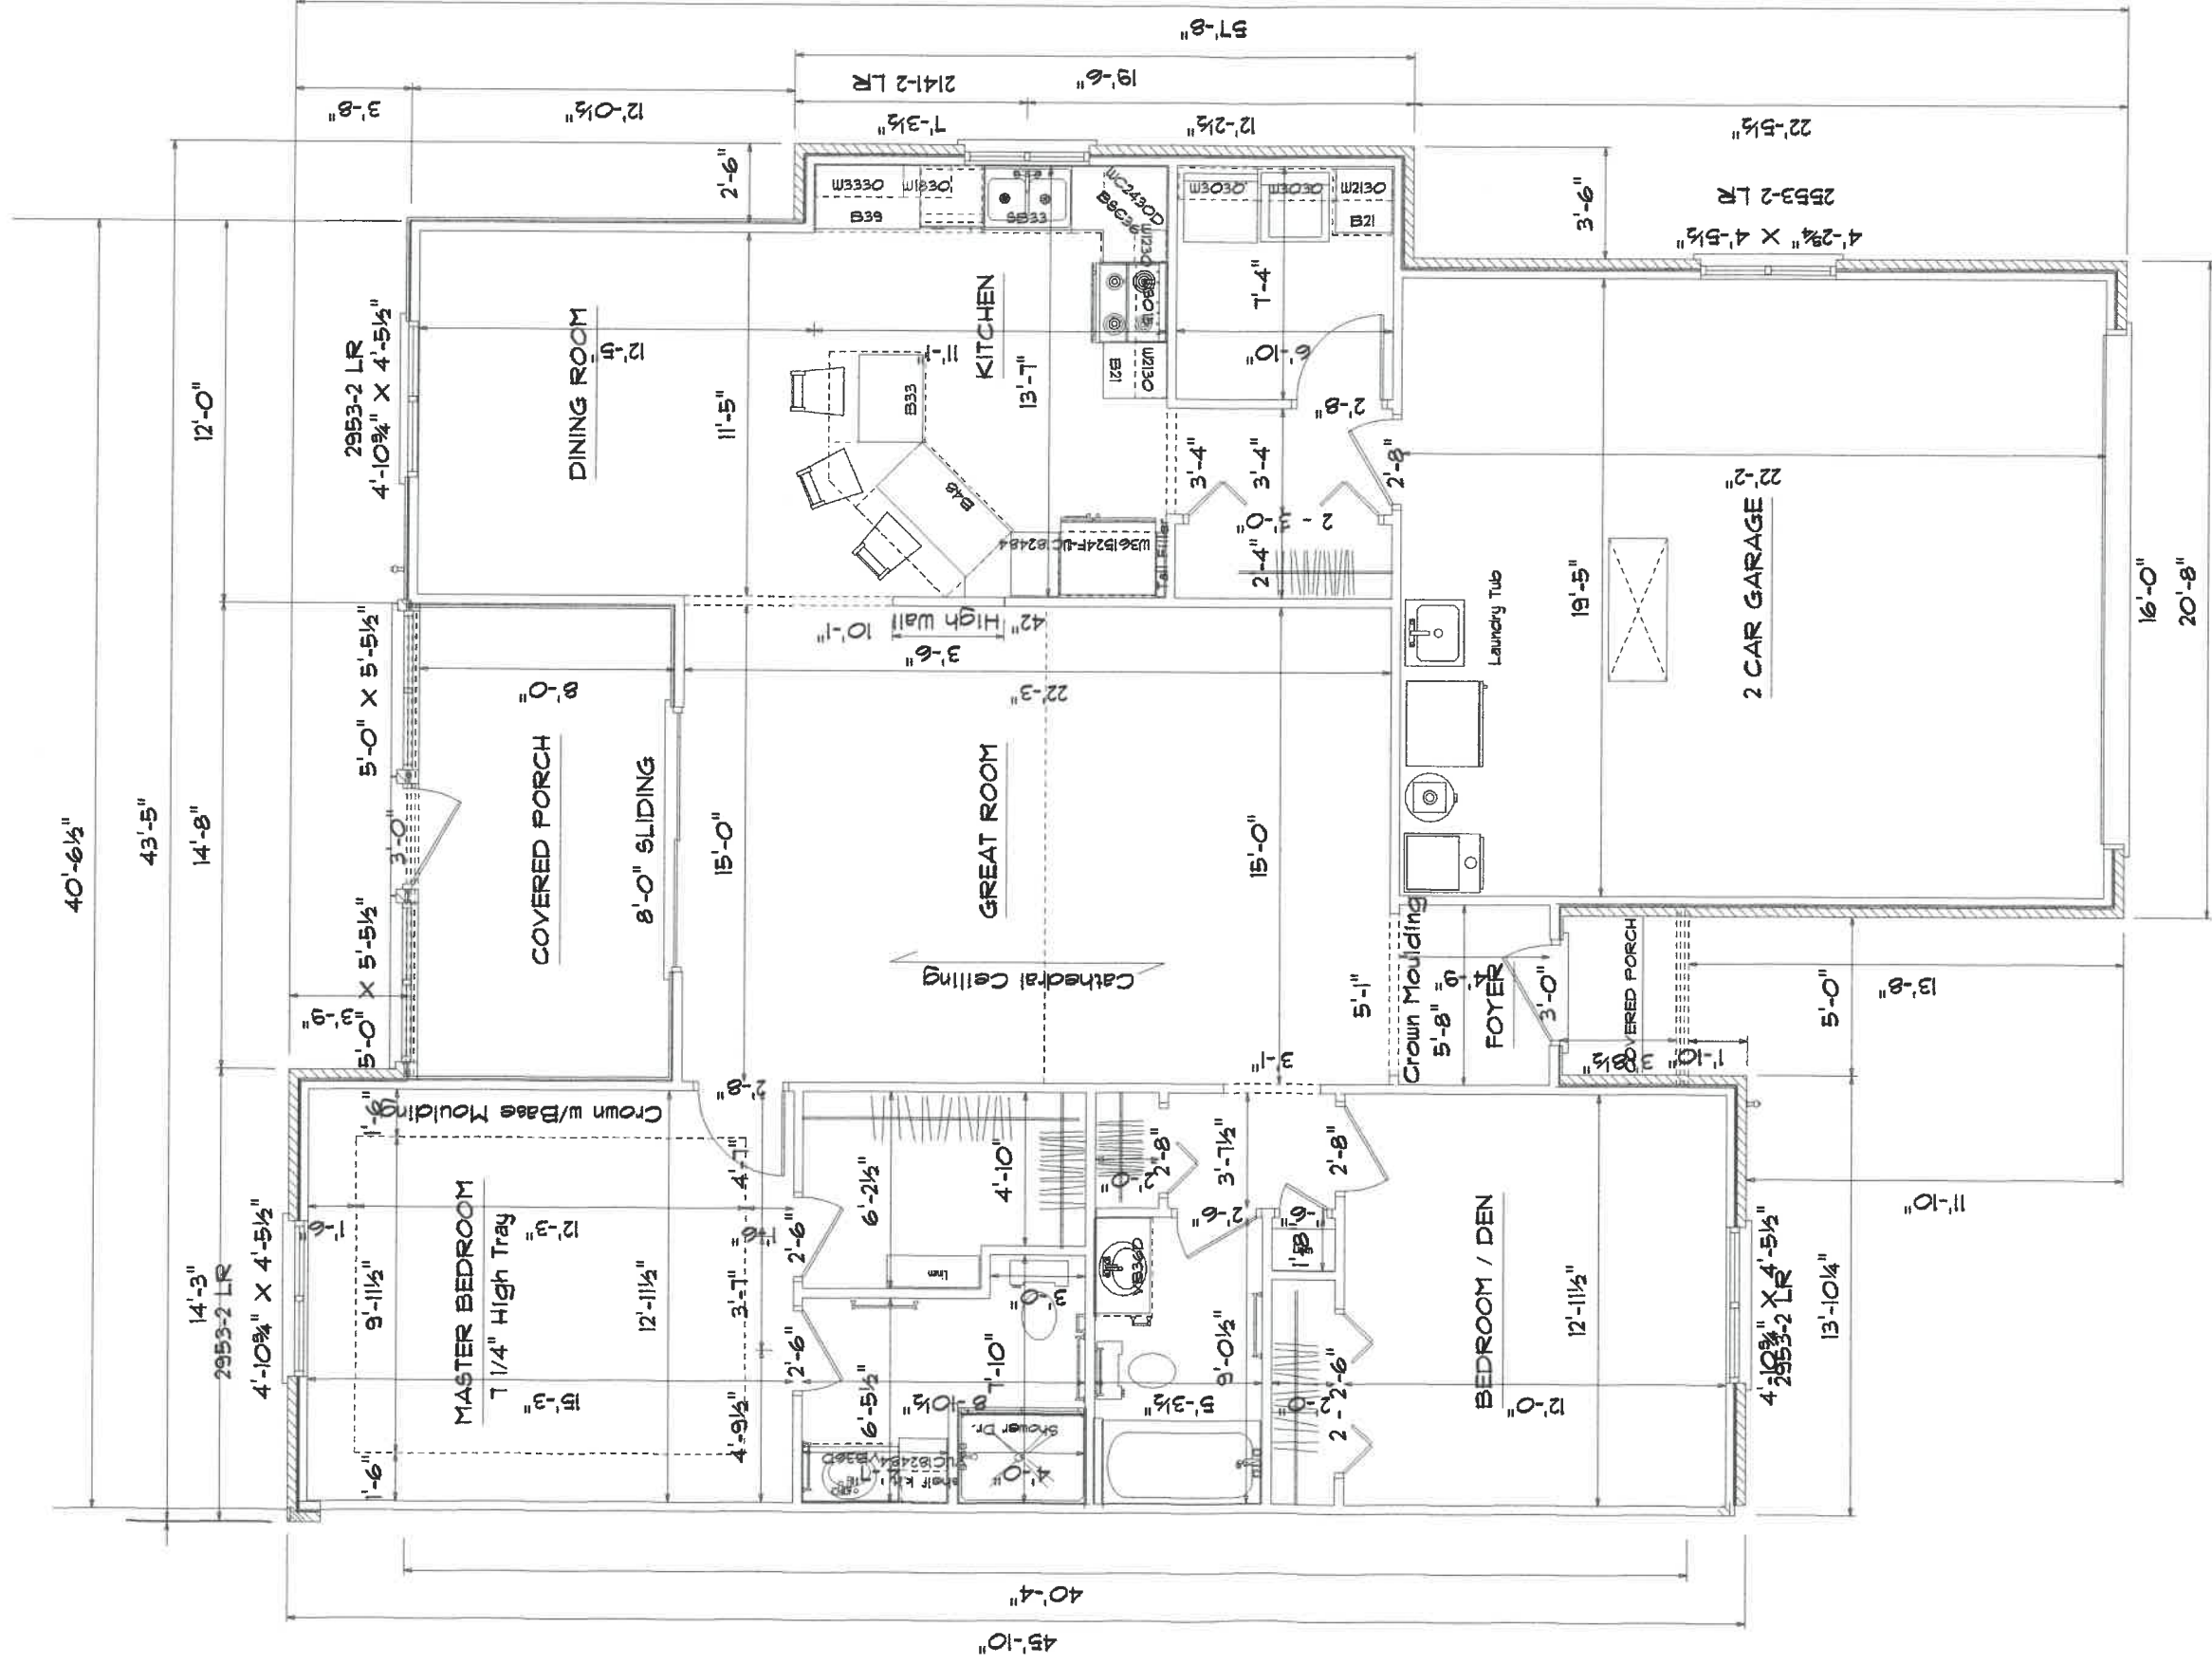

Square Footage : House 1422  
 Garage 465  
 Bk. Porch 122  
 Frt. Porch 20

<i>Kahle Design &amp; Build</i>			
Defiance, Oh	Phone 782-7156	Date	8-16-00
Scale: 3/16"=1'-0"			
Nap. Condo for Dick Denny			
Location : 1155 Chelsea Ave., Napoleon			




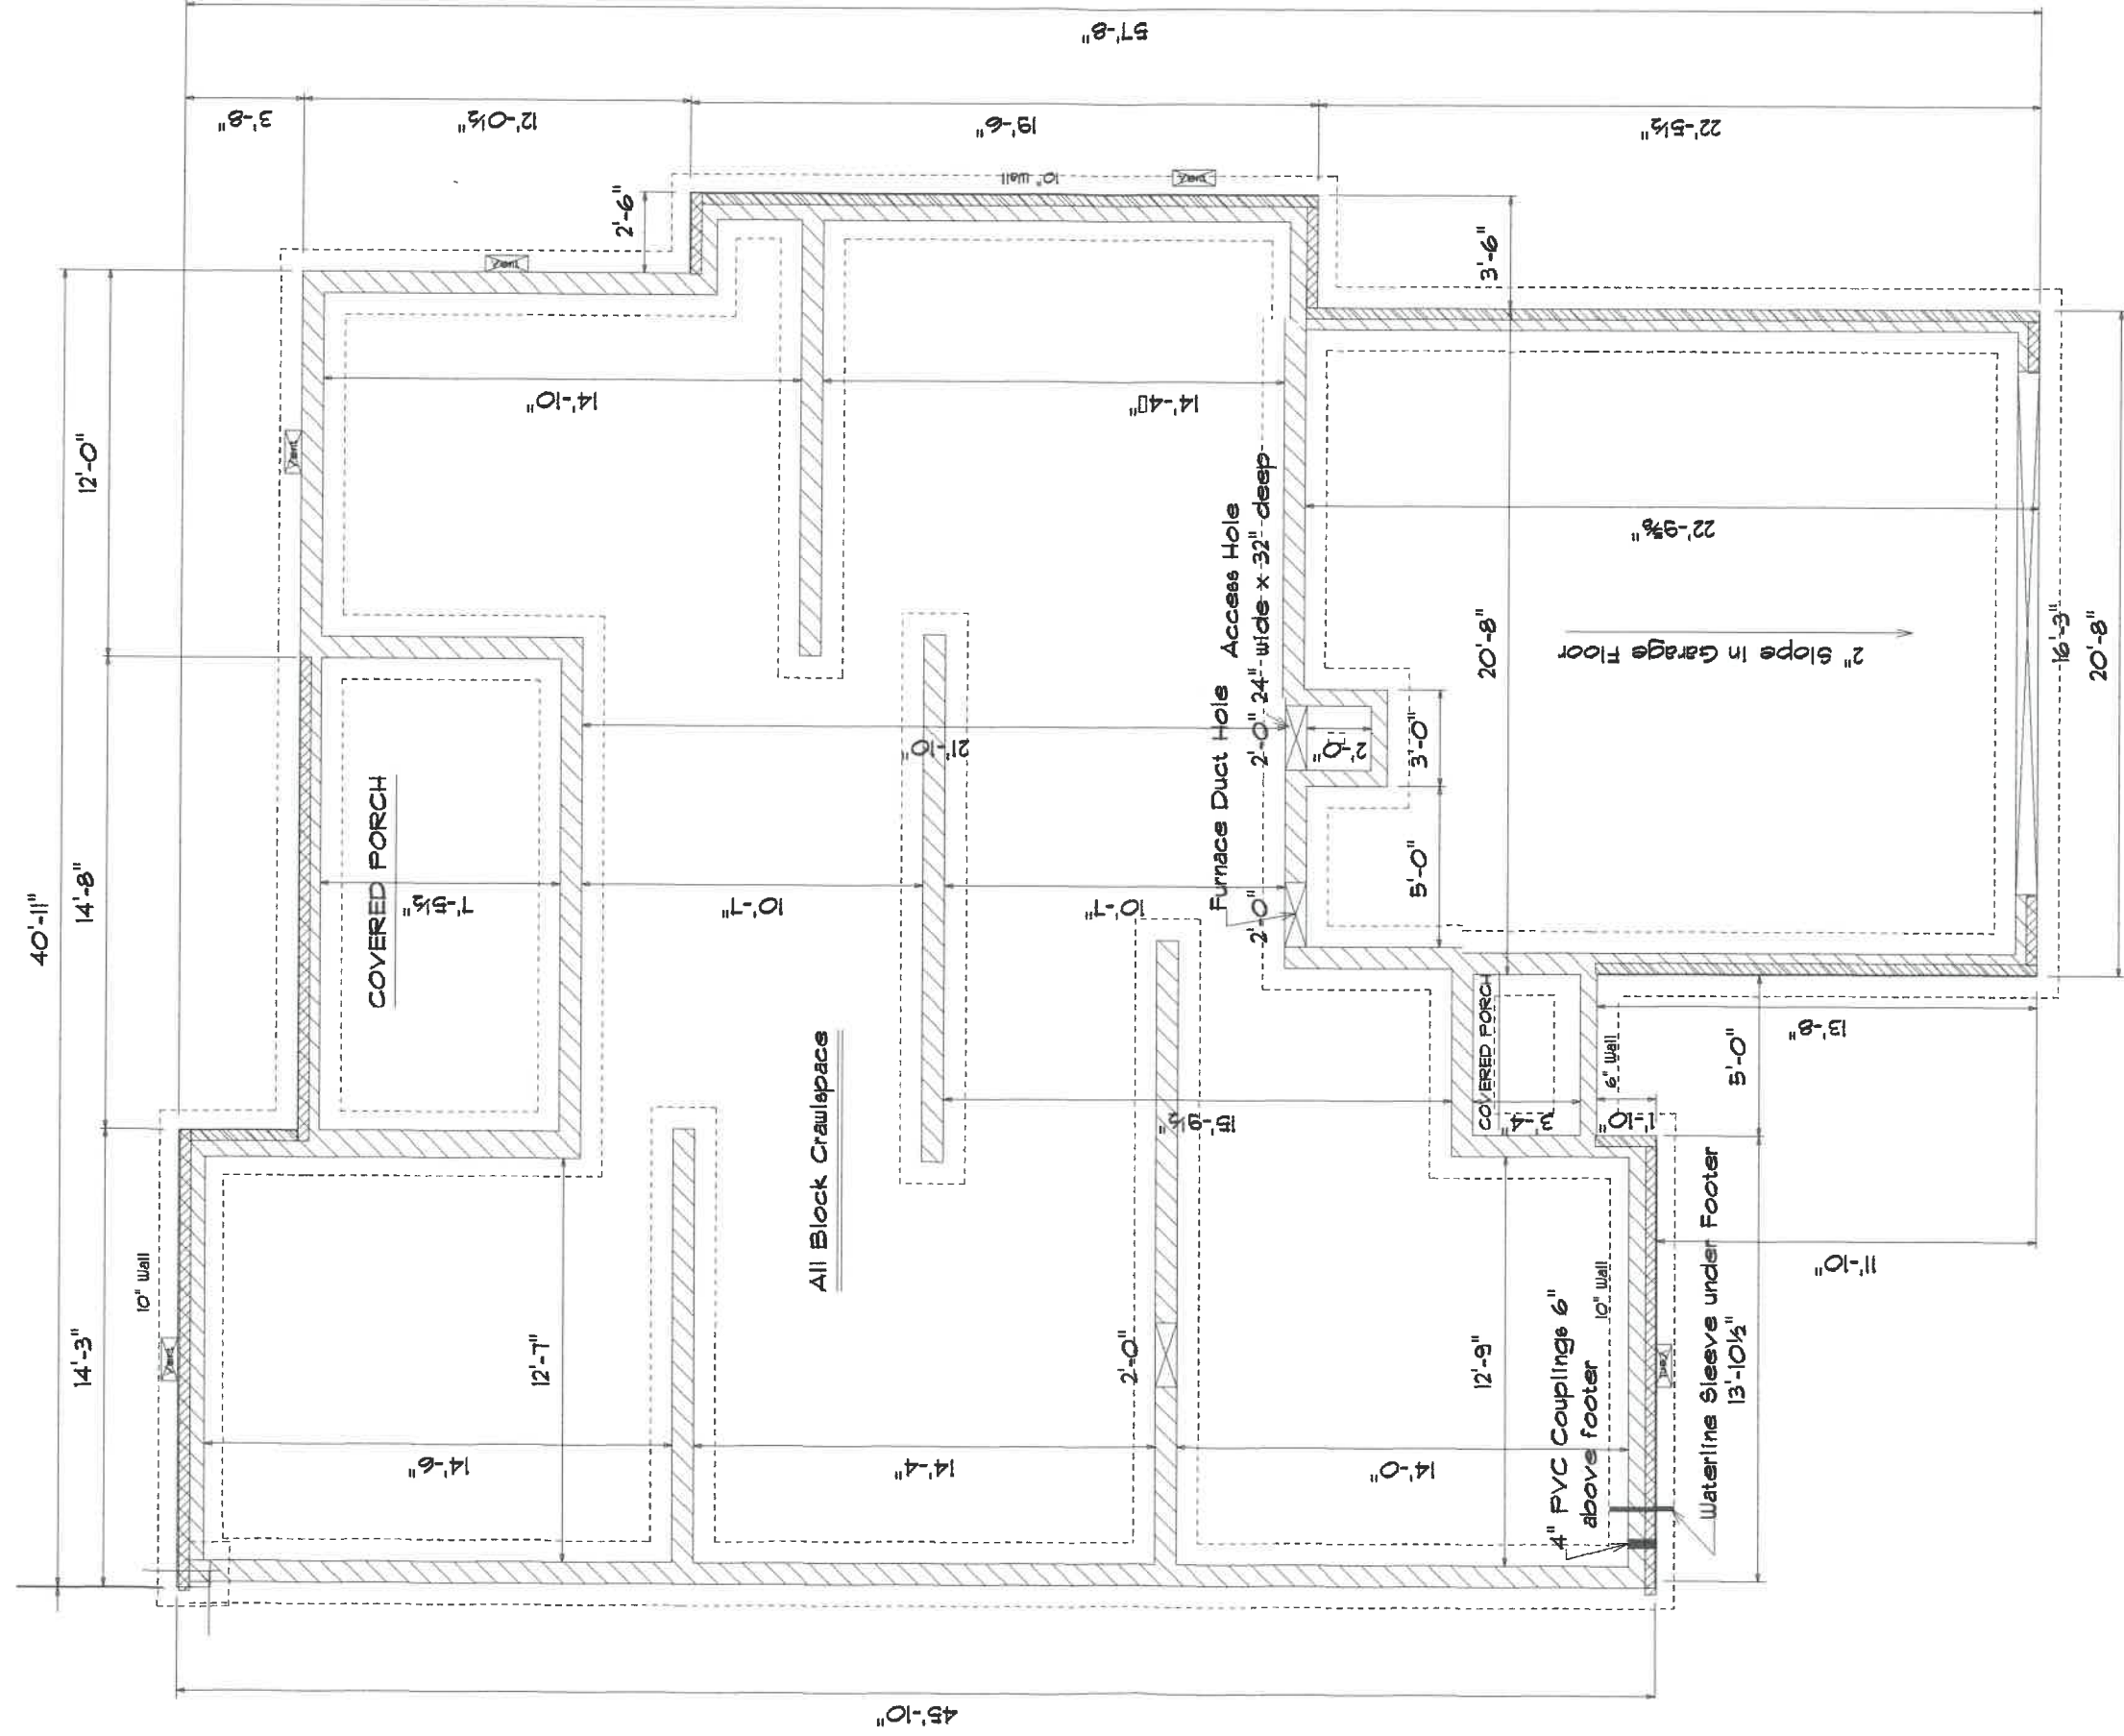

 = Brick Ledge

FOUNDATION PLAN


<i>Kahle Design &amp; Build</i>	
Defiance, Oh	Phone 182-1156
Scale: 3/16"=1'0"	Date 8-16-00
Nap. Condo for Dick Denny	
Location : 1155 Chelsea Ave., Napoleon	

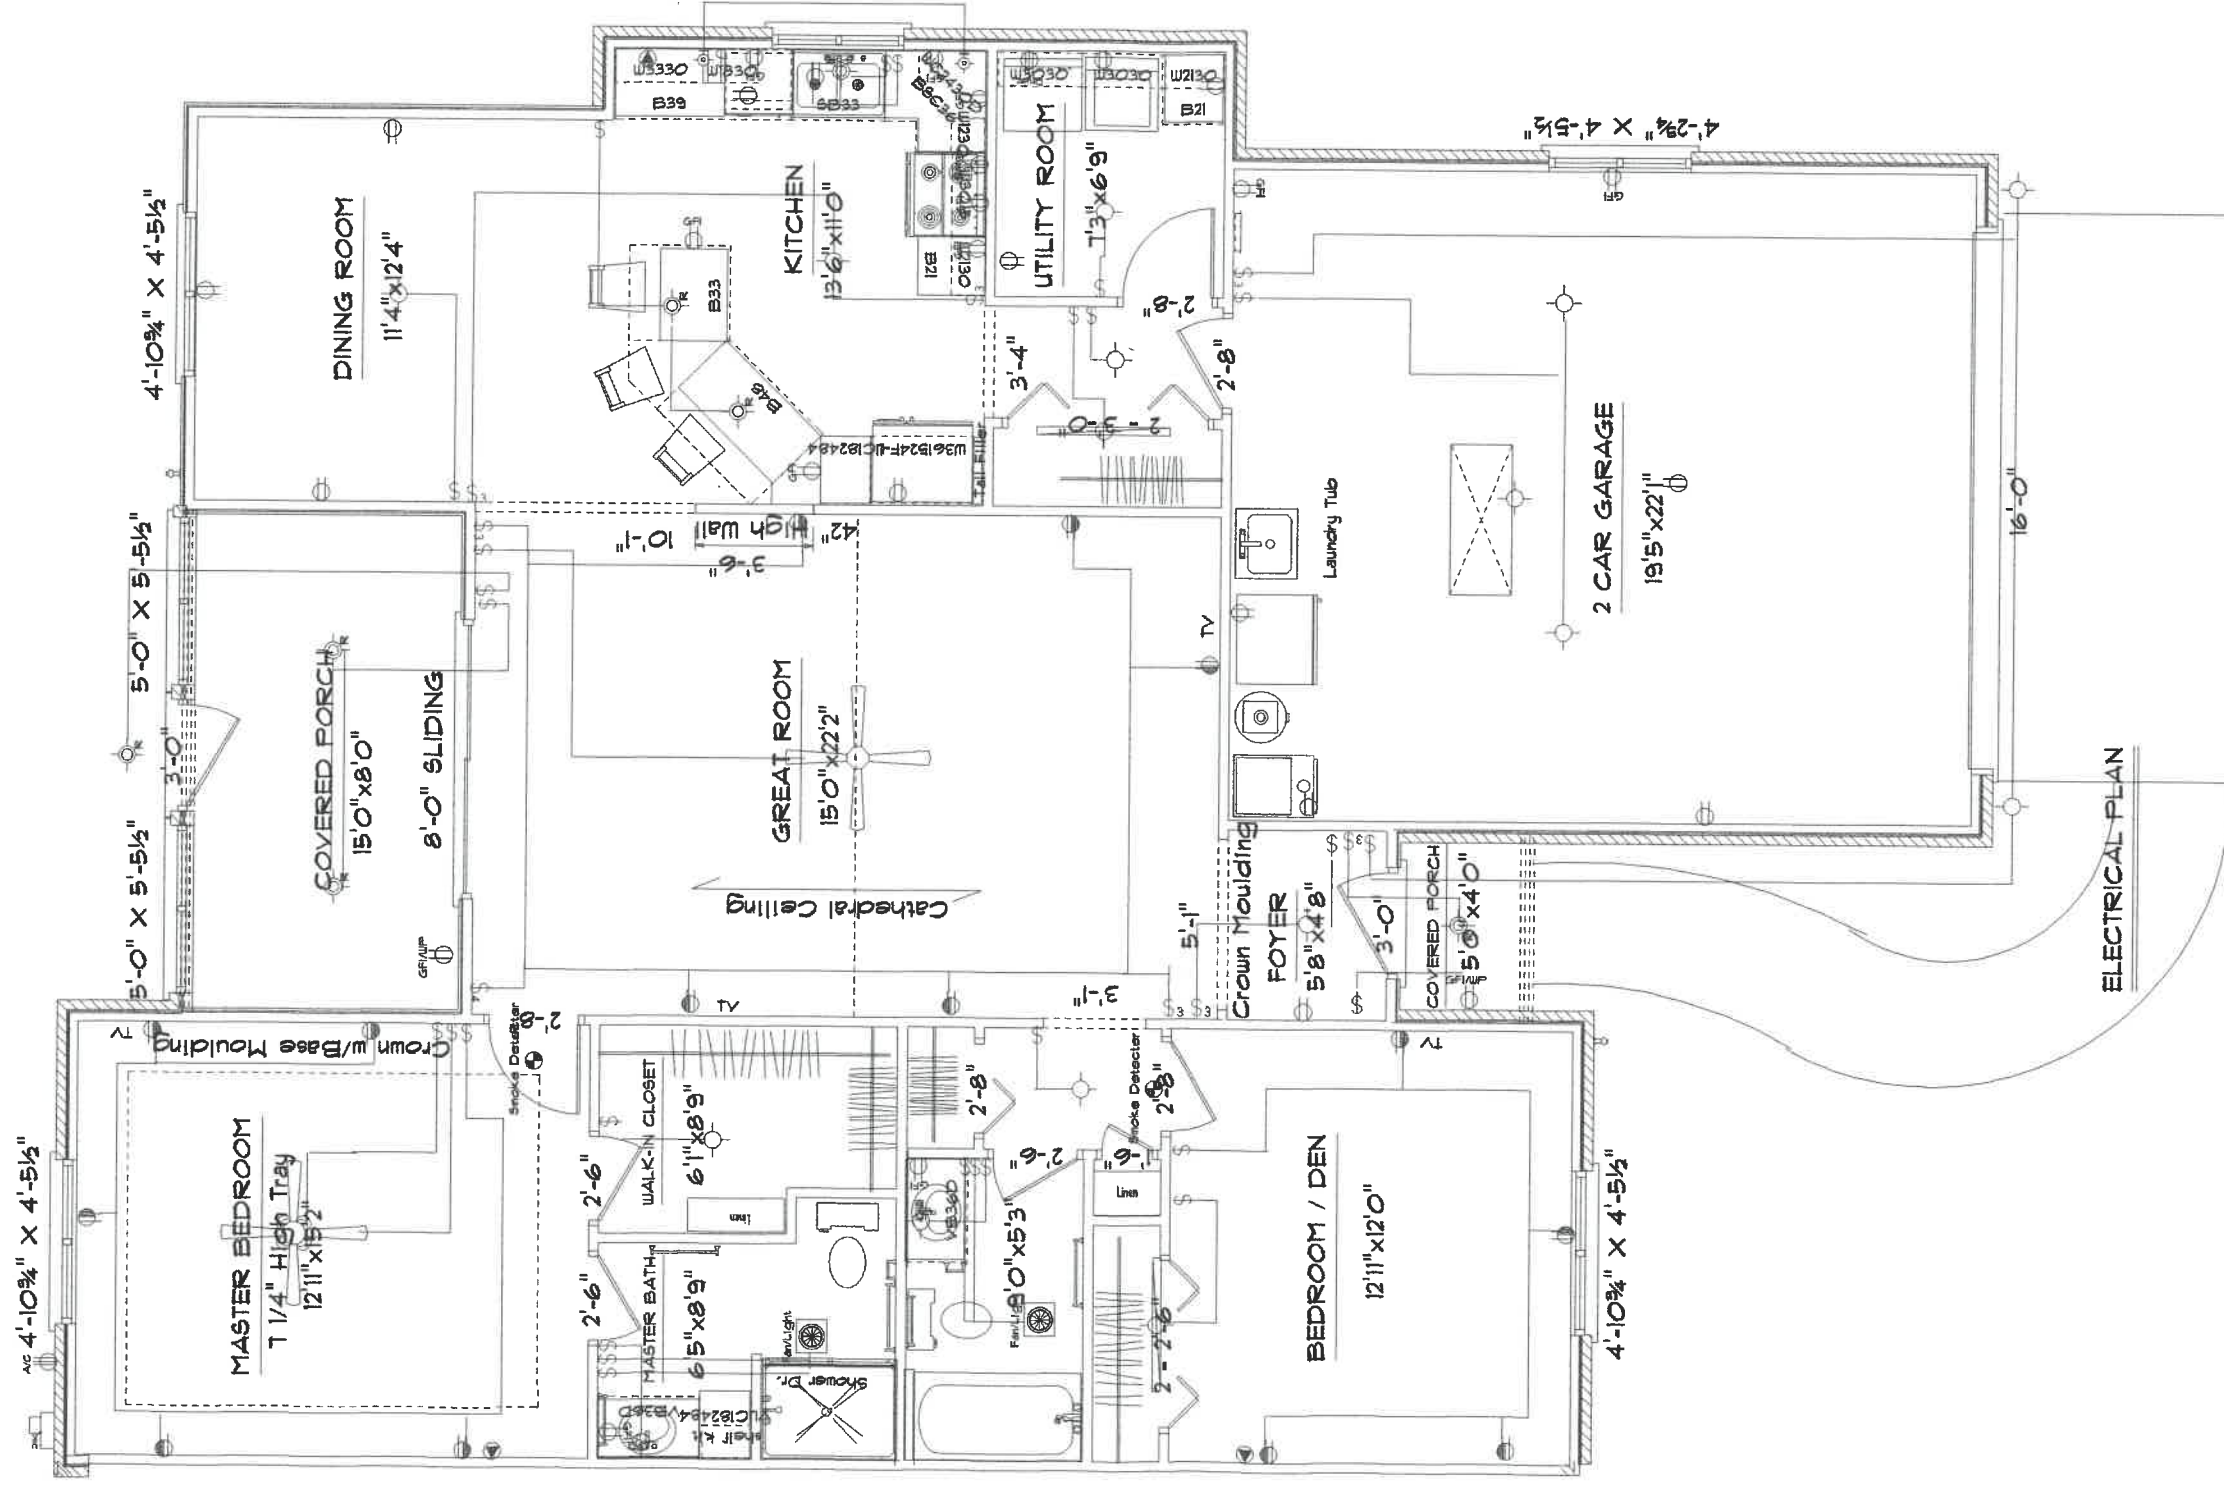

Square Footage : House 1422  
 Garage 465  
 Bk. Porch 122  
 Ft. Porch 20

<b>Kahle Design &amp; Build</b>	
Defiance, Oh	Phone 762-1156
Scale: 3/16"=1'0"	Date 8-16-00
Nap. Condo for Dick Denny	
Location : 1155 Chelsea Ave., Napoleon	

ELECTRICAL PLAN

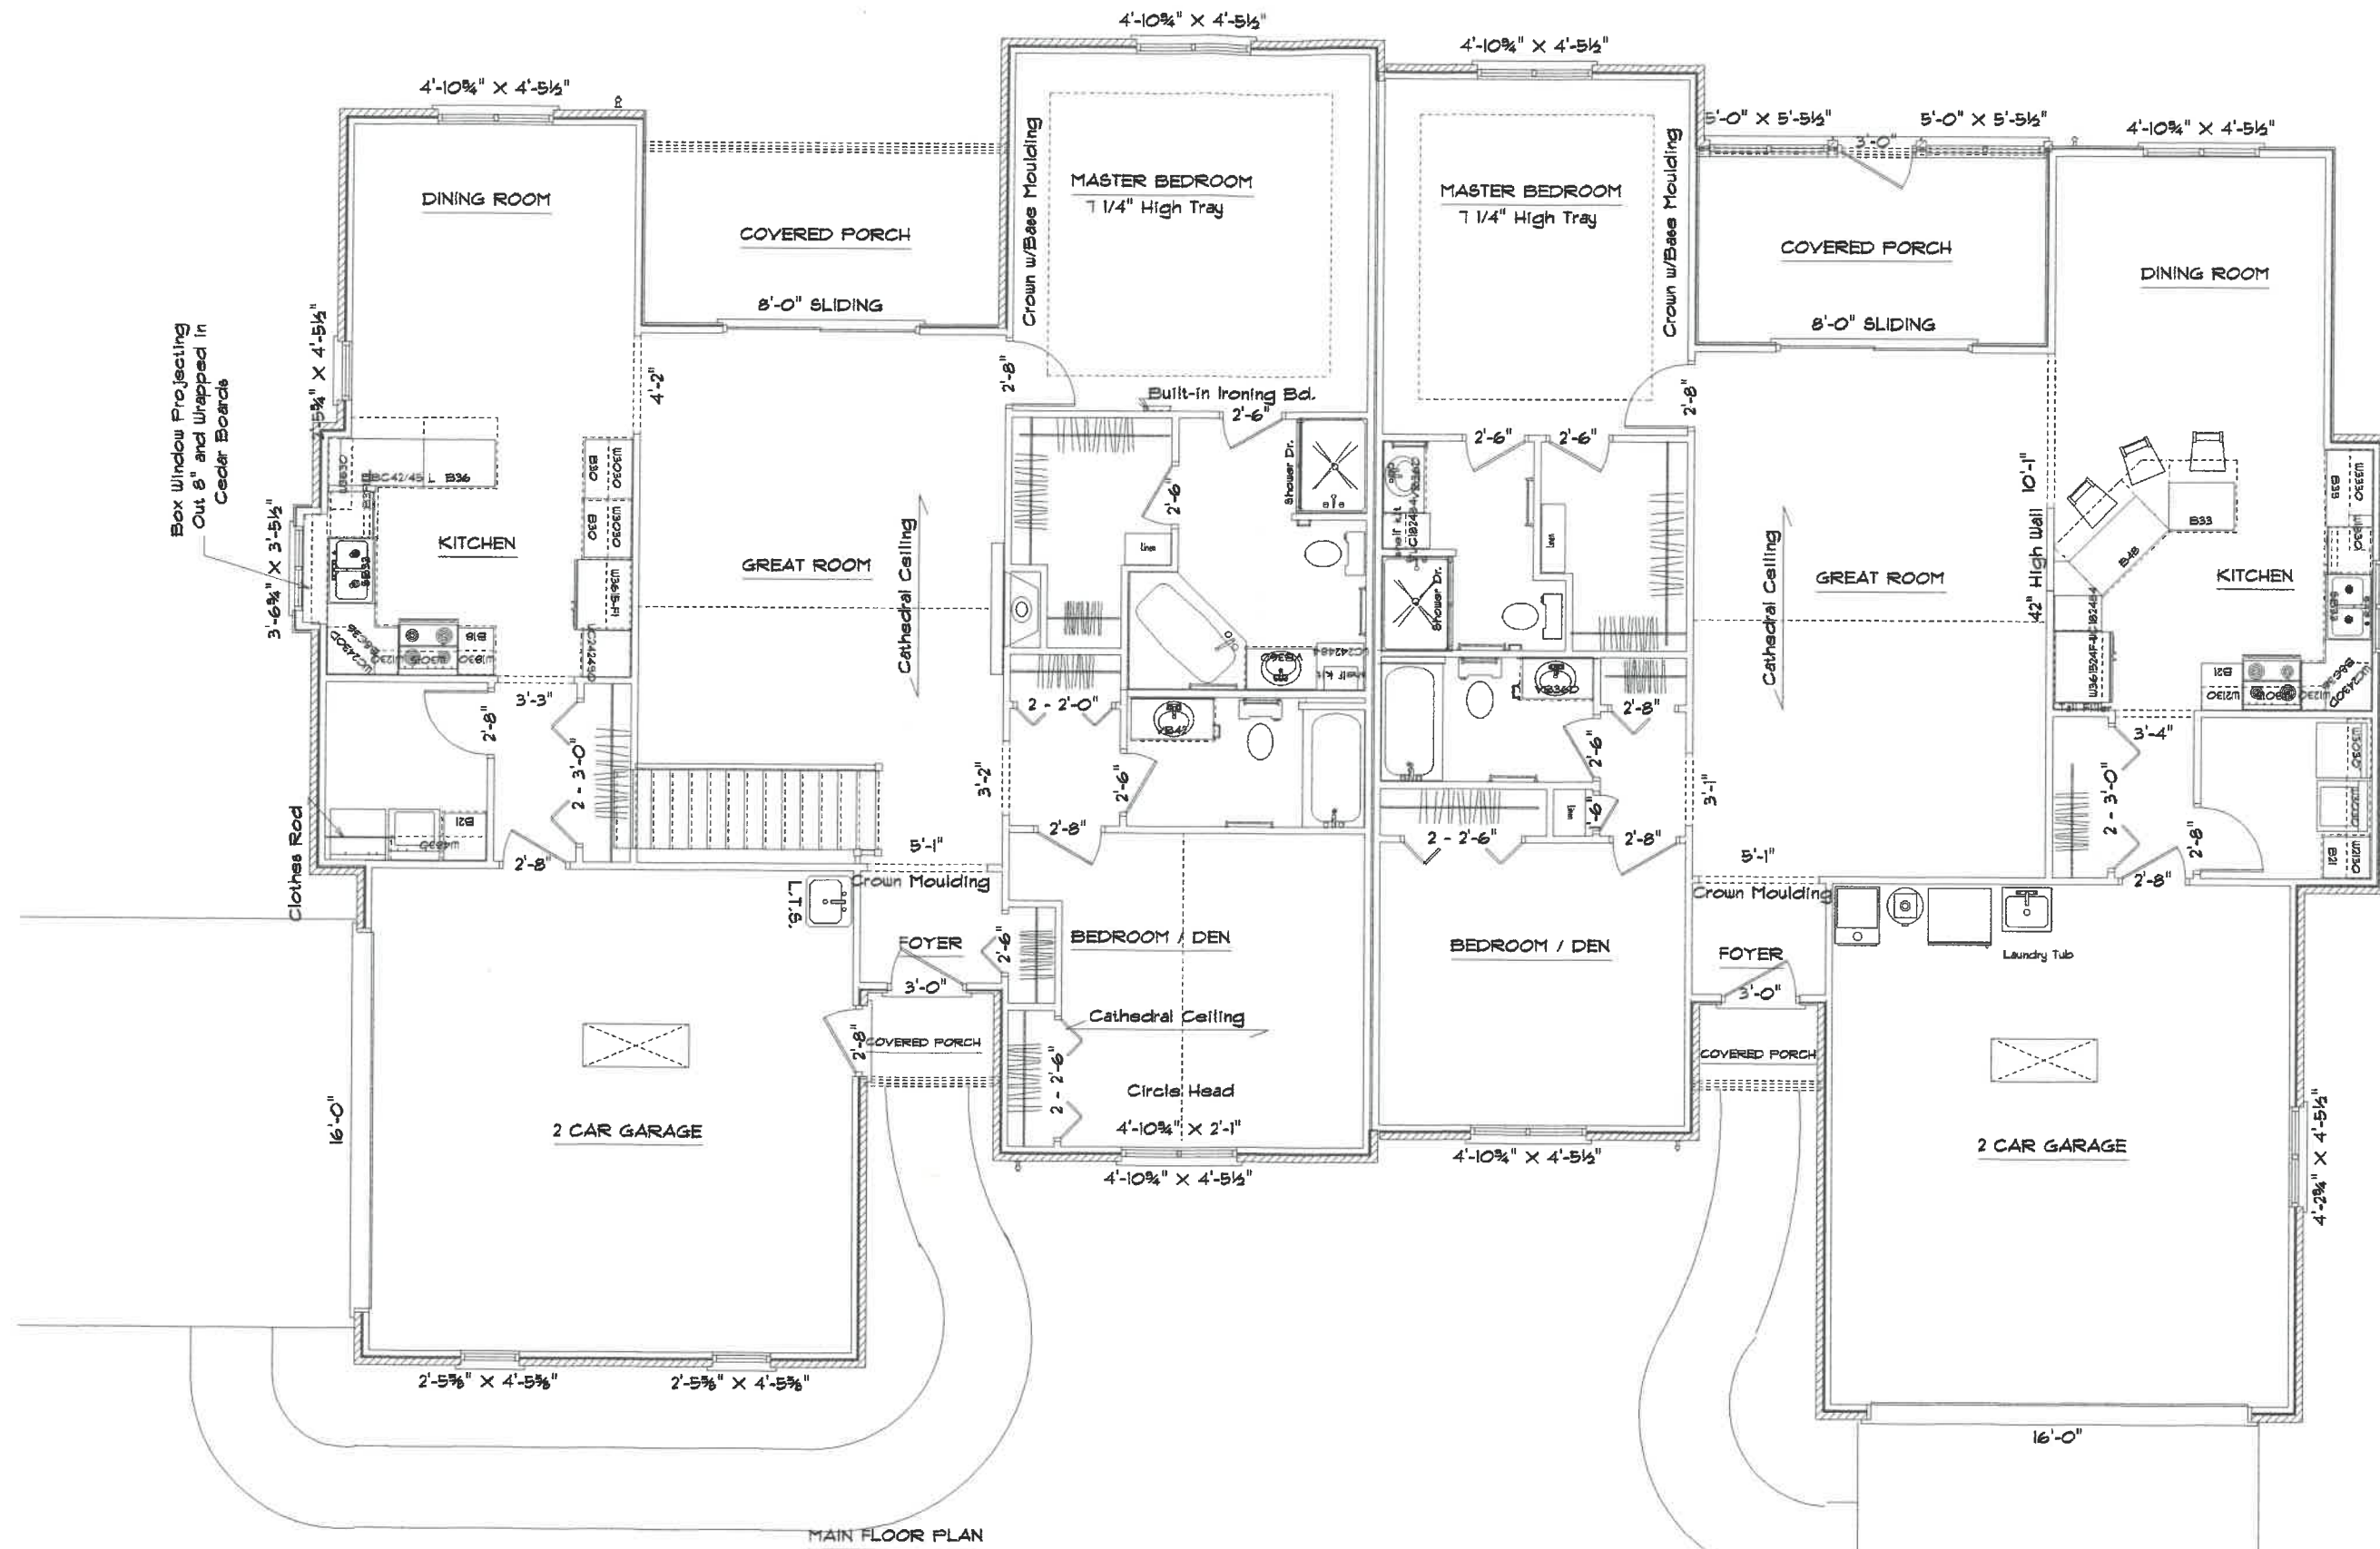

MAIN FLOOR PLAN

**Kahle Design & Build**  
 Phone 782-1186 Defiance, Oh  
 1-21-00 Date Scale: 3/16"=1'-0"  
 Nap. Condo for J. Hoeffel  
 Location :1145 Chelsea Ave., Napoleon

Square Footage : House 1580  
 Garage 455  
 Bk. Porch 114  
 Frt. Porch 24

Square Footage : House 1422  
 Garage 465  
 Bk. Porch 122  
 Frt. Porch 20

**Kahle Design & Build**  
 Defiance, Oh Phone 782-1186  
 Scale: 3/16"=1'-0" Date 8-16-00  
 Nap. Condo for Dick Denny  
 Location :1155 Chelsea Ave., Napoleon



CHELSEA AVENUE

25.00'

12.5'

25.00'

323.4291'

116.00'

225.00'

100.51'

16' Gazebo

25.00'

12.5'

25.00'

88.6645'

64.6154'

23'-0"

Gas

TV  
Data  
Electrical

