



Cedar Siding

FRONT ELEVATION



Vinyl Siding

AC Unit

Projection Around Window

Cedar Boards

REAR ELEVATION

Note:
This drawing and its reproductions are the properties of Kahle Design & Build Ltd.
And may not be reproduced, published or used in any way without written permission
from Kahle Design & Build Ltd.. Building dimensions may vary from prints. In the interest
of continuing product improvement, Kahle Design & Build reserves the right to alter plans,
specifications, materials, and details without prior notice. All notes, plans
and illustrations are subject to change without notice. All notes, plans
and illustrations are approximate. Plans are drawn by Dave Kahle.

Kahle Design & Build


For : Mr. & Mrs. Ron Boestelman
Location : 1158 Chelsea Ave., Nap.
Scale: Var. 1/8" = 1'-0" Defiance, Oh
Date 2-14-06
Phone 497-4805

KDB

1158 Chelsea



RIGHT ELEVATION

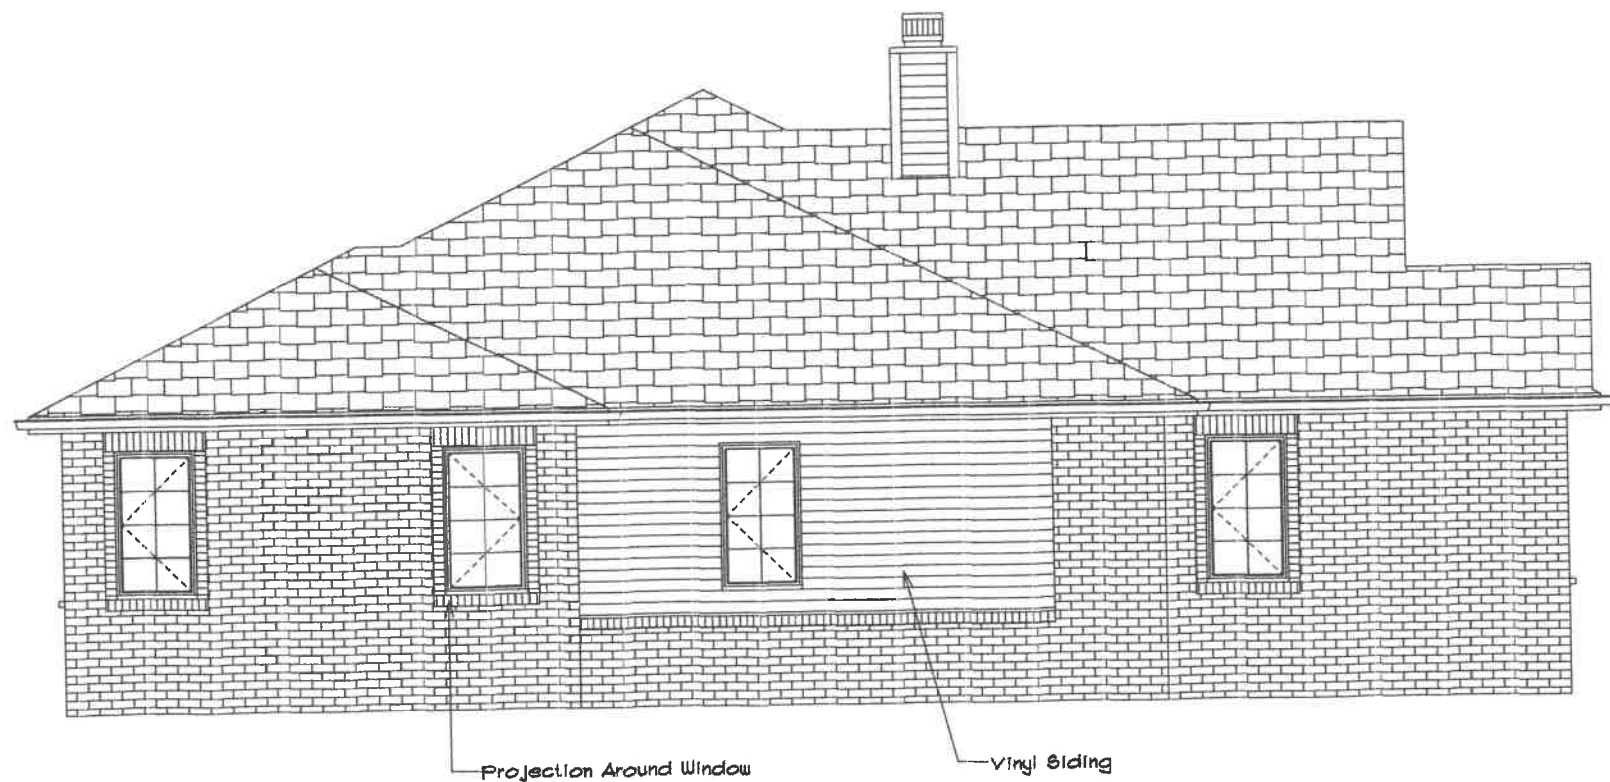


LEFT ELEVATION

Note:
This drawing and its reproductions are the property of Kahle Design & Build, Ltd. And may not be reproduced, published, or otherwise used without written permission from Kahle Design & Build, Ltd. Building elevations may vary from prints. In the interest of protecting product improvement Kahle Design & Build reserves the right to alter plans, specifications, materials, design, appliance features etc. without prior notice. All maps, plans and illustrations are artistic or craftman conceptions and are not necessarily to scale. Square footage are approximate. Plans are drawn by Dave Kahle.

Kahle Design & Build

For :	Mr. & Mrs. Ron Bostelman
Location :	1158 Chelsea Ave., Nap.
Scale:	Var-10"
Date	3-8-06
Phone	497-4805
	Defiance, Oh



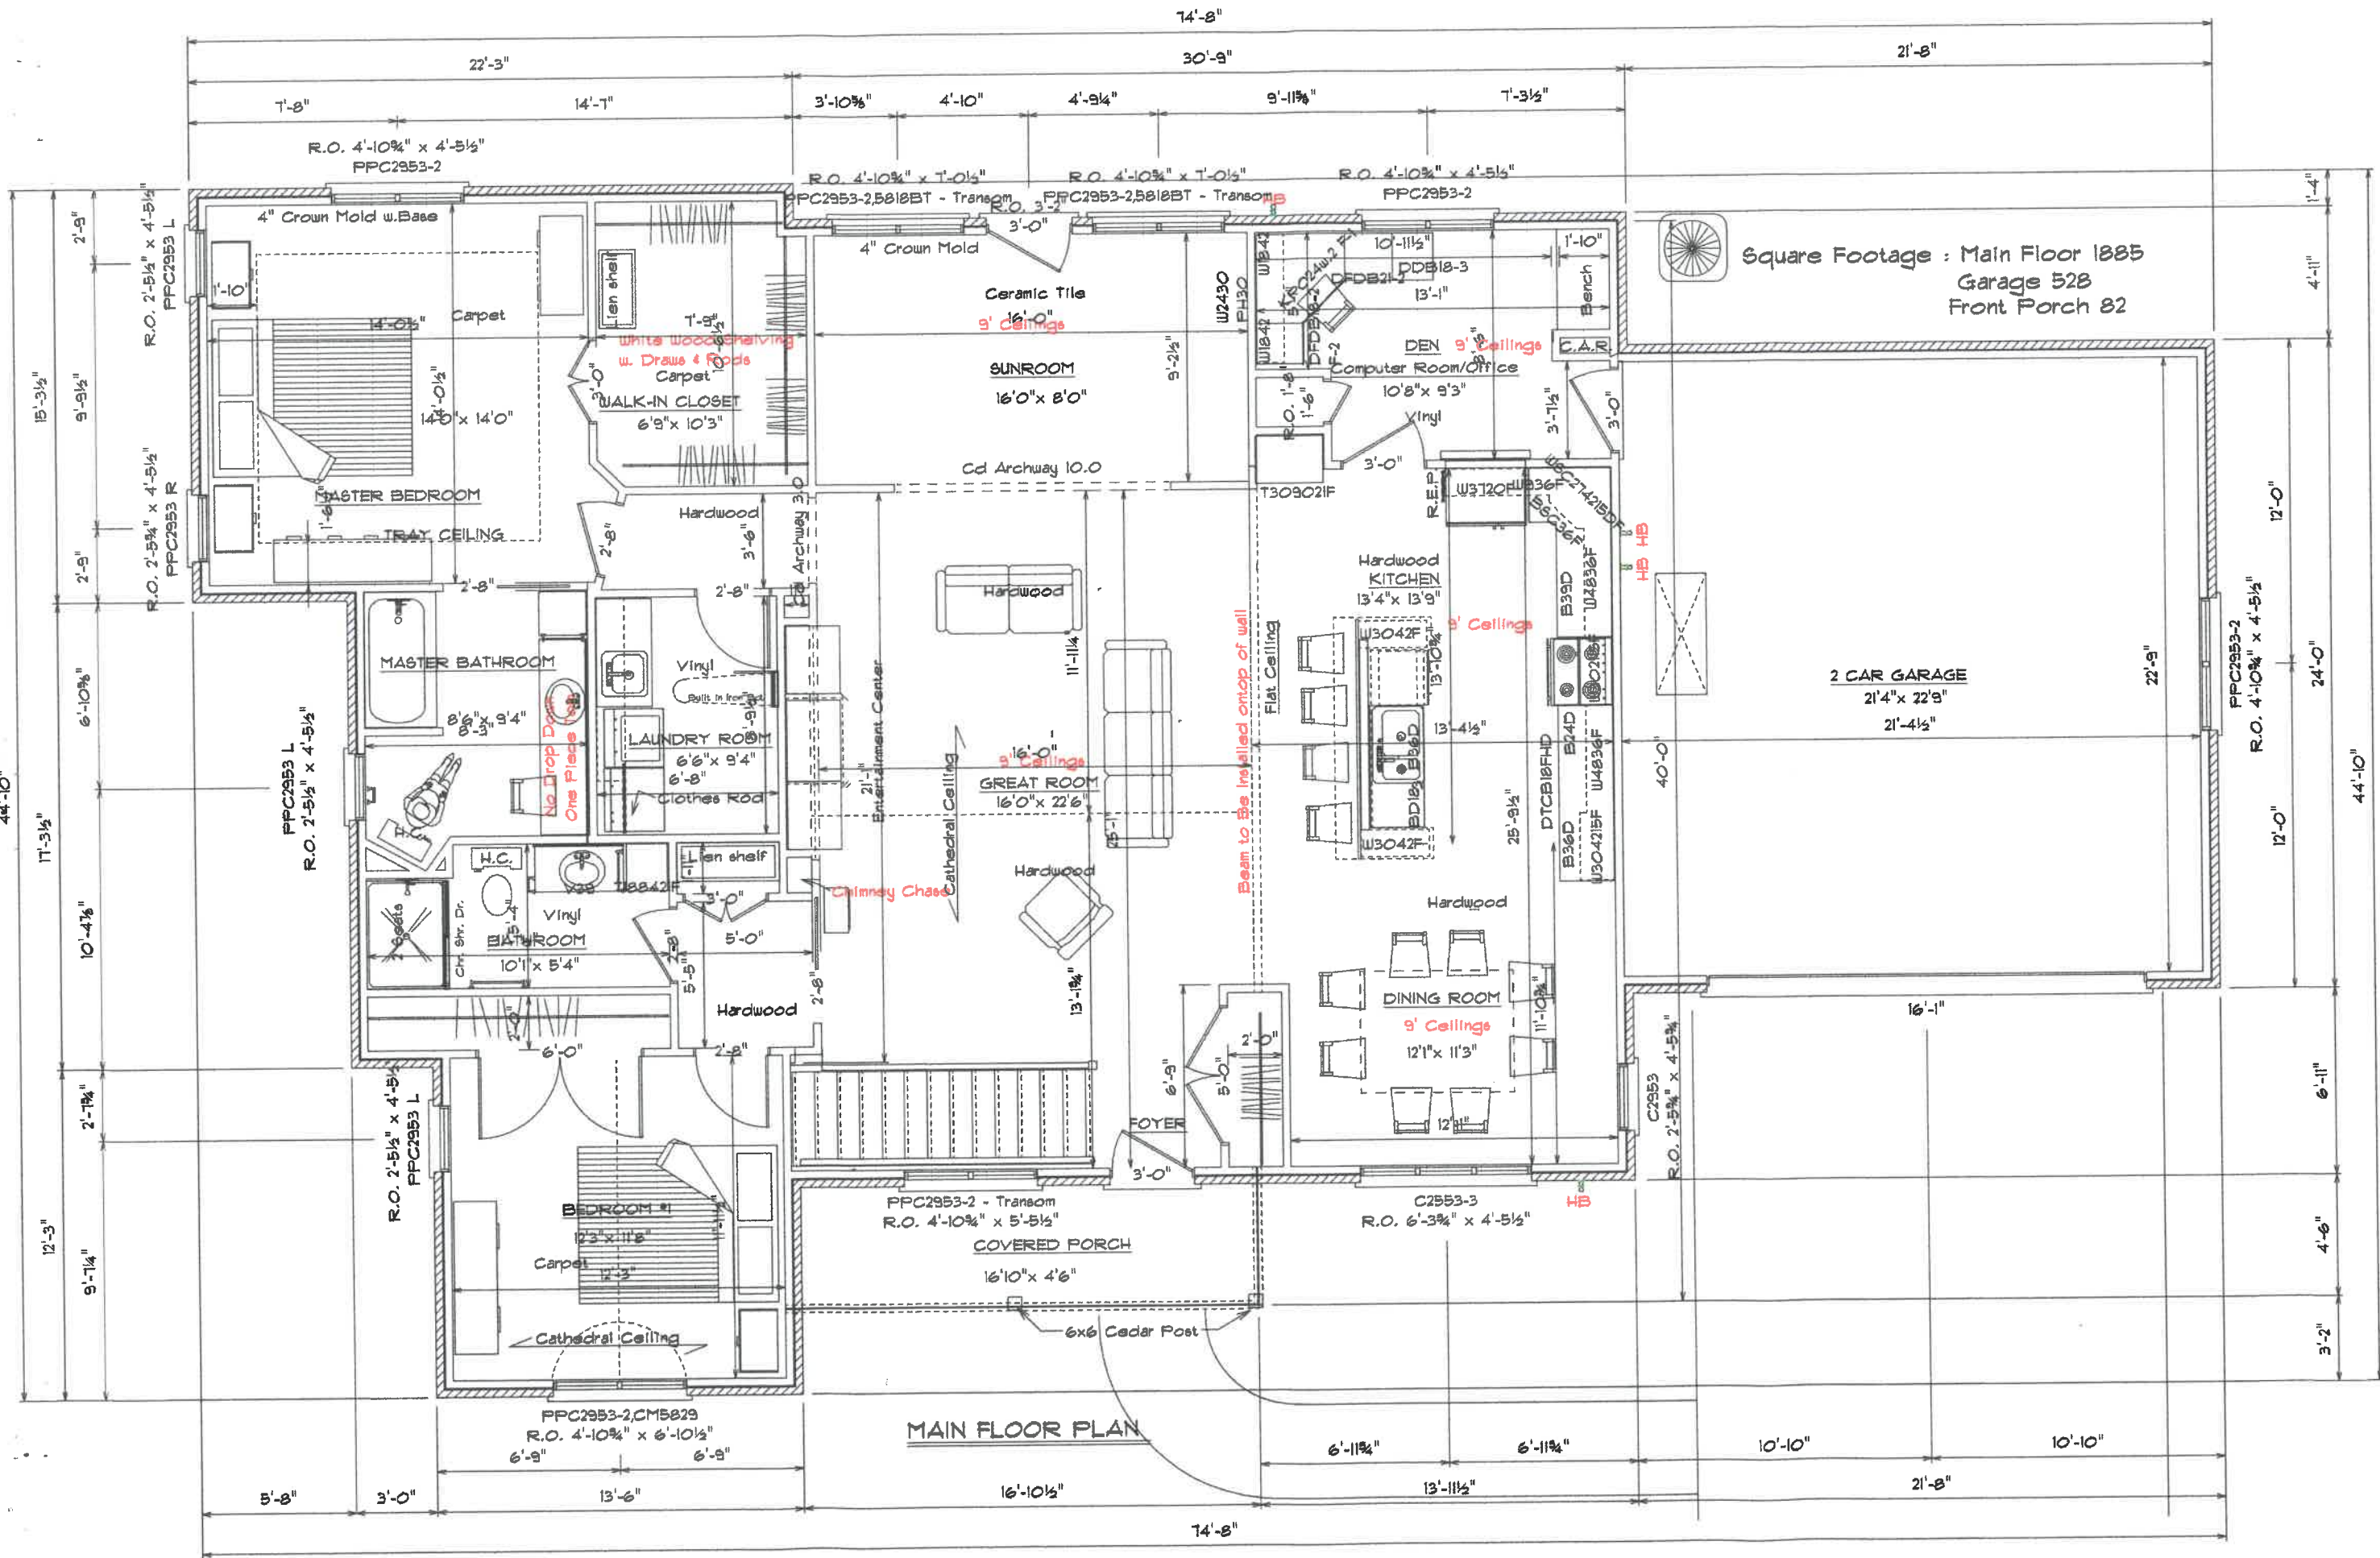


Note: All drawings and reproductions are the property of Kahle Design & Build Ltd. All rights reserved. No part of this drawing may be reproduced, stored in a retrieval system, or transmitted in any form or by any means, electronic, mechanical, photocopying, recording, or by any information storage and retrieval system, without the prior written permission of Kahle Design & Build Ltd. Building dimensions may vary from prints. In the interest of continuing product improvement, Kahle Design & Build reserves the right to alter plans, specifications, materials, design, appliance features etc. without prior notice. All plans, plans and illustrations are artistic or approximate and are not necessarily to scale. Square footages are approximate. Plans are drawn by Dave Rife.

Kahle Design & Build

For: Mr. & Mrs. Ron Bostelman
 Location: 1158 Chelsea Ave., Nap.
 Scale: Var. 1/8" = 1'-0" Defiance, Oh
 Date: 3-8-06
 Phone: 419-480-0505



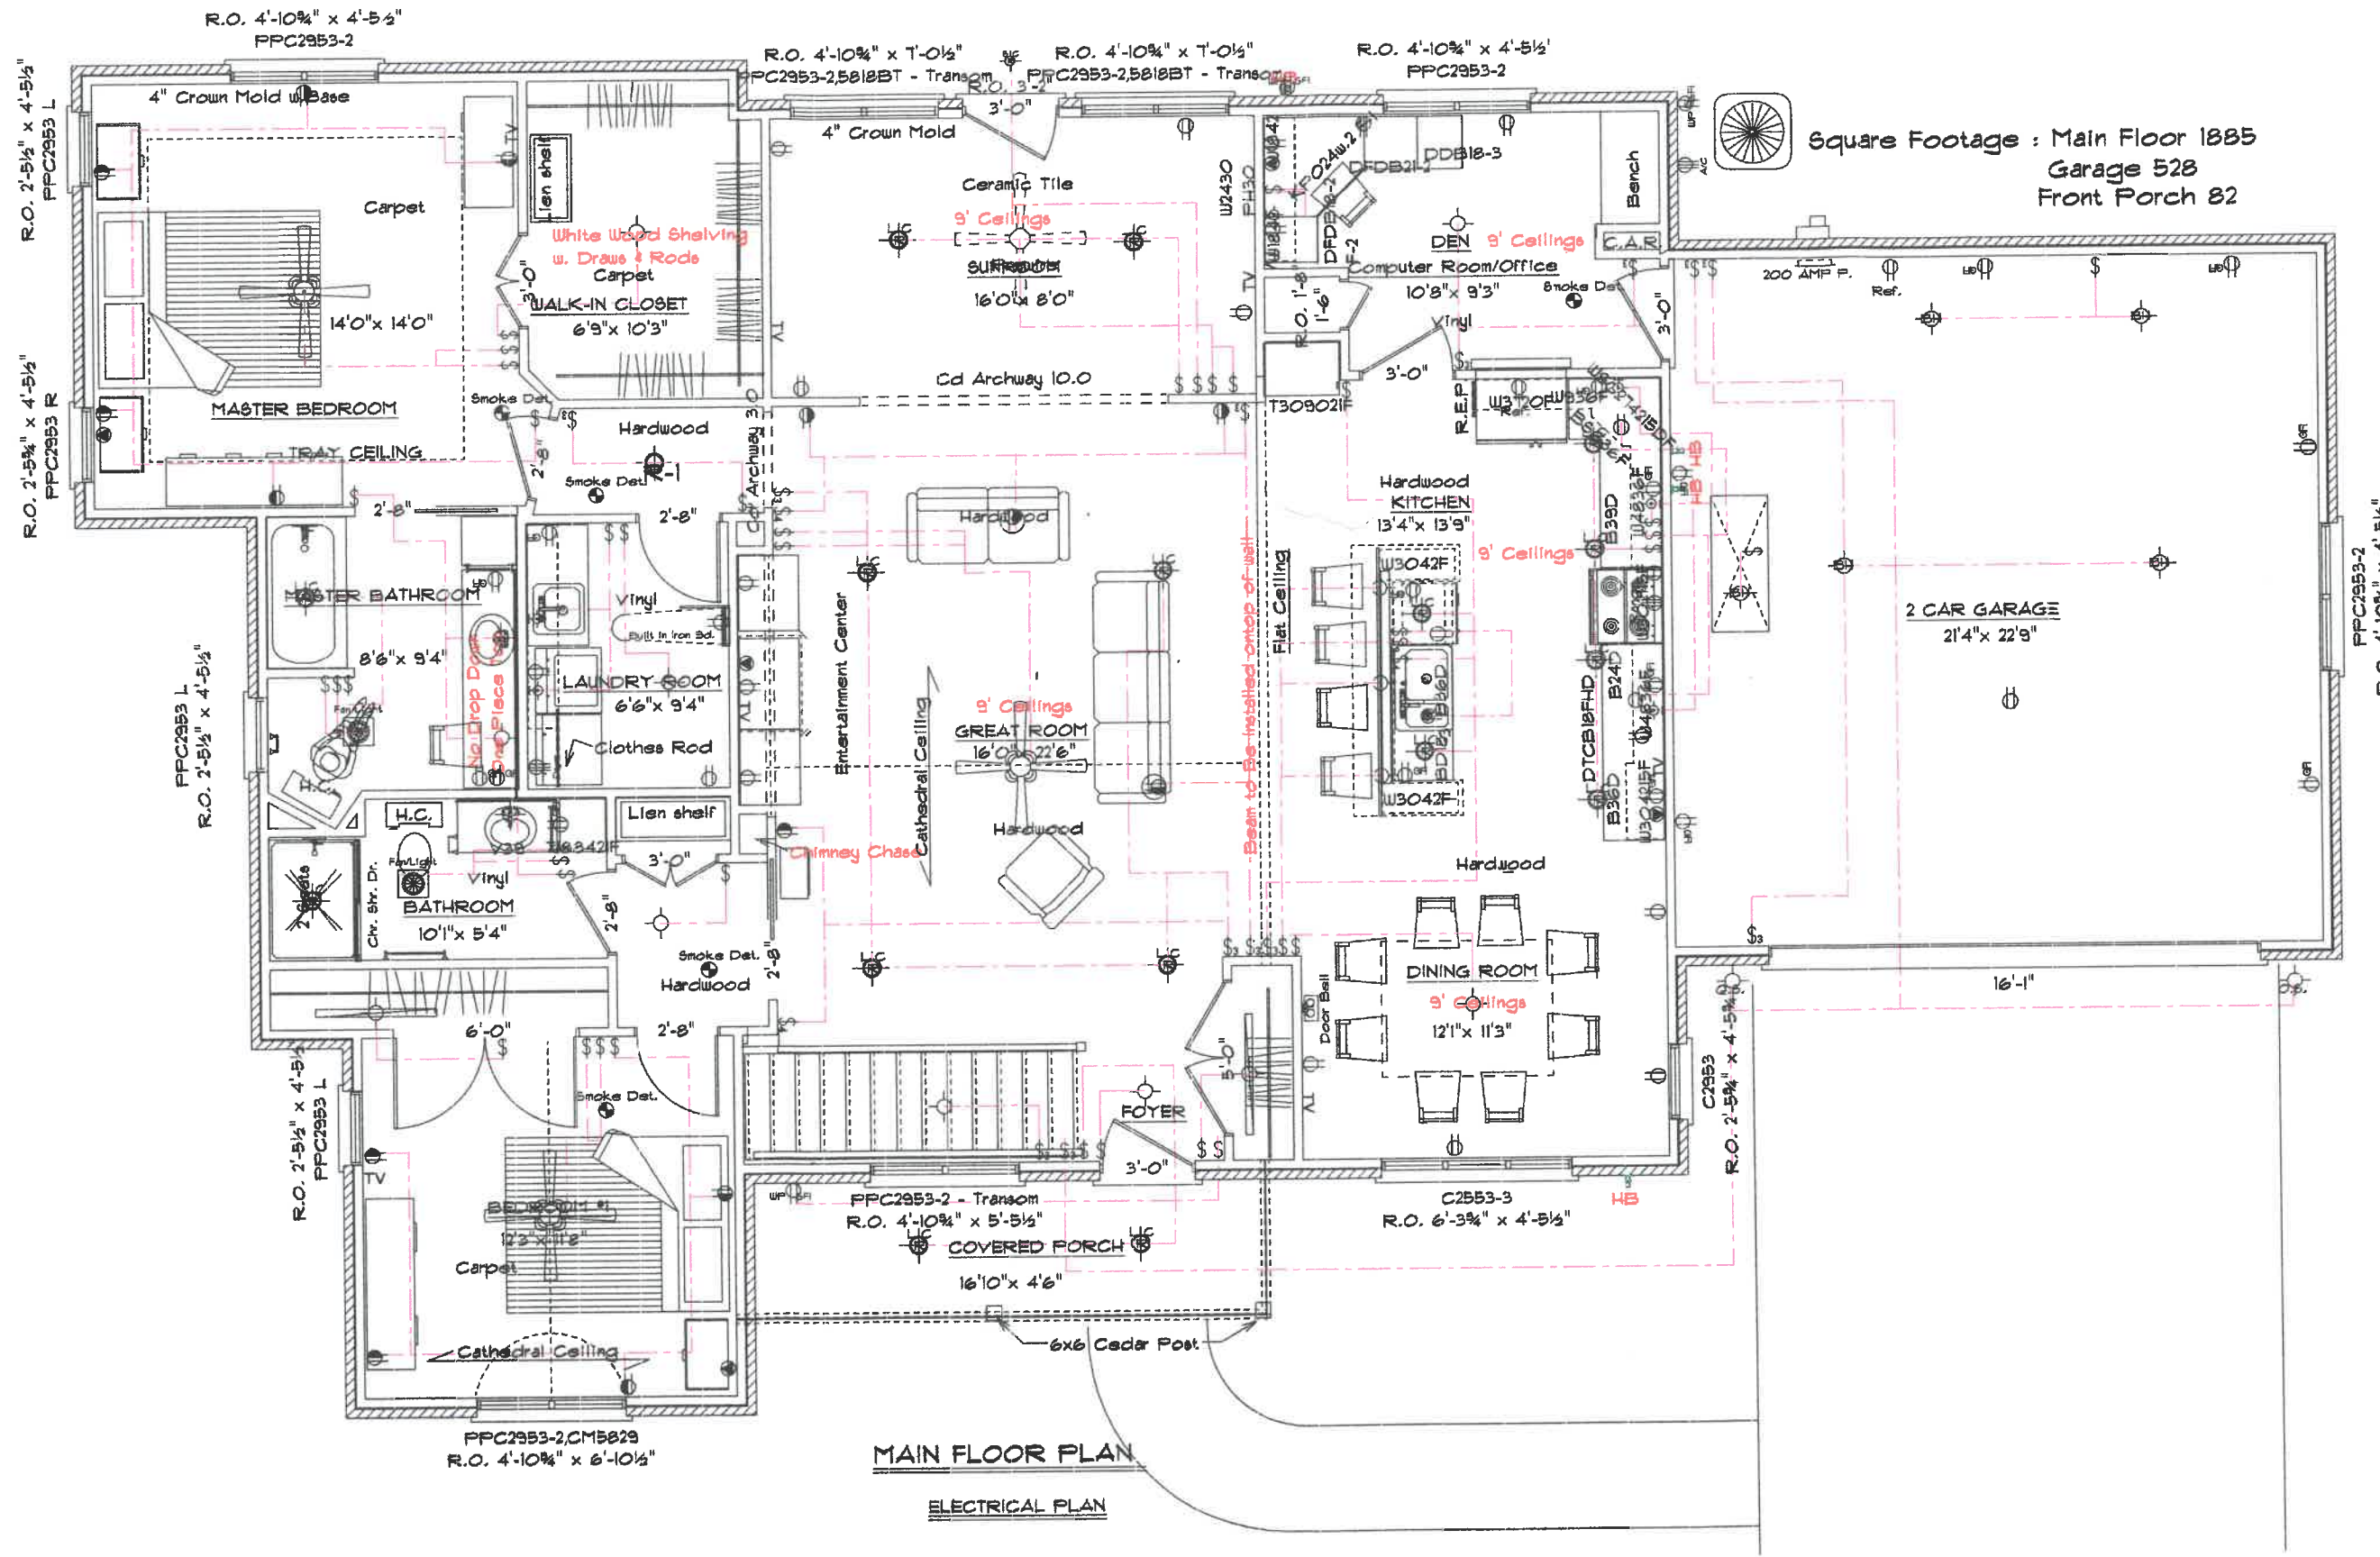

Square Footage : Main Floor 1885
Garage 528
Front Porch 82

MAIN FLOOR PLAN
ELECTRICAL PLAN

Note: This drawing and its reproductions are the properties of Kahle Design & Build Ltd. And may not be reproduced, published or used in any way without written permission from Kahle Design & Build Ltd. Building dimensions may vary from prints. In the interest of containing product, Kahle Design & Build reserves the right to alter plans, specifications, materials, and details of construction and are not necessary to scale. Square Footage are approximate. Plans are drawn by Dave Kahle.

Kahle Design & Build

For : Mr. & Mrs. Ron Boetelmaier
Location : 1155 Chelsea Ave., Nap.
Scale: Var. 1/0"



Date 3-8-06
Phone 491-4805
Defiance, Oh




PLOT PLAN

311.42'

Chelsea Condominium Phase II

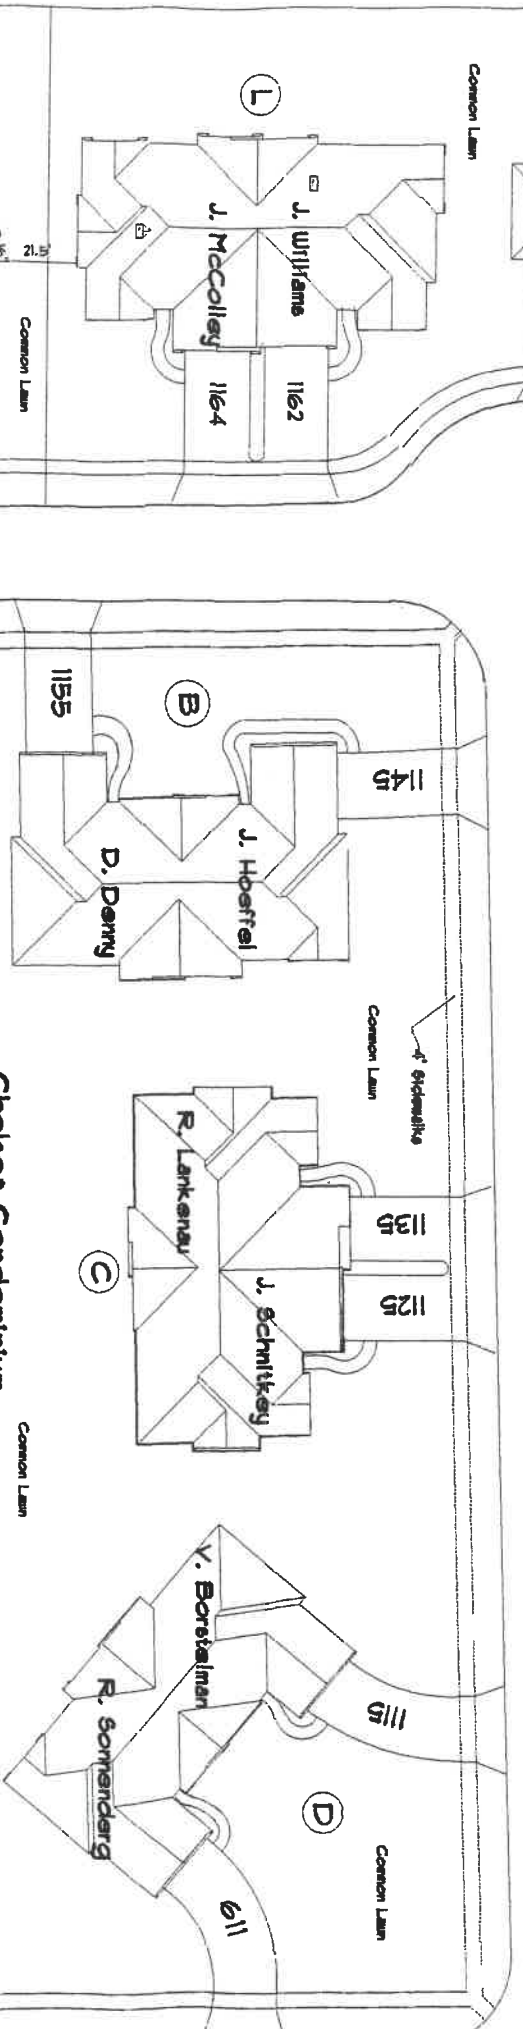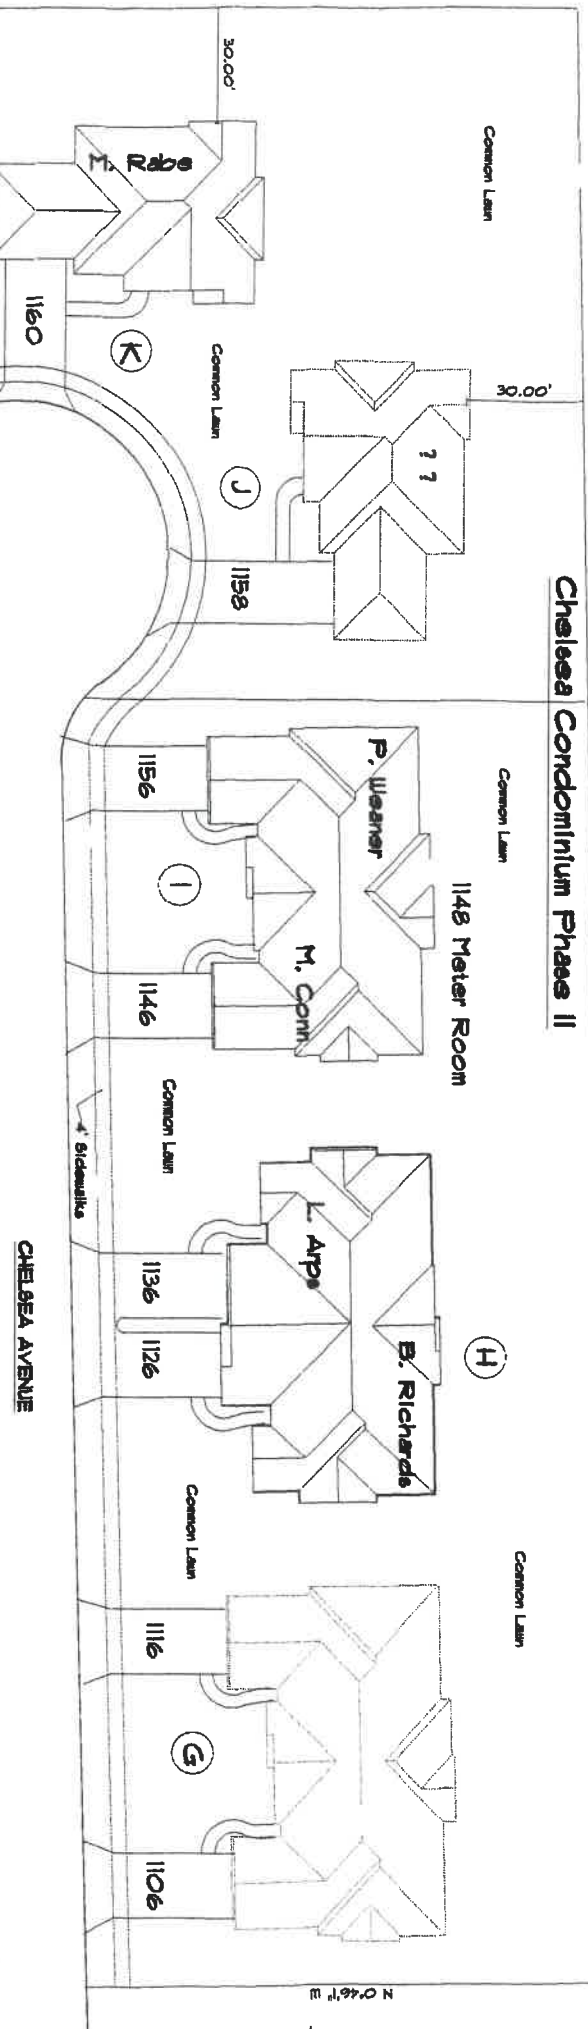

Chelsea Condominium Phase #1

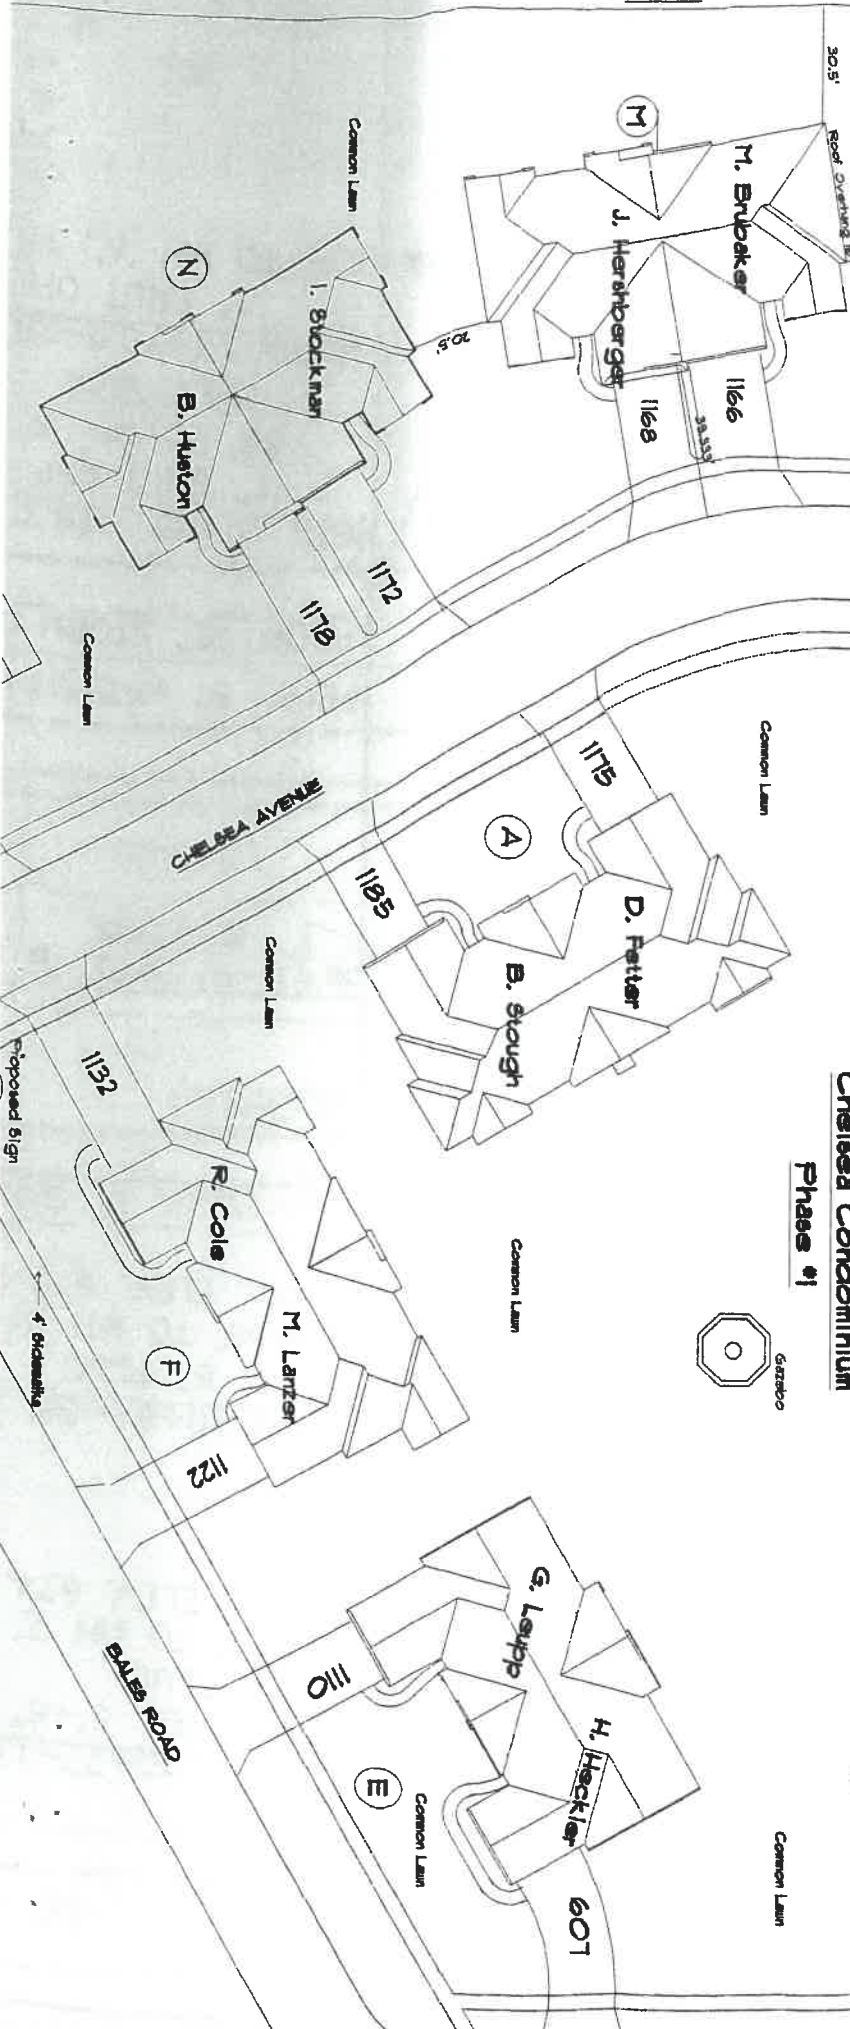

Chelsea Condomi

Common Lawn

Common L

30.00'

??

P. Weans

24'

42'

0.00'

1" Hdcts
water line

Common Lawn

comb
stop

1158

6" sdn 35 sanitary top
7' deep

M. Rabe

1156

J

K

