




FRONT ELEVATION

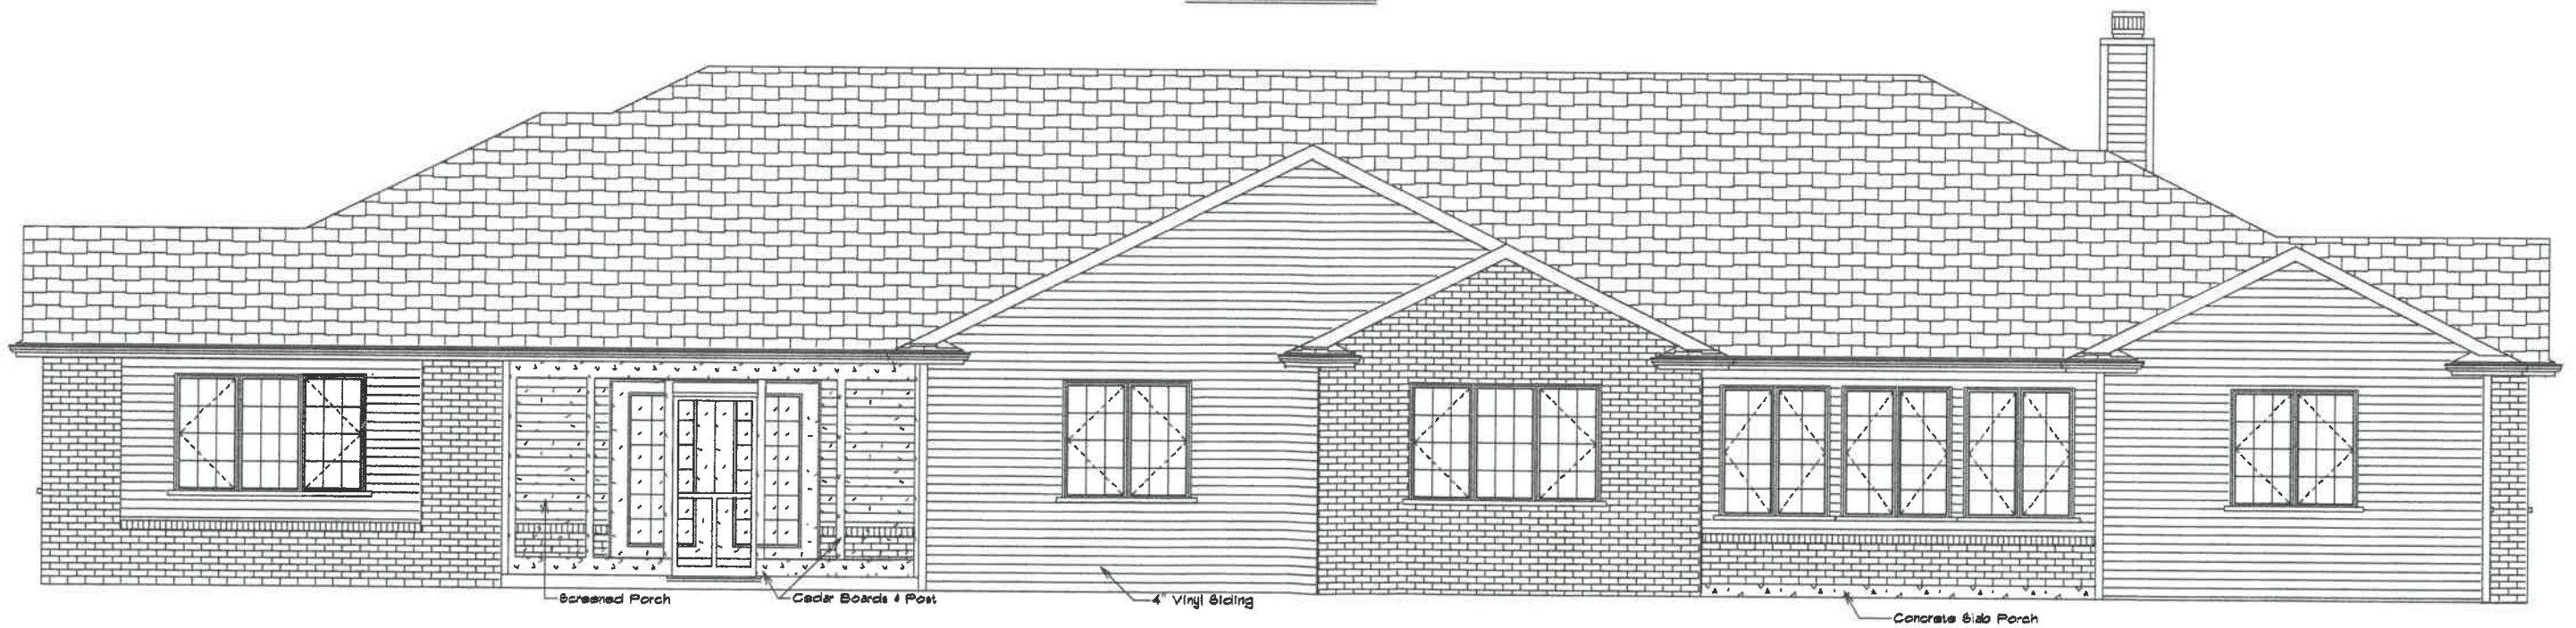


REAR ELEVATION


1164 Chelsea Ave.

Kahle Design & Build	
Defiance, Oh	Phone 497-4805
Scale: Var. 1/8"	Date 9-15-03
Mr. & Mrs. Jim McCollie	
Location: Chelsea Ave., Napoleon	


sewer calc.  
9242 sq. ft. lot area

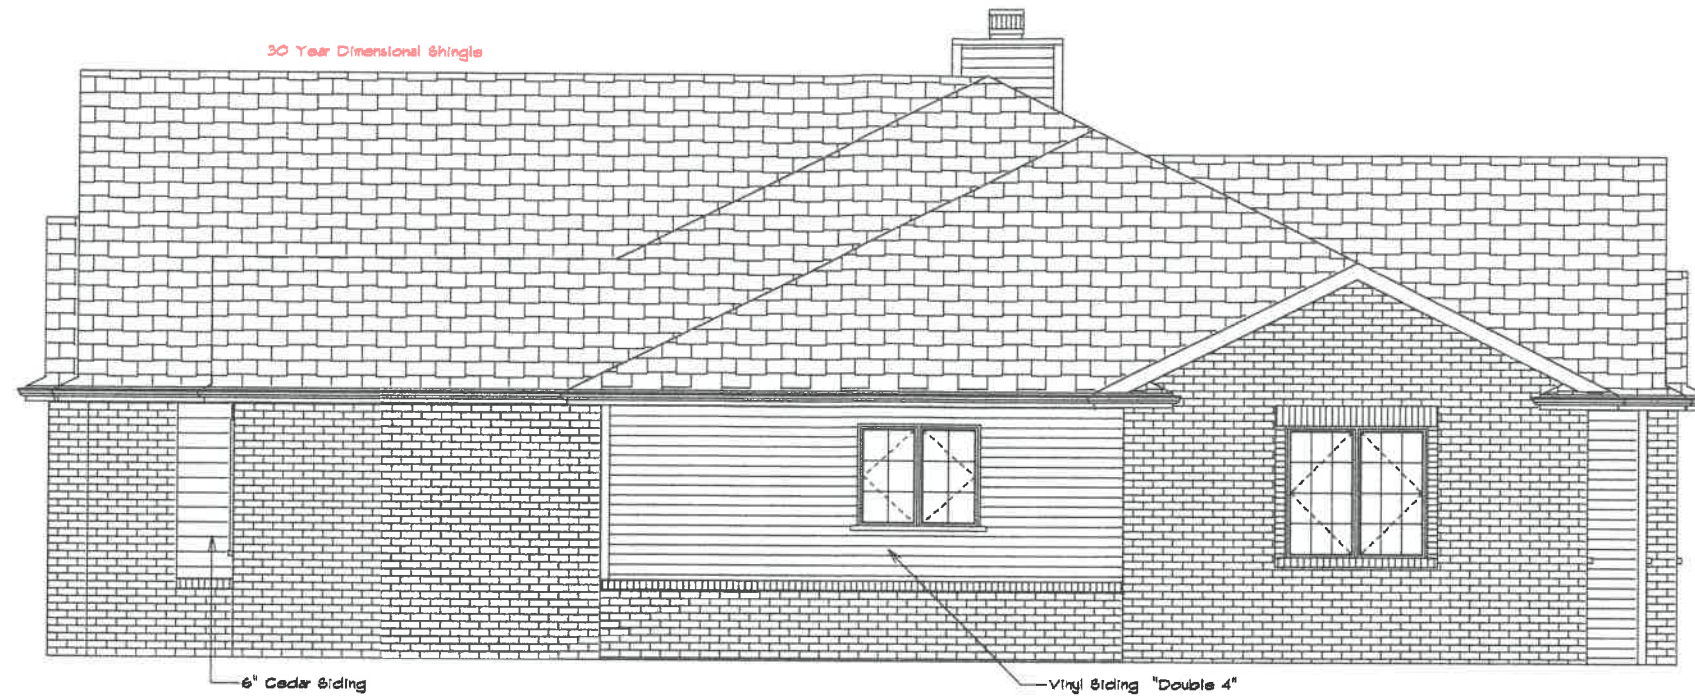

RIGHT ELEVATION

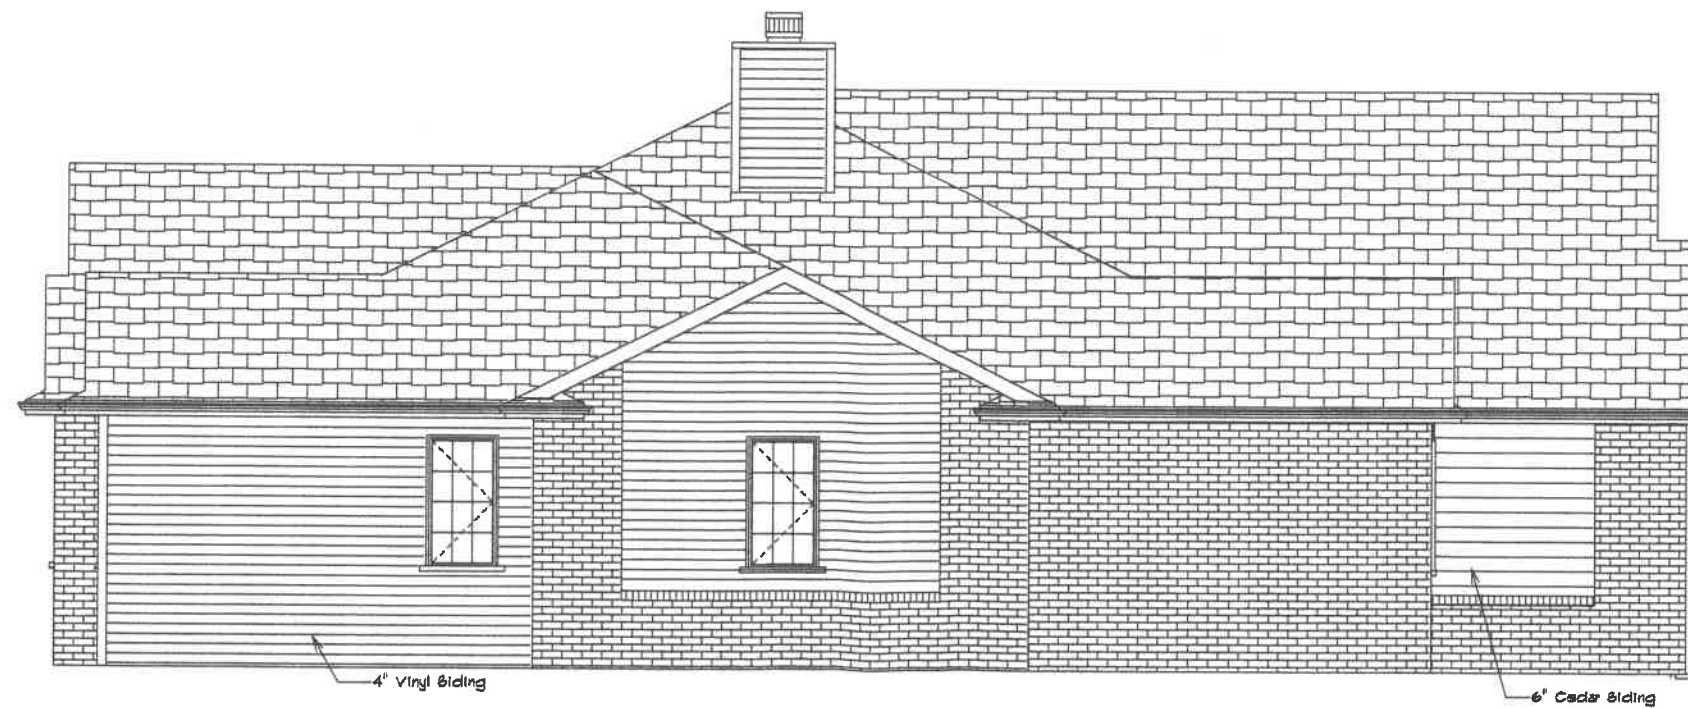

LEFT ELEVATION

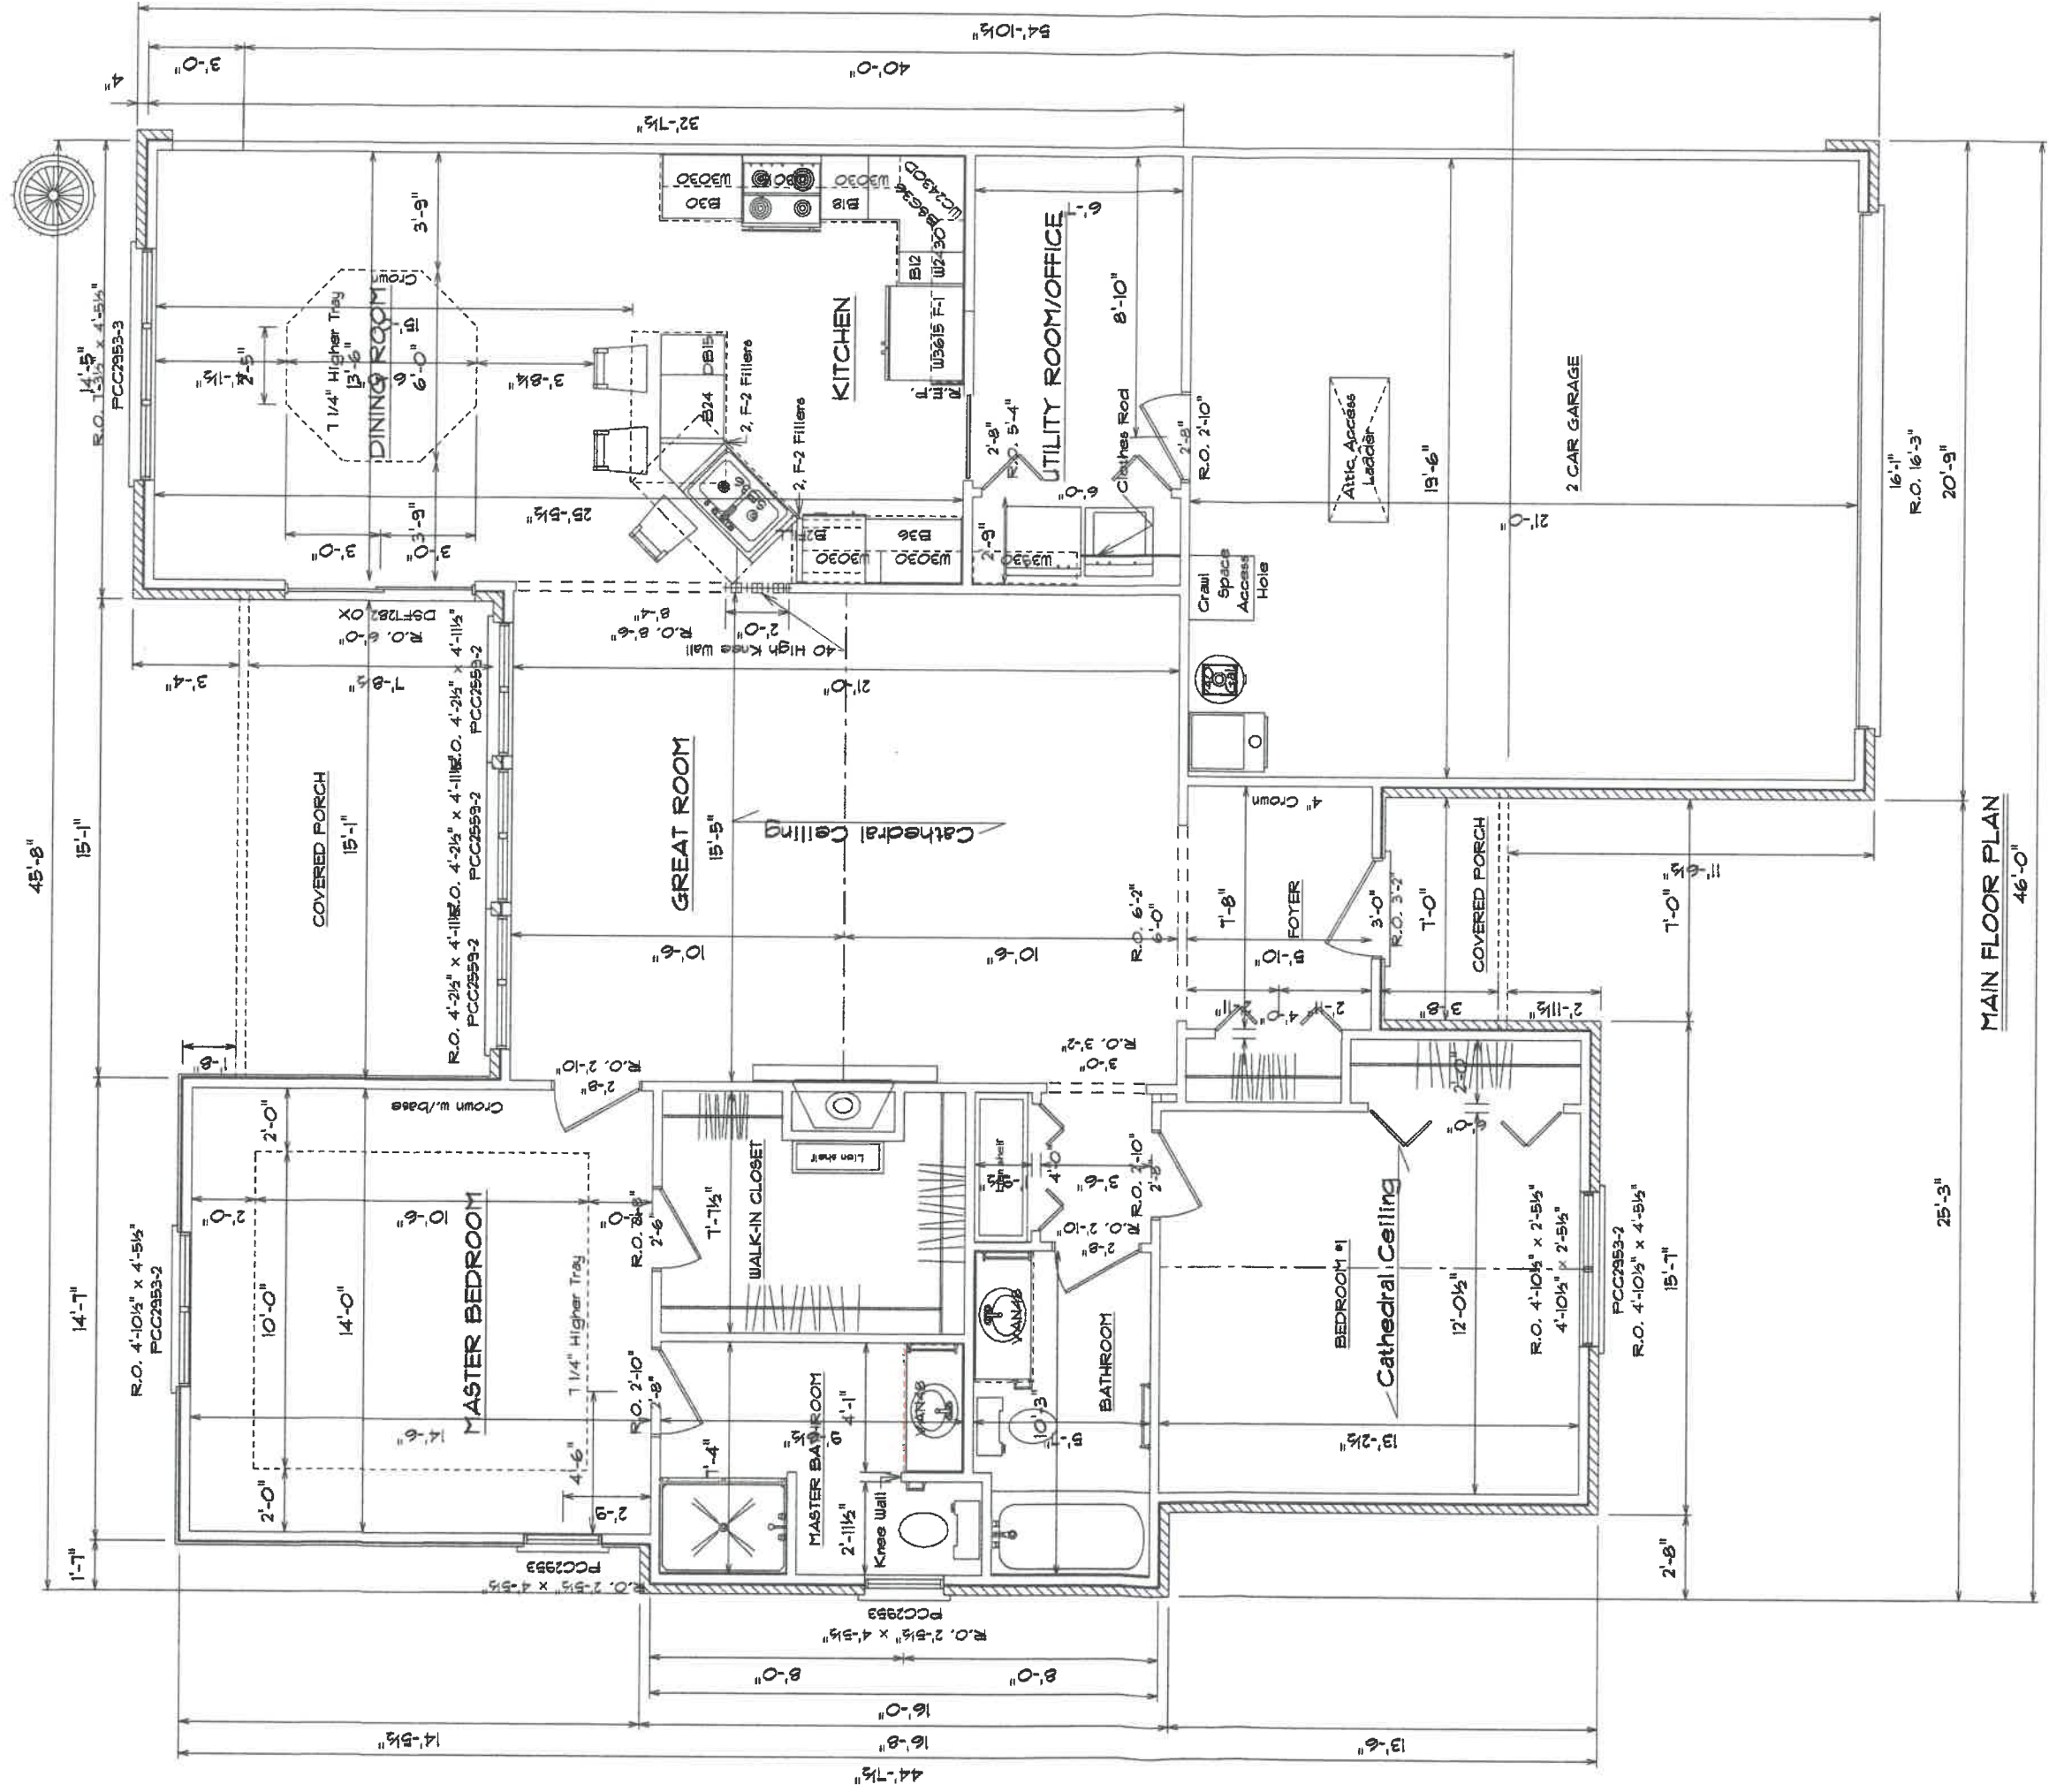


MAIN FLOOR PLAN  
46'-0"

Square Footage : Main Floor 1541  
 Garage 928  
 Front Porch 28  
 Rear Porch 120


November 01, 2003

<b>Kahle Design &amp; Build</b>	
Defiance, Oh	Phone 437-4805
Scale: Var. 1/8" = 1'-0"	Date 9-15-03
Mr. & Ms. Jim McColley	
Location : Chelsea Ave., Napoleon	

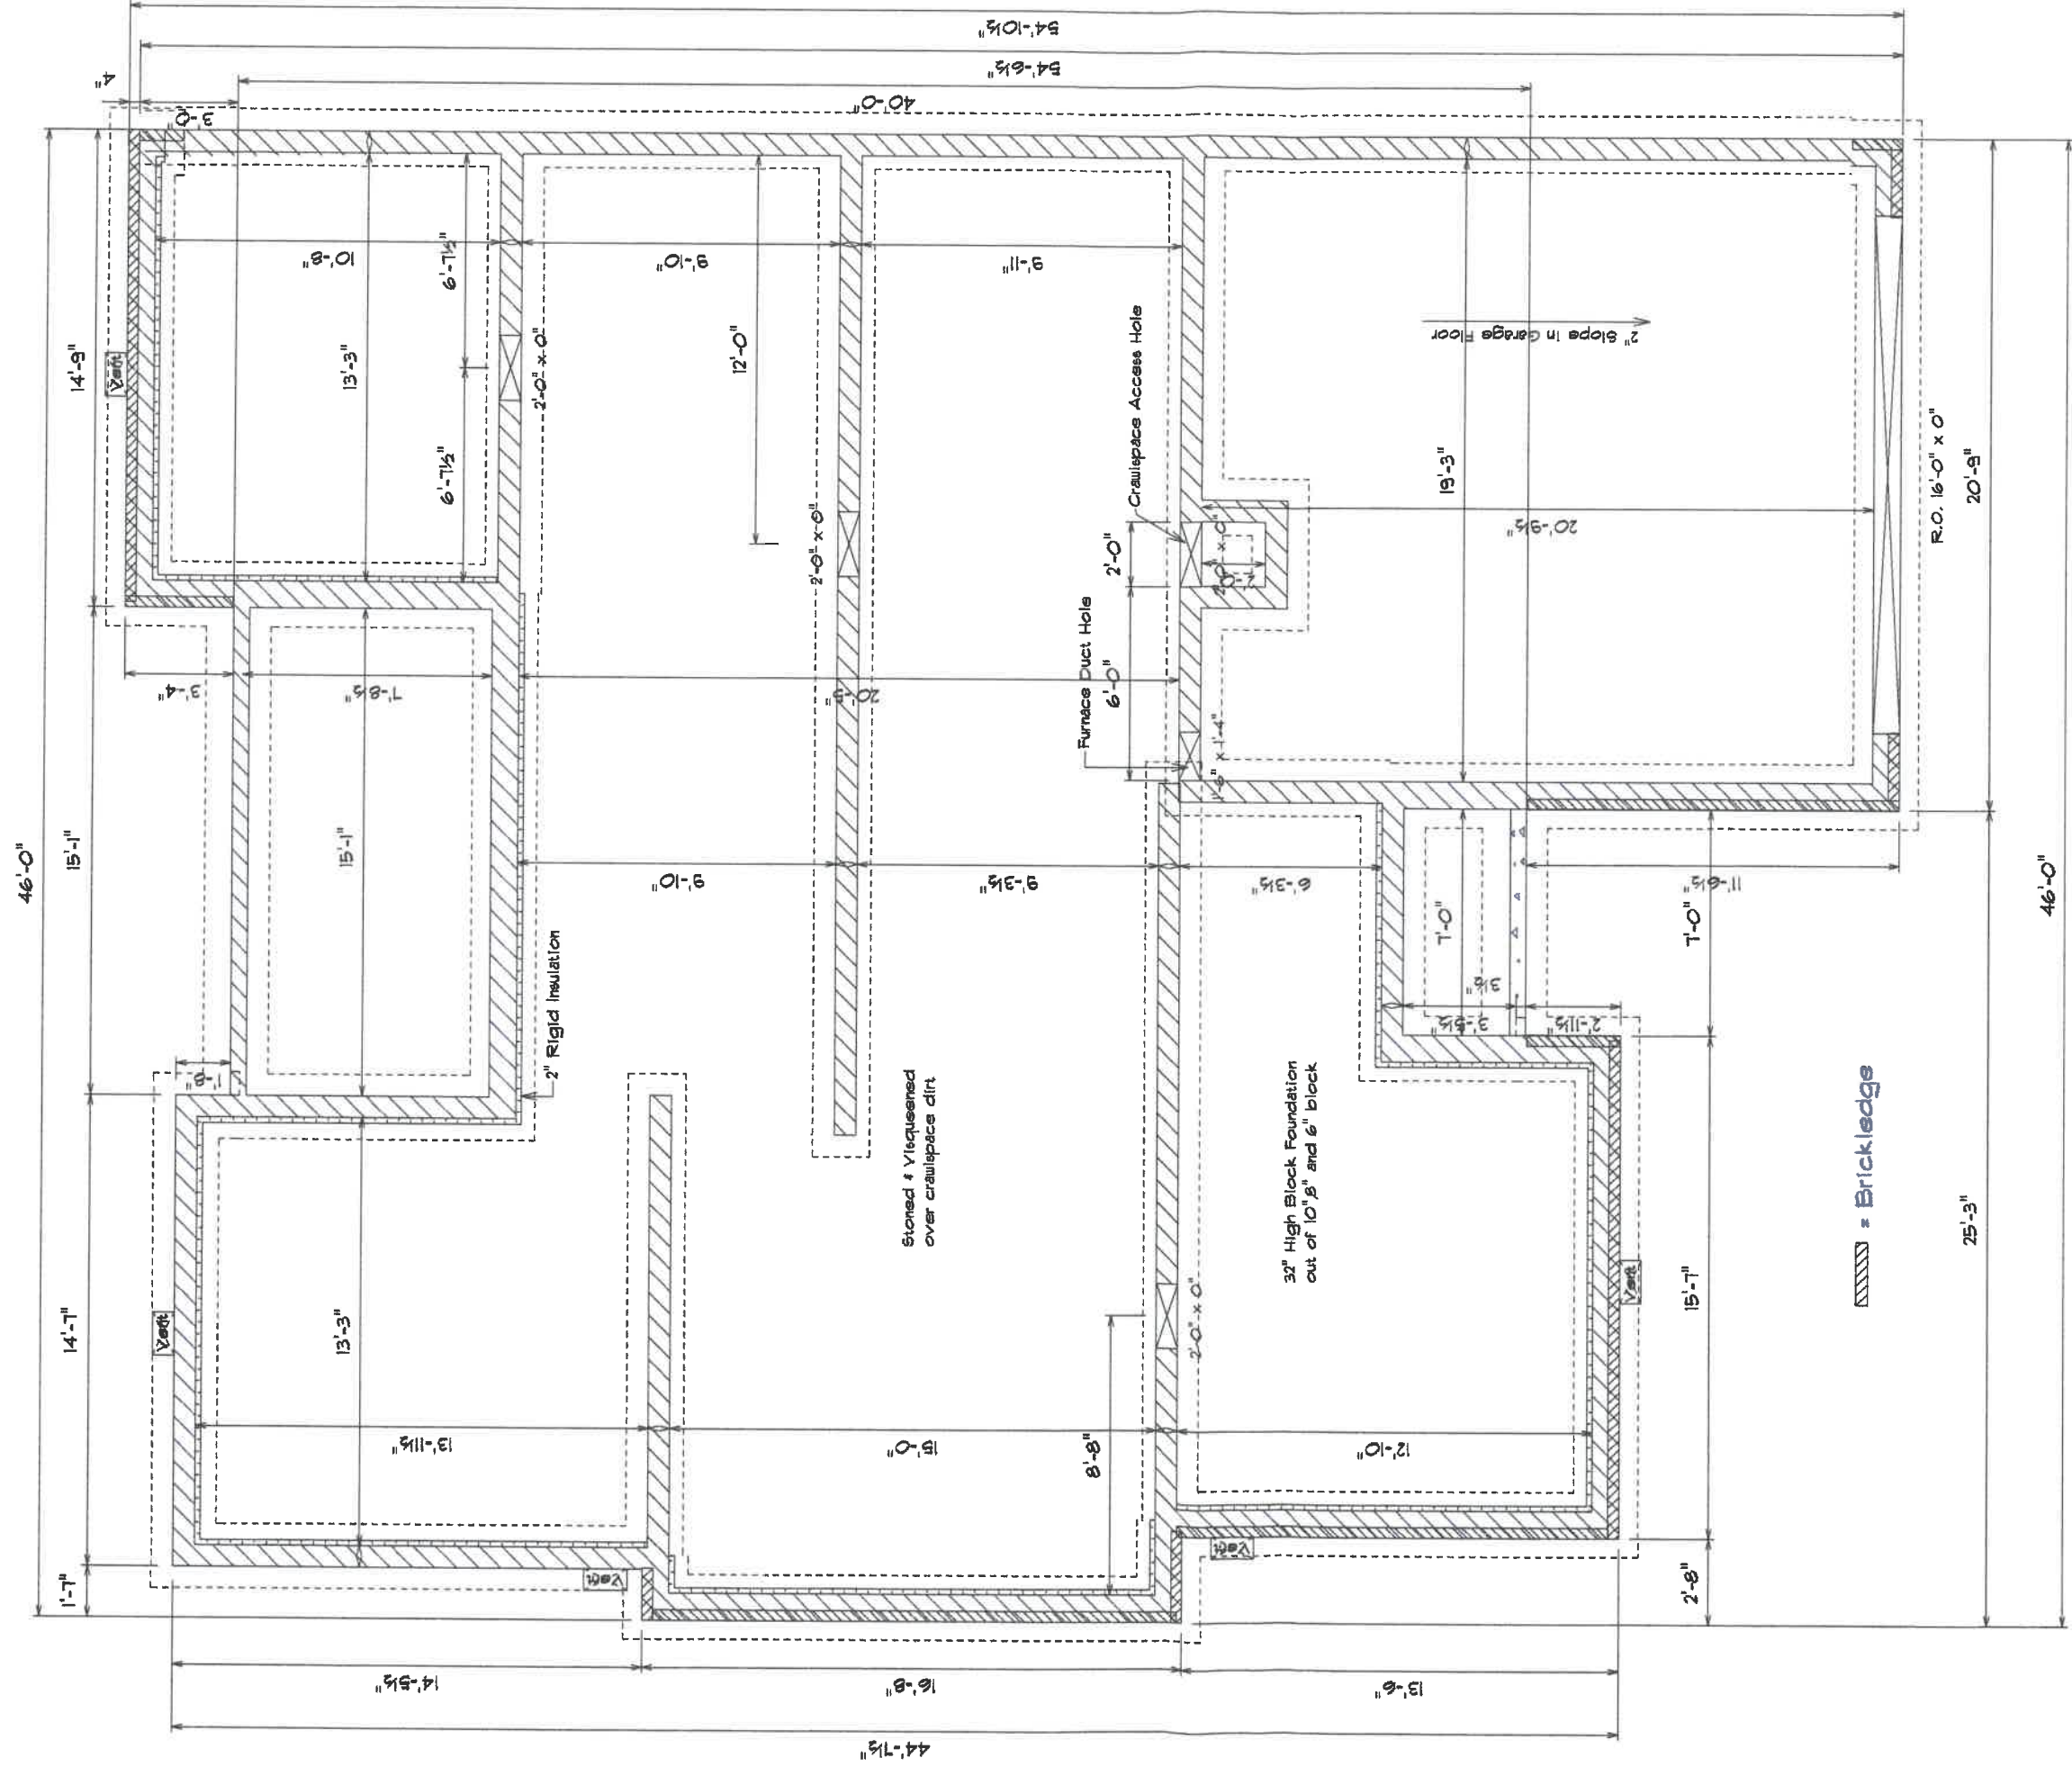


FOUNDATION PLAN

<b>Kahle Design &amp; Build</b>	
Defiance, Oh	Phone 419-4805
Scale: Var. 1/8"	Date 9-15-03
Mr. & Mrs. Jim McColley	
Location: Chelsea Ave., Napoleon	

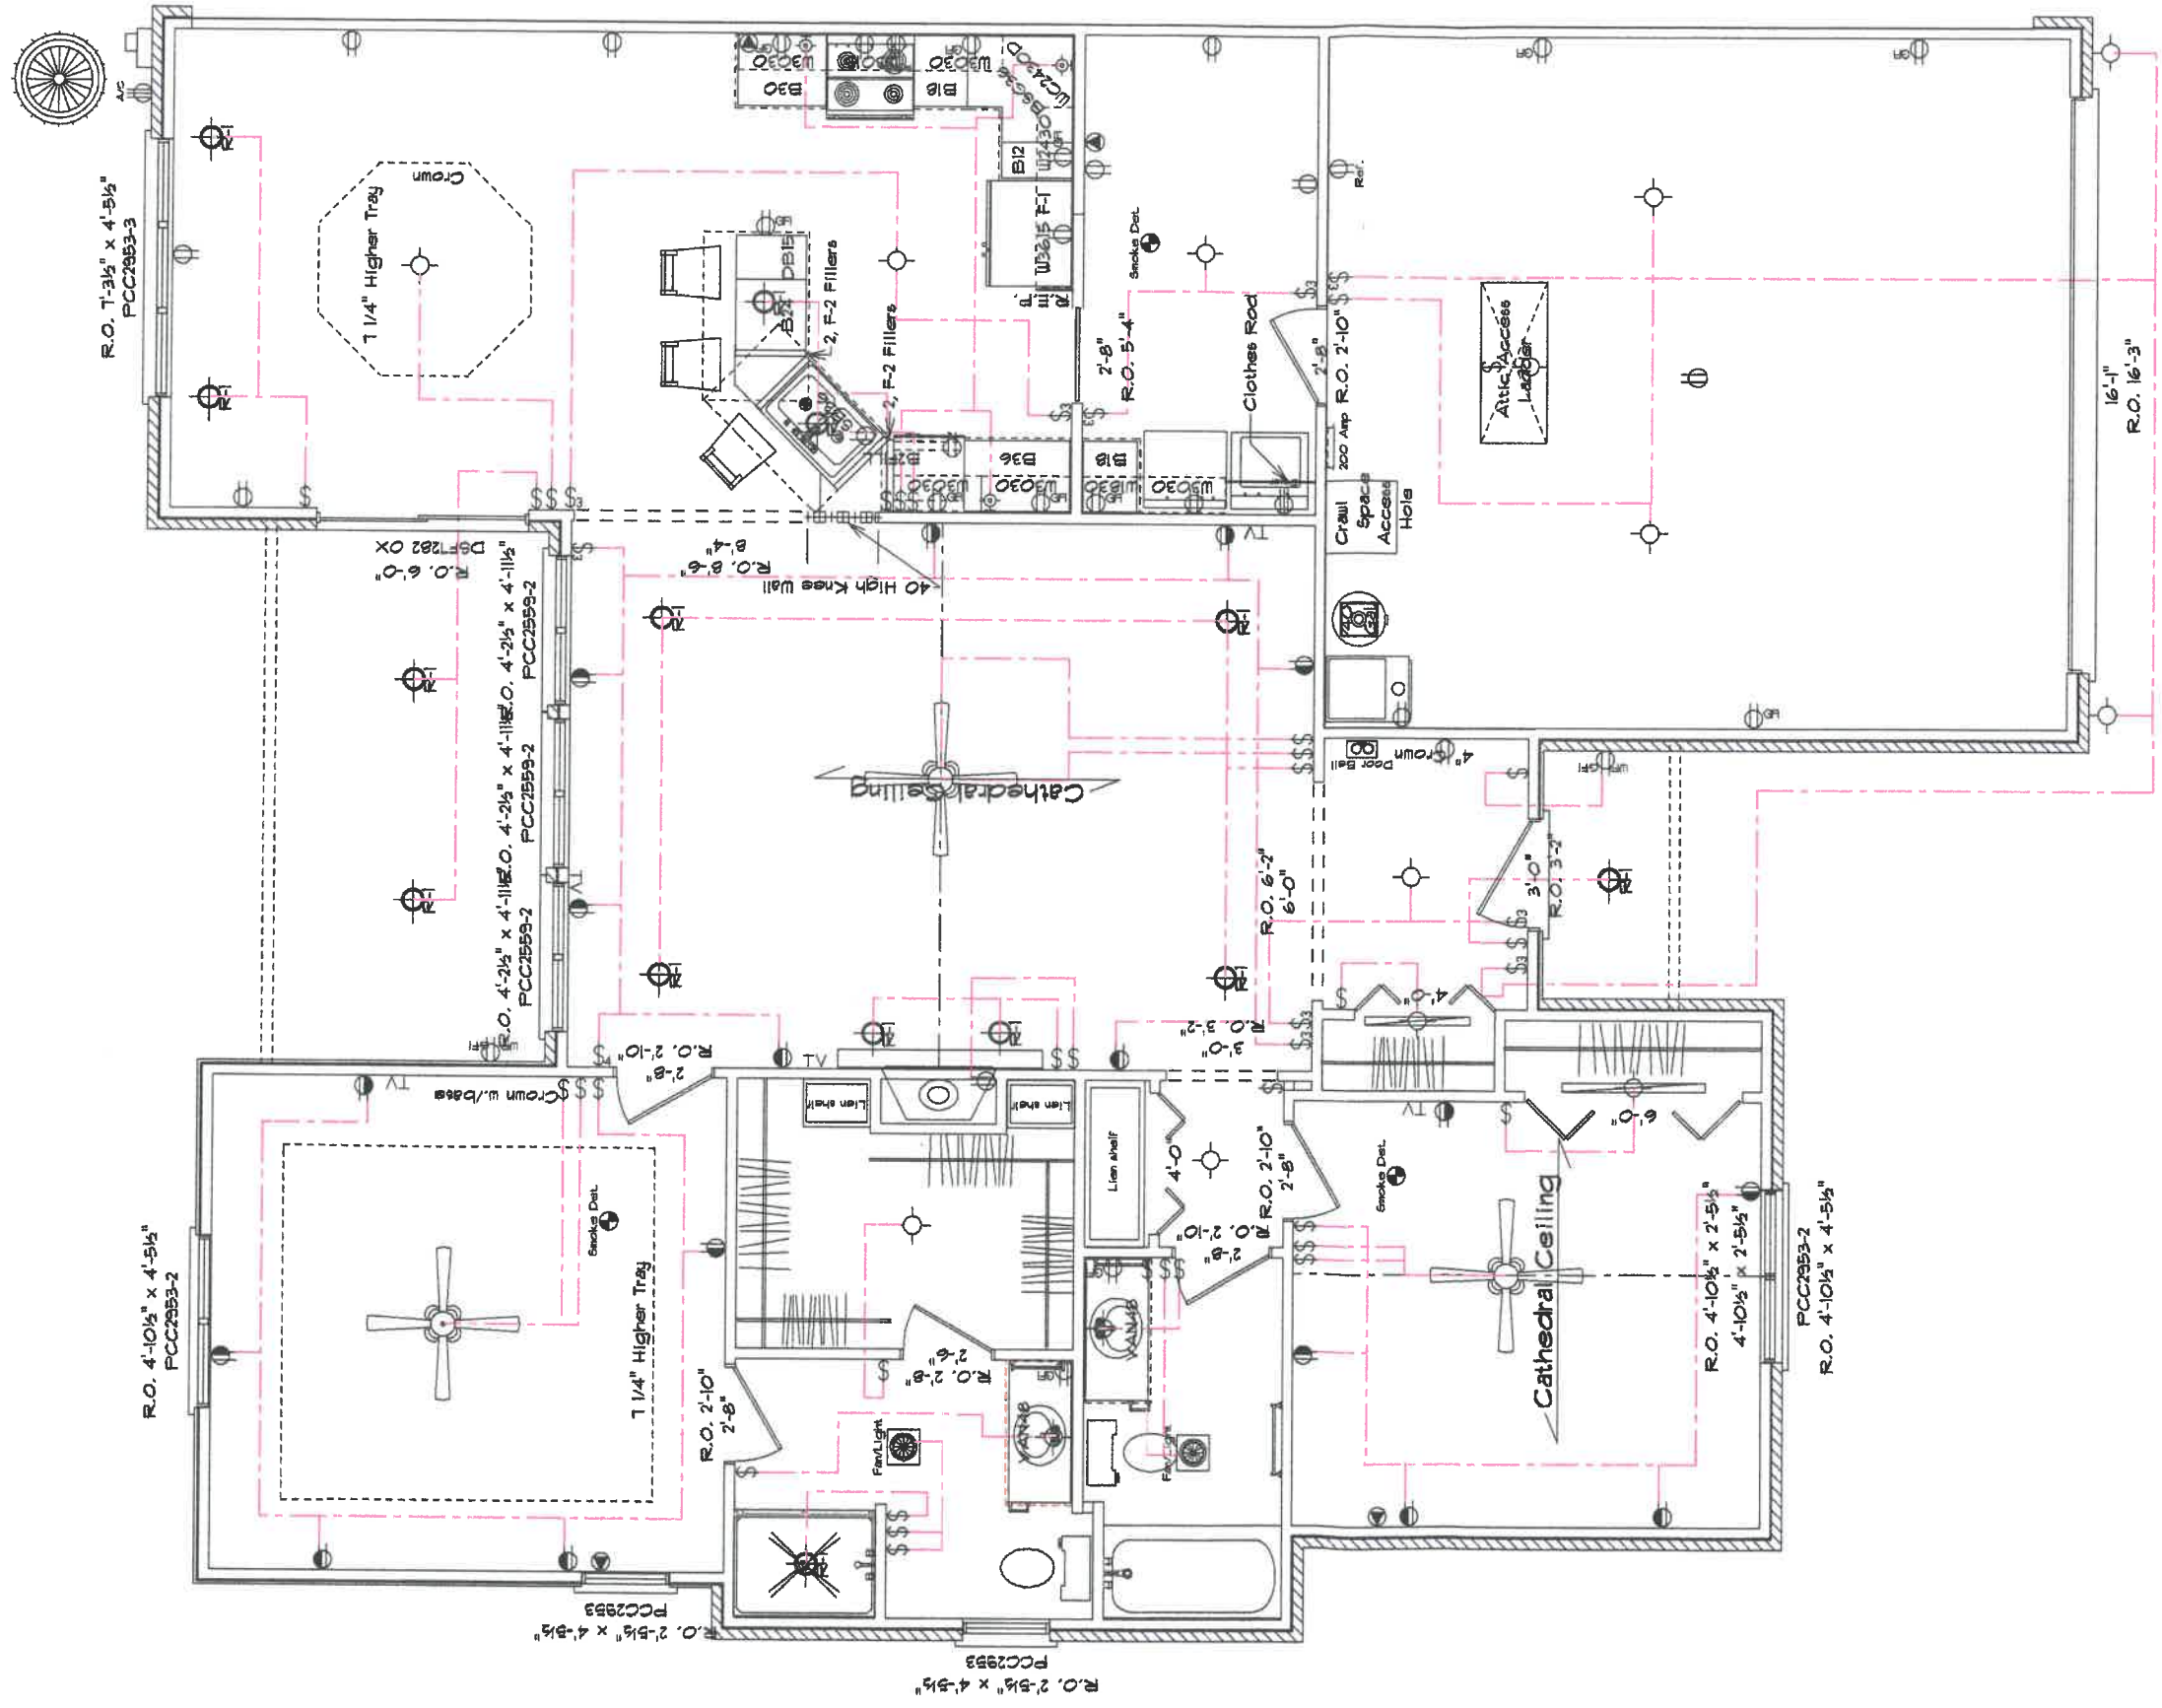

ELECTRICAL PLAN


<i>Kahle Design &amp; Build</i>	
Defiance, Oh	Phone 497-4805
Scale: Var. 1/8"	Date 9-15-03
Mr. & Ms. Jim McColley	
Location: Chelsea Ave., Napoleon	

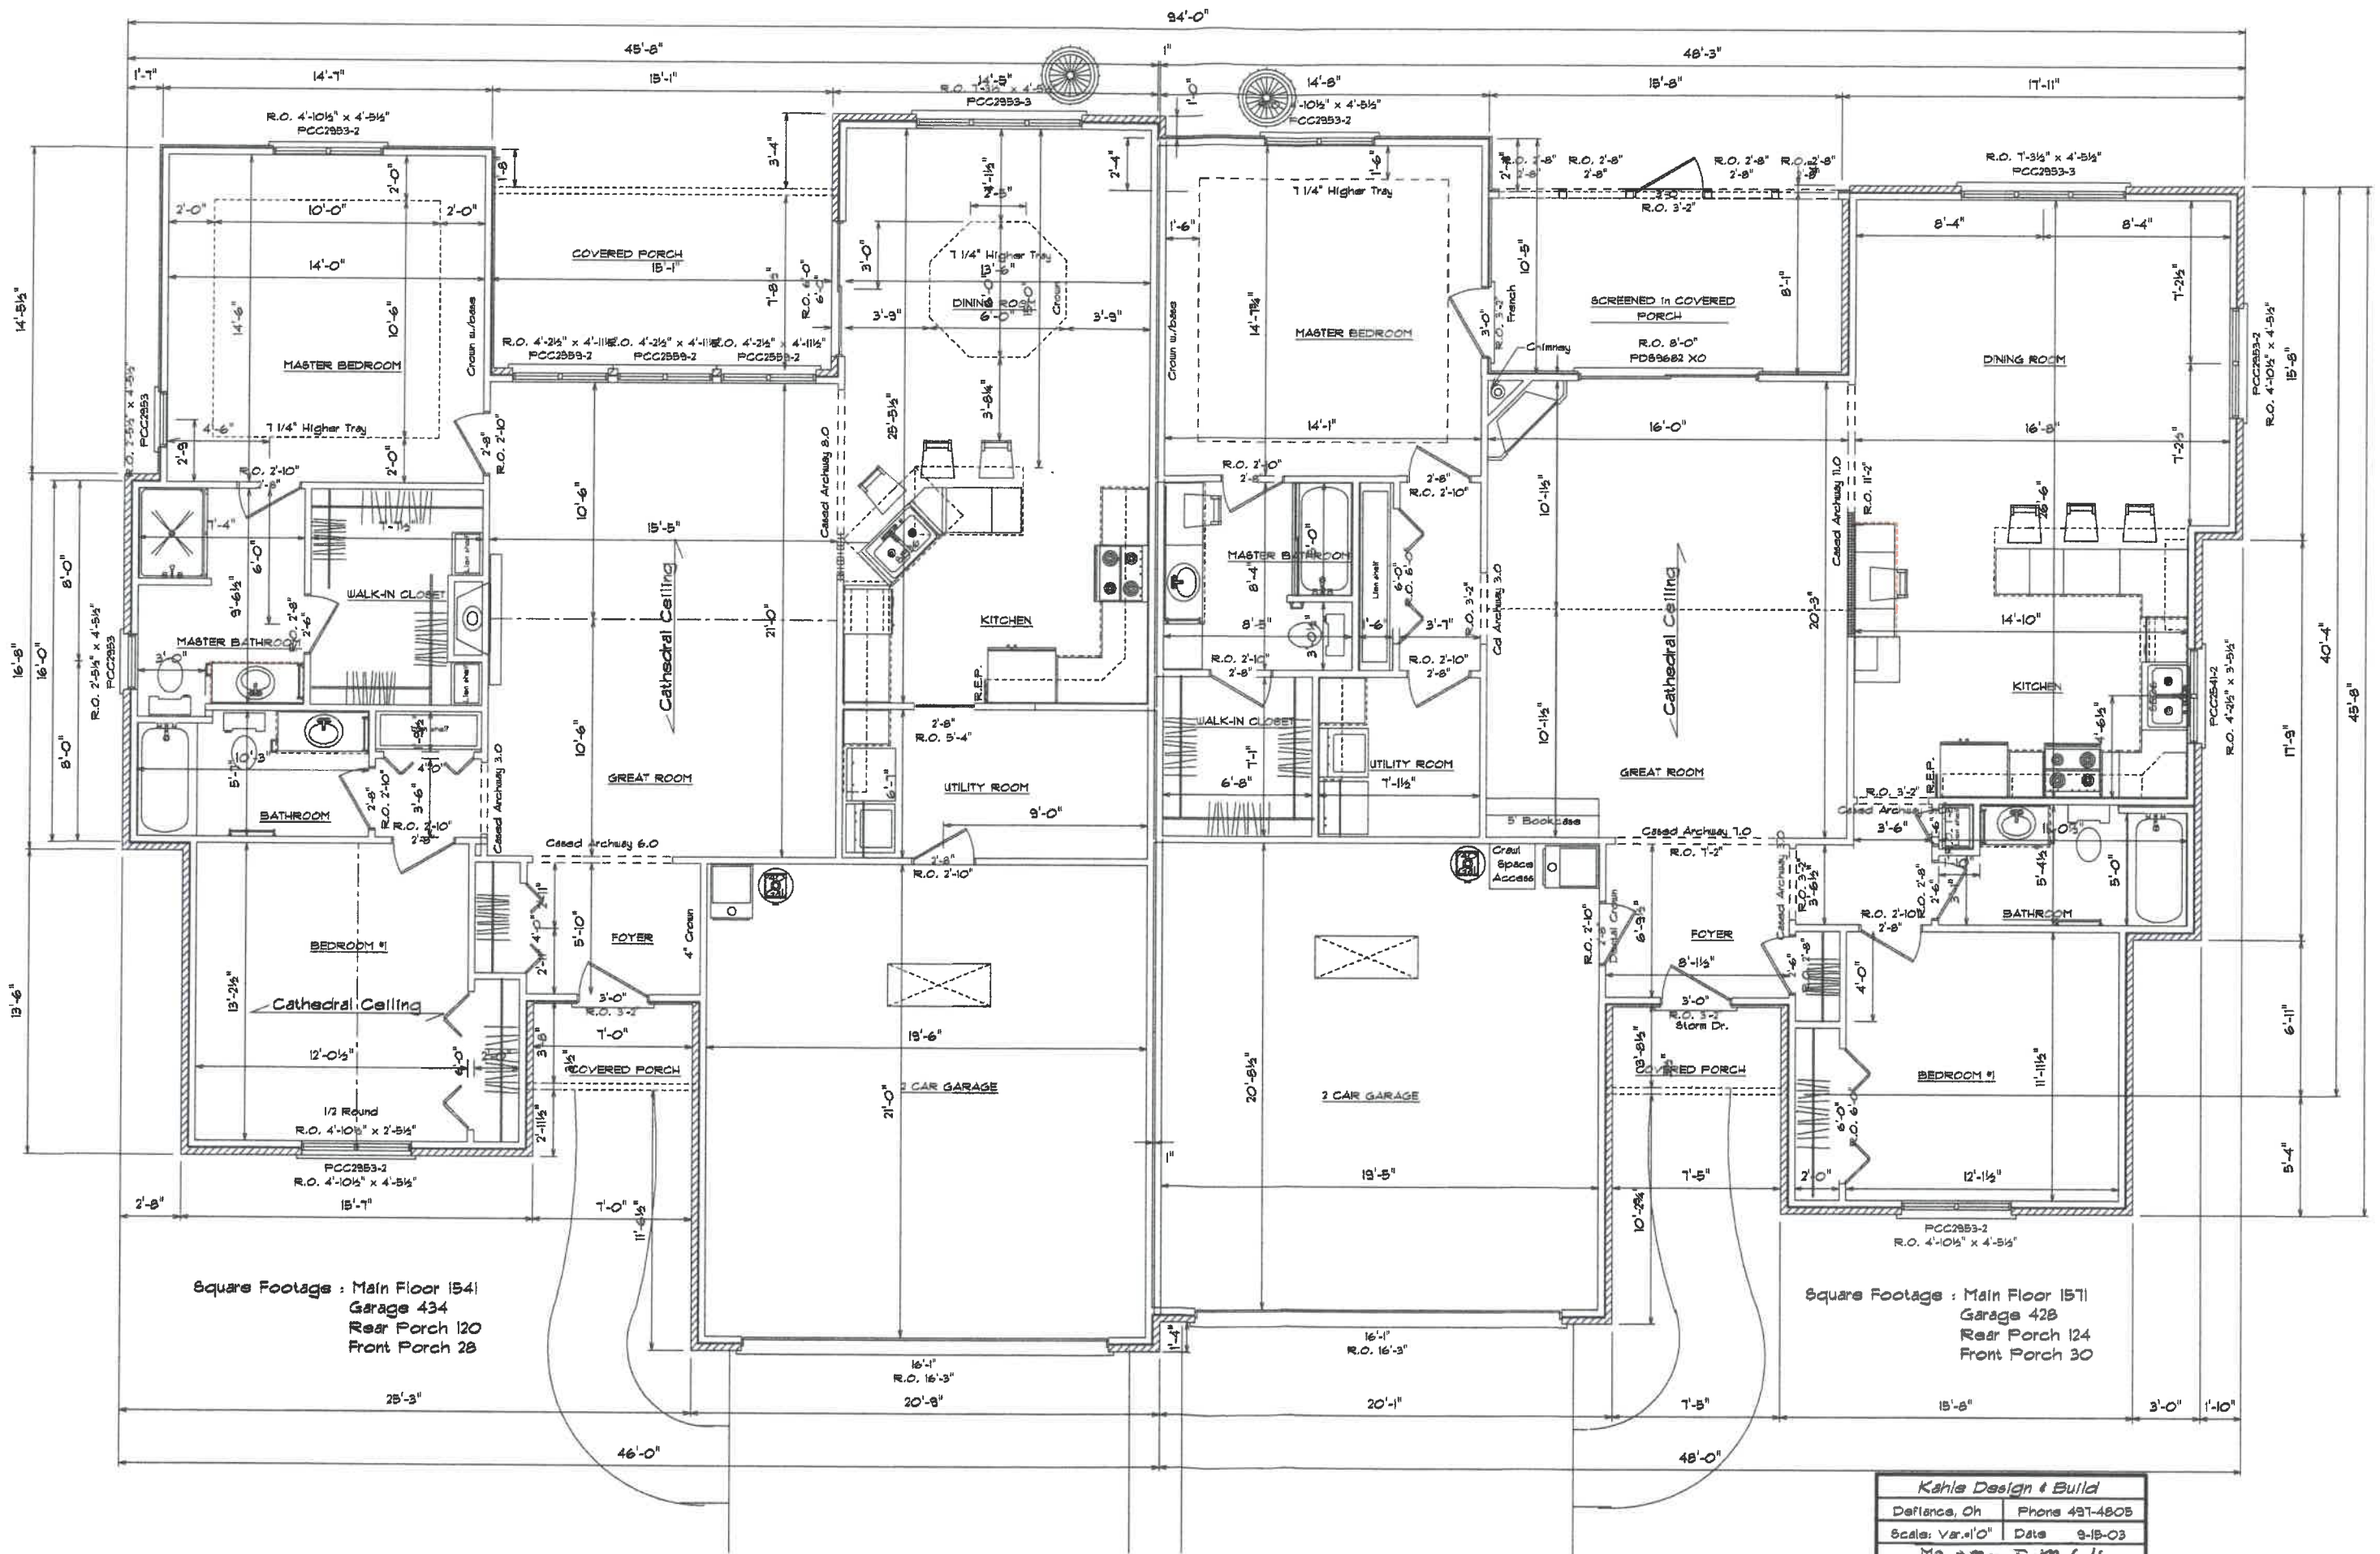

Square Footage : Main Floor 1541  
 Garage 434  
 Rear Porch 120  
 Front Porch 28

Square Footage : Main Floor 1571  
 Garage 428  
 Rear Porch 124  
 Front Porch 30


Kahle Design & Build  
 Defiance, Oh Phone 497-4805  
 Scale: Var.'0" Date 8-18-03  
 Mr. & Mrs. J. McCleary  
 Location: Chelsea Ave., Napoleon

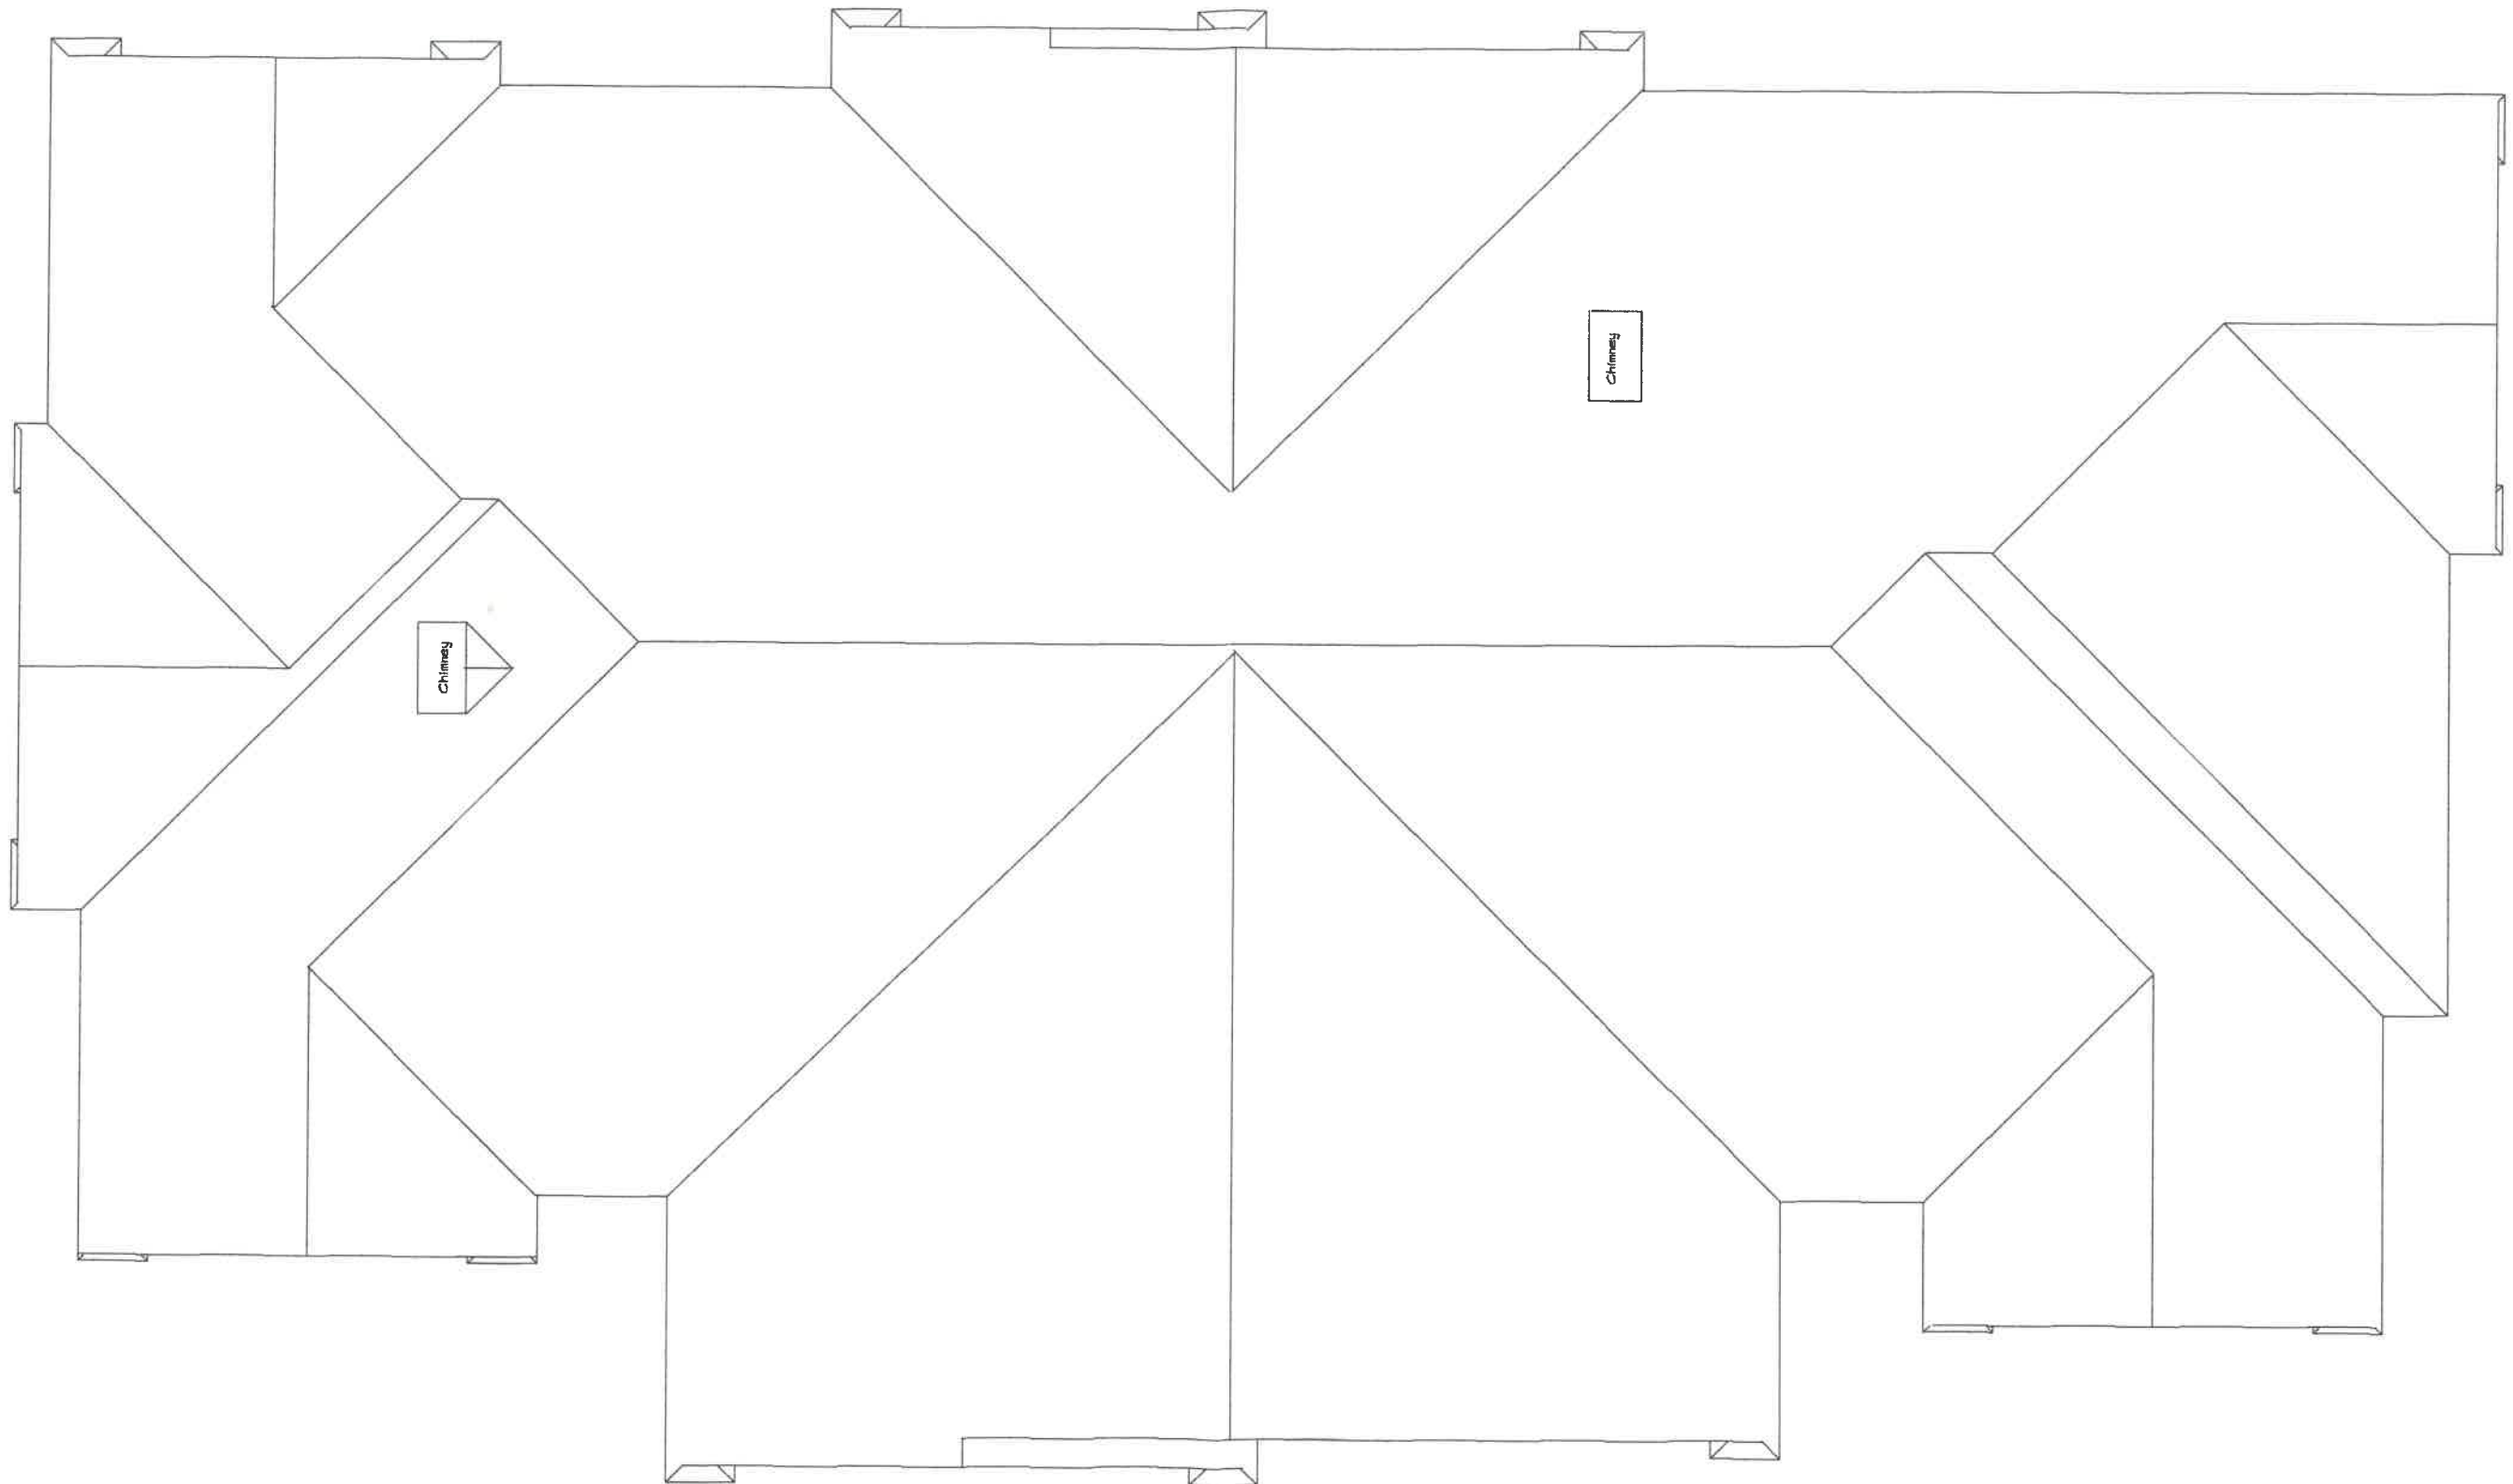

BIRD'S EYE PLAN

Roof Specs.  
Main Roof Pitch 6/12  
Eave Overhang 16"  
Gable Overhang 8"  
Brick Gable Overhang 13" (Rough)  
Degrees of Roof Pitch 26.5  
Heel Height 6"

PLOT PLAN

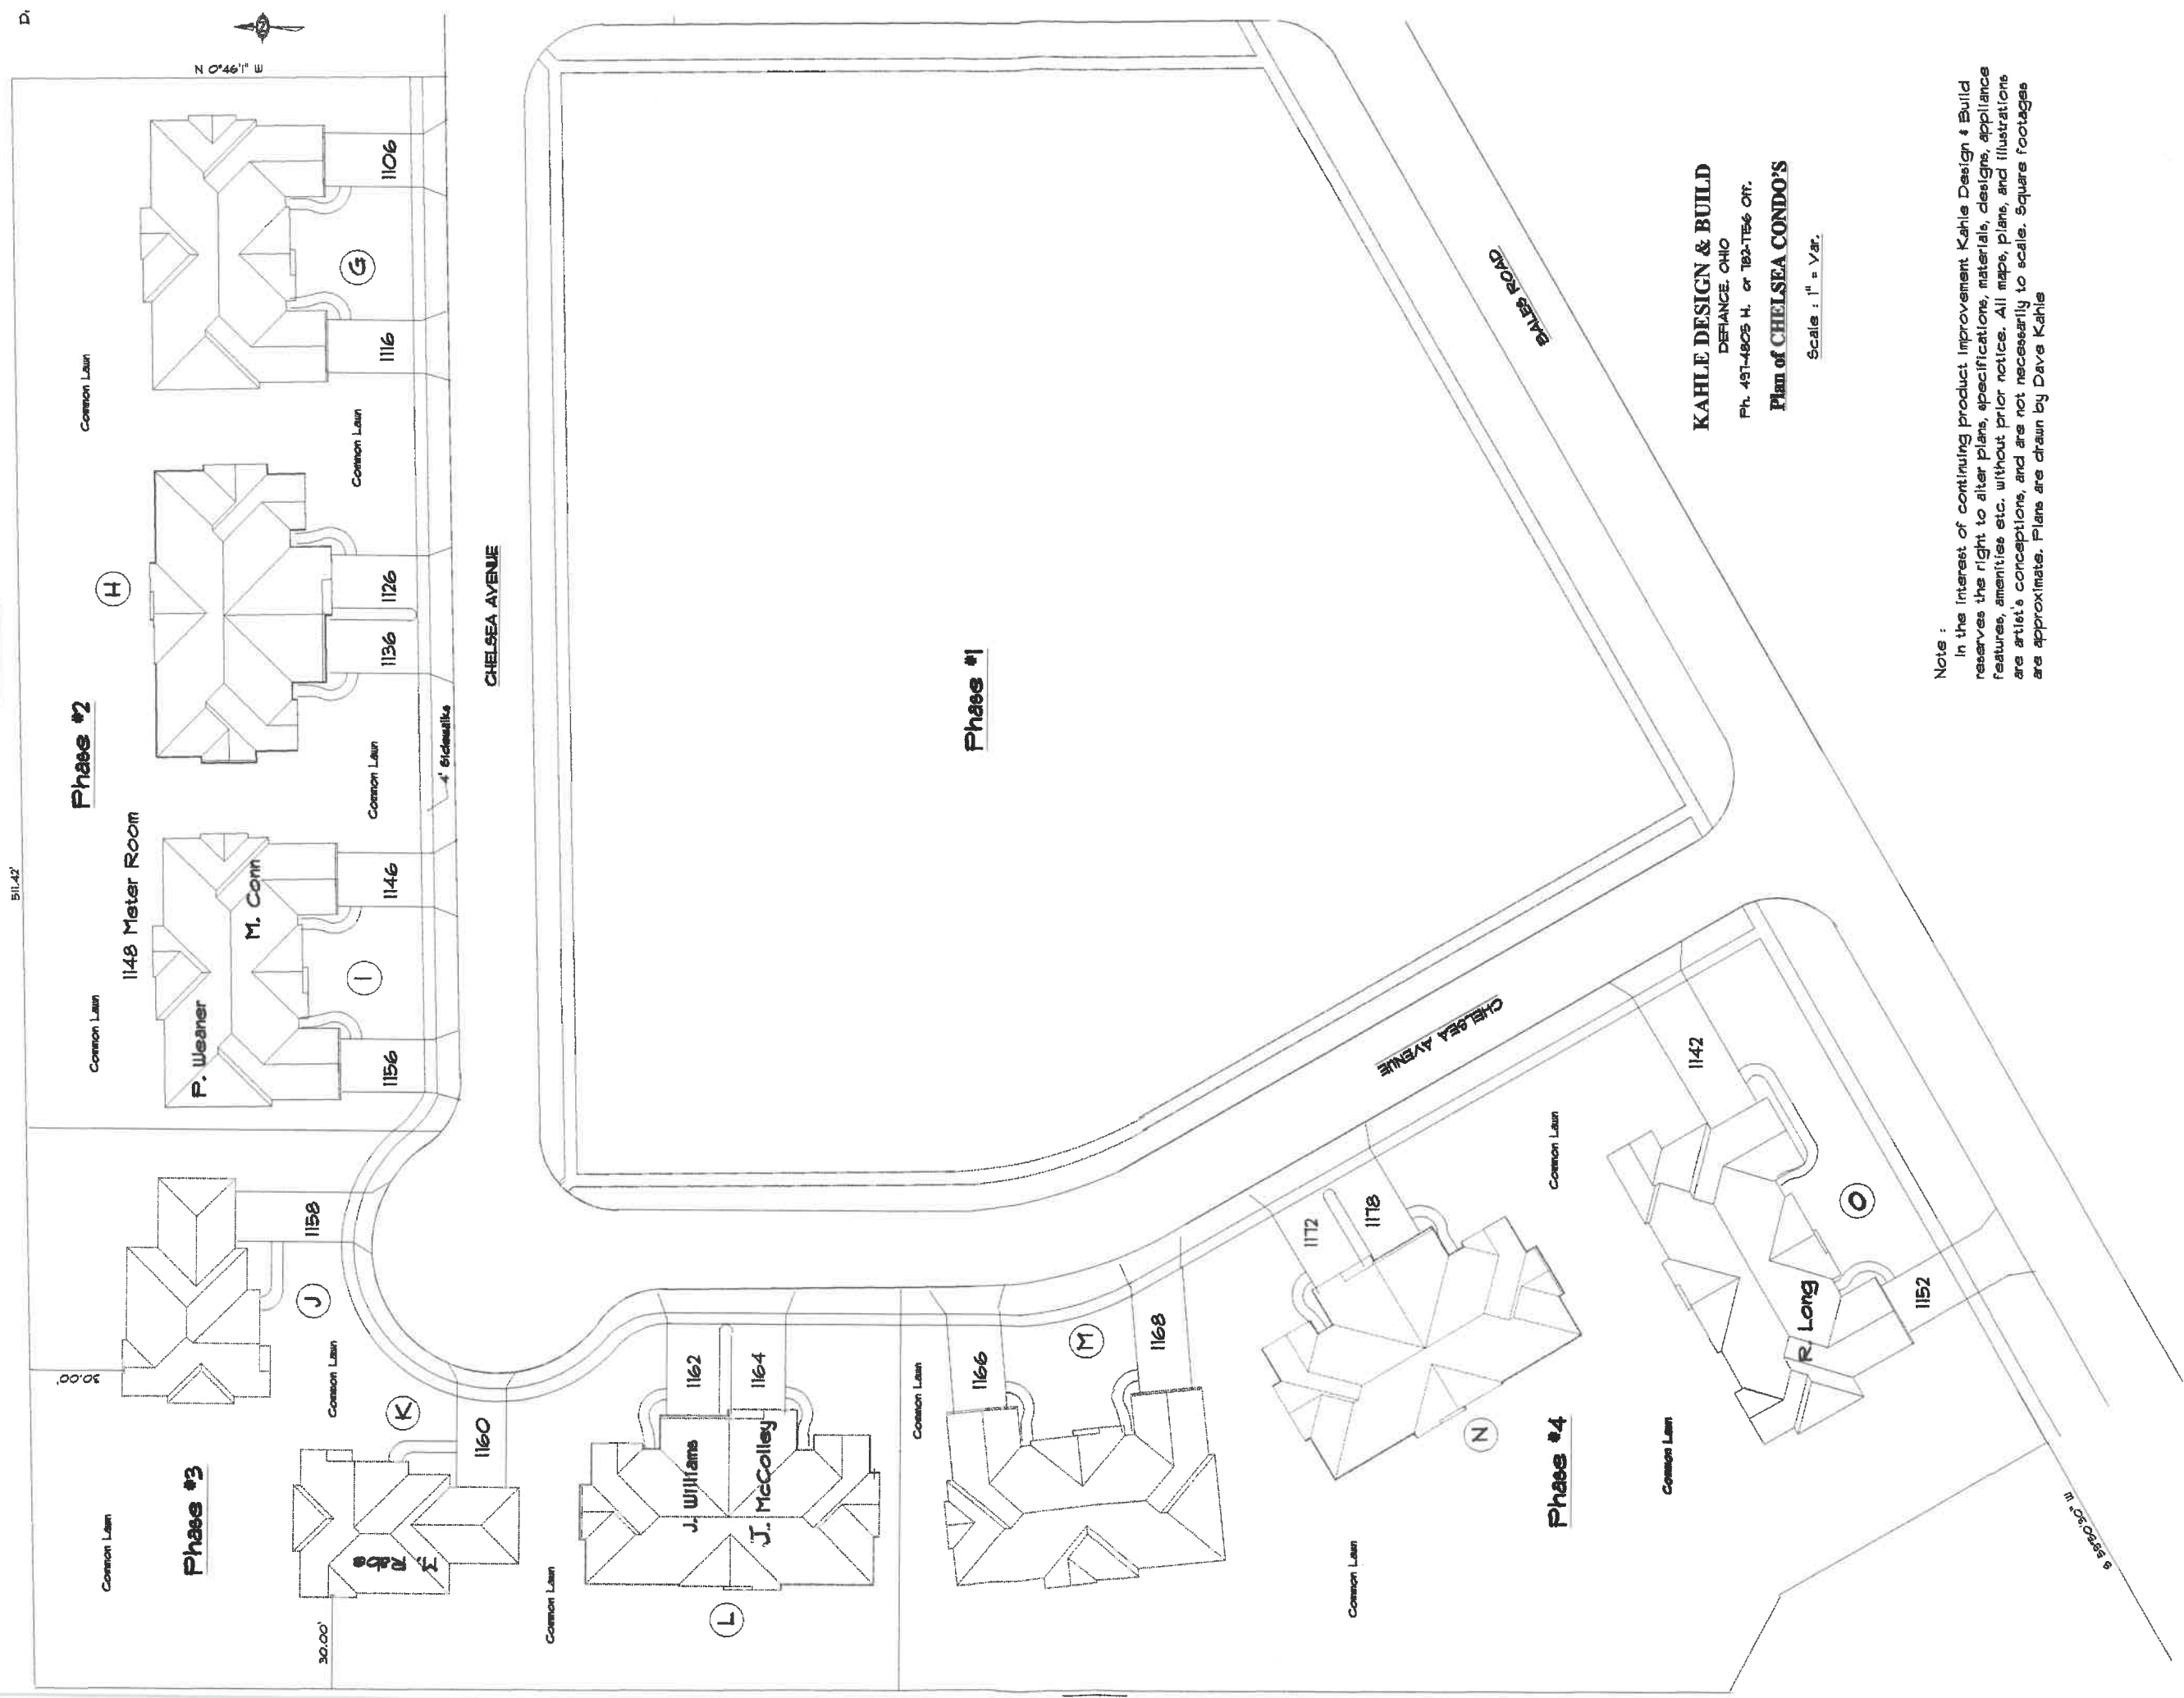

**KAHLE DESIGN & BUILD**  
 DEFANCE, OHIO  
 Ph. 437-4805 H. or 782-786 OFF.  
**Plan of CHELSEA CONDO'S**  
 Scale: 1" = Var.

Note:  
 In the interest of continuing product improvement Kahle Design & Build reserves the right to alter plans, specifications, materials, designs, appliances features, amenities etc. without prior notice. All maps, plans, and illustrations are artist's conceptions, and are not necessarily to scale. Square footages are approximate. Plans are drawn by Dave Kahle