


CAD CONTROL
 PROJECT
 FILE NAME
 1585
 PLOT SCALE
 1/8"=1'
 LAYERS

ADDITION TO NAPOLEON PUBLIC LIBRARY 310 WEST CLINTON ST. NAPOLEON, OHIO

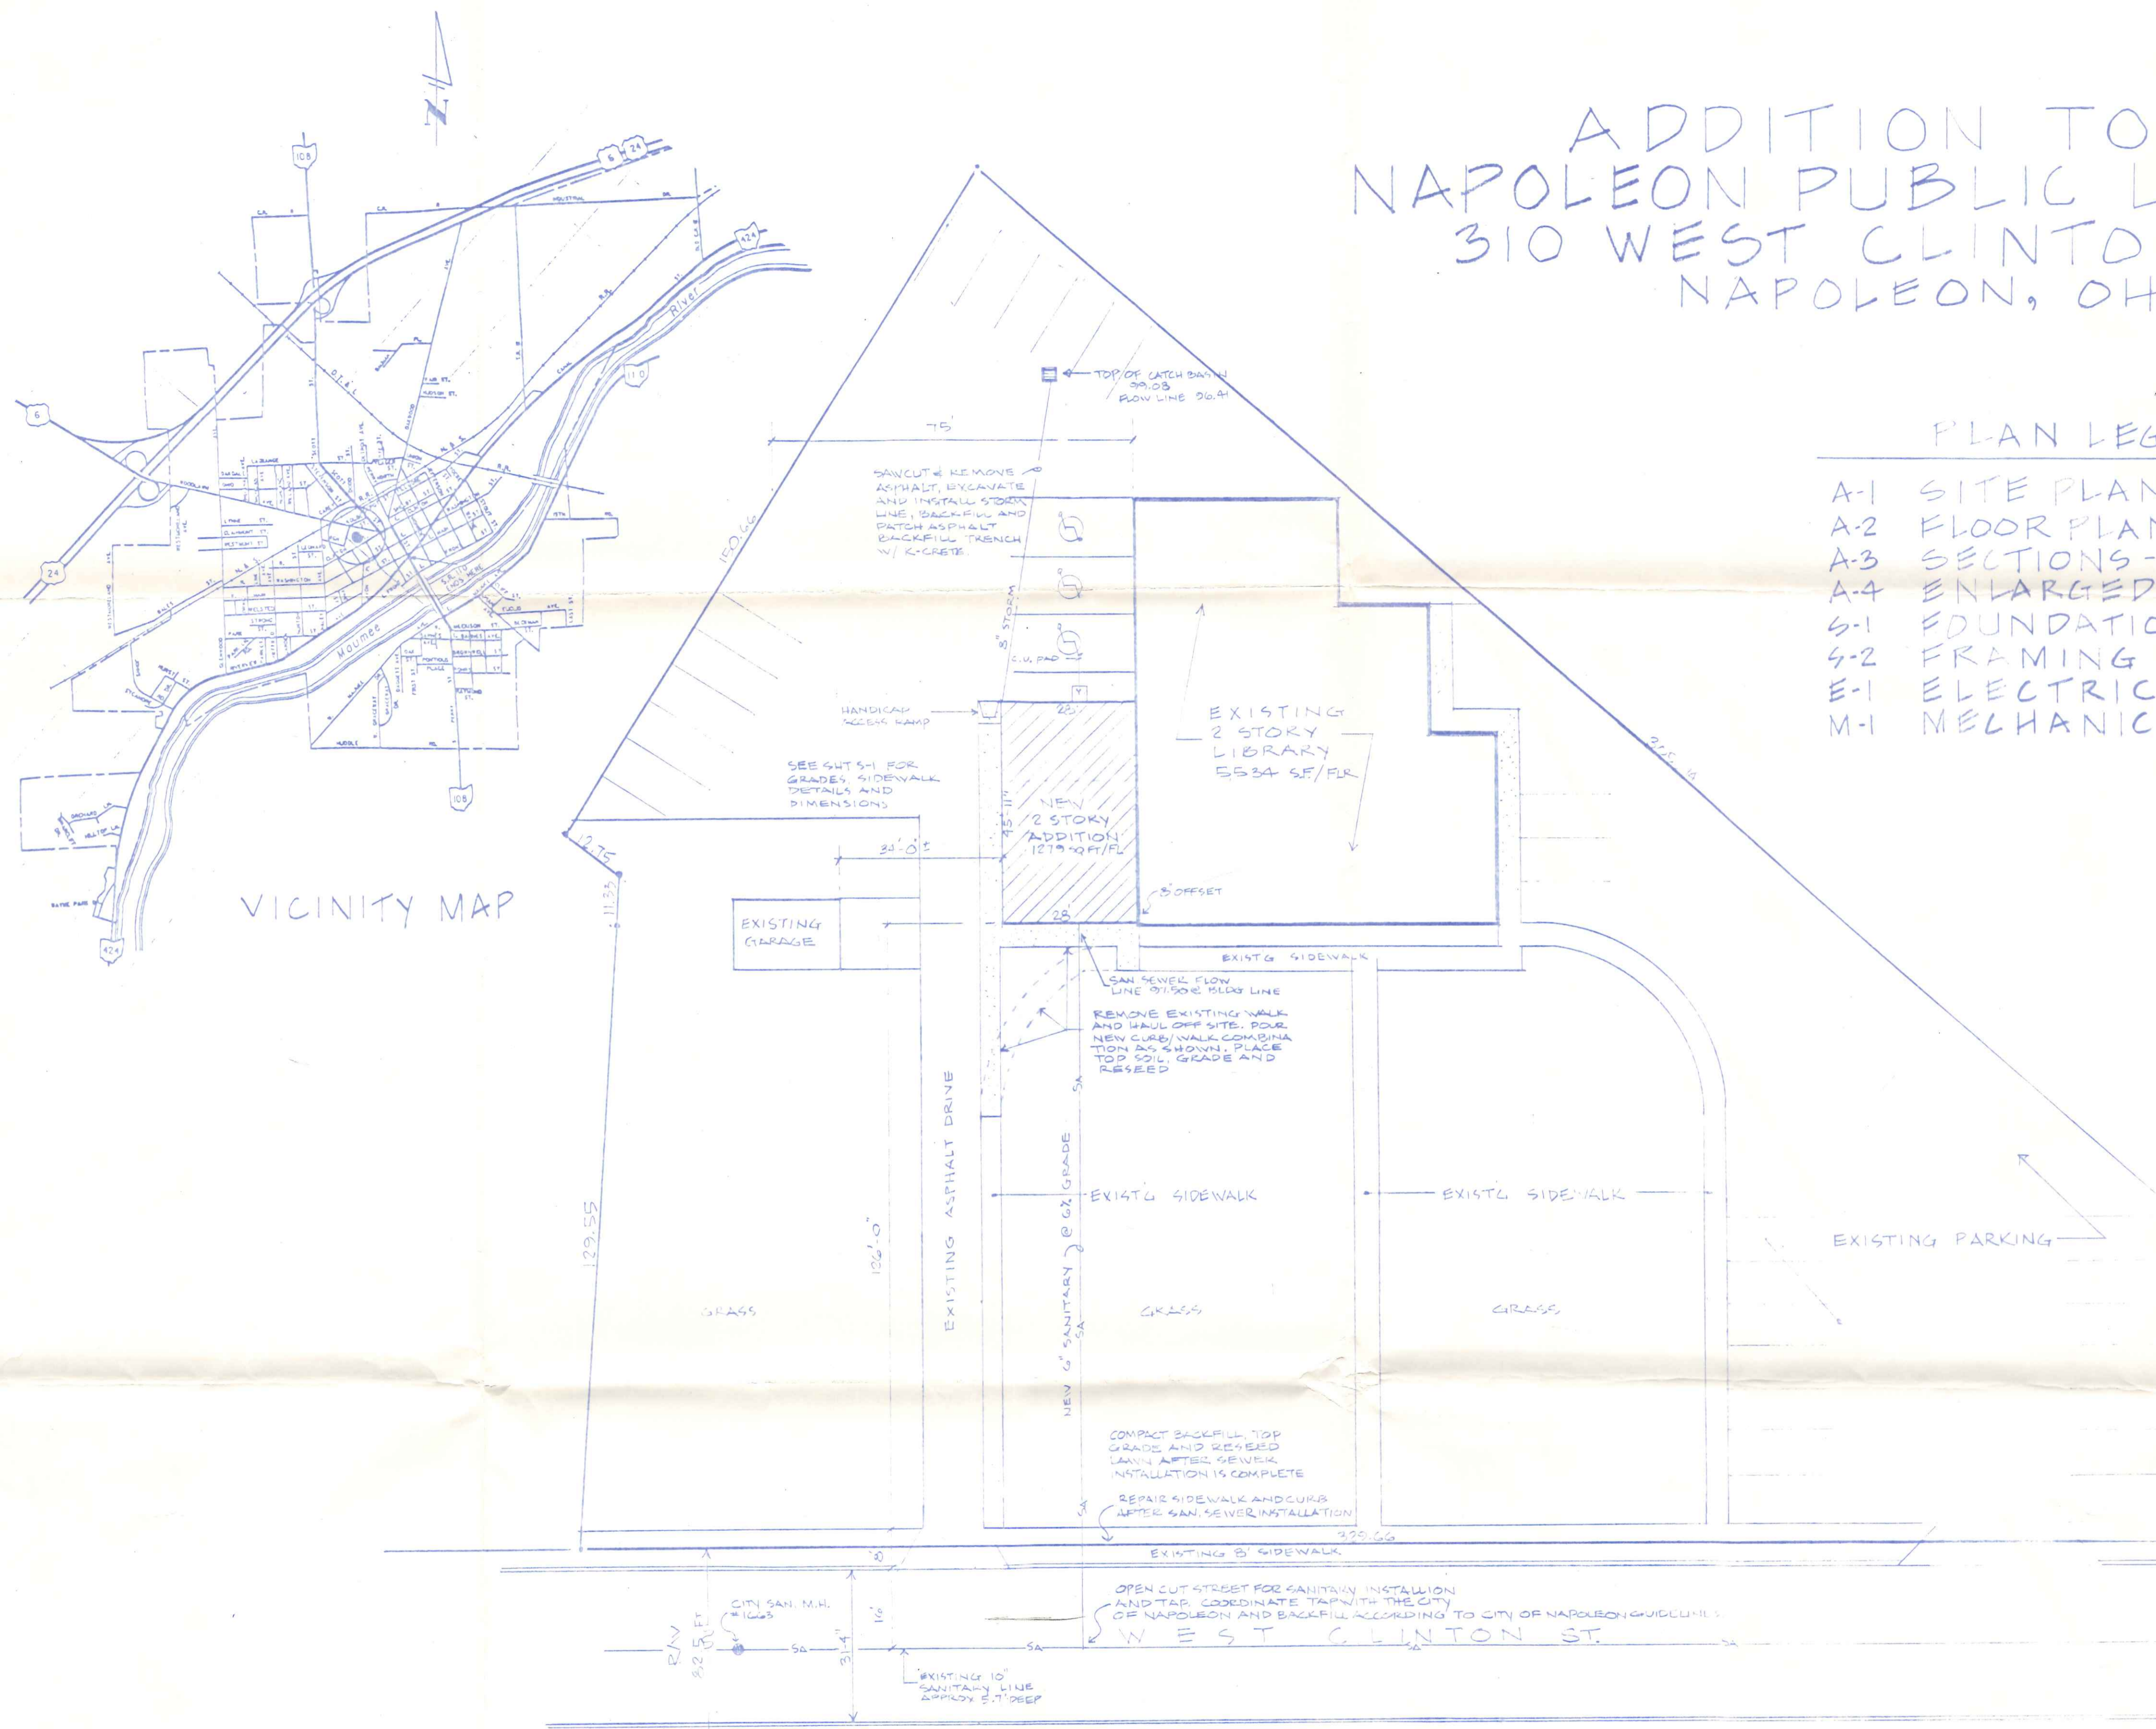

- ### PLAN LEGEND
- A-1 SITE PLAN
 - A-2 FLOOR PLAN - ELEVATIONS
 - A-3 SECTIONS - ROOF PLAN
 - A-4 ENLARGED FLOOR PLANS
 - S-1 FOUNDATION PLAN
 - S-2 FRAMING PLAN
 - E-1 ELECTRICAL PLAN
 - M-1 MECHANICAL PLAN

SITE PLAN
 1" = 20'-0"

REVISIONS

© 1993 BEILHARZ ARCHITECTS INC.
Napoleon Public Library
 BUILDING ADDITION
 310 WEST CLINTON STREET
 NAPOLEON, OHIO 43545

SITE PLAN

date: 3-8-93
 commission: 93-1585
 drawn: R/R
 checked: JSO
 sheet **A1**

310 W. Clinton