




OAKMONT MINIATURE GOLF

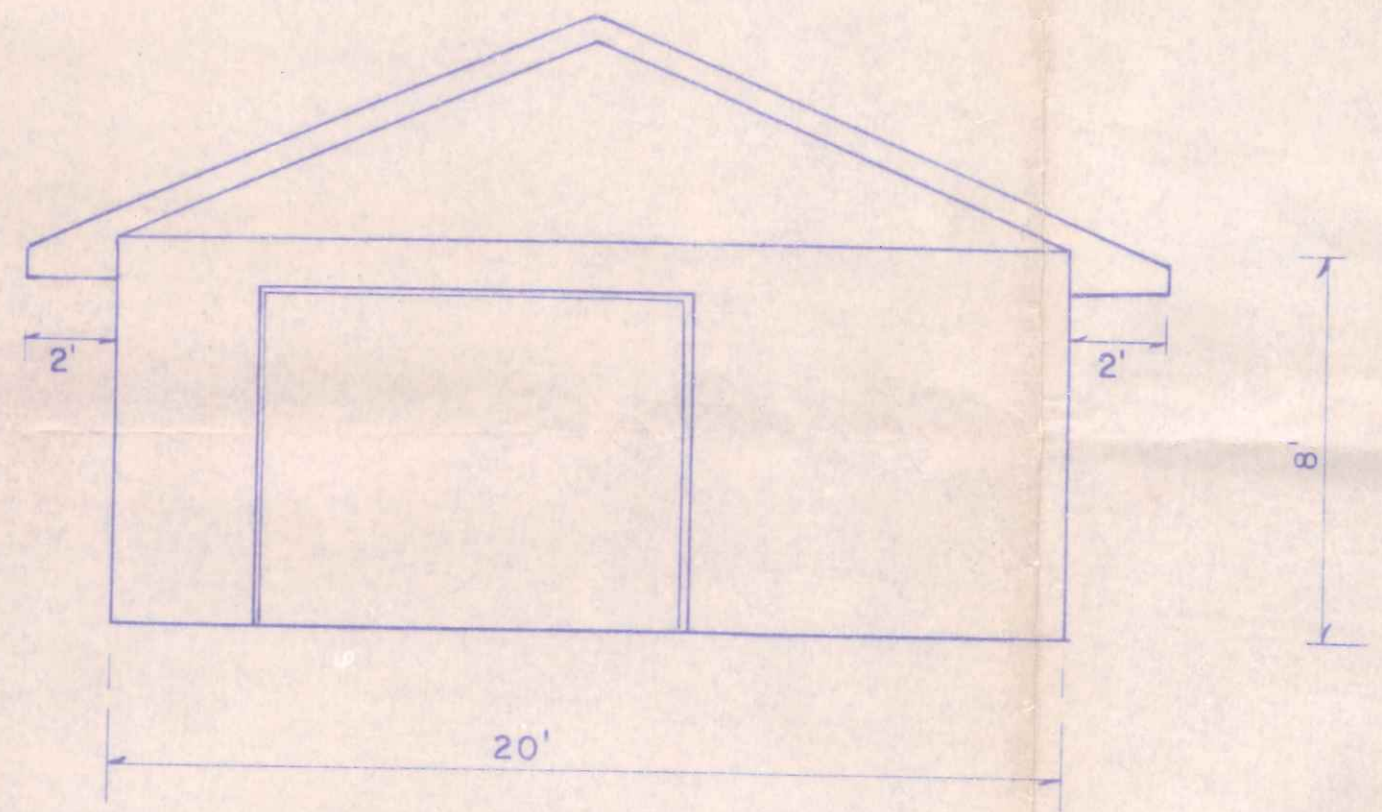


WEST ELEVATION
Scale 1/4" = 1'-0"

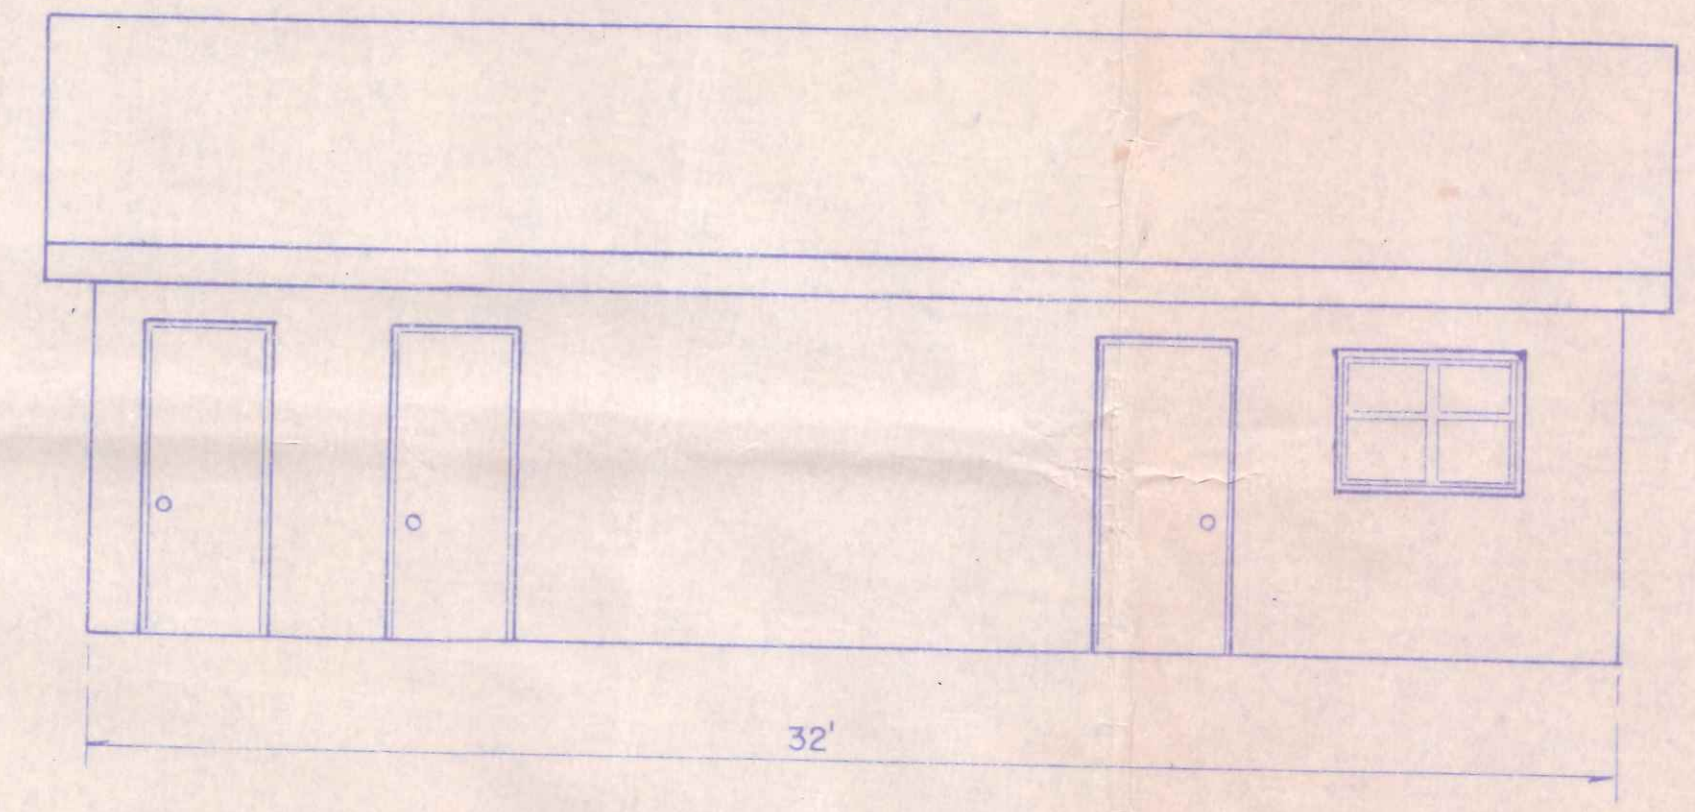


SOUTH ELEVATION
Scale 1/4" = 1'-0"

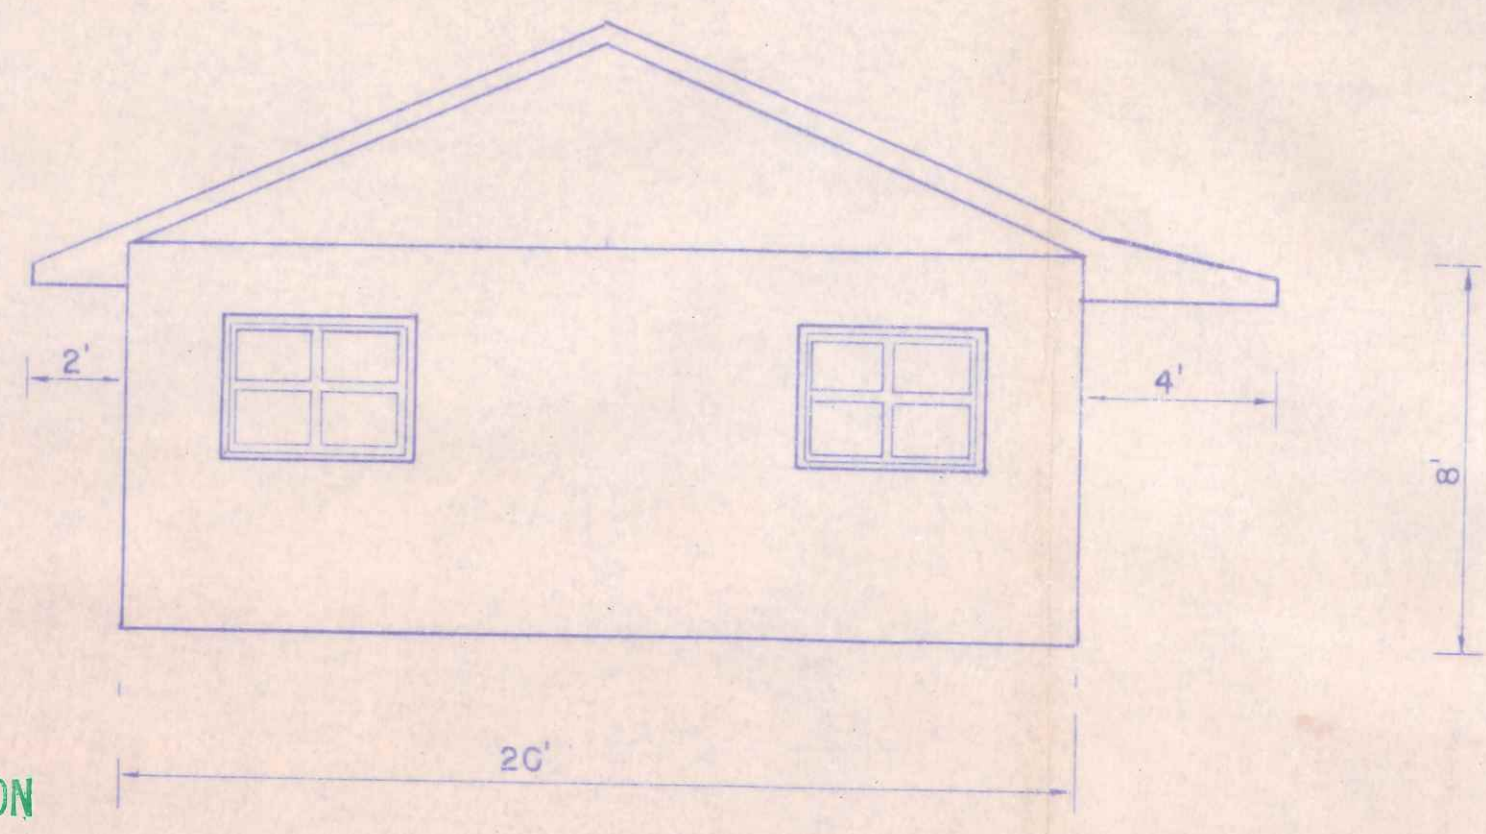

EAST ELEVATION
Scale 1/4" = 1'-0"

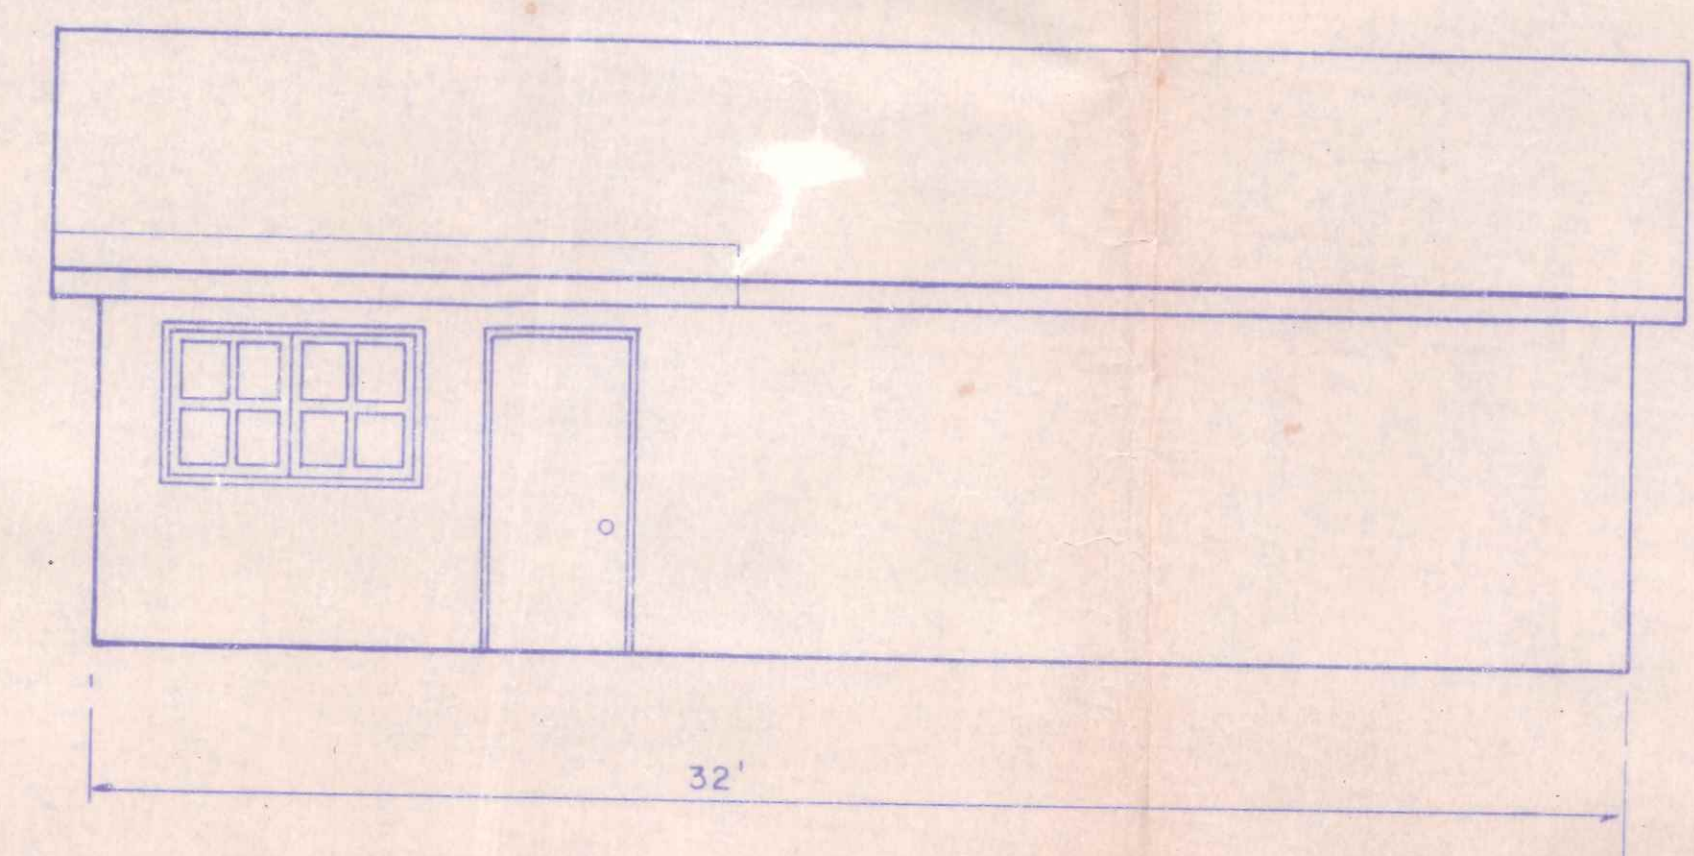


NORTH ELEVATION
Scale 1/4" = 1'-0"

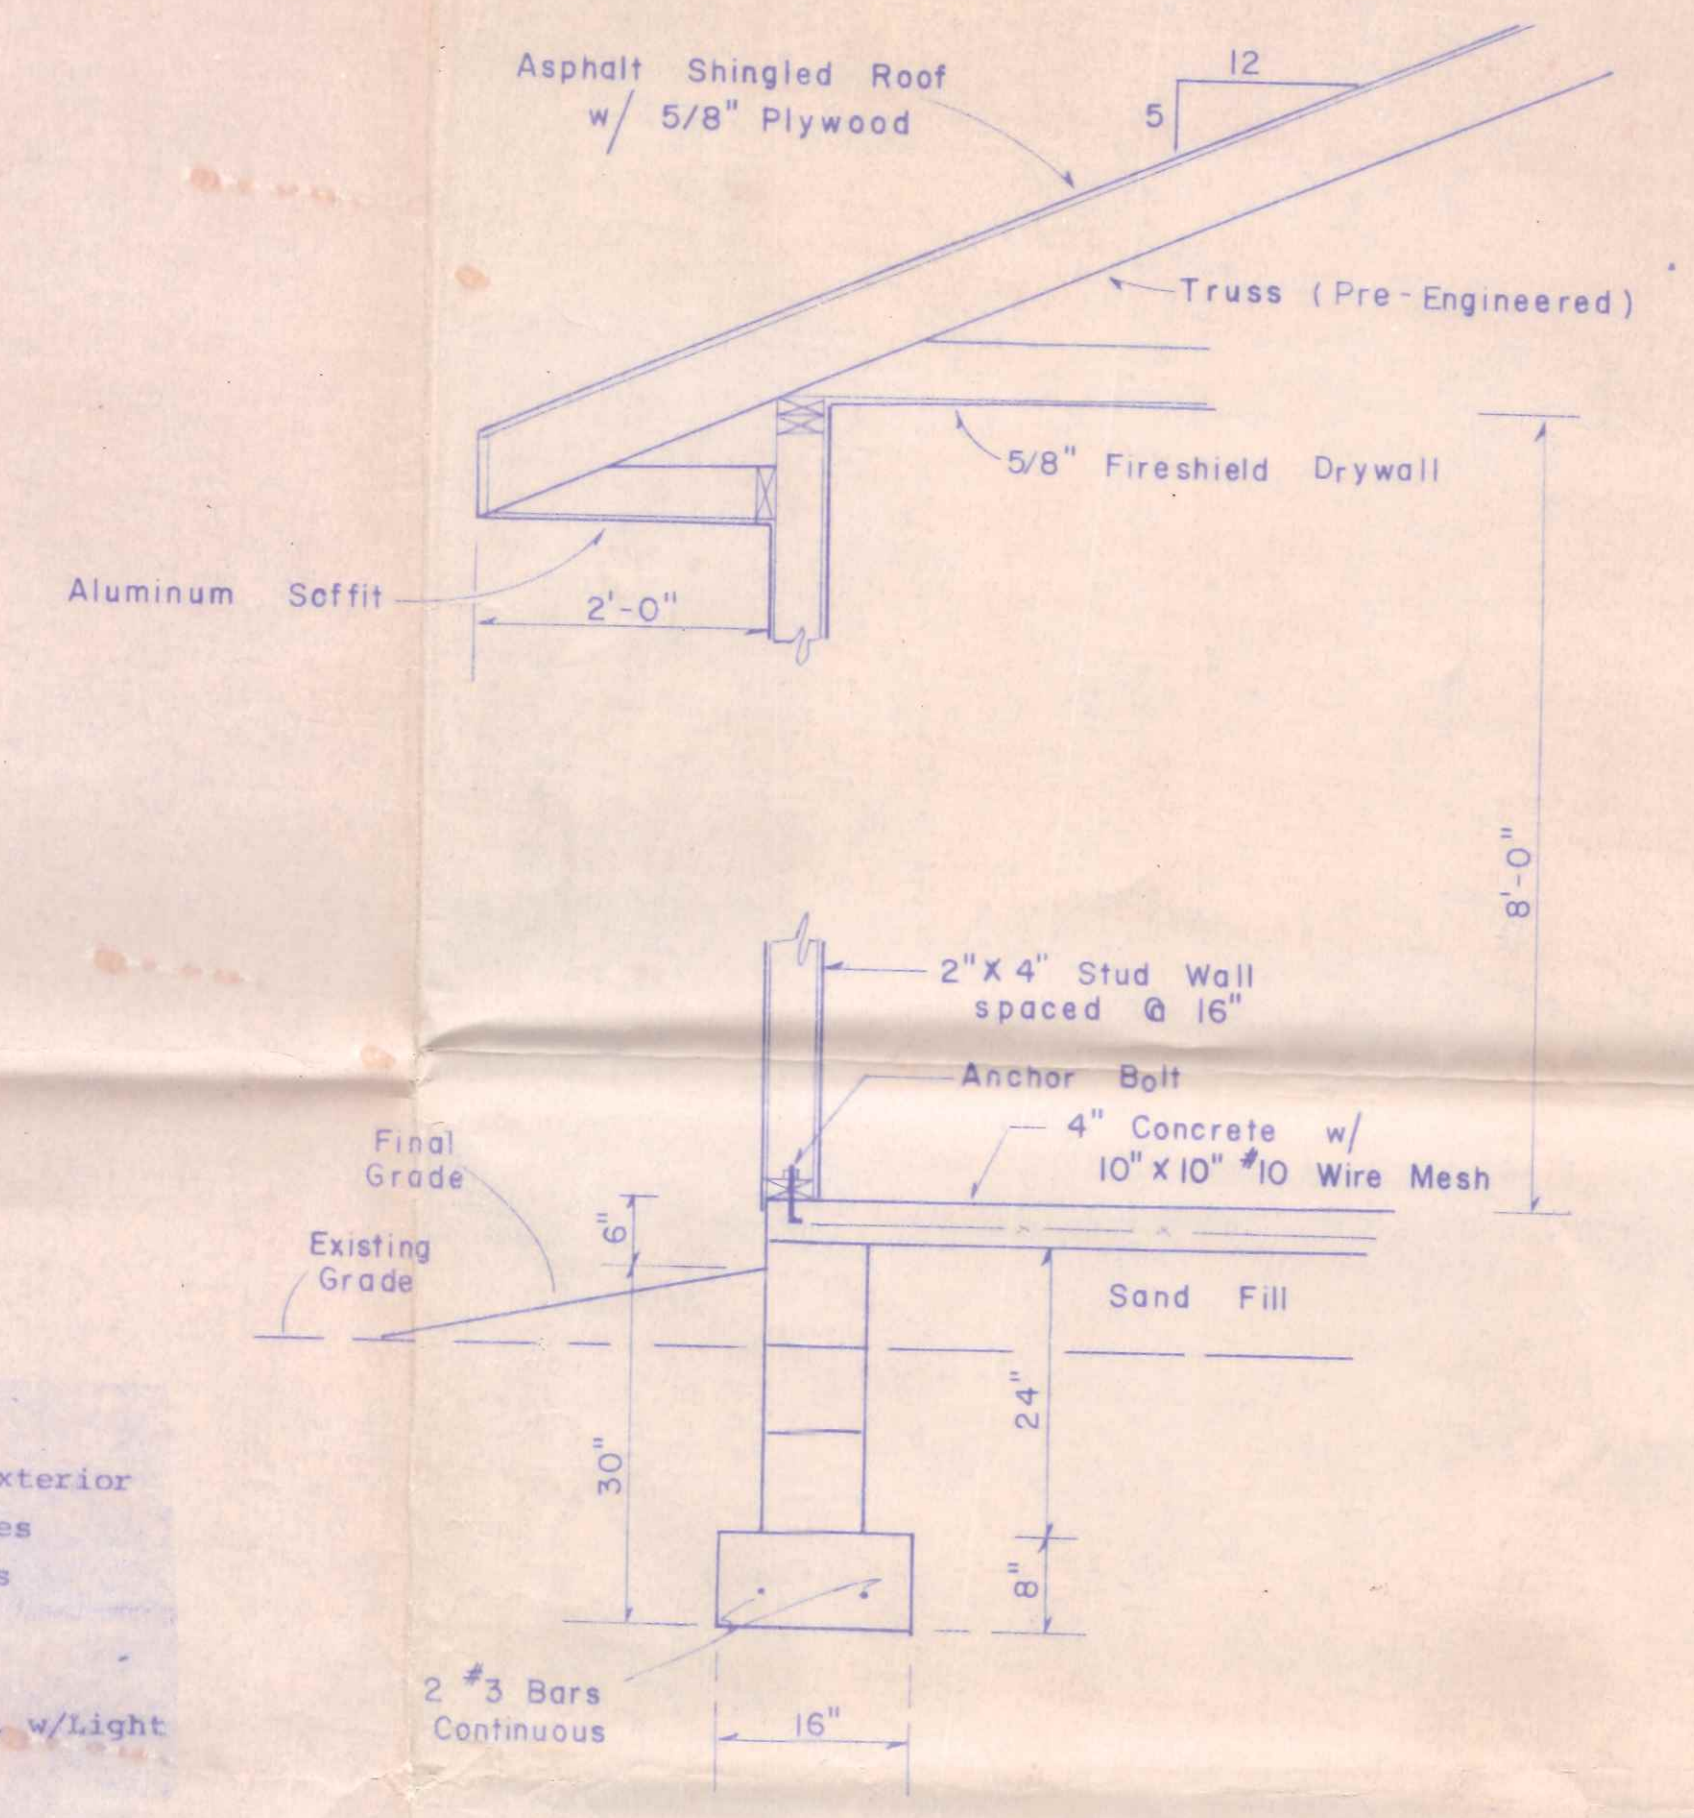

WALL & FOOTER SECTION
Scale 3/4" = 1'-0"

- ELECTRICAL LEGEND**
- ⊙ 110v. Ceiling Lights & Exterior
 - Fluorescent Light Fixtures
 - ⊕ 110v. Convenience Outlets
 - S Single Pole Switches
 - S₃ 3-Pole Switches
 - ⊗ Exhaust Fan - 2CFM/Sq.ft. w/Light
 - ⊞ M.D. Main Disconnect
- All electrical shall conform to all State, National, and Local Codes.
10 Amp Service

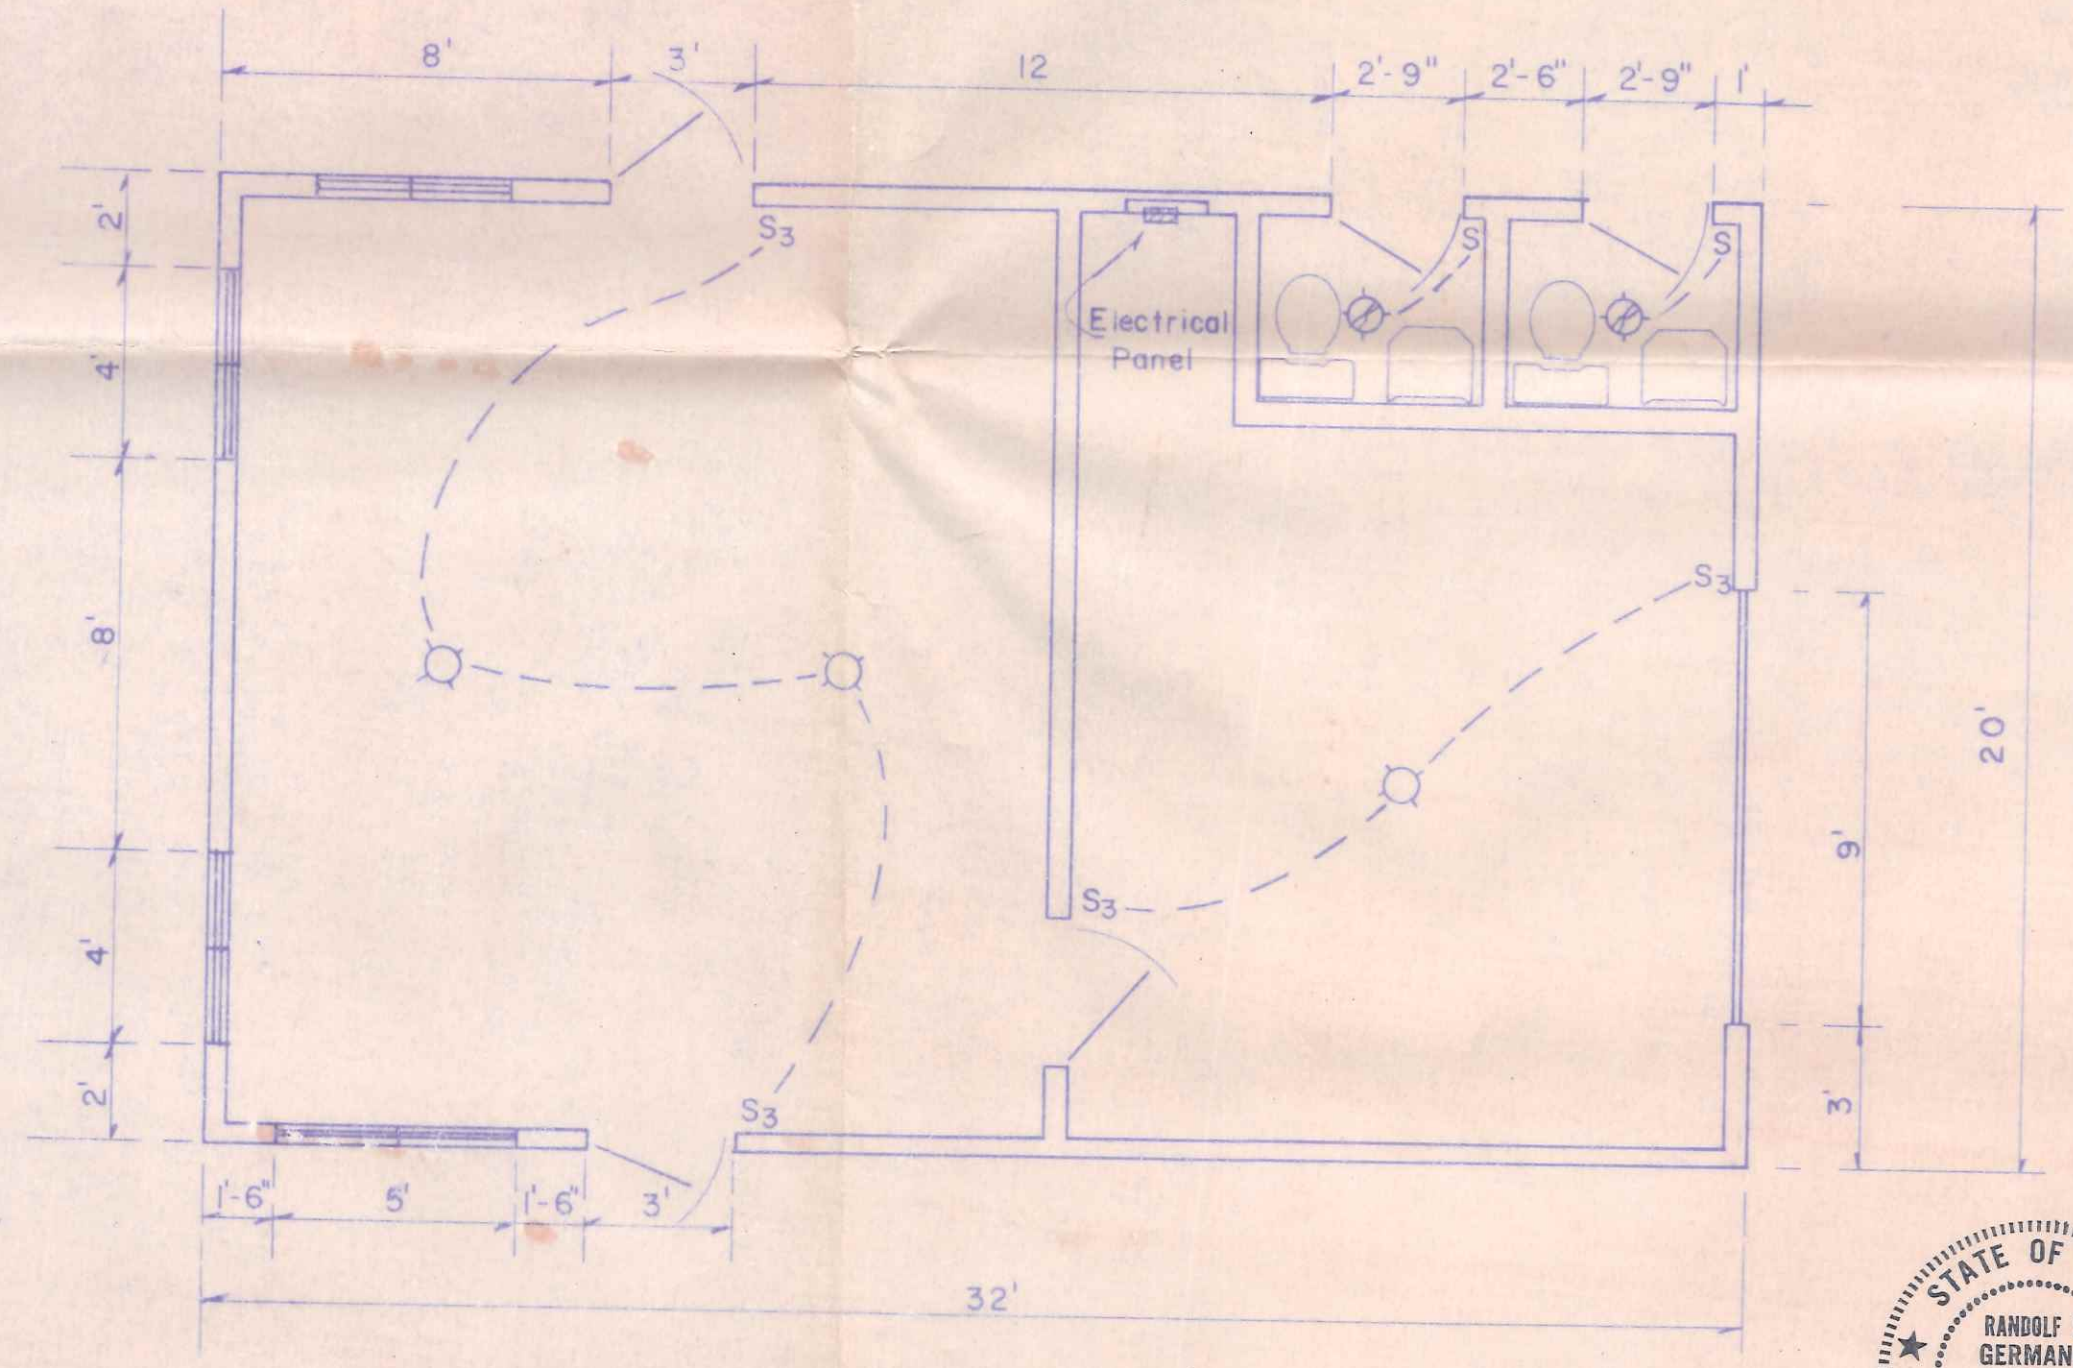

FLOOR PLAN
Scale 1/4" = 1'-0"

CITY OF NAPOLEON
BUILDING DEPT.
Plan Approval
By *P.C.V.* Date 6-28-78

STATE OF OHIO
REGISTERED PROFESSIONAL ENGINEER
RANDOLF L. GERMANN
33142
E.C. GERKEN & ASSOCIATES, INC.
CONSULTING ENGINEERS & SURVEYORS
DEFIANCE, OHIO

551 Freedom