



MAIN FLOOR PLAN

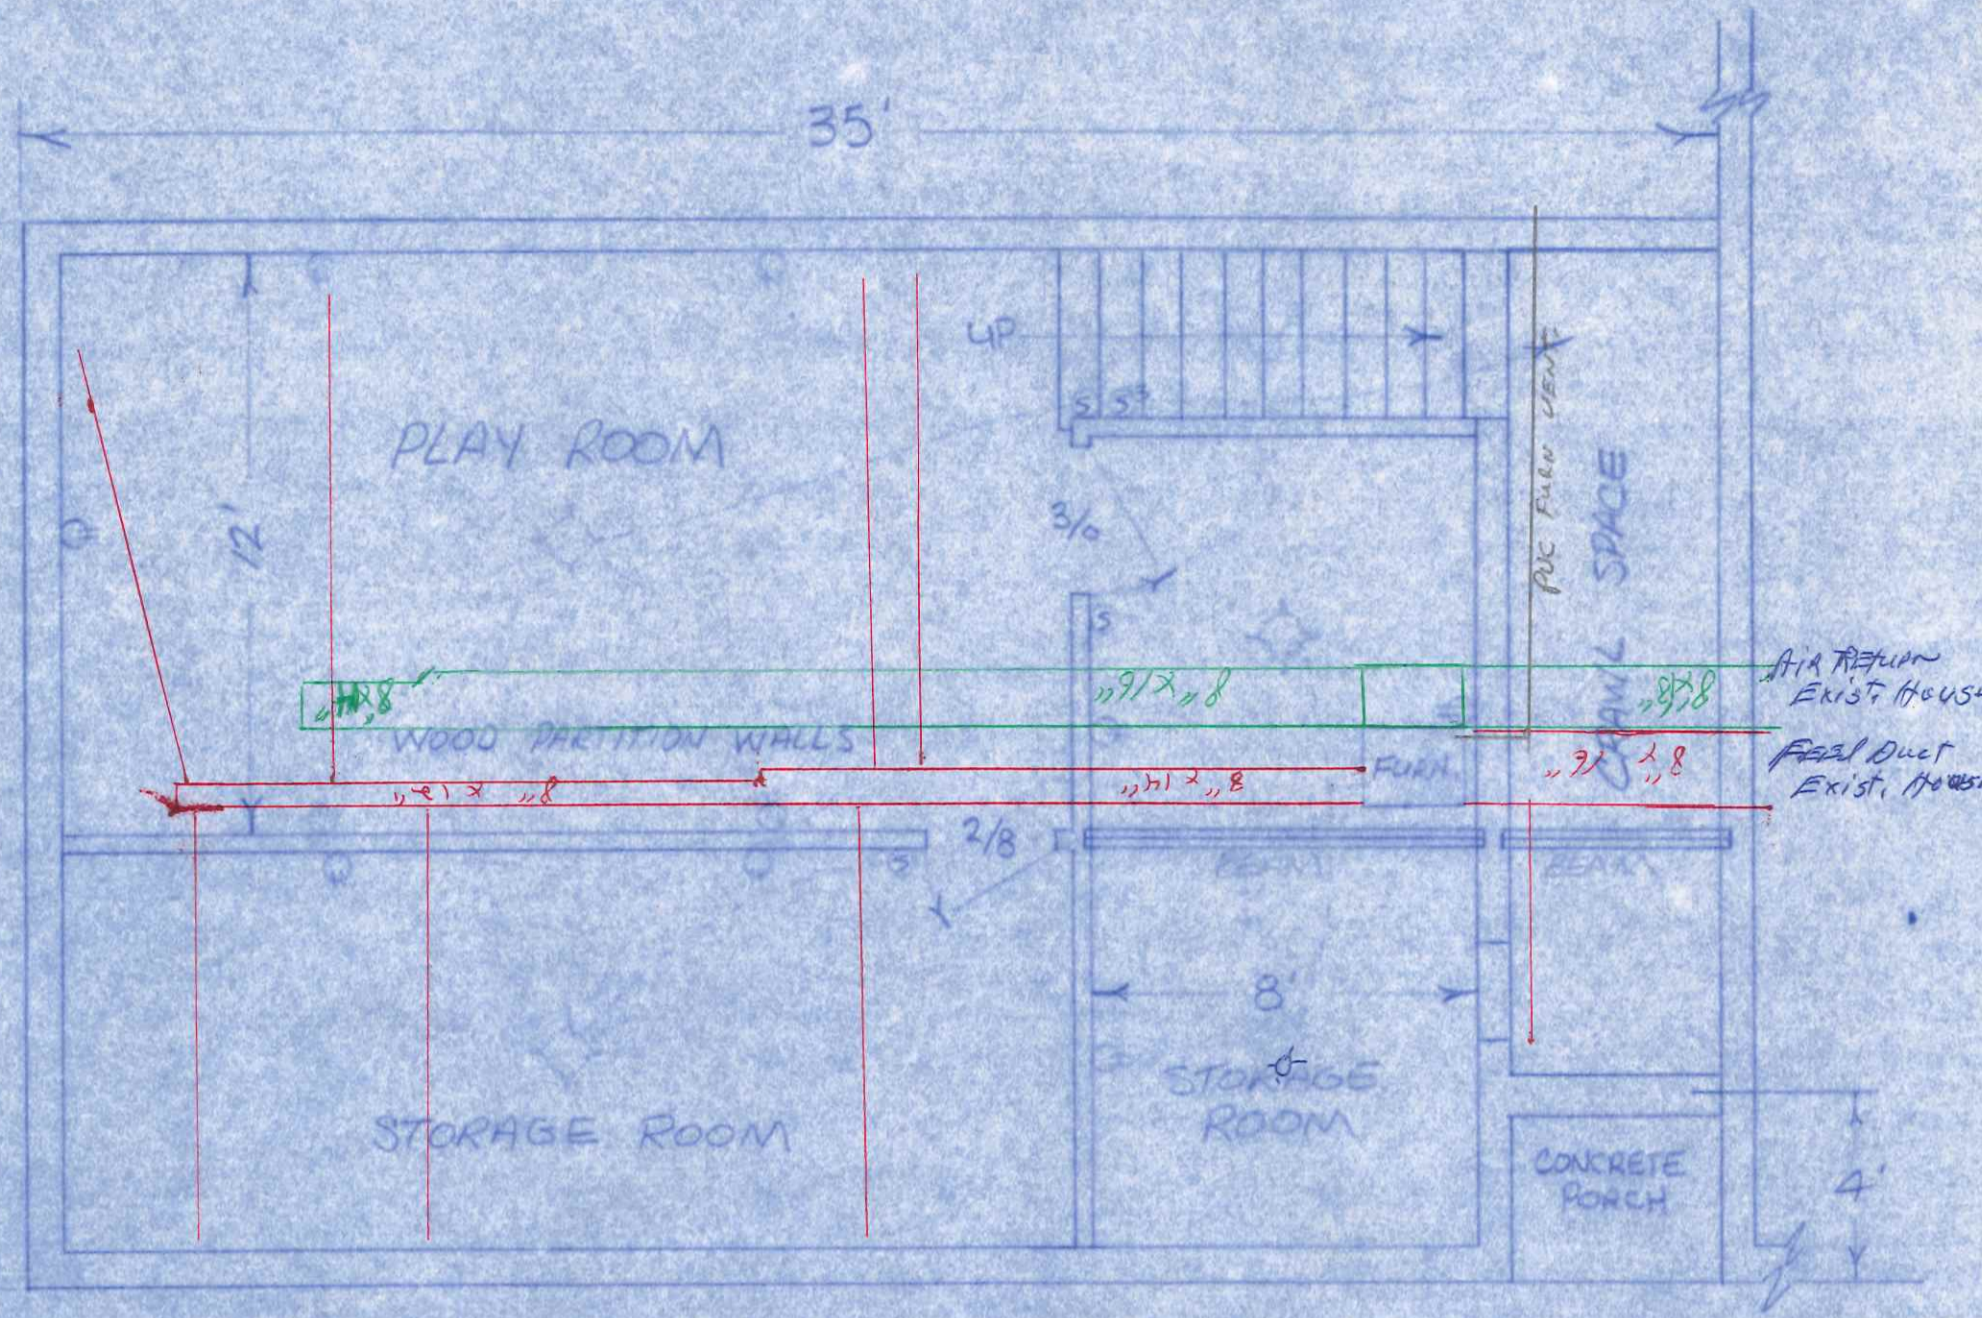

BASEMENT FLOOR PLAN

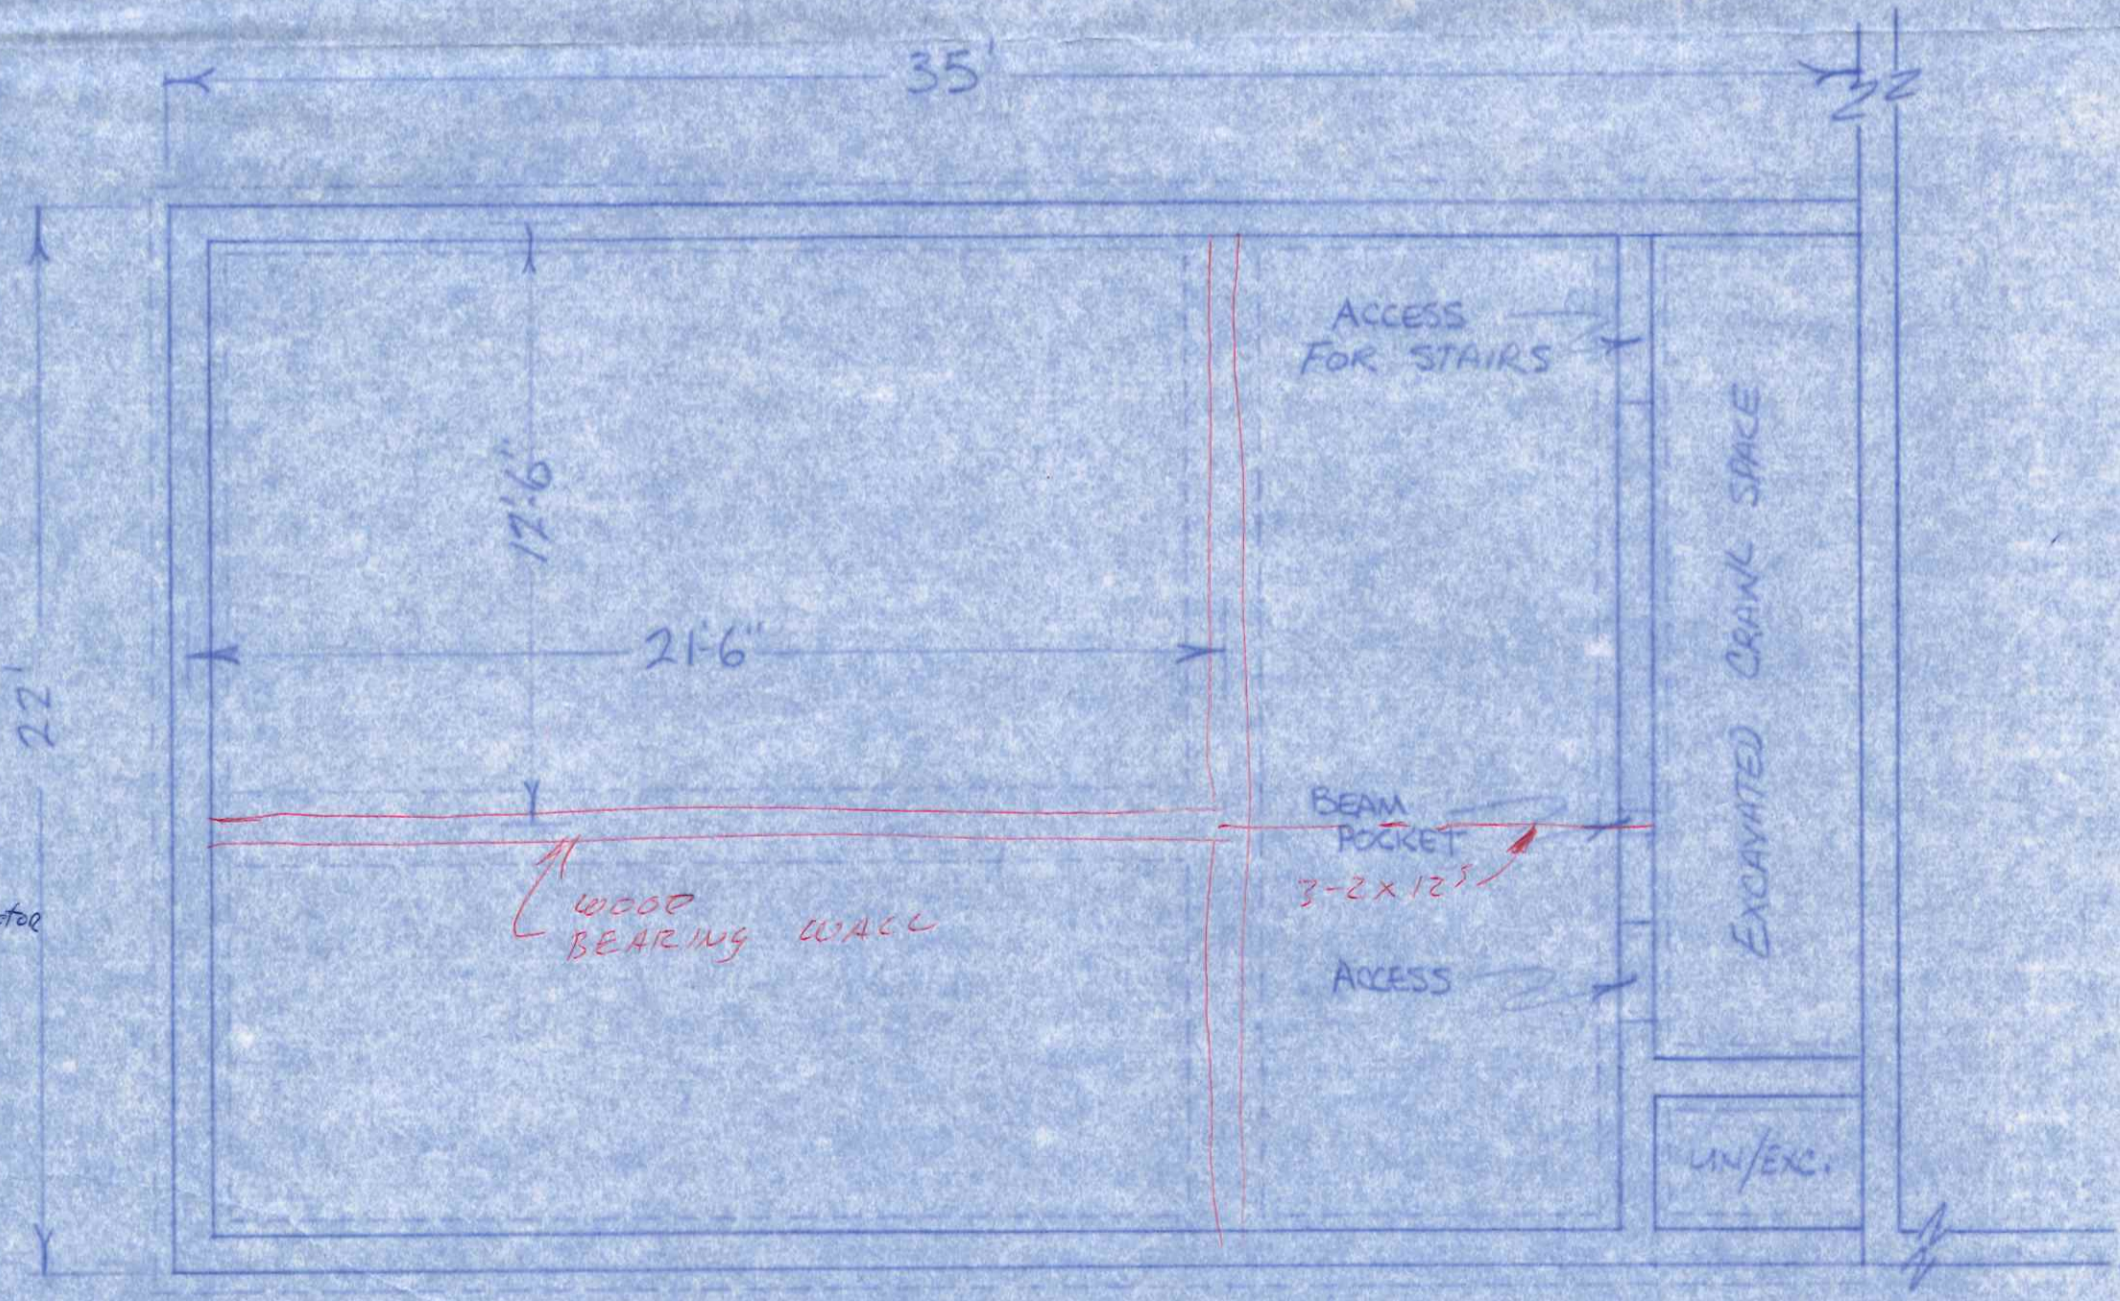

BASEMENT & FOUNDATION PLAN


SCALE
1/4" = 1'-0"

MR & MRS. GARY REBEAU
1415 GLENWOOD AVE.
NAPOLEON, OHIO 43545

HEATING NOTES:

- ① FURNANCE TO BE NAT. GAS High EFF. 100,000 input 90,000 + output
- ② - RED LINES TO BE APP. LOCATION HEAT RUNS
- ③ GREEN LINES TO BE APP. LOCATION AIR RETURN
- ④ BLACK LINE PVC FURNANCE VENT TO OUTSIDE WALL

- Electrical NOTES + symbols:
- ⊙ Electrically supplied smoke detector
 - ⊖ 110 VOLT 15 AMP REC.
 - ⊕ GROUND FAULT CIRCUIT (GFCI) INTERRUPTER REC.

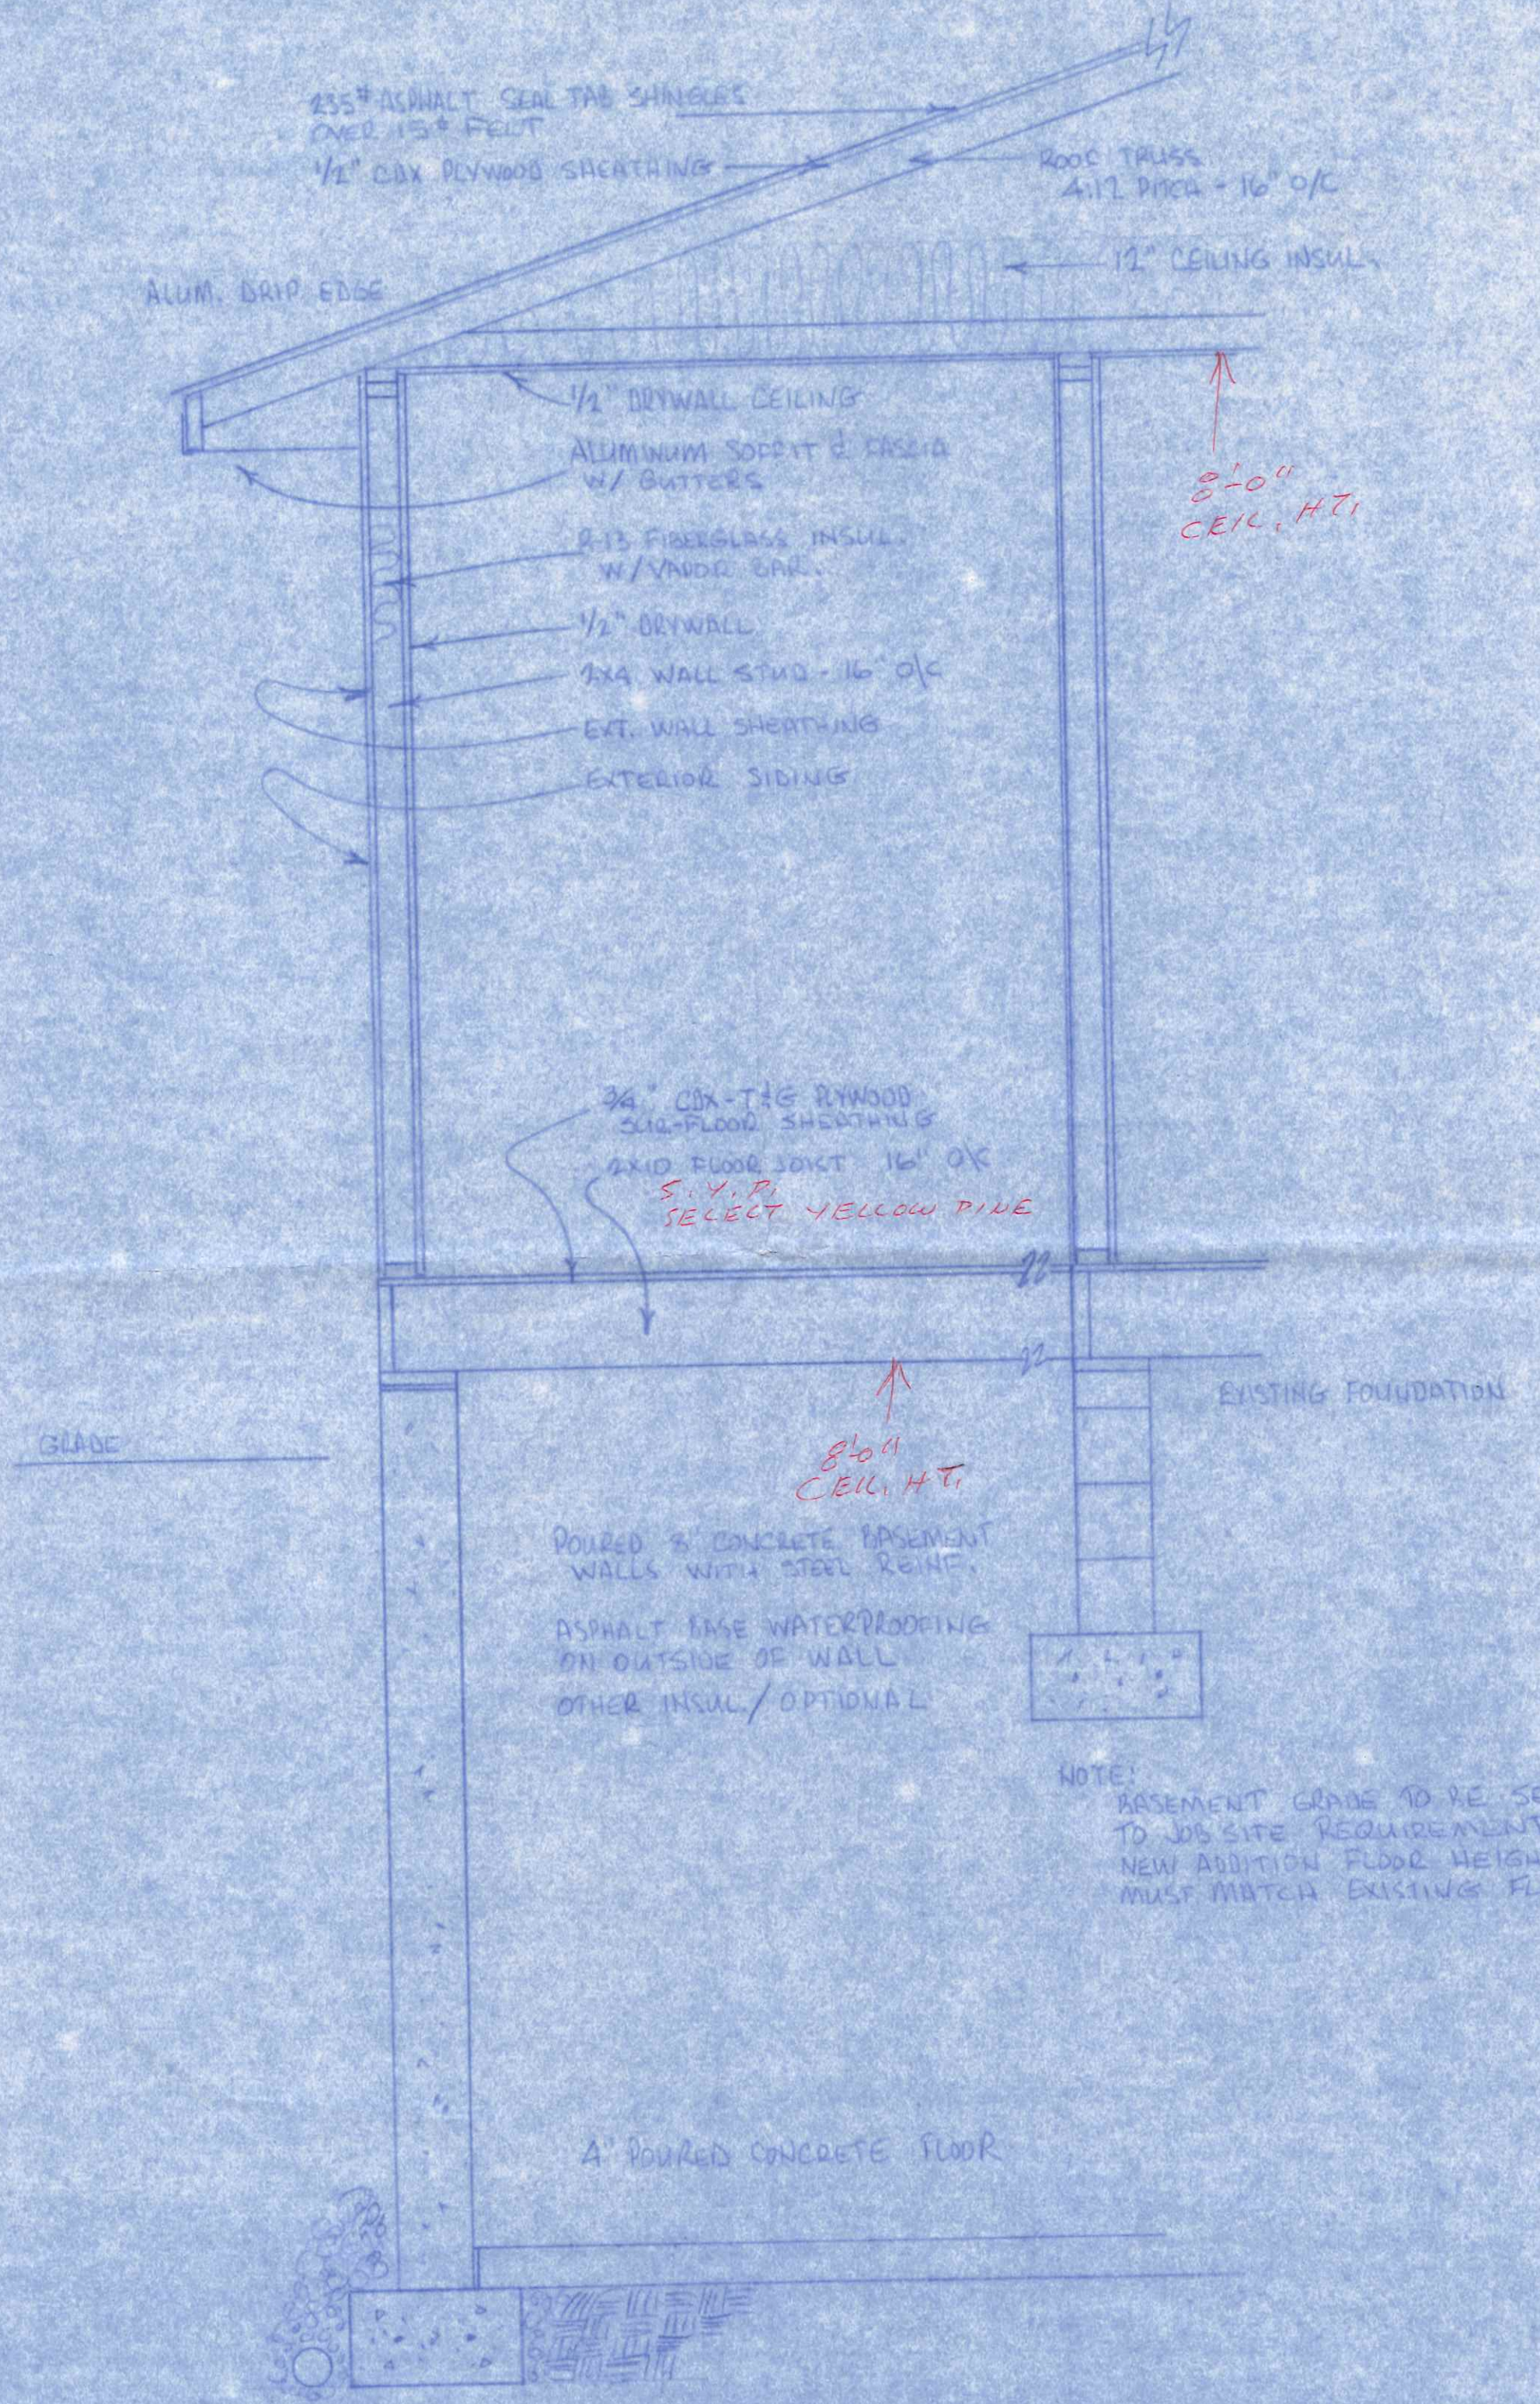

SECTION OF WALLS
SCALE 3/4" = 1'-0"

