


AMERICAN LEGION

BERT G. TAYLOR POST 300

SIGNATURES OF THE BUILDING COMMITTEE FOR THE APPROVAL OF THE PLANS AND SPECIFICATIONS

_____	_____
_____	_____
_____	_____
_____	_____
_____	_____
_____	_____
_____	_____
_____	_____

DATE

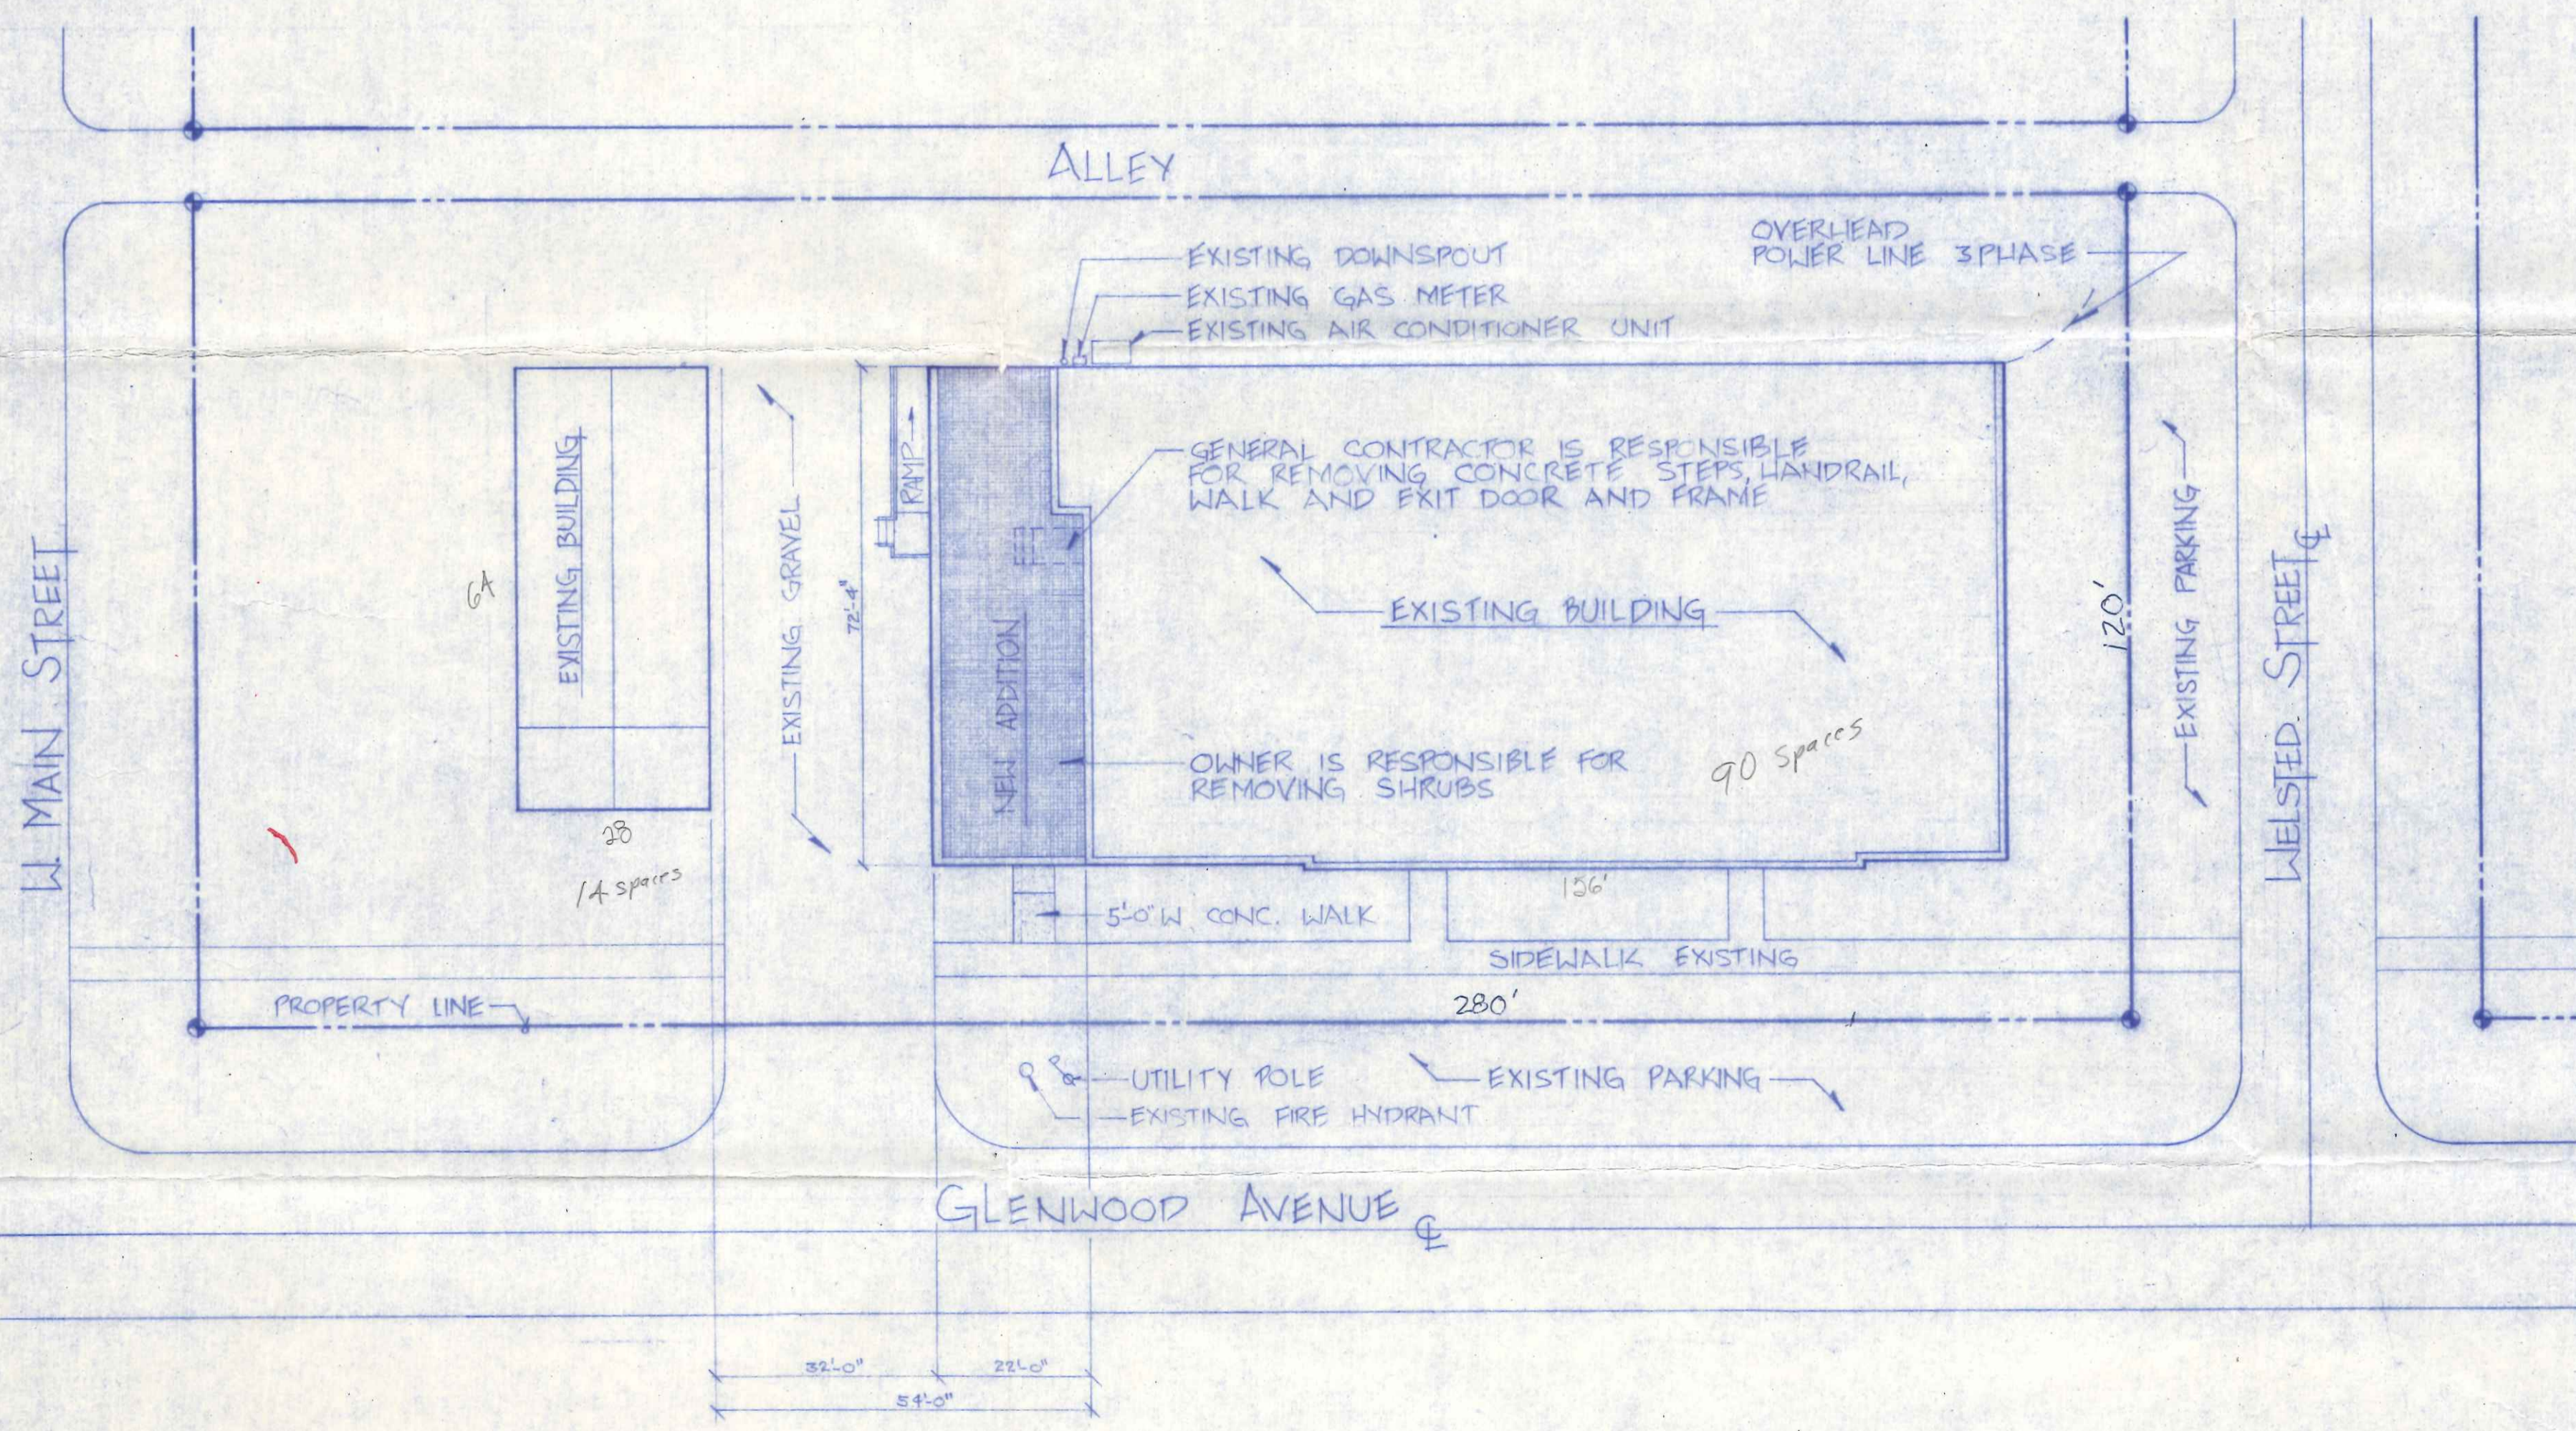


ABBREVIATIONS

ACOUS.	Acoustical	INSUL.	Insulation
ADJ.	Adjustable	INT.	Interior
ALT.	Alternate	JST.	Joist
ALUM.	Aluminum	JT.	Joint
APPROX.	Approximate	LAM.	Laminated
ARCH.	Architect	LAV.	Lavatory
BD.	Board	M.C.	Mechanical Contractor
BLDG.	Building	M.O.	Masonry Opening
BLK.	Block	MT'L	Meta'l
B.N.	Bull Nose	N.I.C.	Not-In-Contract
C/C	Center to Center	N.T.S.	Not To Scale
CLG.	Ceiling	O/C	On Center
CLR.	Clear	OPN'G	Opening
C.O.	Clean Out	P.C.	Plumbing Contractor
COL.	Column	PL.	Plate
CONC.	Concrete	PLAS.	Plaster
CONTR.	Contractor	PLYW'D	Plywood
CONTR.	Contractor	Q.T.	Quarry Tile
C.W.	Cold Water	REINF.	Reinforcing
DET.	Detail	REQ'D	Required
D.F.	Drinking Fountain	RM.	Room
DIM.	Dimension	R.O.	Rough Opening
D.S.	Downspout	S.C.	Solid Core
E.C.	Electrical Contractor	S.M.	Solid Masonry
ELEV.	Elevation	S.S.	Stainless Steel
E.W.	Each Way	ST'L	Steel
E.W.C.	Electric Water Cooler	STOR.	Storage
EXIST.	Existing	SUSP.	Suspended
EXT.	Exterior	TEL.	Telephone
F.D.	Floor Drain	TOIL.	Toilet
F.E.	Fire Extinguisher	URN.	Urinal
FIN.	Finish	U.V.	Unit Ventilator
FLR.	Floor	V.A.T.	Vinyl Asbestos Tile
FLUOR.	Fluorescent	W/	With
FOUND.	Foundation	W.C.	Water Closet
FT.	Foot or Feet	WD.	Wood
GALV.	Galvanized	W.P.	White Pine
G.C.	General Contractor		
GL.	Glass or Glazed		
HGT.	Height		
H.M.	Hollow Metal		
H.V.A.C.	Heating, Ventilating, Air Conditioning		
H.W.	Hot Water		

CROSS REFERENCE LEGEND



MATERIAL LEGEND

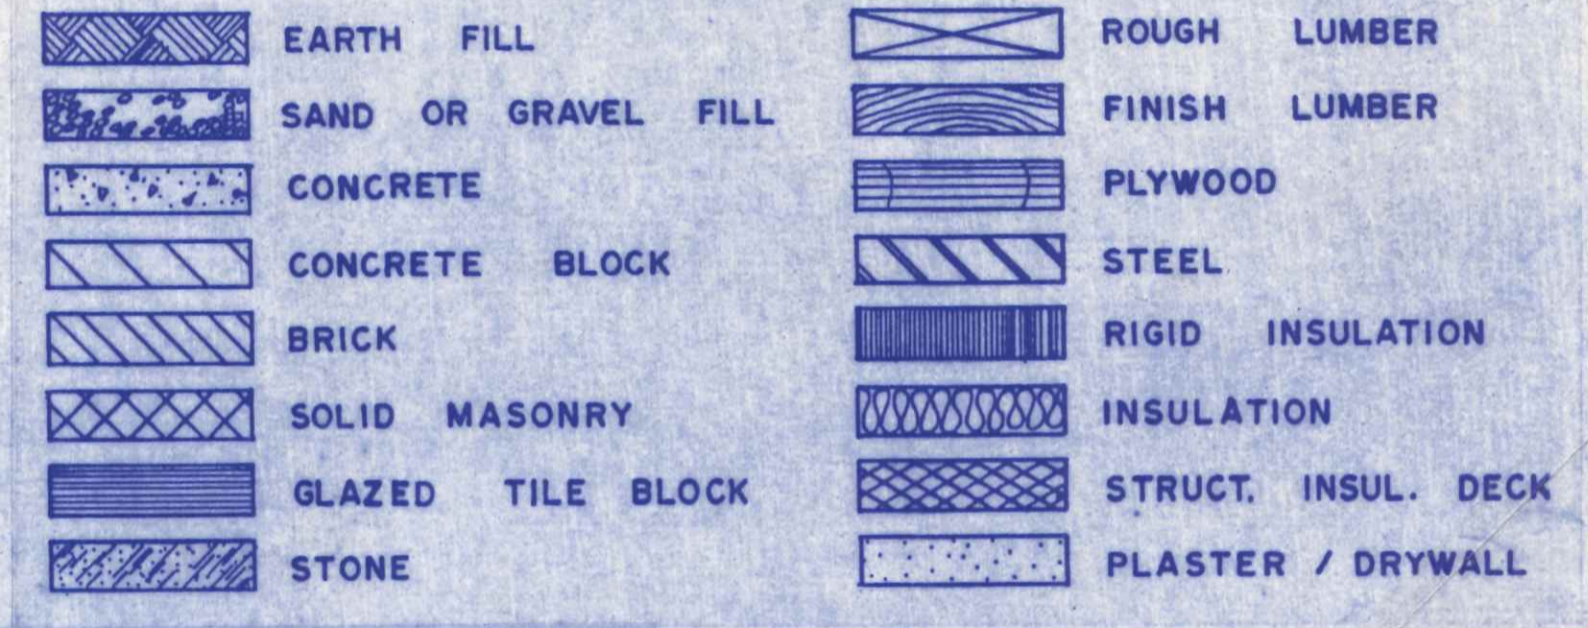

OBBC DESIGN REQUIREMENTS

1. Building Use Group	A-2
2. Construction Type	3-B
3. Floor Area	1507 SF
4. Occupancy Load	325

STRUCTURAL DESIGN CRITERIA

1. Soil Bearing Capacity	3,000 PSF
2. Floor Loading	
Live Load	
Dead Load	
TOTAL	
3. Roof Loading	
Live Load	25 PSF
Dead Load	25 PSF
TOTAL	50 PSF
4. Wind Load	17 PSF


DRAWING INDEX

G-1	PLOT PLAN
G-2	FOUNDATION PLAN & DETAILS
G-3	FLOOR PLAN & SCHEDULES
G-4	EXT. ELEVATIONS & SECTIONS
G-5	BAR DETAILS
G-6	ROOF FRAMING PLAN & DETAILS
G-7	REFLECTED CEILING PLAN, ELECTRICAL, PLUMBING & MECHANICAL PLANS

PRINTED

AUG 20'87

Pastor & Beilharz

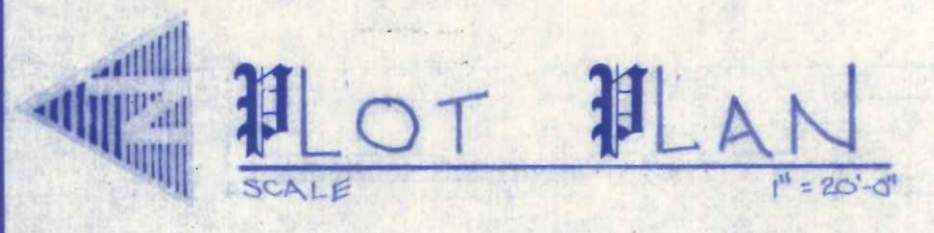

500 Glenwood

STATE OF OHIO
TERRY E. BEILHARZ
REGISTERED ARCHITECT
3860

PLOT PLAN
AMERICAN LEGION Post 300
NAPOLÉON OHIO

pastor & beilharz associates, inc.
landscape architect - architect
701 1/2 w. first st. defiance, oh, 43512

dwg. no. **G-1**
of **7**