


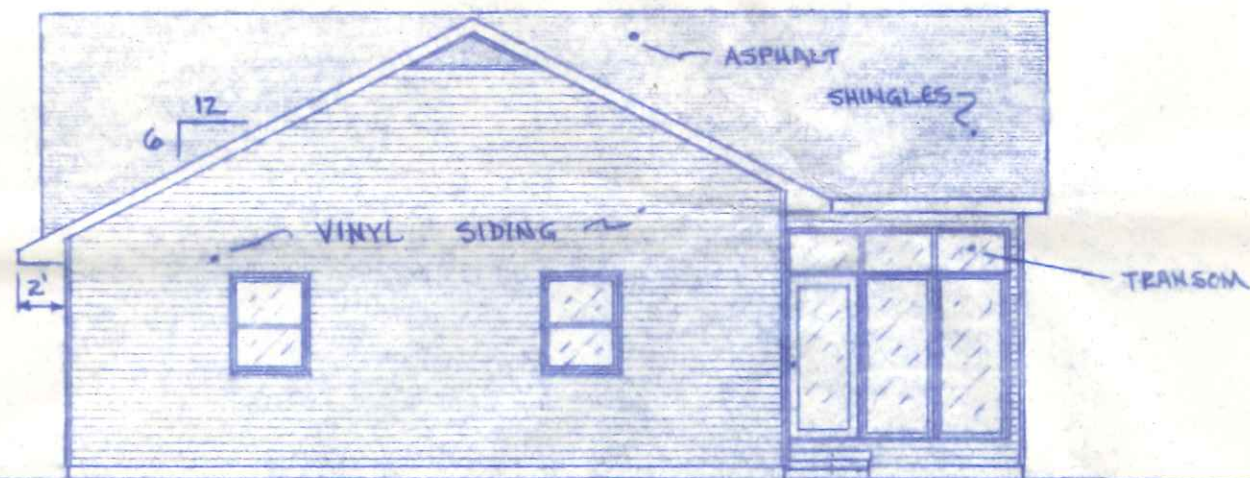


FRONT ELEVATION

1/4" = 1'-0"




REAR ELEVATION

1/8" = 1'-0"

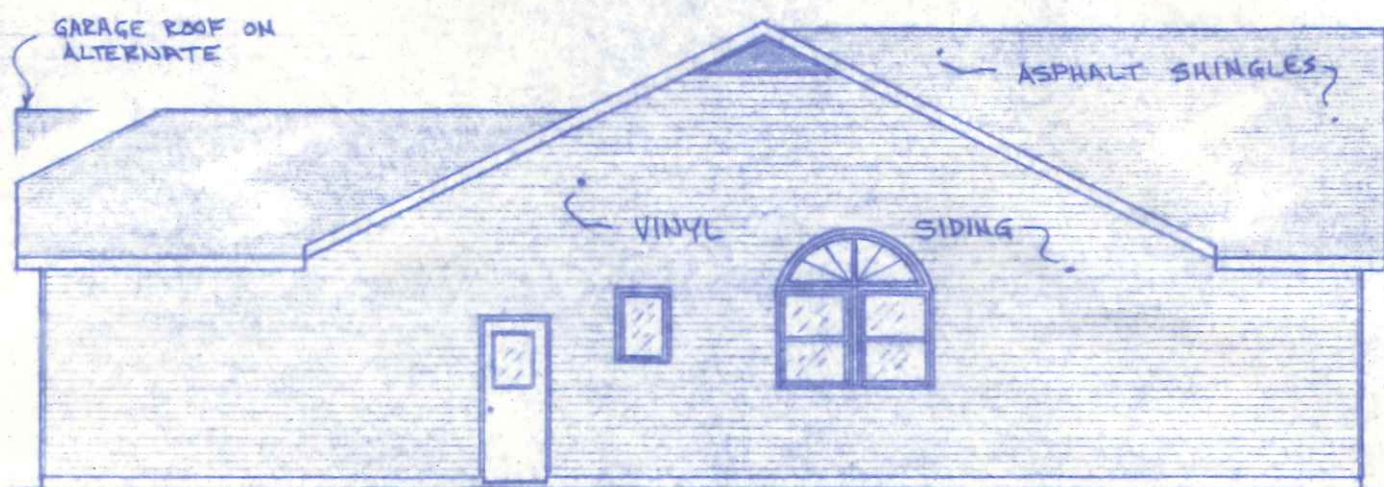

RIGHT SIDE ELEVATION


1/8" = 1'-0"

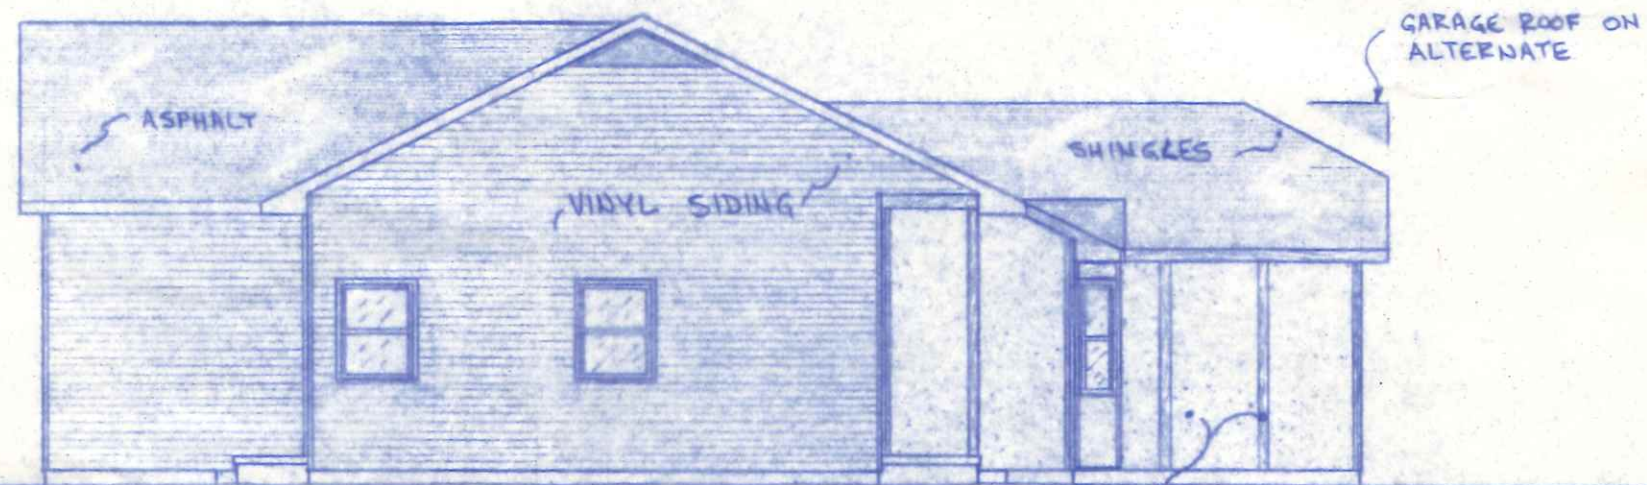

LEFT SIDE ELEVATION

1/8" = 1'-0"

STUCCO & ROUGH SAWN WOOD  
VINYL ON ALTERNATE.

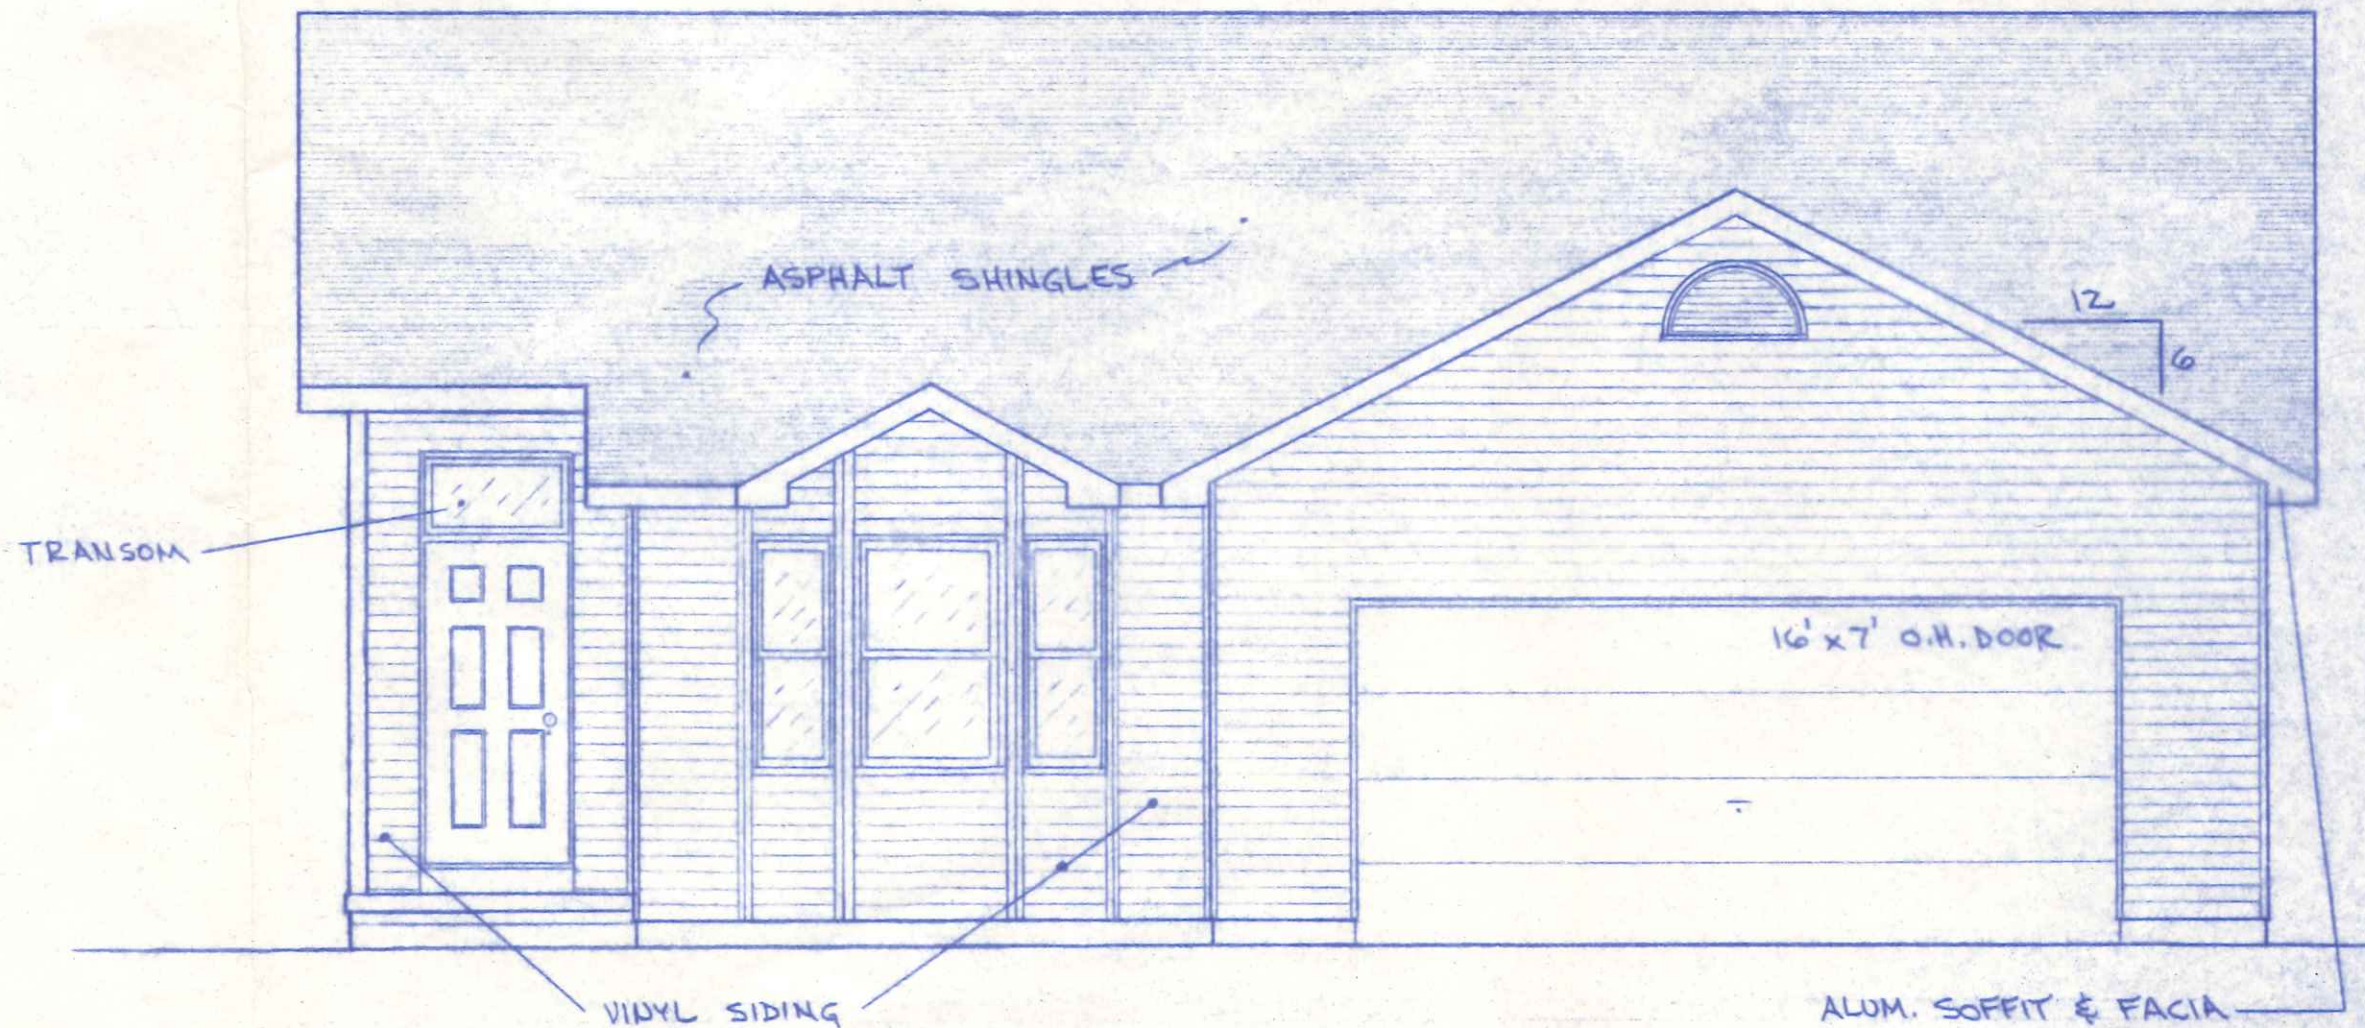


ALTERNATE FRONT ELEVATION

1/4" = 1'-0"



920 N. Harmony

BECKS CONSTRUCTION CO.		
ELEVATIONS		
DNW. EDS.	PLAN NO. 227	SHEET
SEPT. 1987		1 OF 4





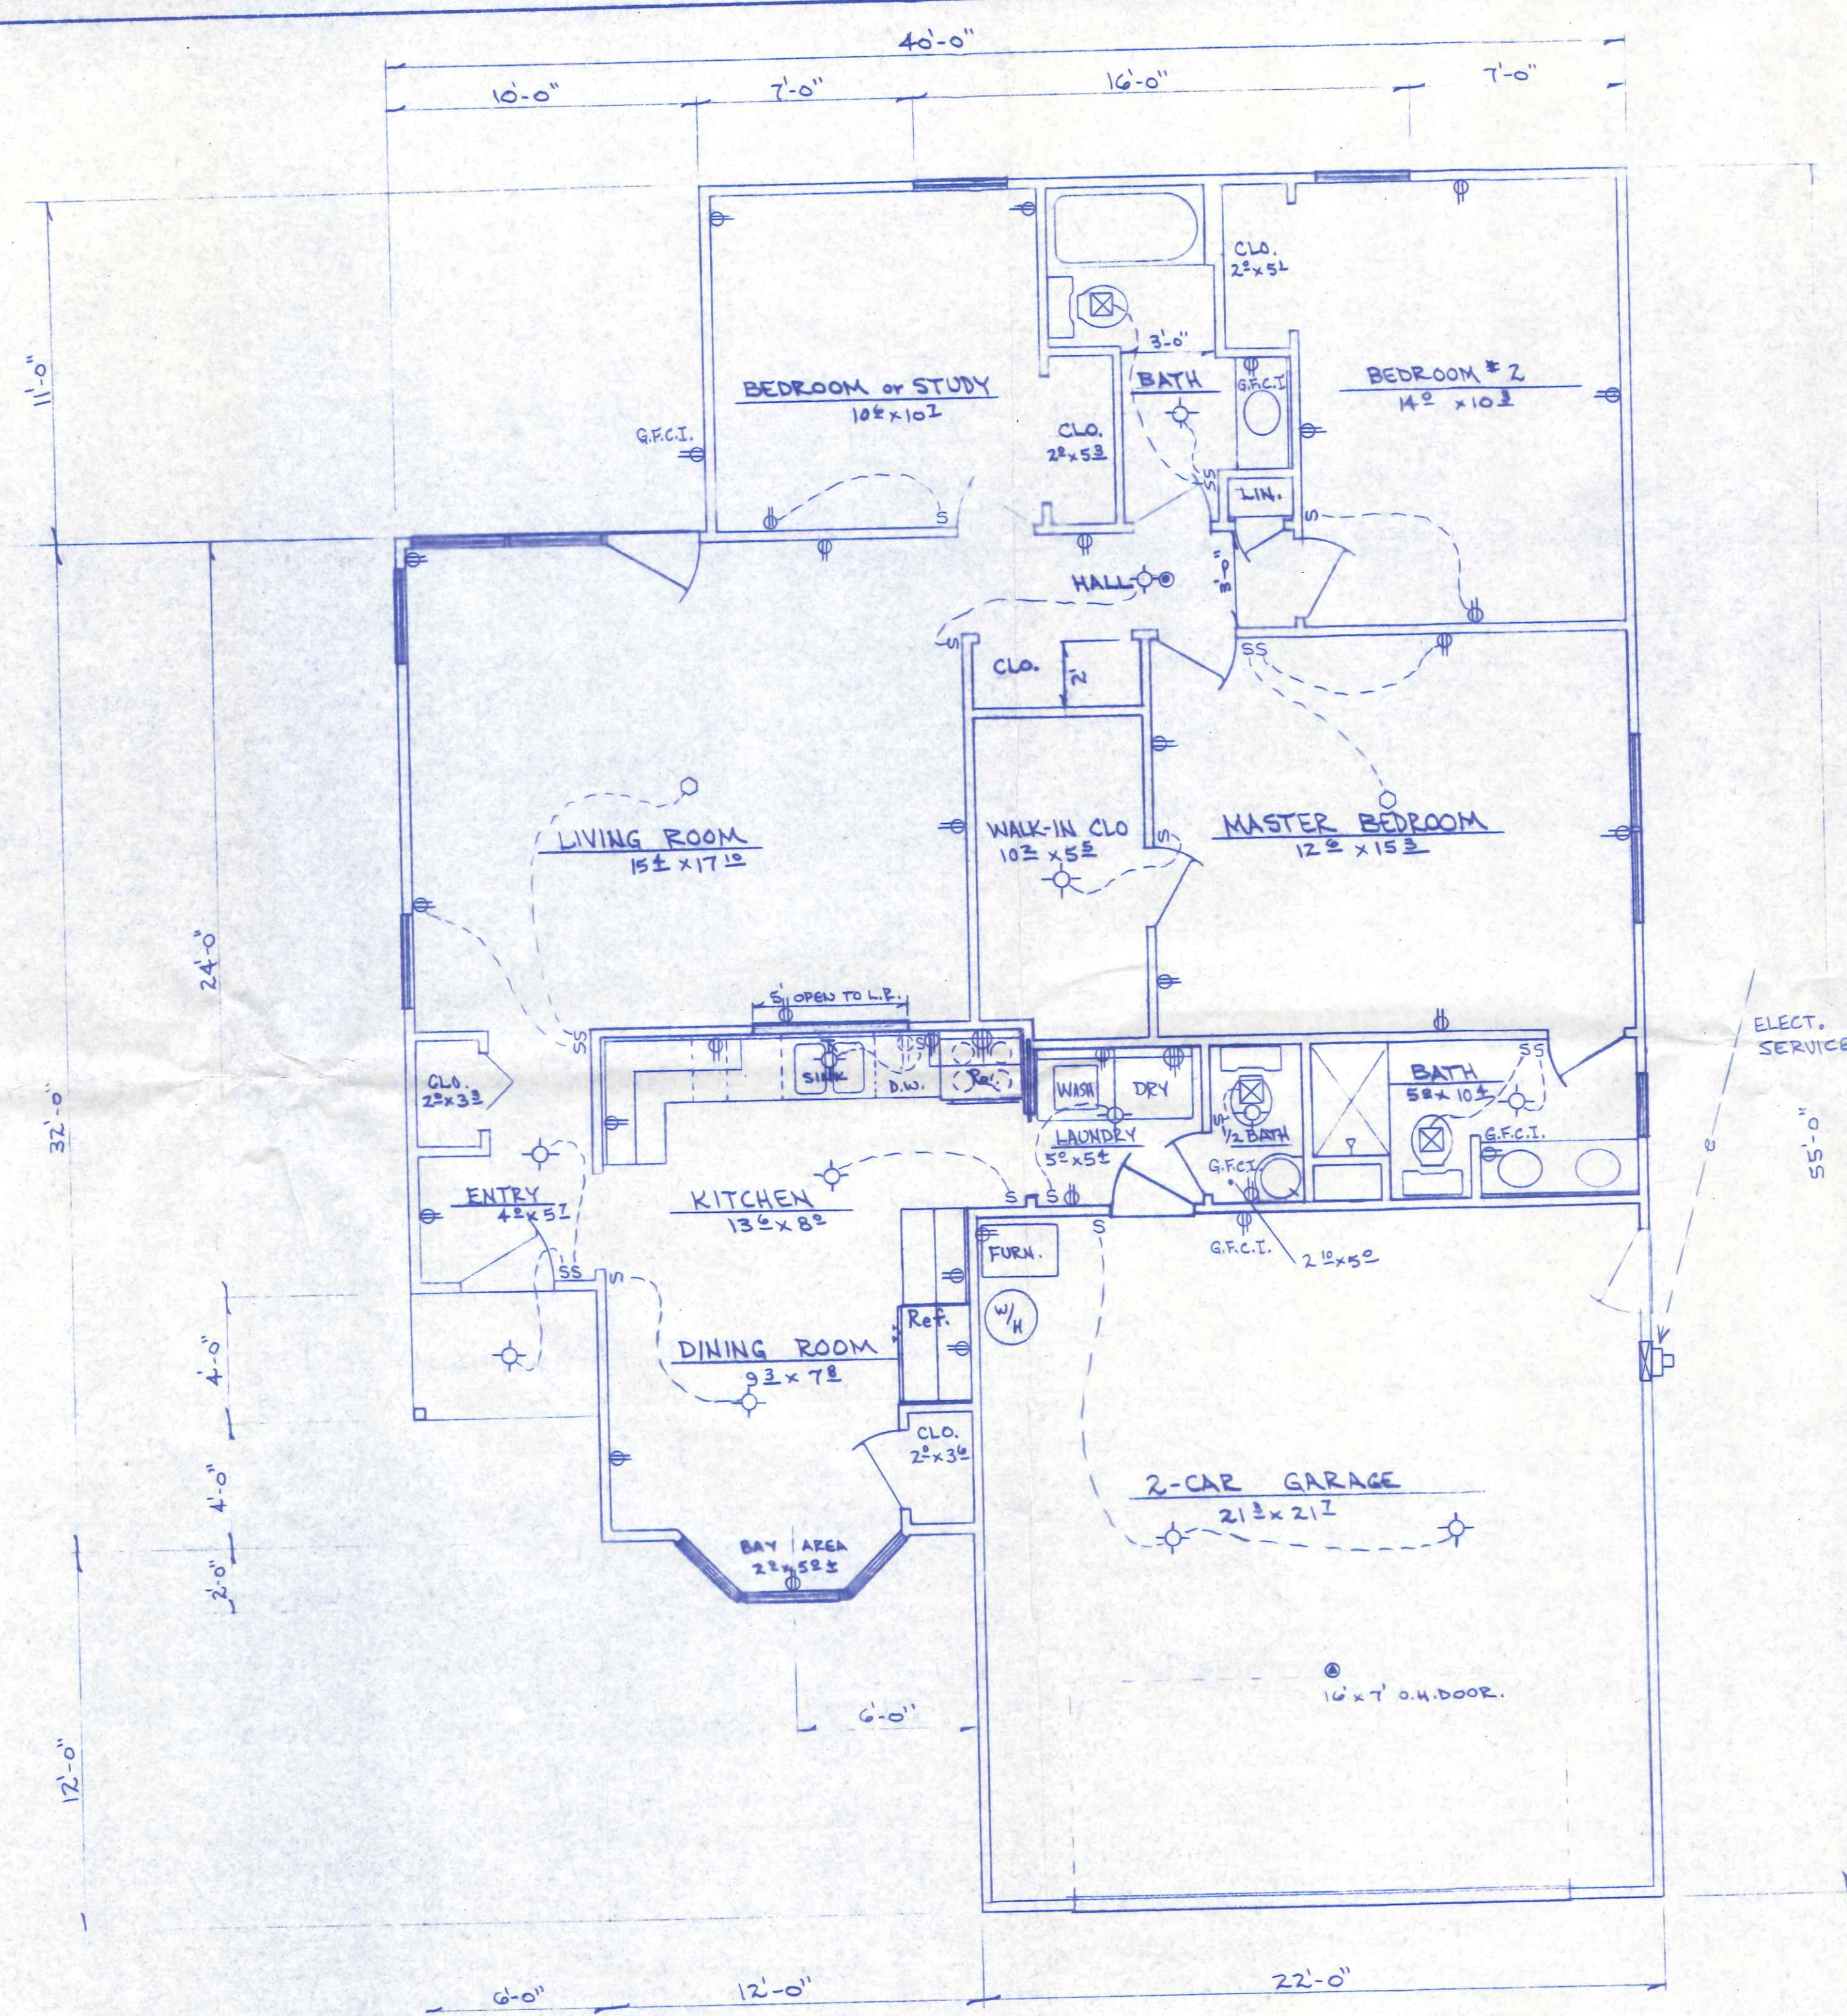

- ELECTRIC LEGEND**
- ⊖ = SWITCH
  - ⊕ = 110 V. OUTLET
  - ⊙ = LIGHT FIXTURE
  - ⊗ = SMOKE DETECTOR
  - ⊚ = GARAGE DOOR OPENER
  - ⊖ = 220 V. OUTLET
  - ⊠ = EXHAUST FAN (VENT TO OUTSIDE)
  - = CEILING FAN OUTLET

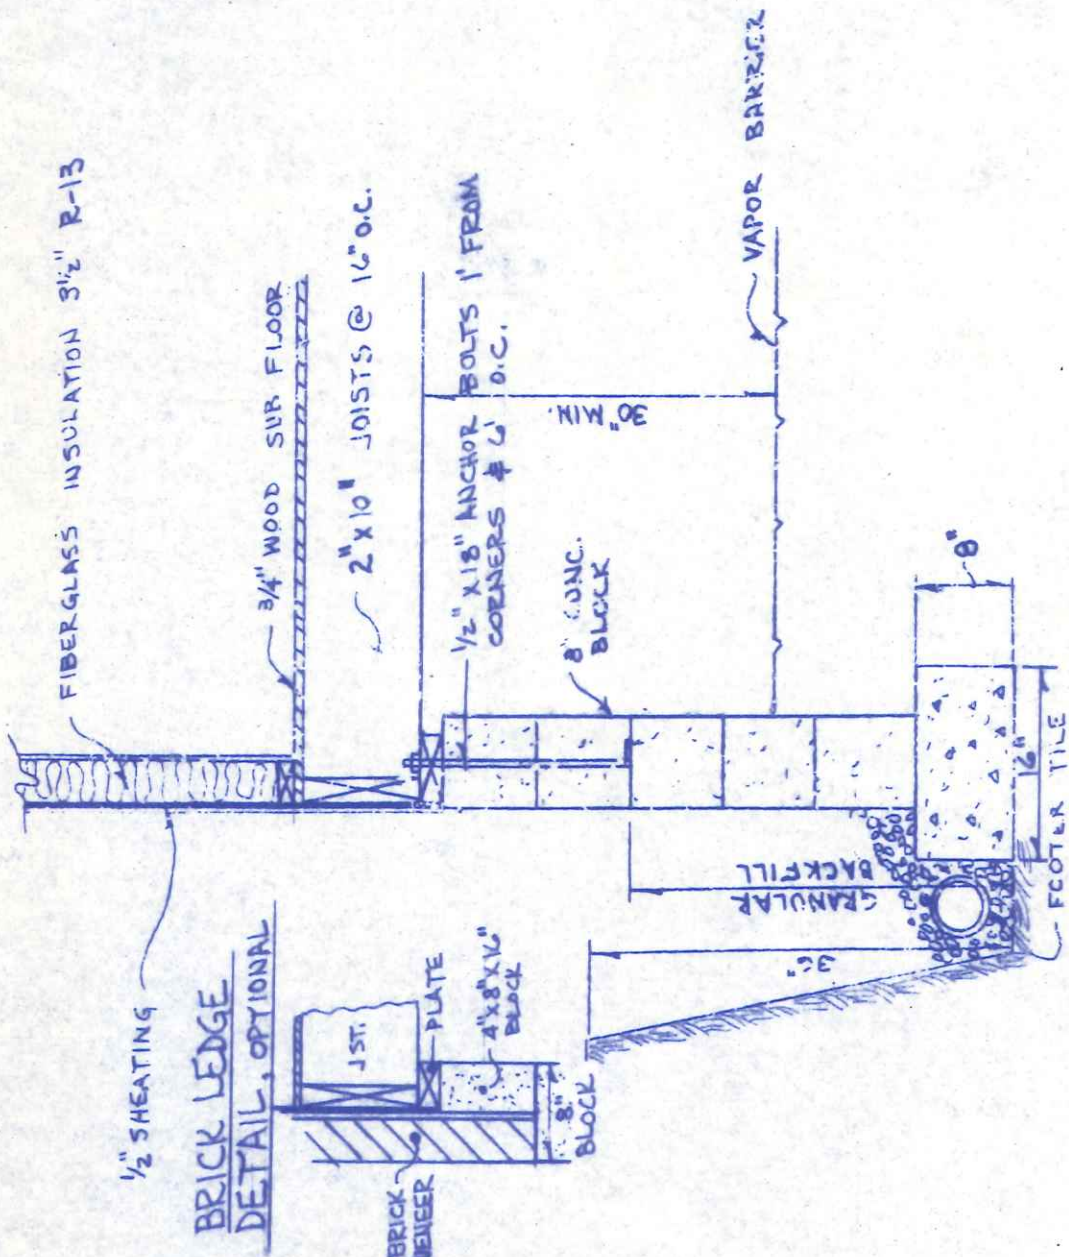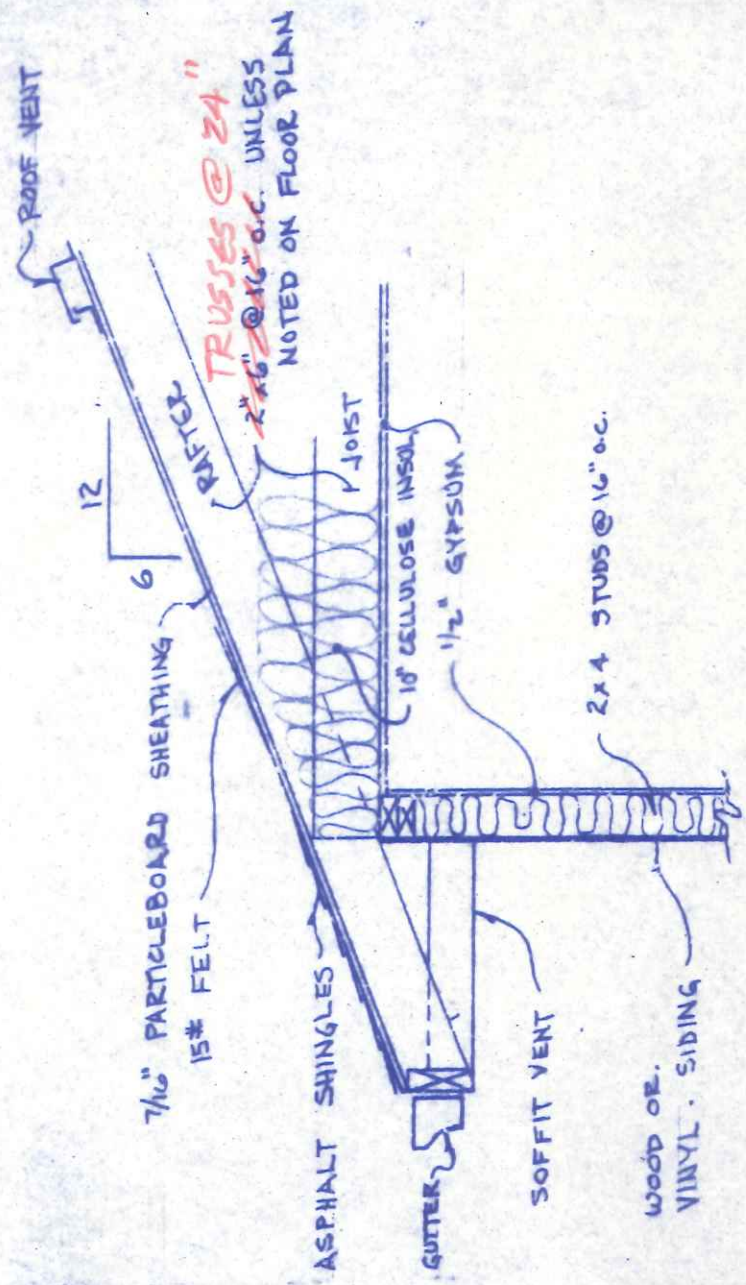

TYPICAL CROSS-SECTION  
3/4" = 1'-0"

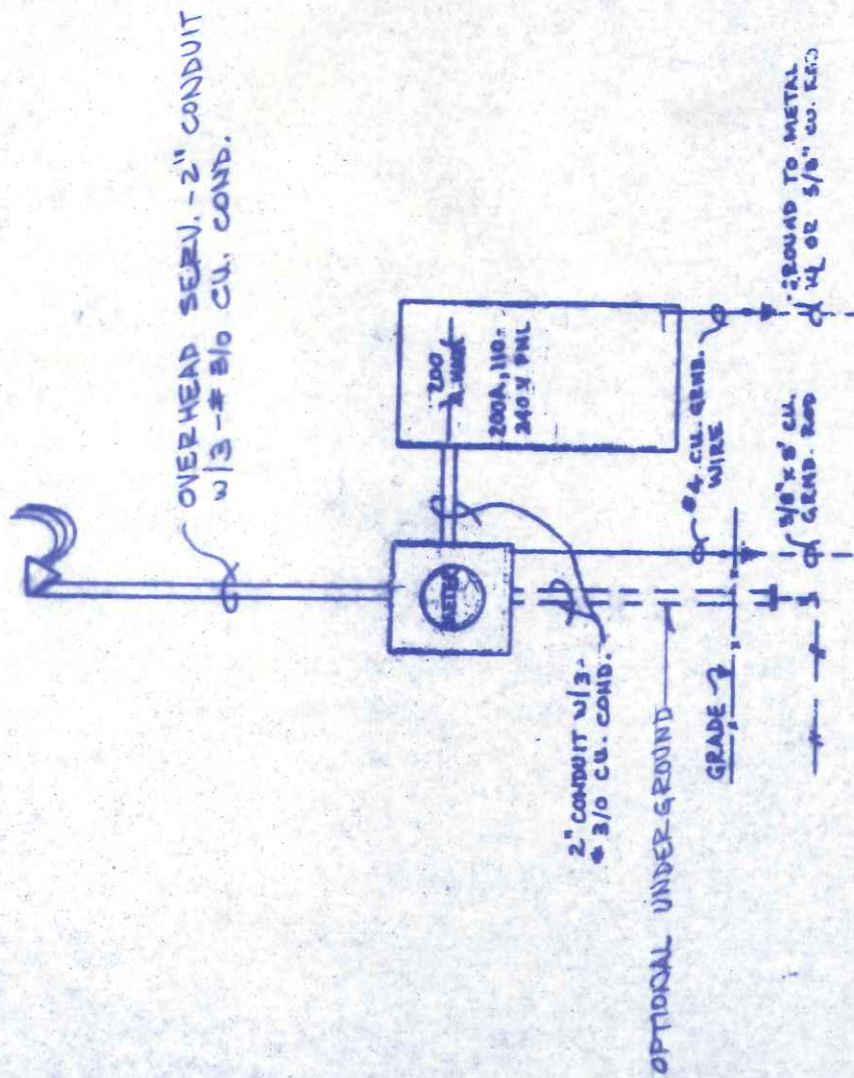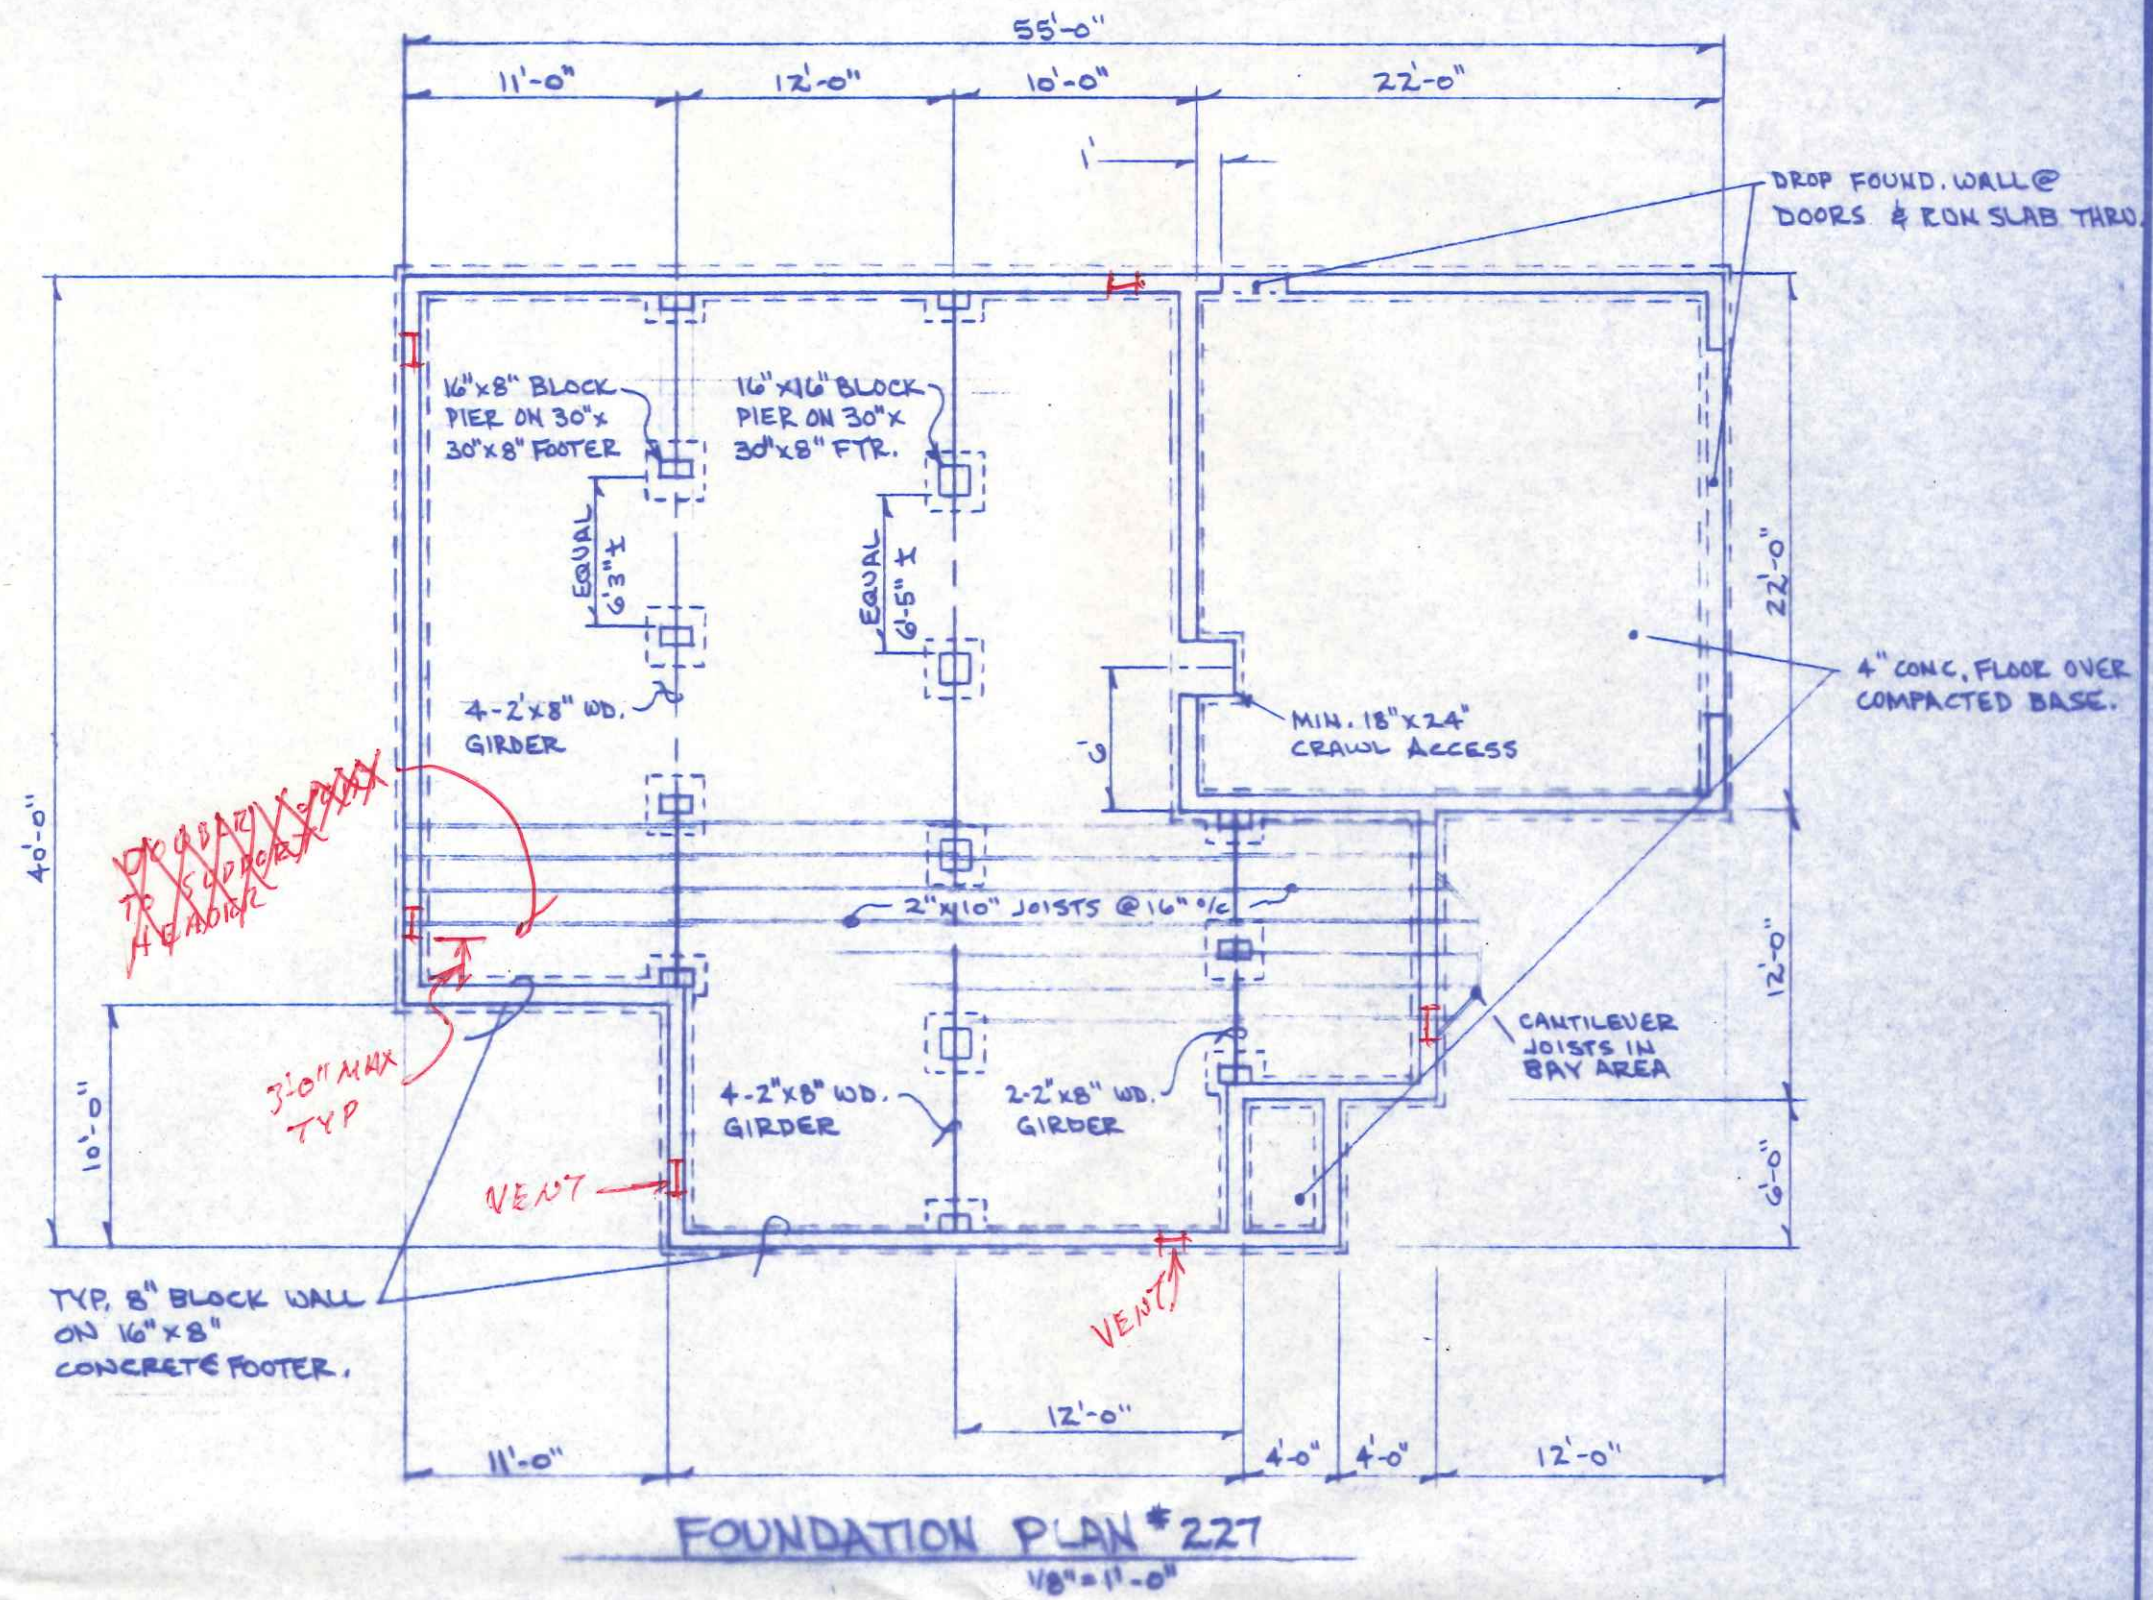

ELECTRICAL RISER DIAGRAM  
NO SCALE

BECKS CONSTRUCTION CO.		
DETAILS & SITE		
DWN. RDS SEPT. 1987	PLAN NO. 227	SHEET 4 OF 4