





FRONT ELEVATION

1/4" = 1'-0"

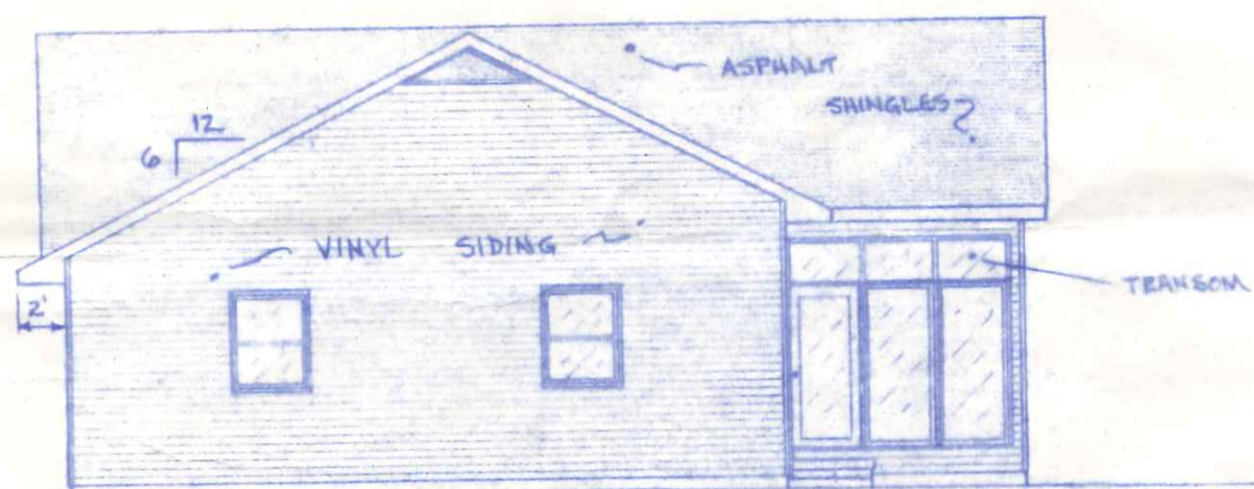


REAR ELEVATION

1/2" = 1'-0"

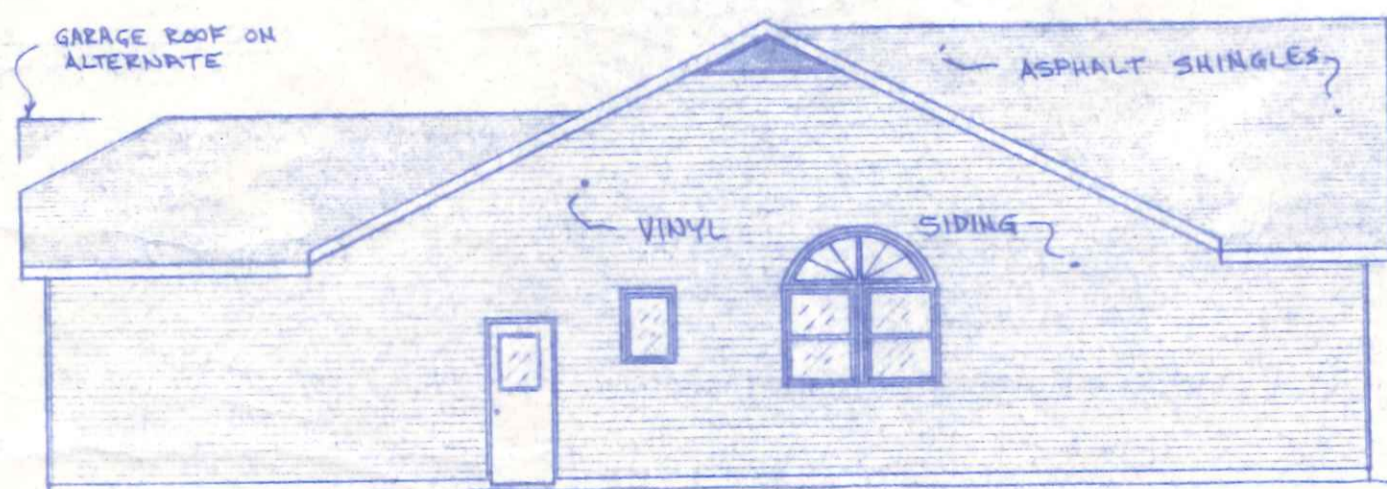

RIGHT SIDE ELEVATION


1/8" = 1'-0"

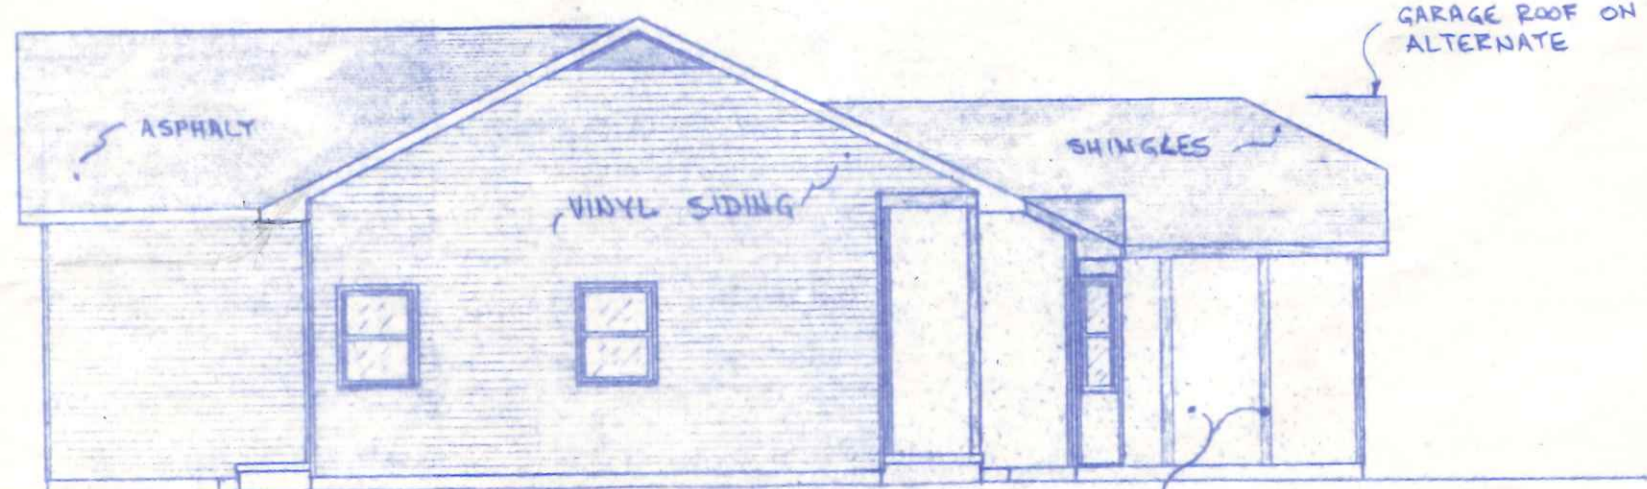

LEFT SIDE ELEVATION

1/8" = 1'-0"

STUCCO & ROUGH SAWN WOOD VINYL ON ALTERNATE.

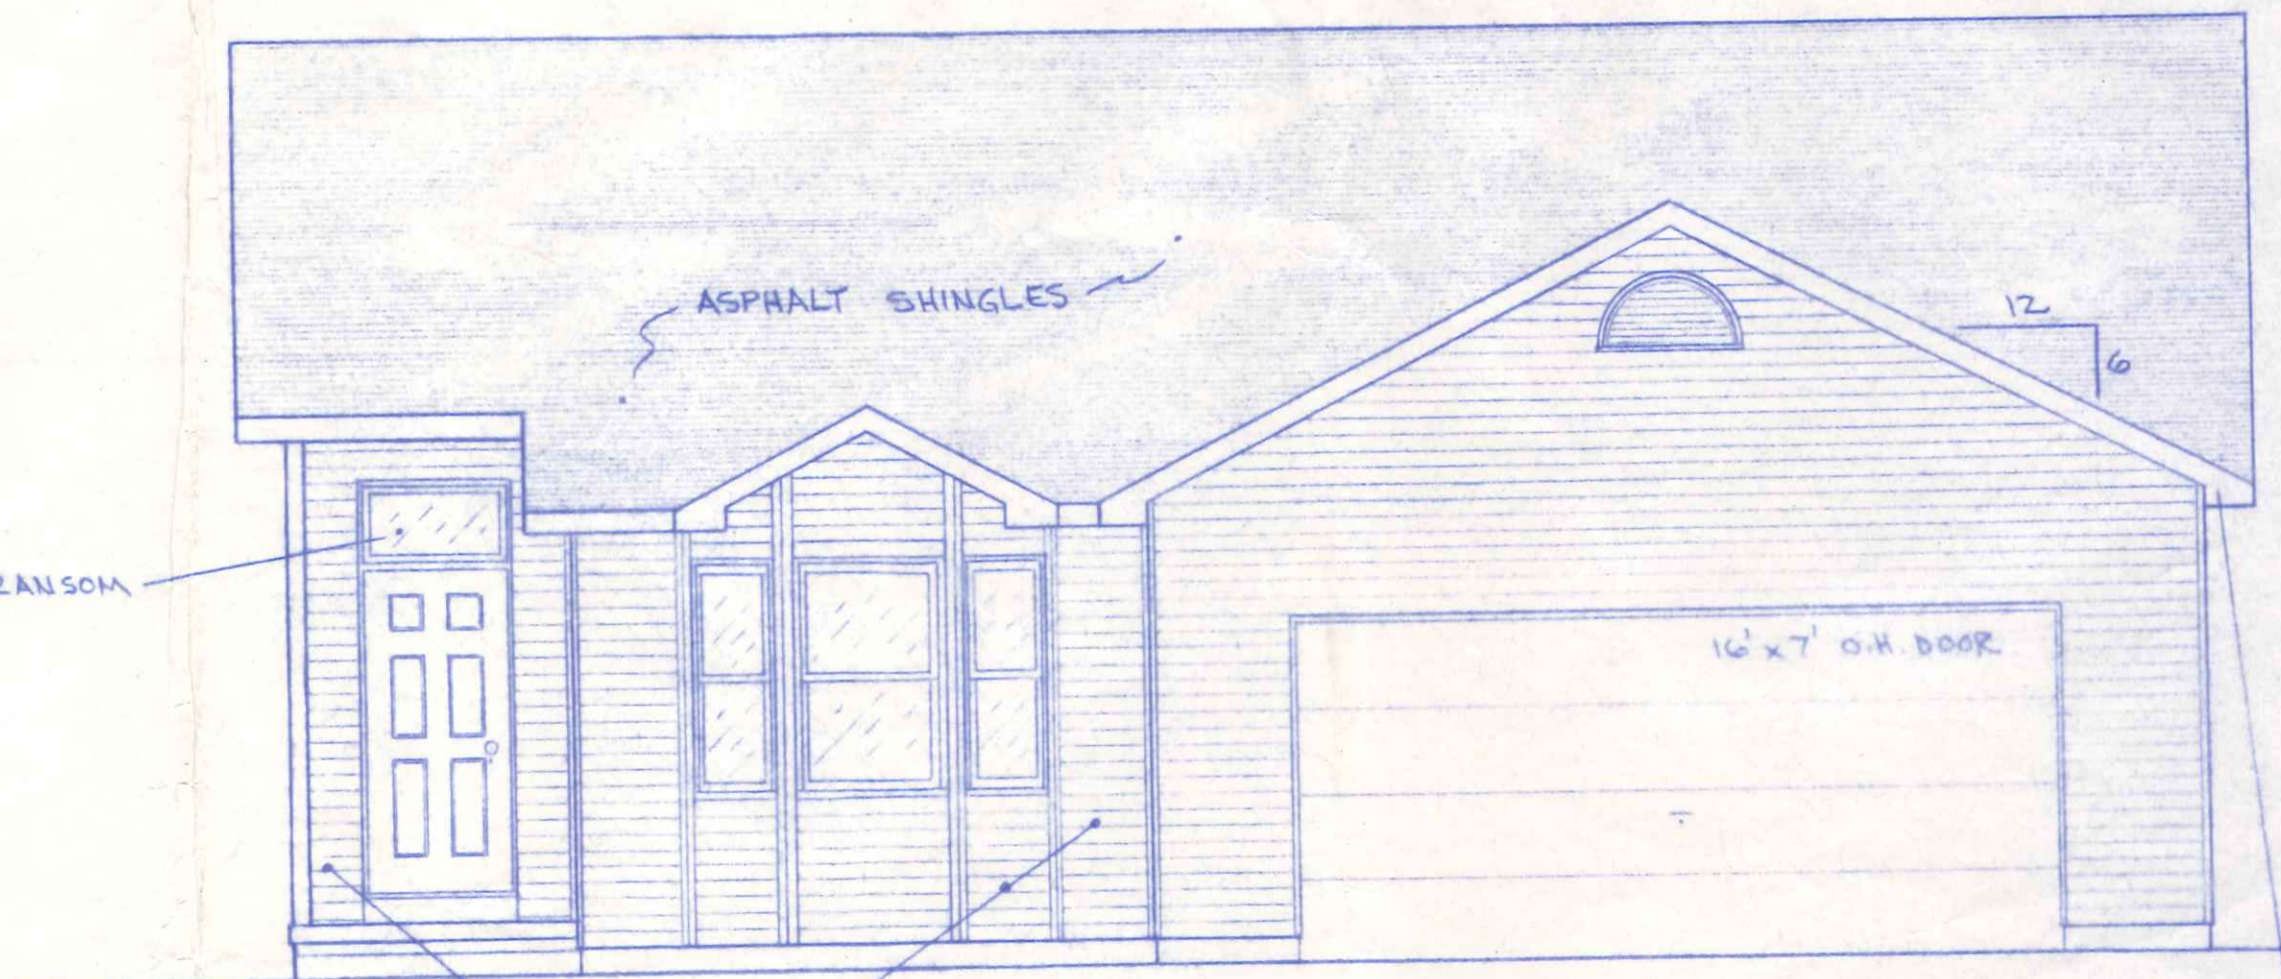

ALTERNATE FRONT ELEVATION


1/4" = 1'-0"

ALUM. SOFFIT & FASCIA

950 N. Harmony

BUILDING INSPECTOR COPY


BECKS CONSTRUCTION CO.		
ELEVATIONS		
DOM. EDS.	PLAN NO. 227	SHEET
SEPT. 1987		1 OF 4

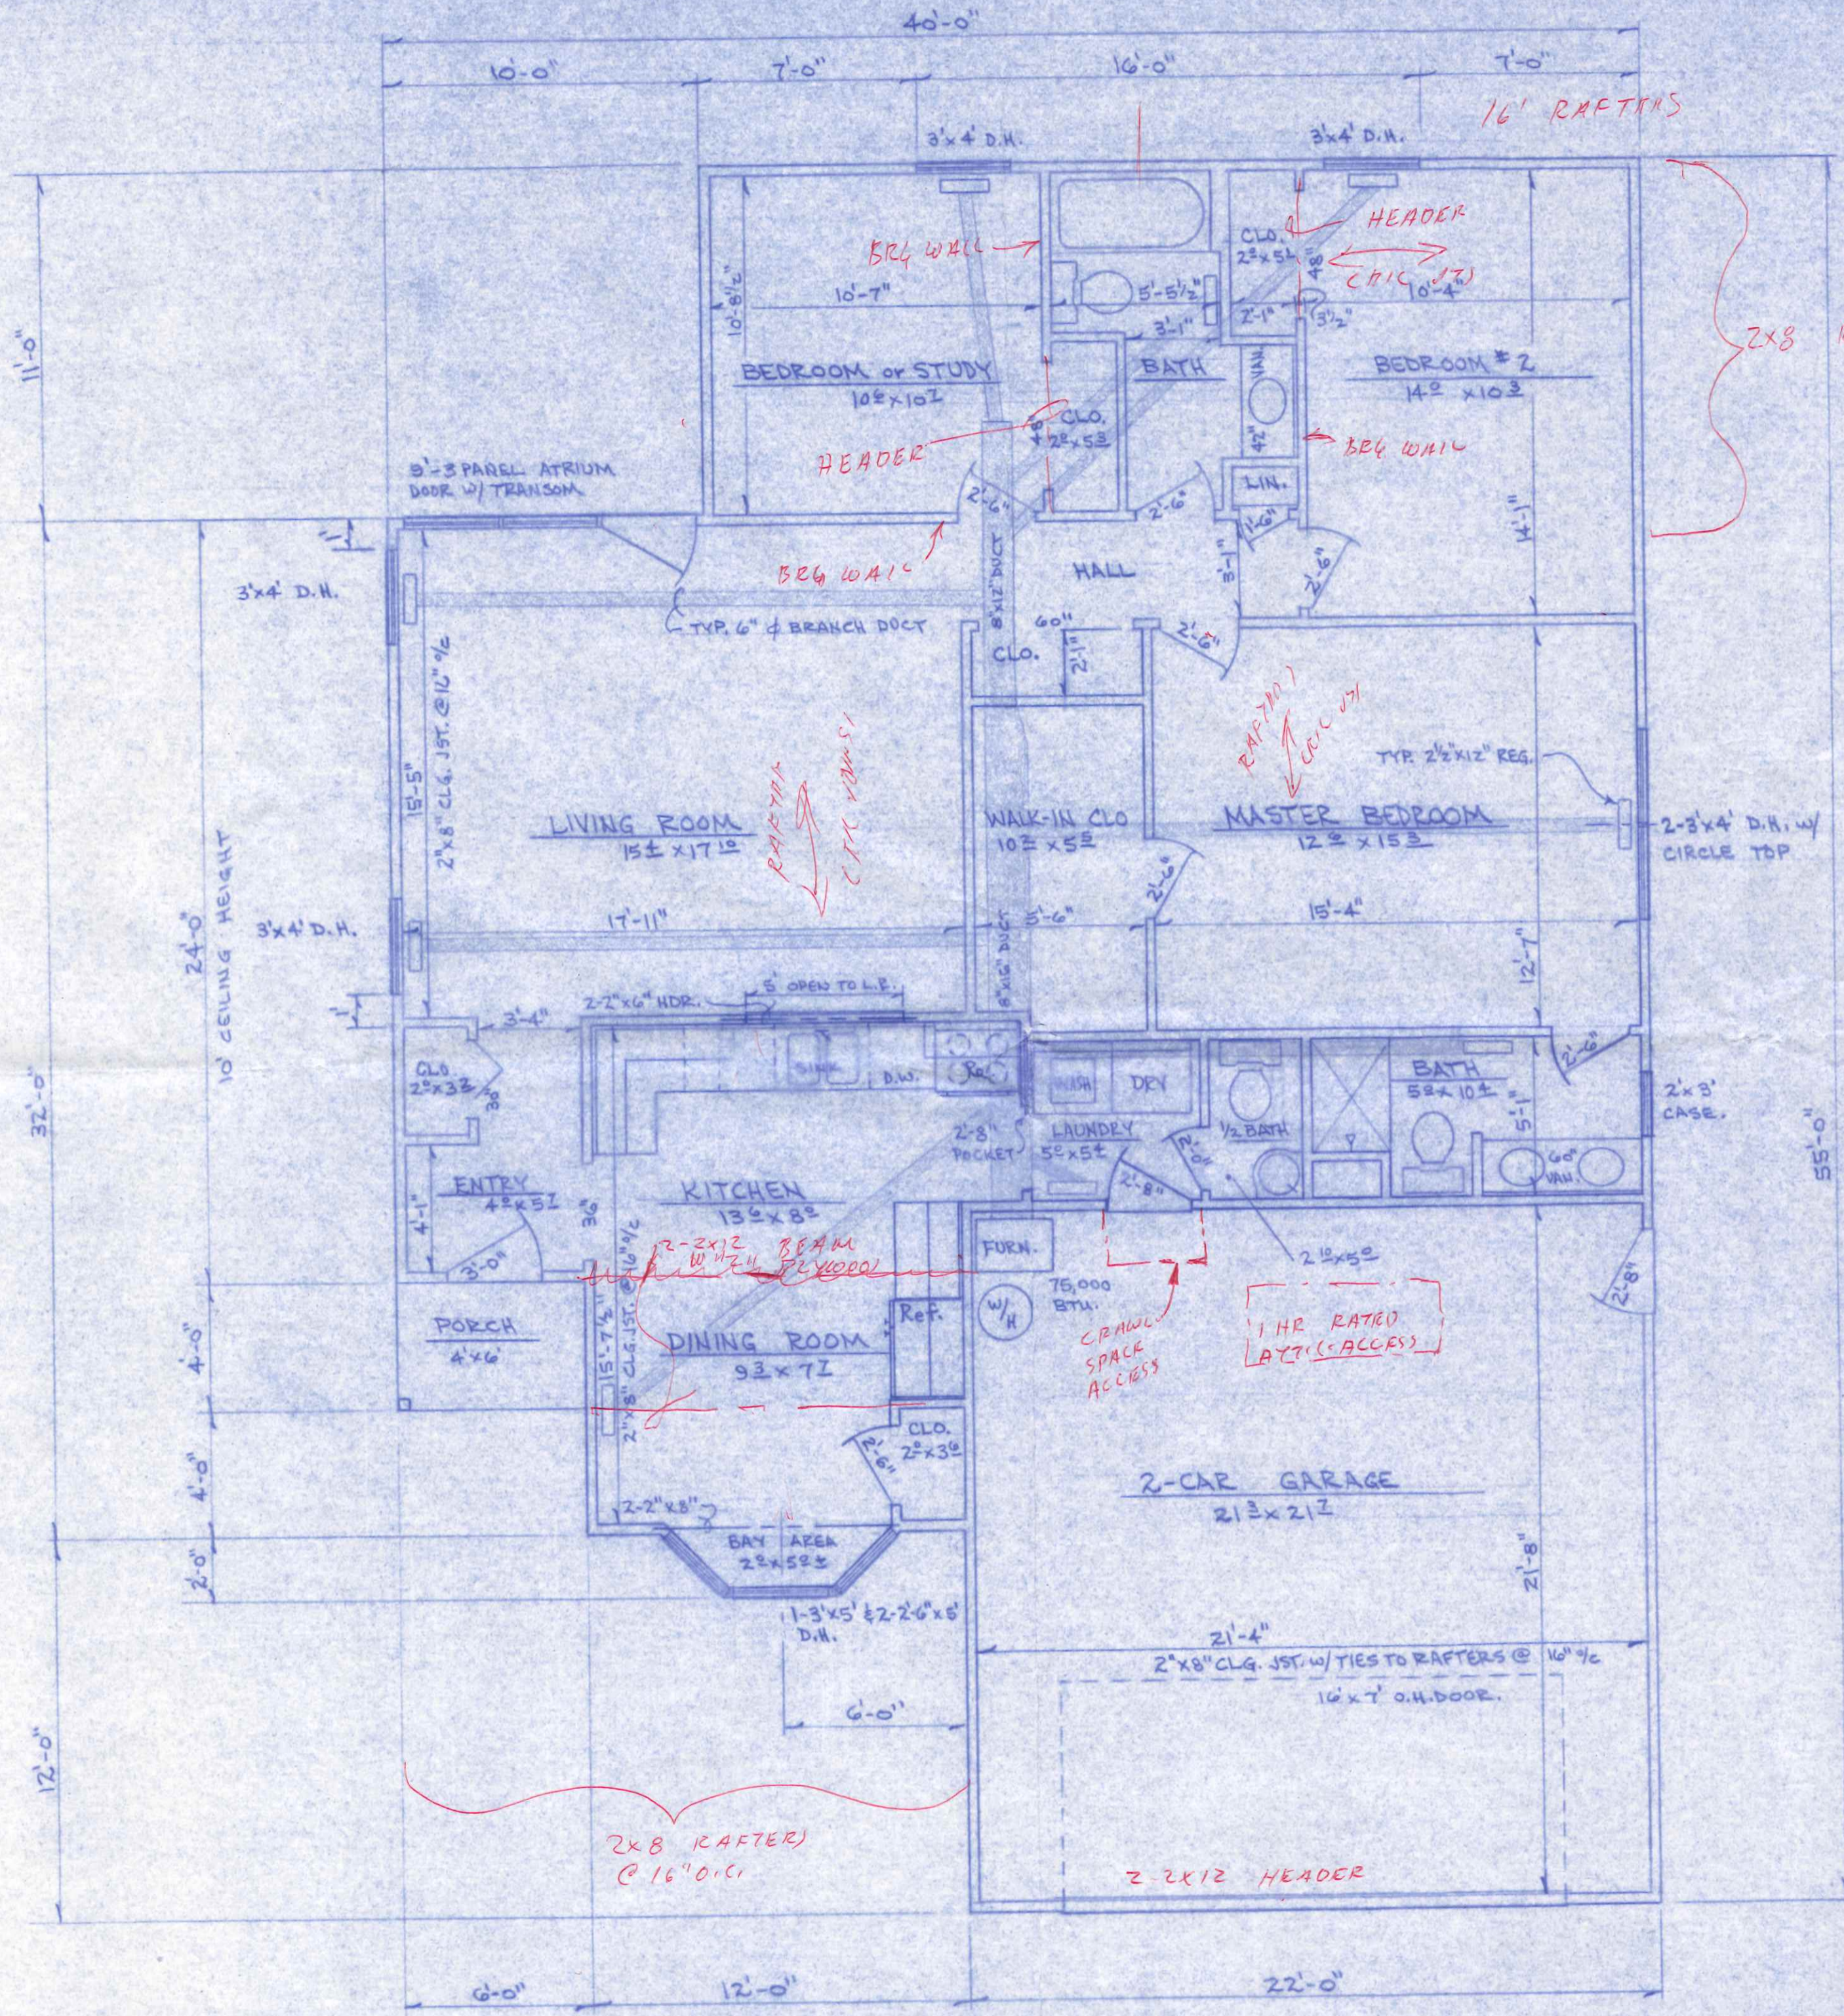

- NOTES:
1. 1488 SQ. FT. HOUSE
 2. 484 " " GARAGE
 3. INTERIOR DIMENSIONS ARE TAKEN TO STUD LINE, EXTERIOR DIMENSIONS TO OUTSIDE OF FOUNDATION.
 4. INTERIOR DOOR HEADERS TO BE MIN. 2-2"x4" EXTERIOR OPENING HEADERS TO BE MIN. 2-2"x6" FOR OPENINGS UP TO 6' WIDE, 2-2"x8" FOR OPENINGS UP TO 8' WIDE, 2-2"x10" FOR OPENINGS UP TO 9'6" WIDE

FLOOR PLAN w/HEATING LAYOUT
1/4" = 1'-0"

BECKS CONSTRUCTION CO.		
FLOOR PLAN		
DATE: EDS.	PLAN NO. 227	SHEET 2 OF 4
SEPT. 1987		


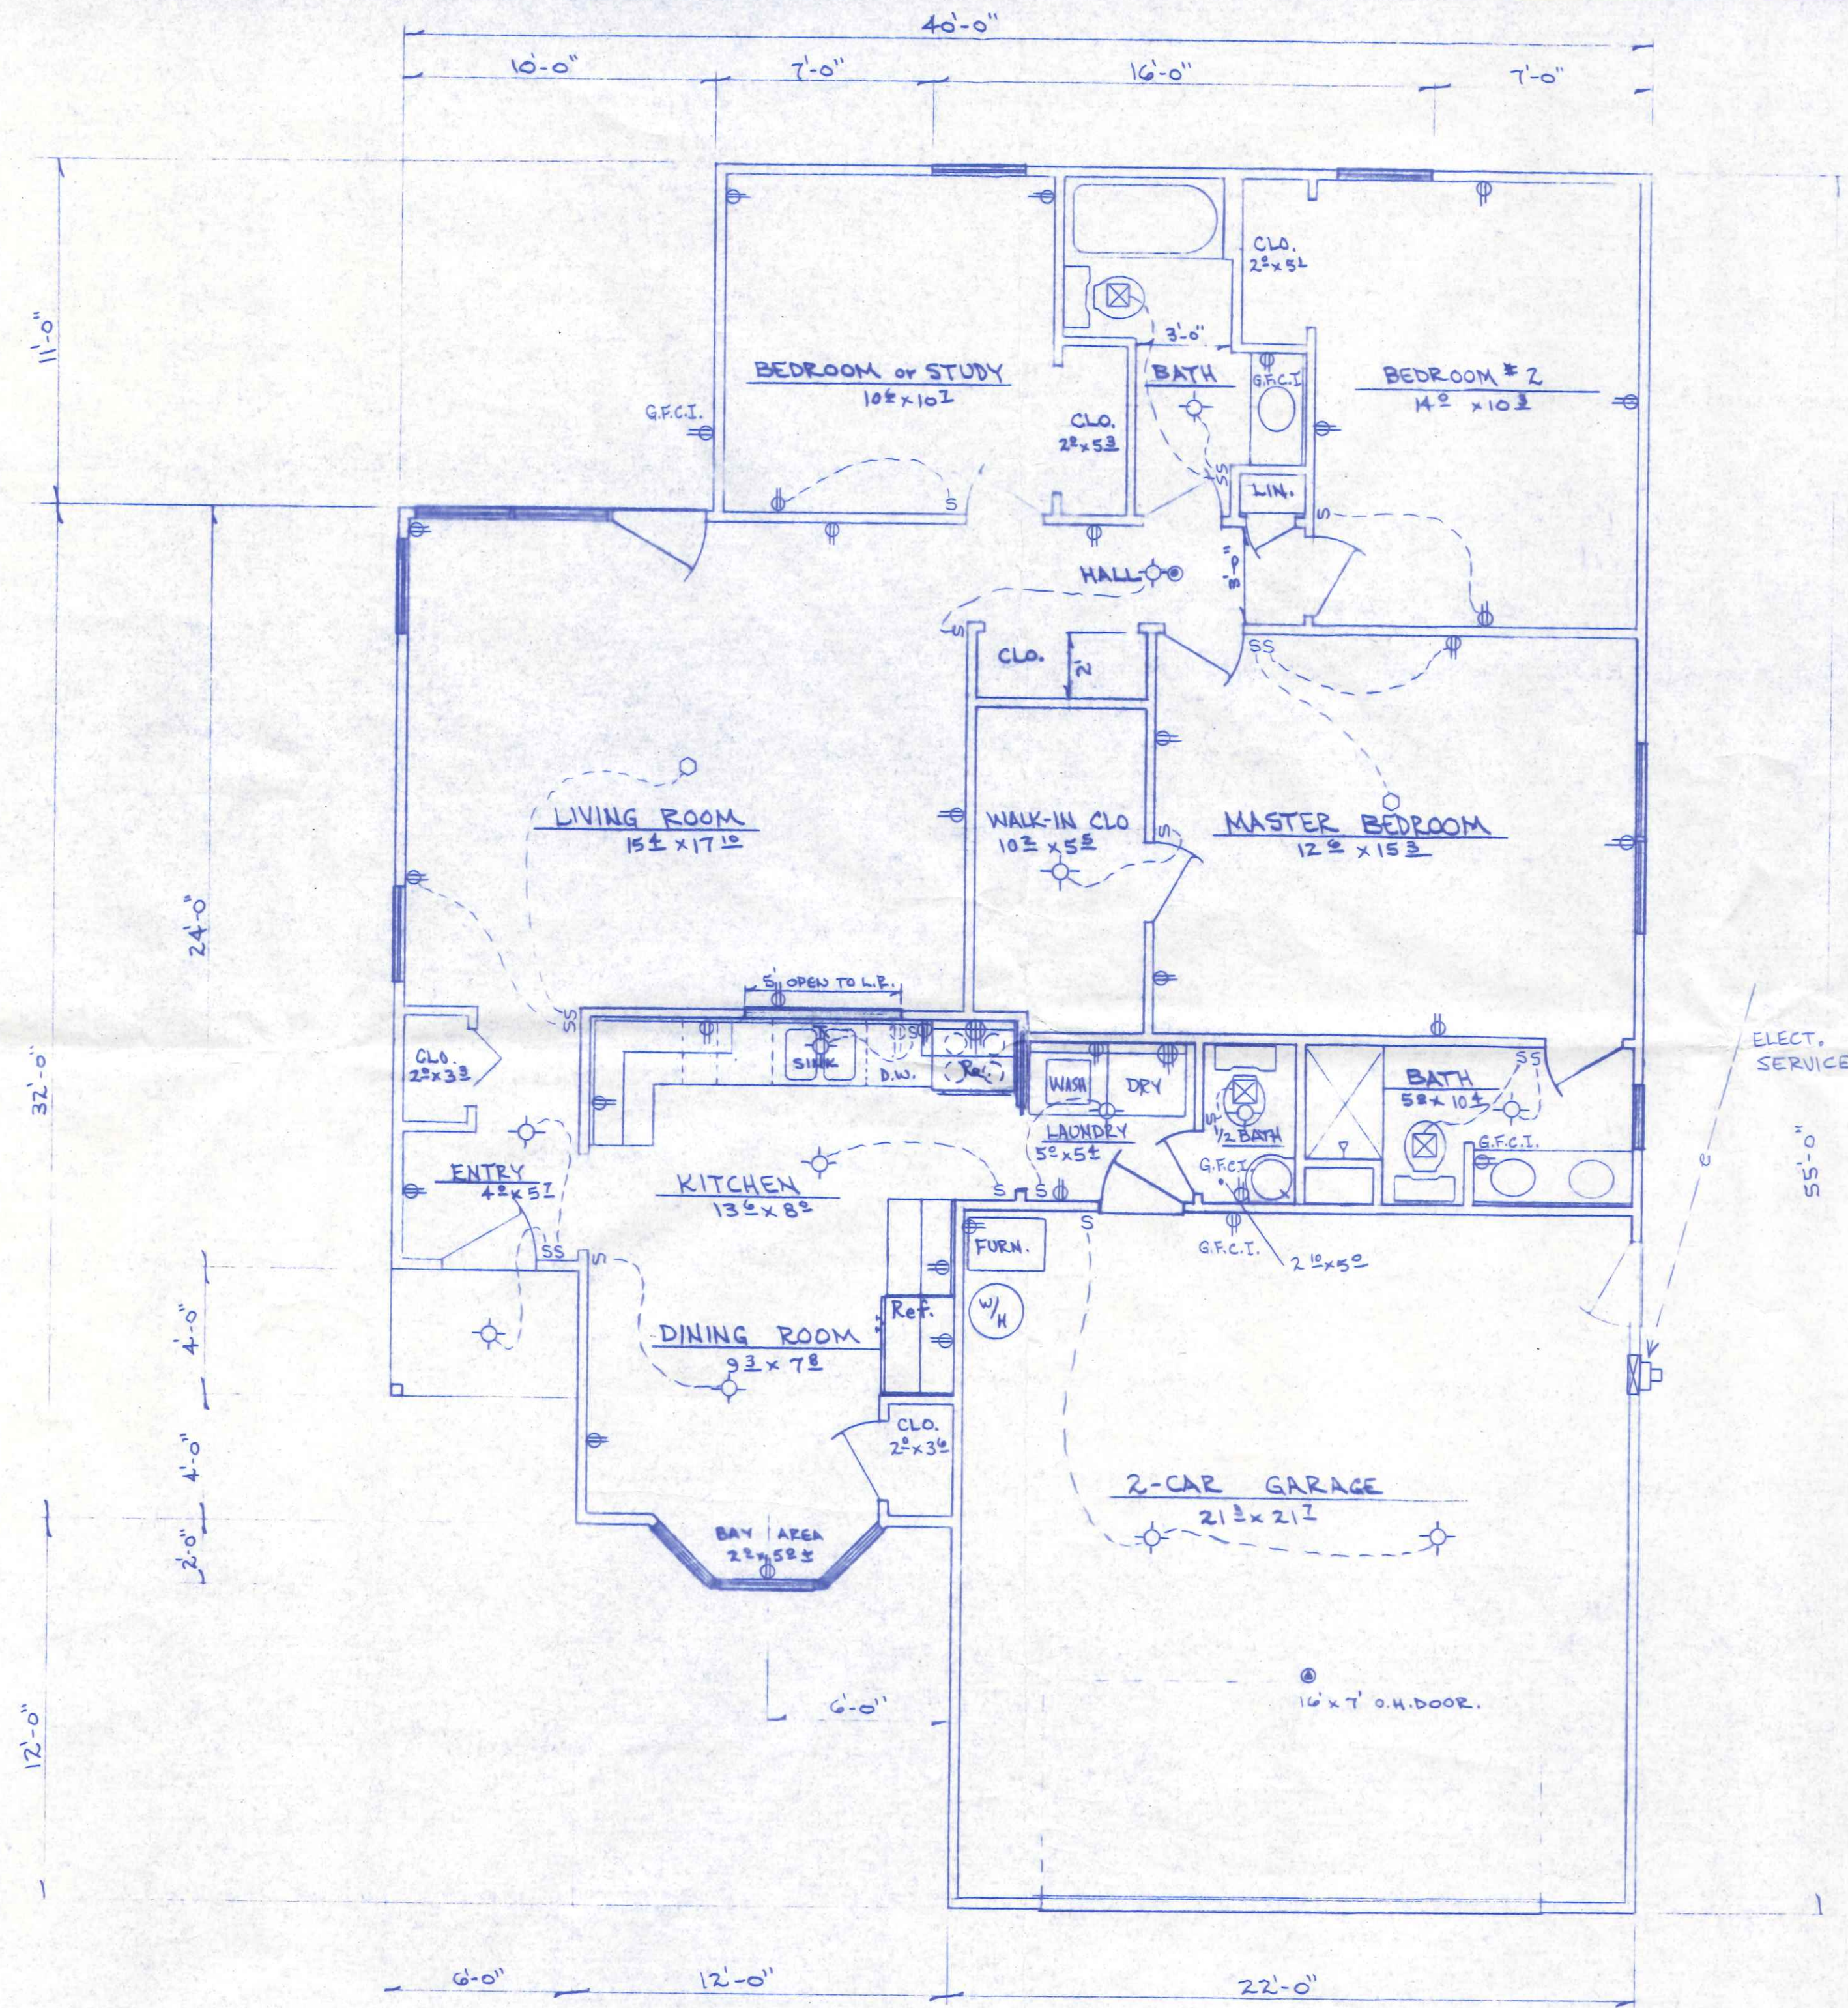


ELECT. SERVICE



ELECTRIC LEGEND

- ⋈ = SWITCH
- ⊕ = 110 V. OUTLET
- ⊙ = LIGHT FIXTURE
- ⊗ = SMOKE DETECTOR
- ⊕ = GARAGE DOOR OPENER
- ⊕ = 220 V. OUTLET
- ⊗ = EXHAUST FAN (VENT TO OUTSIDE)
- = CEILING FAN OUTLET

BECKS CONSTRUCTION CO.		
ELECTRIC PLAN		
DWN. EDS.	PLAN NO. 227	SHEET
SEPT. 1987		3 OF 4

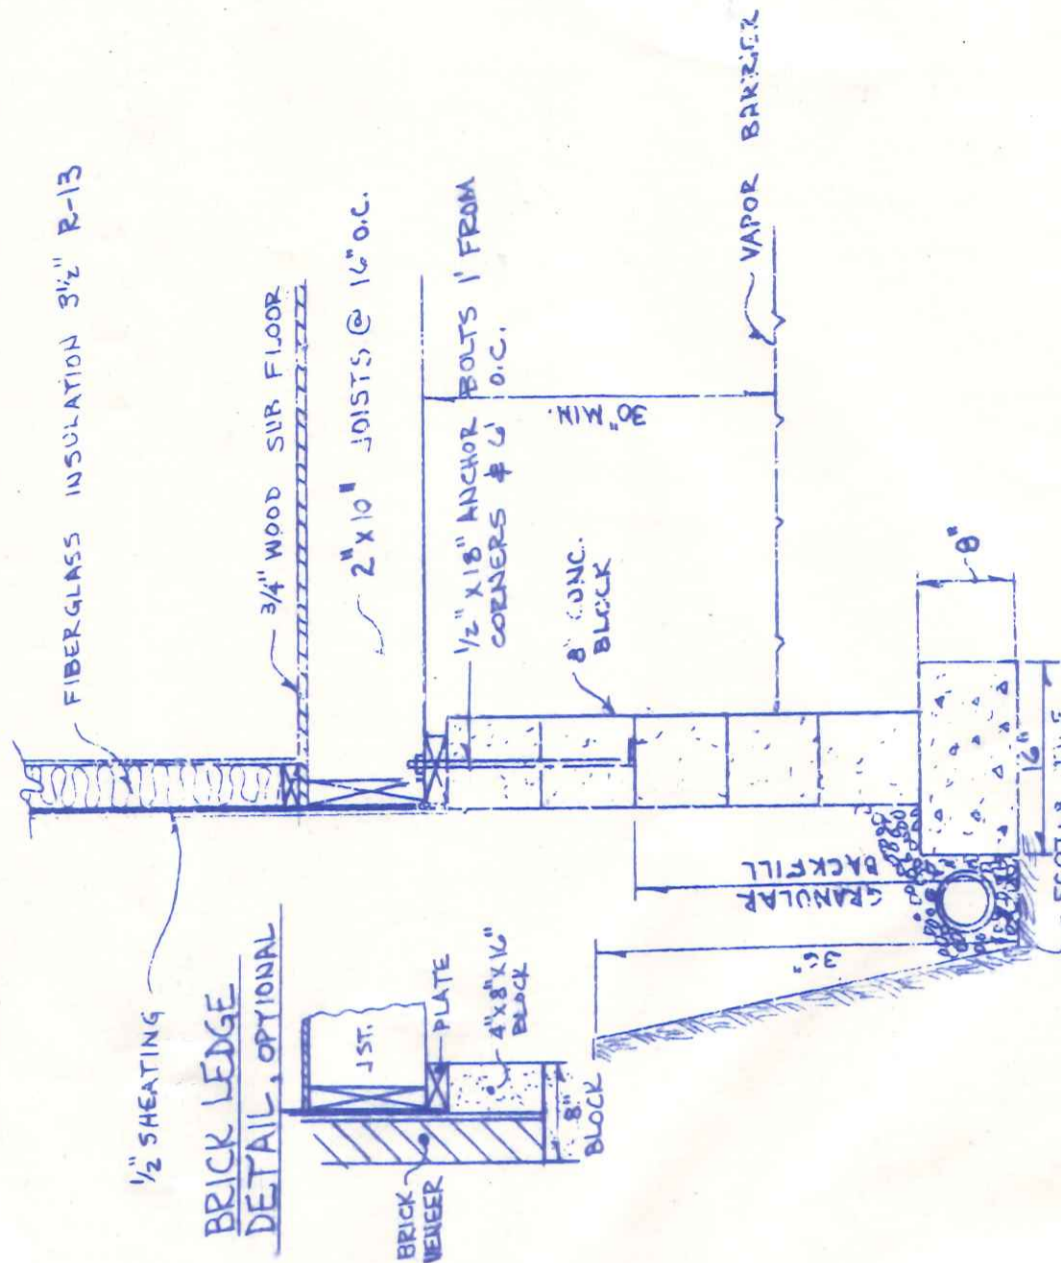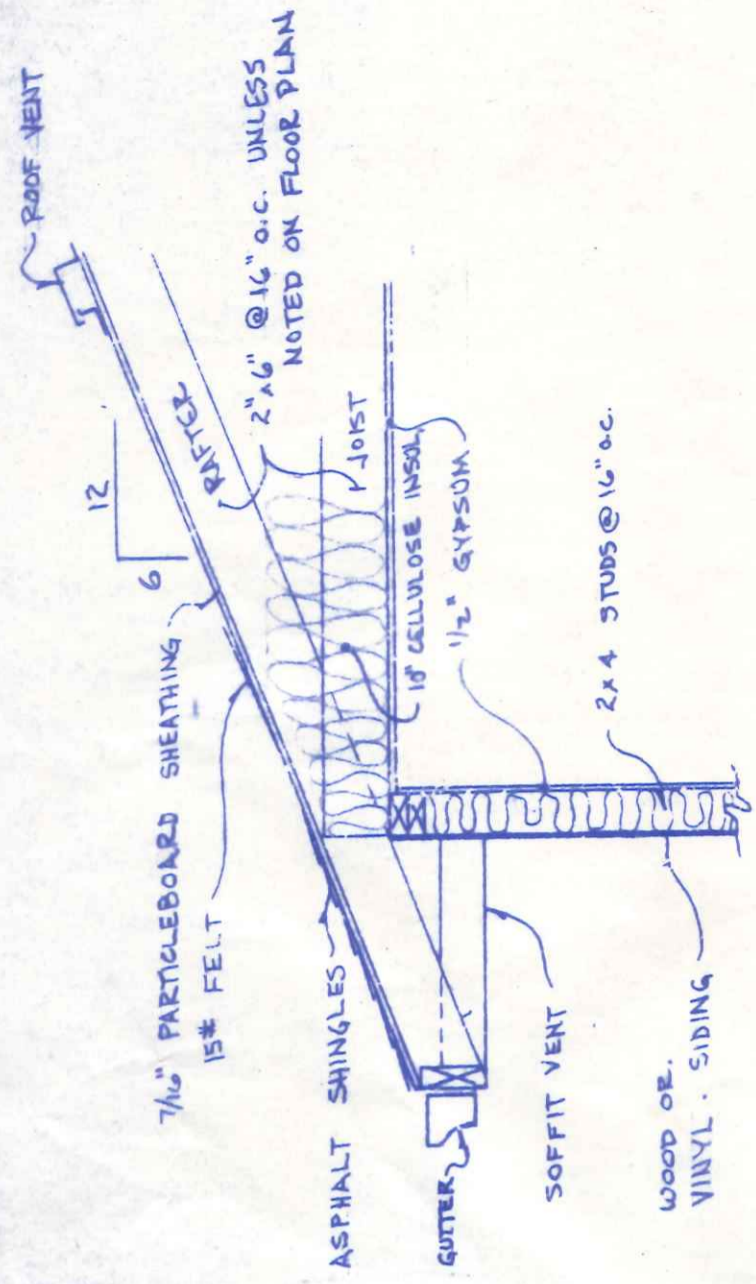

TYPICAL CROSS-SECTION
3/4" = 1'-0"

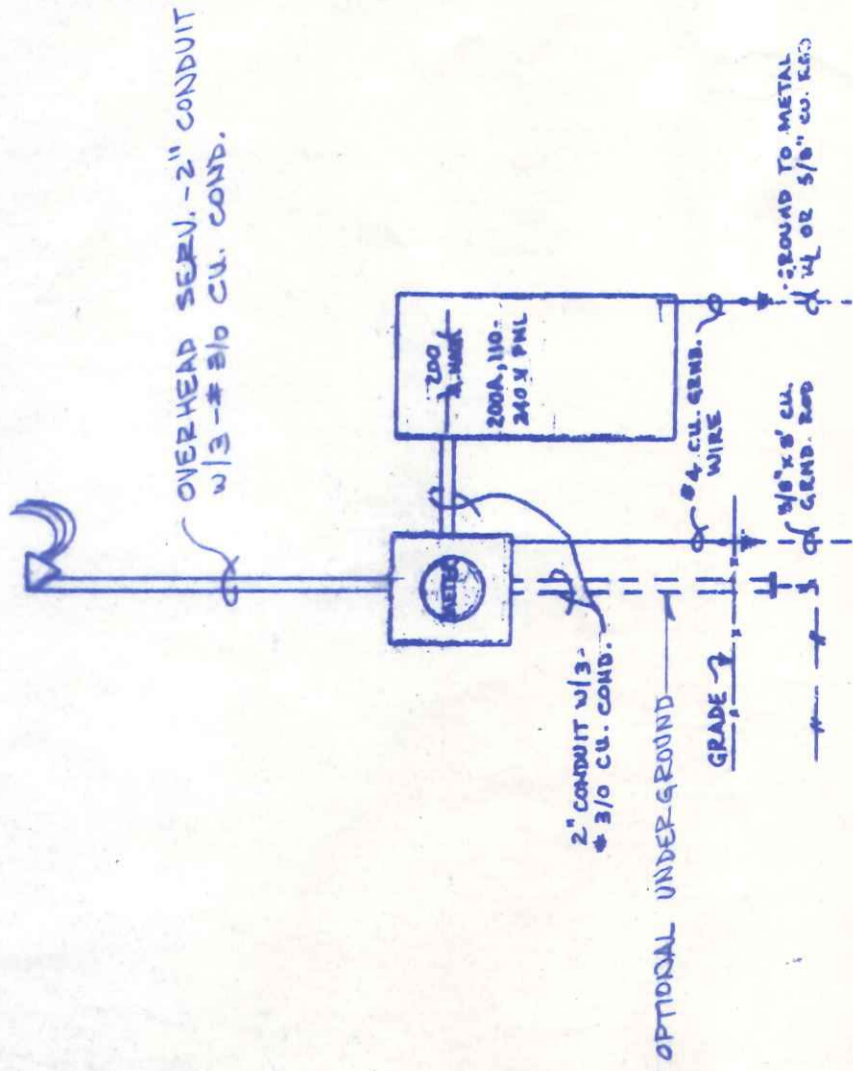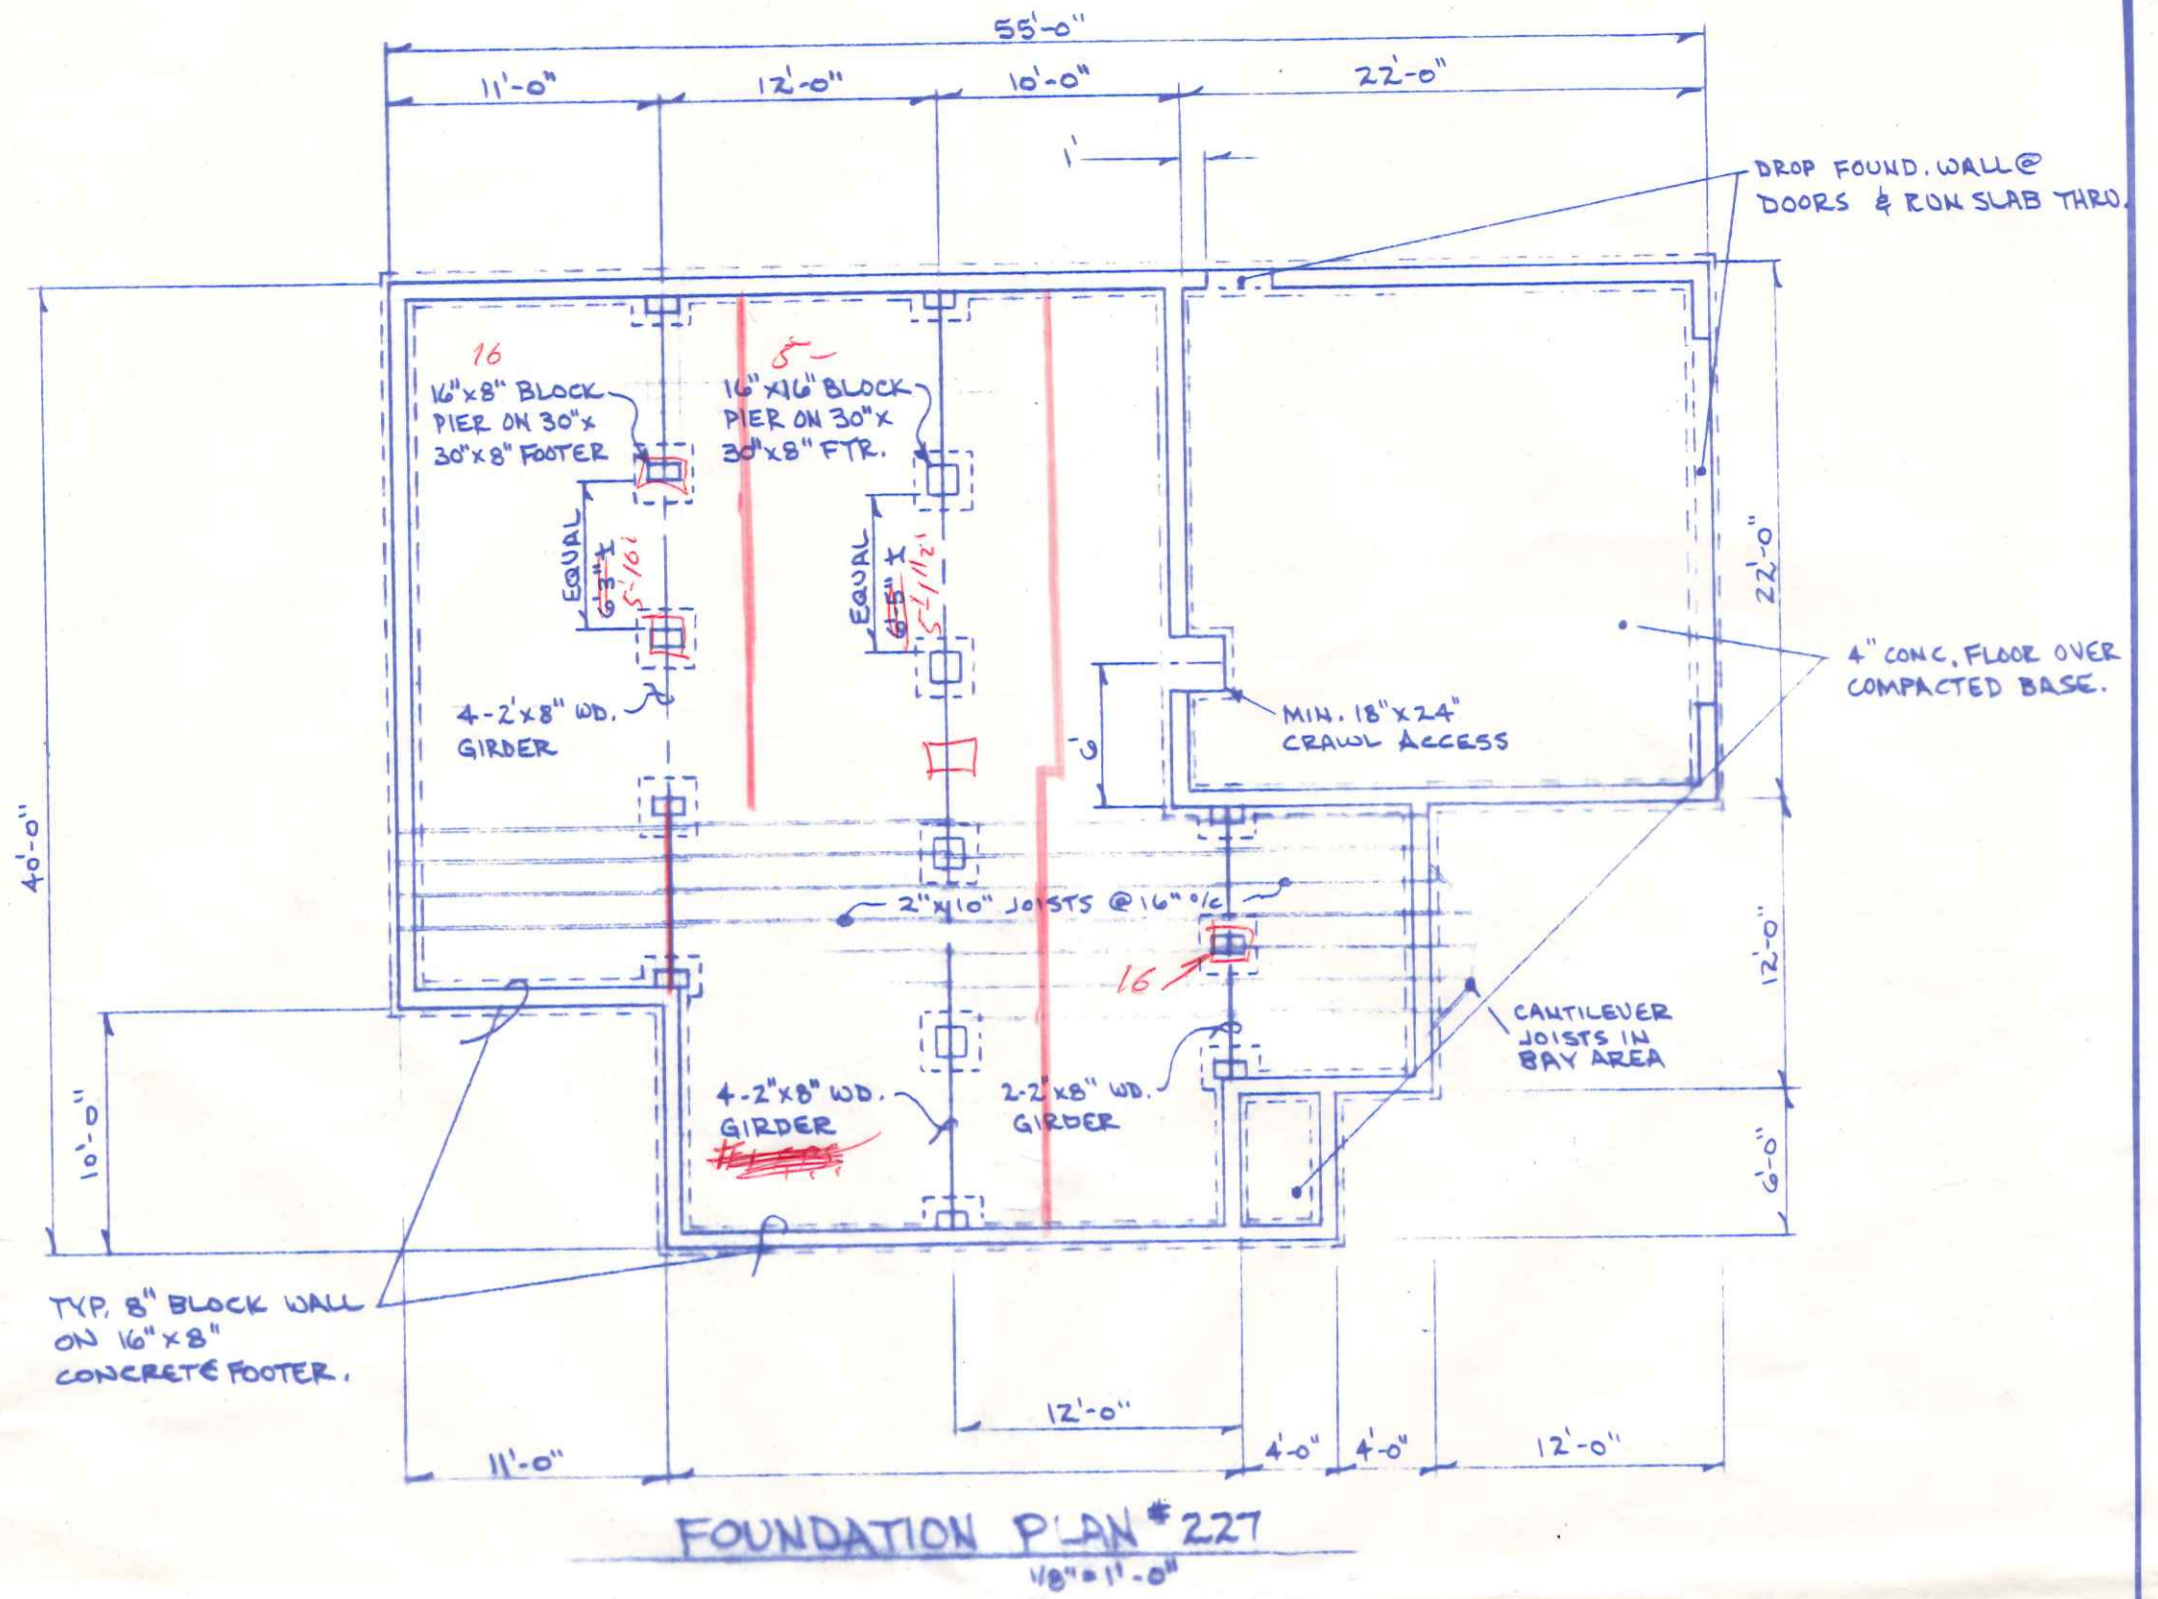

ELECTRICAL RISER DIAGRAM

NO SCALE

