



FLOOR PLAN  
1/4" = 1'-0"


REVERSE FLOOR PLAN

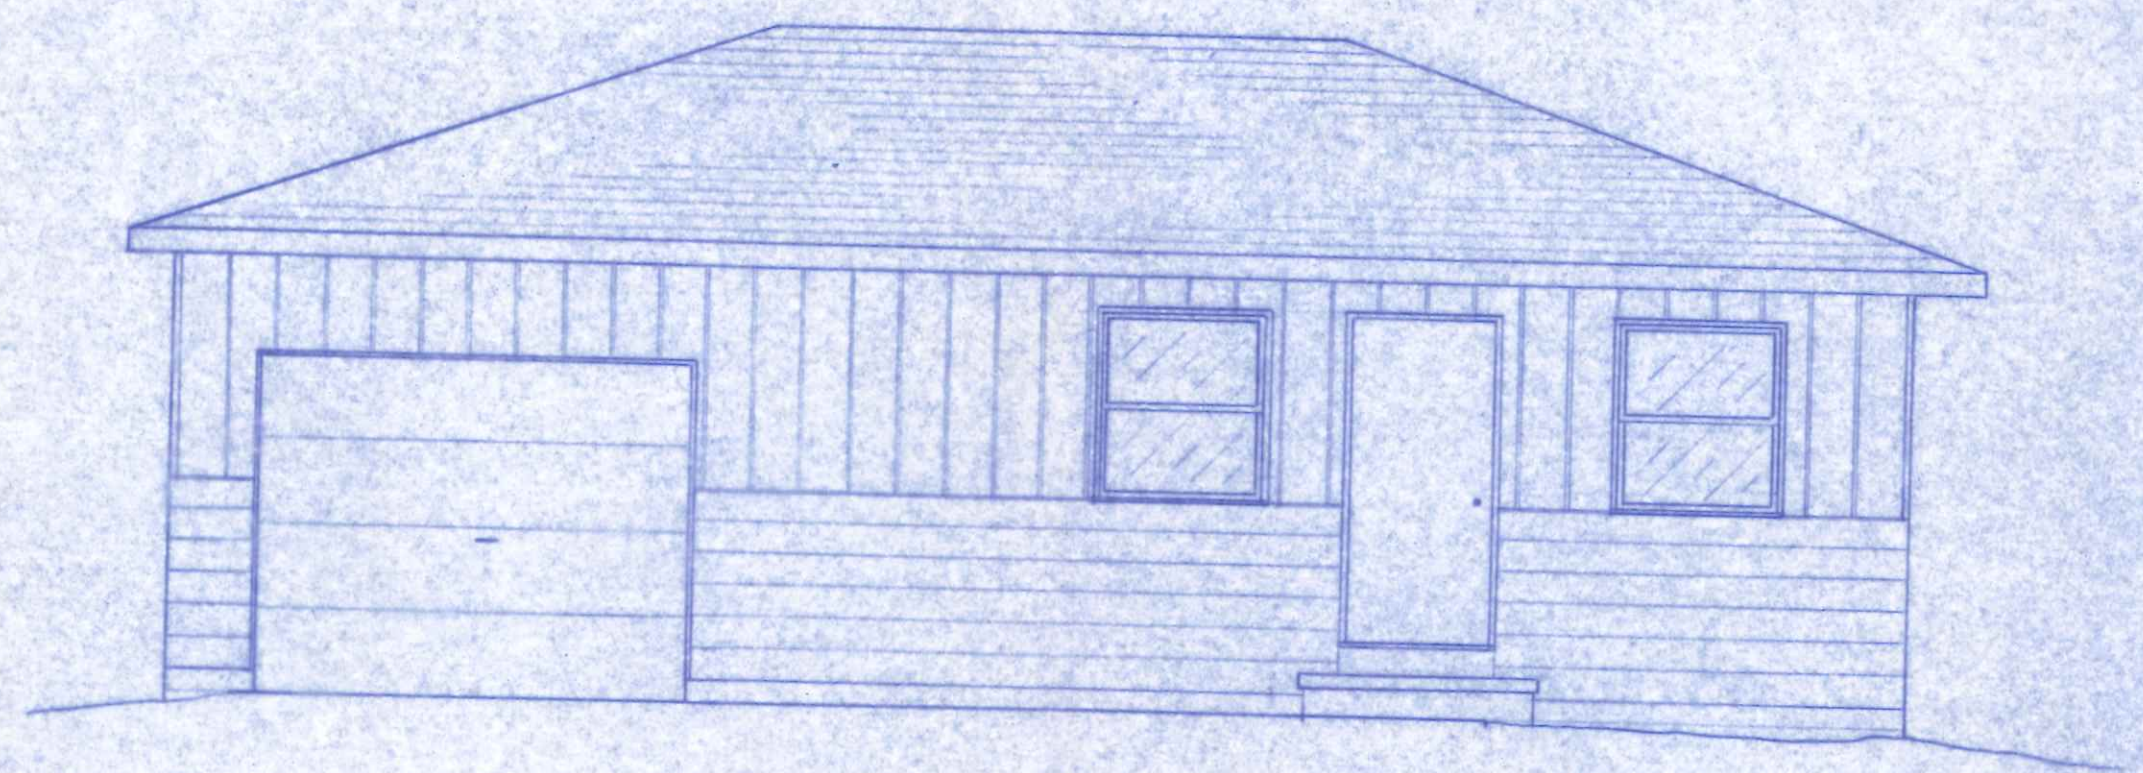


FRONT ELEVATION  
1/4" = 1'-0"

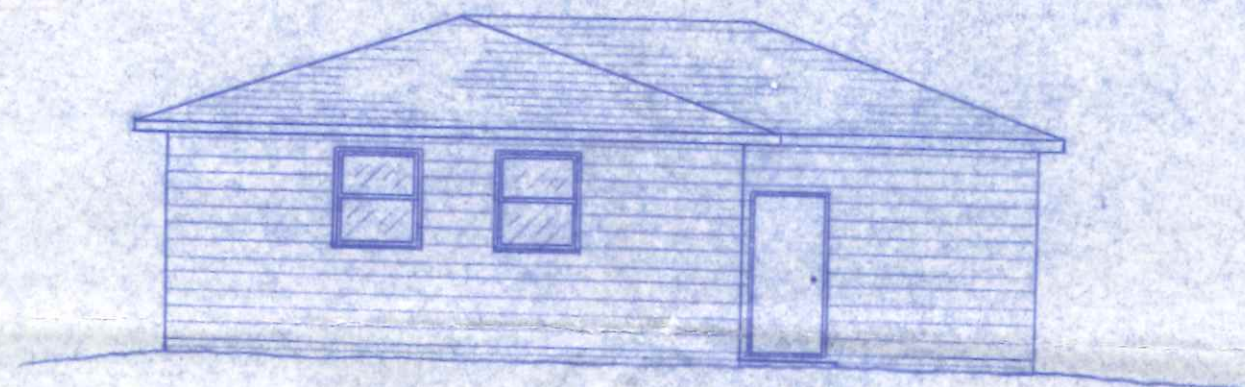

REAR ELEVATION  
1/8" = 1'-0"

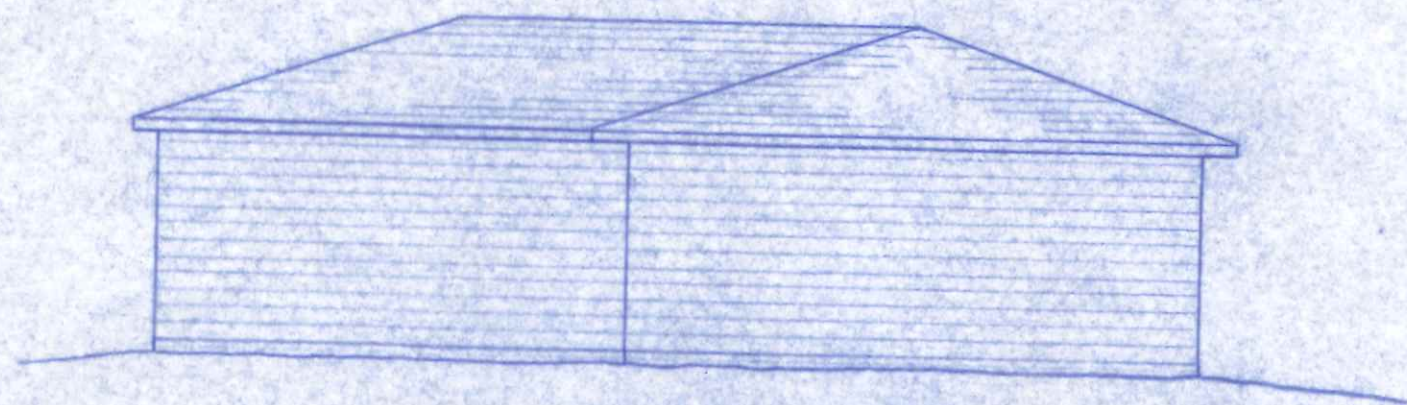

LEFT SIDE ELEVATION  
1/8" = 1'-0"

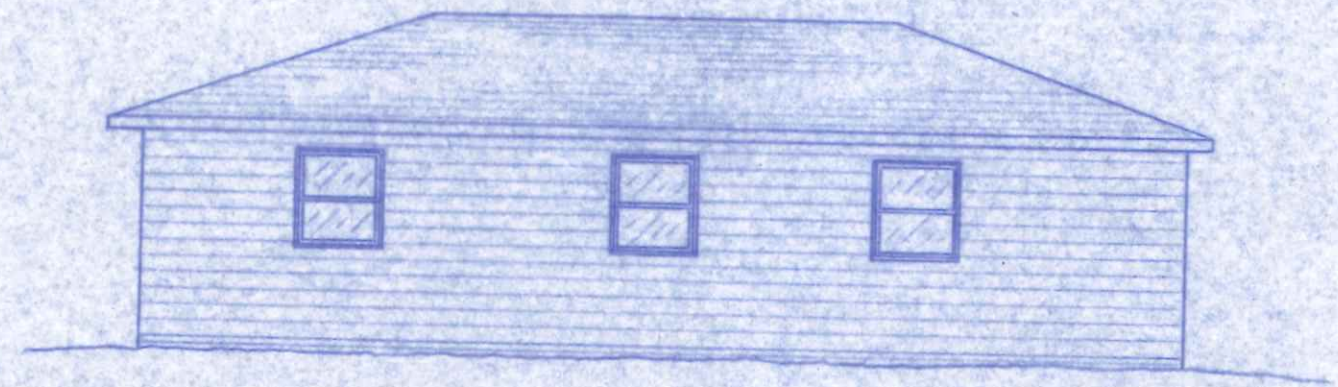


RIGHT SIDE ELEVATION  
1/8" = 1'-0"


537 High St.

BECK CONSTRUCTION CO.		
DRN BY: RDS	PLAN NO. 202	1344 SQ. FT.
CHKD:		FEB 1964




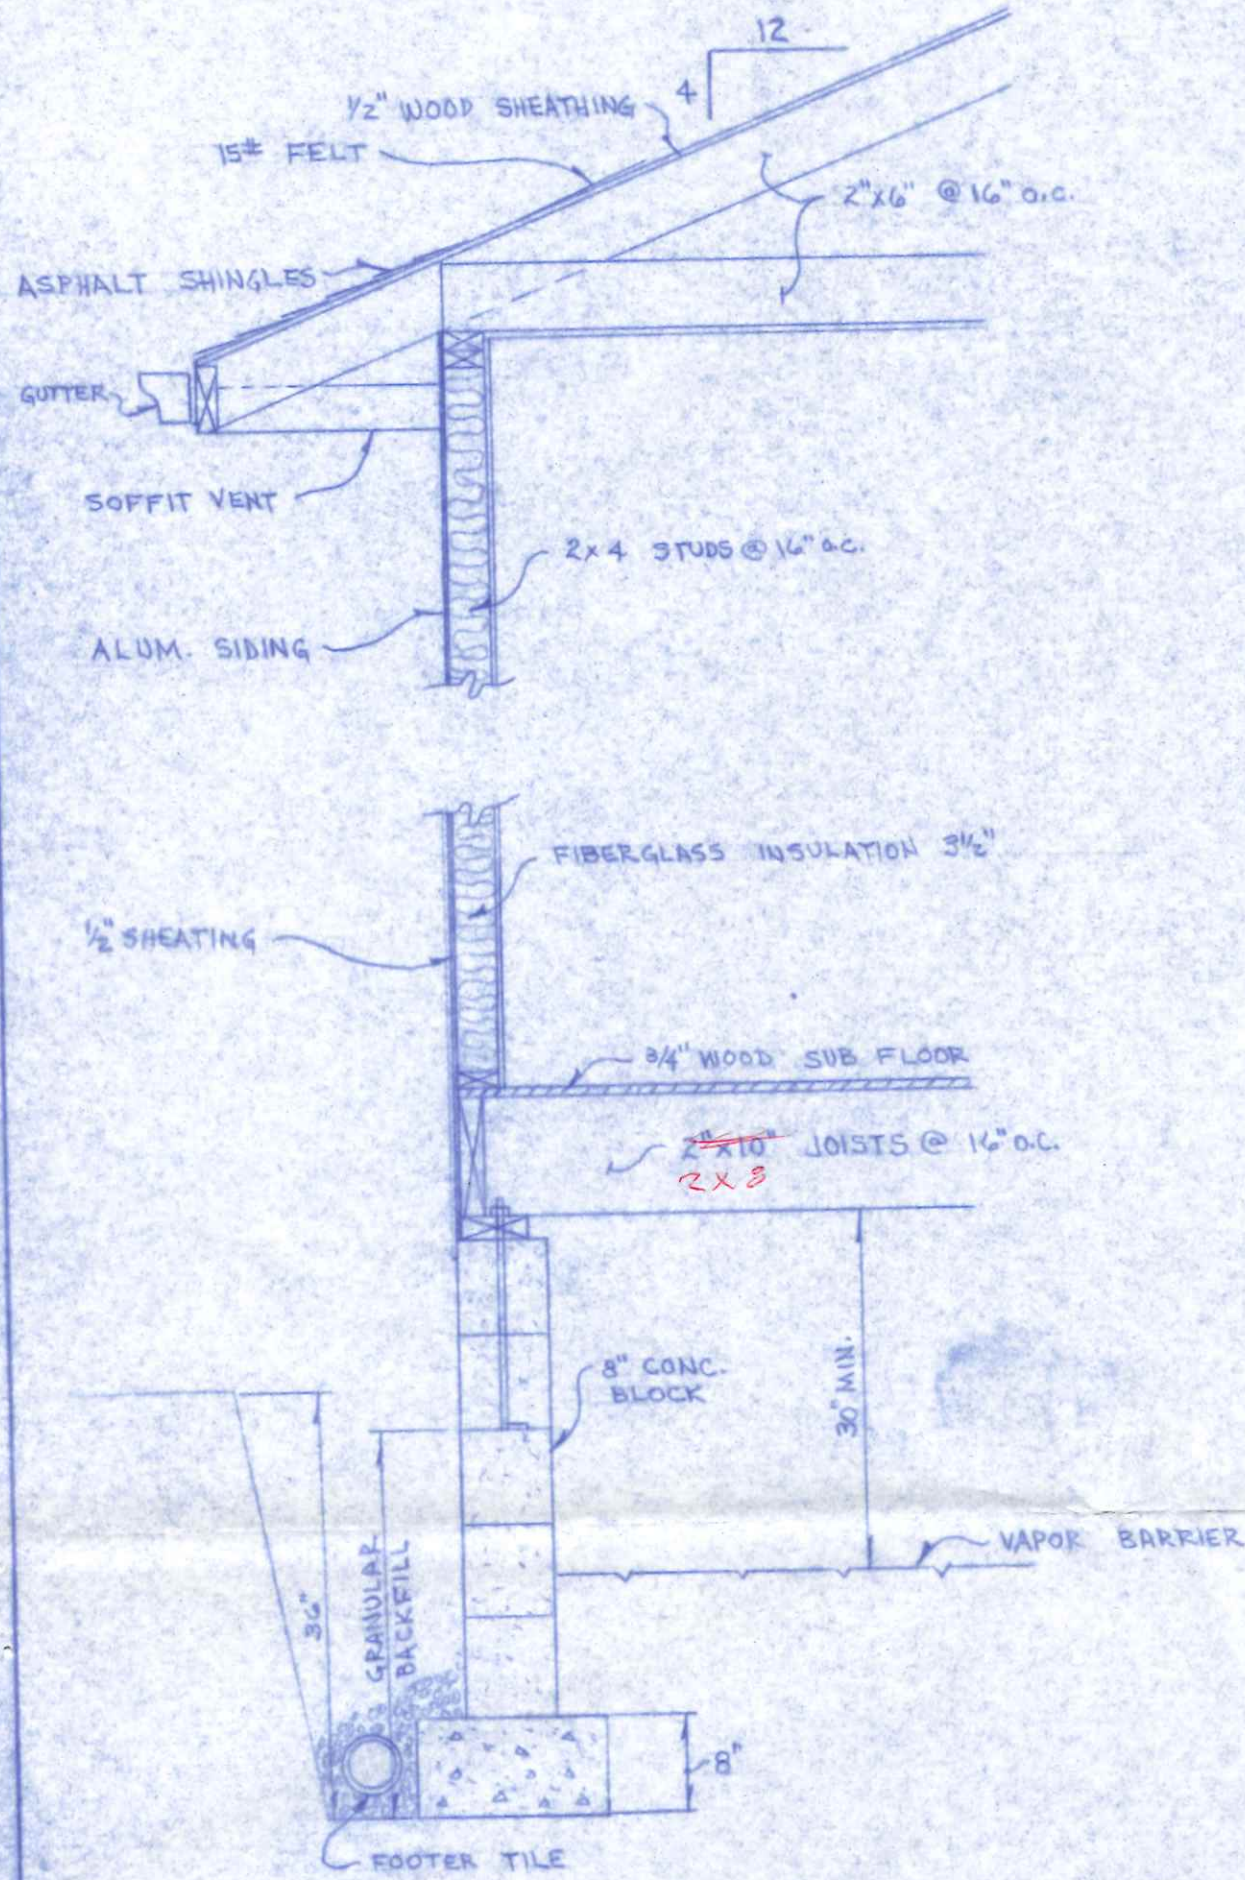


TYPICAL CROSS-SECTION  
3/4" = 1'-0"

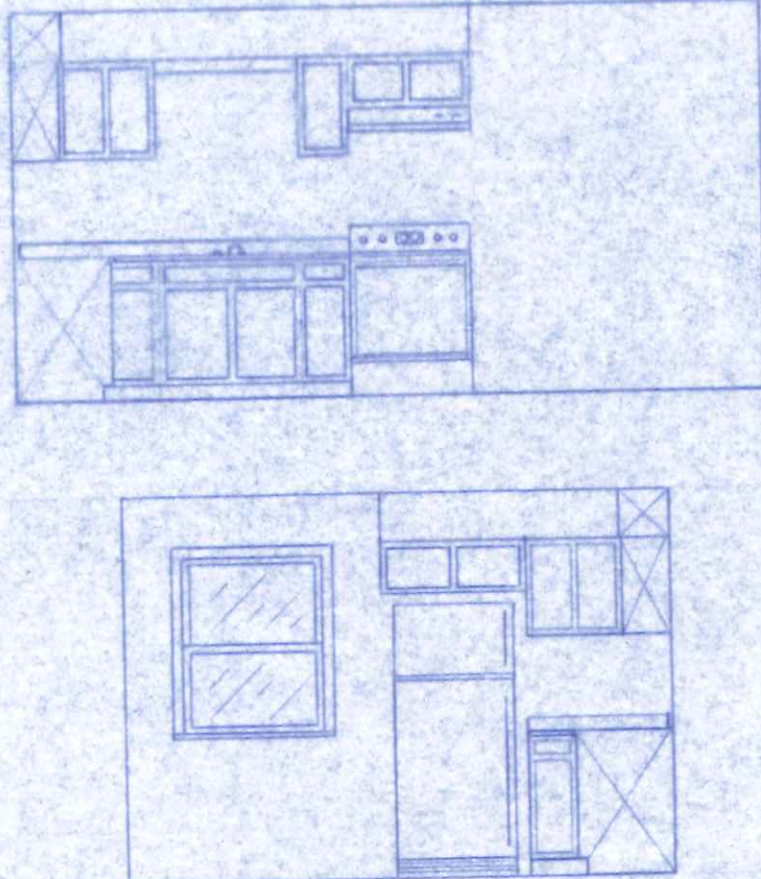

KITCHEN DETAILS  
1/4" = 1'-0"

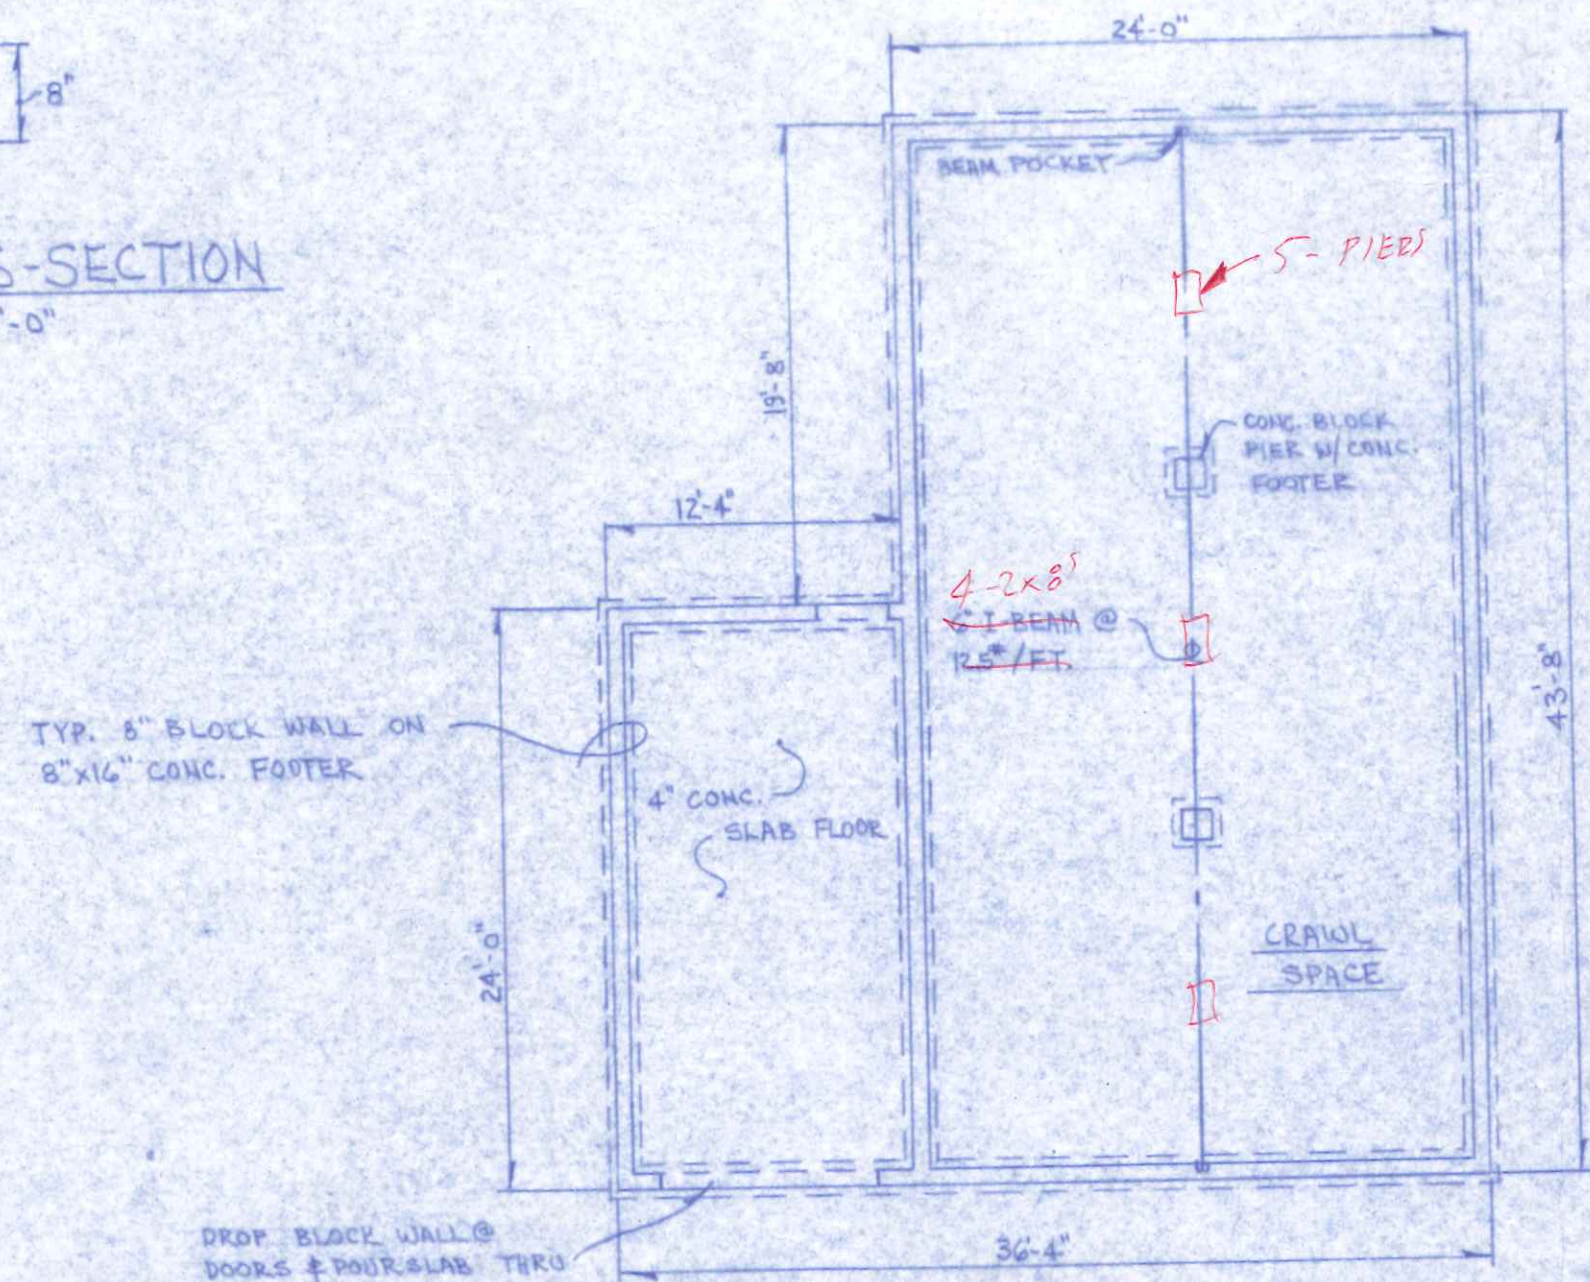

FOUNDATION PLAN  
1/8" = 1'-0"

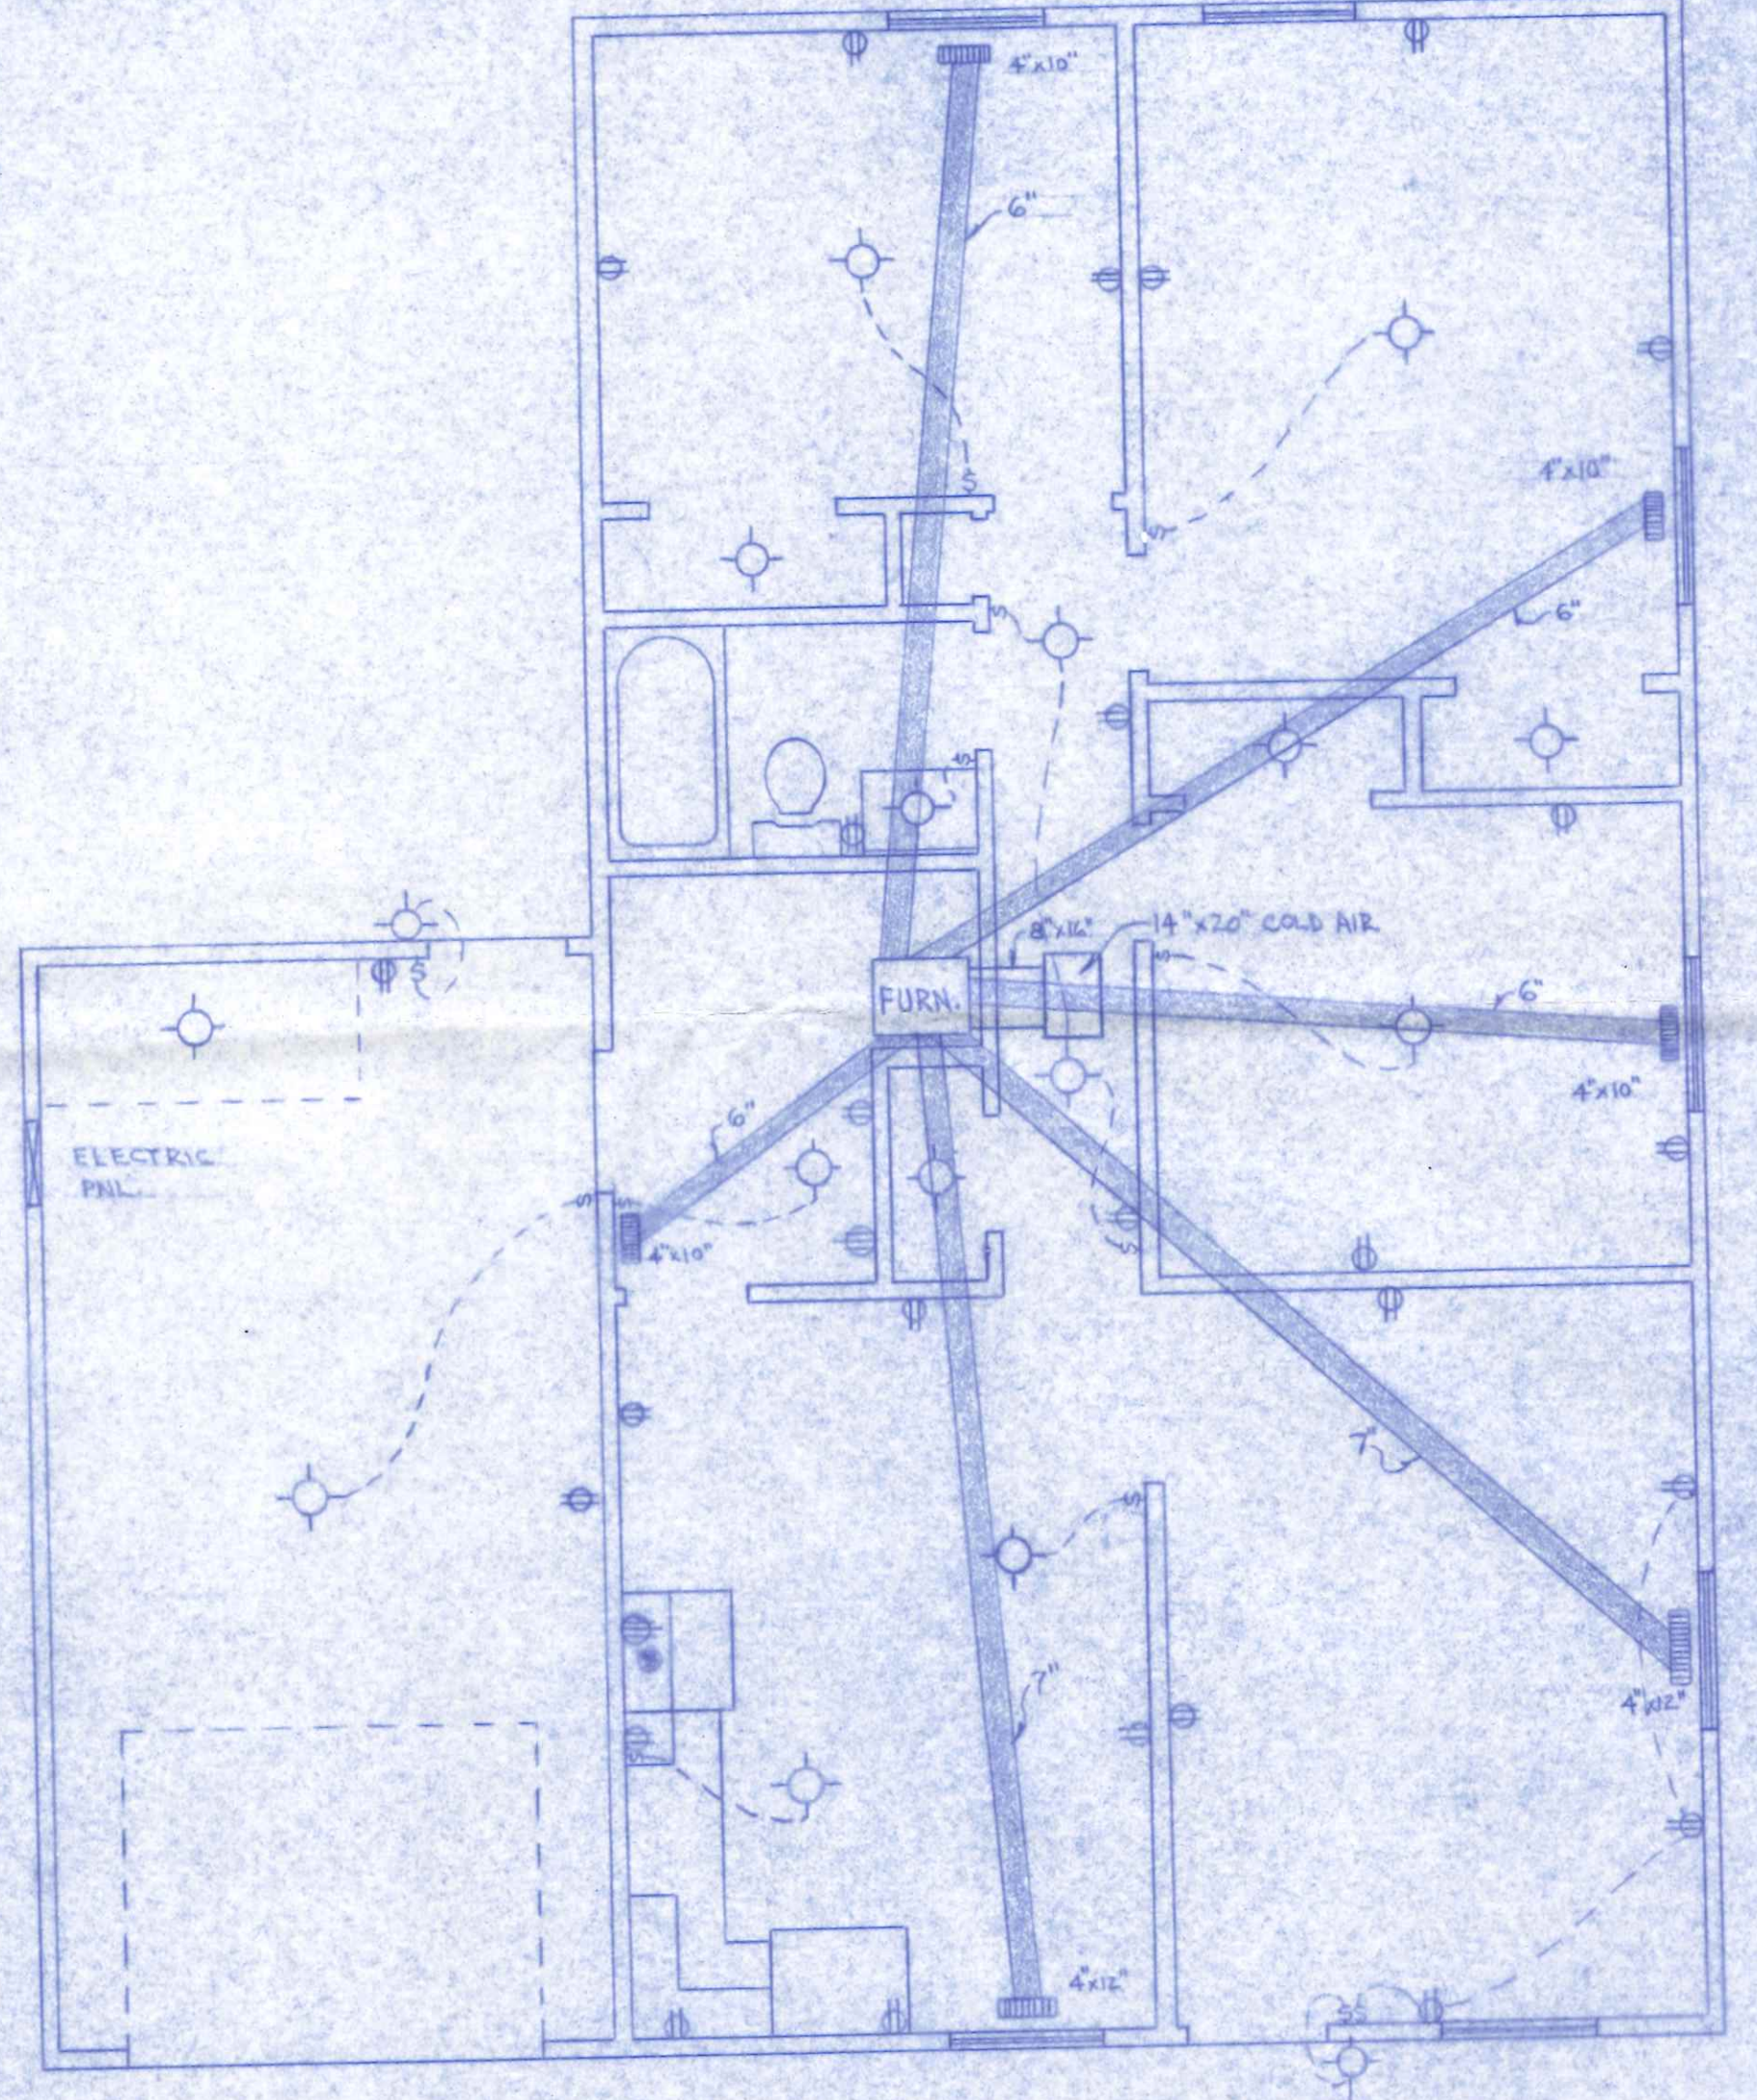

HEATING & ELECTRICAL PLAN  
1/4" = 1'-0"

BECK CONSTRUCTION CO.		
DRAWN BY: RDS	PLAN NO. 202	1344 SQ. FT.
CHKD:		FEB. 1964