




FIRE PROTECTION PIPING PLAN
 OFFICES AND REST ROOMS
 SCALE 1/8" = 1'-0"
 5'-0" A.C.T. CEILINGS - INTERIOR WALLS
 SHALL BE 2X2 1/2" MET. STUDS W/ 5/8" GYPSUM.

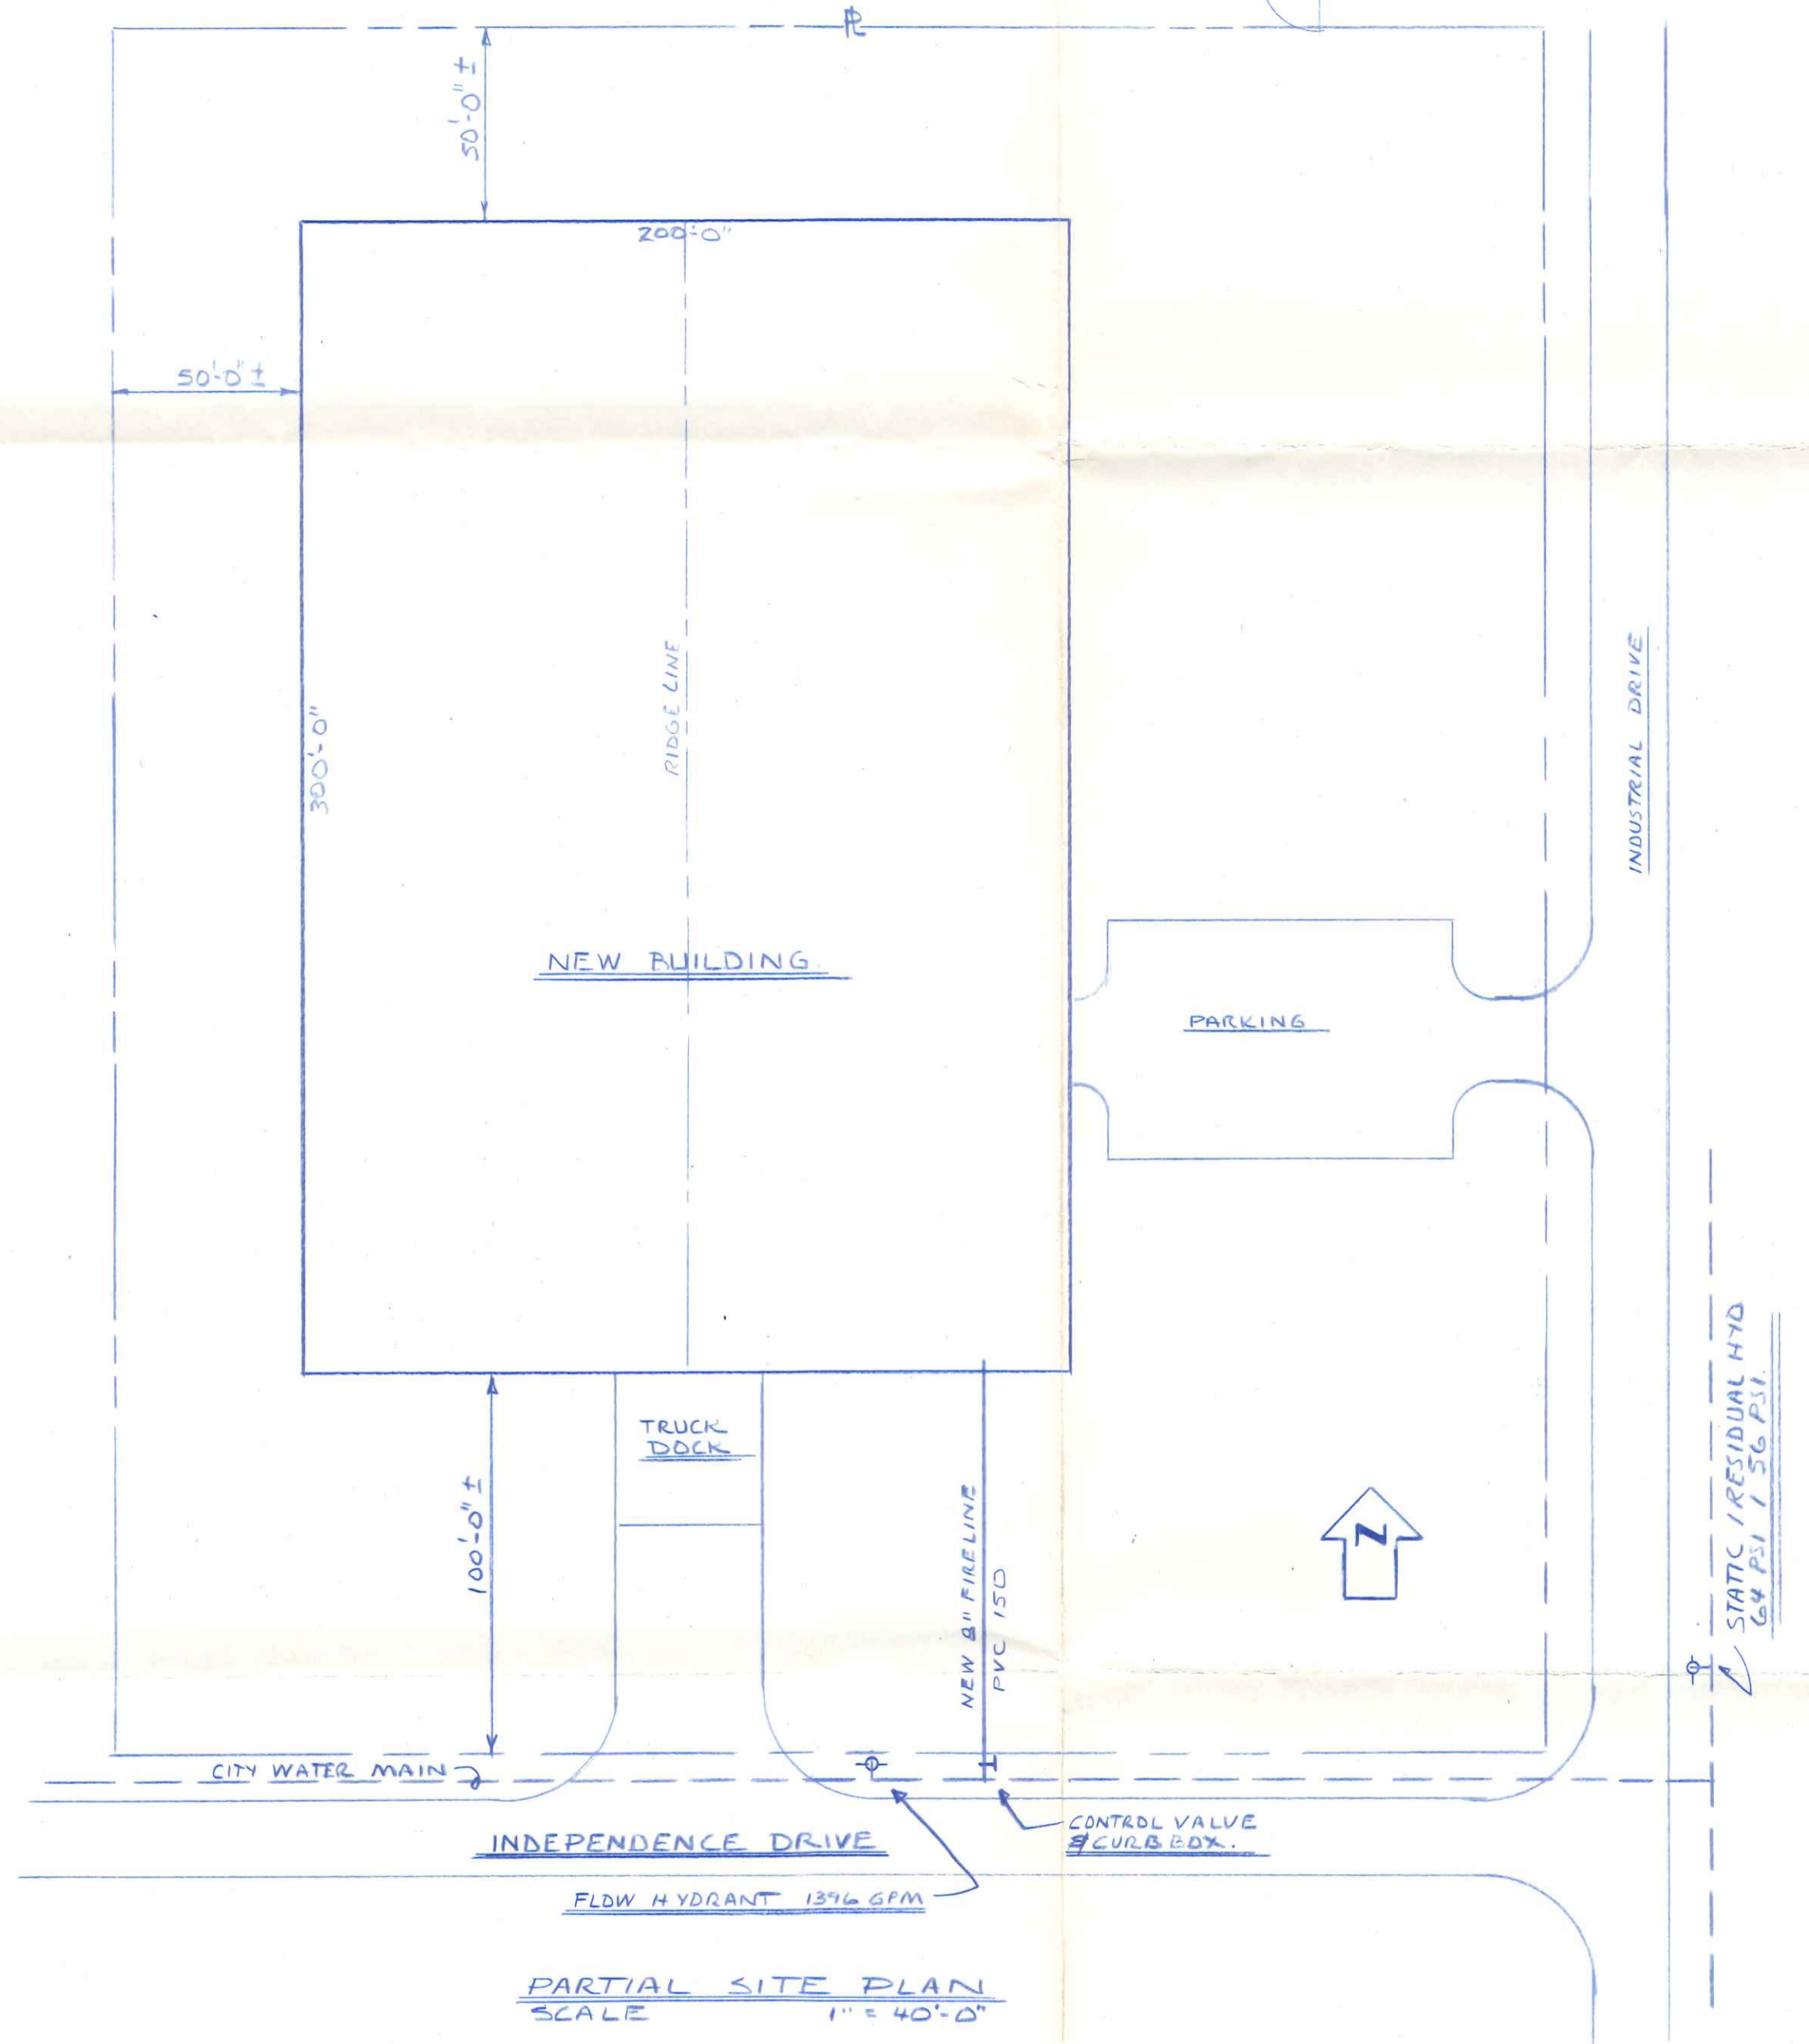

PARTIAL SITE PLAN
 SCALE 1" = 40'-0"

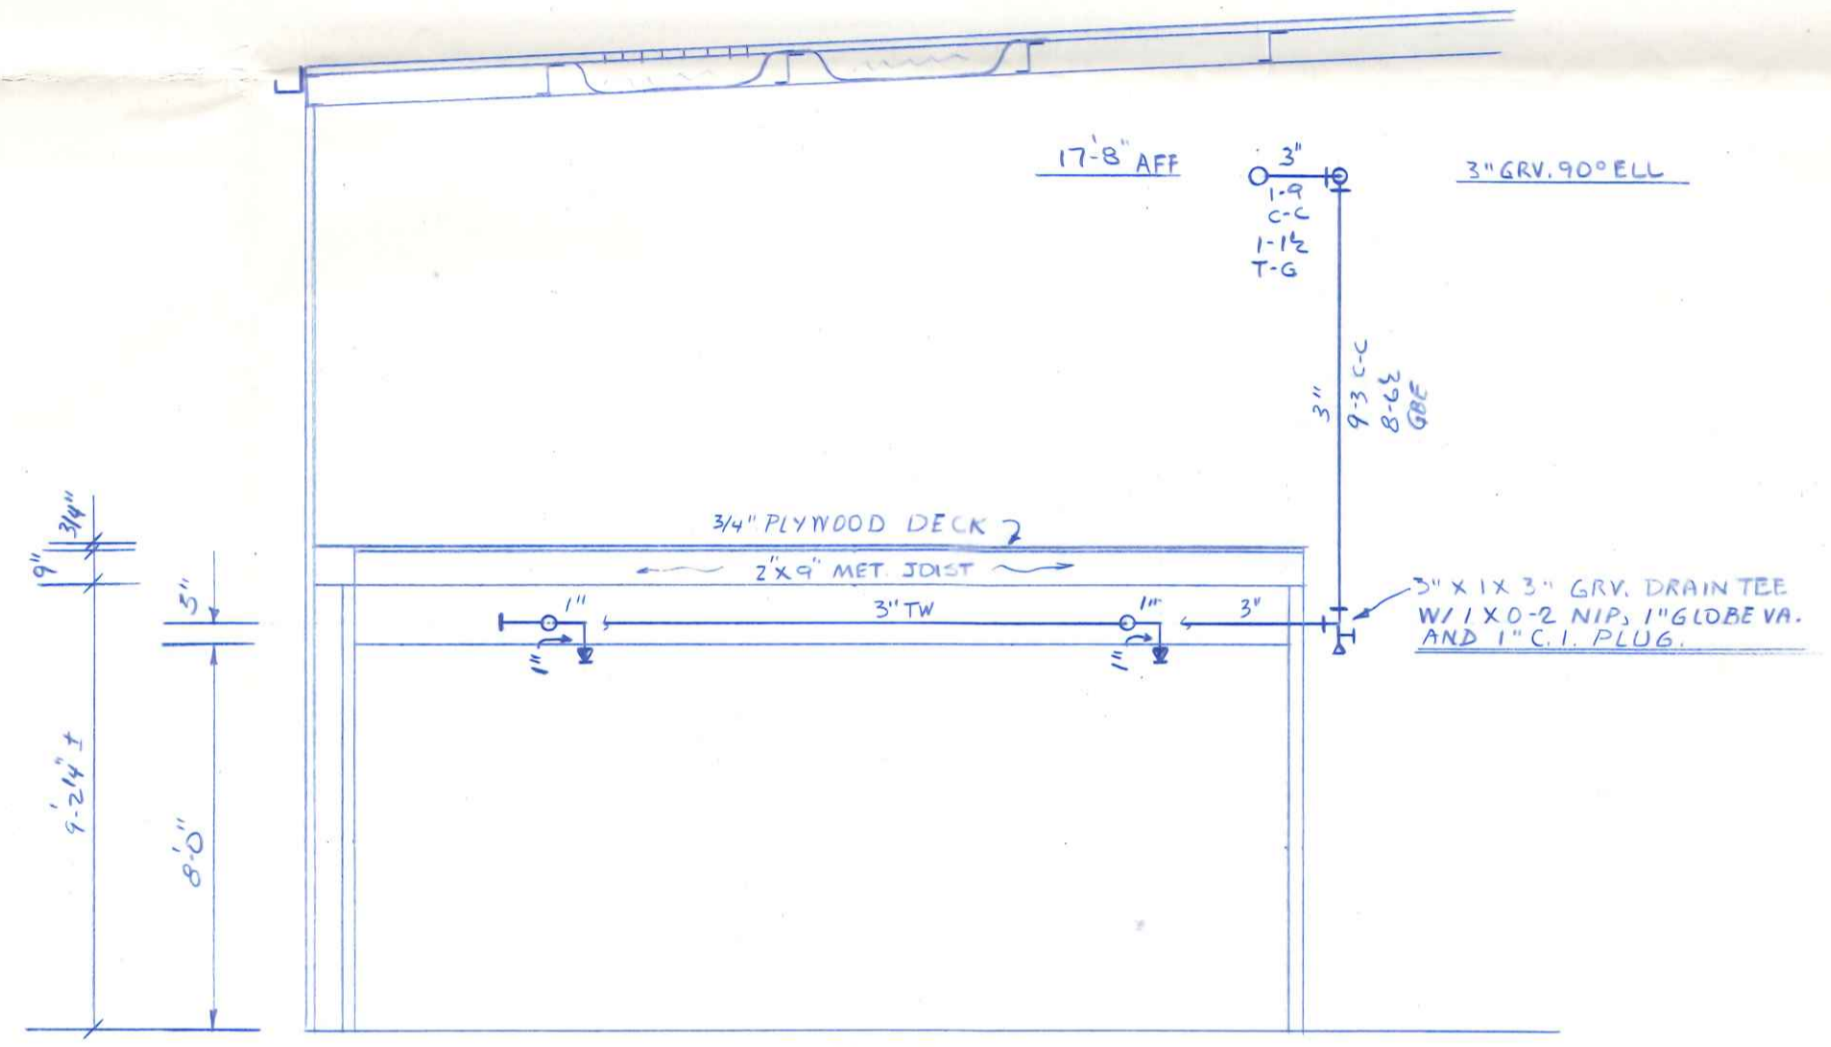

SECTION "C-C"
 SCALE 1/4" = 1'-0"

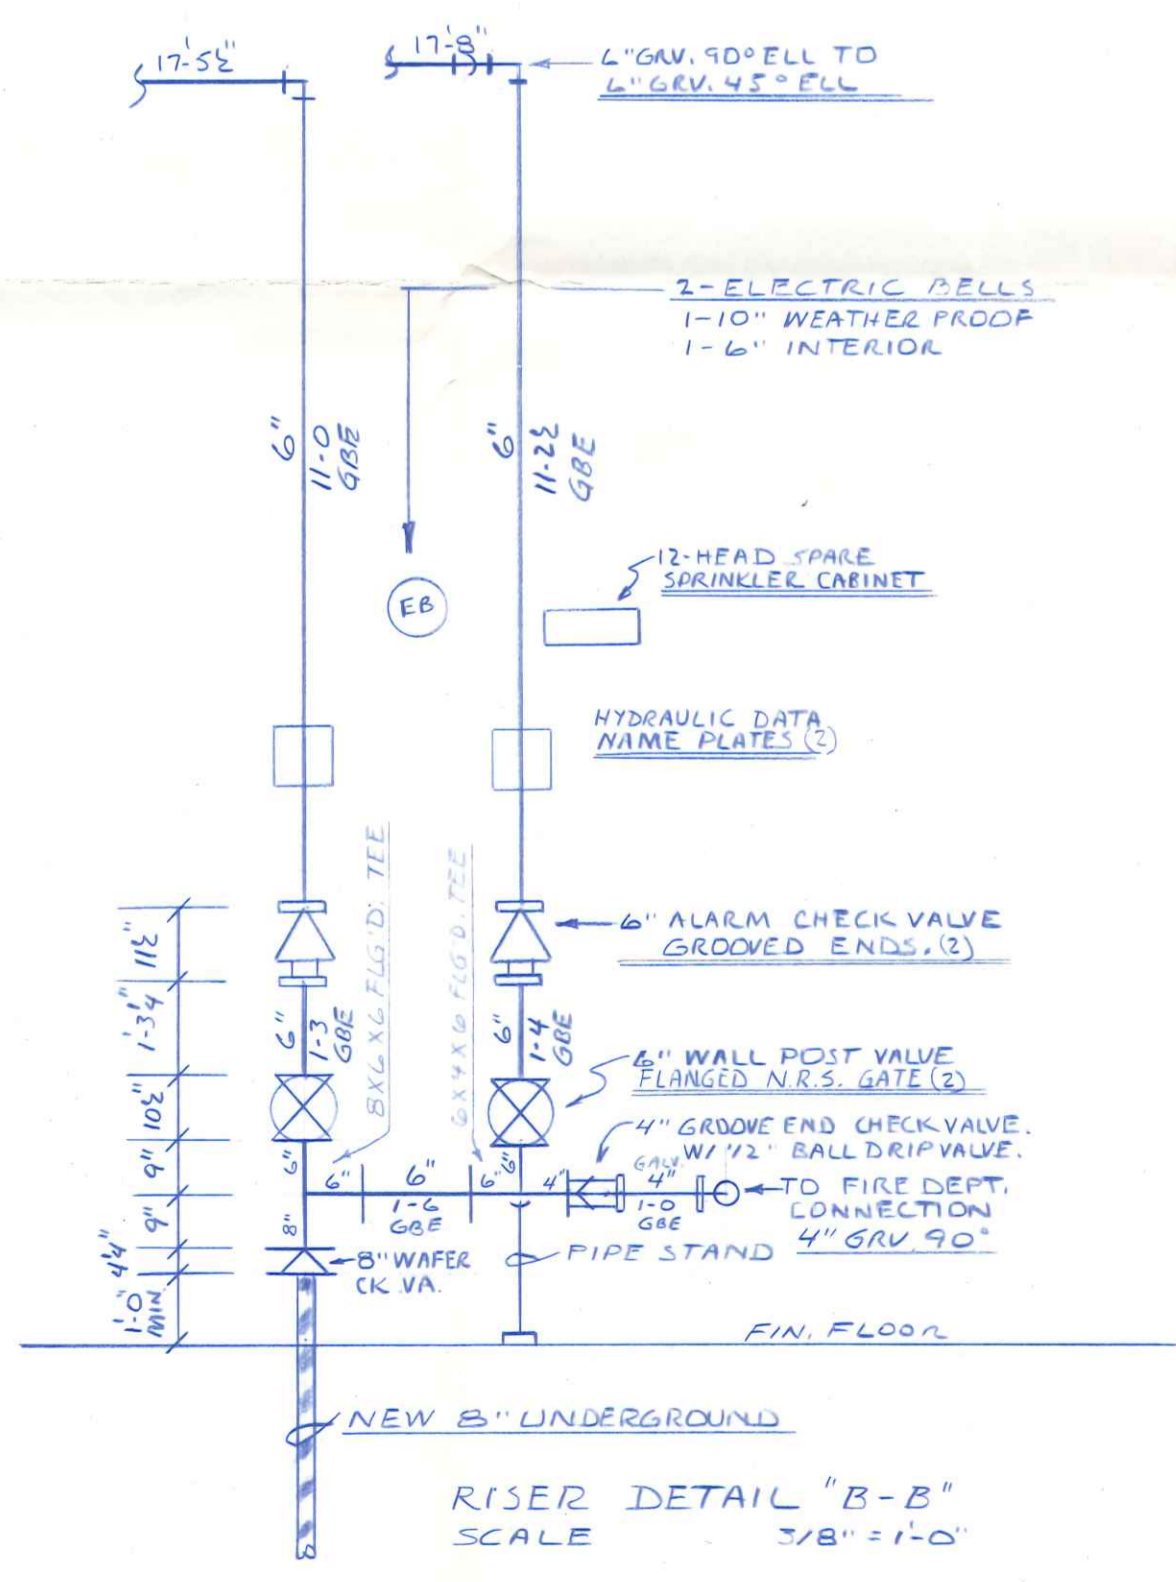

RISER DETAIL "B-B"
 SCALE 3/8" = 1'-0"

SEE DWG FP-2 FOR GENERAL NOTES!

800 Independence

SPRINKLERS				SYSTEM		CONTRACT NAME:		SCALE:	
TYPE	SYMBOL	TEMP	QUANT	WET	DRY	ARROW MOLDED PLASTICS, INC.		AS NOTED	
1/2" CHR. PEND.	⊕	165°	35	<input checked="" type="checkbox"/>	<input type="checkbox"/>	INDEPENDENCE DRIVE		DRAWN BY: D HAYES	
W/1-PC. PLATES				<input type="checkbox"/>	<input type="checkbox"/>	NAPOLEON, OHIO 43545		CHECKED BY:	
				<input type="checkbox"/>	<input type="checkbox"/>	CONTRACT WITH:		PUR. ORD. NO.	
				<input type="checkbox"/>	<input type="checkbox"/>	R & R PROPERTIES		PROJECT NO.	
				<input type="checkbox"/>	<input type="checkbox"/>			FILE NO.	
				<input type="checkbox"/>	<input type="checkbox"/>			DRAWING NO.	
				<input type="checkbox"/>	<input type="checkbox"/>			FP-1 OF 3	
				<input type="checkbox"/>	<input type="checkbox"/>			CONTRACT NO.	
				<input type="checkbox"/>	<input type="checkbox"/>			91105	
TOTAL				DIALECTIC					

FIRE TECH SPRINKLER, INC.
 4248 Kingsmoor Drive Toledo, Ohio 43613