




FRONT ELEVATION
1/4" = 1'-0"

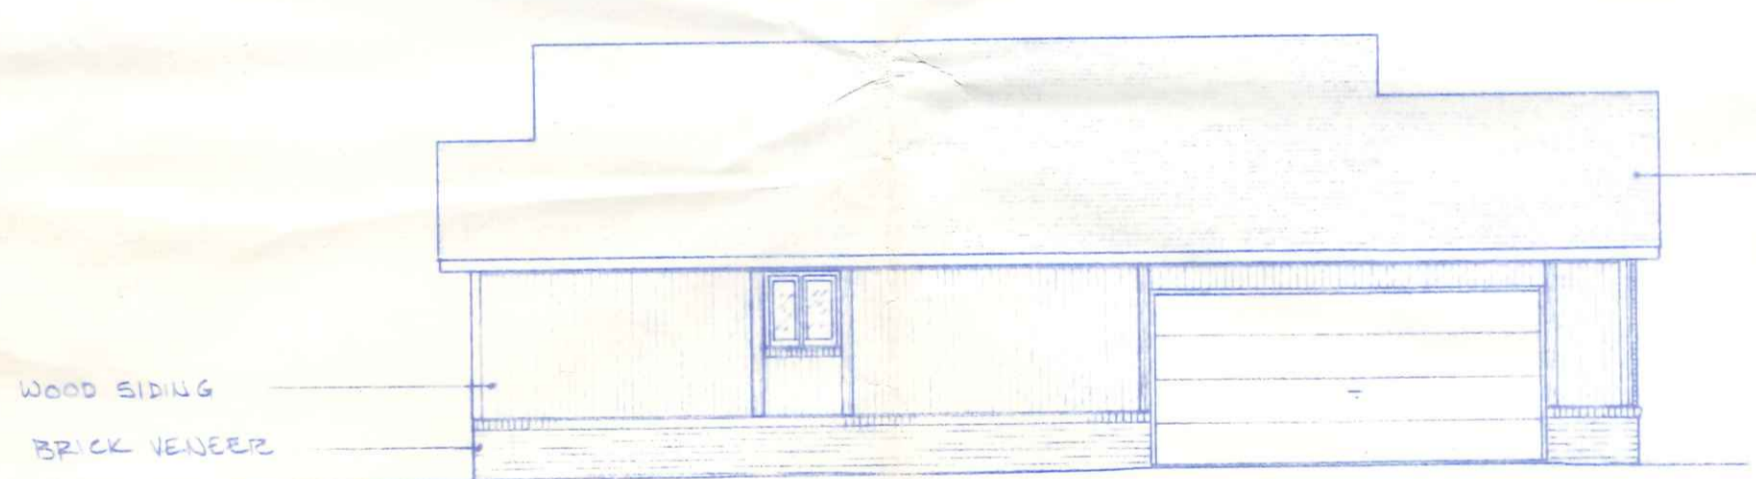

LEFT SIDE ELEVATION
1/8" = 1'-0"

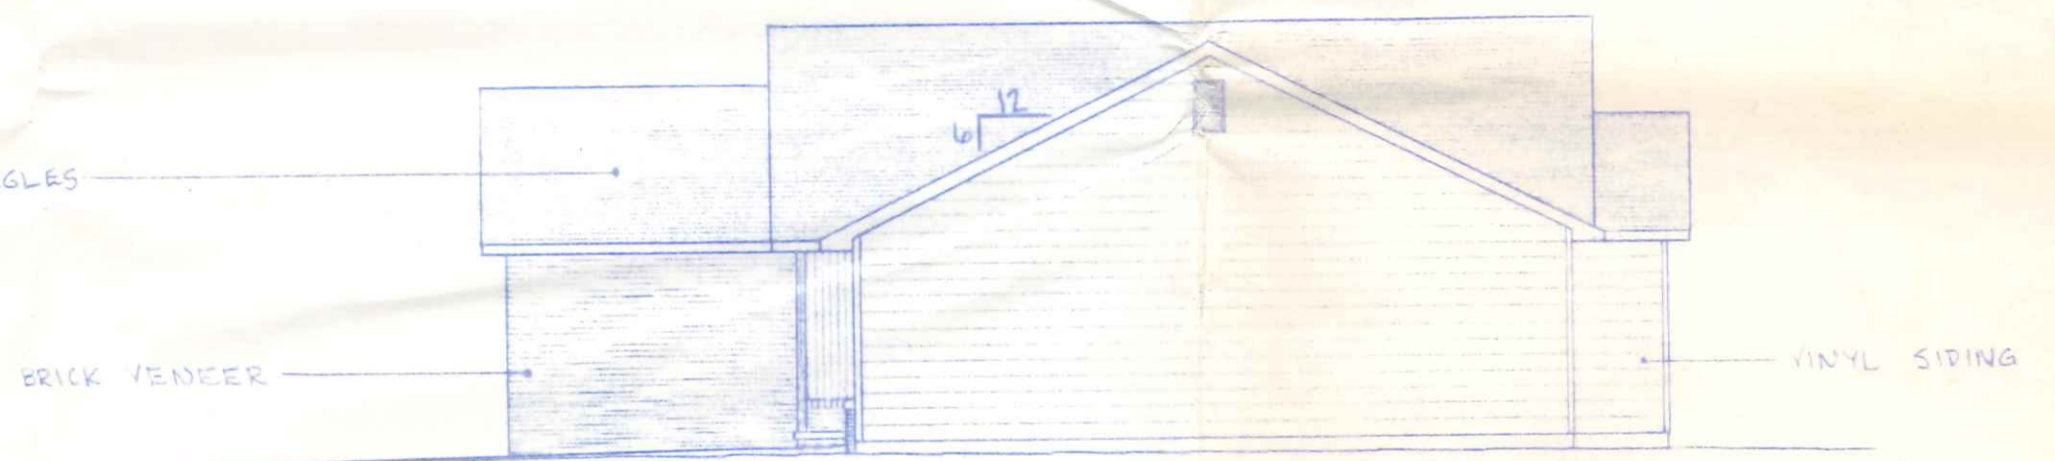



RIGHT SIDE ELEVATION
1/8" = 1'-0"

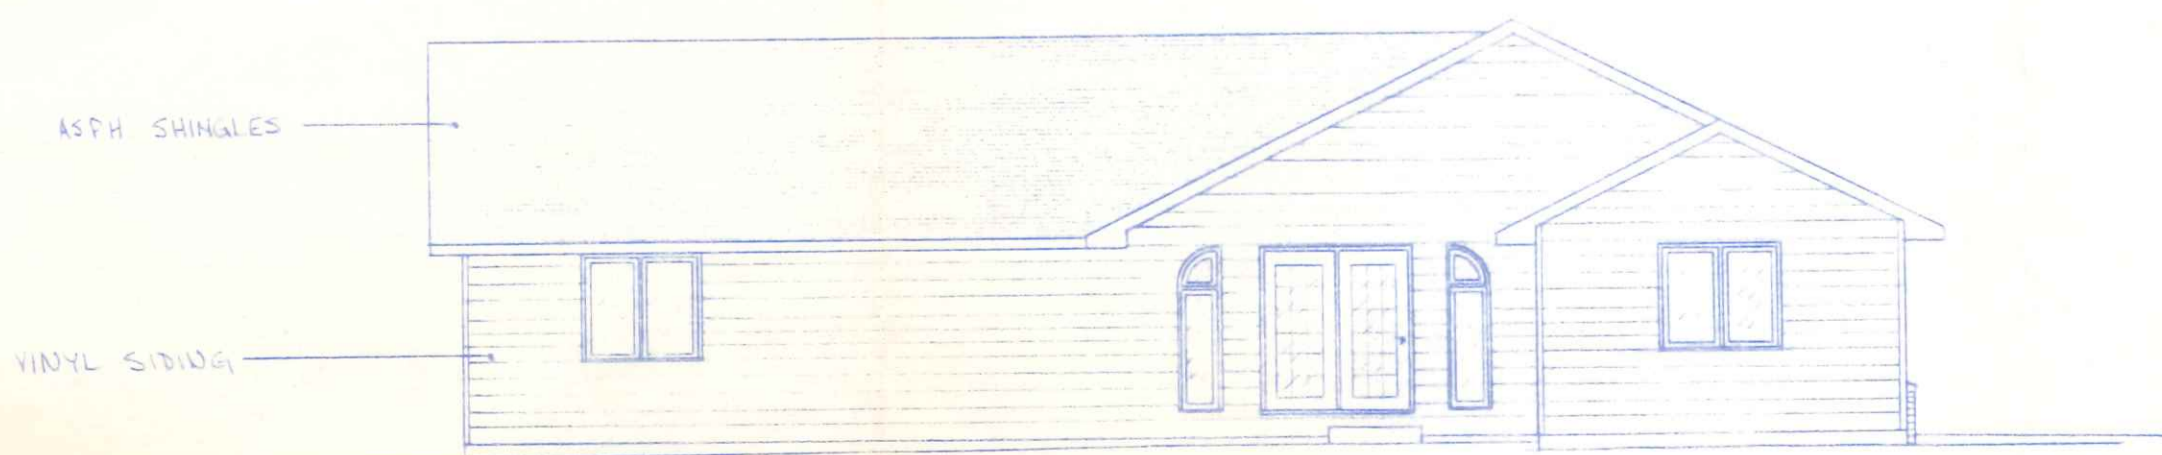

REAR ELEVATION
1/8" = 1'-0"

Rath

BECK CONSTRUCTION CO.		
CO. RD. M.	50 Lemans	NAPOLEON, OHIO
SCALE: NOTED	APPROVED BY:	DRAWN BY R.D.S.
DATE: JULY 1991		REVISED
PLAN No. 259		DRAWING NUMBER 1 OF 5

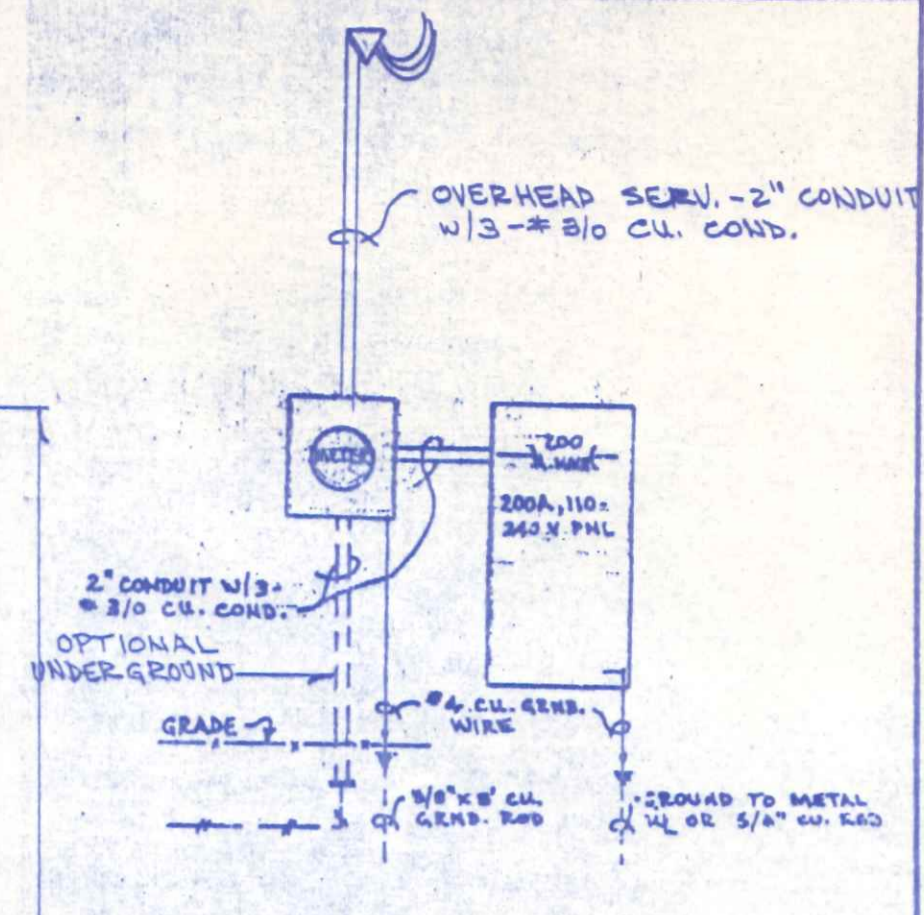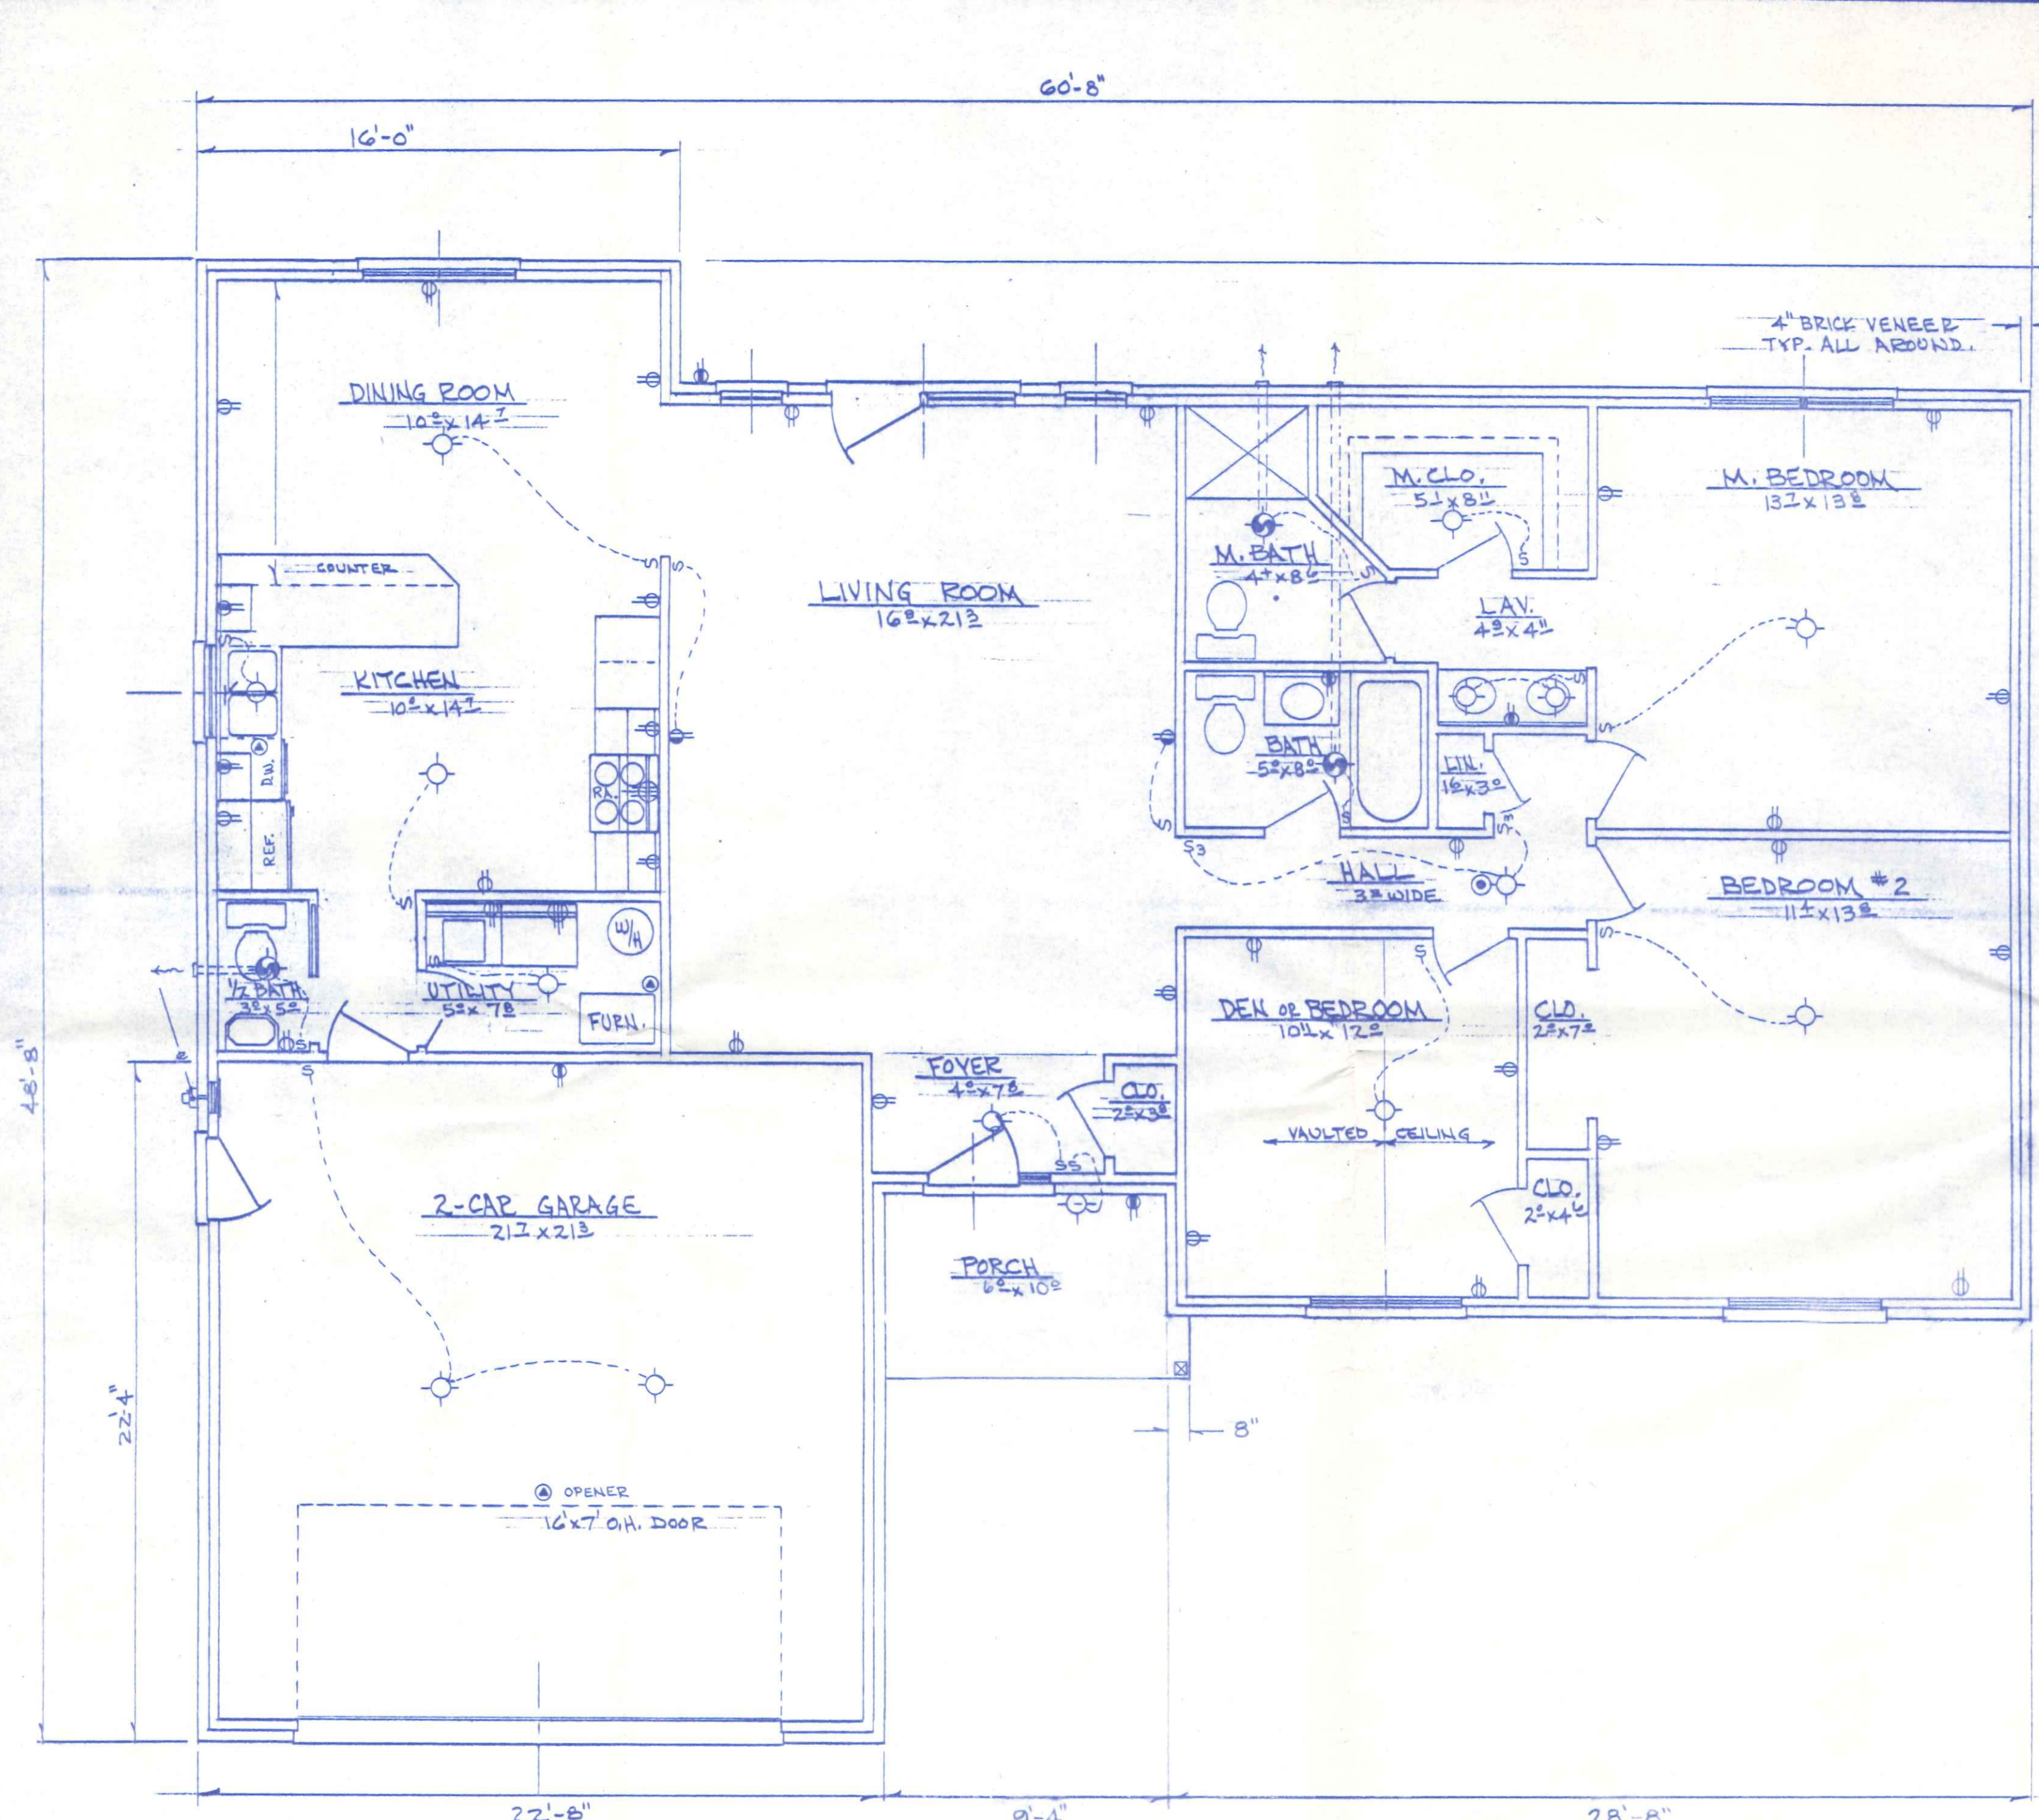

ELECTRICAL RISER DIAGRAM

NO. SCALE

- LEGEND**
- CEILING LIGHT
 - WALL LIGHT
 - CEILING CIRCULATING FAN
 - CEILING LIGHT WITH CIRCULATING FAN
 - CEILING LIGHT WITH EXHAUST FAN
 - EXTERIOR FLOOD LIGHT
 - PRIMARY POWERED SMOKE DETECTOR (WITH BATTERY BACKUP OPTIONAL)
 - SPECIAL OUTLET AS NOTED
 - 120V - 20A DUPLEX RECEPTICLE
 - 120V - 20A DUPLEX RECEPTICLE 2/ SWITCHED
 - 120V - 20A DUPLEX RECEPTICLE WITH G.F.C.I. PROTECTION
 - 240V APPLIANCE OUTLET
 - 120V - 30A LIGHT SWITCH
 - 120V - 20A FAN SWITCH
 - 120V - 20A 3 WAY LIGHT SWITCH

- NOTES**
- 1) See Foundation Plan for Basement Electrical
 - 2) Min. 20A. CIR., #12 Wire
 - 3) All Work and Material shall be as per National Electric Code

BECK CONSTRUCTION CO.

CO. RD. M. NAPOLEON, OHIO

SCALE: 1/4" = 1'-0" APPROVED BY: _____ DRAWN BY: EDS

DATE: MAY, 1991 REVISED _____

FLOOR PLAN - ELECTRICAL


PLAN NO. 259 DRAWING NUMBER 3 of 5

60'-8"

16'-0"

4'-0"

30'-8"
34'-8"

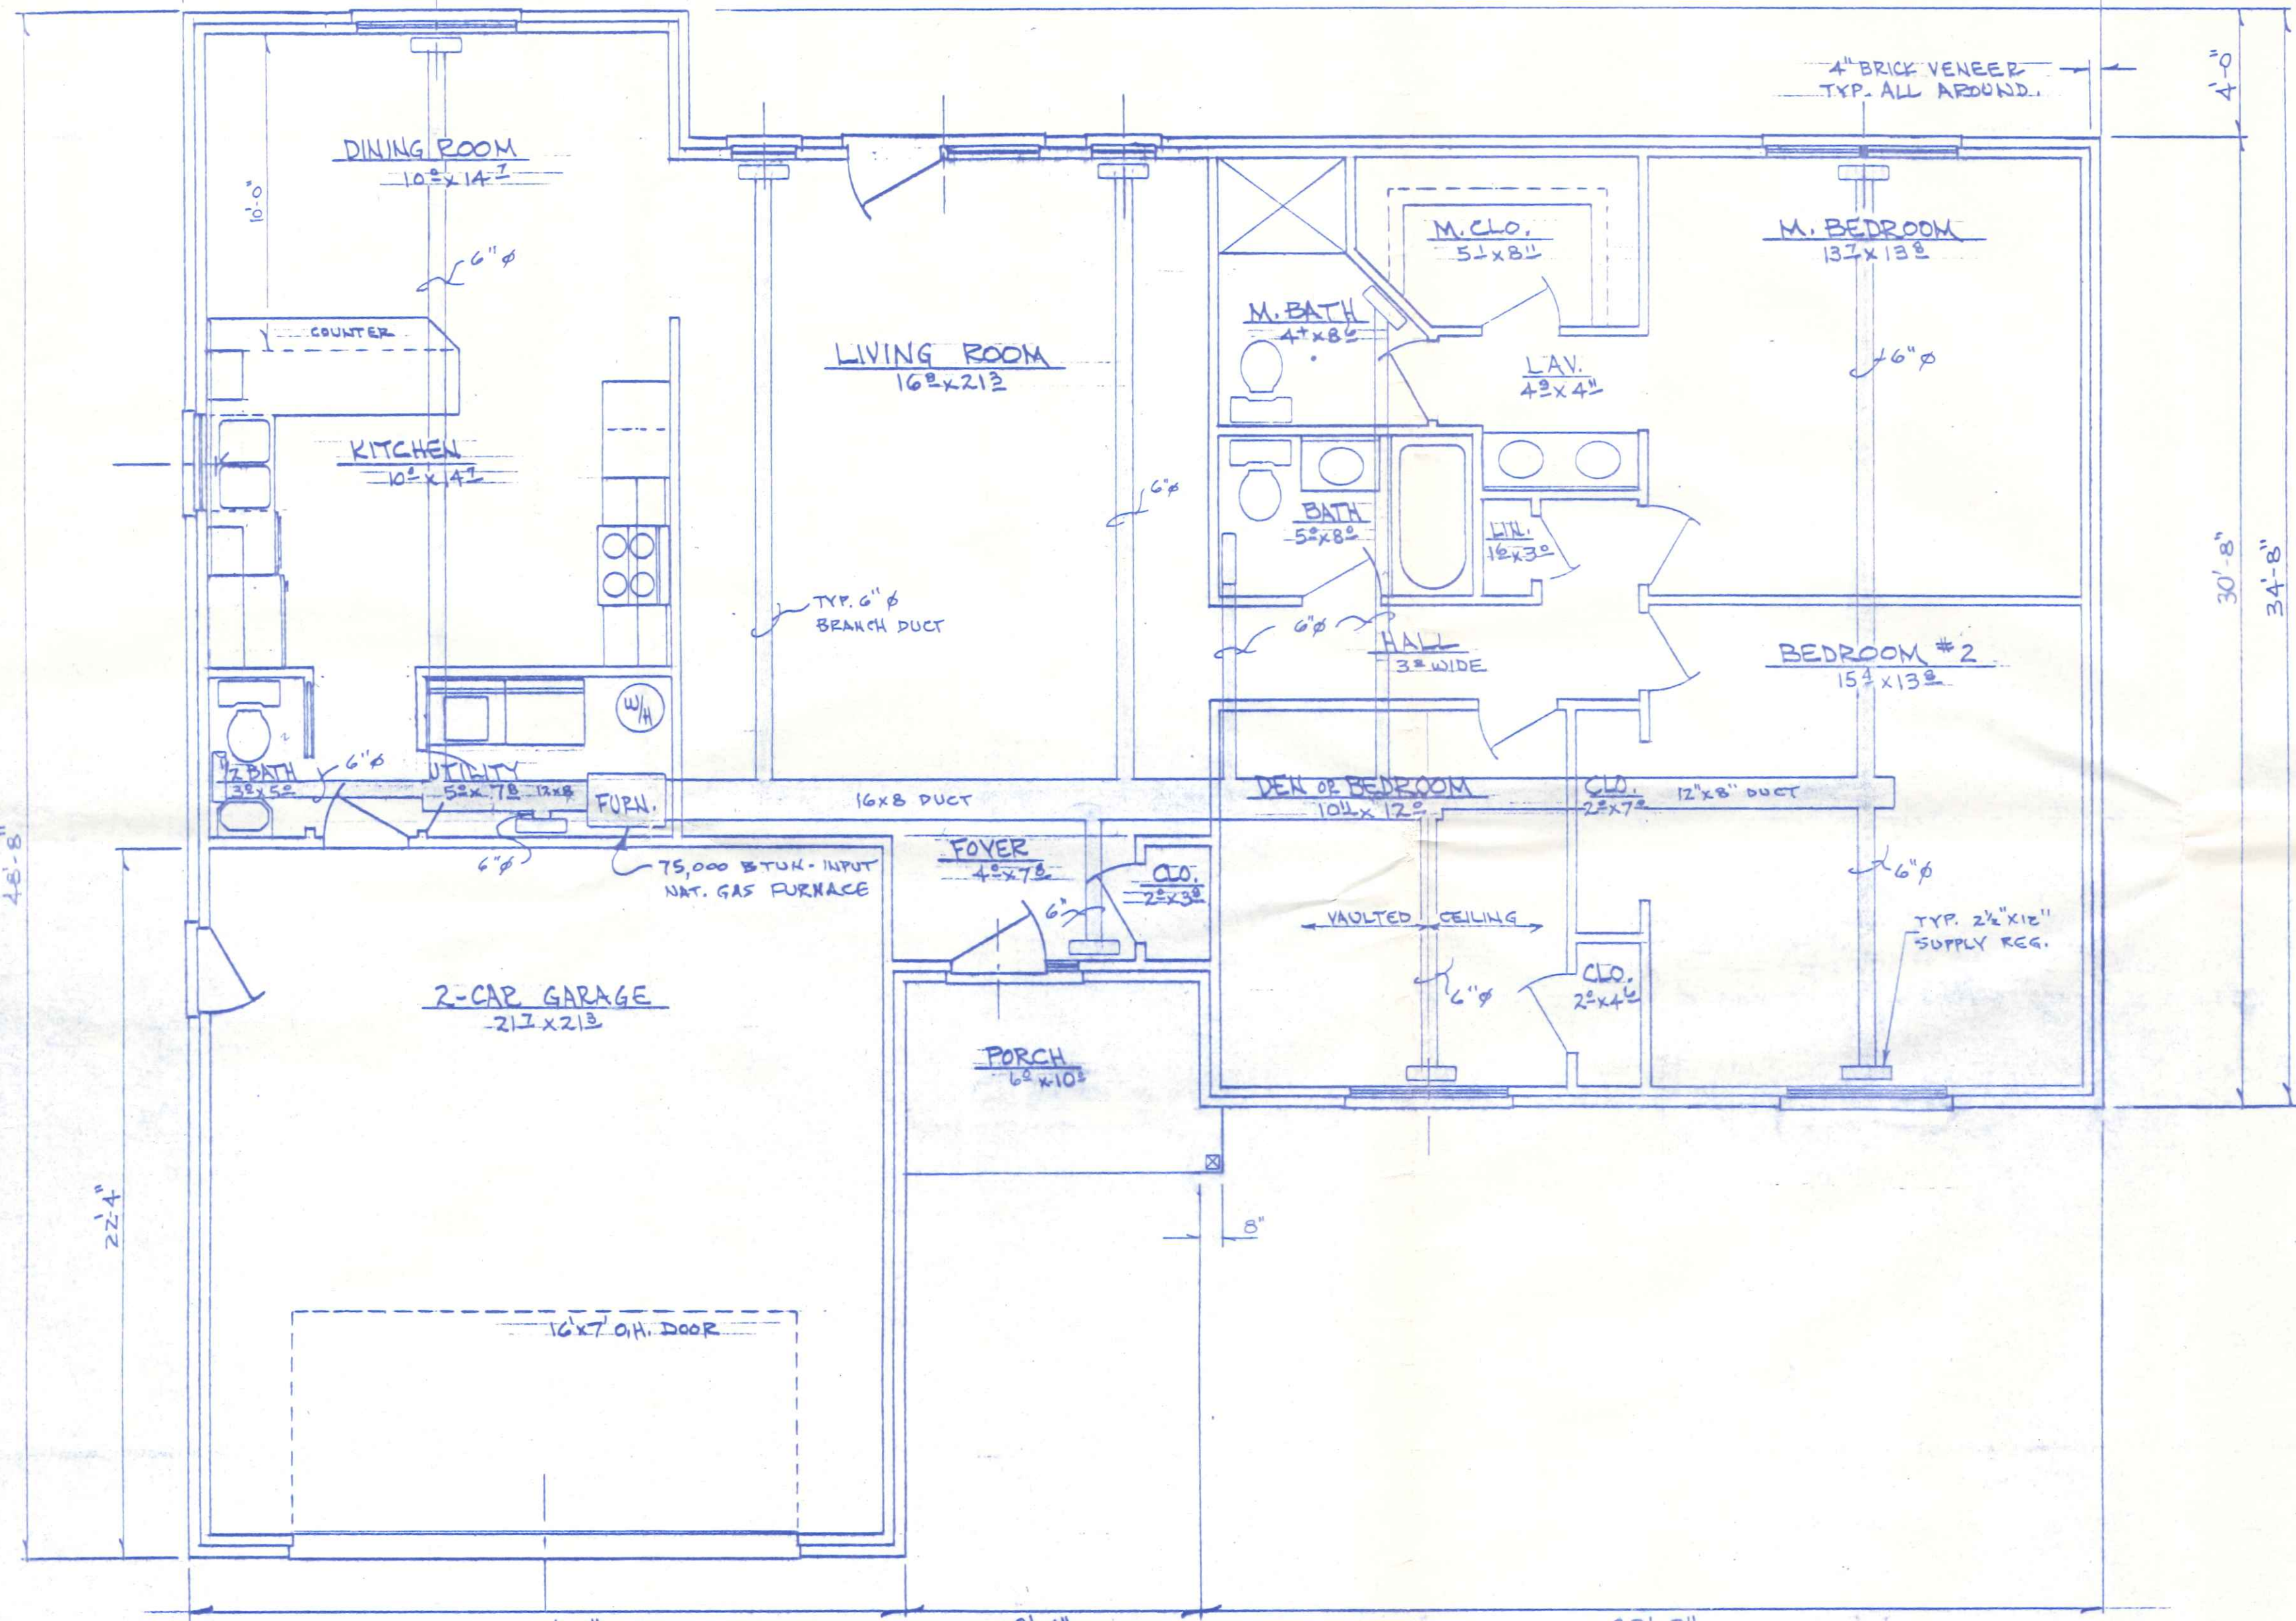

22'-8"

9'-4"

28'-8"

BECK CONSTRUCTION CO.		NAPOLEON, OHIO	
CO. R.D. M.	APPROVED BY:	DRAWN BY EDS	
SCALE: 1/4" = 1'-0"		REVISED	
DATE: MAY, 1991			
FLOOR PLAN - HEATING			
PLAN NO. 259		DRAWING NUMBER 4 of 5	

