






FRONT ELEVATION
1/4" = 1'-0"

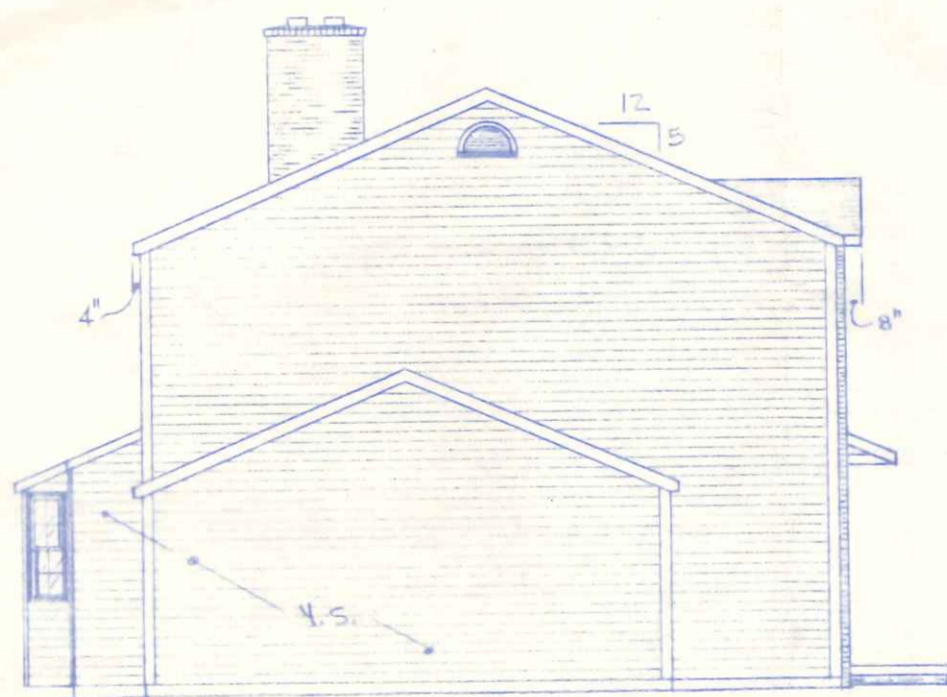

LEFT SIDE ELEVATION
1/8" = 1'-0"

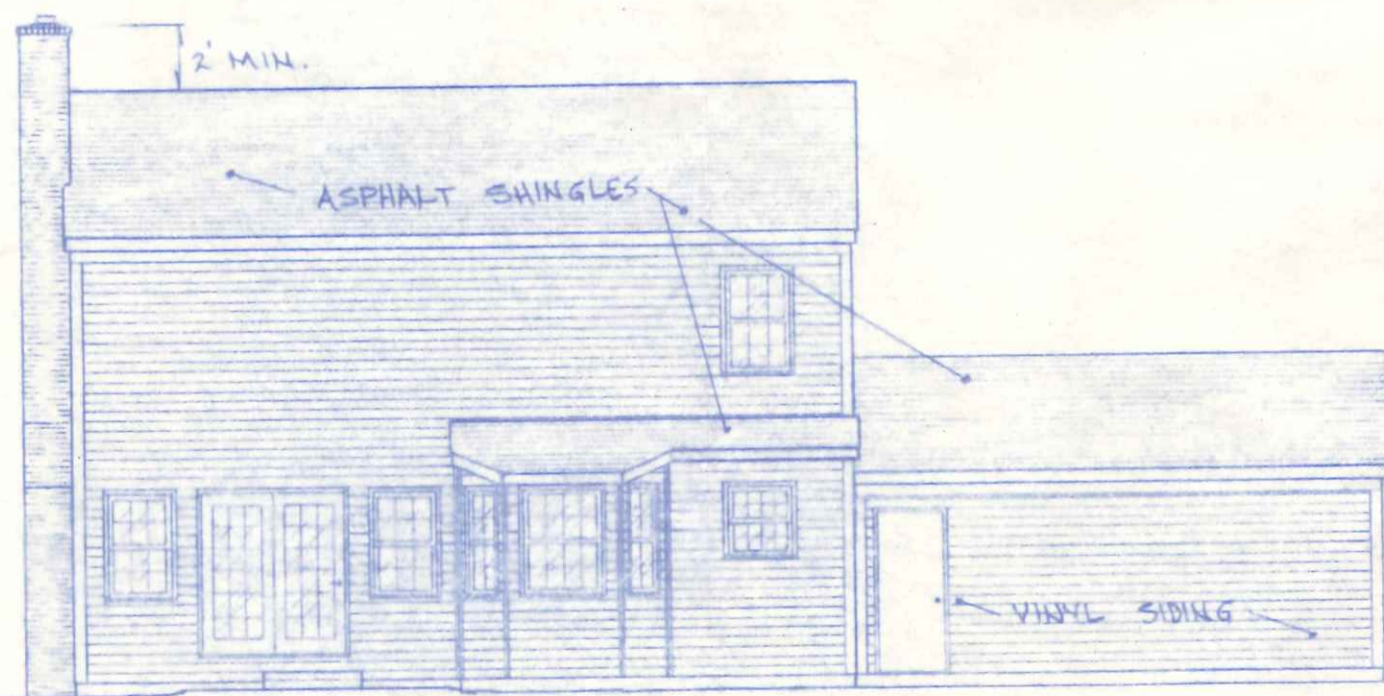


REAR ELEVATION
1/8" = 1'-0"

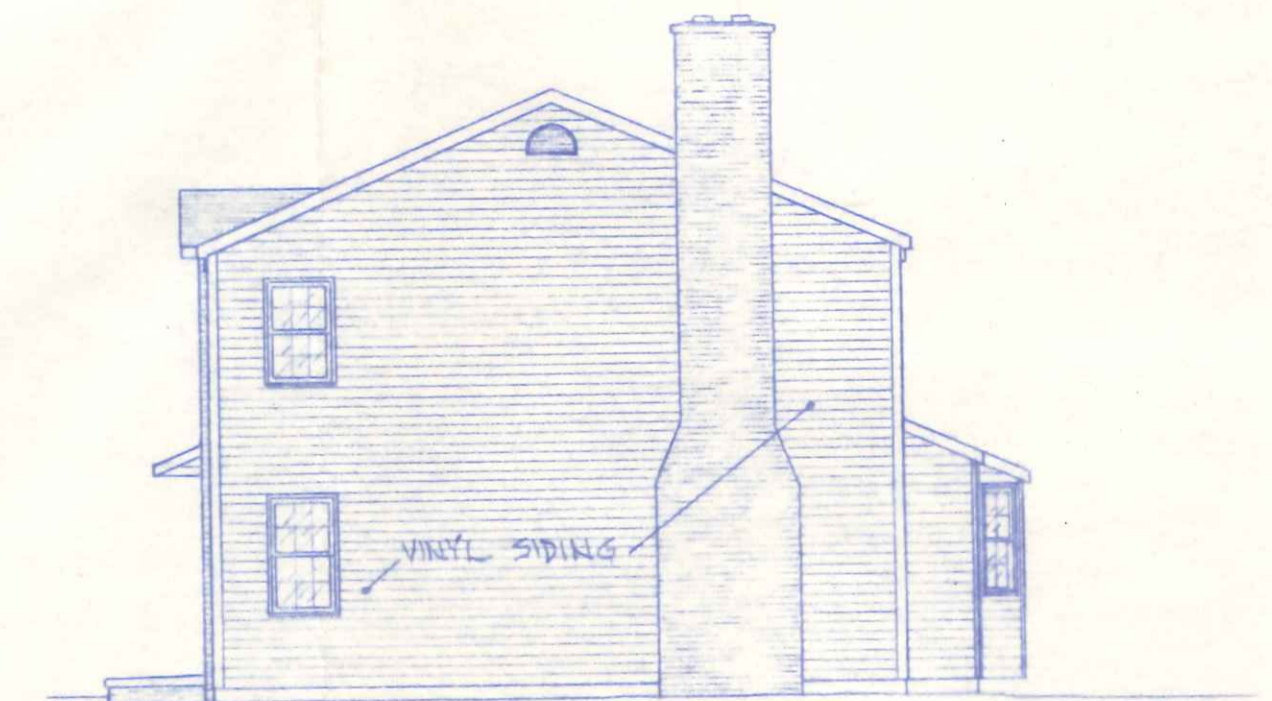

RIGHT SIDE ELEVATION
1/8" = 1'-0"


BECK CONSTRUCTION CO.		NAPOLEON, OHIO	
CO. RD. M	Todd Plassman		
SCALE: NOTED	APPROVED BY	DRAWN BY R.D.S.	
DATE: JUNE - 91	55 Lemans	REVISED	
EXTERIOR ELEVATIONS			
PLAN NO. 258		DRAWING NUMBER	
		1 OF 6	

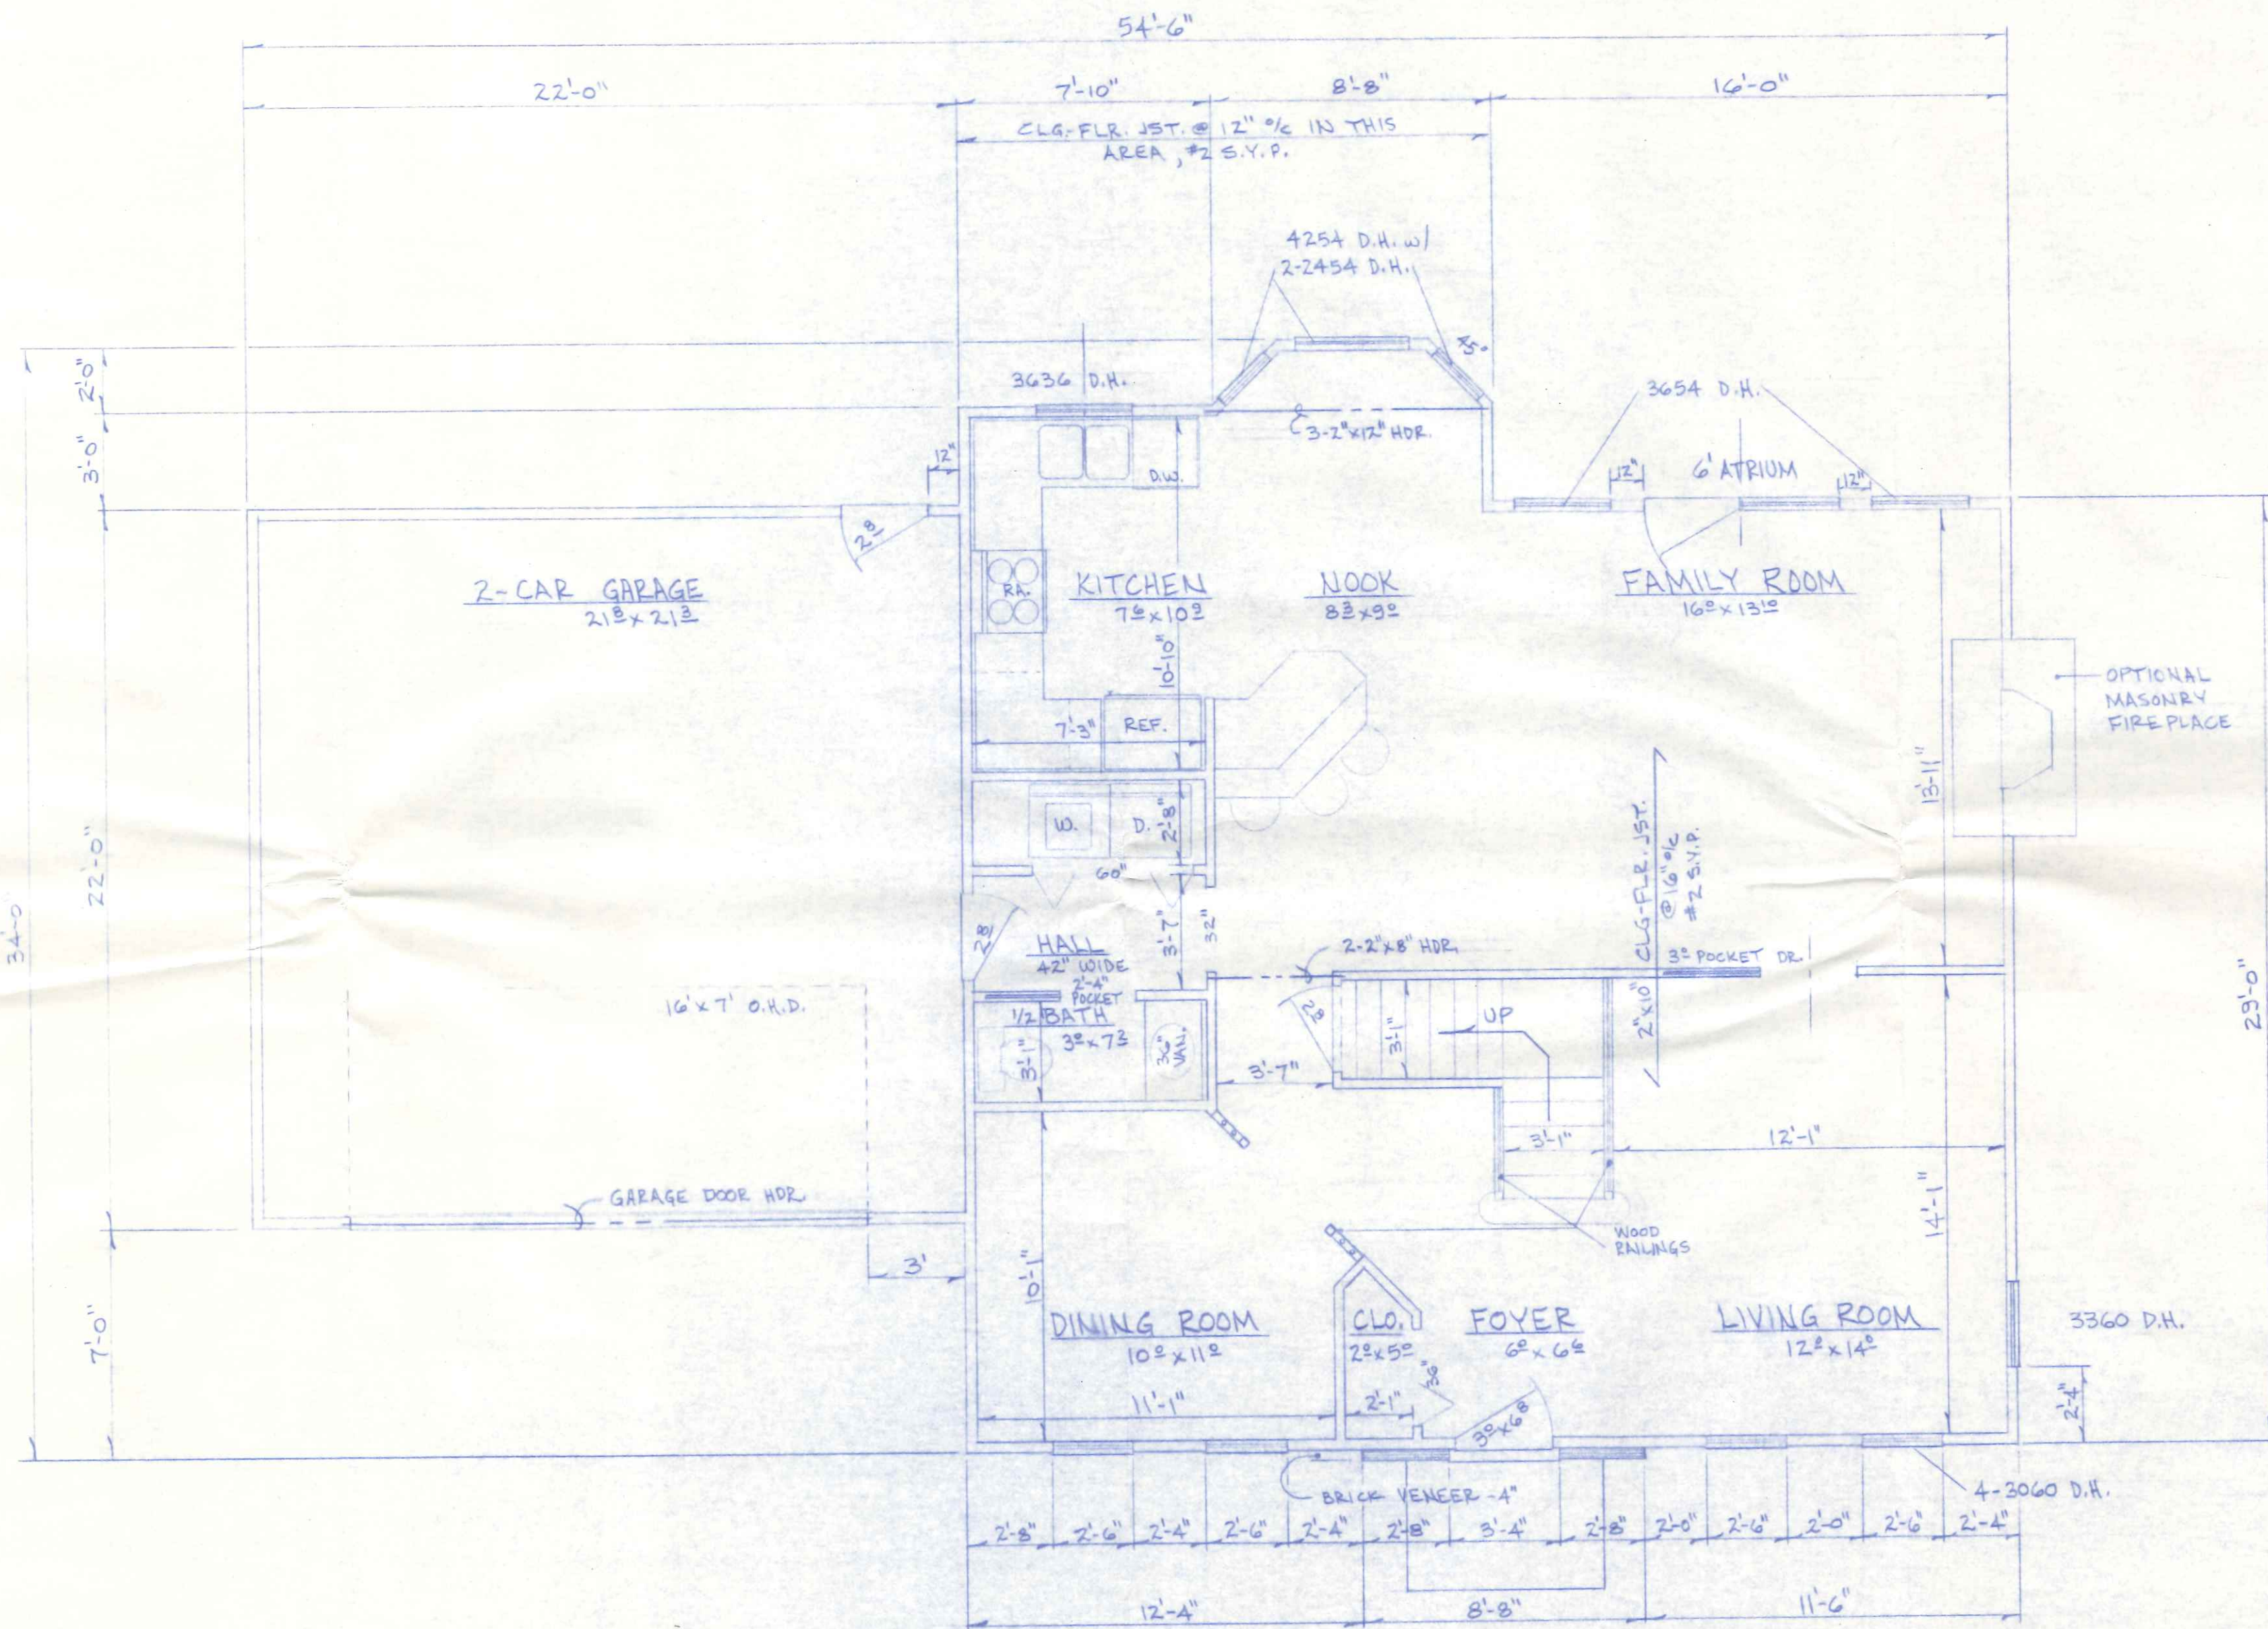


AREAS.

LIVING AREA:		
FIRST FLOOR,	1005.3	SQ. FT. GROSS
SECOND FLOOR,	819.6	" " "
SUB-TOTAL	1824.9	" " "
GARAGE :	484.0	" " "

BECK CONSTRUCTION CO.		
CO. RD. M.	NAPOLEON, OHIO	
SCALE: 1/4" = 1'-0"	APPROVED BY:	DRAWN BY R.D.S.
DATE: JUNE - 91		REVISED
FLOOR PLAN - FIRST		
PLAN NO. 258	DRAWING NUMBER 2 OF 6	

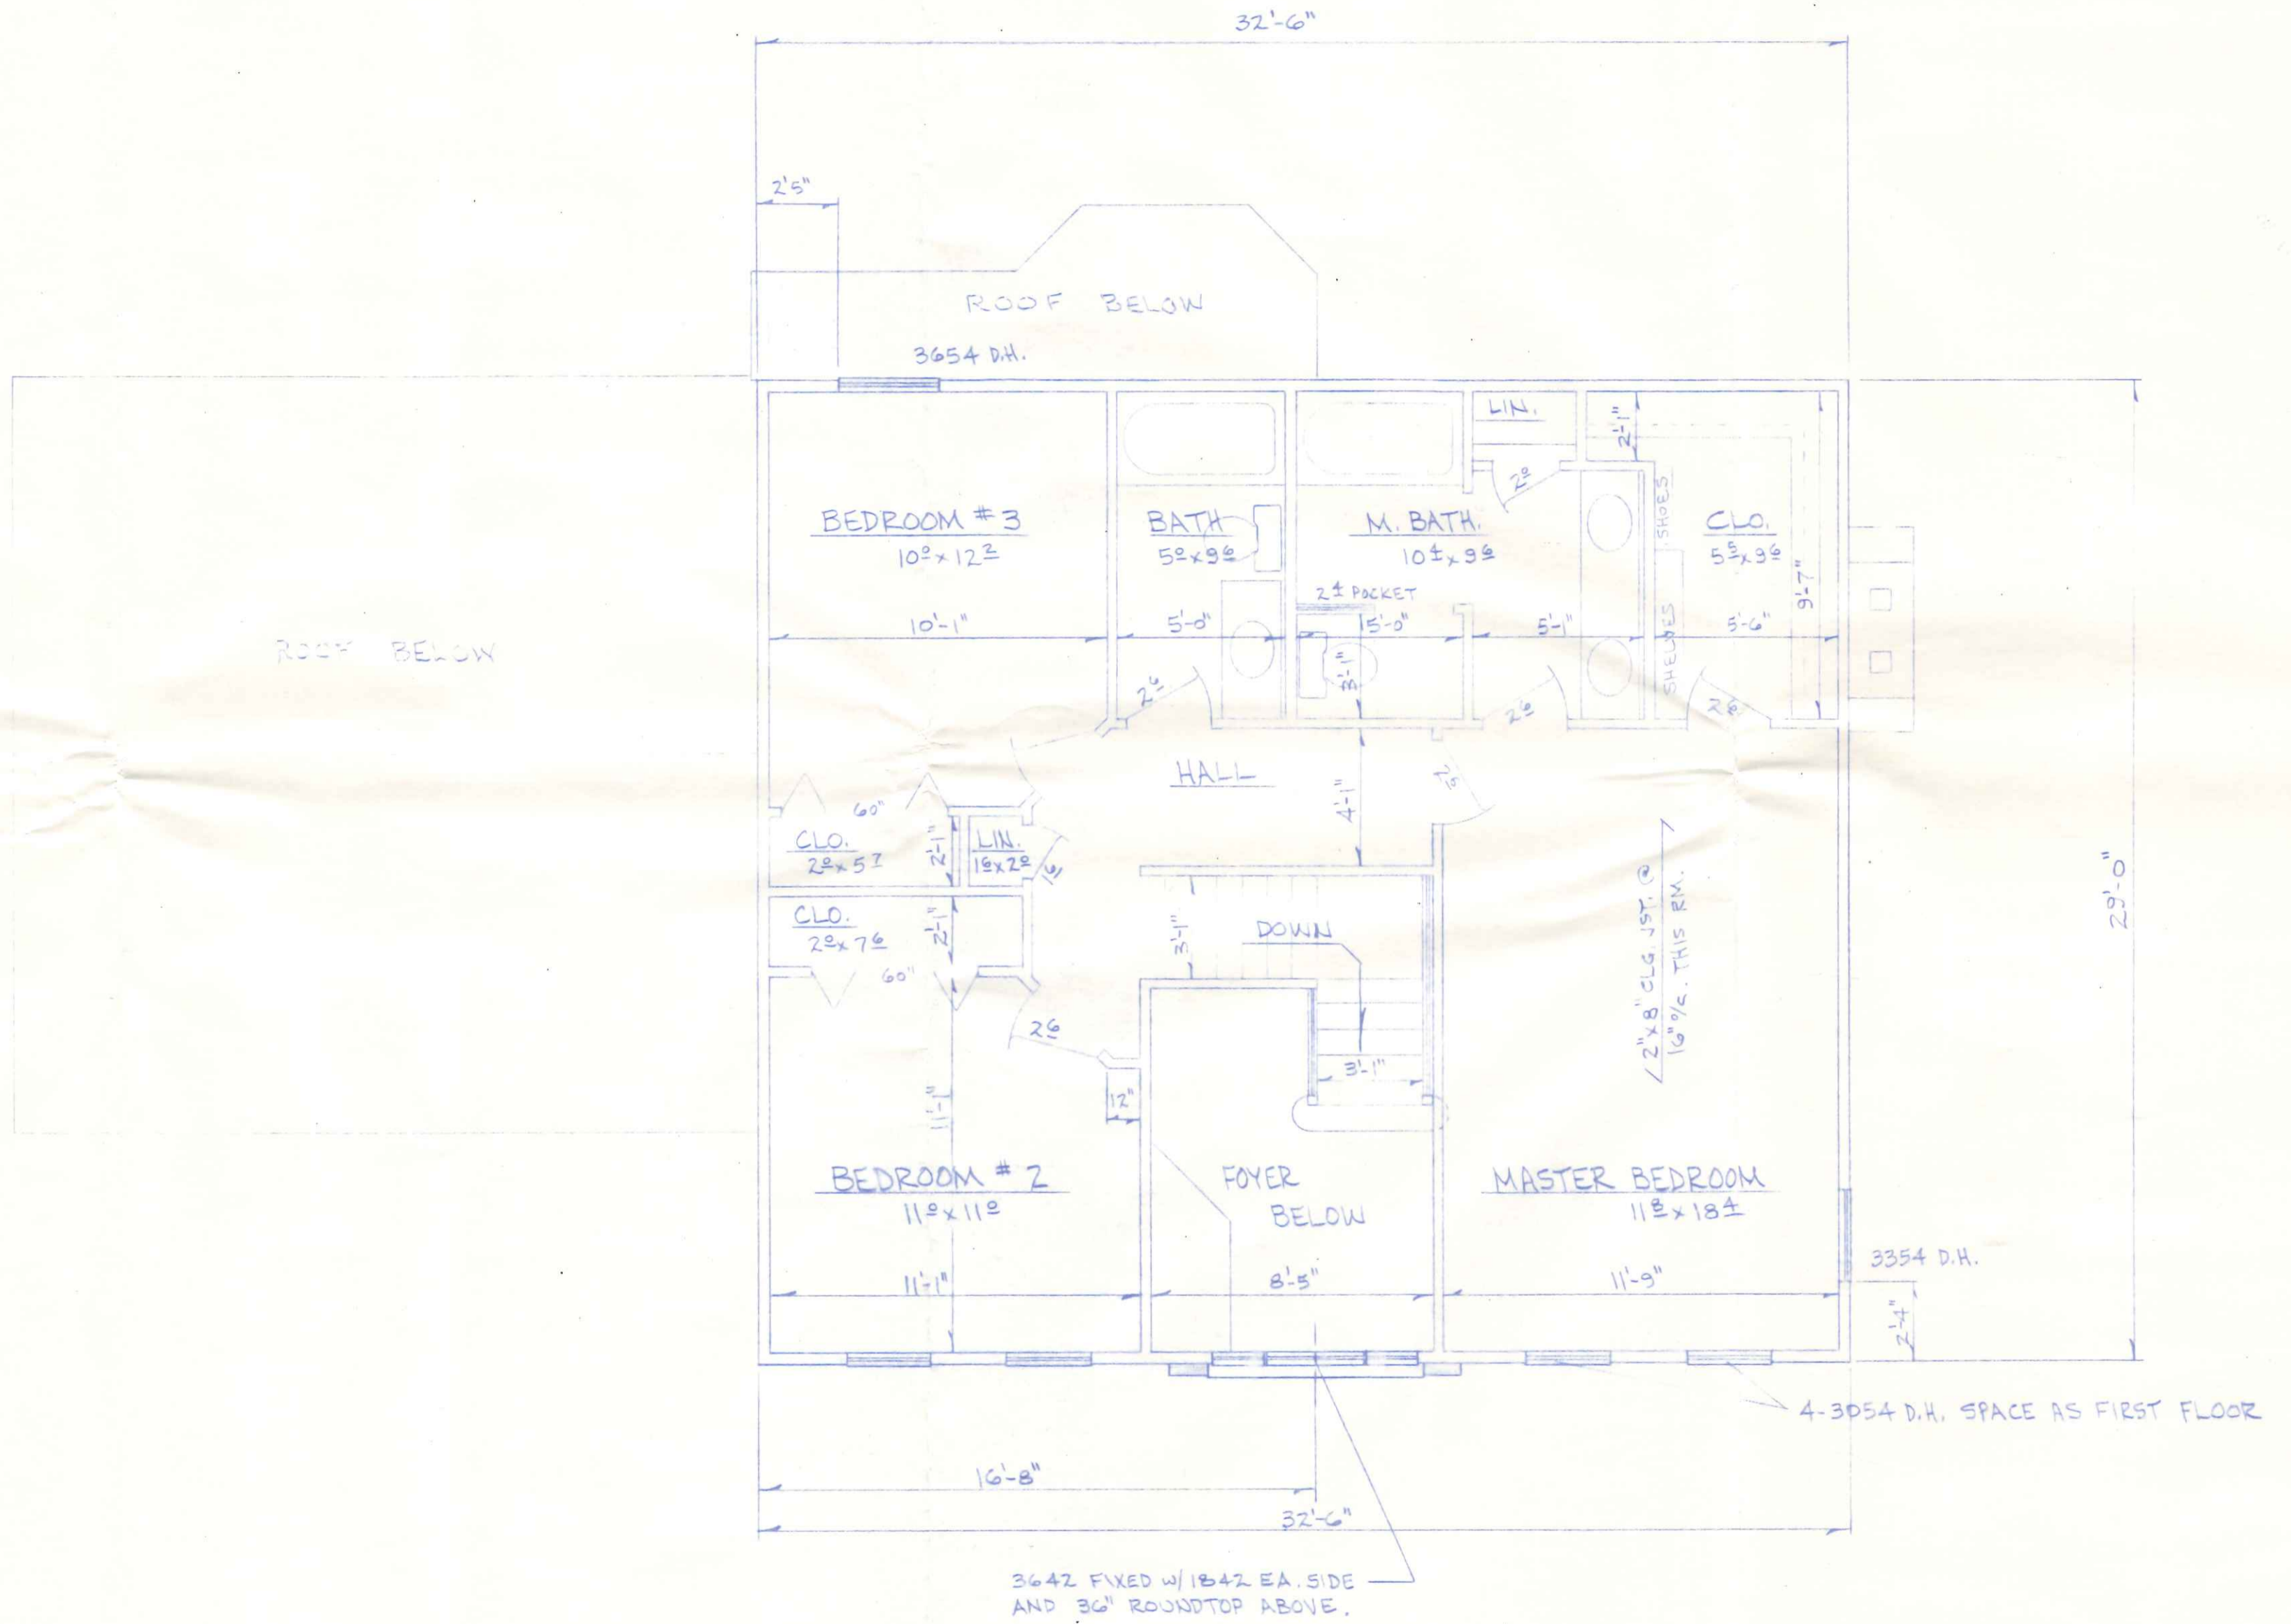


BECK CONSTRUCTION CO.		NAPOLEON, OHIO	
CO. RD. M.	APPROVED BY:	DRAWN BY E.D.S.	
SCALE: 1/4" = 1'-0"		REVISED	
DATE: JUNE - 91		FLOOR PLAN - SECOND	
		DRAWING NUMBER	
		3 OF	

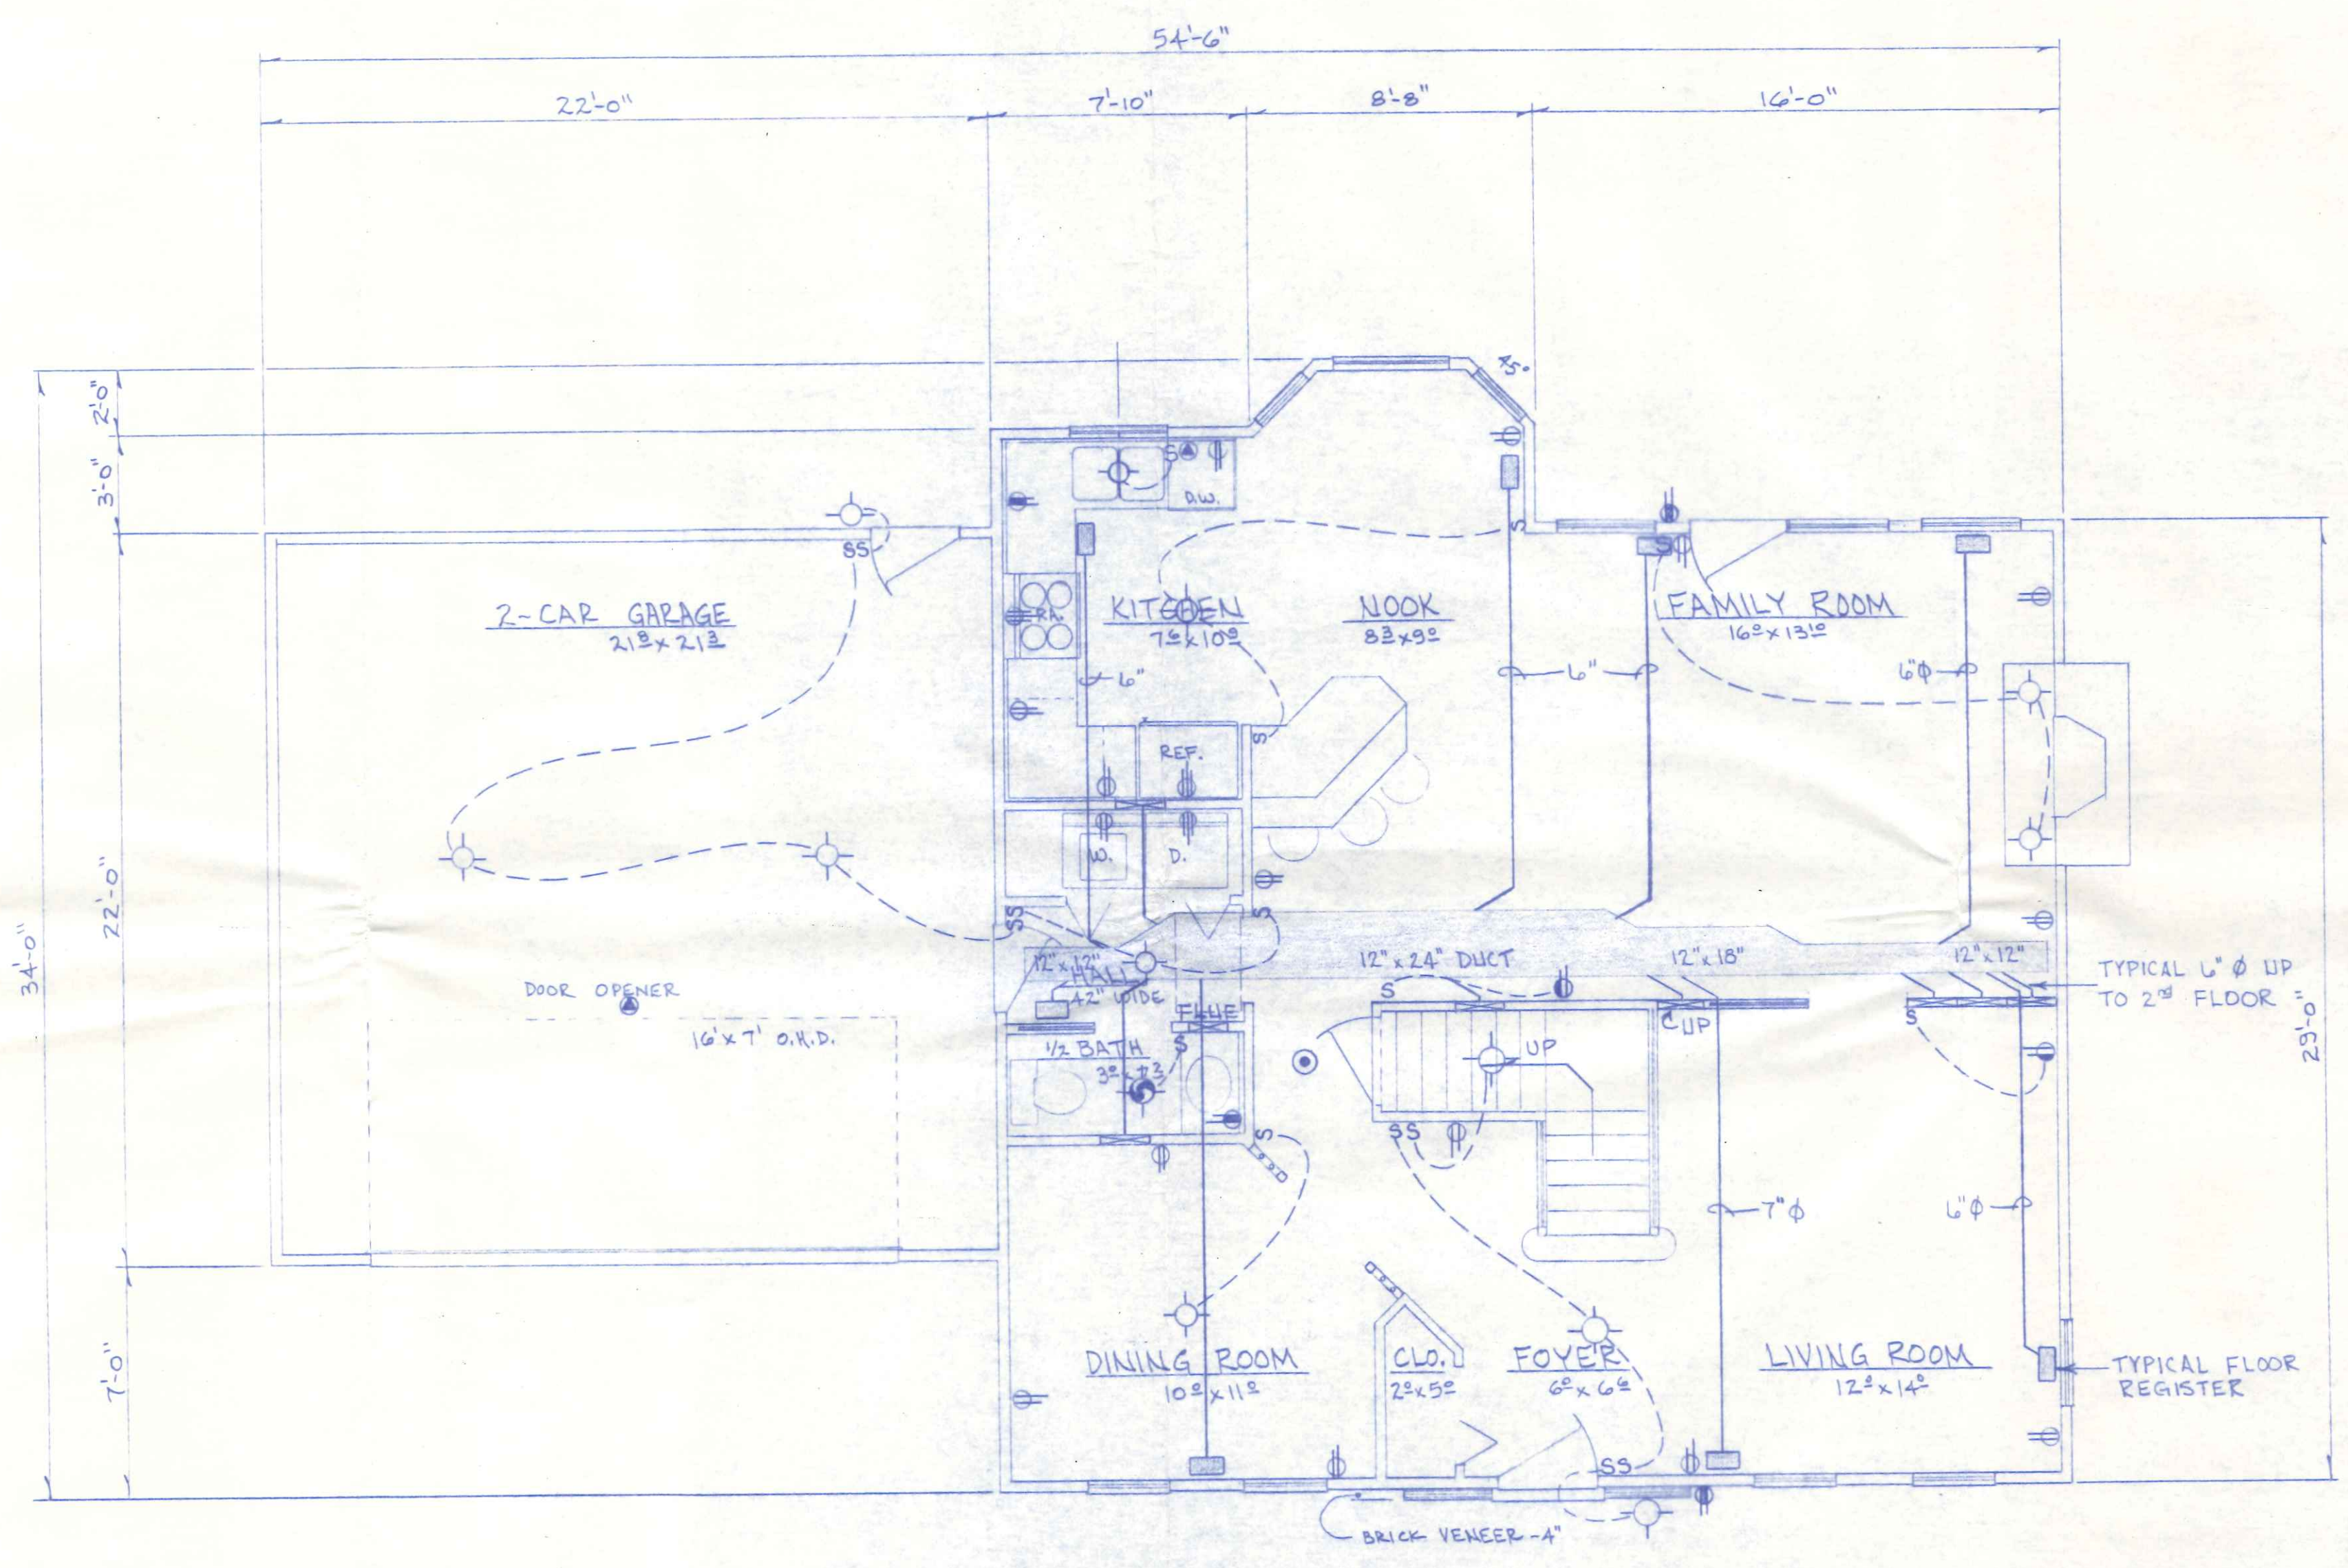

AREAS.

LIVING AREA:			
FIRST FLOOR,	1005.3	SQ. FT.	GROSS
SECOND FLOOR,	819.6	" "	" "
SUB-TOTAL	1824.9	" "	" "
GARAGE :			
	484.0	" "	" "


BECK CONSTRUCTION CO.		NAPOLEON, OHIO	
CO. RD. M	APPROVED BY:	DRAWN BY R.D.S.	
SCALE: 1/4" = 1'-0"		REVISED	
DATE: JUNE . 91			
ELECTRICAL & HEATING SCHEMATIC			
PLAN NO. 258			DRAWING NUMBER 4 OF 6

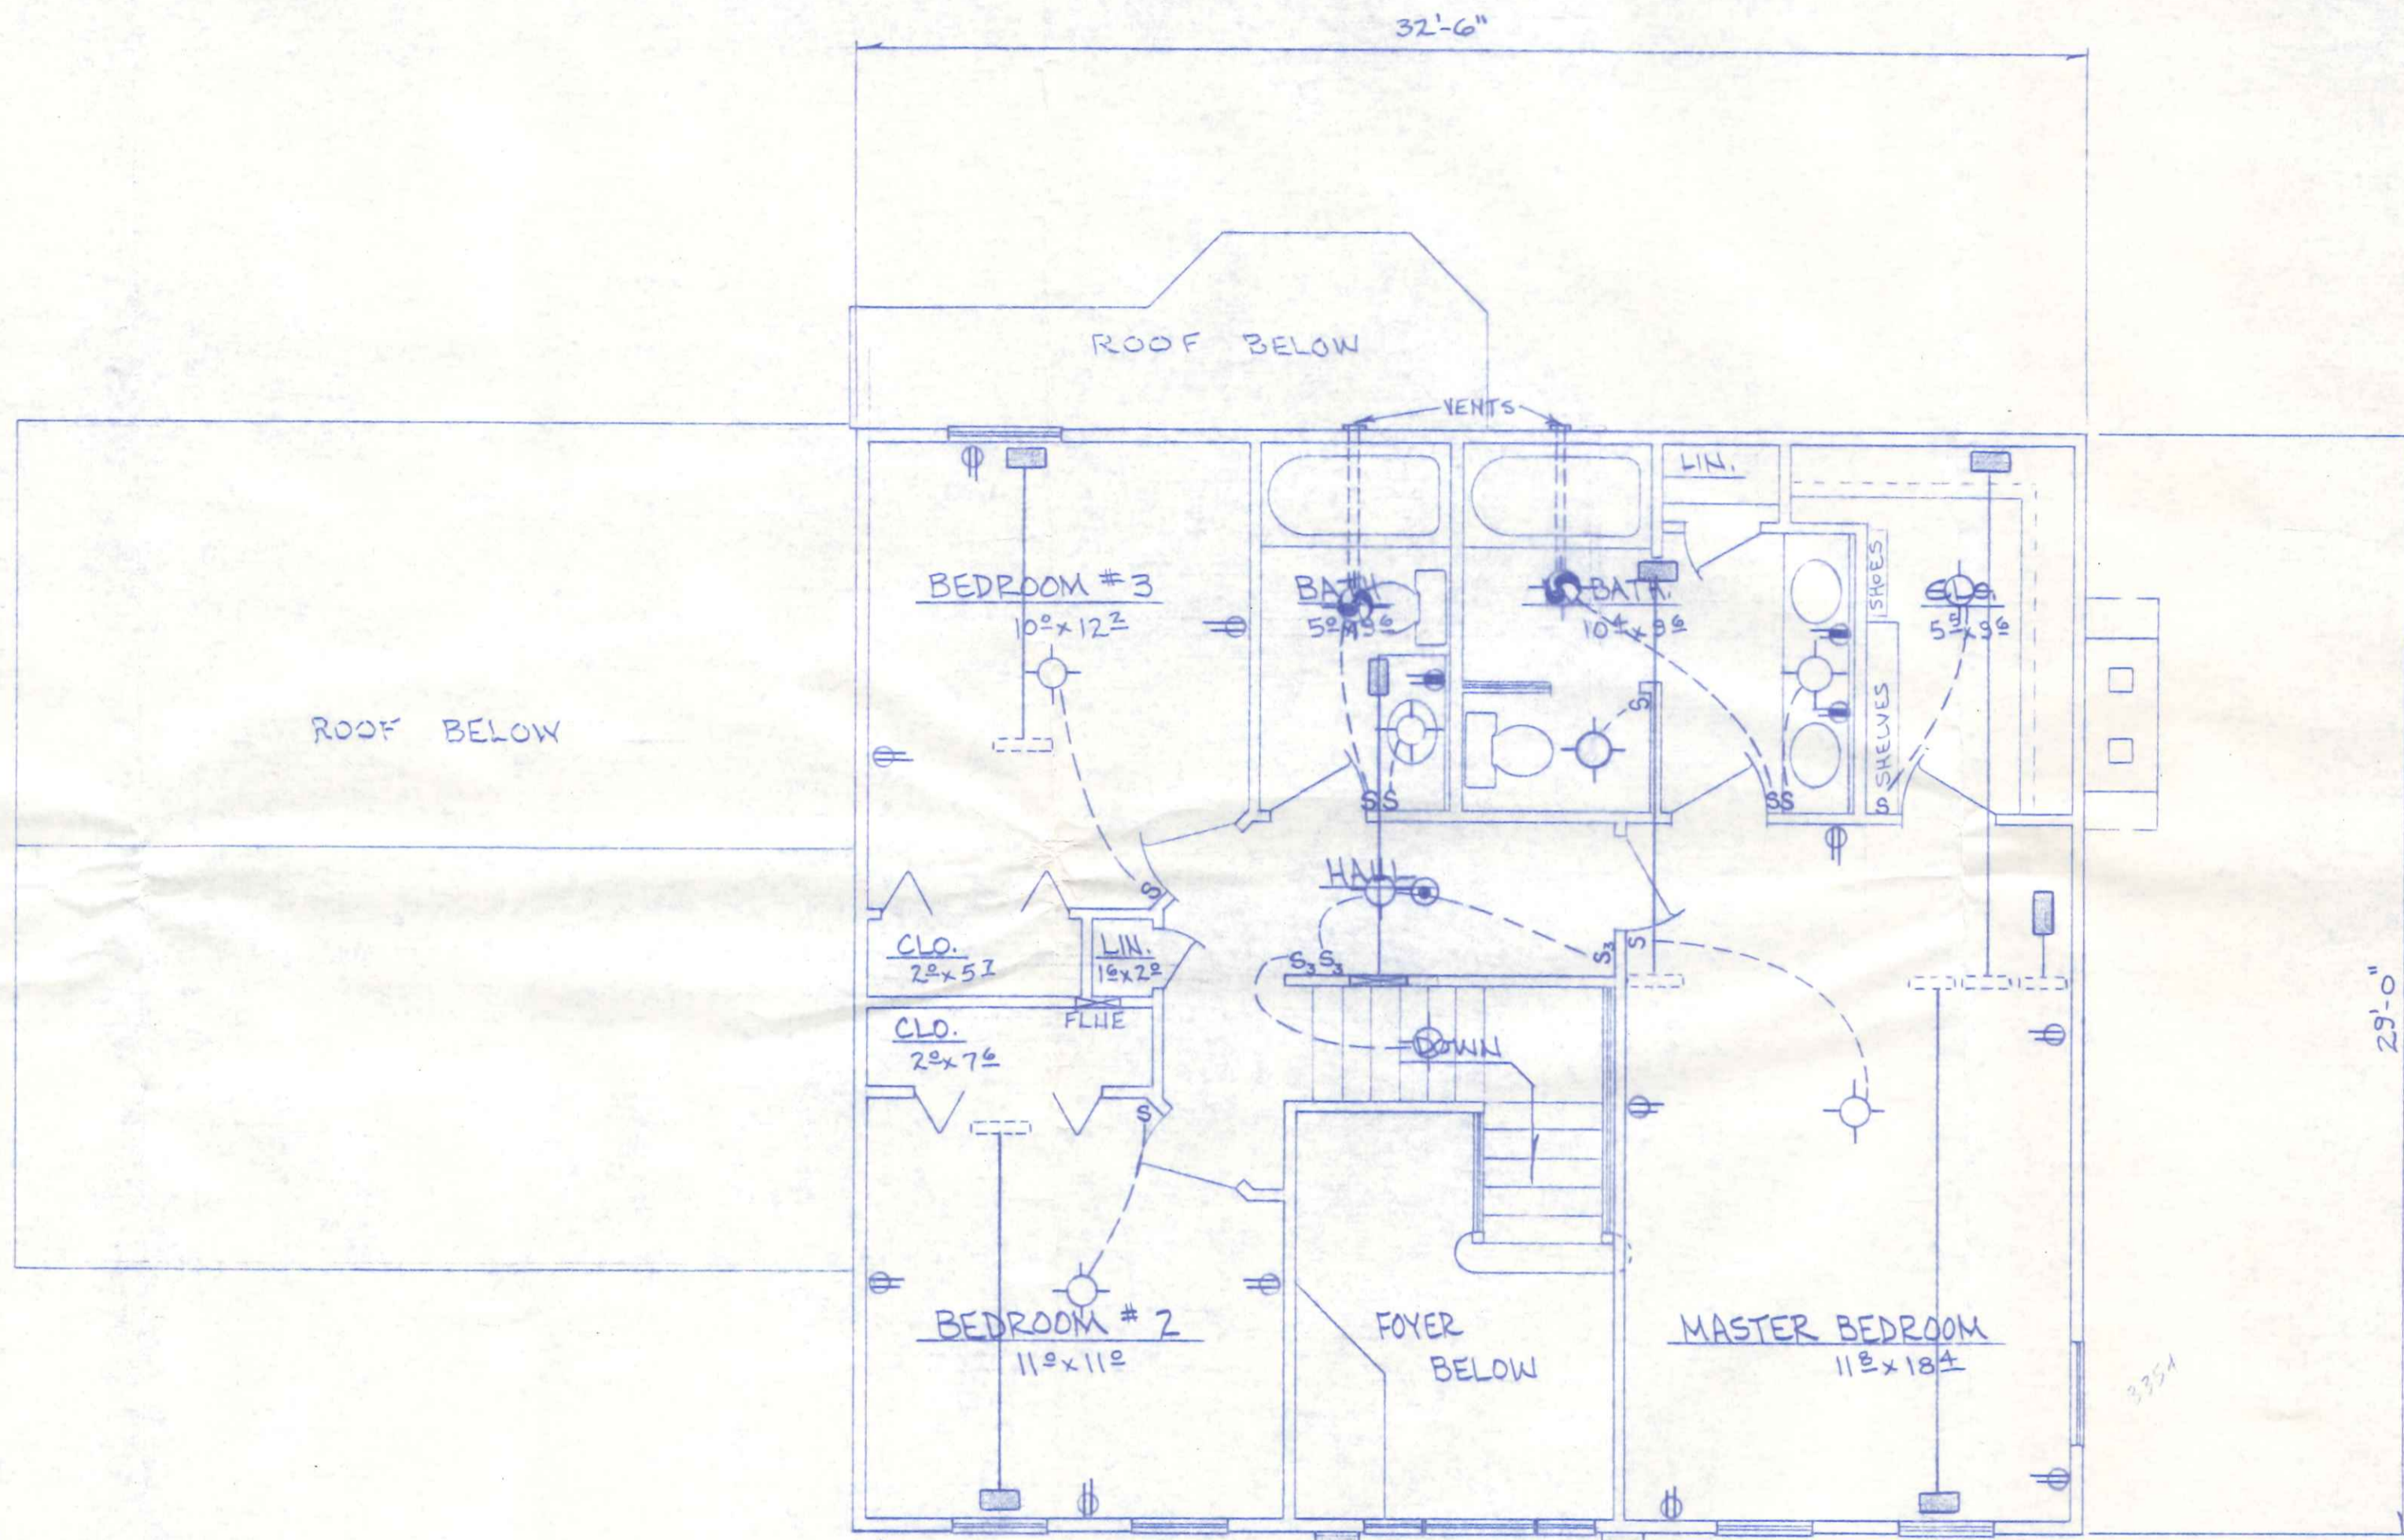


- LEGEND**
- ⊙ CEILING LIGHT
 - ⊙ WALL LIGHT
 - ⊙ CEILING CIRCULATING FAN
 - ⊙ CEILING LIGHT WITH CIRCULATING FAN
 - ⊙ CEILING LIGHT WITH EXHAUST FAN
 - ⊙ EXTERIOR FLOOD LIGHT
 - ⊙ PRIMARY POWERED SMOKE DETECTOR WITH BATTERY BACKUP
 - ⊙ SPECIAL OUTLET AS NOTED
 - ⊙ 120V - 20A DUPLEX RECEPTICLE
 - ⊙ 120V - 20A DUPLEX RECEPTICLE 2/1 SWITCHED
 - ⊙ 120V - 20A DUPLEX RECEPTICLE WITH G.F.C.I. PROTECTION
 - ⊙ 240V APPLIANCE OUTLET
 - ⊙ 120V - 20A LIGHT SWITCH
 - ⊙ 120V - 20A FAN SWITCH
 - ⊙ 120V - 20A 3 WAY LIGHT SWITCH

- NOTES**
- 1) See Foundation Plan for Basement Electrical
 - 2) Min. 20A. CIR., #12 Wire
 - 3) All Work and Material shall be as per National Electric Code


BECK CONSTRUCTION CO.		
CO. RD. M		NAPOLÉON, OHIO
SCALE: 1/4" = 1'-0"	APPROVED BY:	DRAWN BY R.D.S.
DATE: JUNE 91		REVISED
ELECTRICAL & HEATING 2ND FLOOR		
PLAN NO. 258		DRAWING NUMBER 5 OF 6

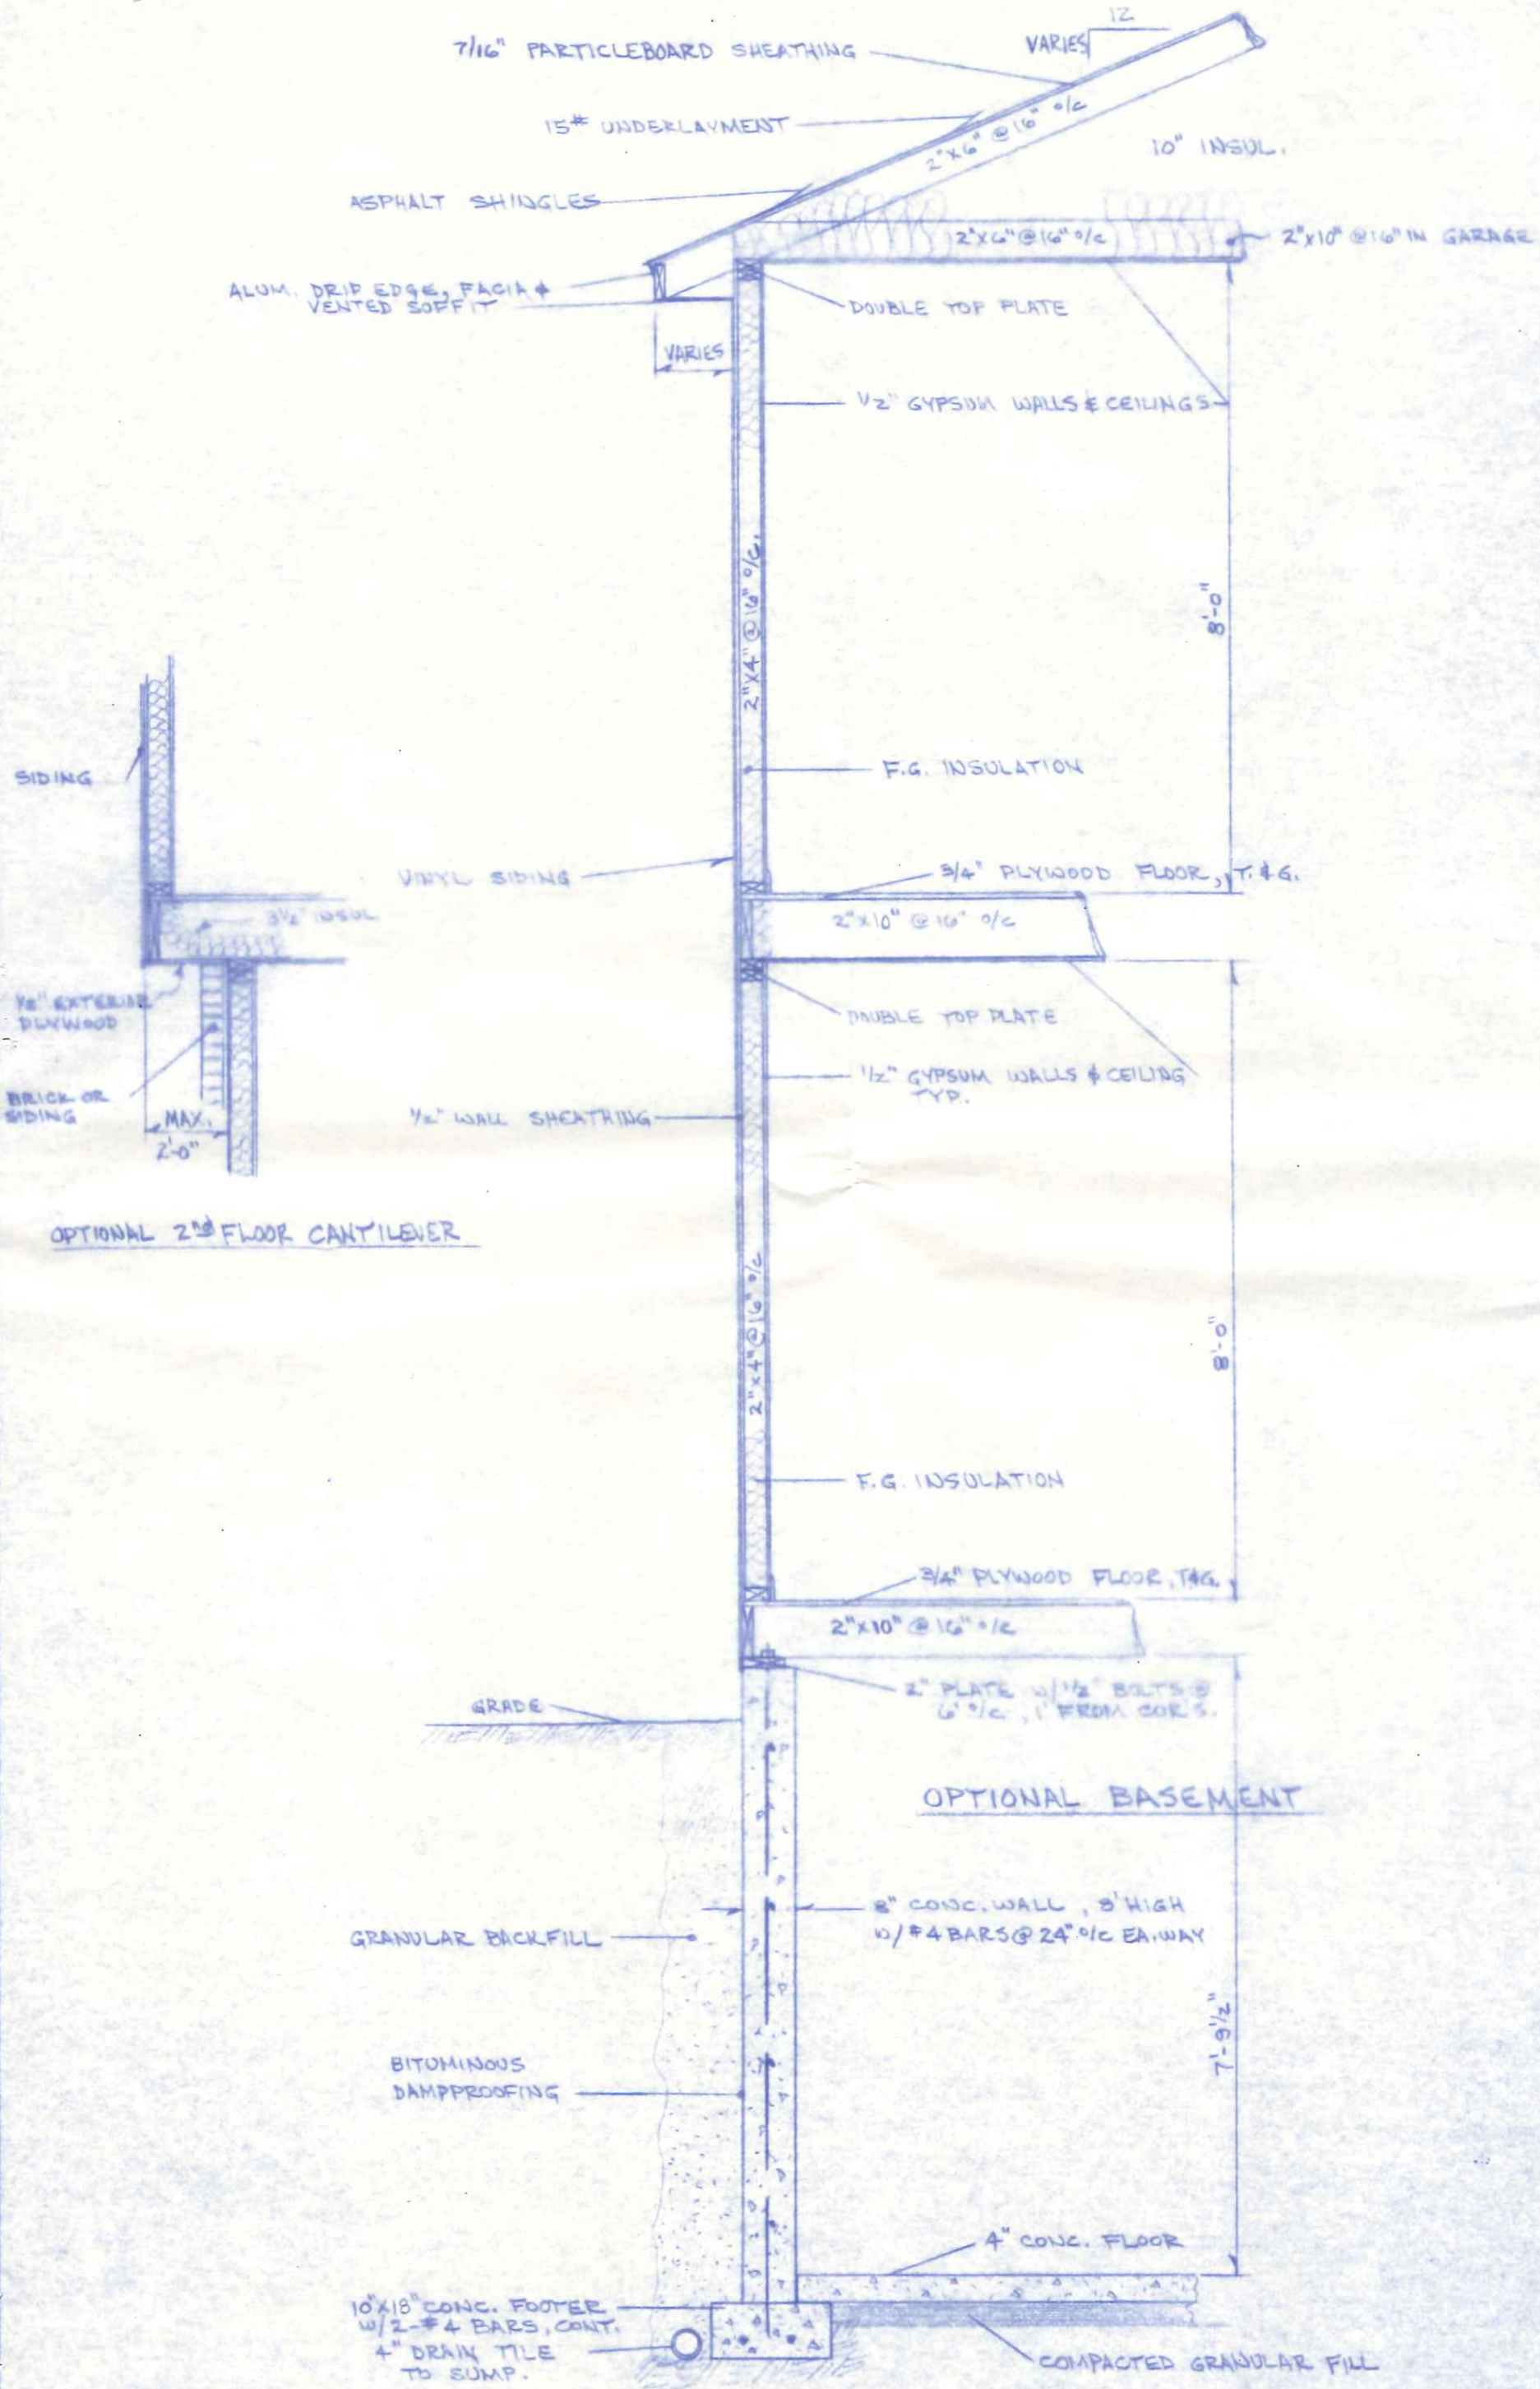

TYPICAL SECTION 2 STORY W/BASEMENT
 1/2" = 1'-0"
 BECK CONSTRUCTION CO.
 AUG. 1986
 R.D.S.

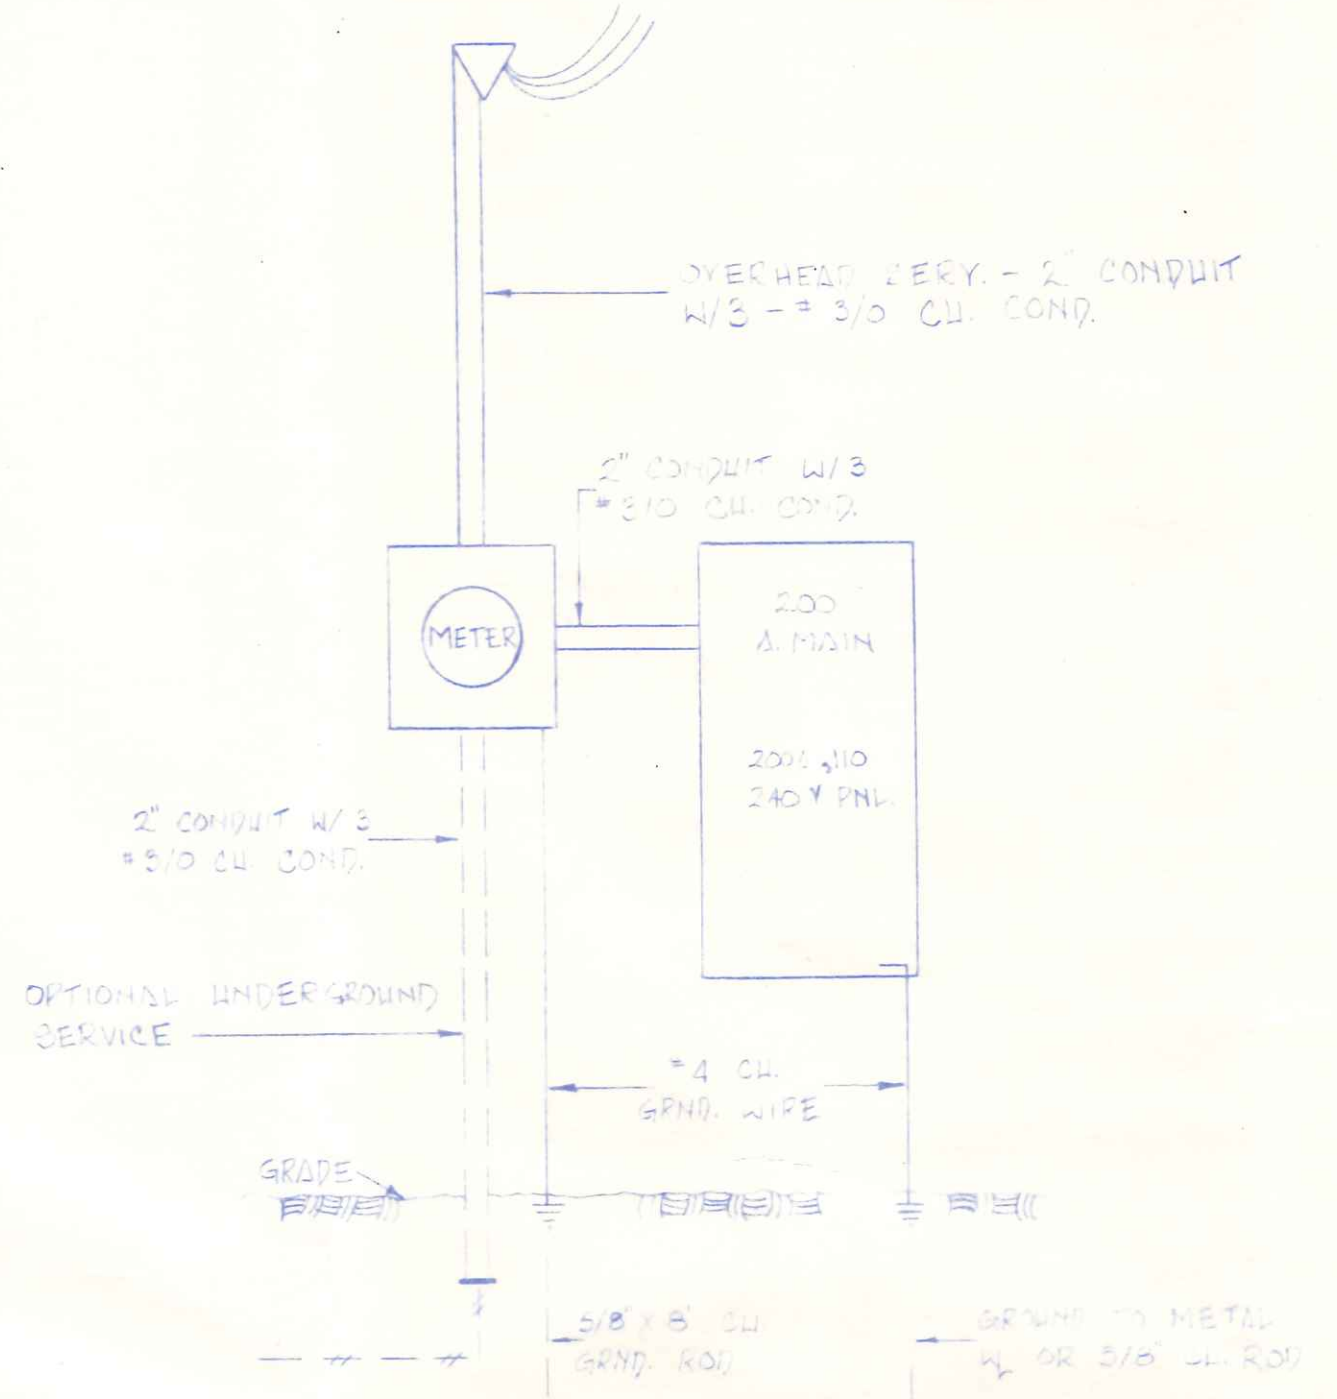

ELECTRICAL SERVICE DIAGRAM

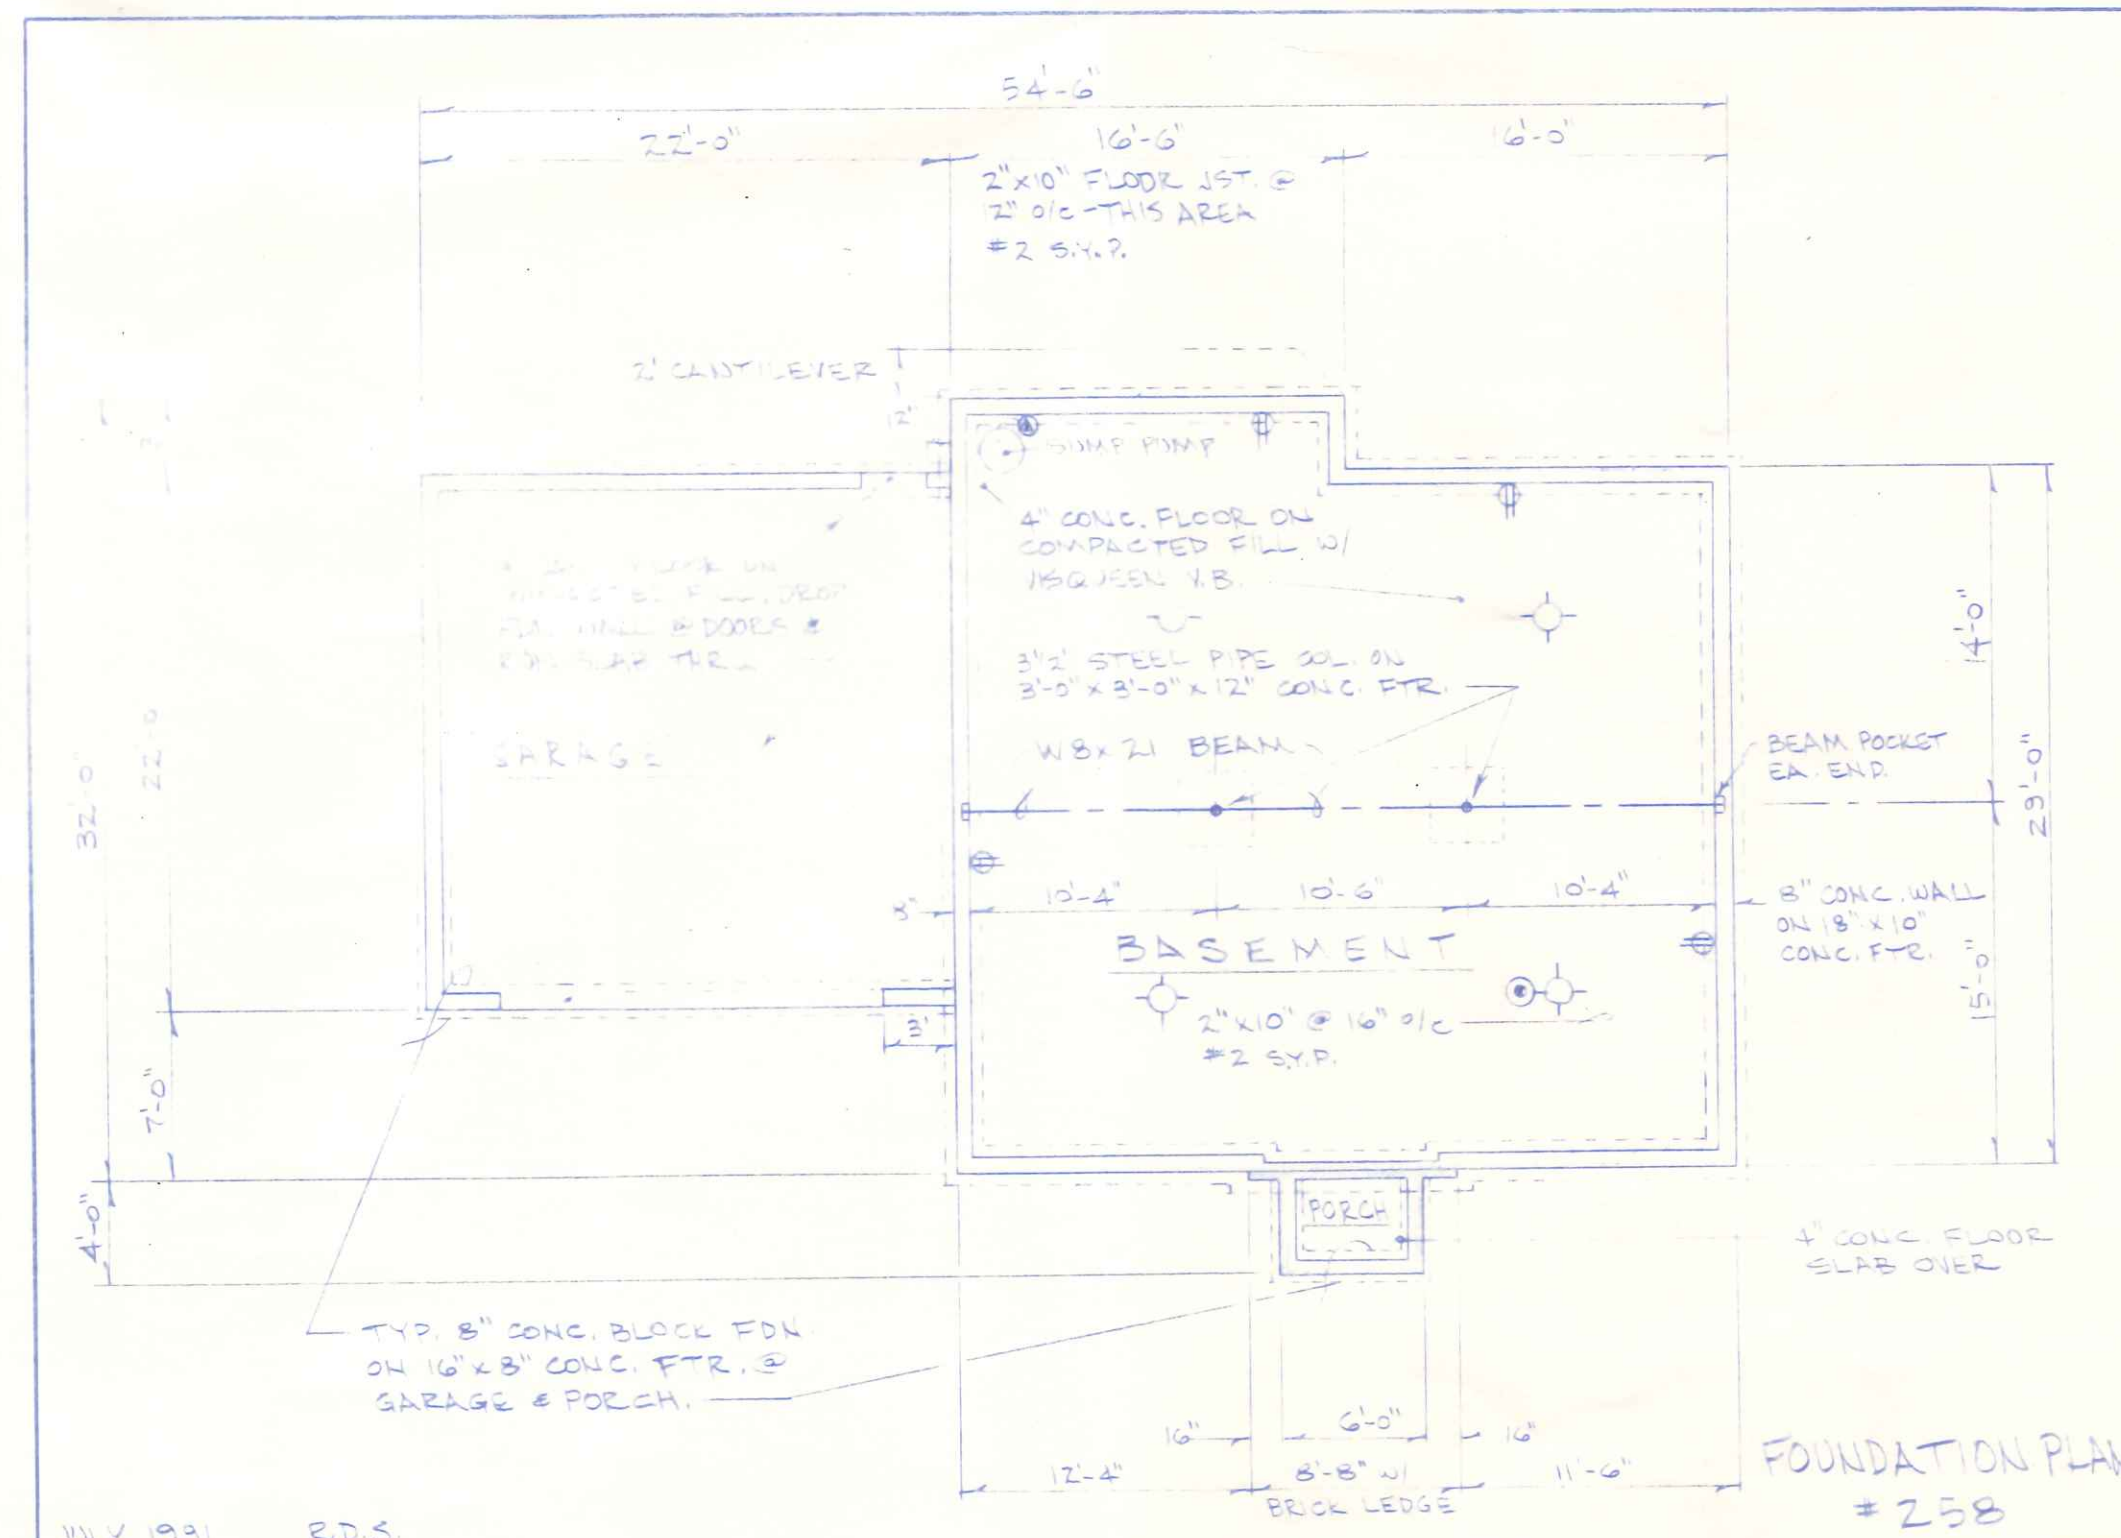

FOUNDATION PLAN # 258

JULY 1991 R.D.S.