



FRONT ELEVATION
1/4" = 1'-0"



LEFT SIDE ELEVATION
1/8" = 1'-0"

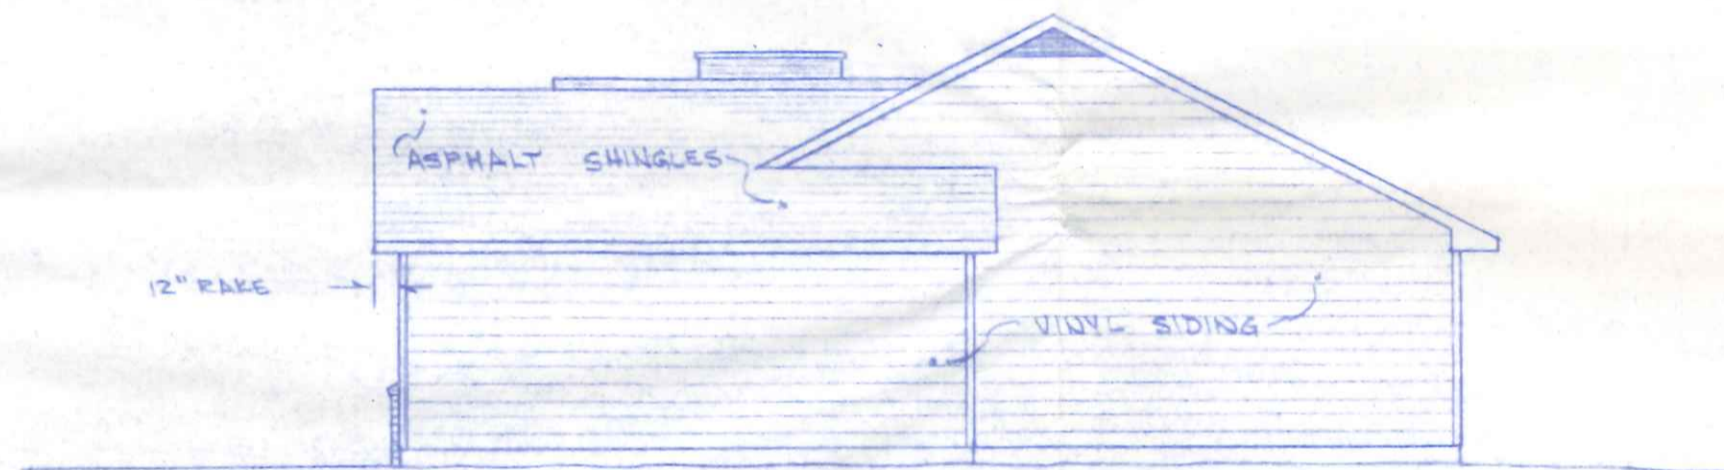


RIGHT SIDE ELEVATION
1/8" = 1'-0"

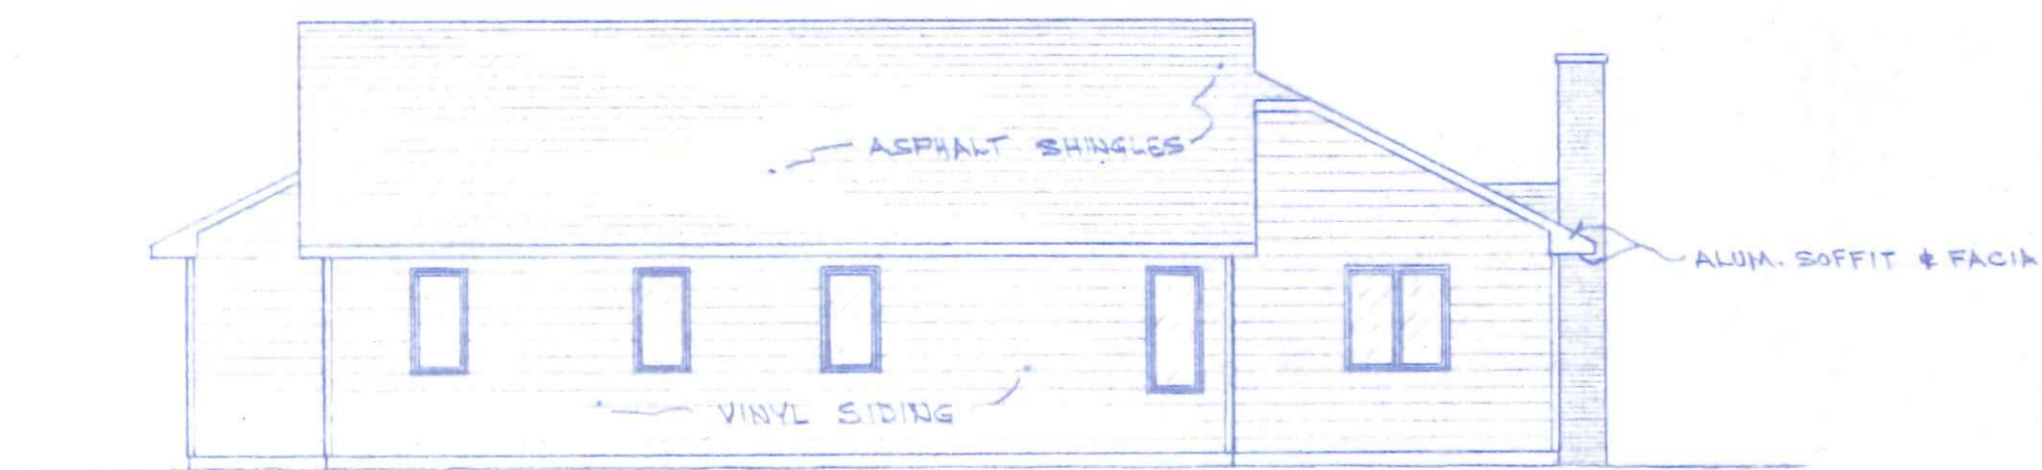

REAR ELEVATION
1/8" = 1'-0"

Max Bukomastic
930 Melody

BECK CONSTRUCTION CO.		
JULY 1986	PLAN NO. 216	DWN. R.D.S.
SCALE: AS NOTED		SHEET 1/3

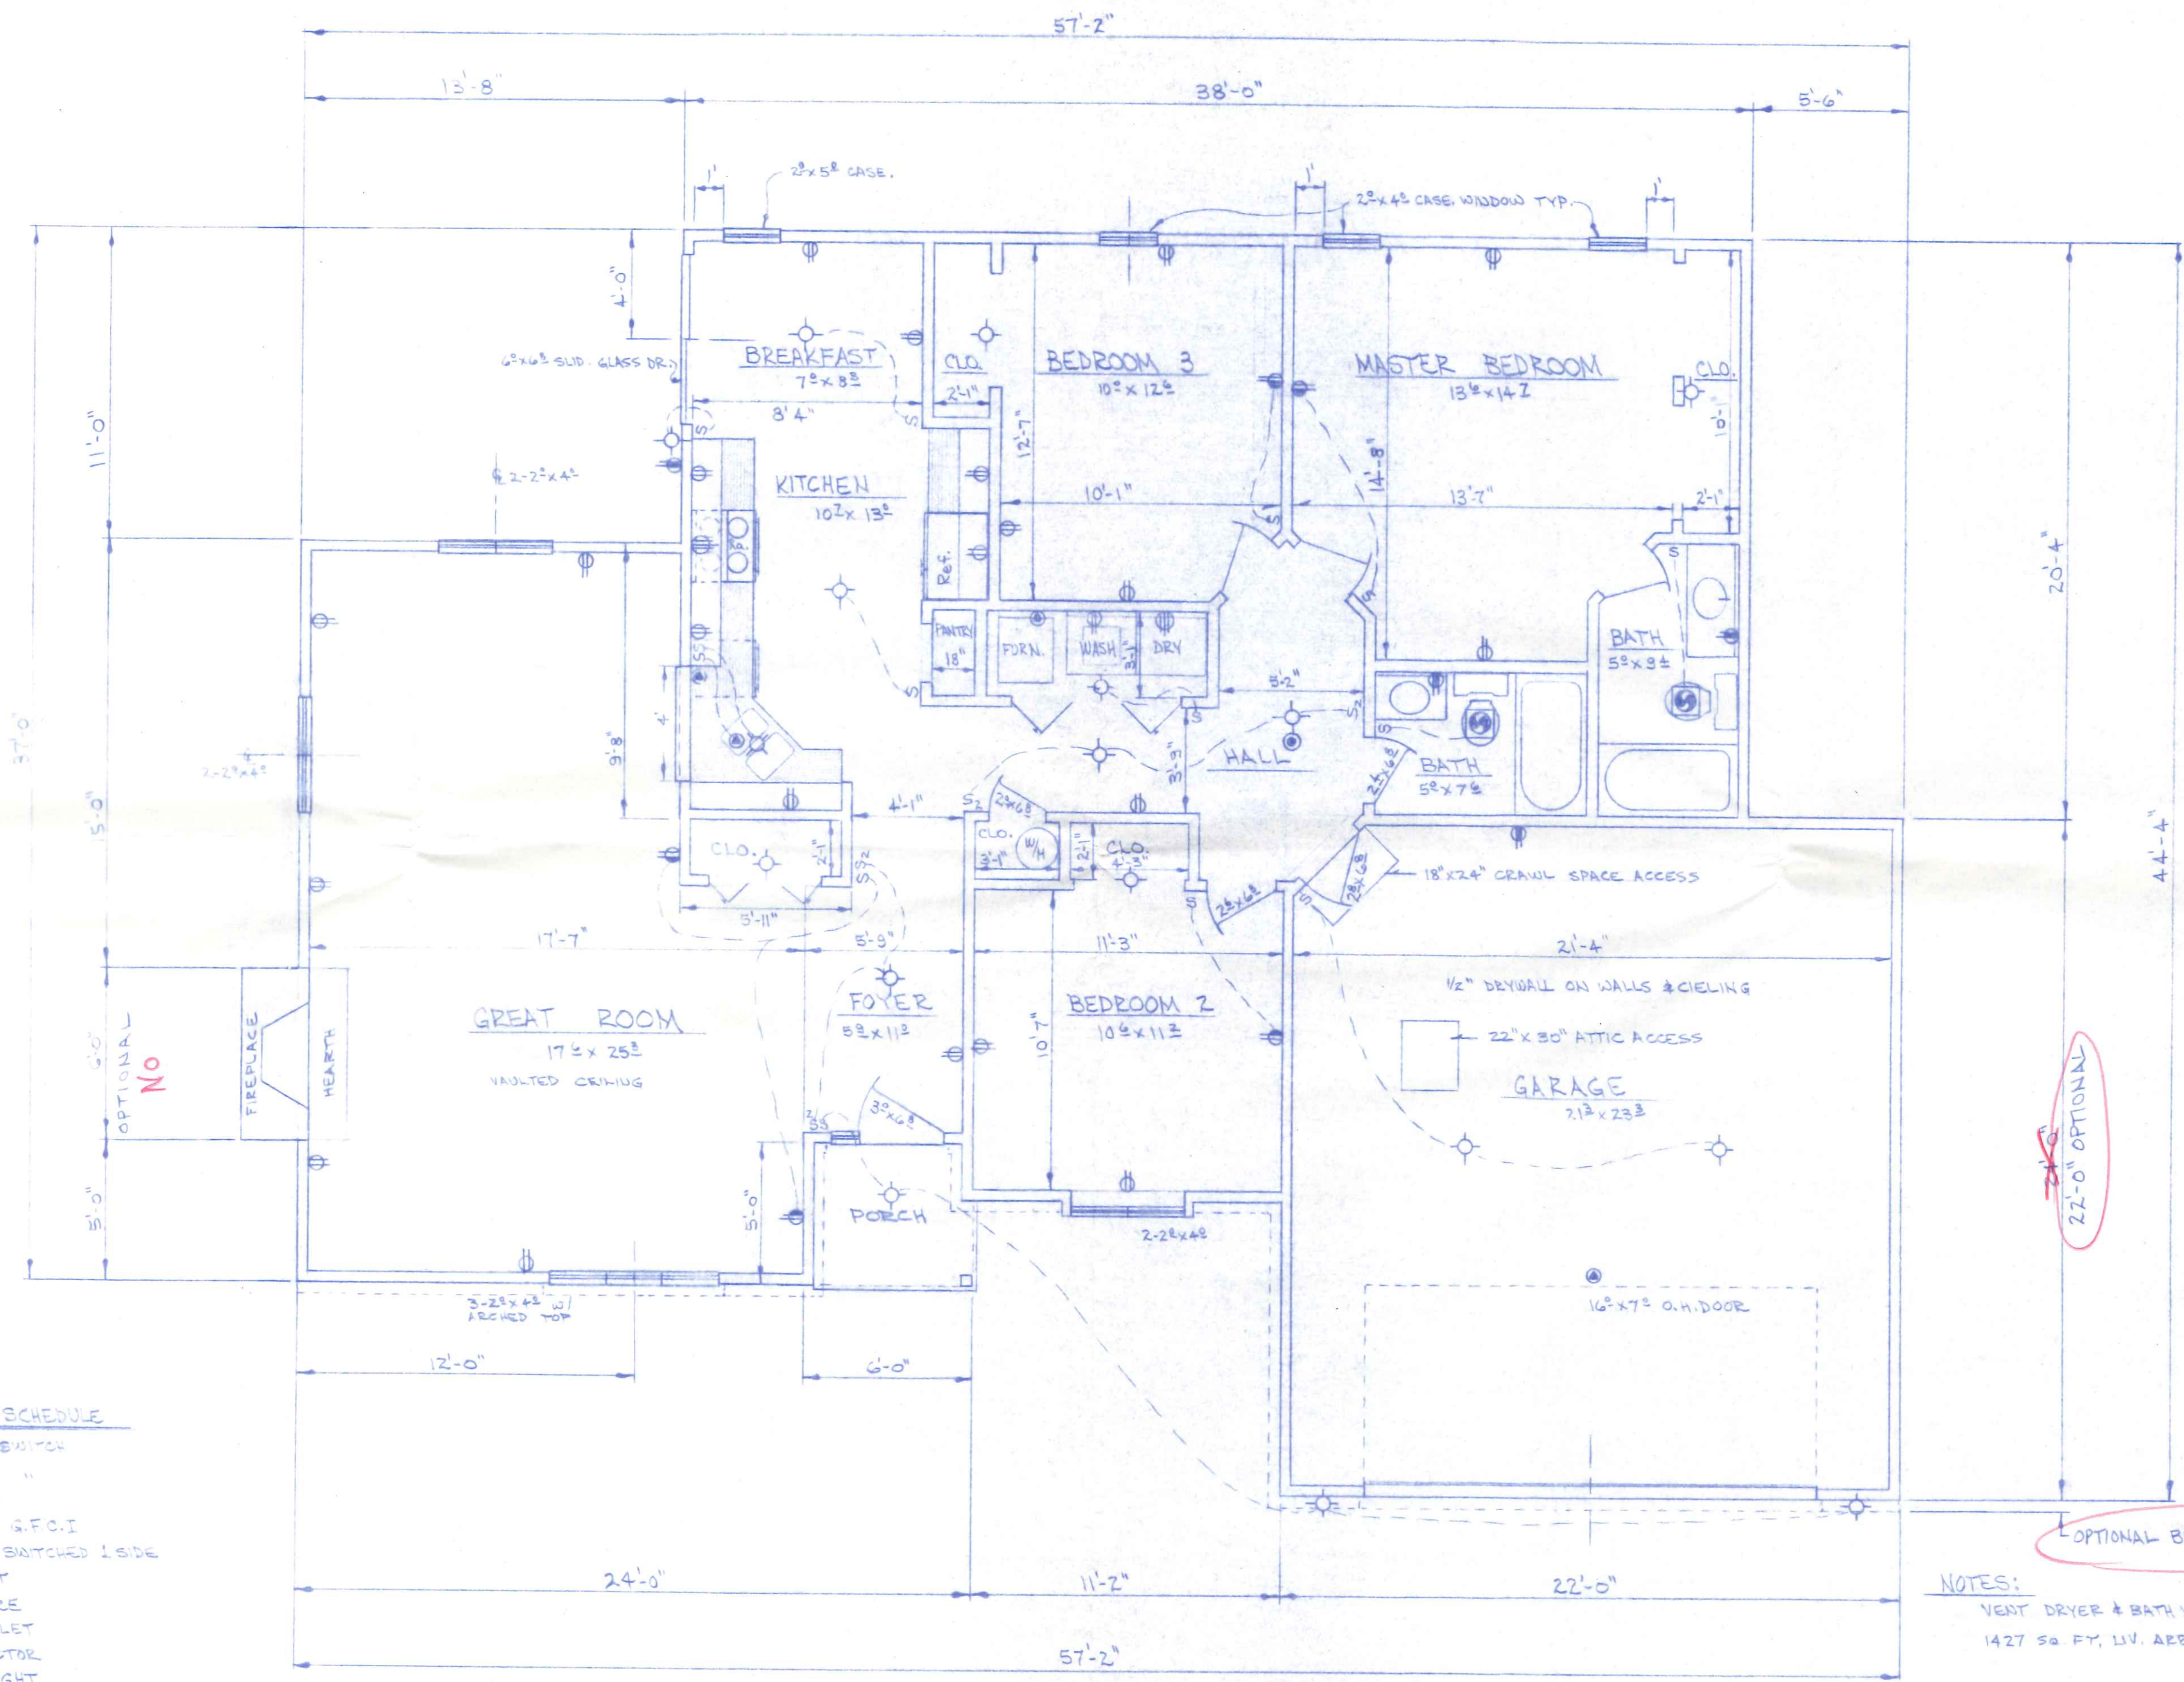

ELECTRICAL SCHEDULE

- S - SINGLE POLE SWITCH
- S₂ - DOUBLE " "
- ⊕ - 110 V. OUTLET
- ⊕ - " " G.F.C.I.
- ⊕ - " " SWITCHED 1 SIDE
- ⊕ - 220 V. OUTLET
- ⊙ - LIGHT FIXTURE
- ⊙ - SPECIAL OUTLET
- ⊙ - SMOKE DETECTOR
- ⊙ - VENT FAN & LIGHT

FLOOR PLAN
1/4" = 1'-0"

NOTES:
 VENT DRYER & BATH VENTS TO OUTSIDE
 1427 SQ. FT. LIV. AREA

BECKS CONSTRUCTION CO.
 JULY 1986
 SCALE: AS NOTED
 PLAN NO. 216
 DWG. R.D.S.
 SHEET 3/3

OPTIONAL
No

~~21'-0"~~ 22'-0" OPTIONAL

OPTIONAL BRICK VENEER @ FRONT

