



975 MELODY

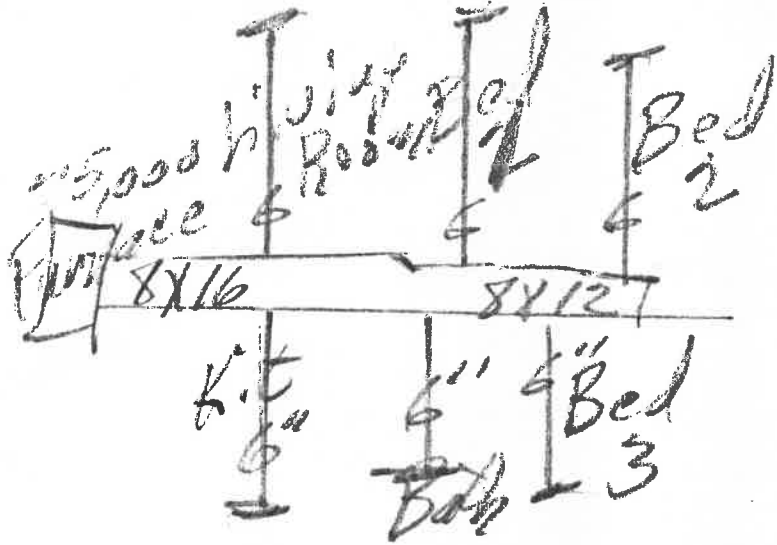

SITE PLAN FOR  
BECKS CONSTRUCTION CO.  
 LOT NO. 2, PHASE I BRICKYARD SUB-  
 DIVISION, CITY OF NAPOLEON, HENRY CO. OHIO.

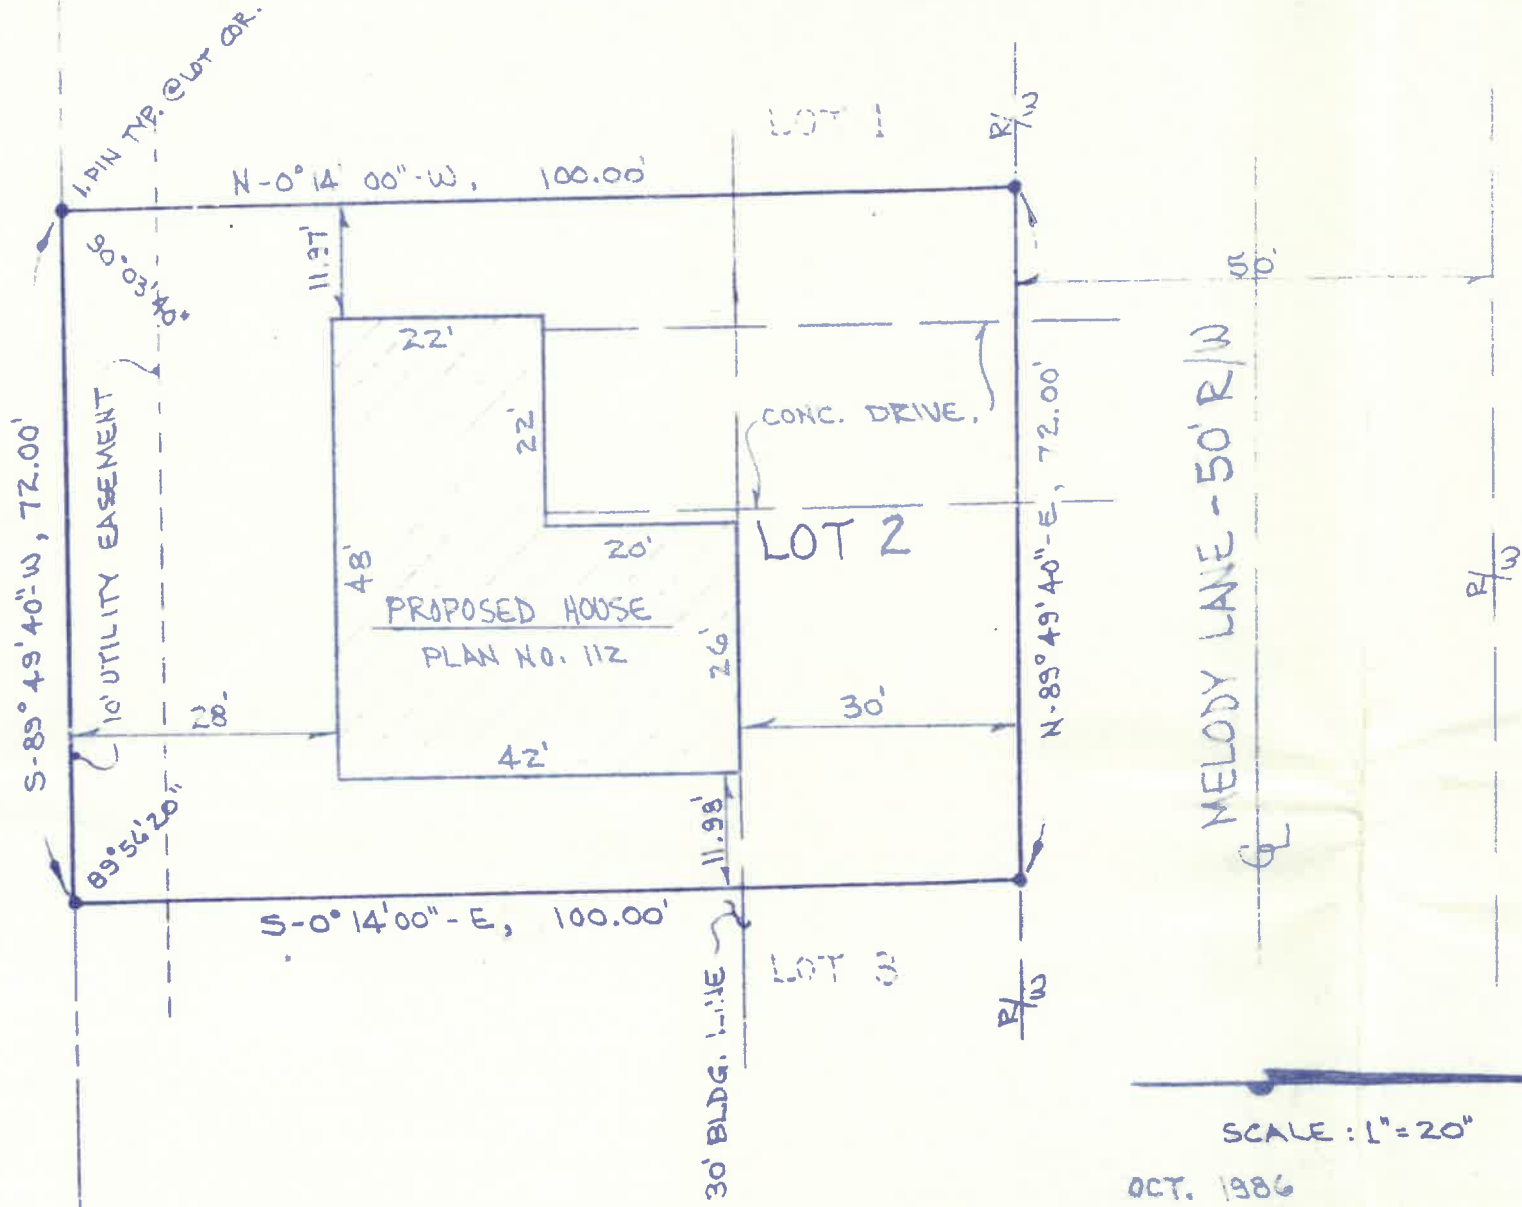


MELODY LANE - 50' R/W

SCALE: 1" = 20'


OCT. 1986

R.D.S.

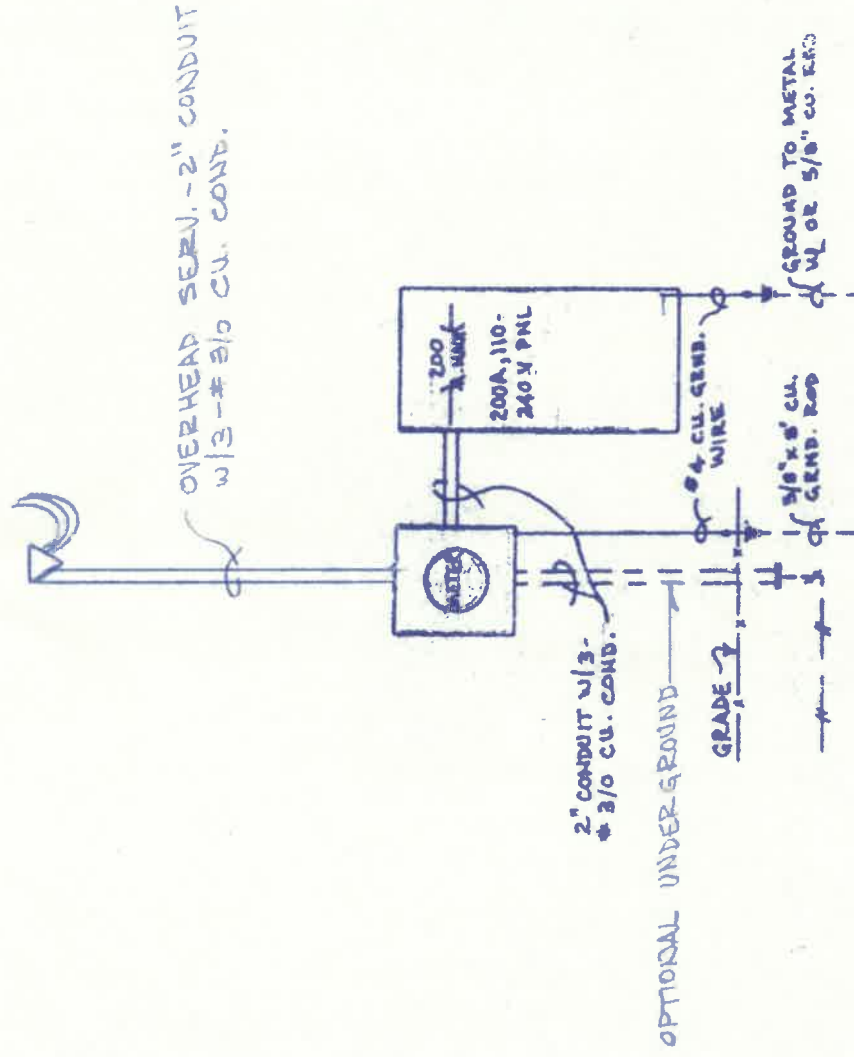


ELECTRICAL RISER DIAGRAM

NO SCALE

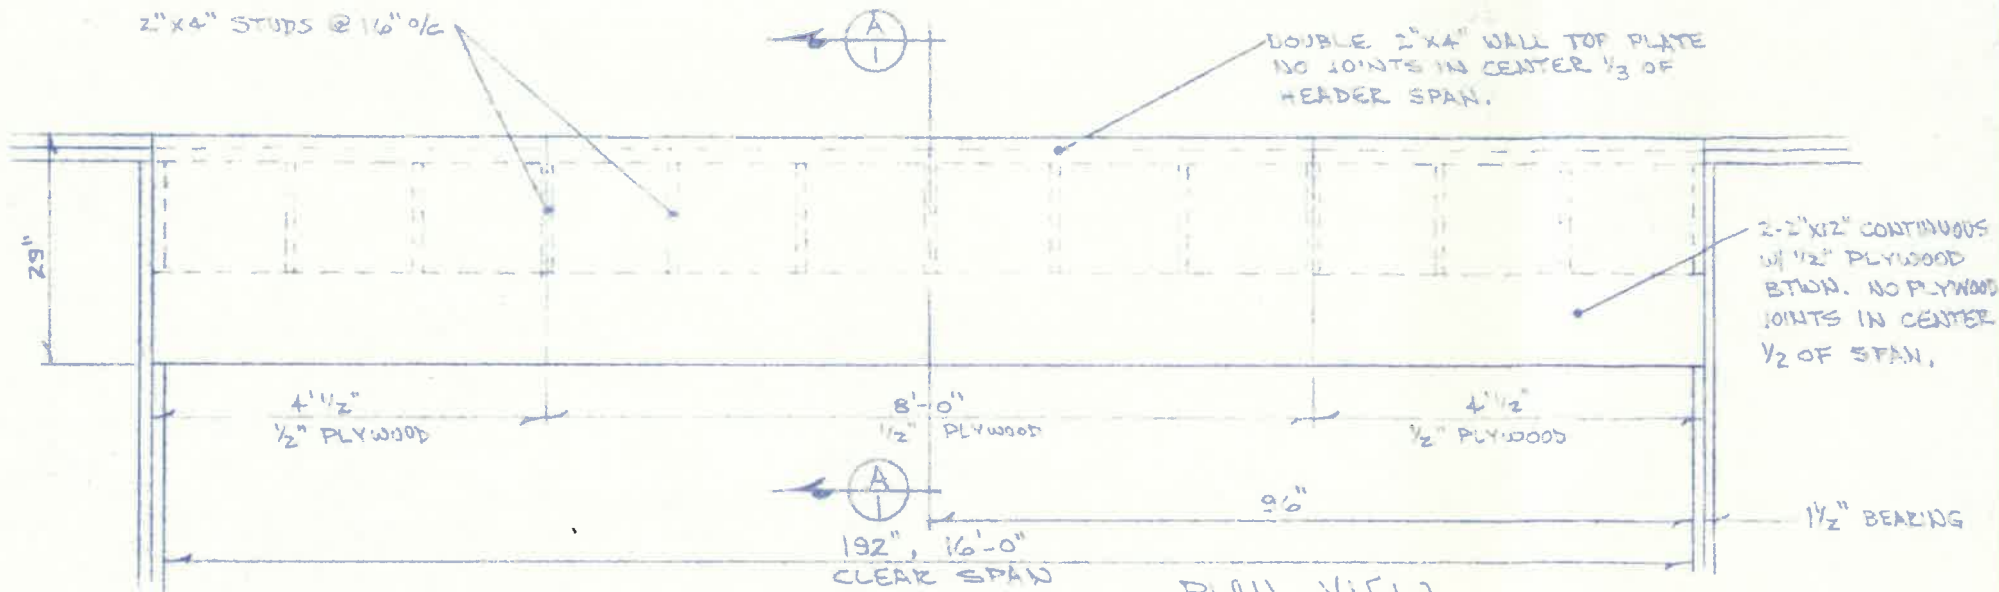

ASSUMED LOADS: 30# / FT<sup>2</sup> ROOF, LIVE & DEAD  
 30# / " CEILING.  
 60# / " TOTAL w/ 11'-0"  
 TRIBUTARY LOAD

LUMBER DESIGN VALUES:  
 FIBER STRESS, 1400 PSI MIN.  
 MODULUS 'E', 1,400,000 PSI MIN.

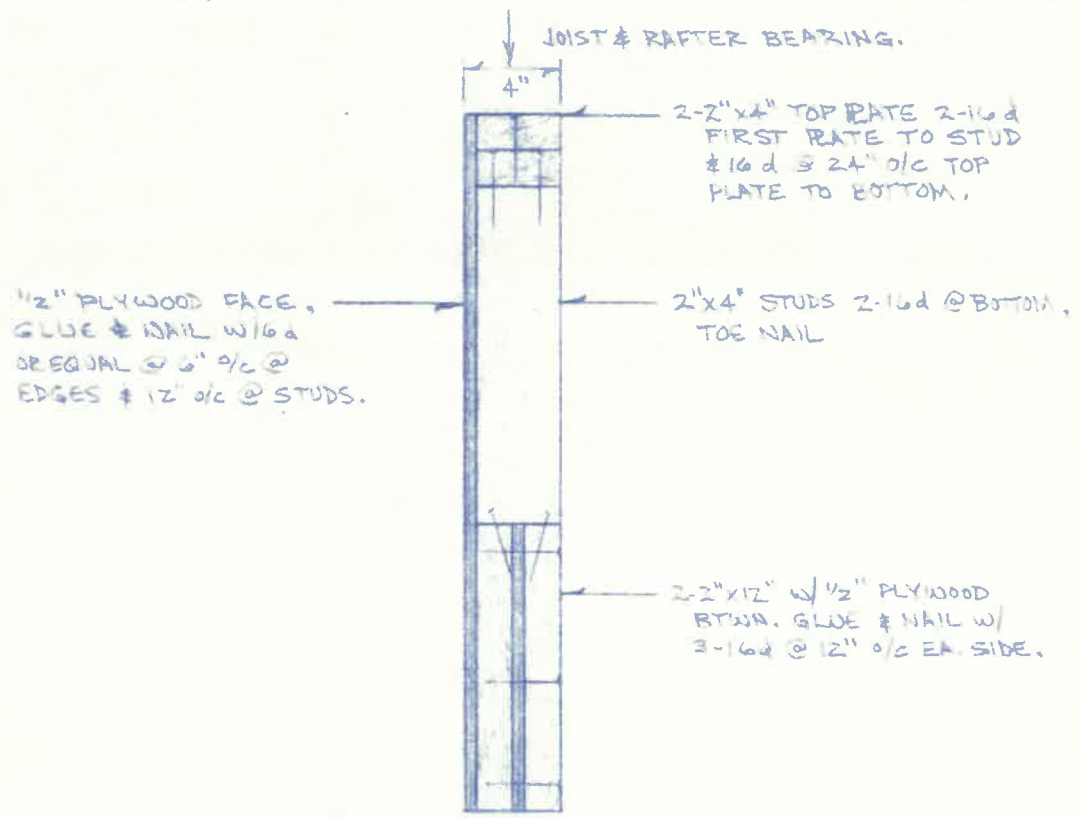

SECTION A-I  
 1 1/2" = 1'-0"

*Richard F. Bertz*  
 RICHARD F. BERTZ, P.E.

THIS DRAWING IS THE PROPERTY OF  
 NAPOLEON EISE & SON, INC. AND SHALL NOT  
 BE USED WITHOUT THEIR PERMISSION.