



FRONT ELEVATION  
1/4" = 1'-0"



LEFT SIDE ELEVATION  
1/8" = 1'-0"

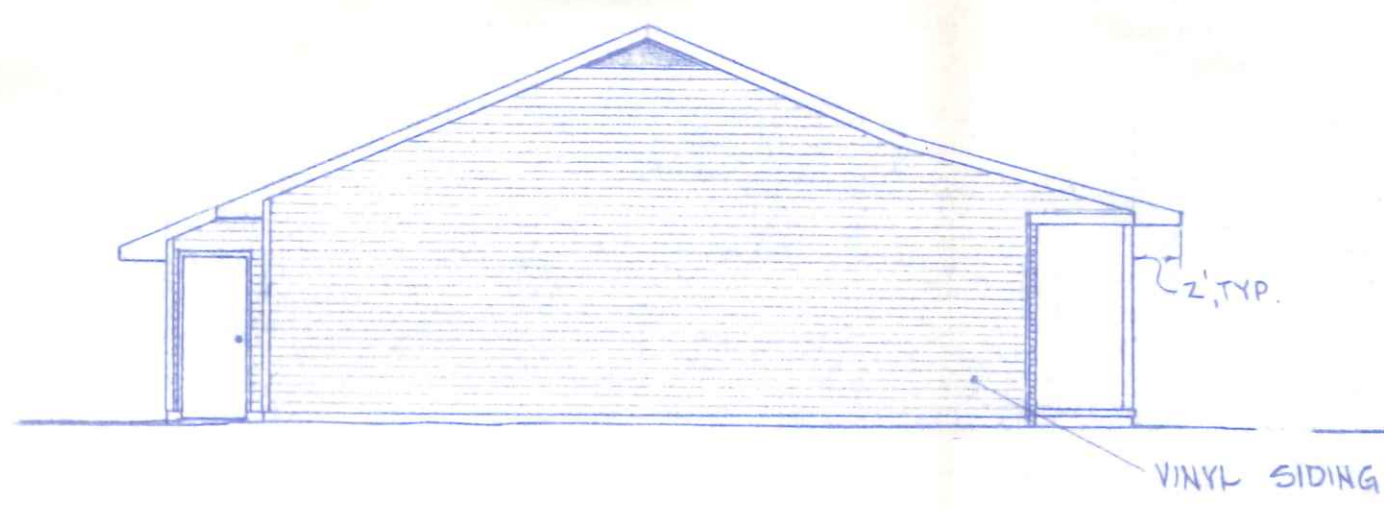

REAR ELEVATION  
1/8" = 1'-0"

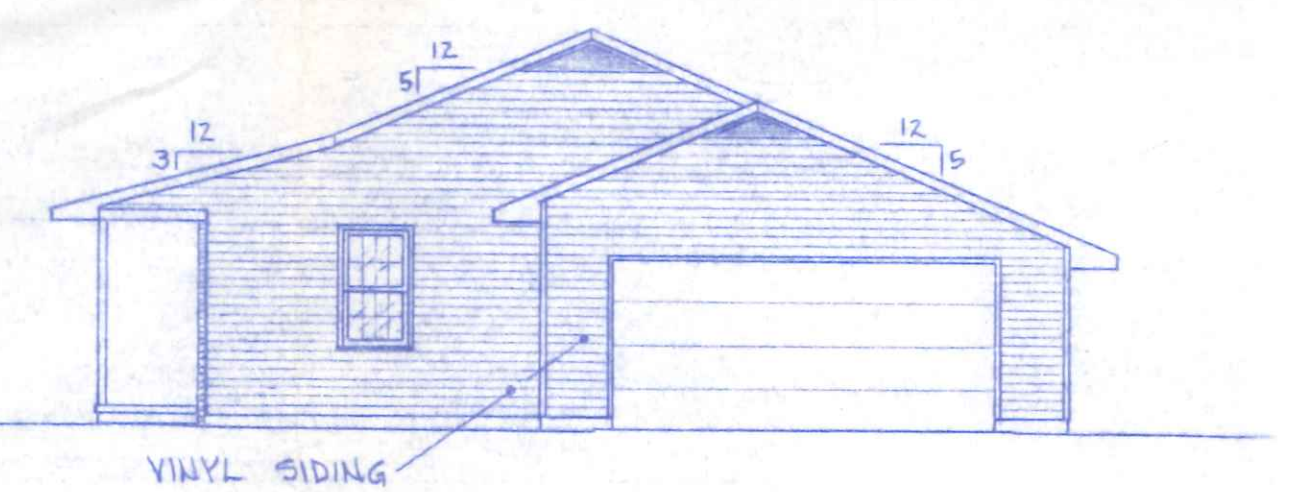


RIGHT SIDE ELEVATION  
1/8" = 1'-0"

Spec.  
980 melody

BECK CONSTRUCTION CO.		
CO. RD. M	APPROVED BY:	NAPOLEON, OHIO
SCALE: NOTED		DRAWN BY R.D.S.
DATE: APR. 92		REVISED
EXTERIOR ELEVATIONS		
PLAN NO. 260	DRAWING NUMBER 1 OF 4	




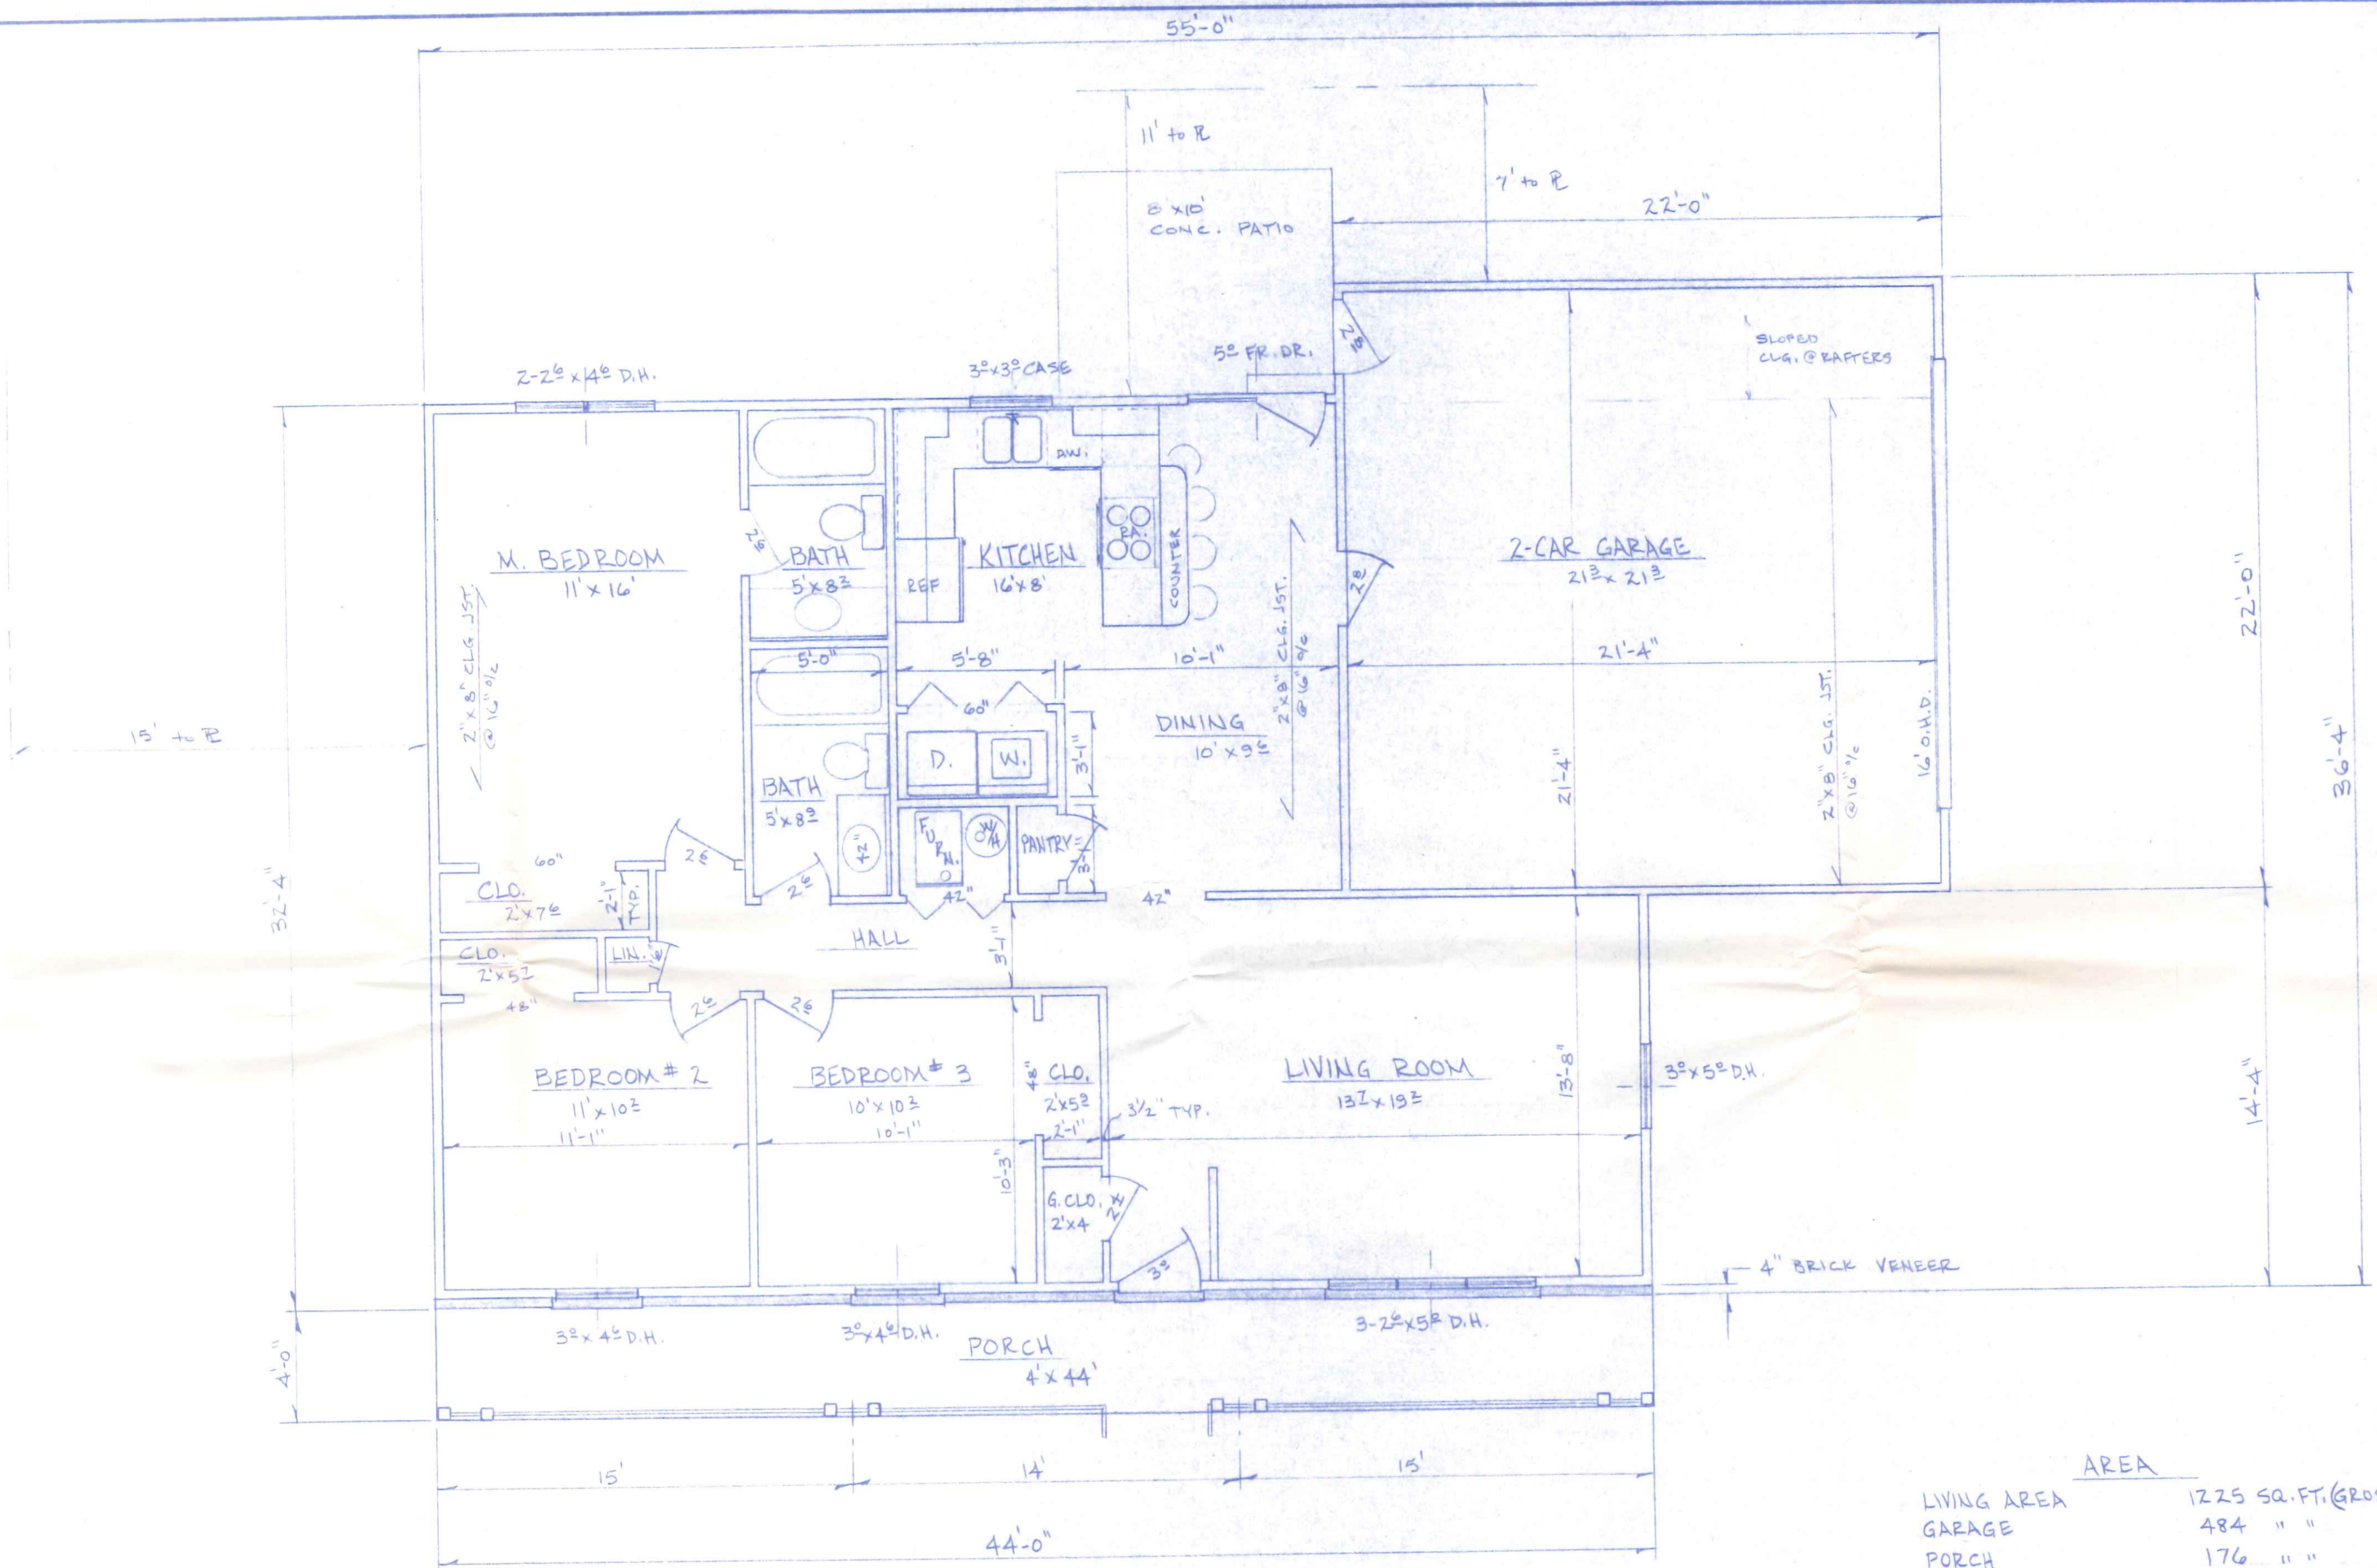

	AREA
LIVING AREA	1725 SQ. FT. (GROSS)
GARAGE	484 " "
PORCH	176 " "

BECK CONSTRUCTION CO.		NAPOLEON, OH.
CO. R.D. M	APPROVED BY:	DRAWN BY RDS
SCALE: 1/4" = 1'-0"	DATE: APR. 92	REVISED
FLOOR PLAN		DRAWING NUMBER
PLAN NO. 260		2 OF 4



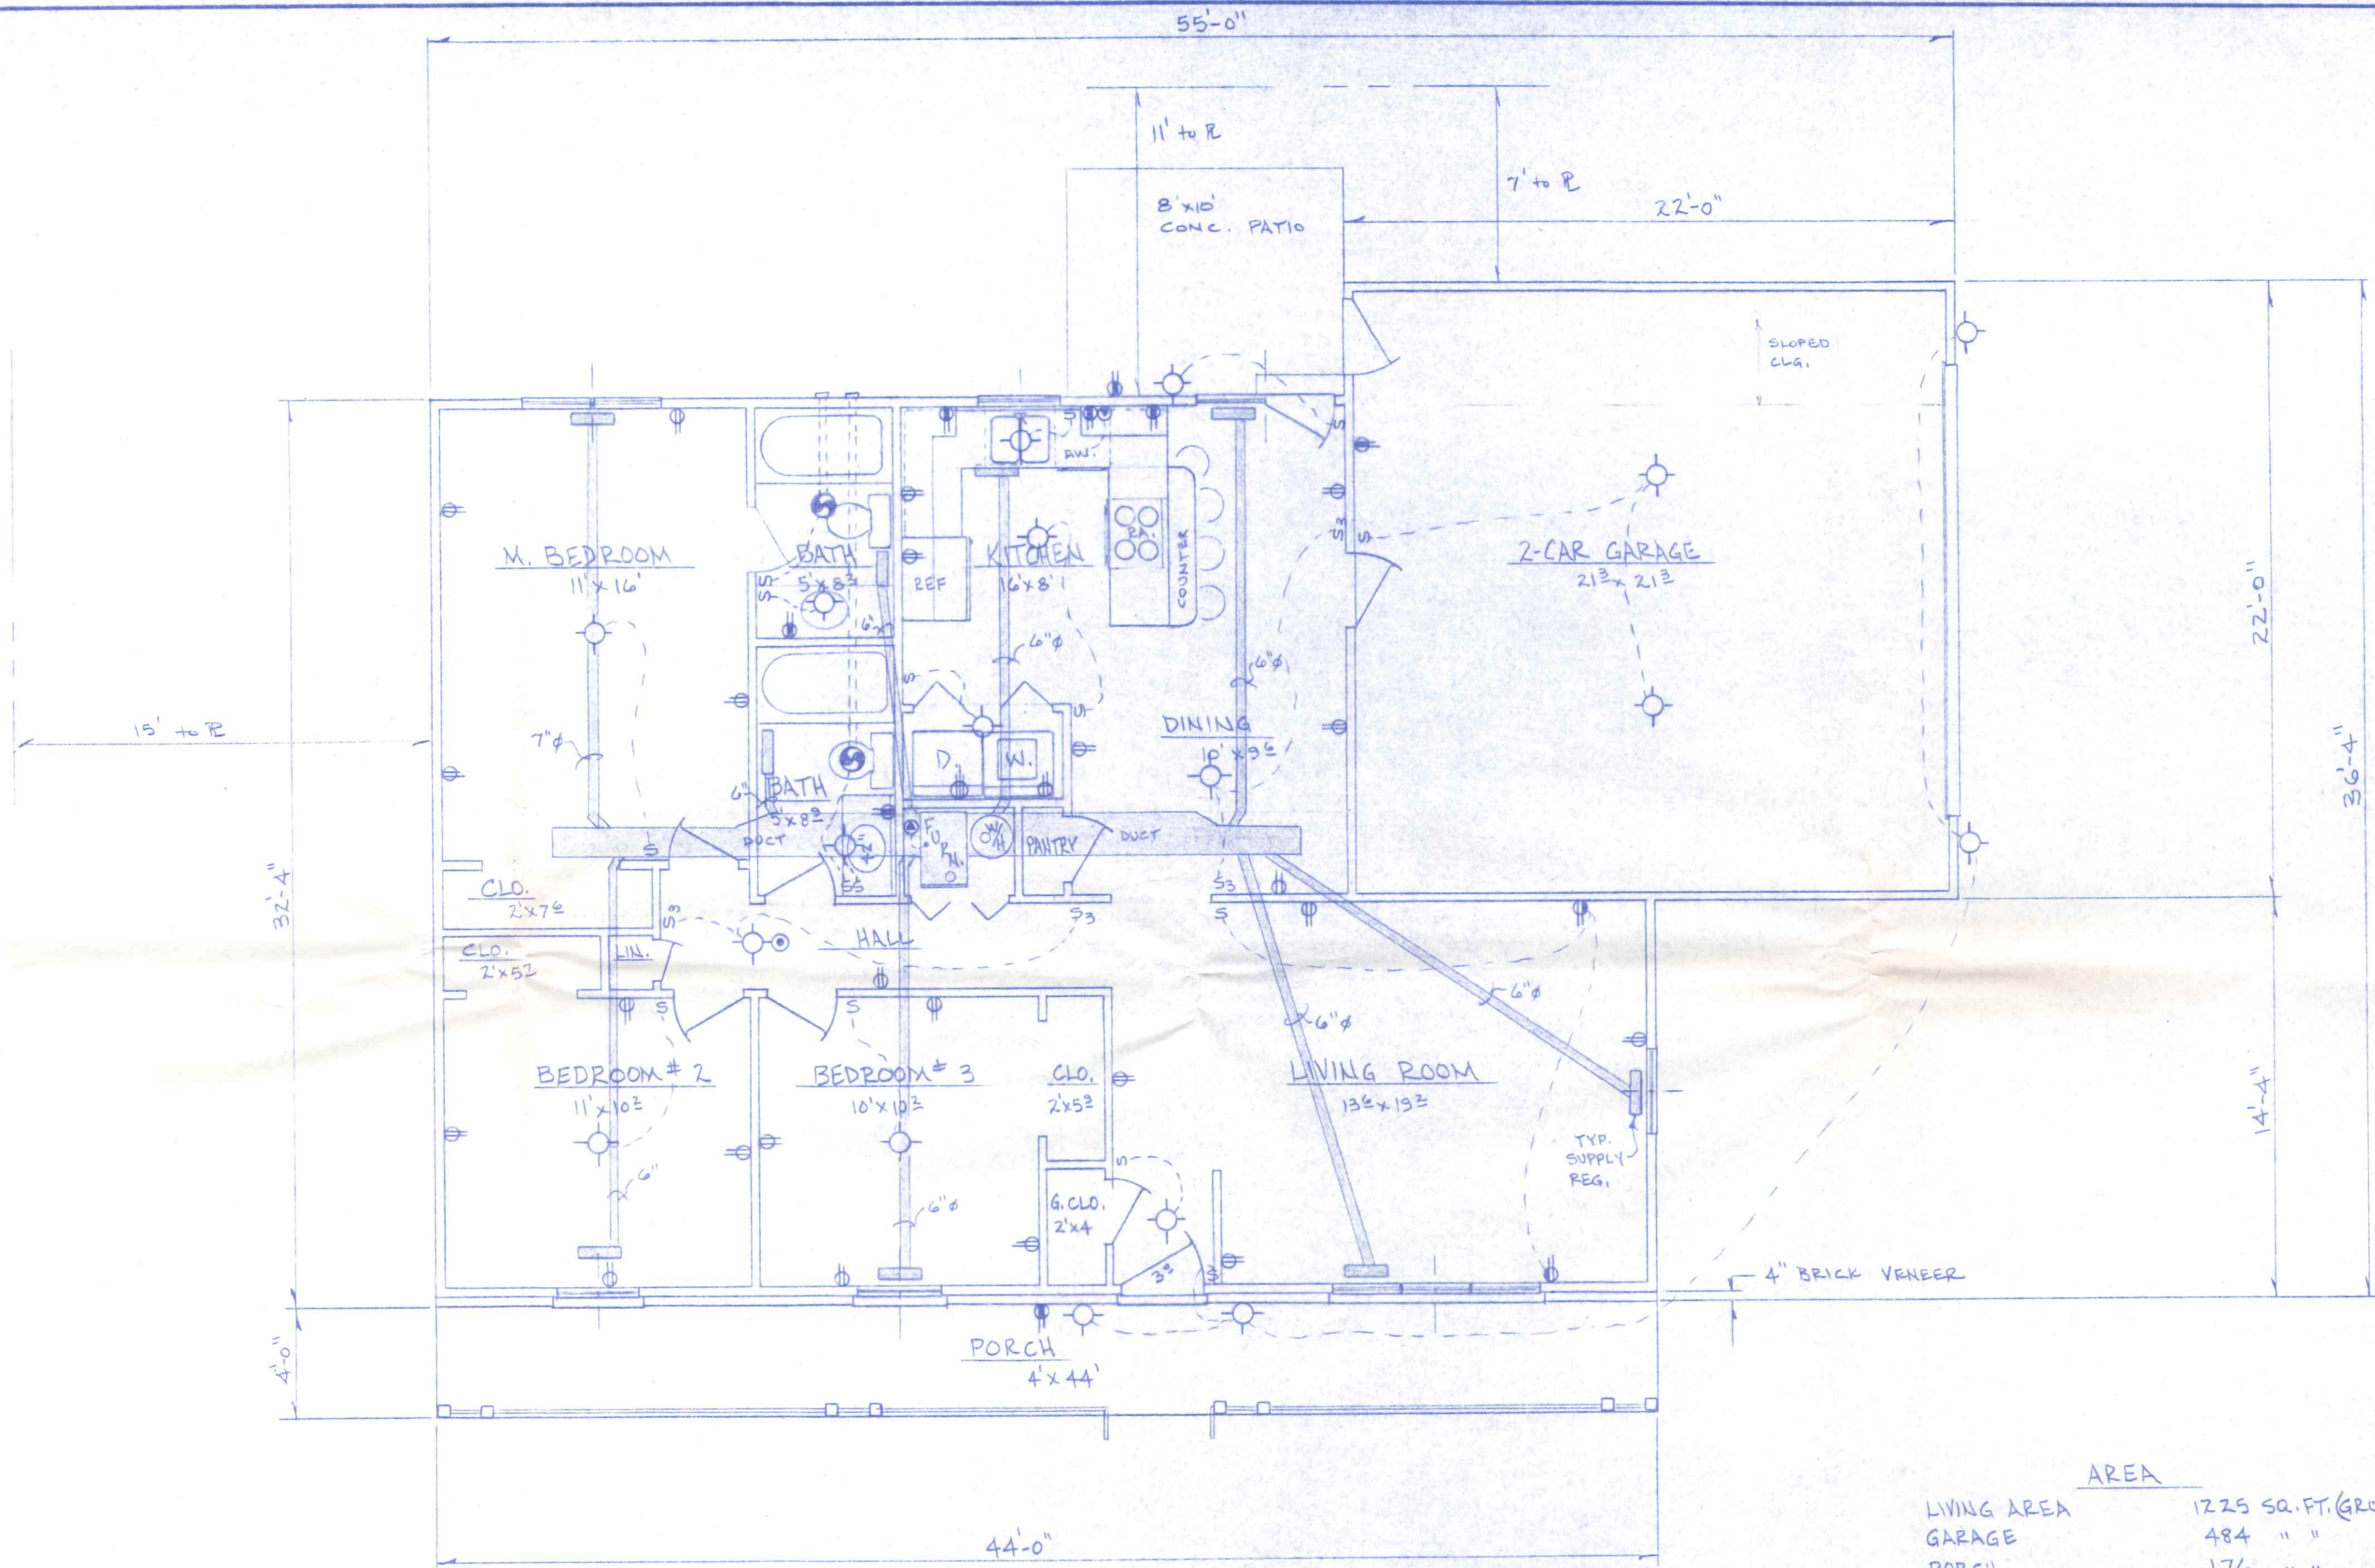


	AREA
LIVING AREA	1225 SQ. FT. (GROSS)
GARAGE	484 " "
PORCH	176 " "

ELECTRIC LEGEND

- S - SWITCH
- S<sub>3</sub> - " (THREE WAY)
- ⊕ - 120V. DUPLEX
- ⊕ - " " (G.F.C.I.)
- ⊕ - " " (1/2 SWITCHED)
- ⊕ - SPECIAL OUTLET
- ⊕ - PRIMARY POWERED SMOKE DETECTOR
- ⊕ - VENT FAN, EXHAUST TO 1/5 AIR
- ⊕ - LIGHT FIXTURE




BECK CONSTRUCTION CO.		NAPOLEON, OH.
CO. RD. M	APPROVED BY:	DRAWN BY EDS
SCALE: 1/4" = 1'-0"		REVISED
DATE: APR. 92	<b>FLOOR PLAN, ELECT. &amp; HEAT</b>	
PLAN NO. 260	DRAWING NUMBER 3 OF 4	



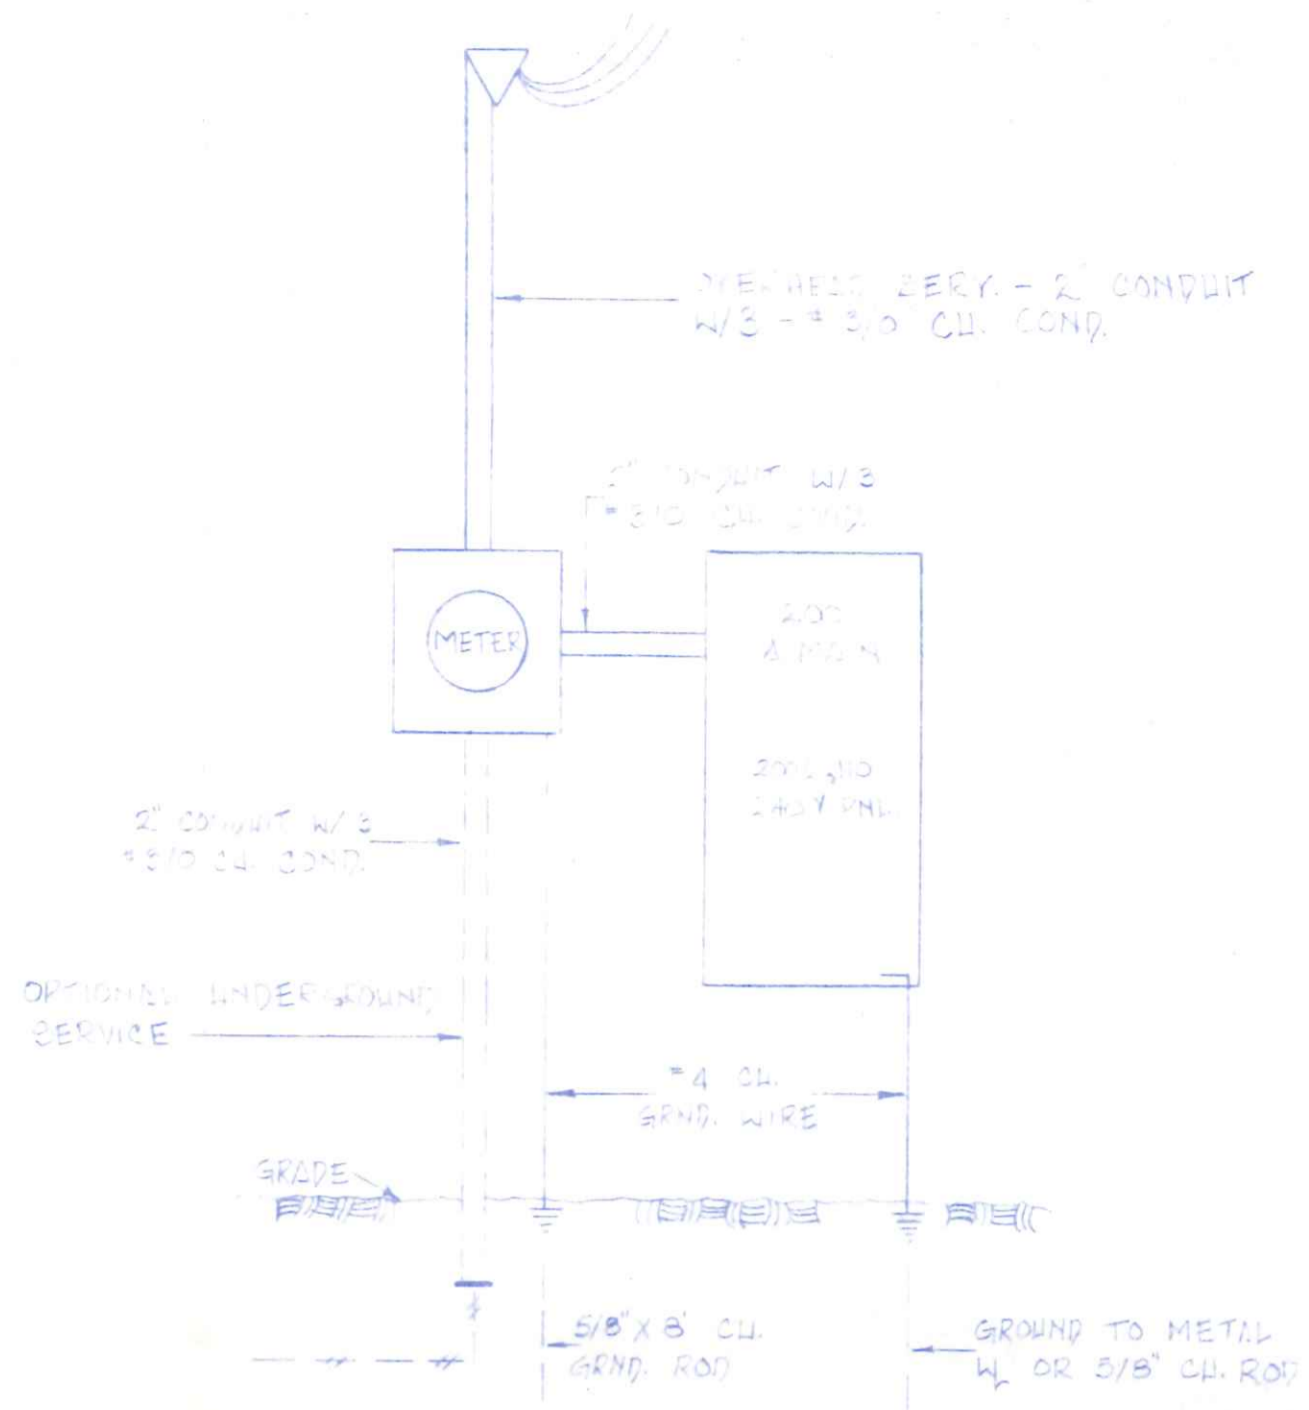

ELECTRICAL RISER DIAGRAM

NO SCALE

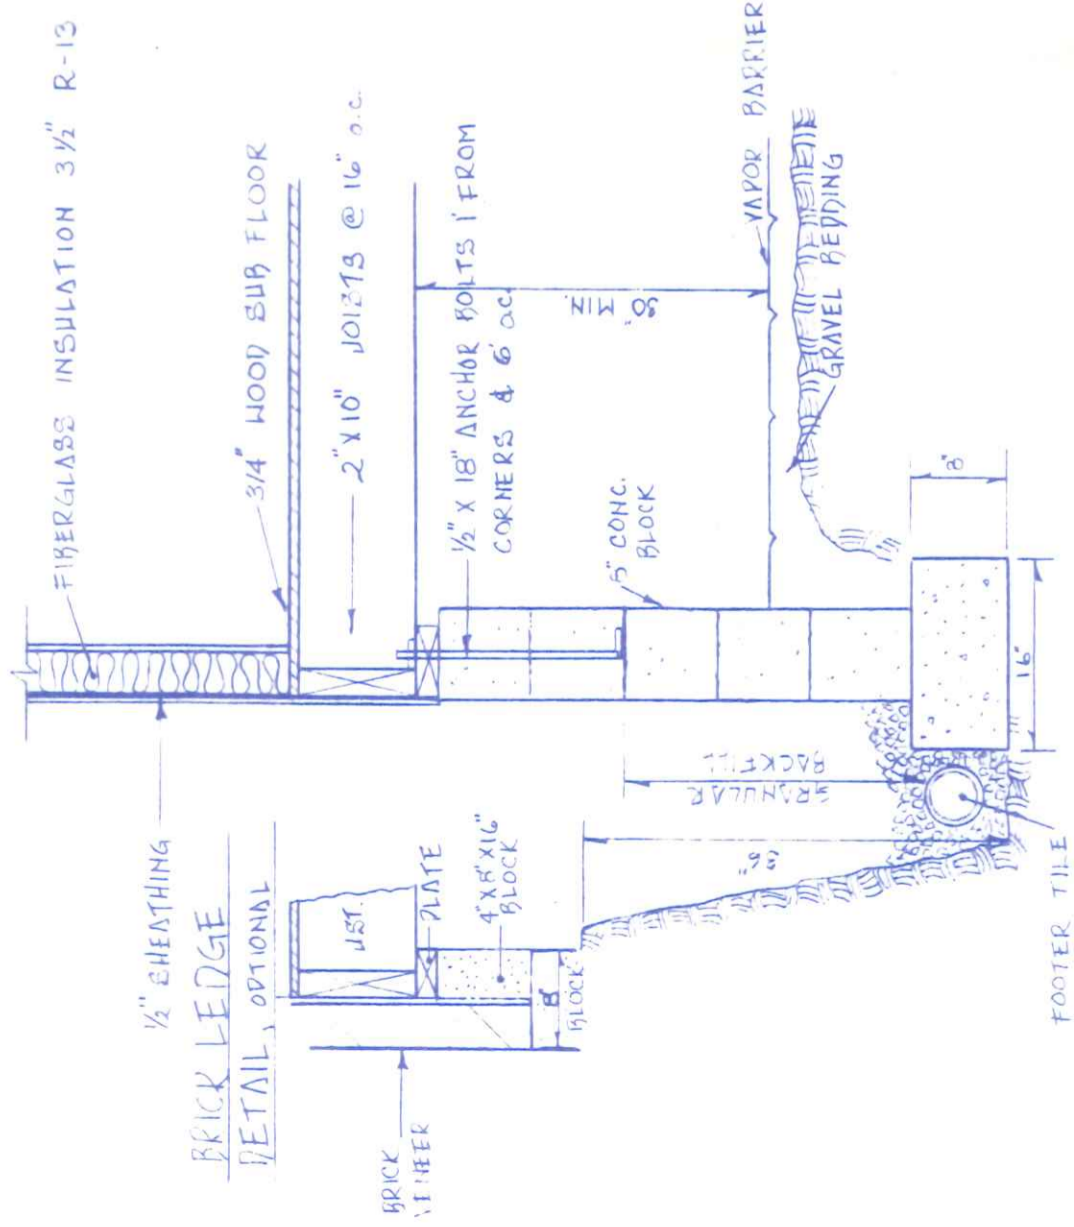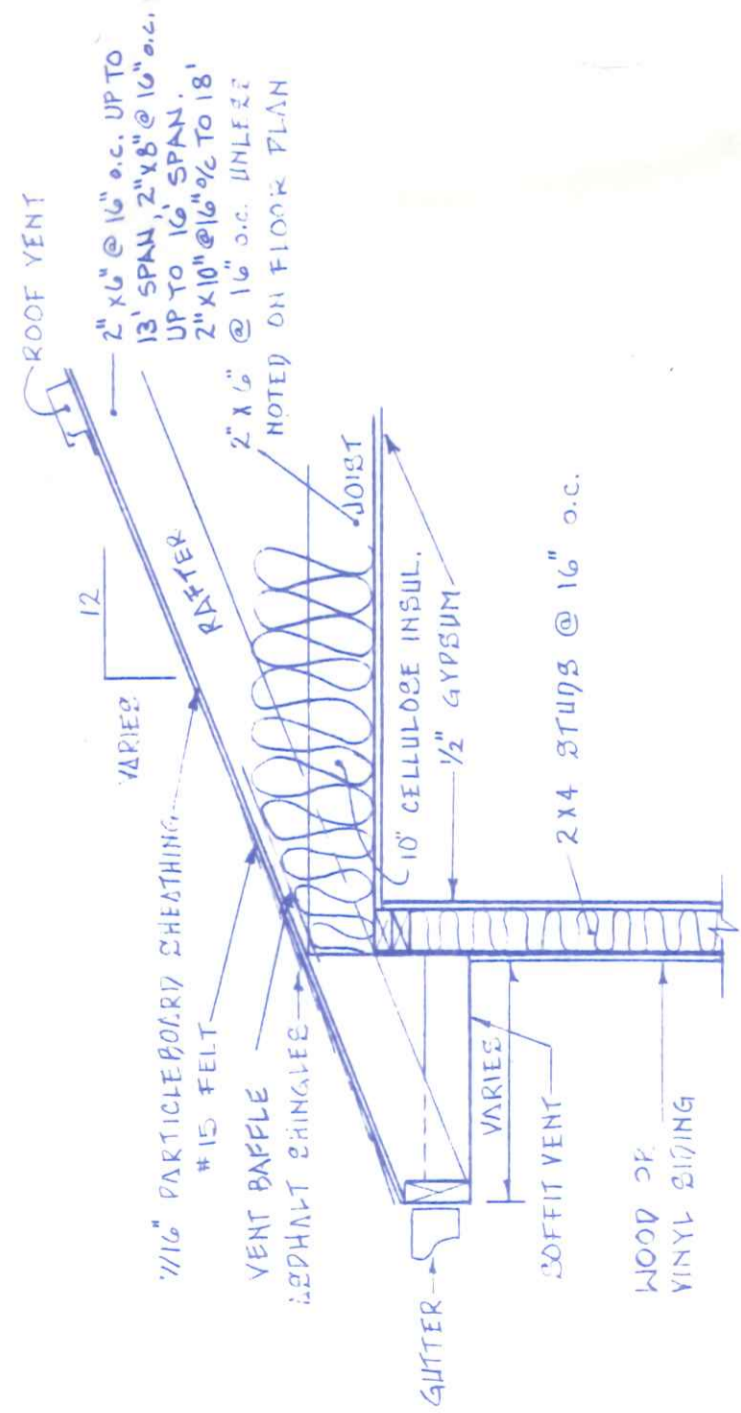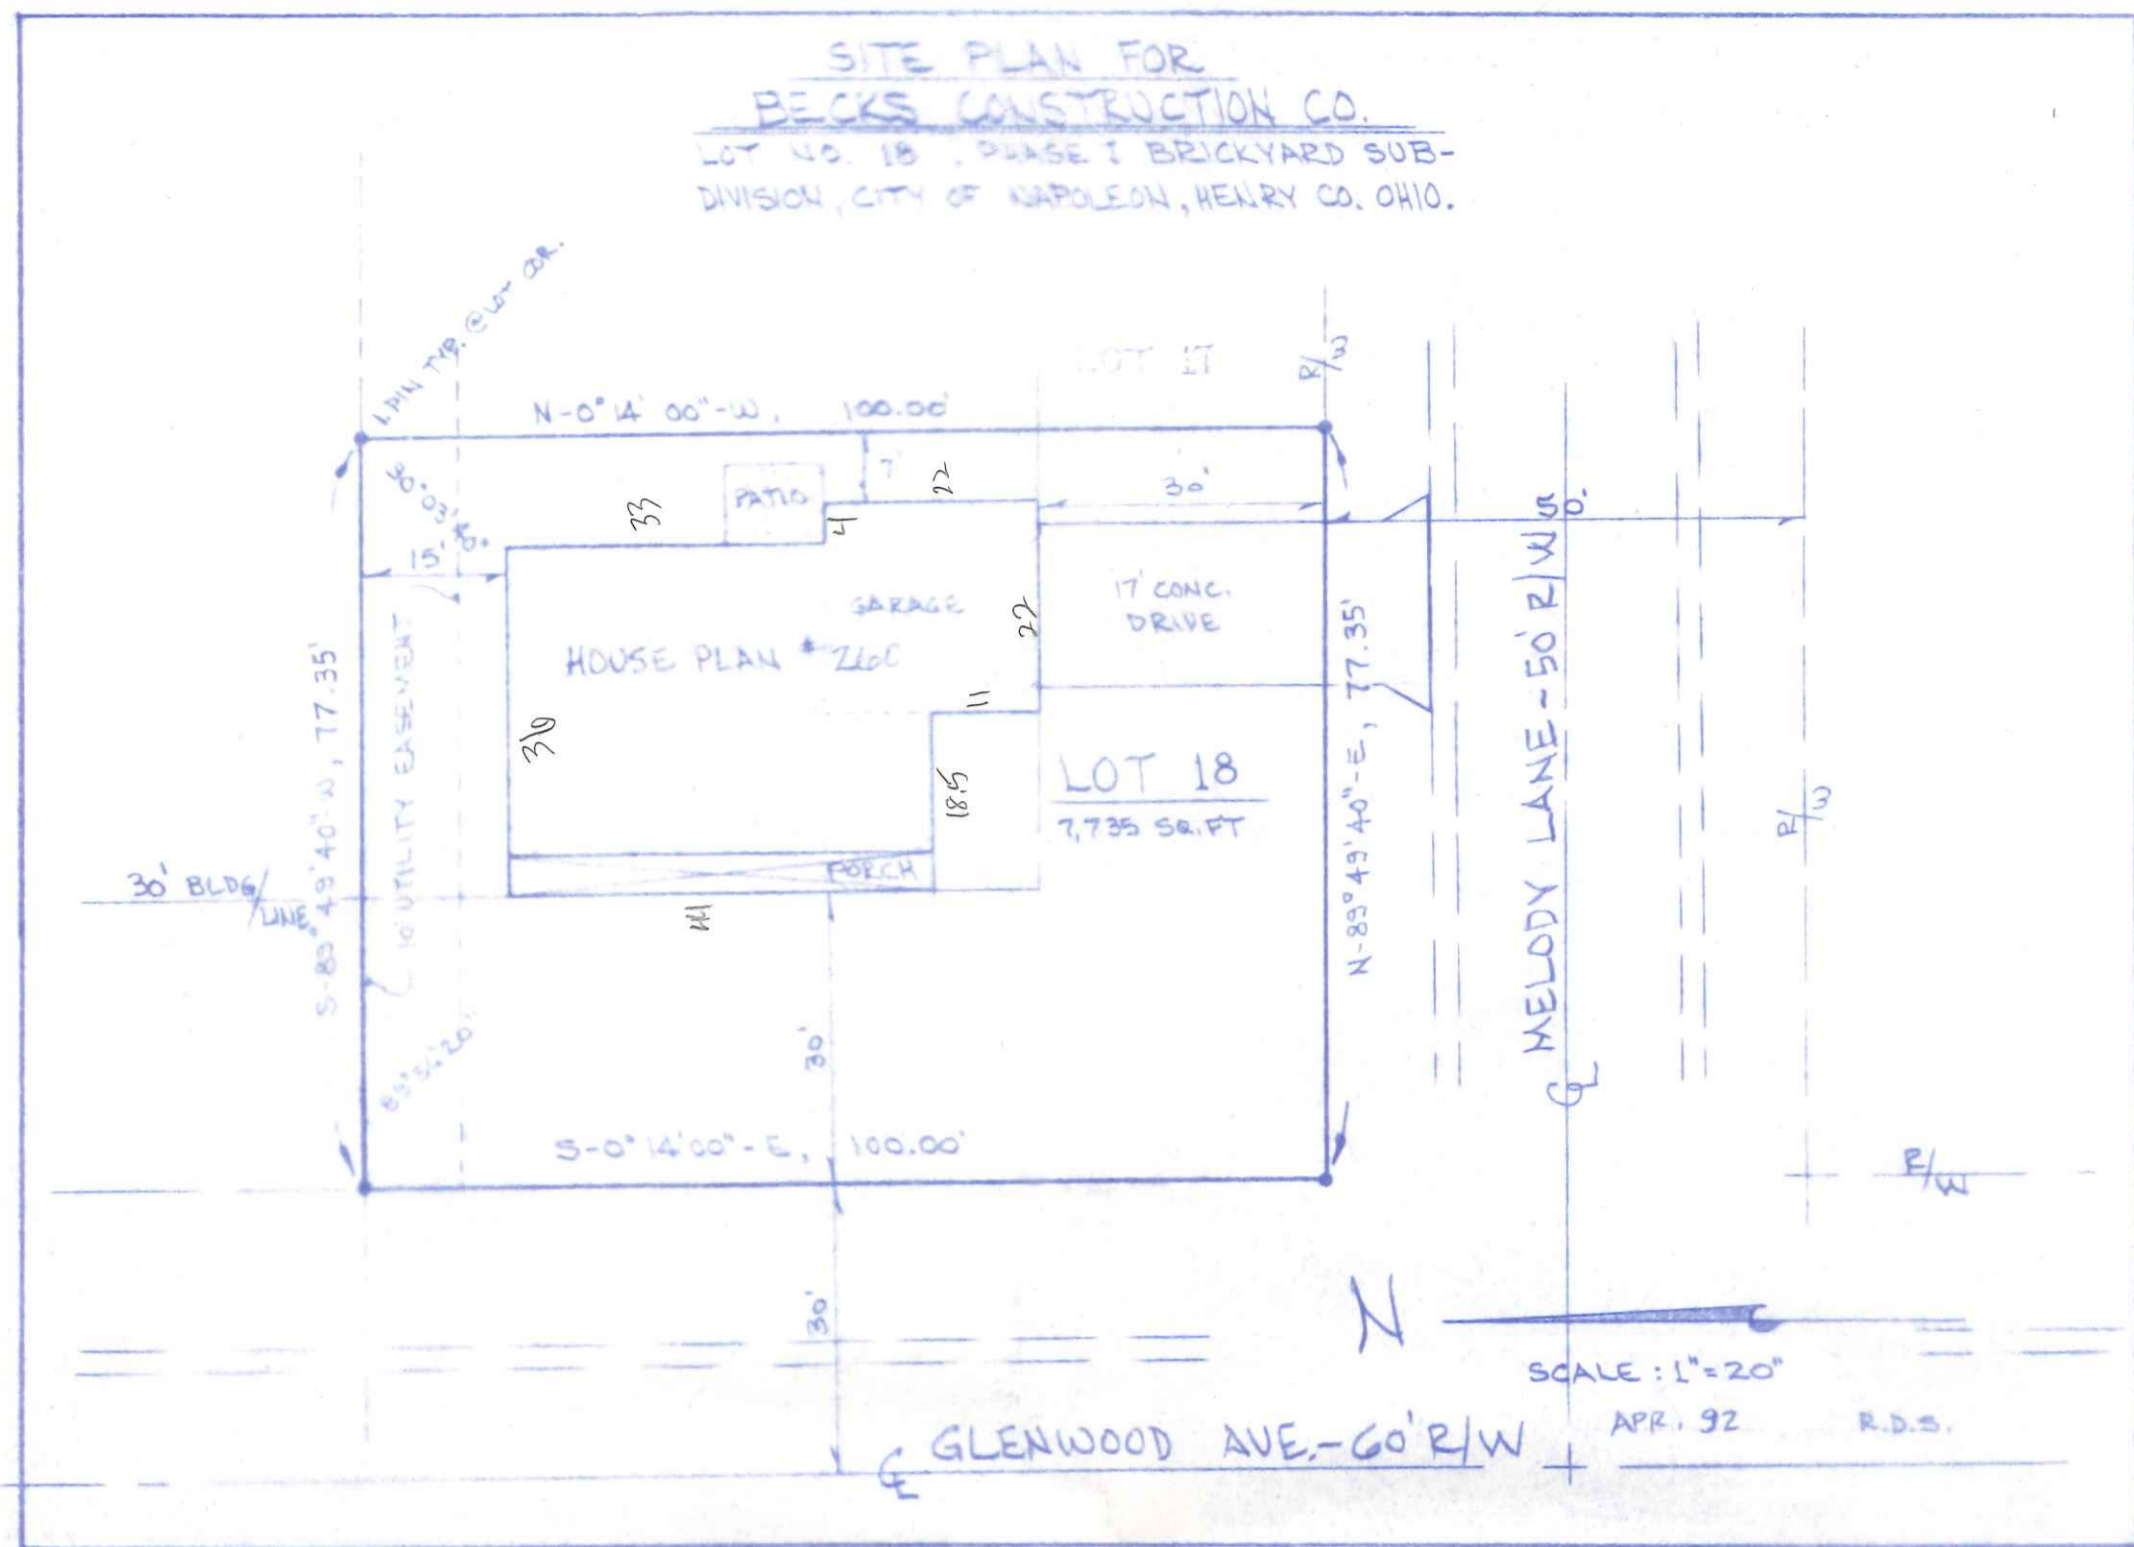

TYPICAL CROSS-SECTION

5/4" = 1'-0"

