
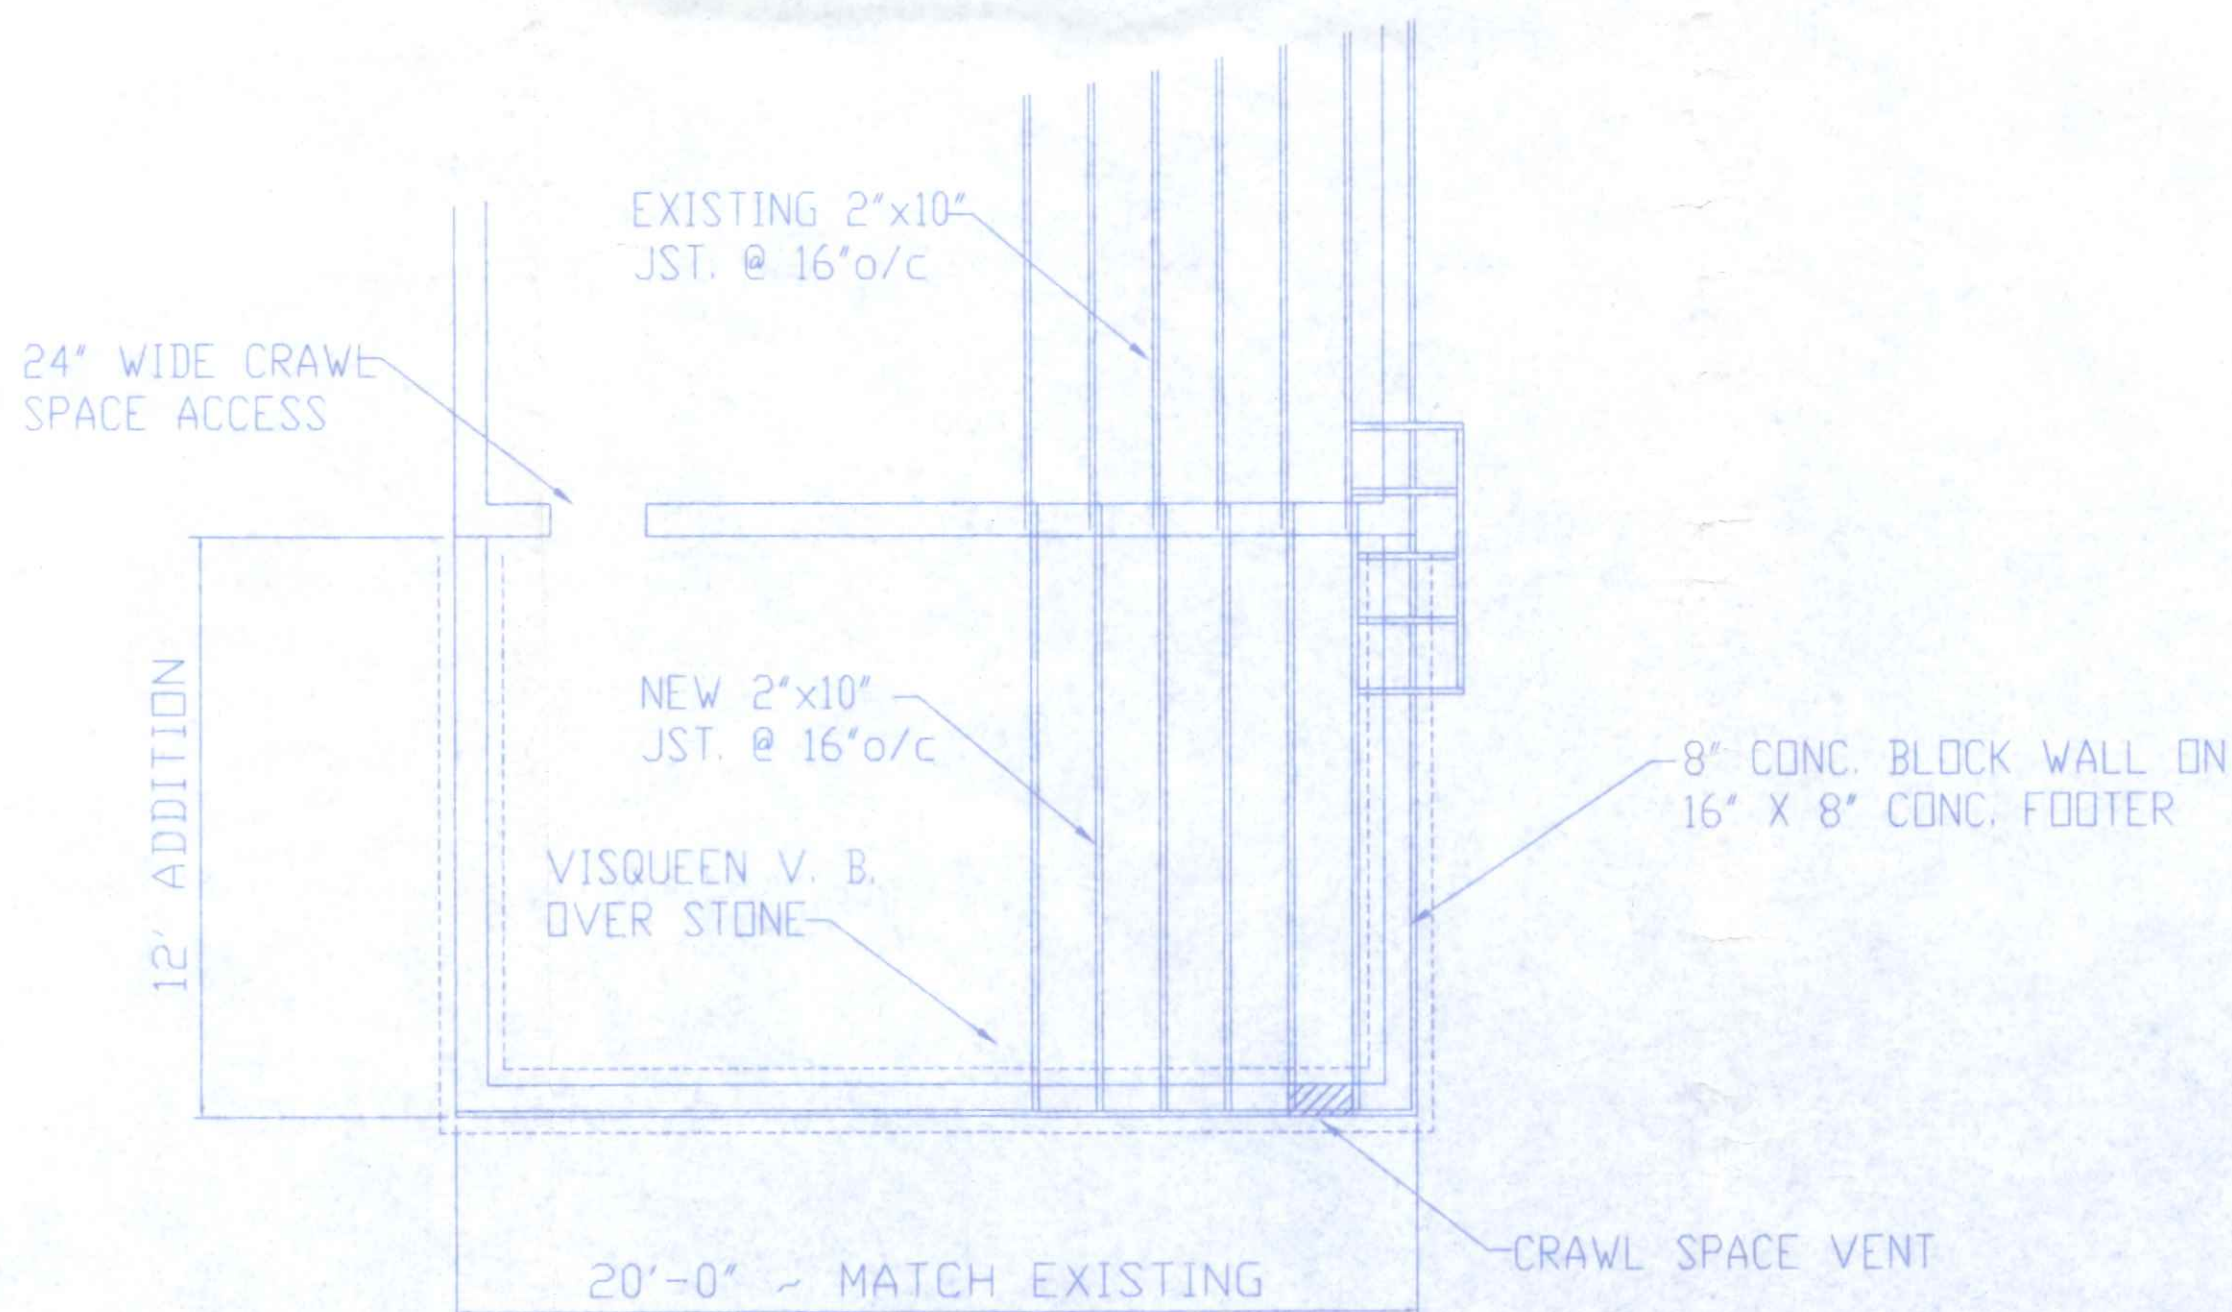


VAULTED CEILING FRAMING
NO SCALE

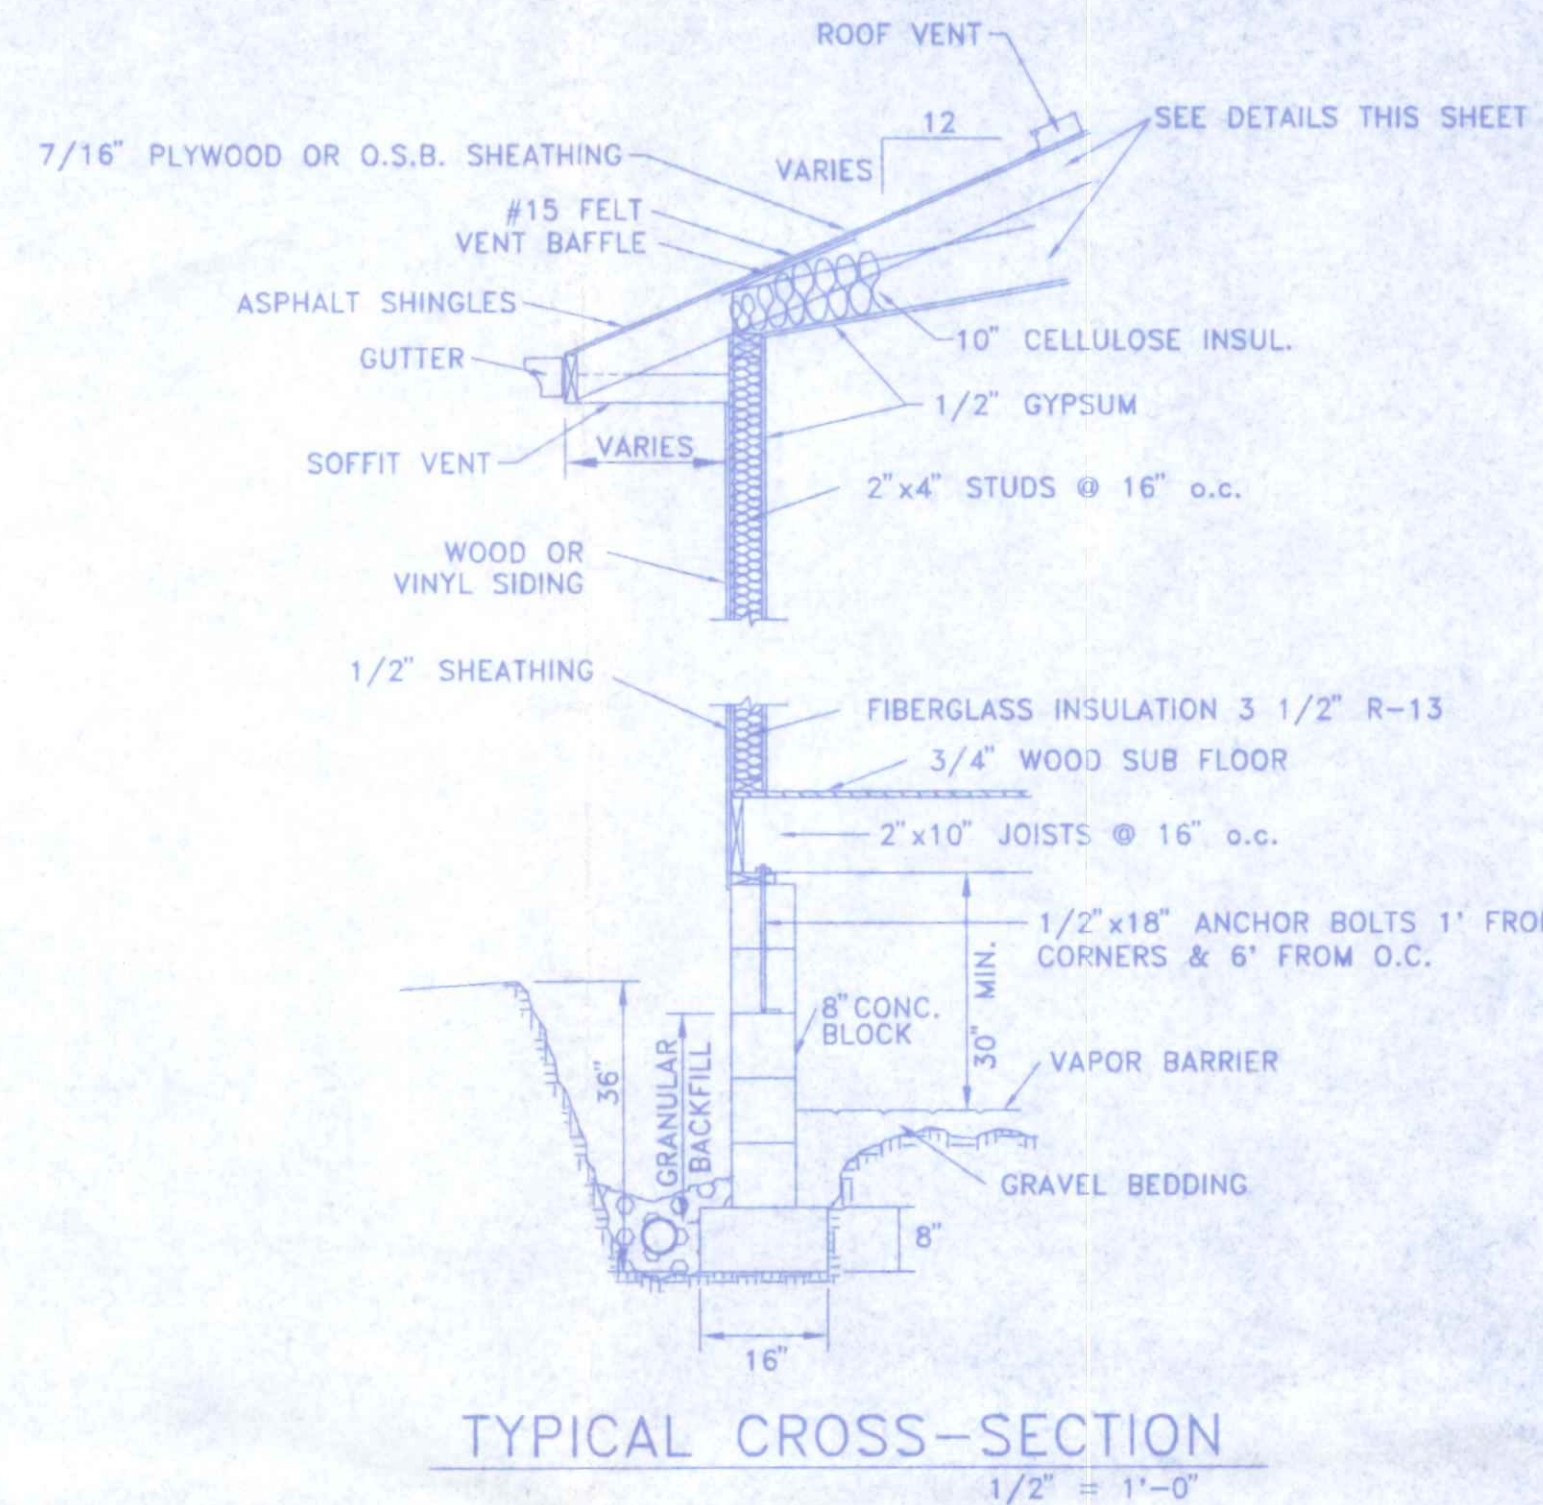


FOUNDATION PLAN
1/4" = 1' 0"


ELECTRICAL LEGEND

- Ⓢ PRIMARY POWERED SMOKE DETECTOR
- Ⓢ EXHAUST FAN
- ⊙ CEILING LIGHT FIXTURE
- ⊙ WALL MOUNT LIGHT FIXTURE
- Ⓢ LIGHT SWITCH
- 110 V. OUTLET G.F.C.I.
- 110 V. OUTLET SWITCHED 1 SIDE
- 120 V. DUPLEX RECEPTICLE
- 240 V RECEPTICLE
- ⊙ SPECIAL OUTLET


NOTE: ALL WORK AND MATERIAL SHALL BE IN ACCORDANCE WITH THE NATIONAL ELECTRIC CODE, LATEST EDITION, AND ANY LOCAL CODES AND REQUIREMENTS.
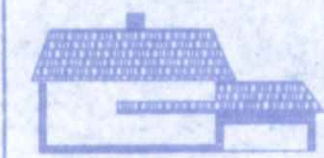
| | | |
|---|--|---------------------------------|
|  | BECK CONSTRUCTION CO COUNTY ROAD W 419/592-8307 NAPOLEON, OHIO | |
| | DIRECTORY: C:\BECK FILE NAME: LANKADDN.DWG | DRAWN BY: R.D.S. REVISED: |
| LANKENAU ADDITION | | SCALE: NOTED DATE: OCT. 1995 |
| ELECT LEGEND, X-SECTIONS & DETAILS | | DRAWING NUMBER: 2 OF 2 |

260 ordered in

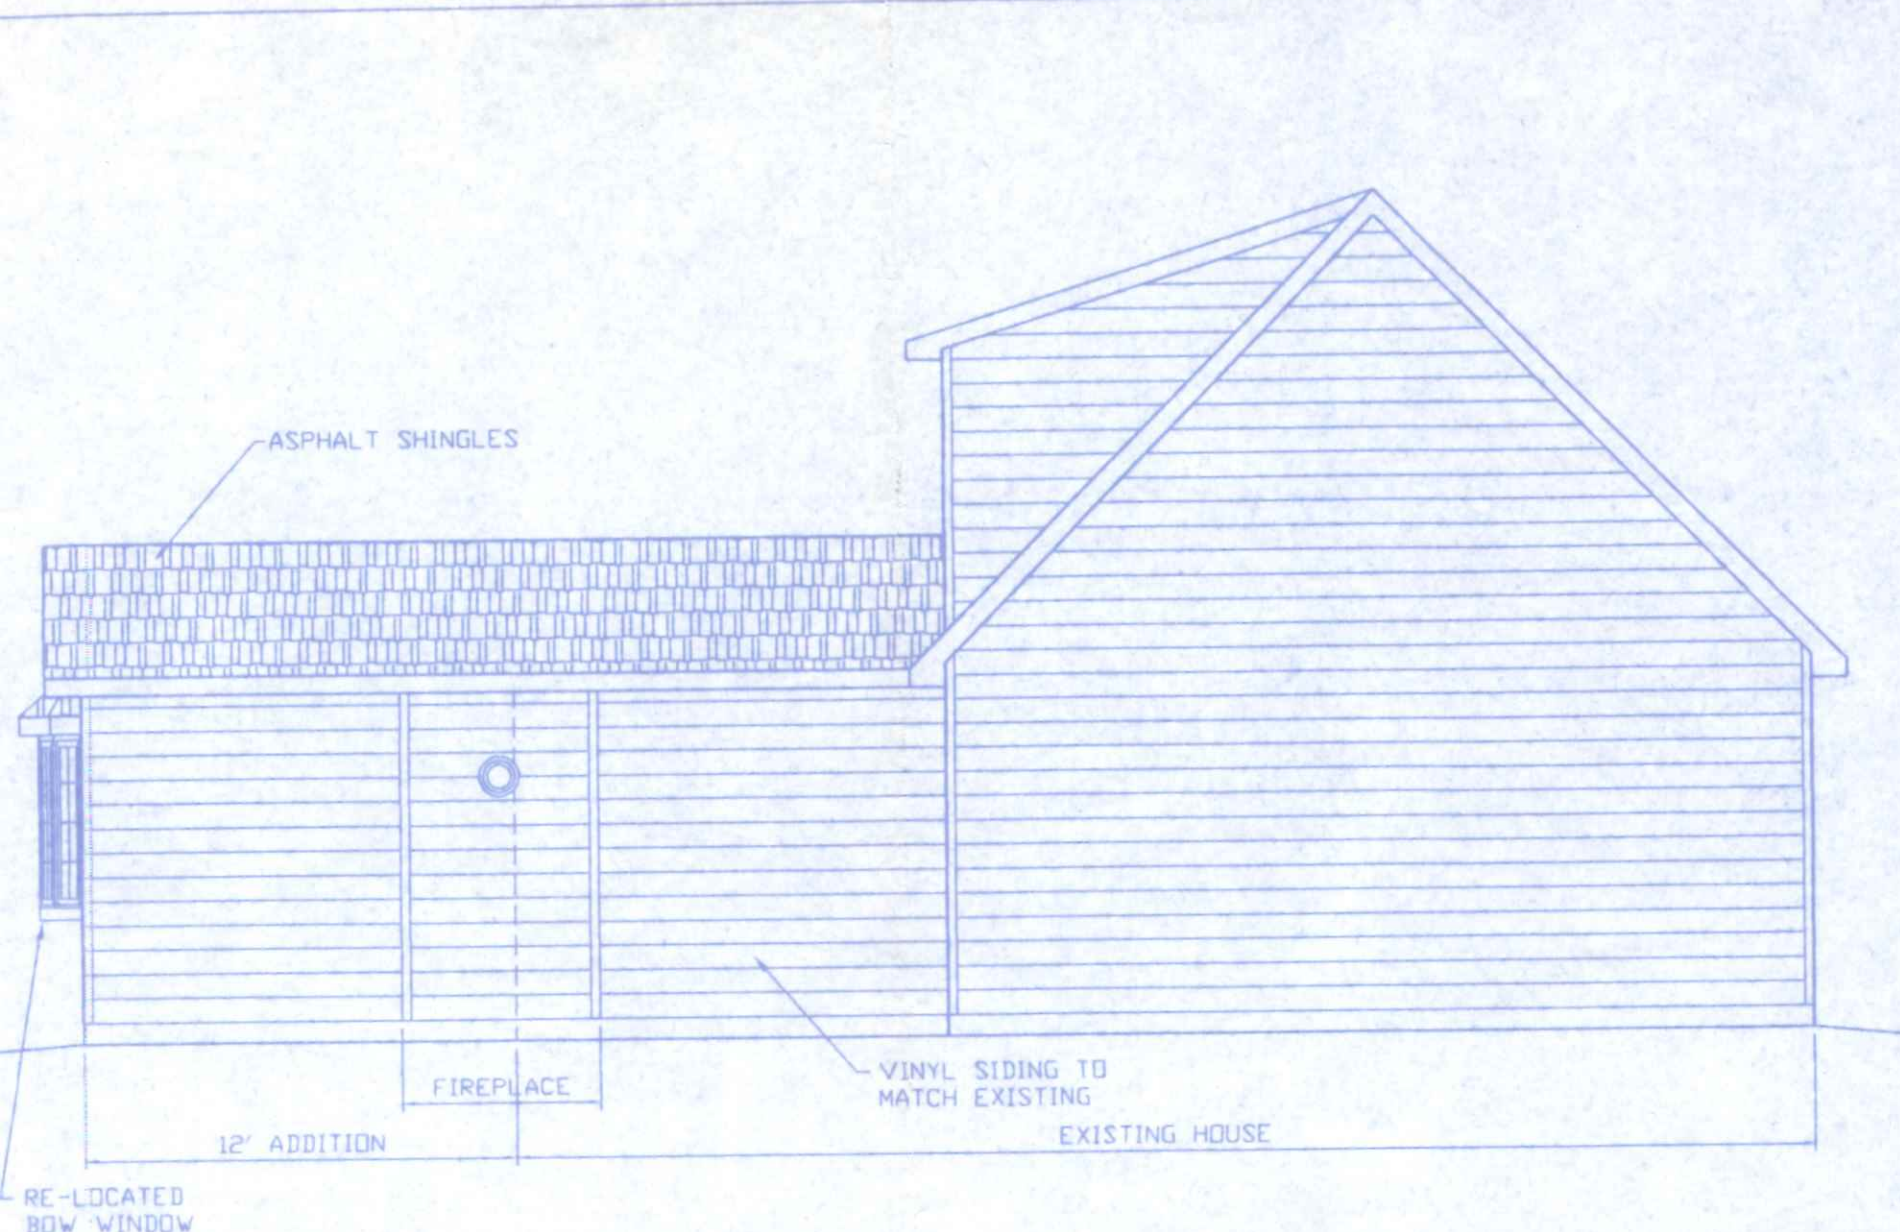


LEFT SIDE ELEVATION
3/16" = 1'-0"

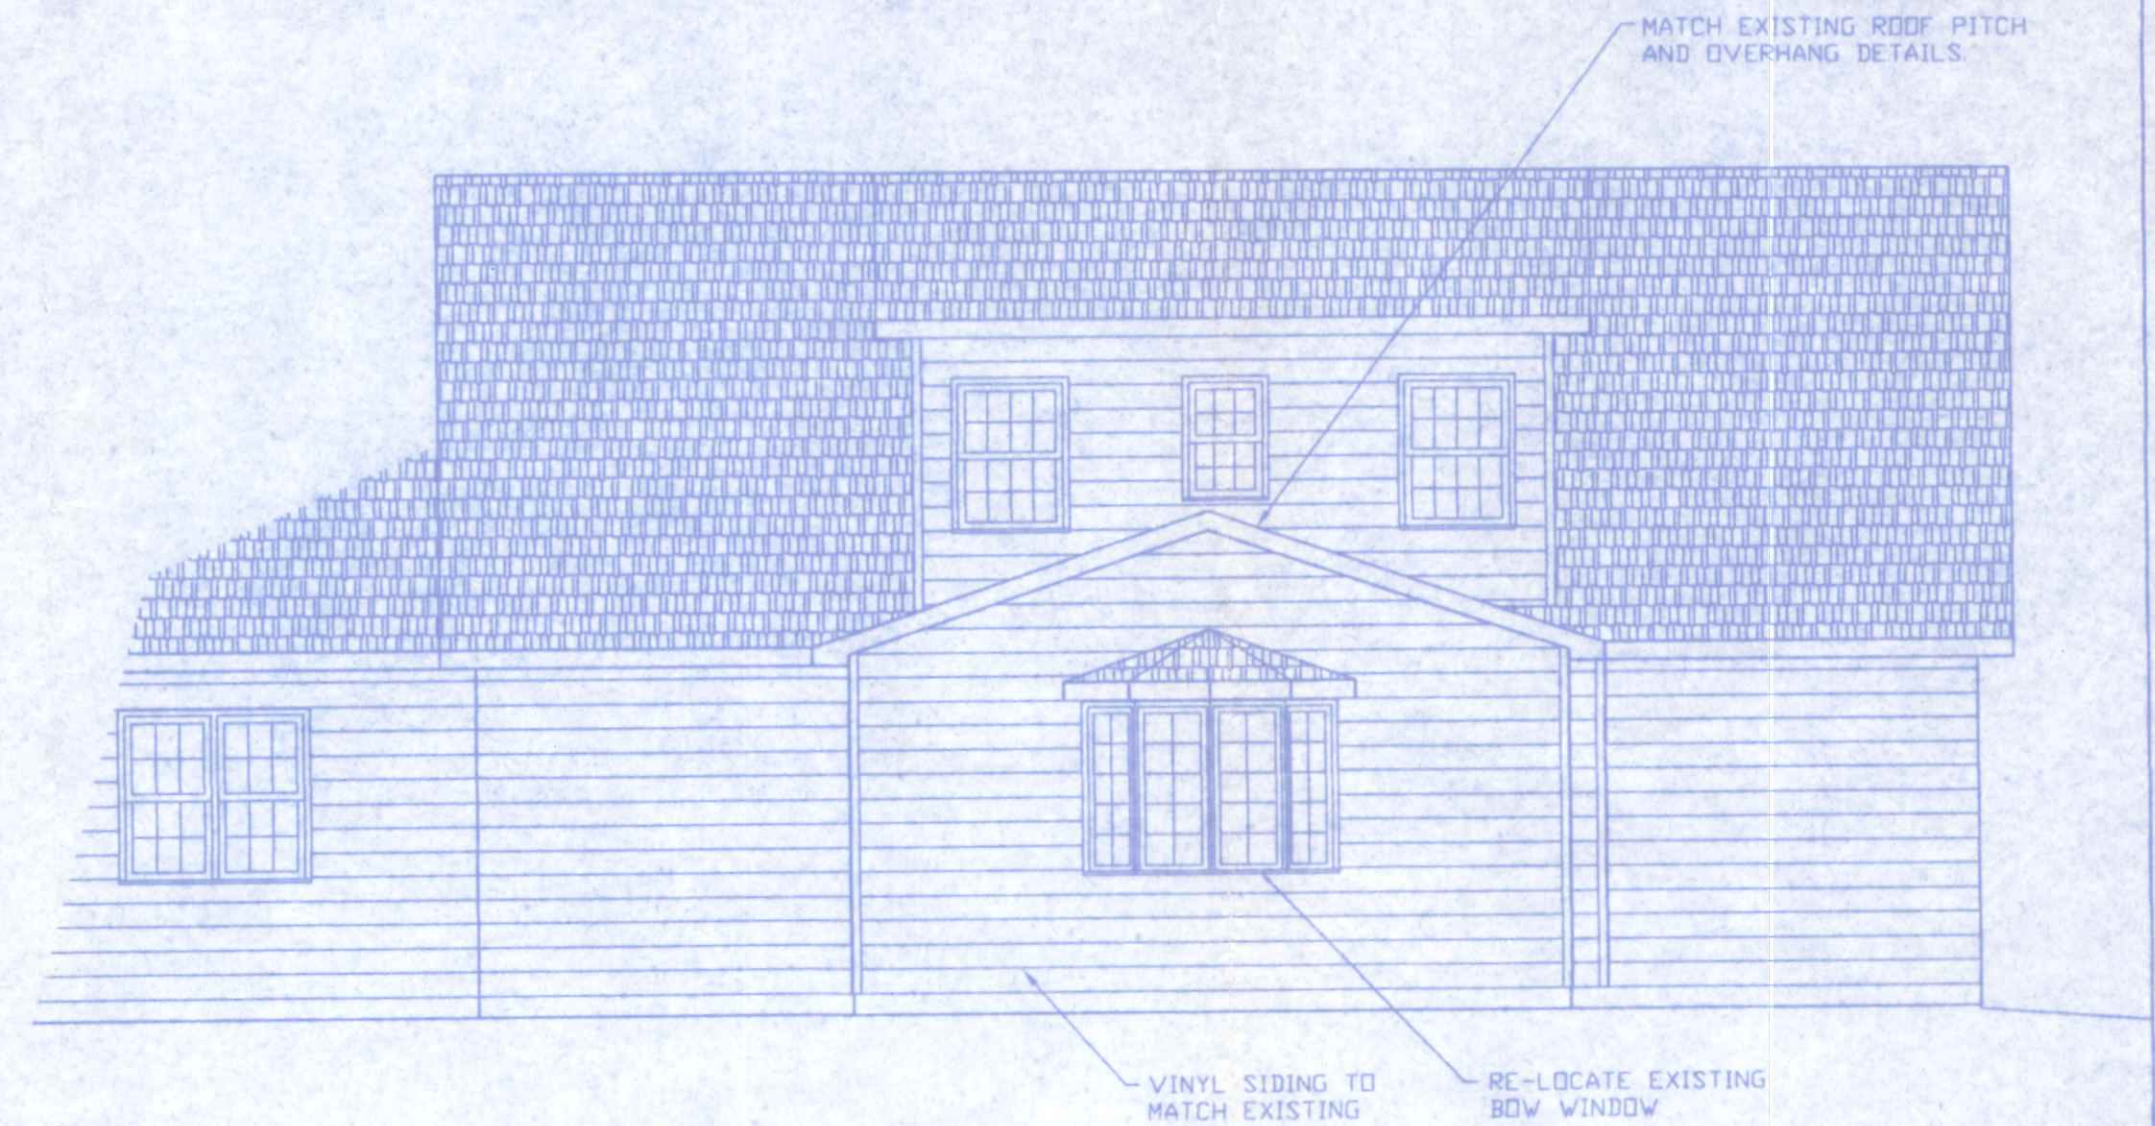


REAR ELEVATION
3/16" = 1'-0"

on Lan Keway
260 Orchard Ln.

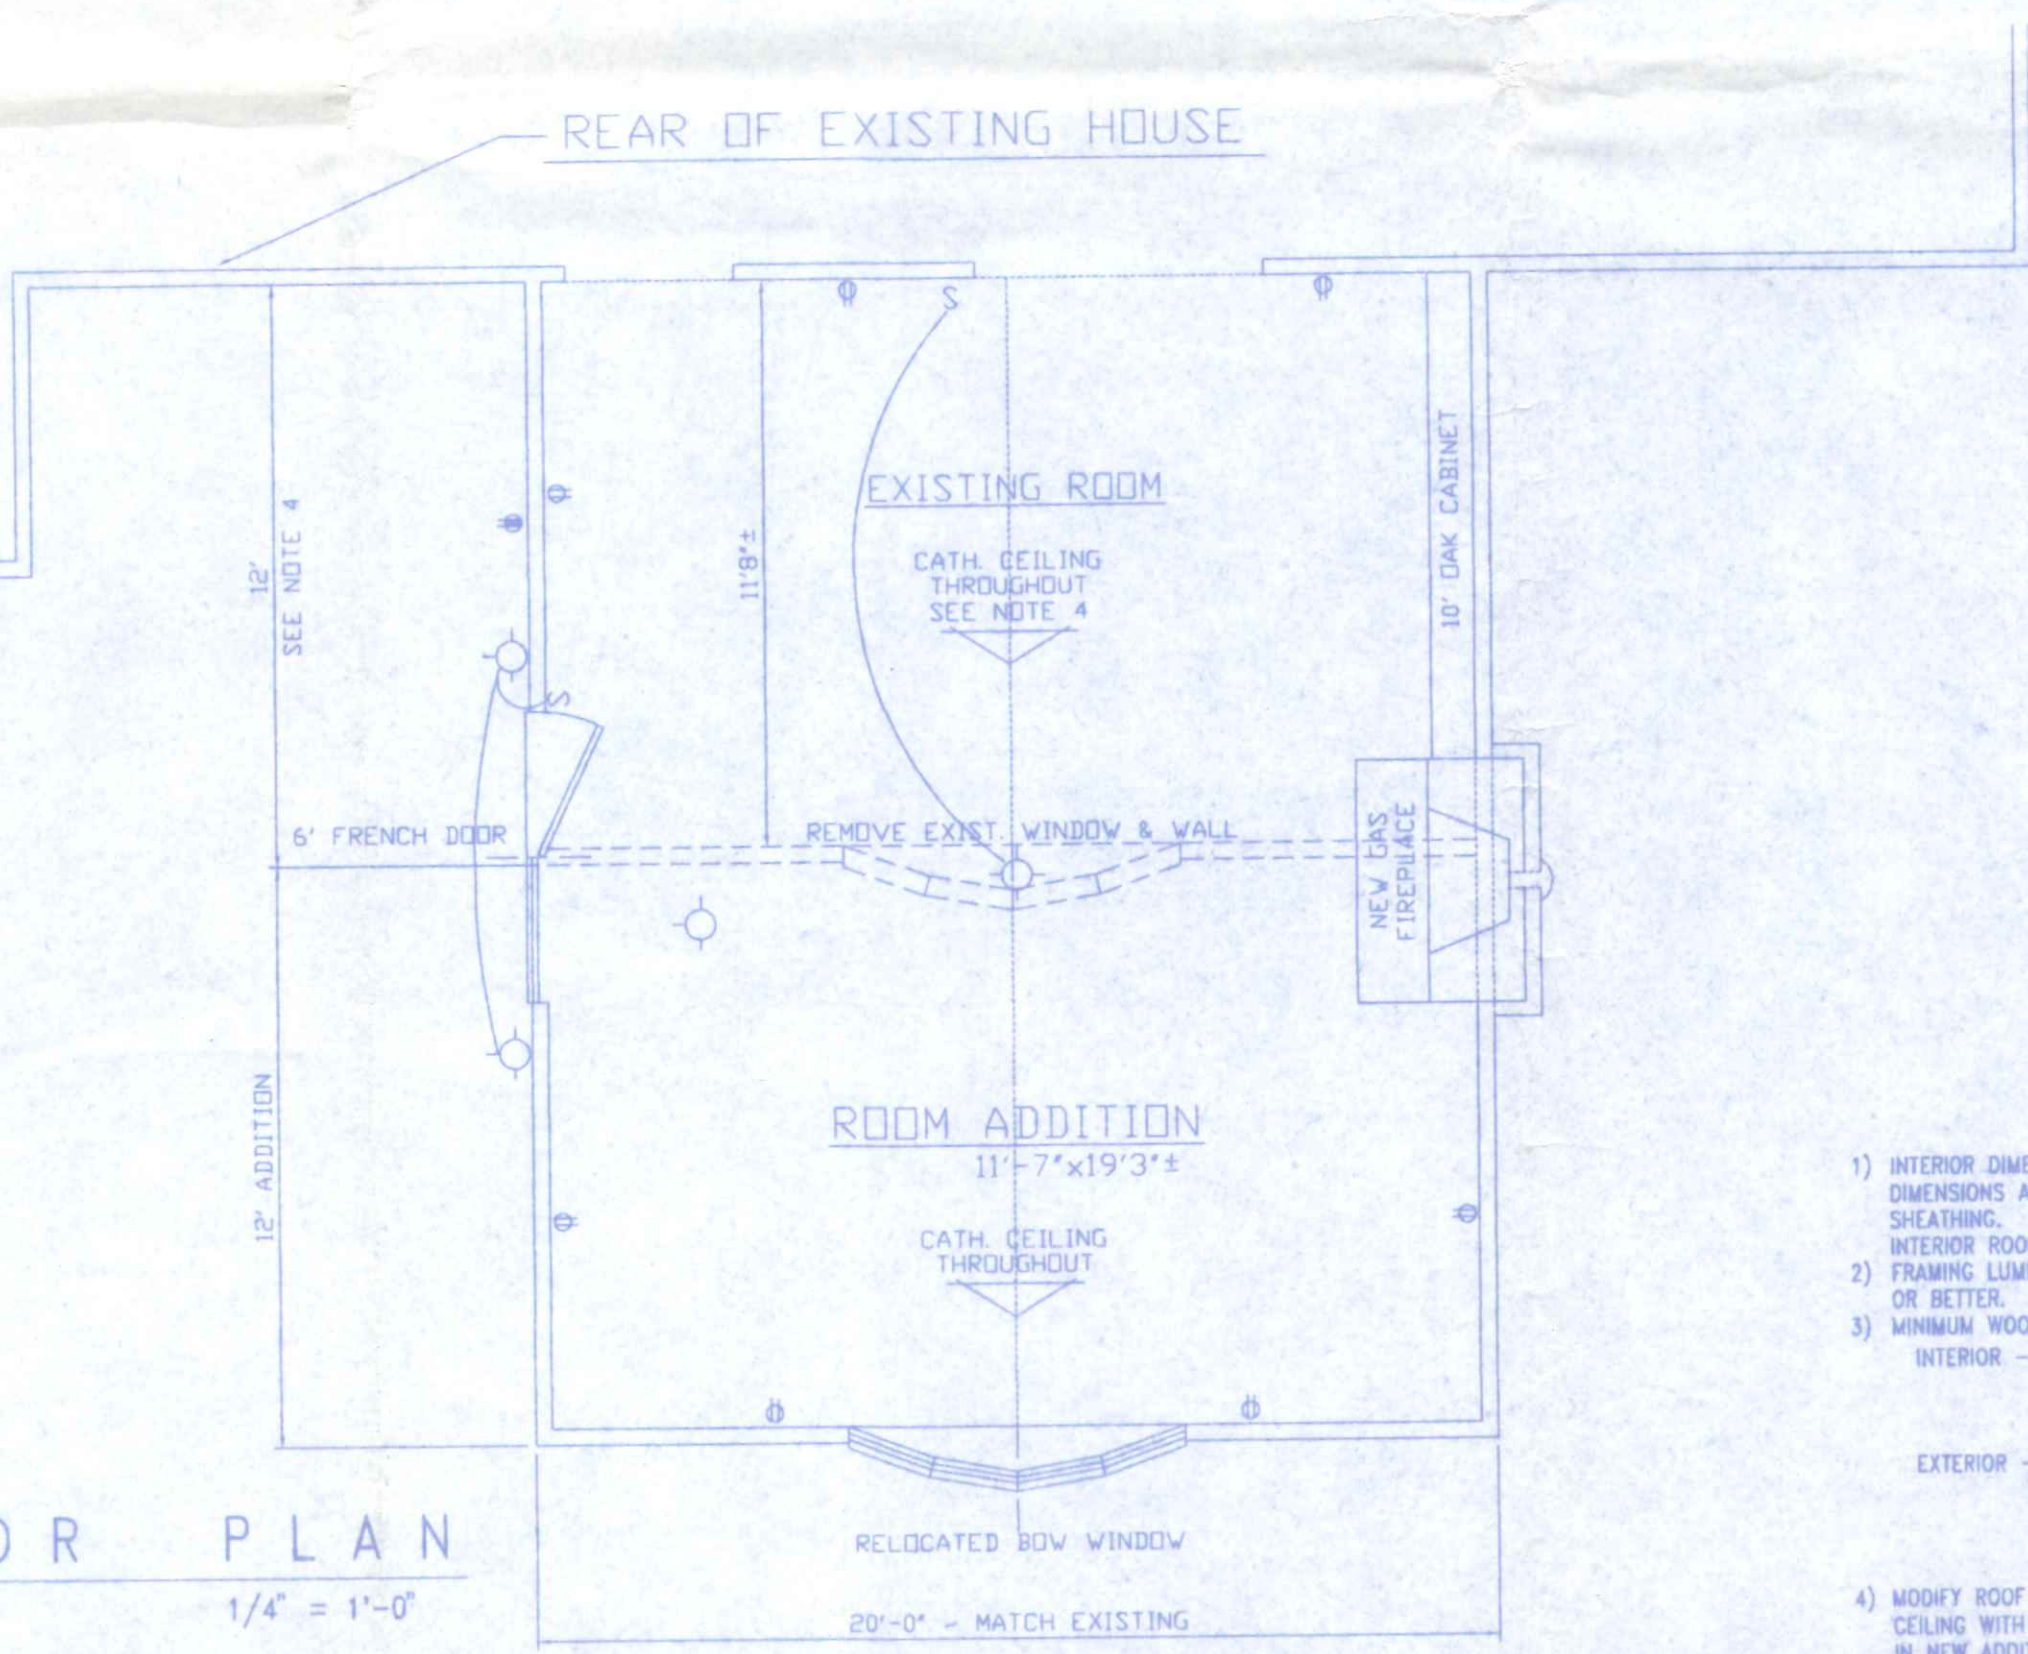

FLOOR PLAN
1/4" = 1'-0"

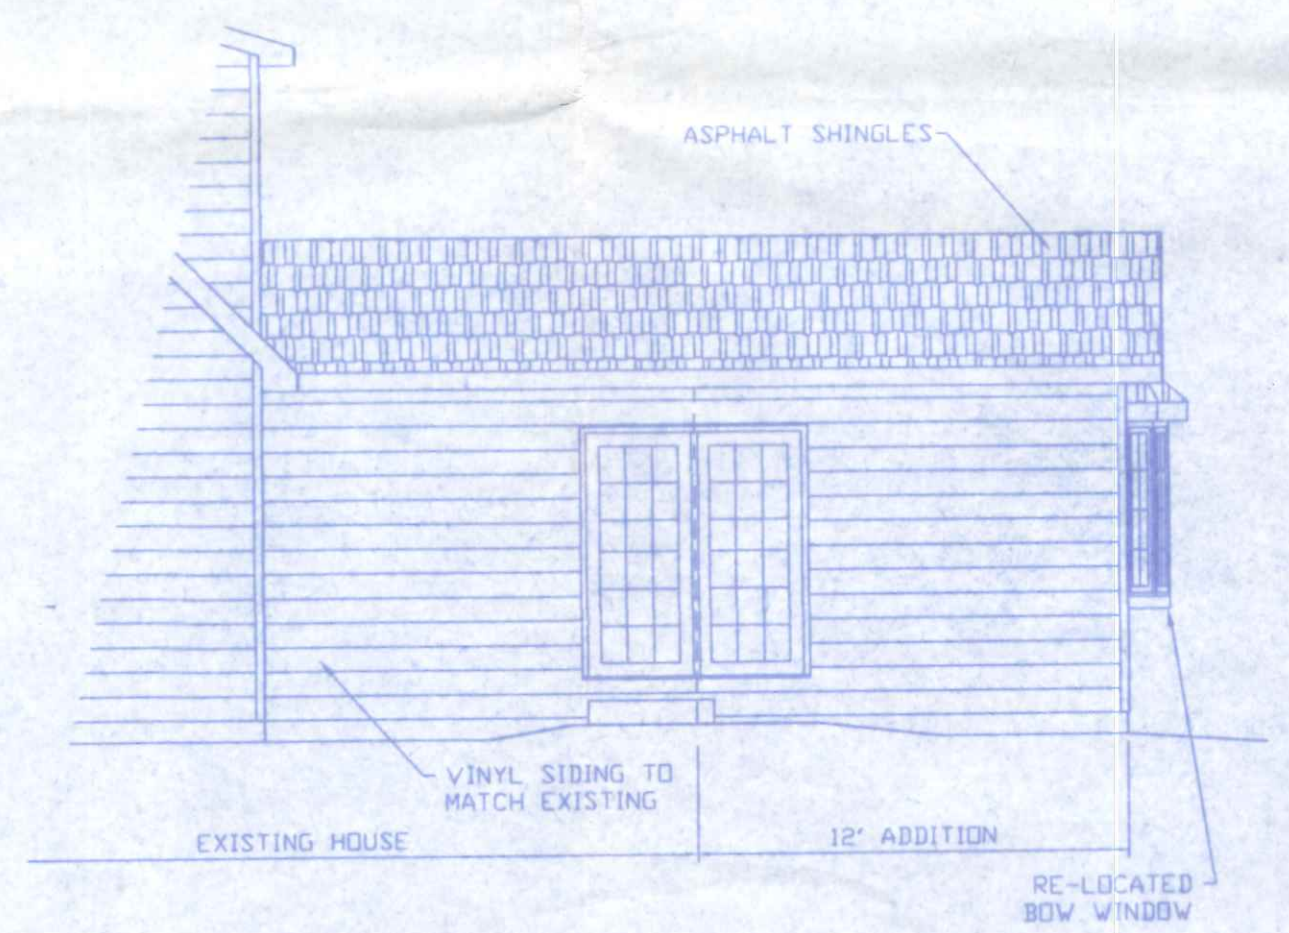

RIGHT SIDE ELEVATION
3/16" = 1'-0"

22,000

- NOTES**
- 1) INTERIOR DIMENSIONS ARE TAKEN TO STUD LINE, EXTERIOR DIMENSIONS ARE TAKEN TO OUTSIDE OF FOUNDATION OR SHEATHING.
INTERIOR ROOM SIZES ARE APPROXIMATE FINISHED DIMENSIONS
 - 2) FRAMING LUMBER TO BE MINIMUM NO. 2 SPRUCE-PINE-FIR, OR BETTER.
 - 3) MINIMUM WOOD HEADER SIZES SHALL BE AS FOLLOWS:
INTERIOR - 2-2"x6" FOR SPANS FROM 0' TO 4'
2-2"x8" FOR SPANS FROM 4' TO 8'
2-2"x10" FOR SPANS FROM 6' TO 8'
GREATER SPANS AS NOTED.
EXTERIOR - 2-2"x6" FOR SPANS FROM 0' TO 3'
2-2"x8" FOR SPANS FROM 3' TO 5'
2-2"x10" FOR SPANS FROM 5' TO 7'
2-2"x12" FOR SPANS FROM 7' TO 9'
GREATER SPANS AS NOTED ON PLAN
 - 4) MODIFY ROOF TRUSSES IN EXISTING ROOM TO CATHEDRAL CEILING WITH 2:12 PITCH, MAXIMUM TO MATCH CEILING IN NEW ADDITION.

| | | |
|---|--|---|
| | BECK CONSTRUCTION CO COUNTY ROAD M 419/592-8307 NAPOLEON, OHIO | |
| | DIRECTORY: C:\BECK FILE NAME: LANKADDN.DWG | DRAWN BY: R.D.S. REVISED: SCALE: NOTED DATE: OCT. 1995 |
| LANKENAU ADDITION FLOOR PLAN & ELEVATIONS | | DRAWING NUMBER: 1 OF 2 |