

EQUIPMENT SCHEDULE (SUPPLIED BY OWNER - INSTALLED BY CONTRACTOR)

NO.	ITEM	MANUFACTURER	MODEL NO.	SPECIFICATION
9	UNDER-COUNTER REFRIGERATOR	BERG NEO	EDUR-27-B-HC	172.5W, 1φ

DATE/REVISION:

05/12/23 REVISION

05/05/23 PERMIT

PROJECT NO: DATE:

22126 05/12/2023

DRAWN BY: CHECKED BY:

A.J.C. D.N.G.

SK-1

1 OF 2 DRAWINGS

# FLOOR PLAN

SCALE: 1/8" = 1'-0"



FLOOR PLAN

INTERIOR ALTERATIONS FOR:

VALDA JUNES ICE CREAM

613 N. PERRY STREET  
NAPOLEON, OHIO




## Architecture by Design, Ltd.

5622 Mayberry Square, Sylvania, Ohio 43560

(419) 824-3311 | architecturebydesign.net

© Architecture by Design, Ltd. 2023

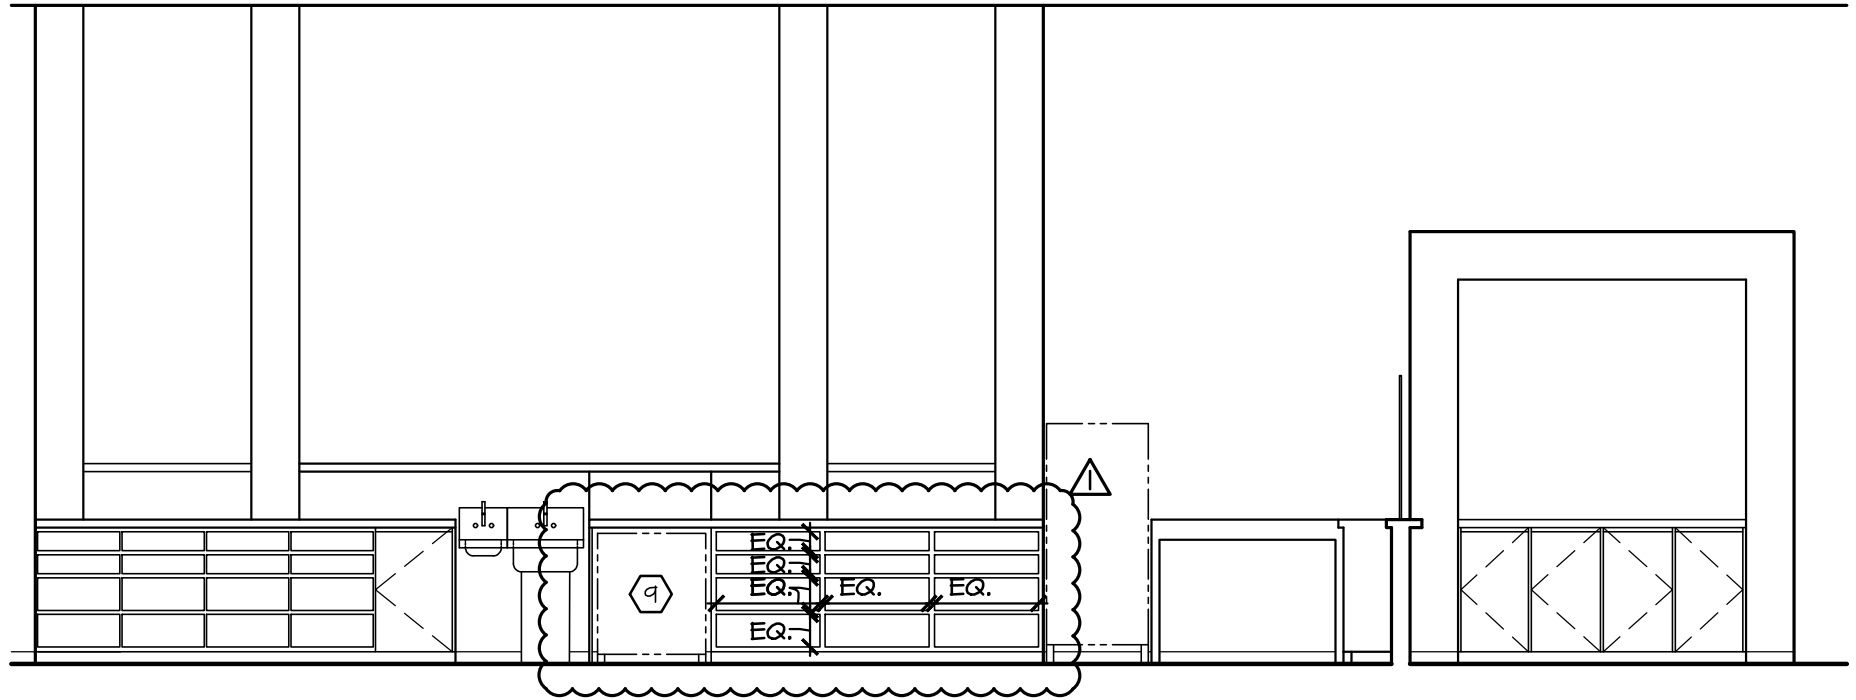

EQUIPMENT SCHEDULE (SUPPLIED BY OWNER - INSTALLED BY CONTRACTOR)				
NO.	ITEM	MANUFACTURER	MODEL NO.	SPECIFICATION
9	UNDER-COUNTER REFRIGERATOR	BERG NEO	EDUR-27-B-HC	172.5W, 1φ

DATE/REVISION:	
05/12/23 REVISION	
05/05/23 PERMIT	
PROJECT NO:	DATE:
22126	05/12/2023
DRAWN BY:	CHECKED BY:
A.J.C.	D.N.G.
SK-2	
2 OF 2 DRAWINGS	

# BACK COUNTER SERVICE AREA

SCALE: 1/4" = 1'-0"

ELEVATION ▲

INTERIOR ALTERATIONS FOR:

VALDA JUNES ICE CREAM

613 N. PERRY STREET  
NAPOLEON, OHIO



**Architecture by Design, Ltd.**

5622 Mayberry Square, Sylvania, Ohio 43560  
(419) 824-3311 | [architecturebydesign.net](http://architecturebydesign.net)

© Architecture by Design, Ltd. 2023