



HENRY COUNTY FAIR GROUNDS

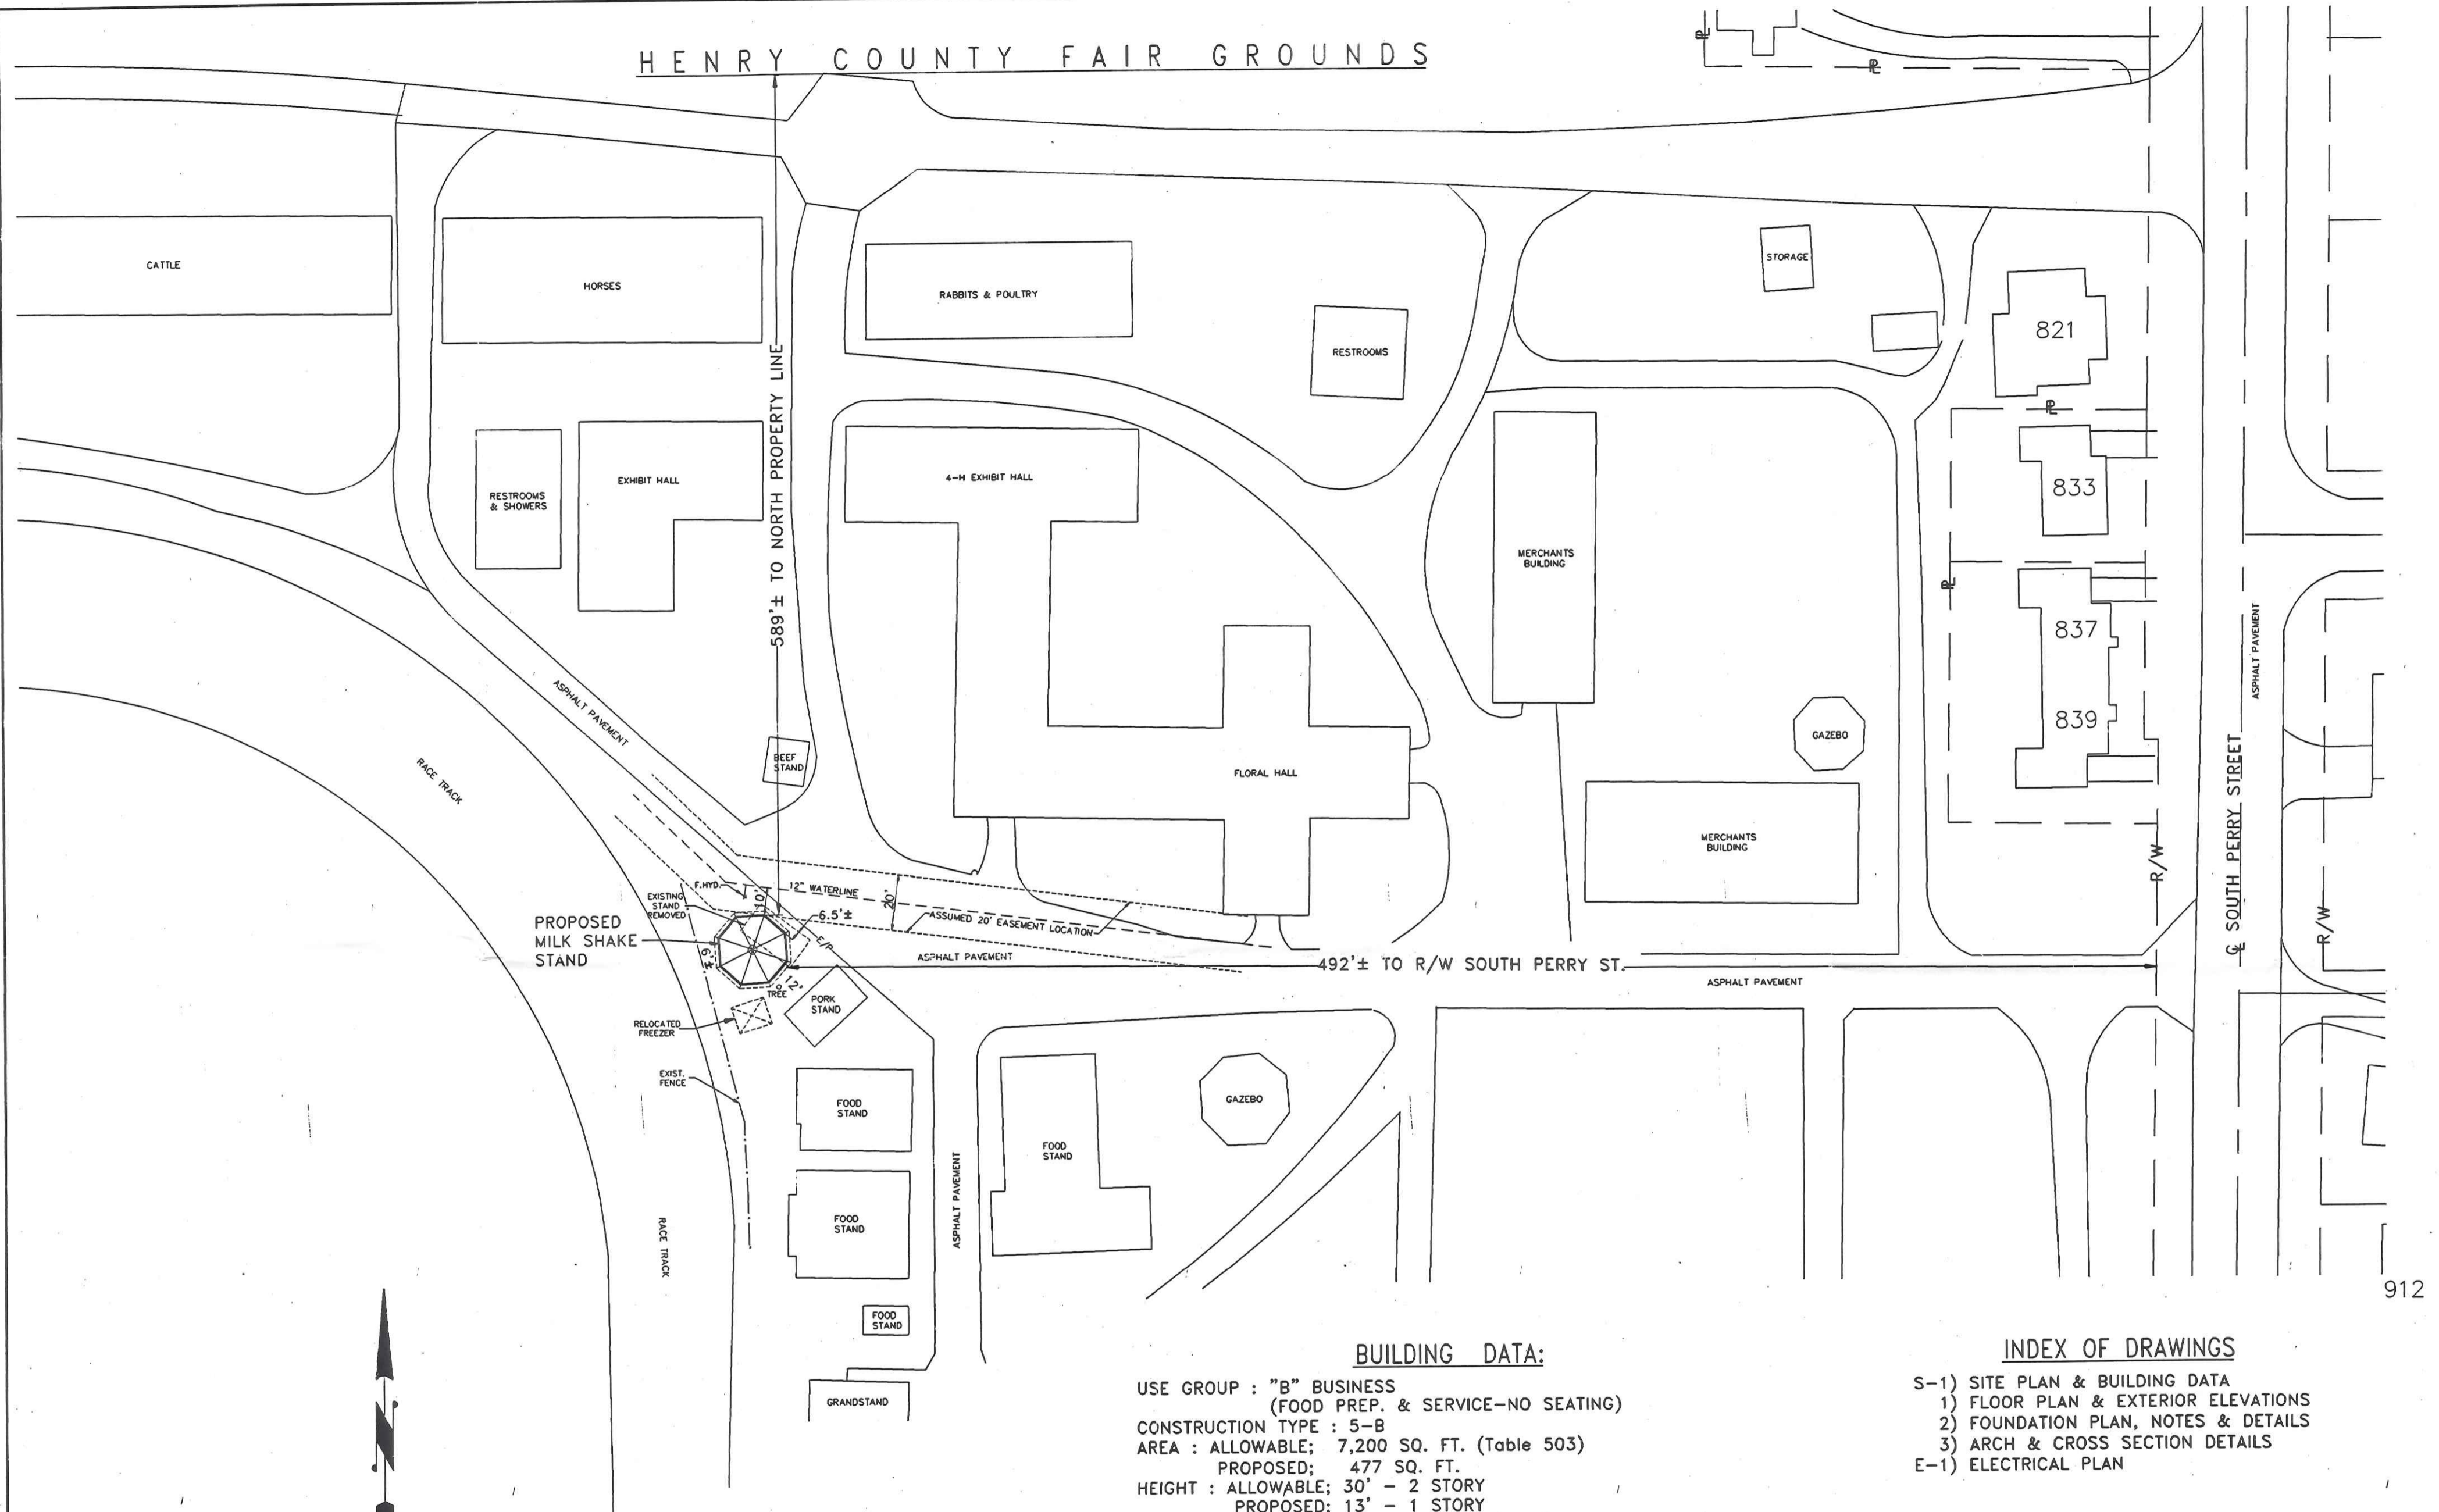

912

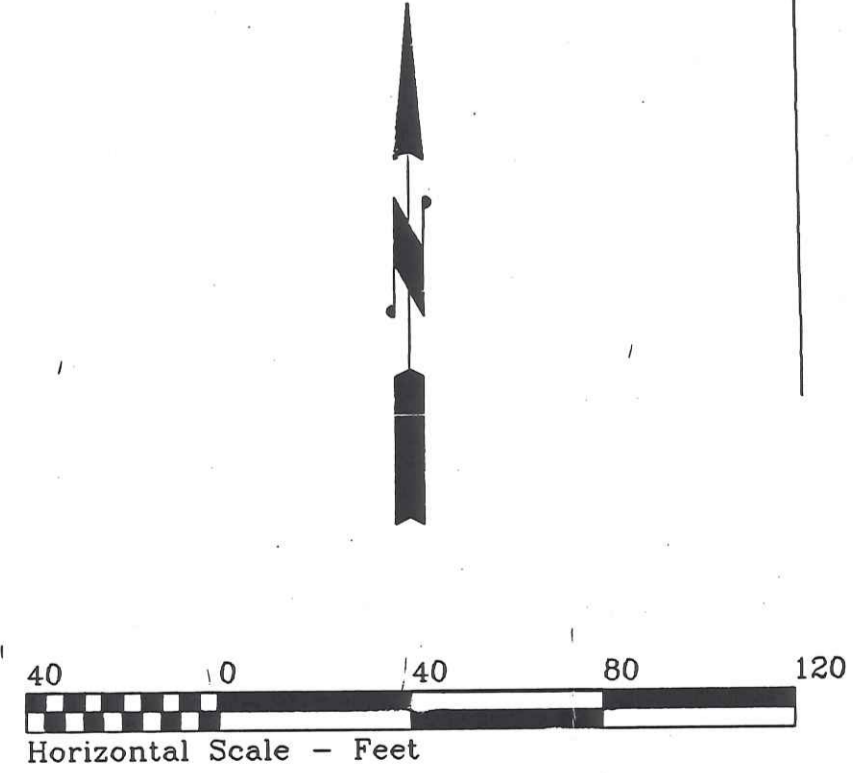

BUILDING DATA:

USE GROUP : "B" BUSINESS
 (FOOD PREP. & SERVICE-NO SEATING)
 CONSTRUCTION TYPE : 5-B
 AREA : ALLOWABLE; 7,200 SQ. FT. (Table 503)
 PROPOSED; 477 SQ. FT.
 HEIGHT : ALLOWABLE; 30' - 2 STORY
 PROPOSED; 13' - 1 STORY
 MAXIMUM OCCUPANCY LOAD : 20 PERSONS (Estimated Actual)
 MAXIMUM EXIT ACCESS TRAVEL DISTANCE : 200' ALLOWABLE
 32' PROPOSED
 DESIGN LOADS : FLOOR; 100 psf. LIVE plus DEAD LOAD
 ROOF; 20 psf. LIVE LOAD plus DEAD LOAD
 25 psf. MIN. GROUND SNOW LOAD
 WIND; 80 mph wind speed, EXPOSURE "B"
 SOIL BEARING CAPACITY: 2,500 p.s.f. (Class 5 Soils)
 SEISMIC INFORMATION:
 ZONE: 1
 Av = 0.077
 Aa = 0.10
 HAZARD EXPOSURE GROUP = GROUP 1
 PERFORMANCE CATEGORY = B
 SOIL PROFILE TYPE = S4
 BASIC STRUCTURAL SYSTEM = 2
 R = 7 Cd = 4.5
 ANALYSIS PROCEDURE = ELF, (1610.4)

INDEX OF DRAWINGS

- S-1) SITE PLAN & BUILDING DATA
- 1) FLOOR PLAN & EXTERIOR ELEVATIONS
- 2) FOUNDATION PLAN, NOTES & DETAILS
- 3) ARCH & CROSS SECTION DETAILS
- E-1) ELECTRICAL PLAN

NOTE: 1) THIS BUILDING WILL NOT BE MECHANICALLY COOLED OR HEATED.
 2) RESTROOMS FOR THE OCCUPANTS ARE AVAILABLE IN AN ADJACENT BUILDING UNDER THE SAME OWNERSHIP & CONTROL

901 HENRY COUNTY FAIR BOARD		
S. PERRY STREET		NAPOLEON, OHIO
DIRECTORY: C:\ND\HENRYCO	FILE NAME: DAIRYUNIT.DWG	REVISED: MAR. 2000
DRAWN BY: R.D.S. ~ dba: NEW DIMENSIONS		
PROPOSED MILK SHAKE STAND		SCALE: 1"=40'
SITE PLAN & BUILDING DATA		DATE: FEB. 2000
		DRAWING NUMBER: S - 1