

GENERAL NOTES:

1. EXISTING CONDITIONS PROVIDED BY TENNECO PLANT REPRESENTATIVE. CONTRACTOR SHALL VERIFY ALL DIMENSIONS AND ELEVATIONS. CONTRACTOR SHALL VISIT THE SITE, AND FAMILIARIZE HIMSELF WITH THE ACTUAL CONDITIONS AND VERIFY EXISTING CONDITIONS IN THE FIELD PRIOR TO BID.
2. THE CONTRACTOR SHALL REPAIR OR REPLACE ANY FACILITY DAMAGED BY OPERATIONS TO THE SATISFACTION OF TENNECO. CONTRACTOR SHALL PROVIDE TEMPORARY SHORING AND BRACING AS REQUIRED.
3. ALL PIPING AND EQUIPMENT ARRANGEMENTS AND LOCATIONS SHALL BE PROPERLY REFERENCED AND RECORDED ON THE PROJECT "RECORD" DRAWINGS.
4. THE CONTRACTOR SHALL BE RESPONSIBLE FOR MAINTAINING A MARKED-UP SET OF DESIGN DRAWINGS SHOWING "AS-BUILT" CONDITIONS. THESE "RECORD DRAWINGS" SHALL BE MADE AVAILABLE TO THE DESIGNER AND/OR THE COUNTY INSPECTOR UPON REQUEST. THE MARKUPS SHALL BE AT THE SITE AT ALL TIMES AND SHALL BE UTILIZED TO DEVELOP FINAL RECORD DRAWINGS.


LEGEND

- ST—ST—ST— ROOF & STORM DRAIN
- S—S—S— SANITARY
- W—W—W— INDUSTRIAL WASTE
- X—X—X— FENCE
- — — — — EXISTING




1400 E. River Road

WASTEWATER TREATMENT PLANT EXISTING CONDITIONS	TENNECO CLEVE ELASTOMERS NAPOLEON, OHIO PARSONS ENGINEERING SCIENCE, INC. Atlanta, Georgia (770) 446-4900	Issue Certification NOT FOR BIDDING OR CONSTRUCTION
Job No. 735191 Designed _____ Drawn _____ Checked _____ Reviewed _____ Approved _____ Reg. No. _____		

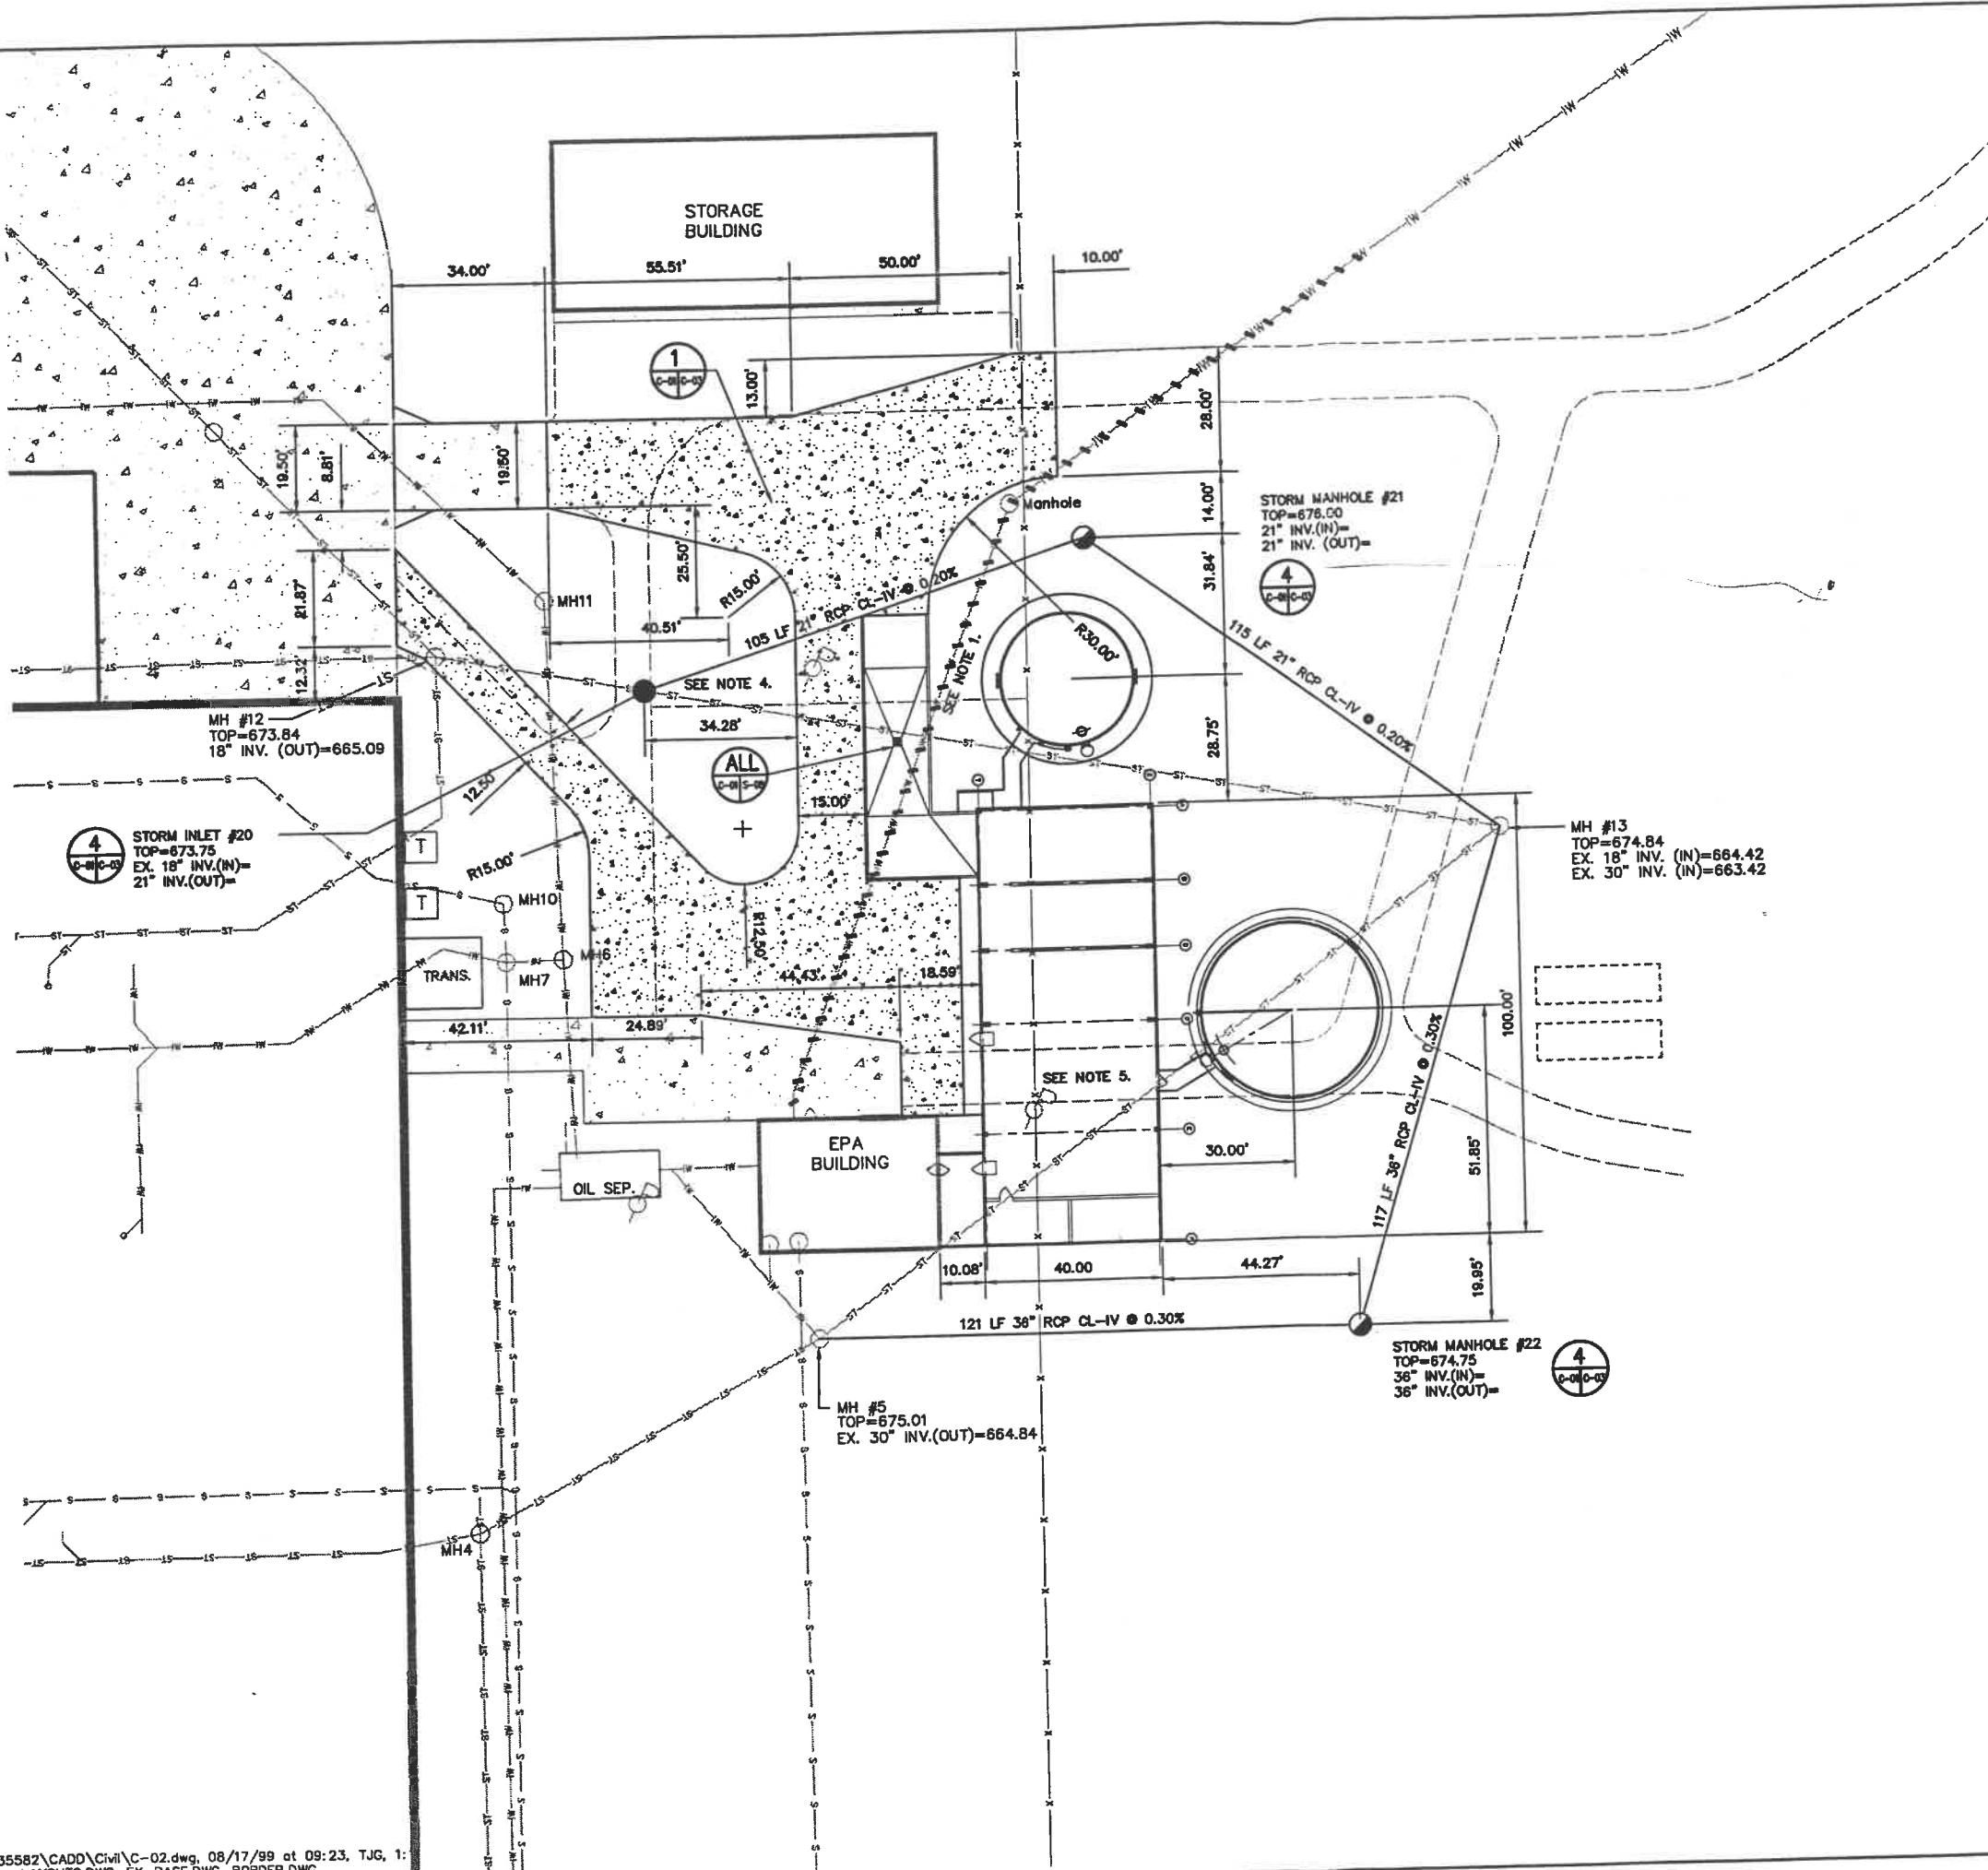

- GENERAL NOTES:**
- EXISTING INDUSTRIAL WASTE LINE AND MANHOLE TO POND #1 IS TO REMAIN IN SERVICE UNTIL THE NEW TREATMENT PLANT HAS STARTED-UP AND HAD BEEN TESTED AND APPROVED BY THE OWNER.
 - CONTRACTOR SHALL PROVIDE WATER, GAS AND ELECTRICAL SERVICE AS DIRECTED BY TENNECO REPRESENTATIVE.
 - EXISTING UTILITY INFORMATION PROVIDED BY TENNECO. IT HAS BEEN ASSUMED THAT THE EXISTING STORM SEWERS HAD BEEN DESIGNED TO FLOW FULL. NEW STORM LINES SHALL MET OR EXCEED THIS CAPACITY. THE CONDITIONS OF THE STORM OUTLET HAS NOT BEEN VERIFIED. IT MAY BECOME NECESSARY TO UPGRADE THE STORM OUTLET DEPENDING ON EXISTING CONDITIONS.
 - EXISTING POWER POLE TO BE PERMANENTLY RELOCATED AS DIRECTED BY A TENNECO REPRESENTATIVE.
 - EXISTING POWER POLE TO BE TEMPORARILY RELOCATED AS DIRECTED BY A TENNECO REPRESENTATIVE.

Job No. 736191		Designed	Drawn	Checked	Reviewed	Approved	Reg. No.	Date	
Issue Certification		NOT FOR BIDDING OR CONSTRUCTION						Rev	Date
TENNECO		TENNECO CLEVITE ELASTOMERS NAPOLEON, OHIO						By	
TENNECO		PARSONS ENGINEERING SCIENCE, INC. Atlanta, Georgia						Date	
WASTEWATER TREATMENT PLANT		SITE PLAN						DRAWING NO. C-02	
								REV. A	

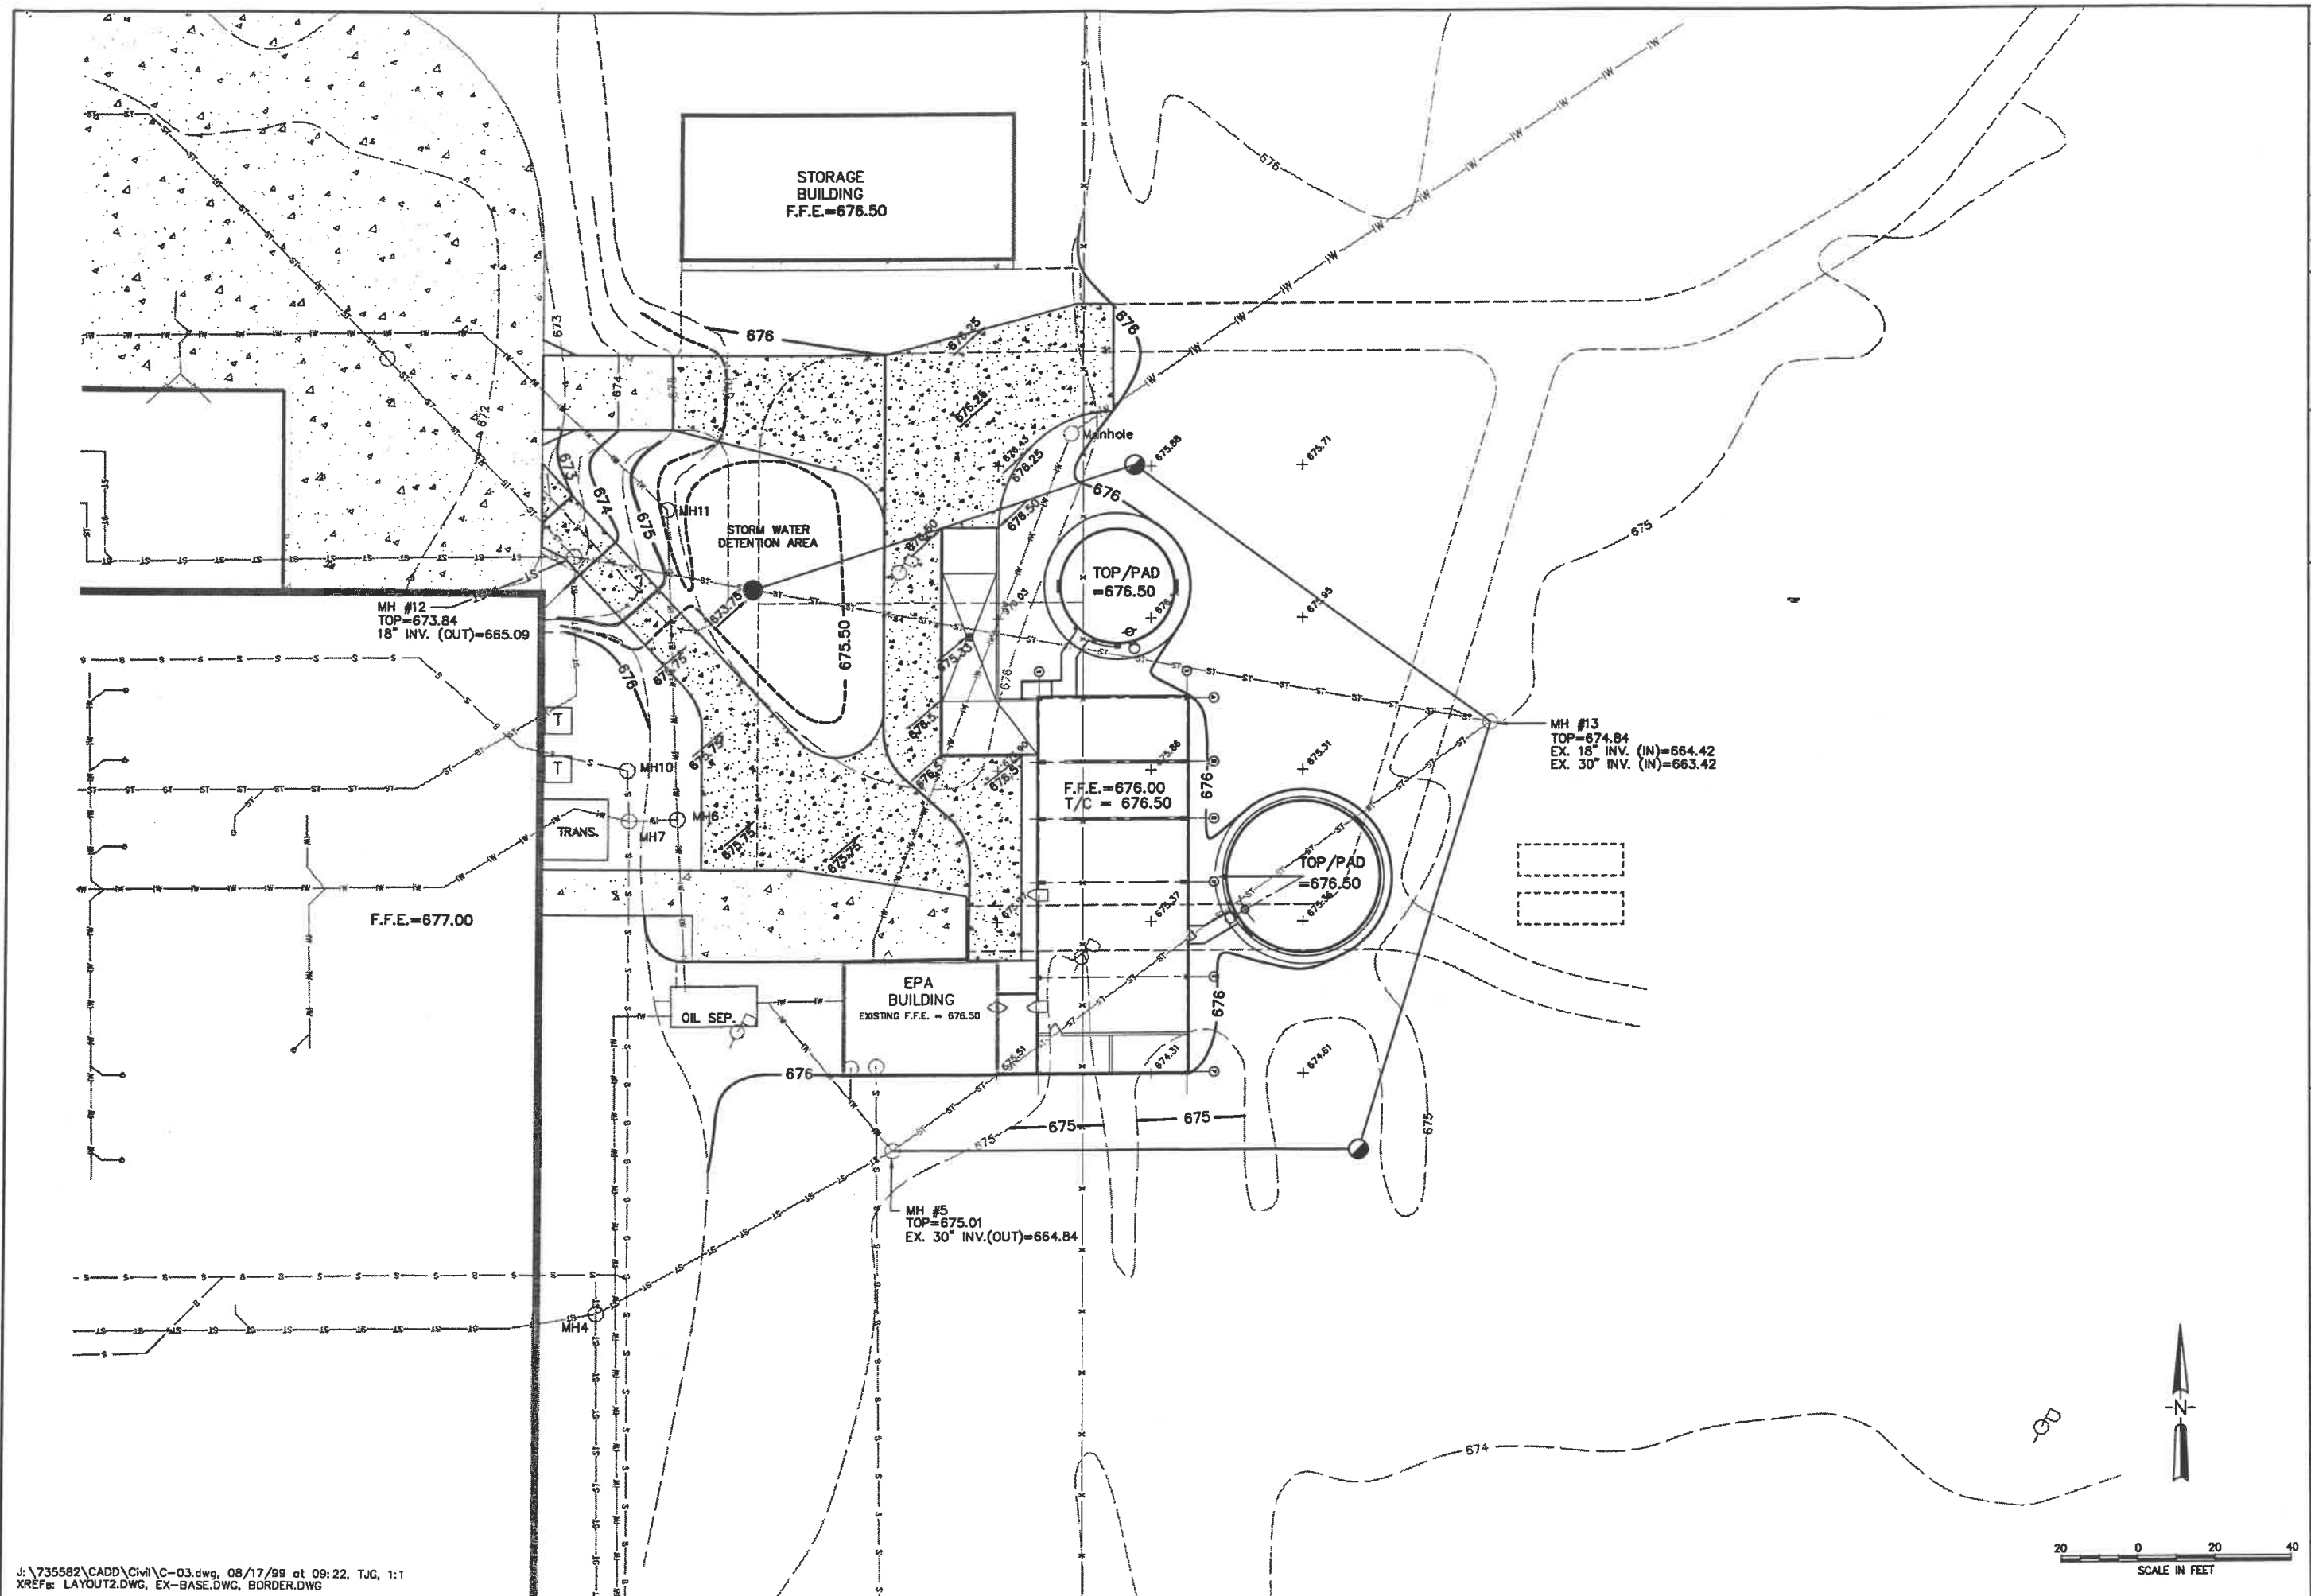

J:\735582\CADD\Civil\C-03.dwg, 08/17/99 at 09:22, T.J.G, 1:1
XREFs: LAYOUT2.DWG, EX-BASE.DWG, BORDER.DWG

<p>Job No. 735191</p> <p>Designed _____</p> <p>Drawn _____</p> <p>Checked _____</p> <p>Reviewed _____</p> <p>Approved _____</p> <p>Reg. No. _____</p> <p>Date _____</p>		<p>Rev</p> <p>Date</p> <p>Description</p>
<p>Issue Certification</p> <p>NOT FOR BIDDING OR CONSTRUCTION</p>		
<p>TENNECO</p> <p>TENNECO CLEVITE ELASTOMERS</p> <p>NAPOLEON, OHIO</p>		<p>PARSONS ENGINEERING SCIENCE, INC.</p> <p>Atlanta, Georgia</p> <p>(770) 446-4900</p>
<p>WASTEWATER TREATMENT PLANT</p> <p>GRADING, DRAINAGE AND EROSION CONTROL PLAN</p>		
<p>DRAWING NO.</p> <p>C-03</p>	<p>REV.</p> <p>A</p>	