


INDEX OF SHEETS

1	EXTERIOR ELEVATIONS & TYPICAL SECTION
2	FLOOR PLAN & GENERAL SPECIFICATIONS
3	FOUNDATION PLAN, SECTIONS & MISC. DETAILS
S-1	BUILDING DATA, SITE & LOCATION PLAN
E-1	ELECTRICAL PLAN & NOTES

ATTACHMENTS: MANUFACTURED ROOF TRUSS SPECIFICATION
CITY OF NAPOLEON ZONING PERMIT

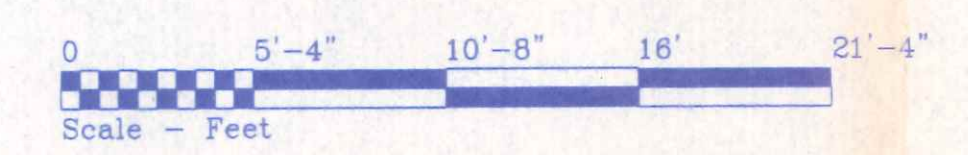

REVISED: 8.18.11; CHANGED HAND & GUARD RAILS PER WOOD COUNTY REVIEW

AZUL TEQUILA MEXICAN RESTAURANT

601 E. Riverview Ave. 419/599-9028 NAPOLEON, OHIO

DIRECTORY: C:\ND\BECK FILE NAME: COMMERCIAL\AZUL TEQUILA_CONST REVISED: 8.18.11

DRAWN BY: R.D.S. ~ dba: NEW DIMENSIONS

SCALE: 3/16" = 1'

DATE: AUGUST 2011

EXTERIOR ELEVATIONS & TYPICAL CROSS SECTION

DRAWING NUMBER: 1 of 3