


LIST OF DRAWINGS	
A-1	SITE PLAN
A-2	FLOOR & ELECTRICAL PLAN
A-3	ELEVATIONS & SECTIONS
S-1	FOUNDATION PLAN & DETAILS

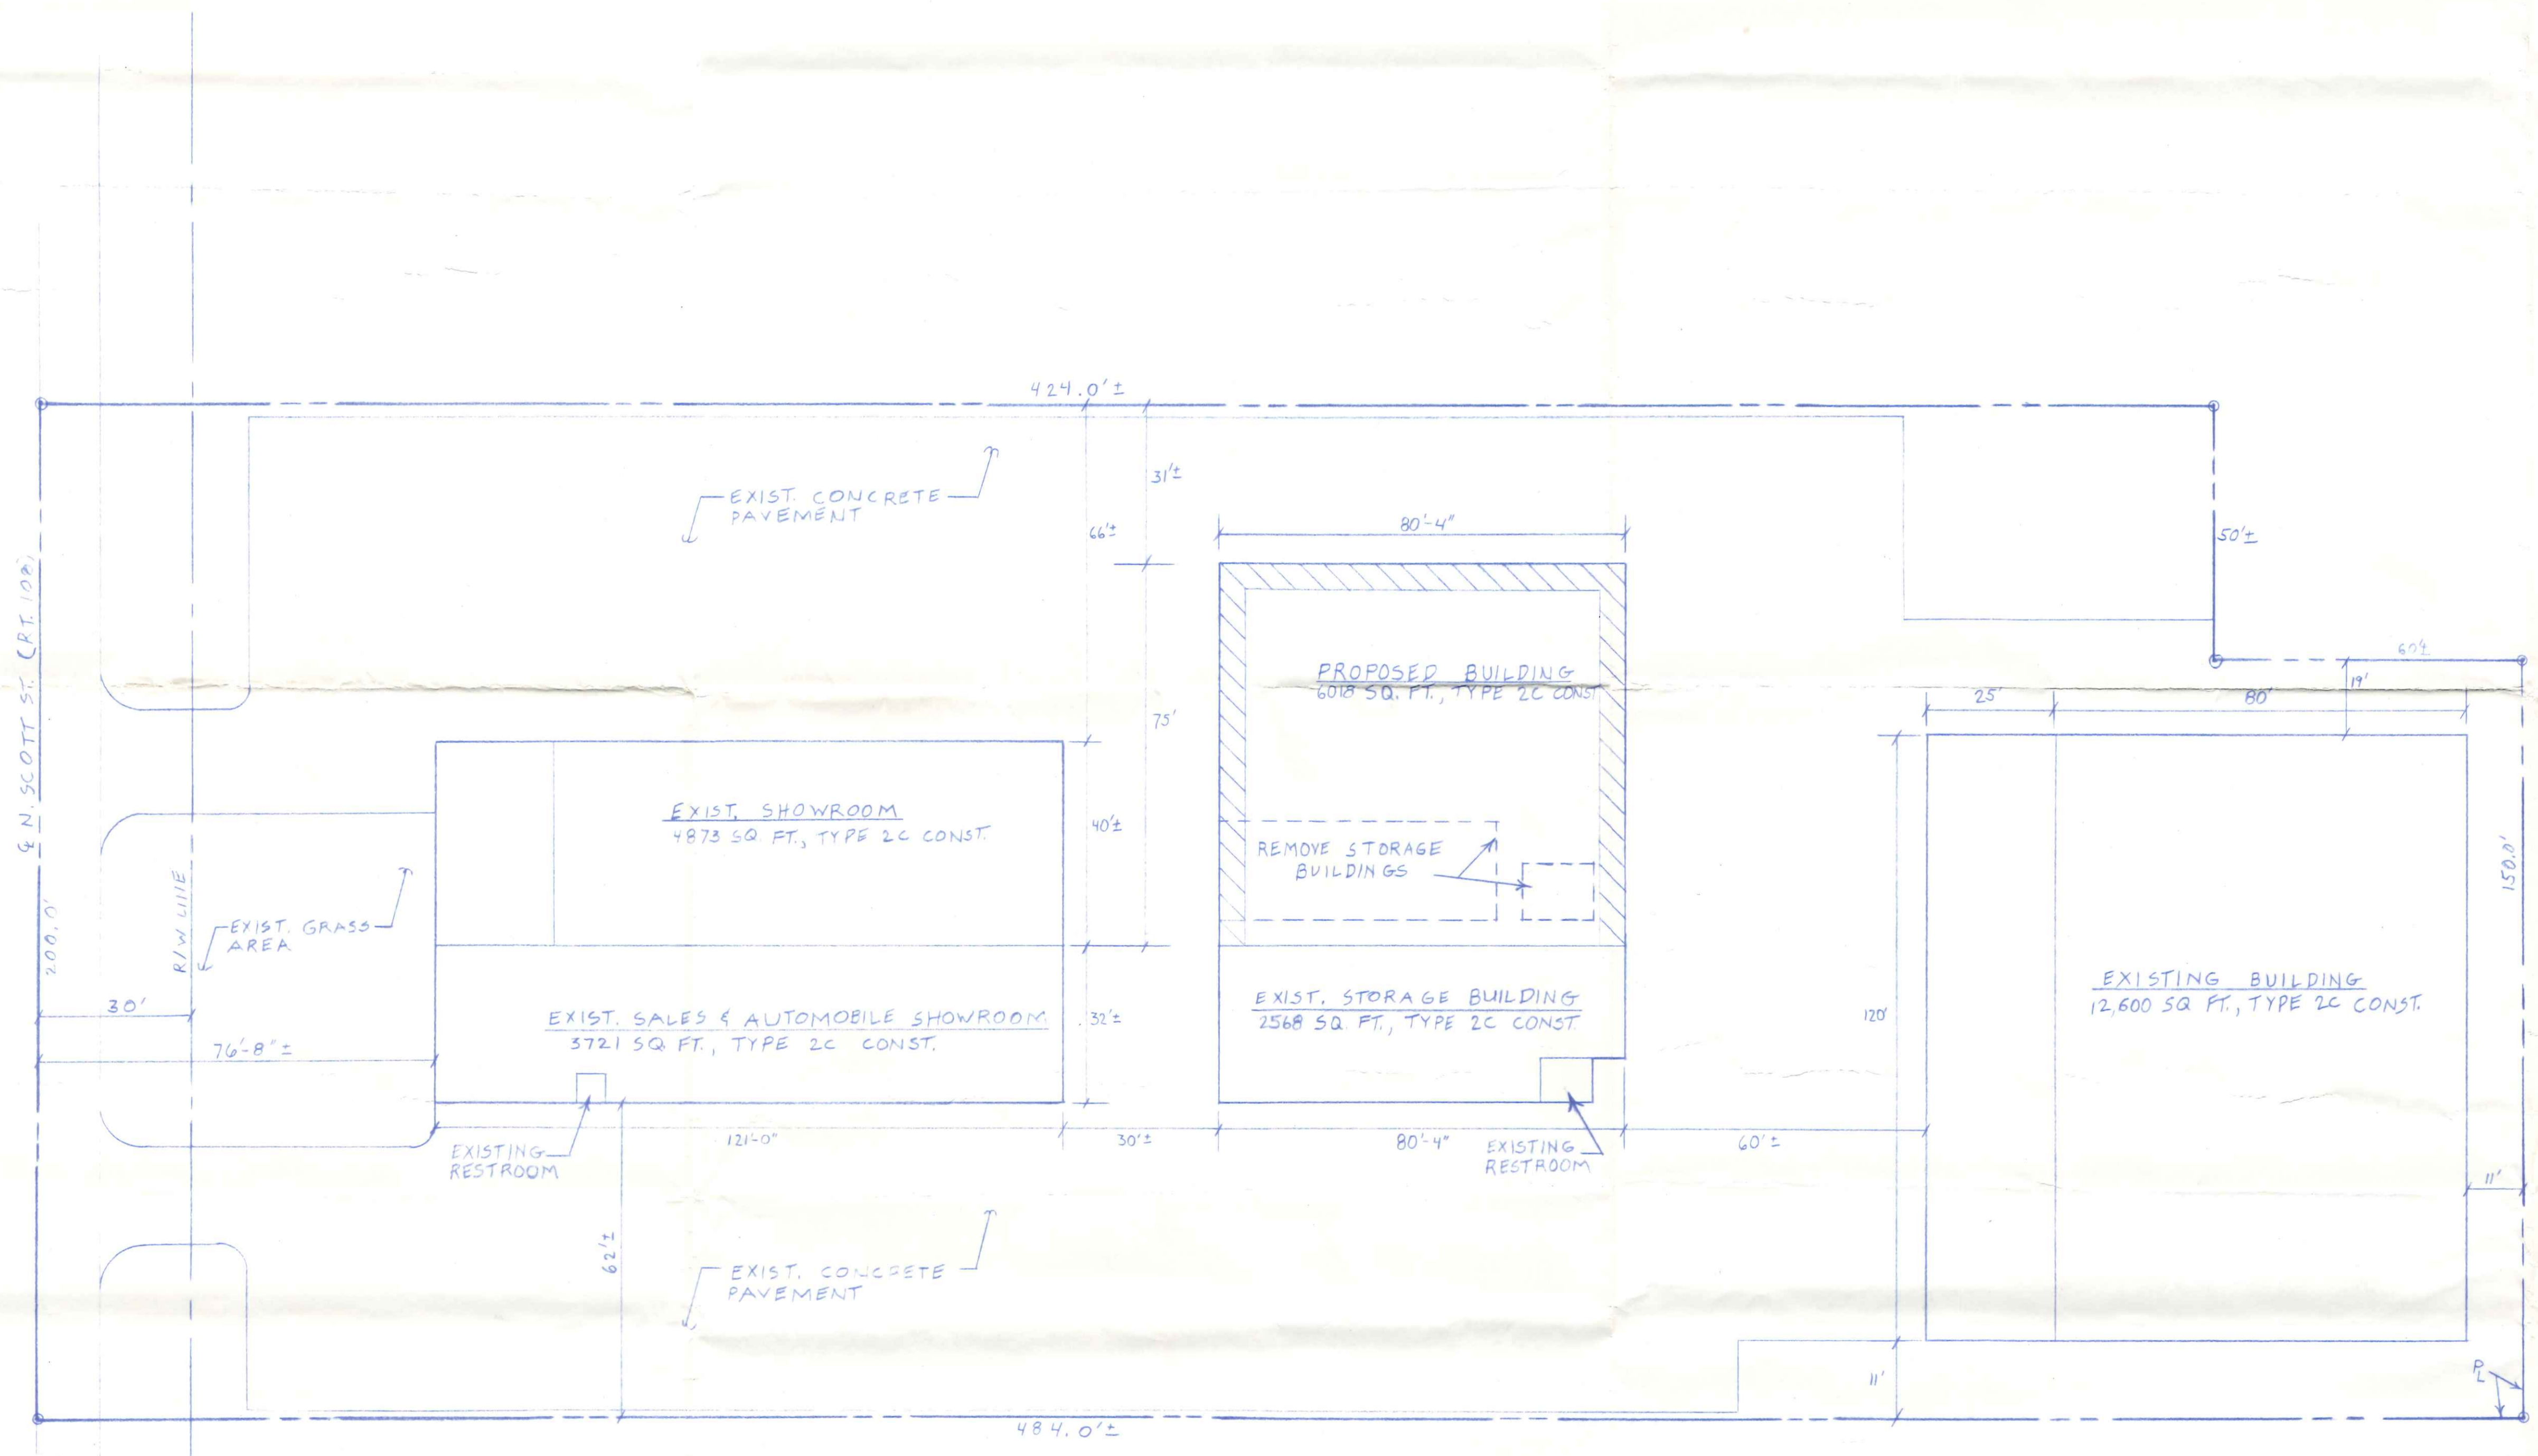

SITE PLAN  
SCALE: 1" = 20'-0"



SITE PLAN		
SCALE: AS NOTED	APPROVED BY:	DRAWN BY: R.S.K.
DATE: 3-2-92		REVISED:
TRIPLE M ENTERPRISES 1410 N. Scott St. NAPOLEON, OH		
	DRAWING NUMBER	A-1