


# PROPOSED WAREHOUSE BUILDING FOR FOSTER CANNING, INC.

## NAPOLEON, OHIO

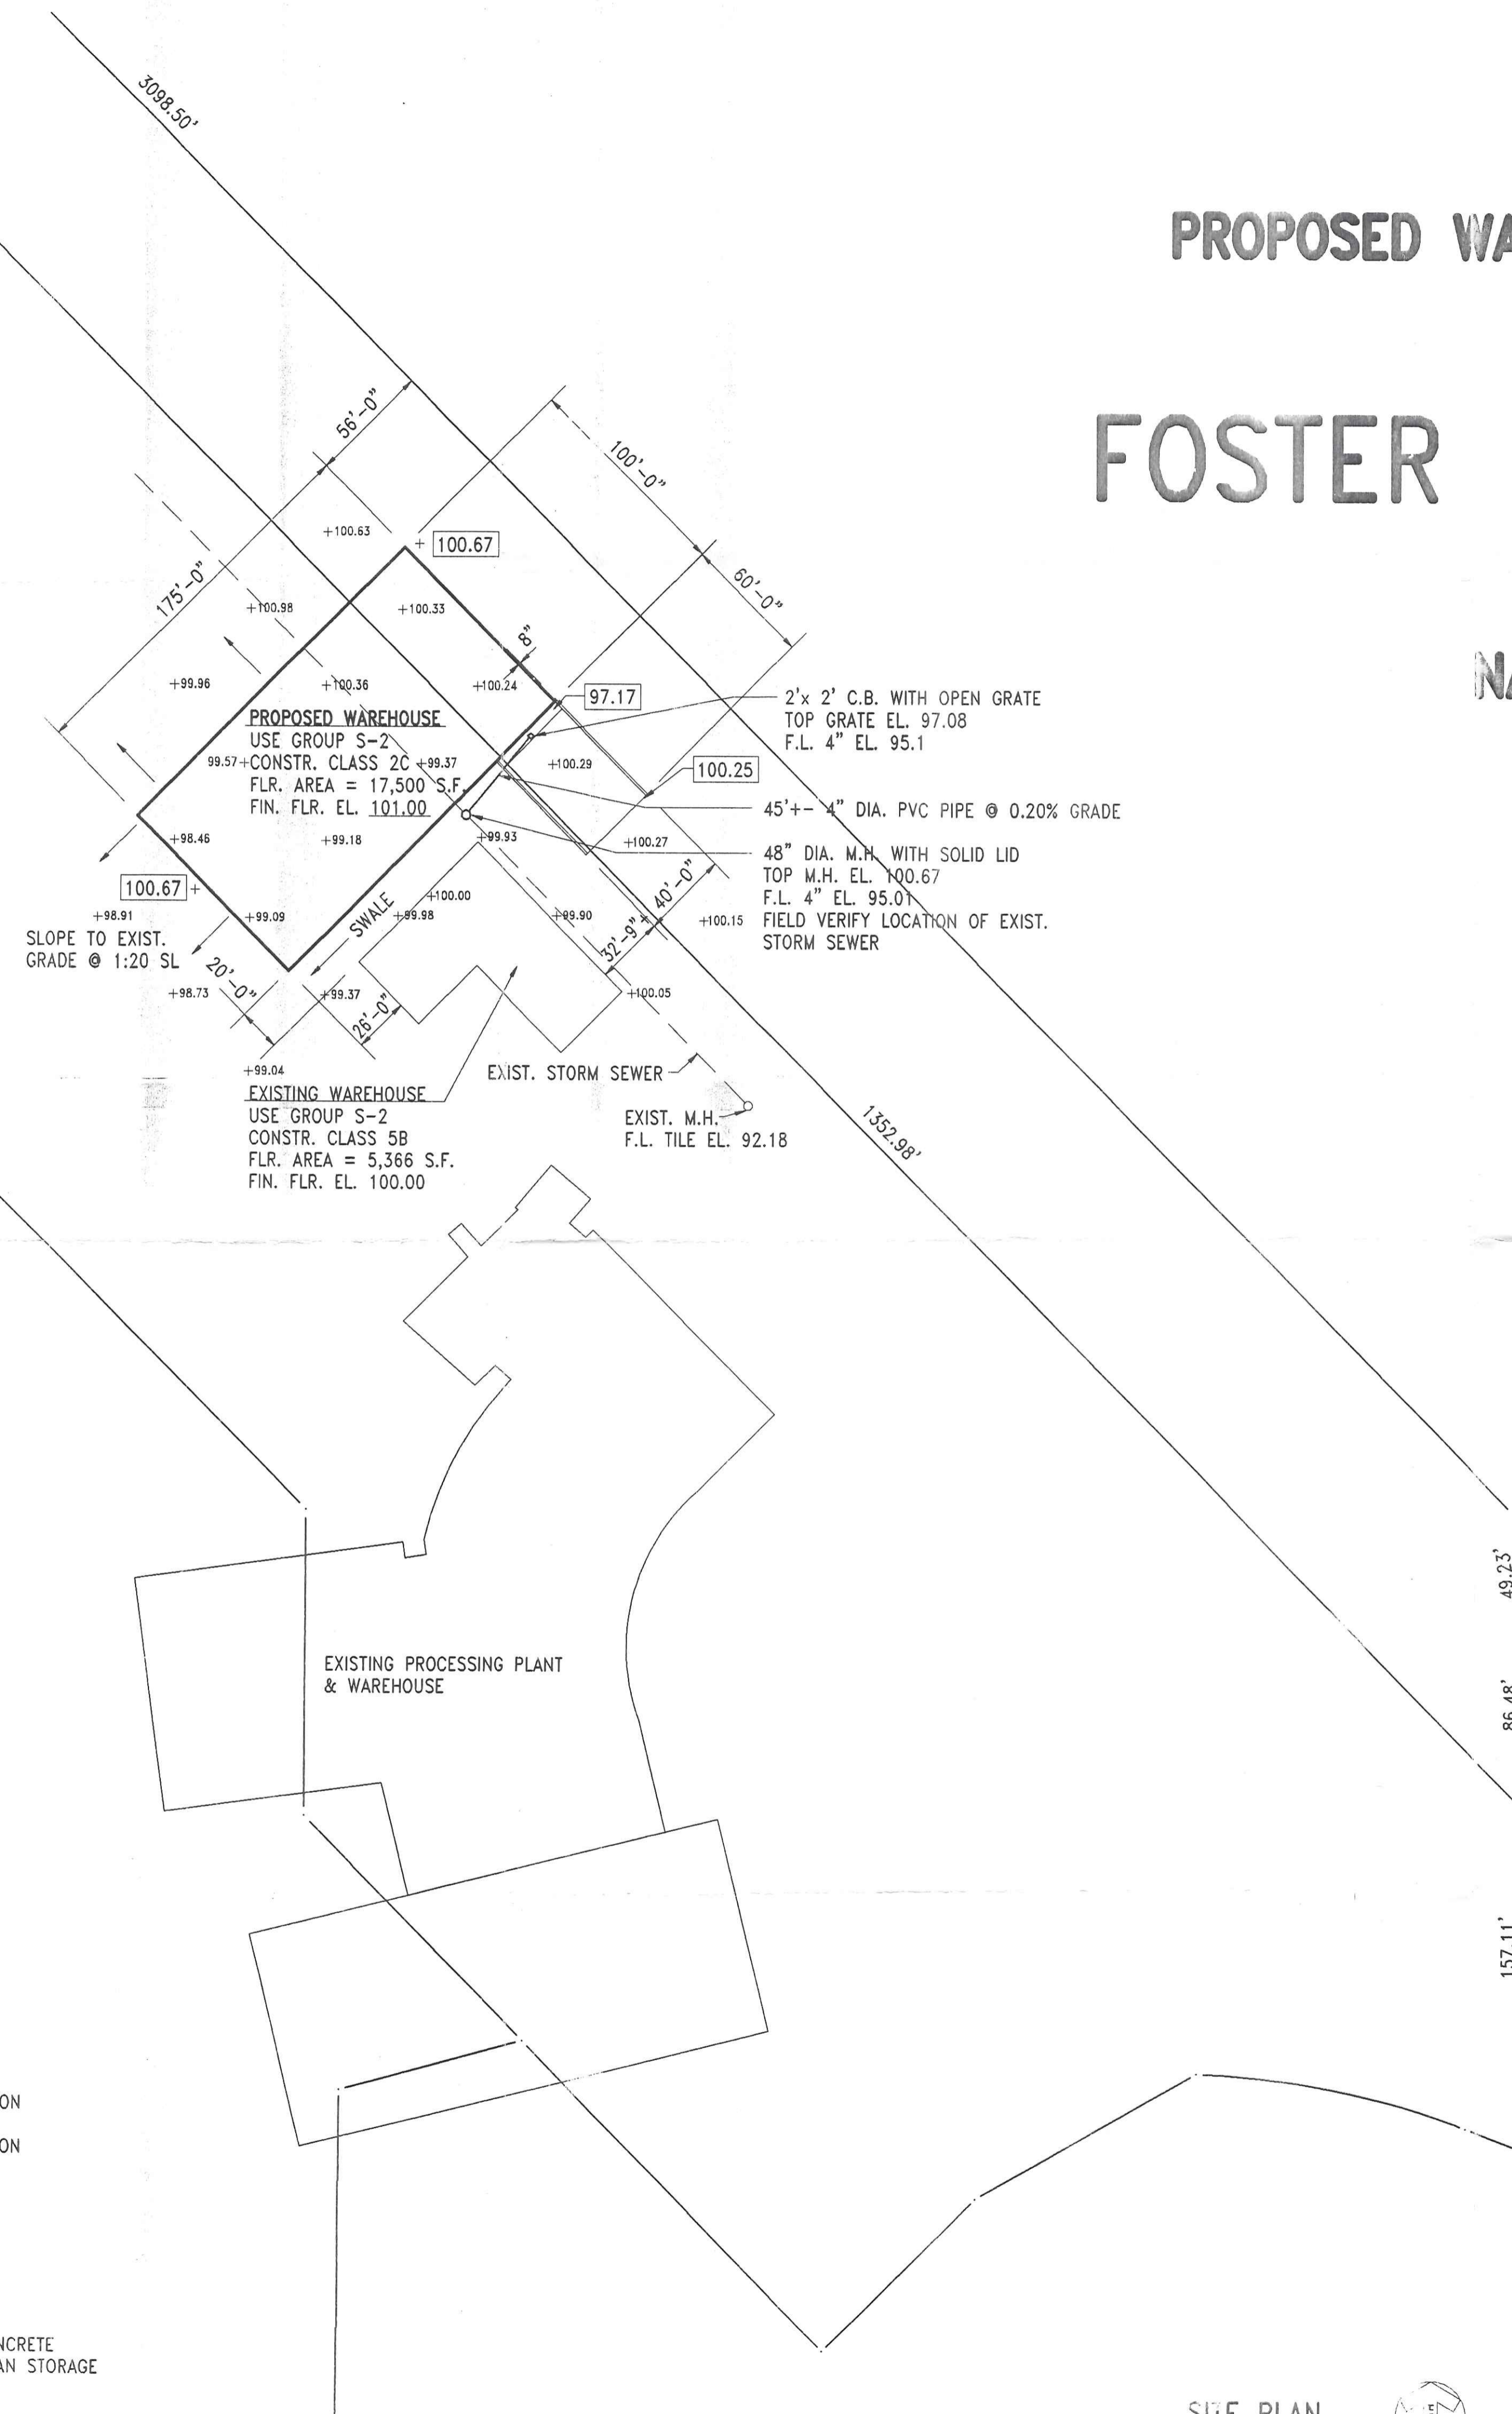

### LIST OF DRAWINGS


- A-1 SITE PLAN
- A-2 FLOOR PLAN & DOOR SCHEDULE
- A-3 BUILDING ELEVATIONS
- A-4 BUILDING SECTION & ELEVATION
- S-1 FOUNDATION PLAN & DETAILS
- S-2 FOUNDATION DETAILS
- M-1 HEATING & VENTILATION PLAN
- E-1 ELECTRICAL PLAN

PLANS PREPARED BY  
 RICHARD F. BERTZ P.E.  
 NAPOLEON, OHIO

**LEGEND**  
 +100.33 EXISTING GROUND ELEVATION  
 + 100.67 PROPOSED GRADE ELEVATION

**BENCHMARK DESCRIPTION**  
 + CHISELED AT SOUTHEAST CORNER CONCRETE APRON LOCATED ON WEST SIDE EXIST. CAN STORAGE BUILDING ELEV. 100.00

SITE PLAN  
 SCALE: 1"=50'

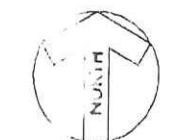

BEAUT City of  
 NAPOLEON



DRAWN: JEFF	A-1
DATE: 19SEPT98	
REVISED:	
SHEET NO.	