




SOUTH ELEVATION
SCALE 1/8" = 1'-0"

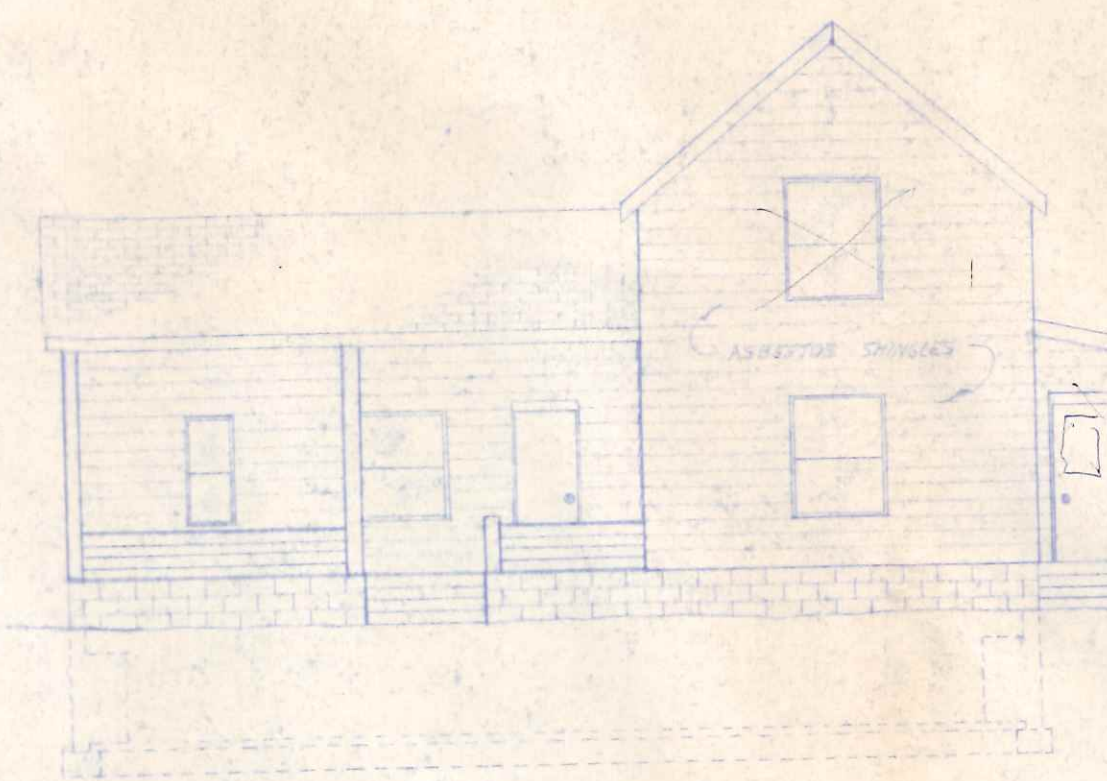


EAST ELEVATION
SCALE 1/8" = 1'-0"

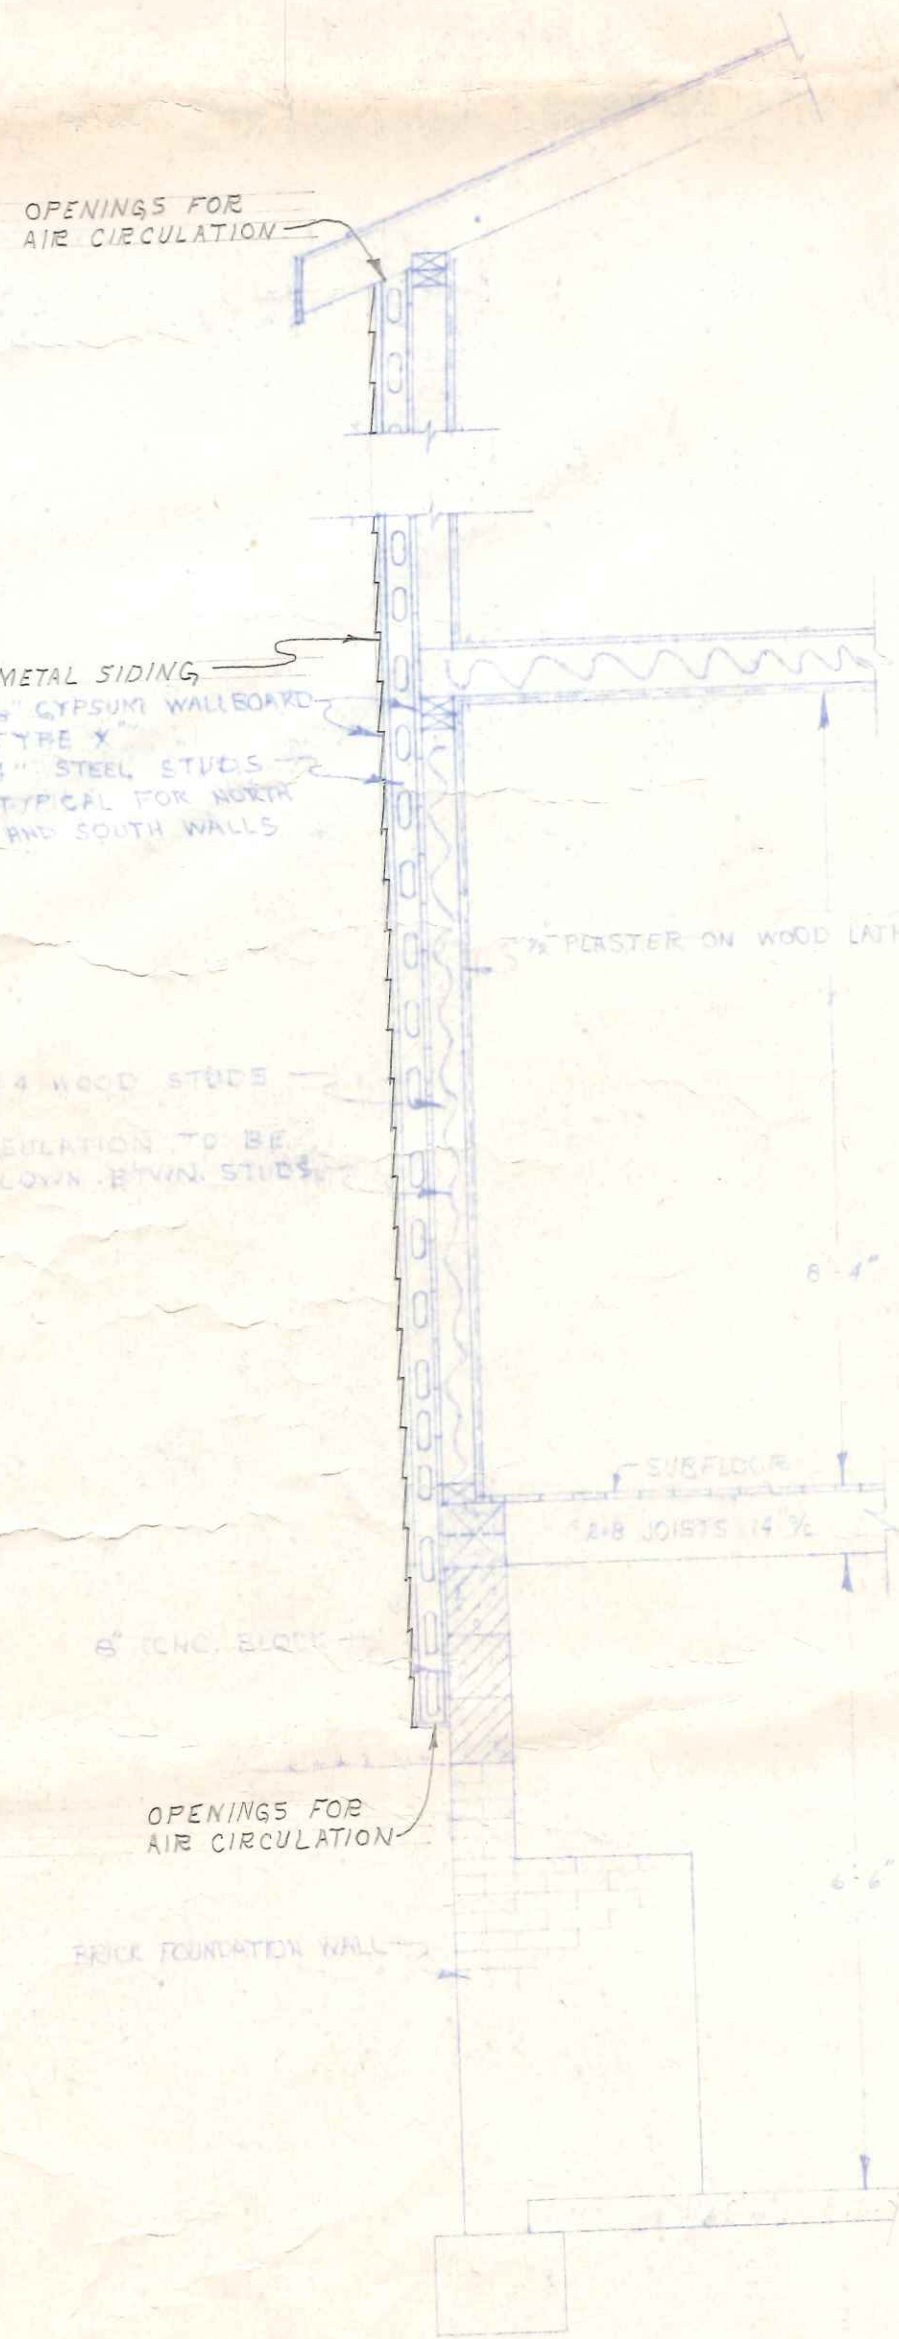

WALL DETAIL
SCALE 1/4" = 1'-0"

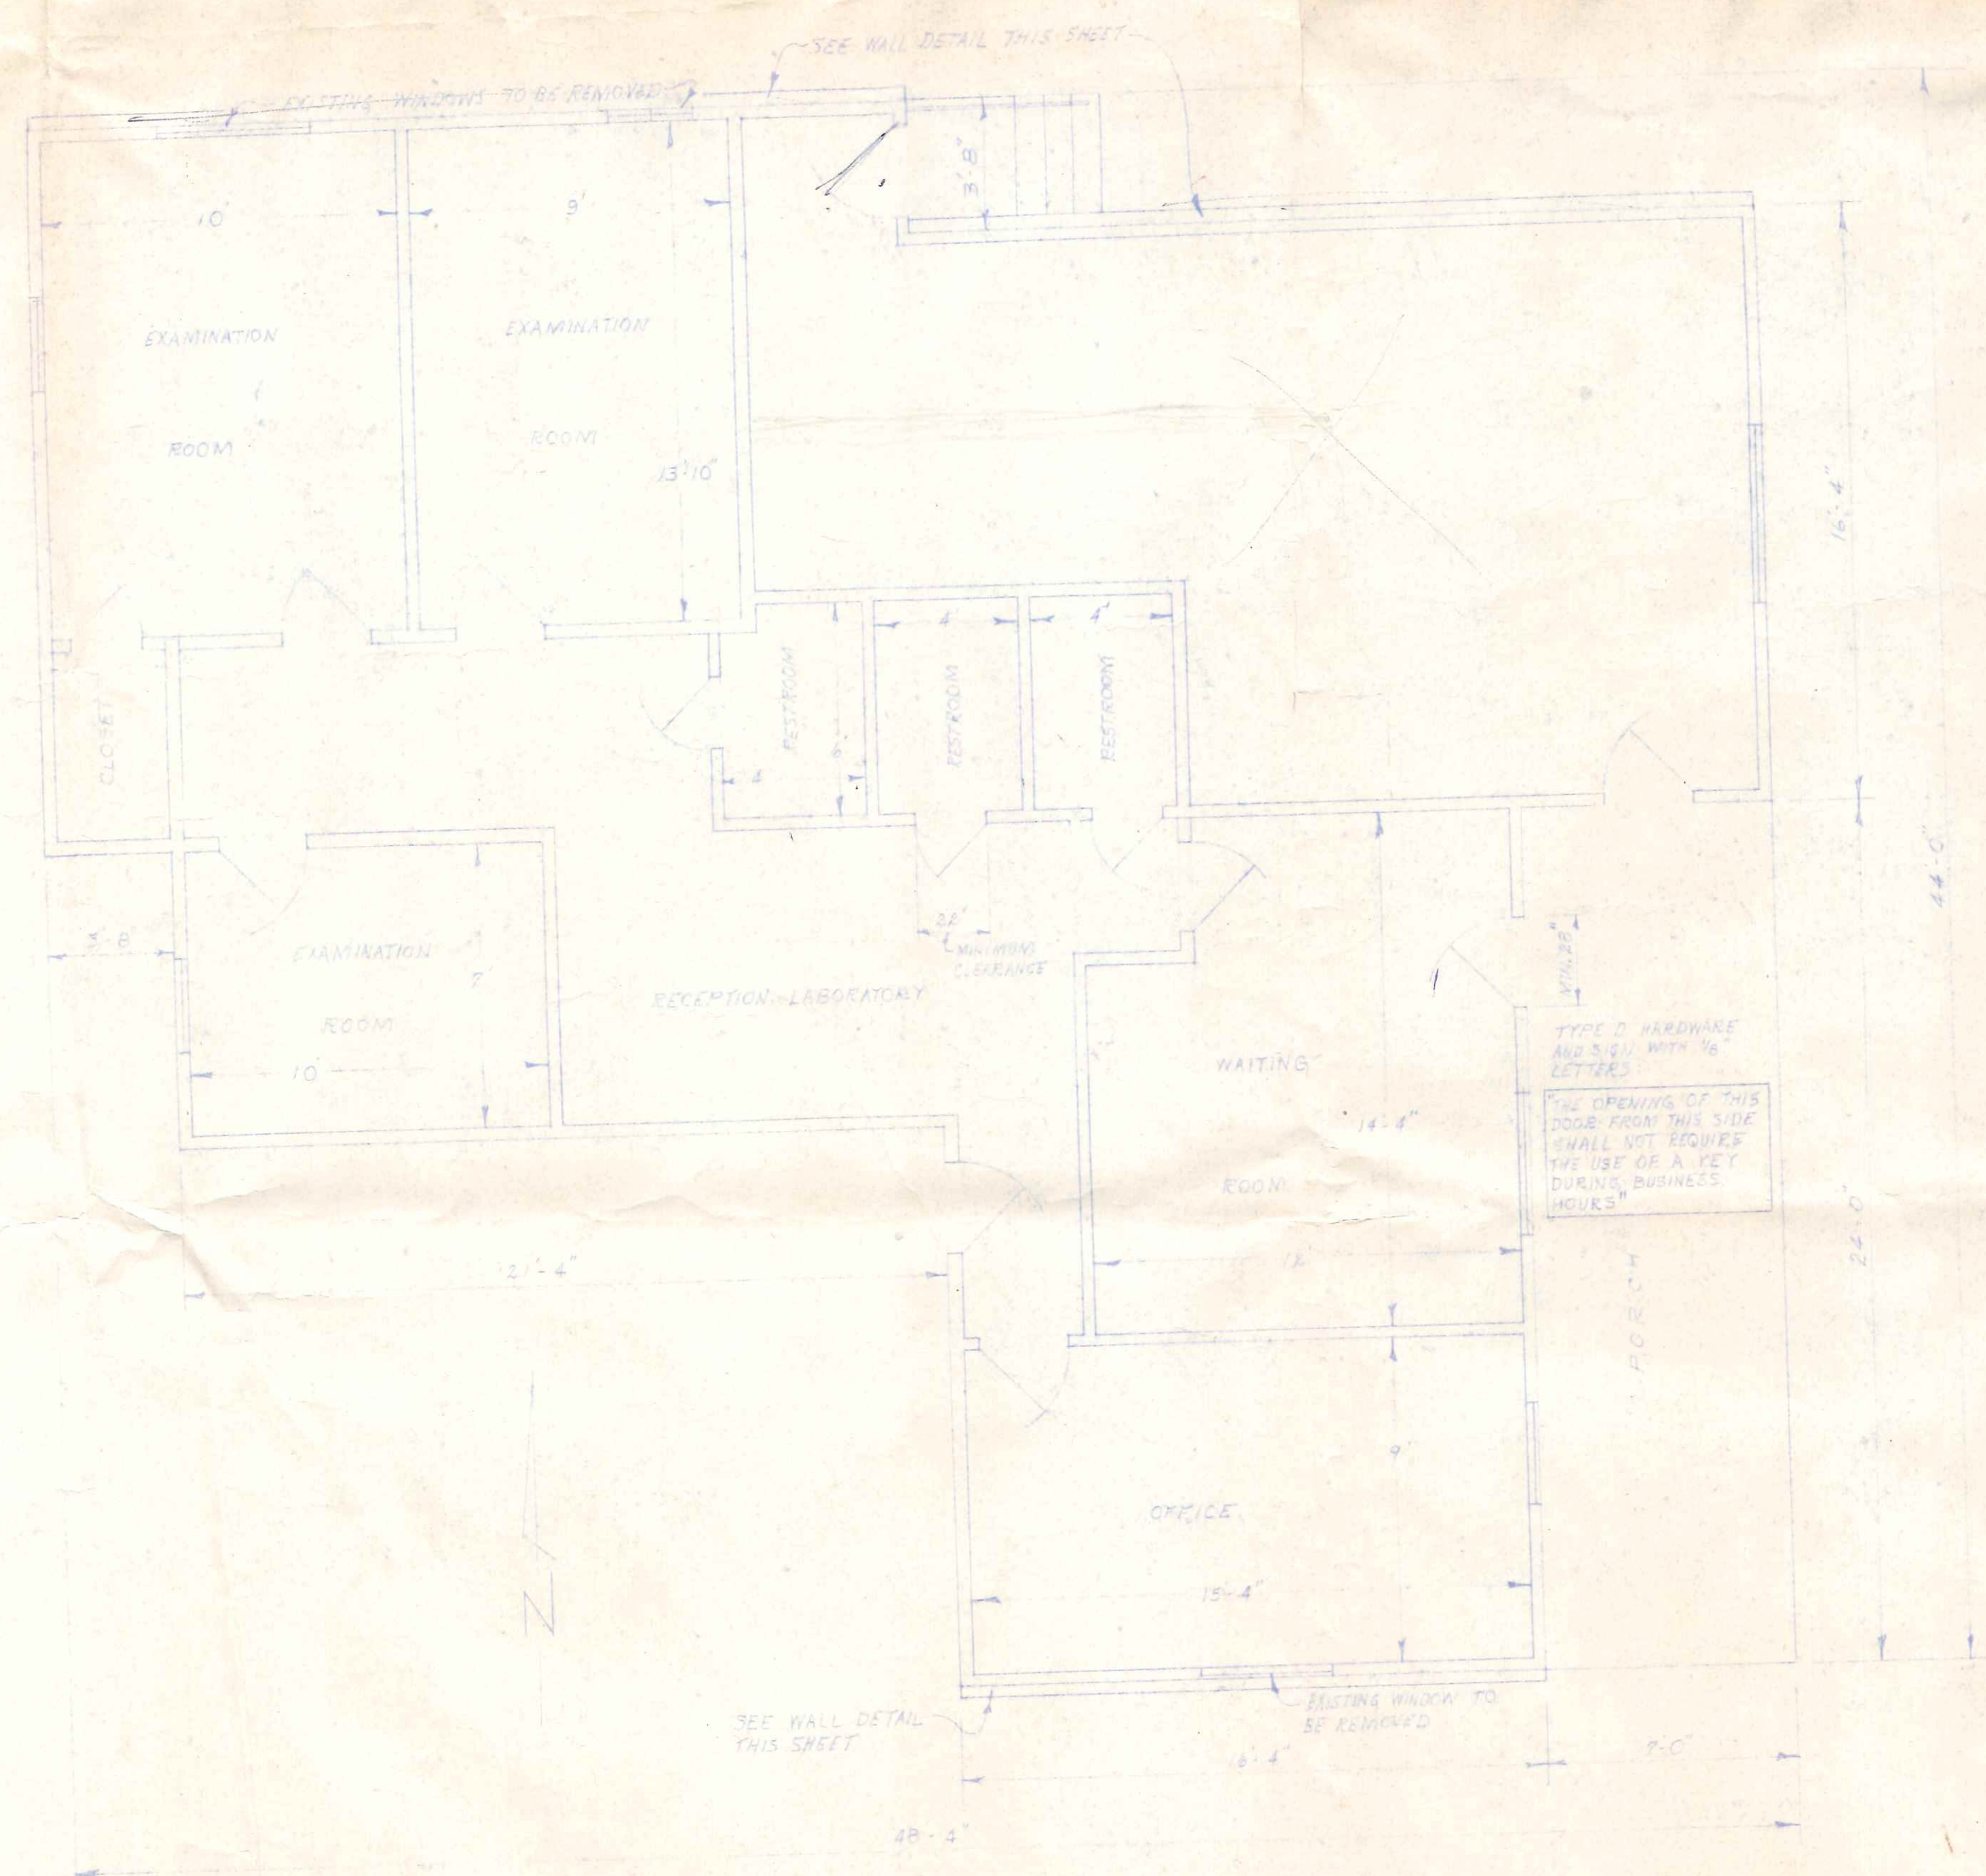

FLOOR PLAN
SCALE 1/4" = 1'-0"

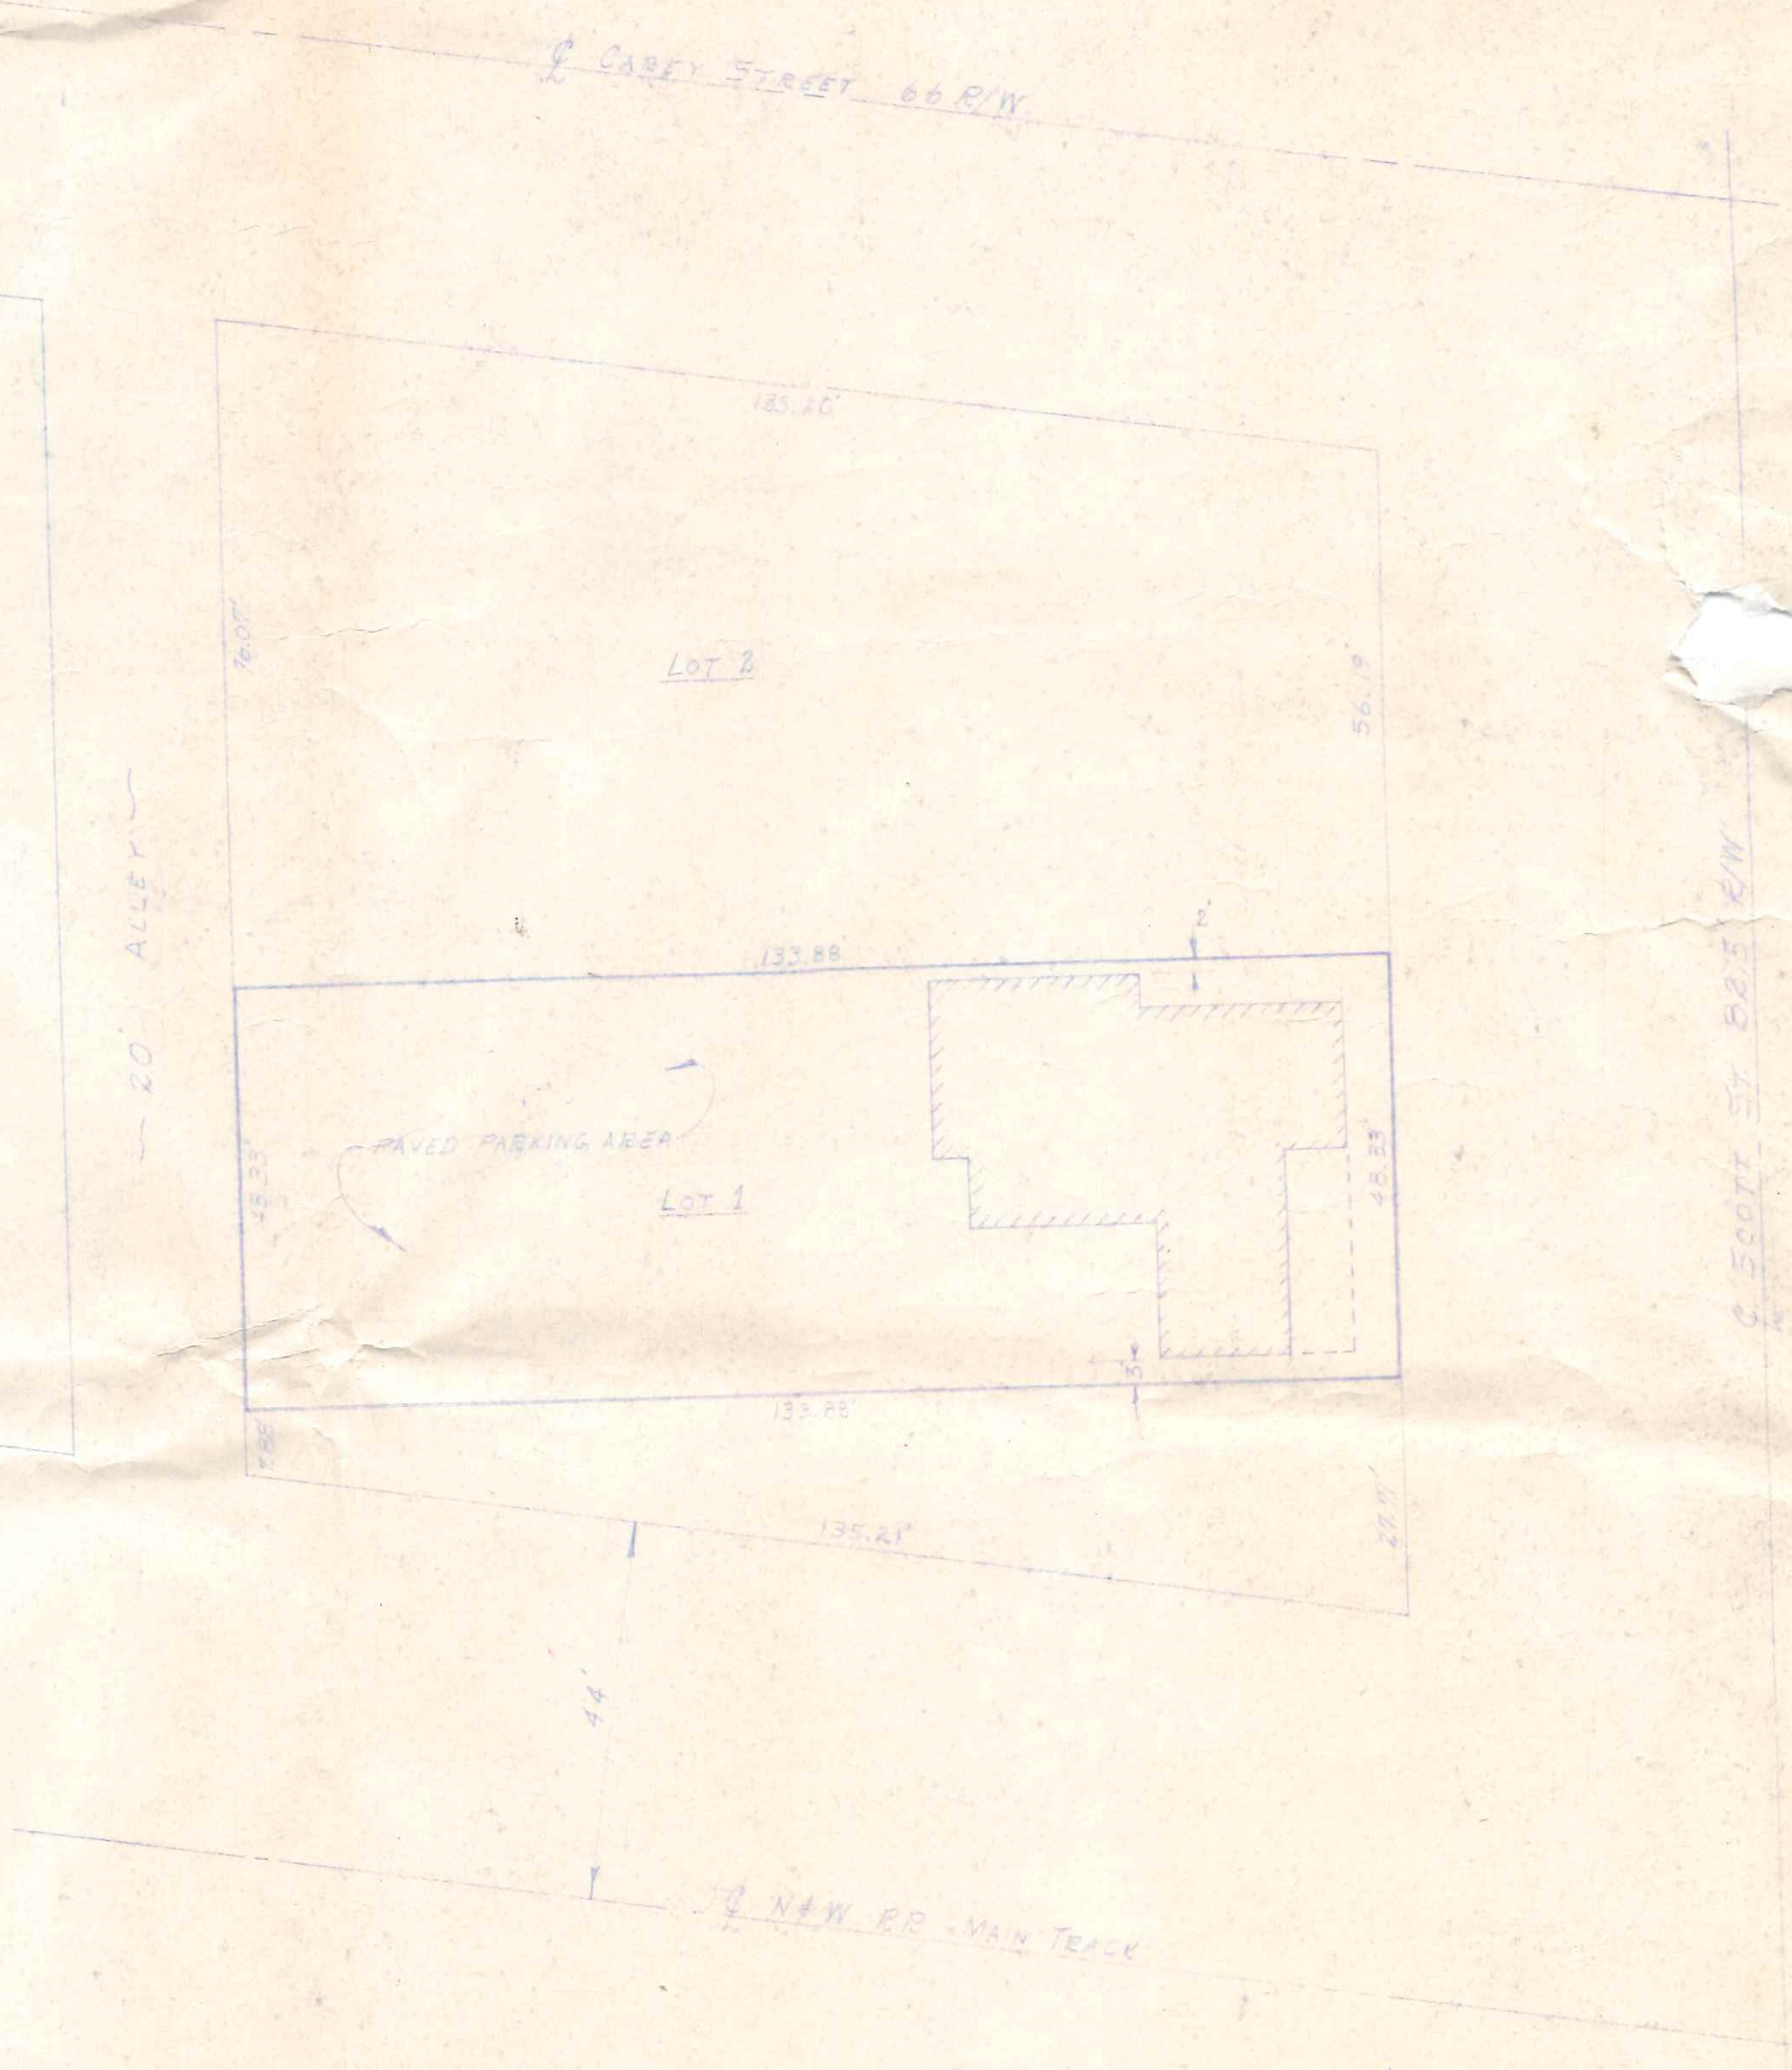

PLOT PLAN
SCALE 1/4" = 1'-0"


LOT'S IN MARY DODD'S FIRST ADD., NAPOLEON, OHIO

NOTE
ALL ELECTRICAL WIRING SHALL BE INSTALLED IN ACCORDANCE WITH THE NATIONAL FIRE PROTECTION ASSOCIATION BULLETIN NO. 13, NATIONAL ELECTRICAL CODE AND THE OHIO BUILDING CODE.

PREPARED BY:
FLOYD G. BROWNE AND ASSOCIATES, LIMITED
NAPOLEON, OHIO
DRAWN BY: R.W.W.

OWNER:
LUTHER GERKEN
23 LAKE VIEW DRIVE
NAPOLEON, OHIO

925
South St.

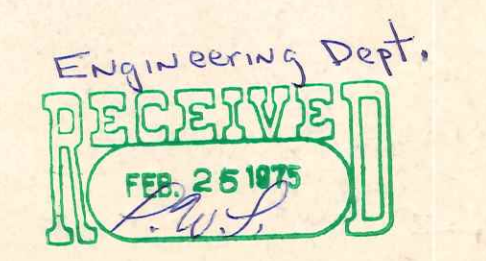


NEW 125A 290V 1 PHASE
ENTRANCE SERVICE
3 # 2 THW COPPER
1/4" RIGID CONDUIT


1/2" ENT CONDUIT

#4 STRANDED COPPER GROUND WIRE

3/8" x 8' ADDED WELD GROUND ROD

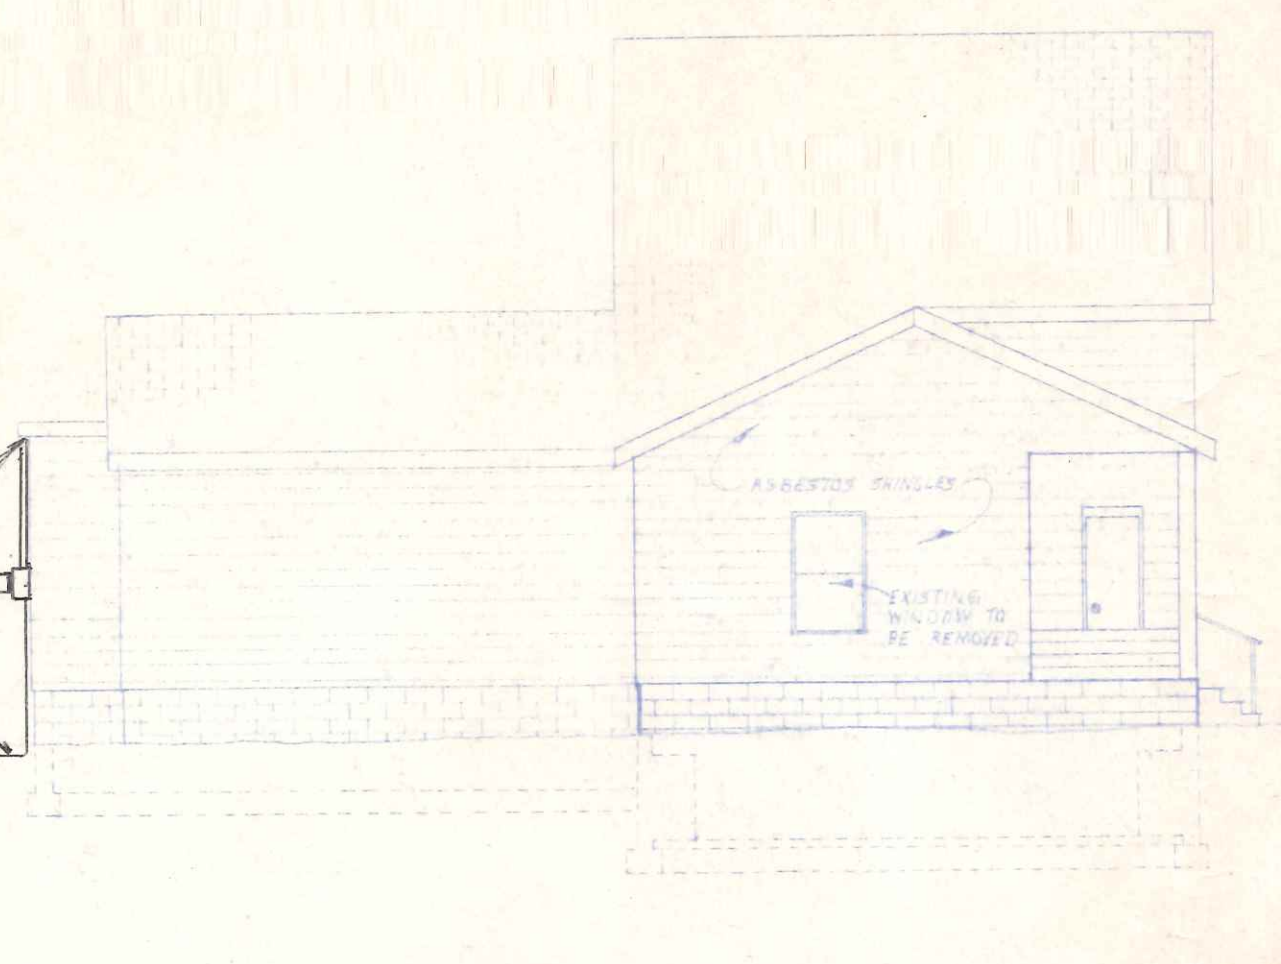


SOUTH ELEVATION
SCALE 1/4" = 1'-0"

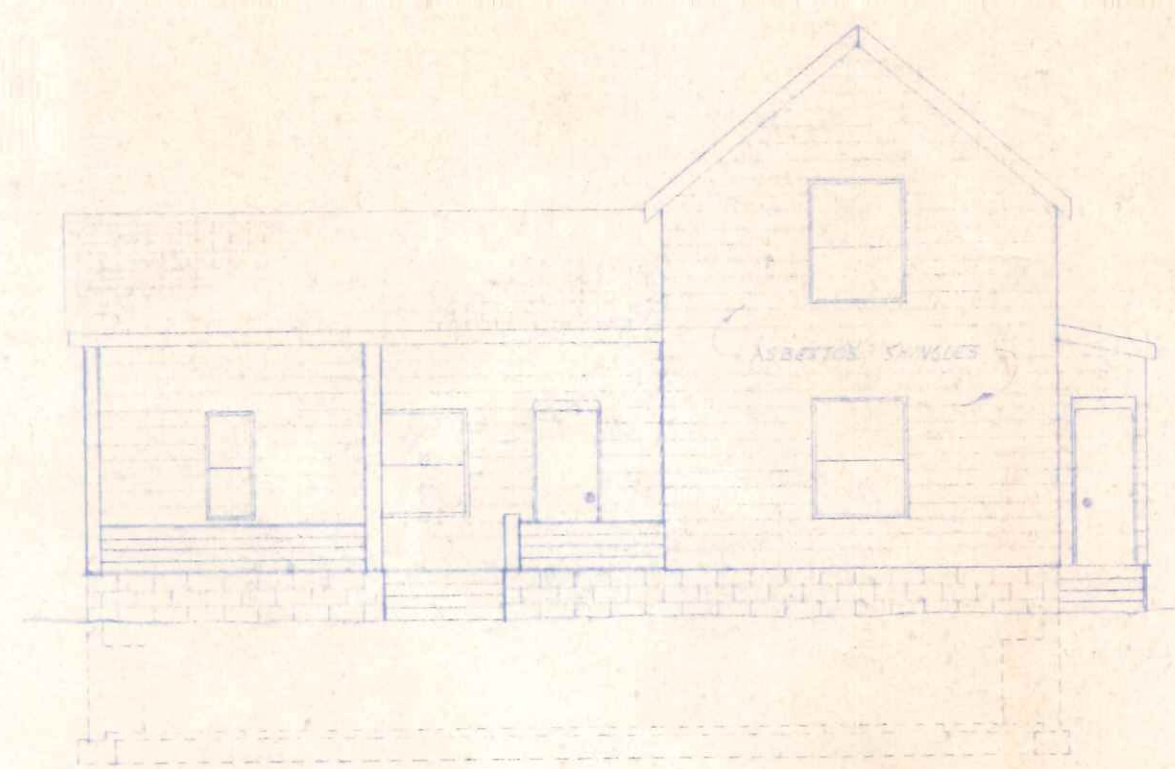


EAST ELEVATION
SCALE 1/4" = 1'-0"

JIM SPEISER ELECTRIC
R. R. 2 BOX 201
PH. 599-1846 NAPOLEON, OHIO 43545

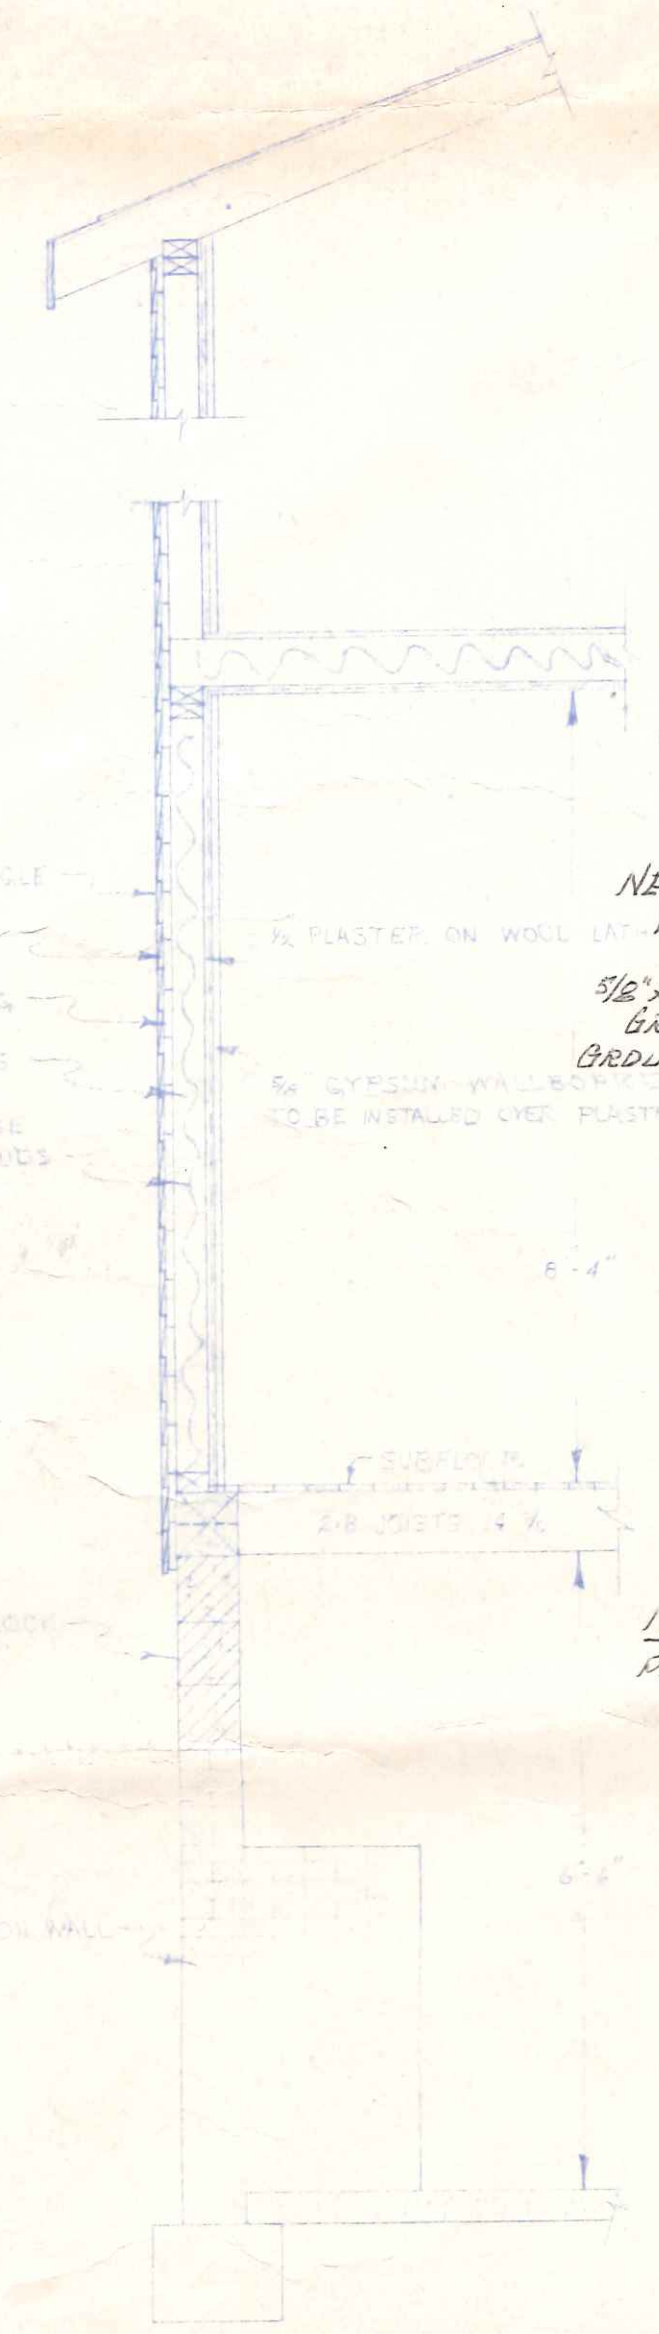


WALL DETAIL
SCALE 1/2" = 1'-0"

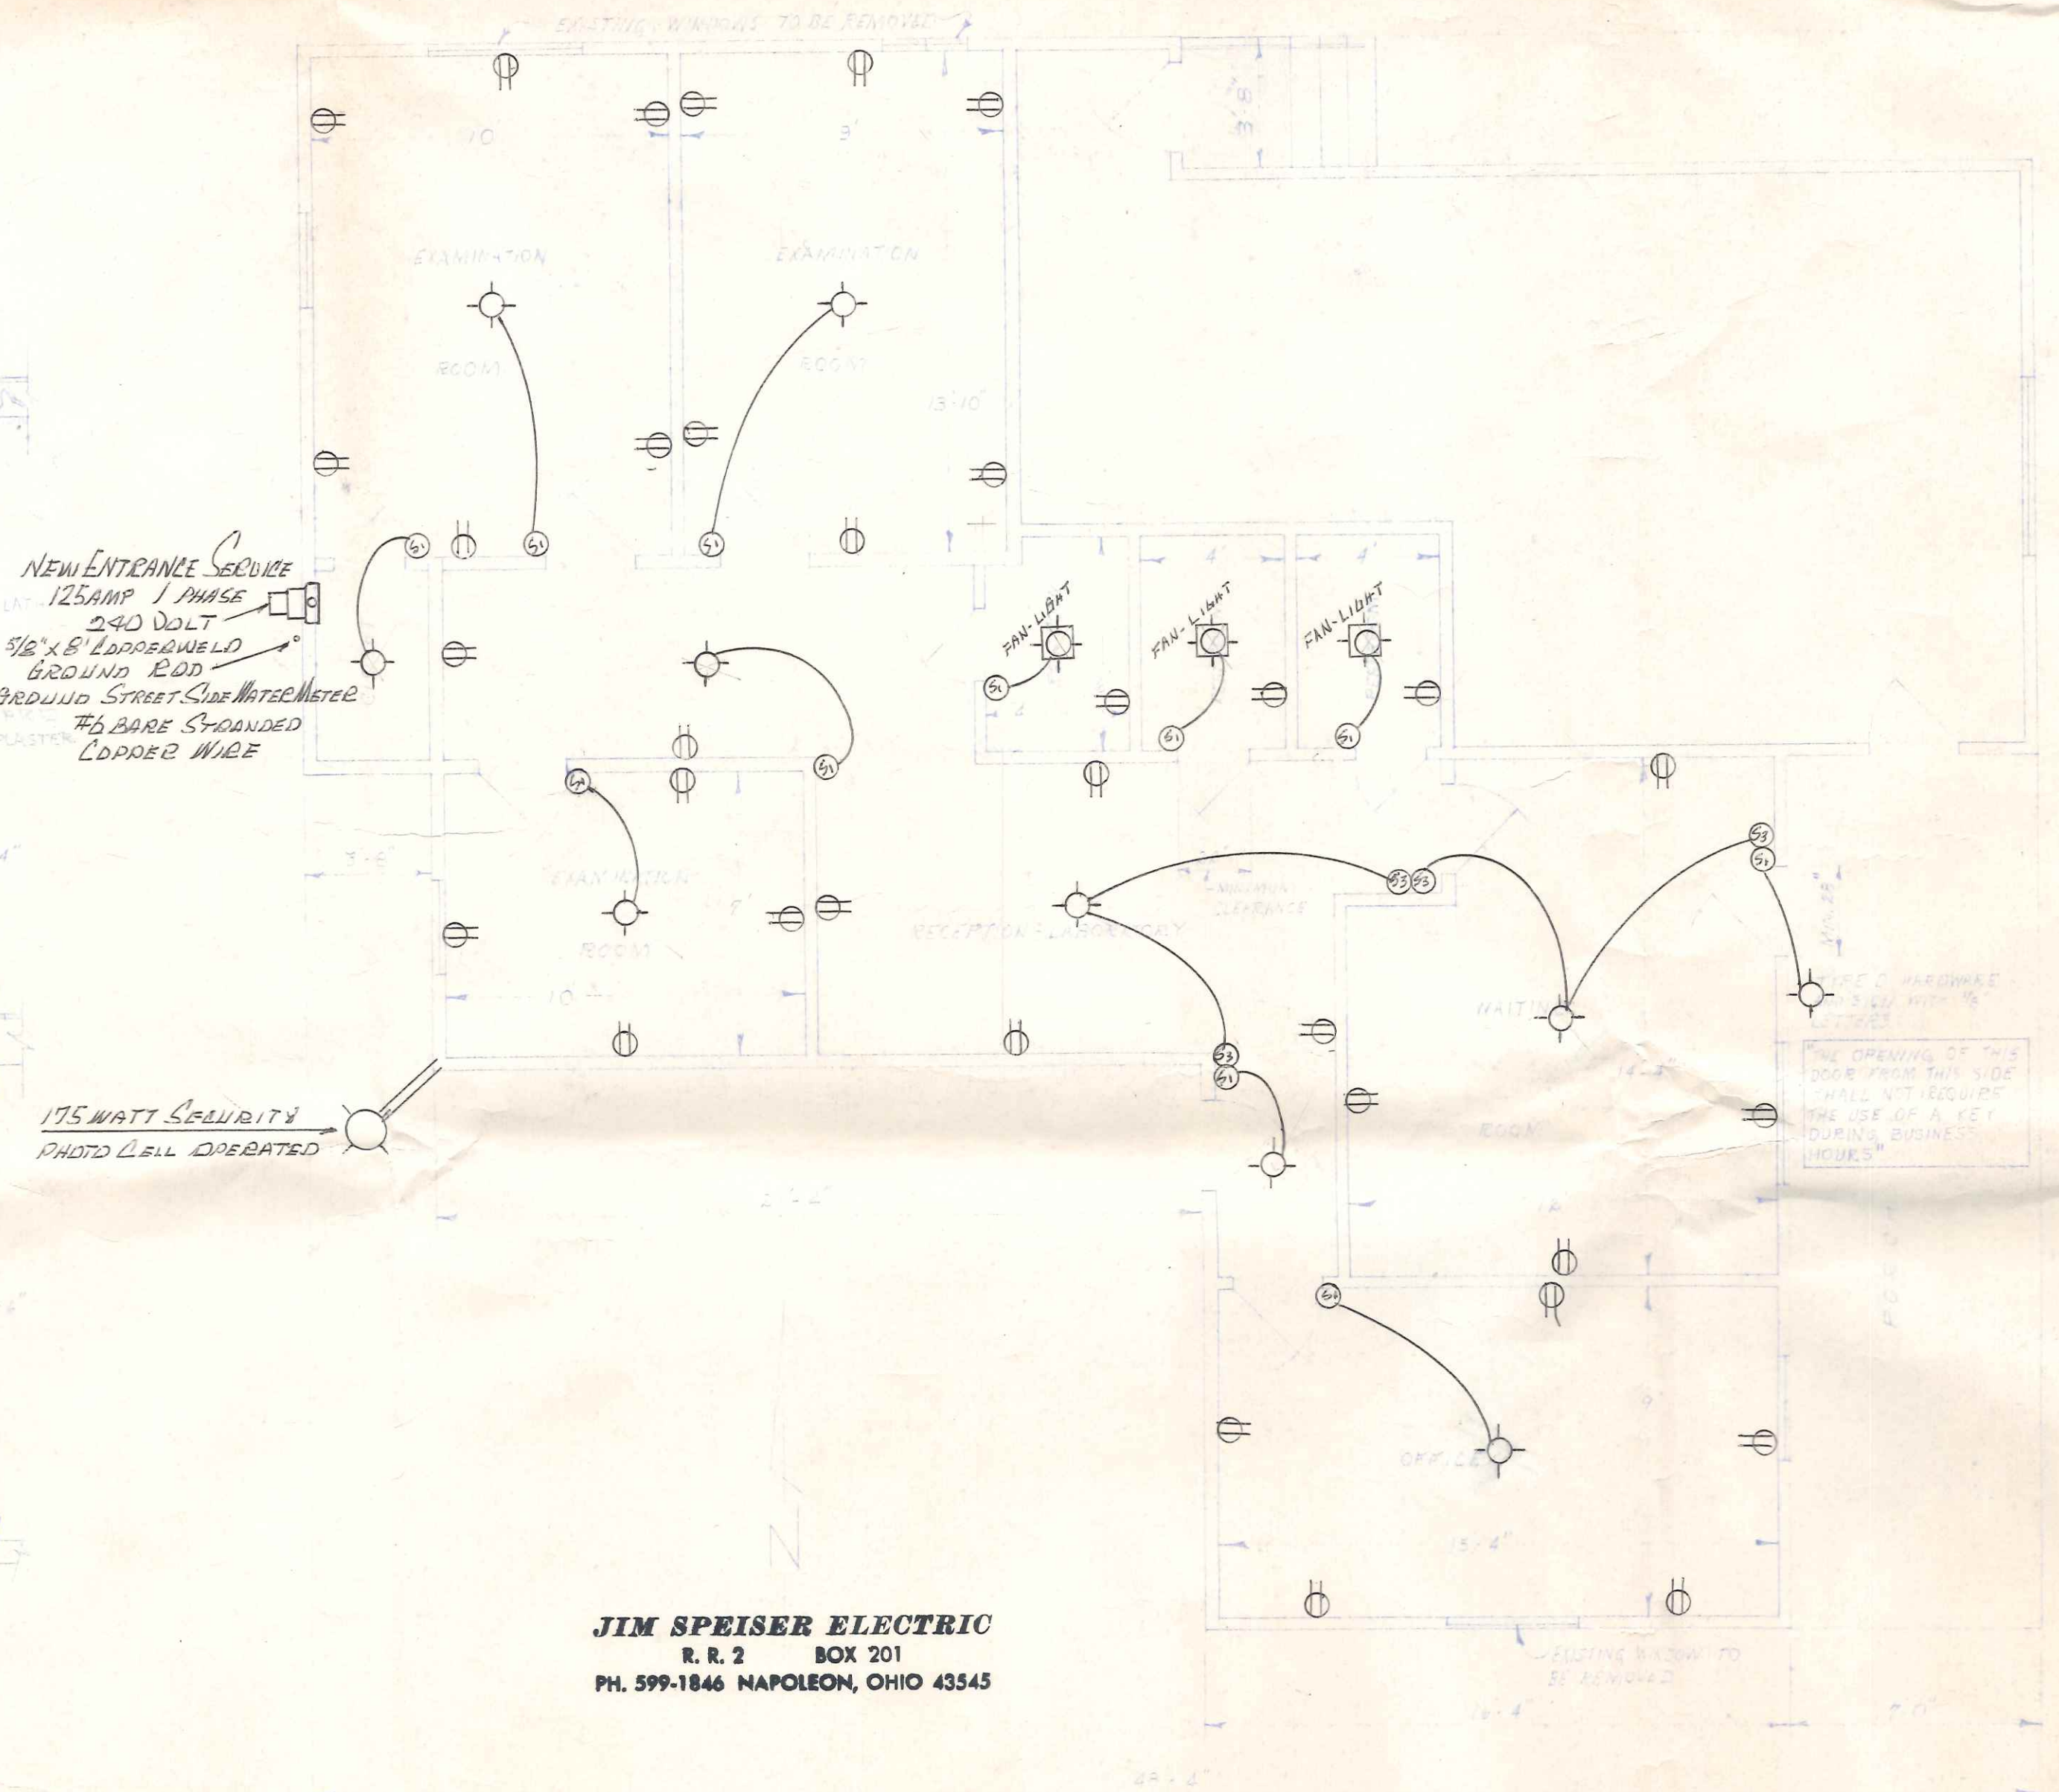

FLOOR PLAN
SCALE 1/4" = 1'-0"

JIM SPEISER ELECTRIC
R. R. 2 BOX 201
PH. 599-1846 NAPOLEON, OHIO 43545

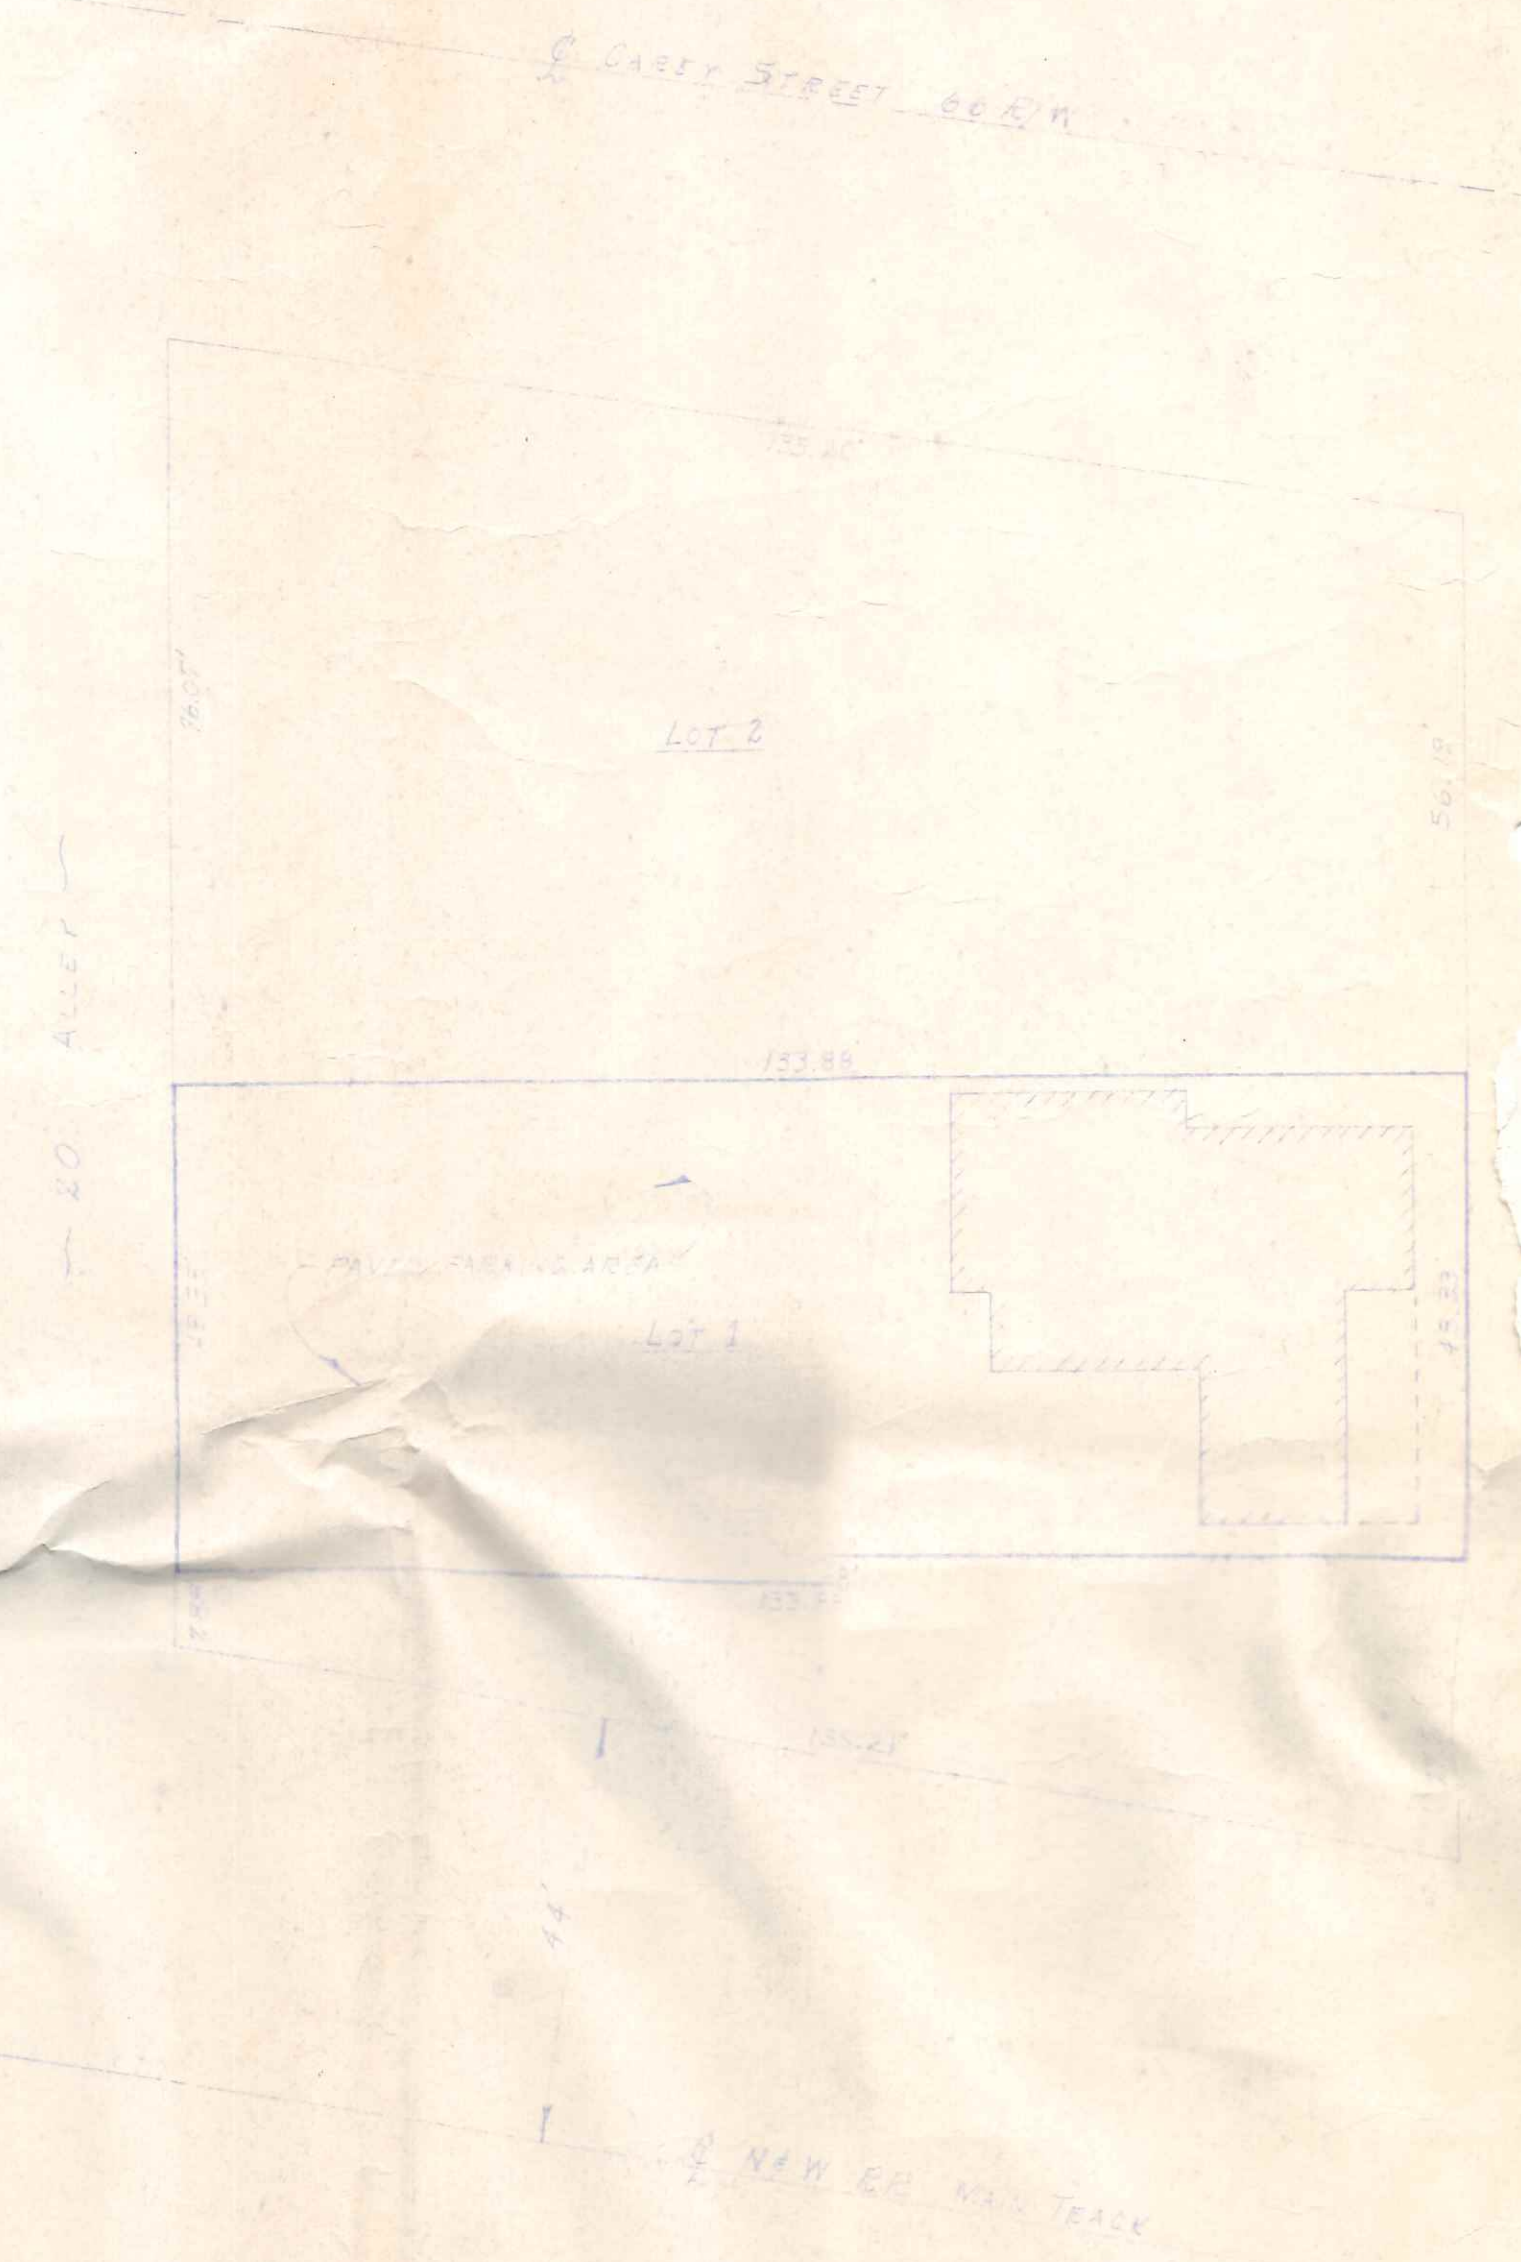

PLAT PLAN
SCALE 1/4" = 1'-0"

NOTE
ALL ELECTRICAL WORK SHALL BE
INSTALLED IN ACCORDANCE WITH THE
NATIONAL FIRE PROTECTION ASSOCIATION
PUBLICATION NO. 98, NATIONAL ELECTRIC
CODE AND THE OHIO BUILDING CODE.

OWNER
LUTHER GERRY
23 LAUREL DRIVE
NAPOLEON, OHIO

Engineering Dept.
RECEIVED
FEB 26 1978
J.S.