



8 12

BUILDING DEPT.
Plan Approval
By RJA Date 5/14/88
60 Vincennes
Permit 1037

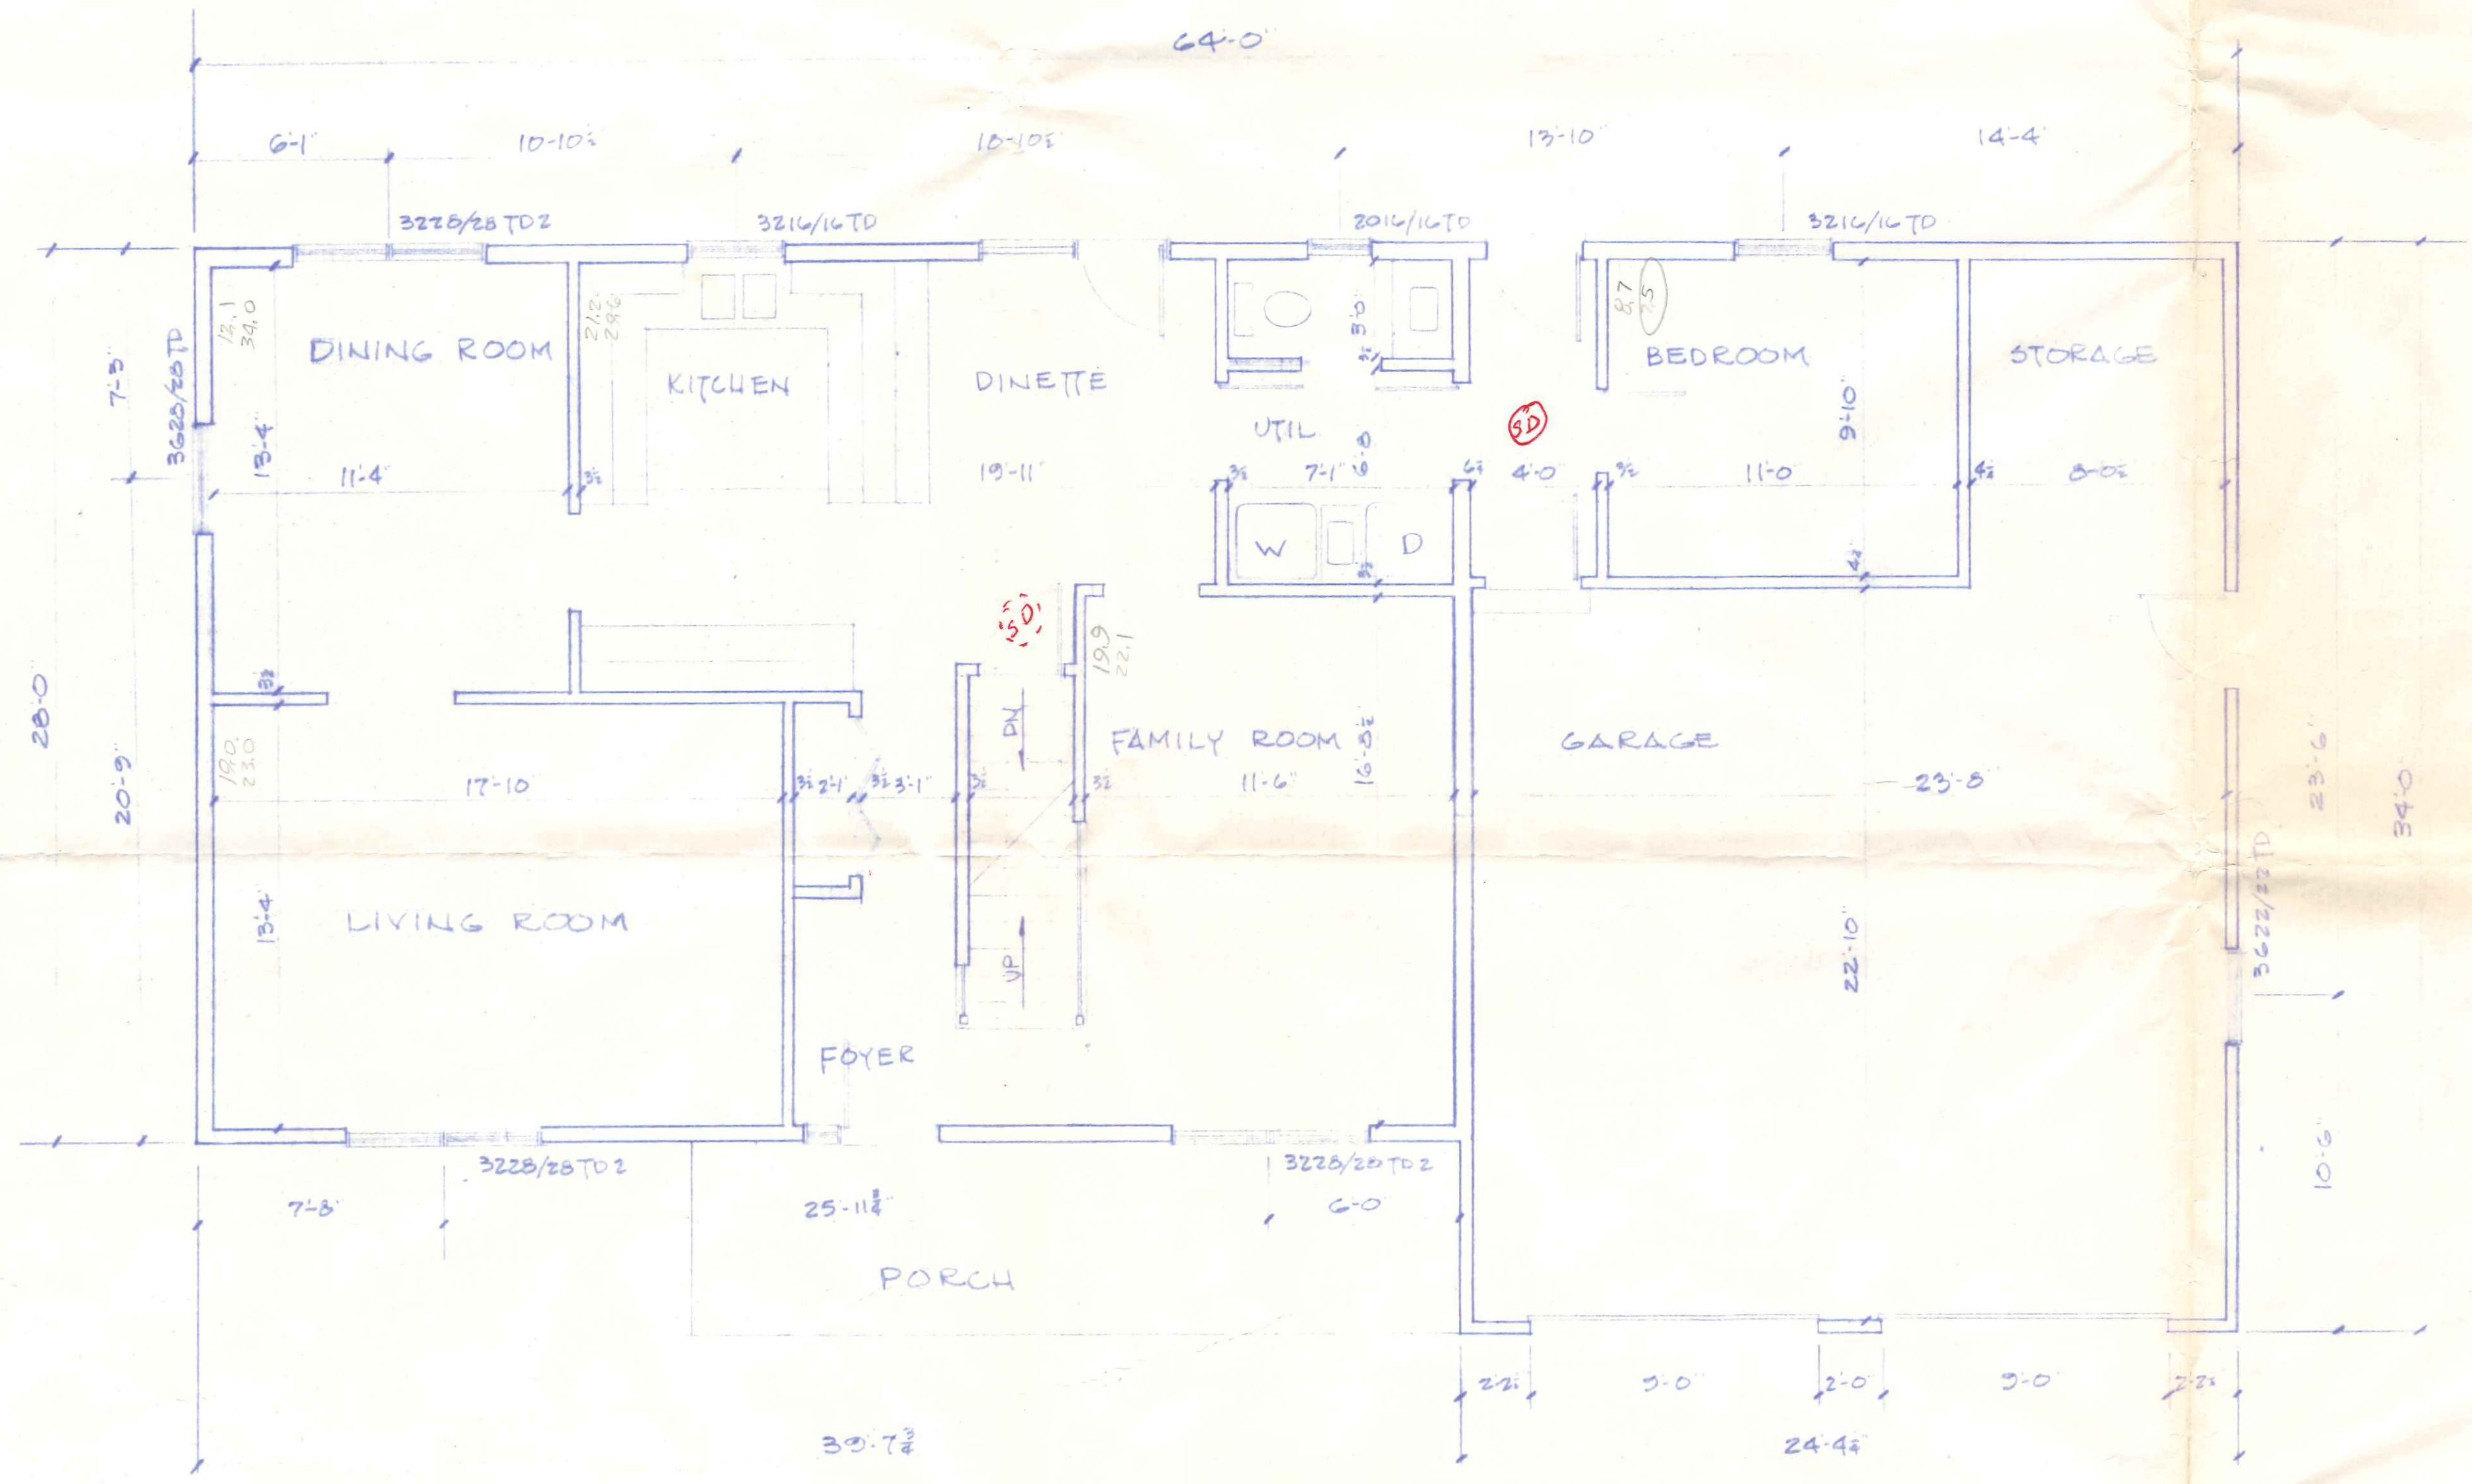


1st FL. - FLOOR PLAN
SCALE 1/8"=1'-0"

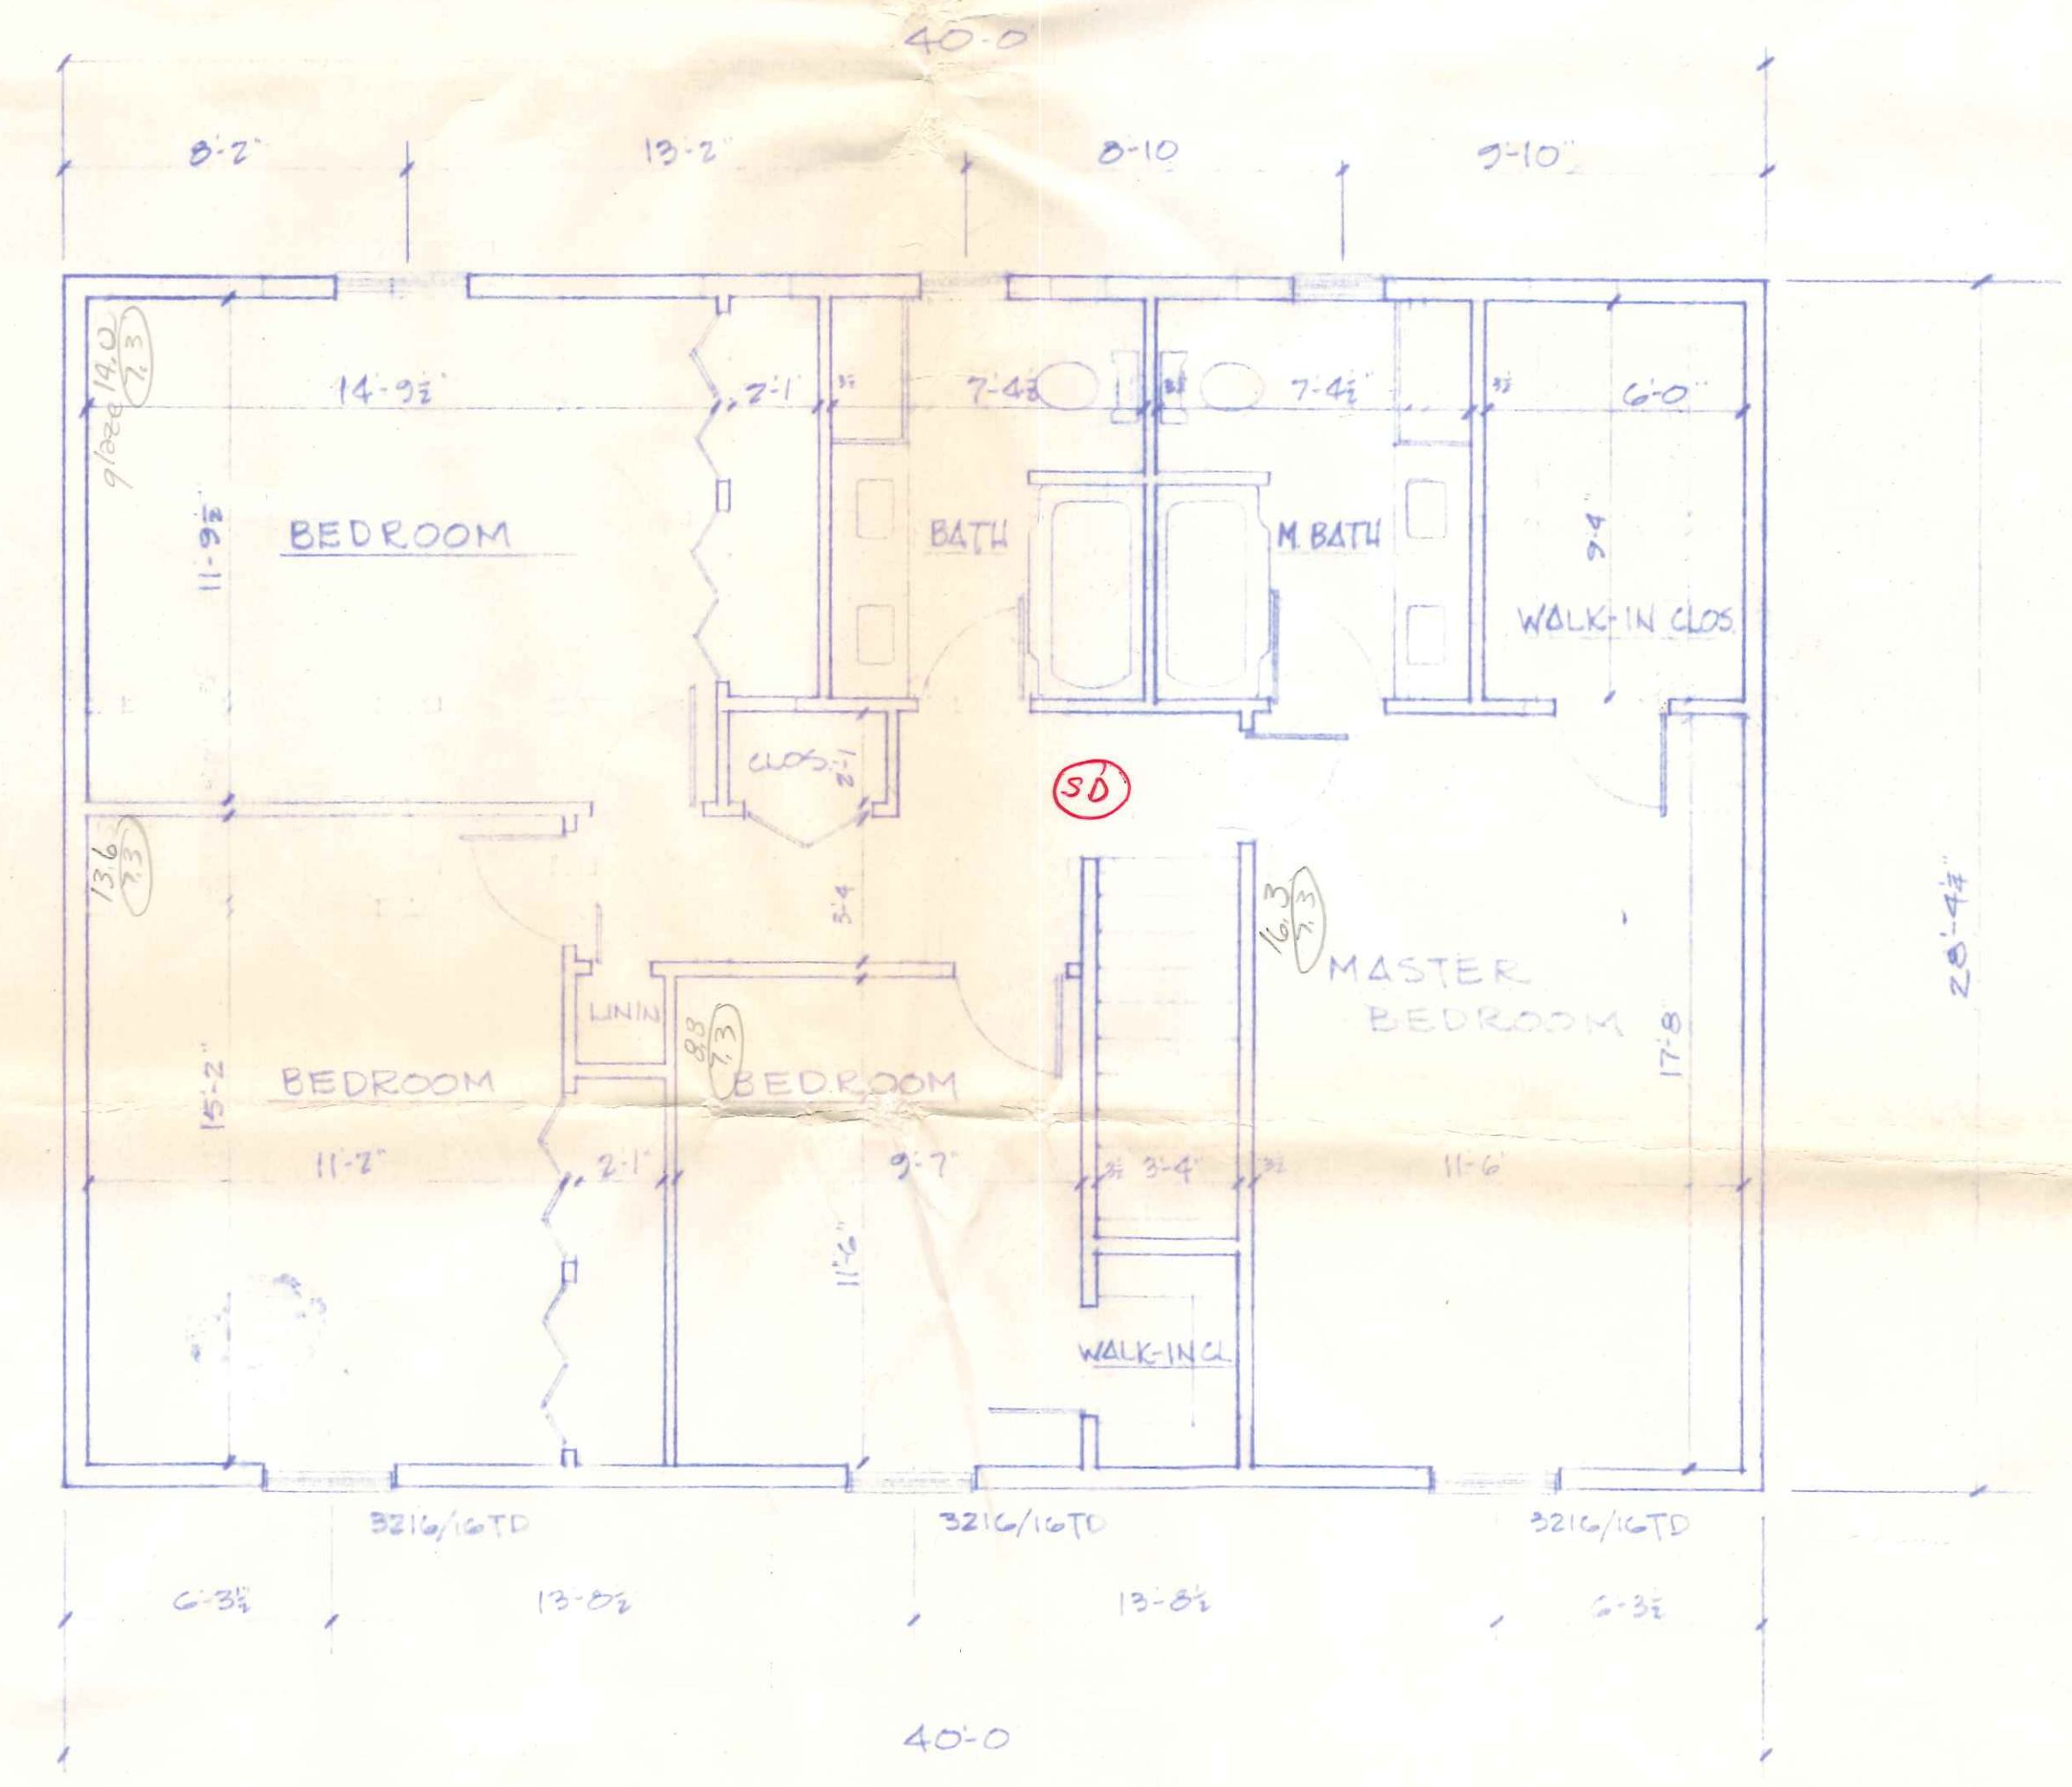


2nd FL. FLOOR PLAN
SCALE 1/8"=1'-0"


RALPH BADENHOP RESIDENCE		
SCALE 1/8"=1'-0"	APPROVED BY	DRAWN BY K.M.D.
DATE APRIL 23 1988		REVISED
ROLAND DEMALINE & SONS CONSTRUCTION WAUSEAN, OHIO		
		DRAWING NUMBER 1 OF 3

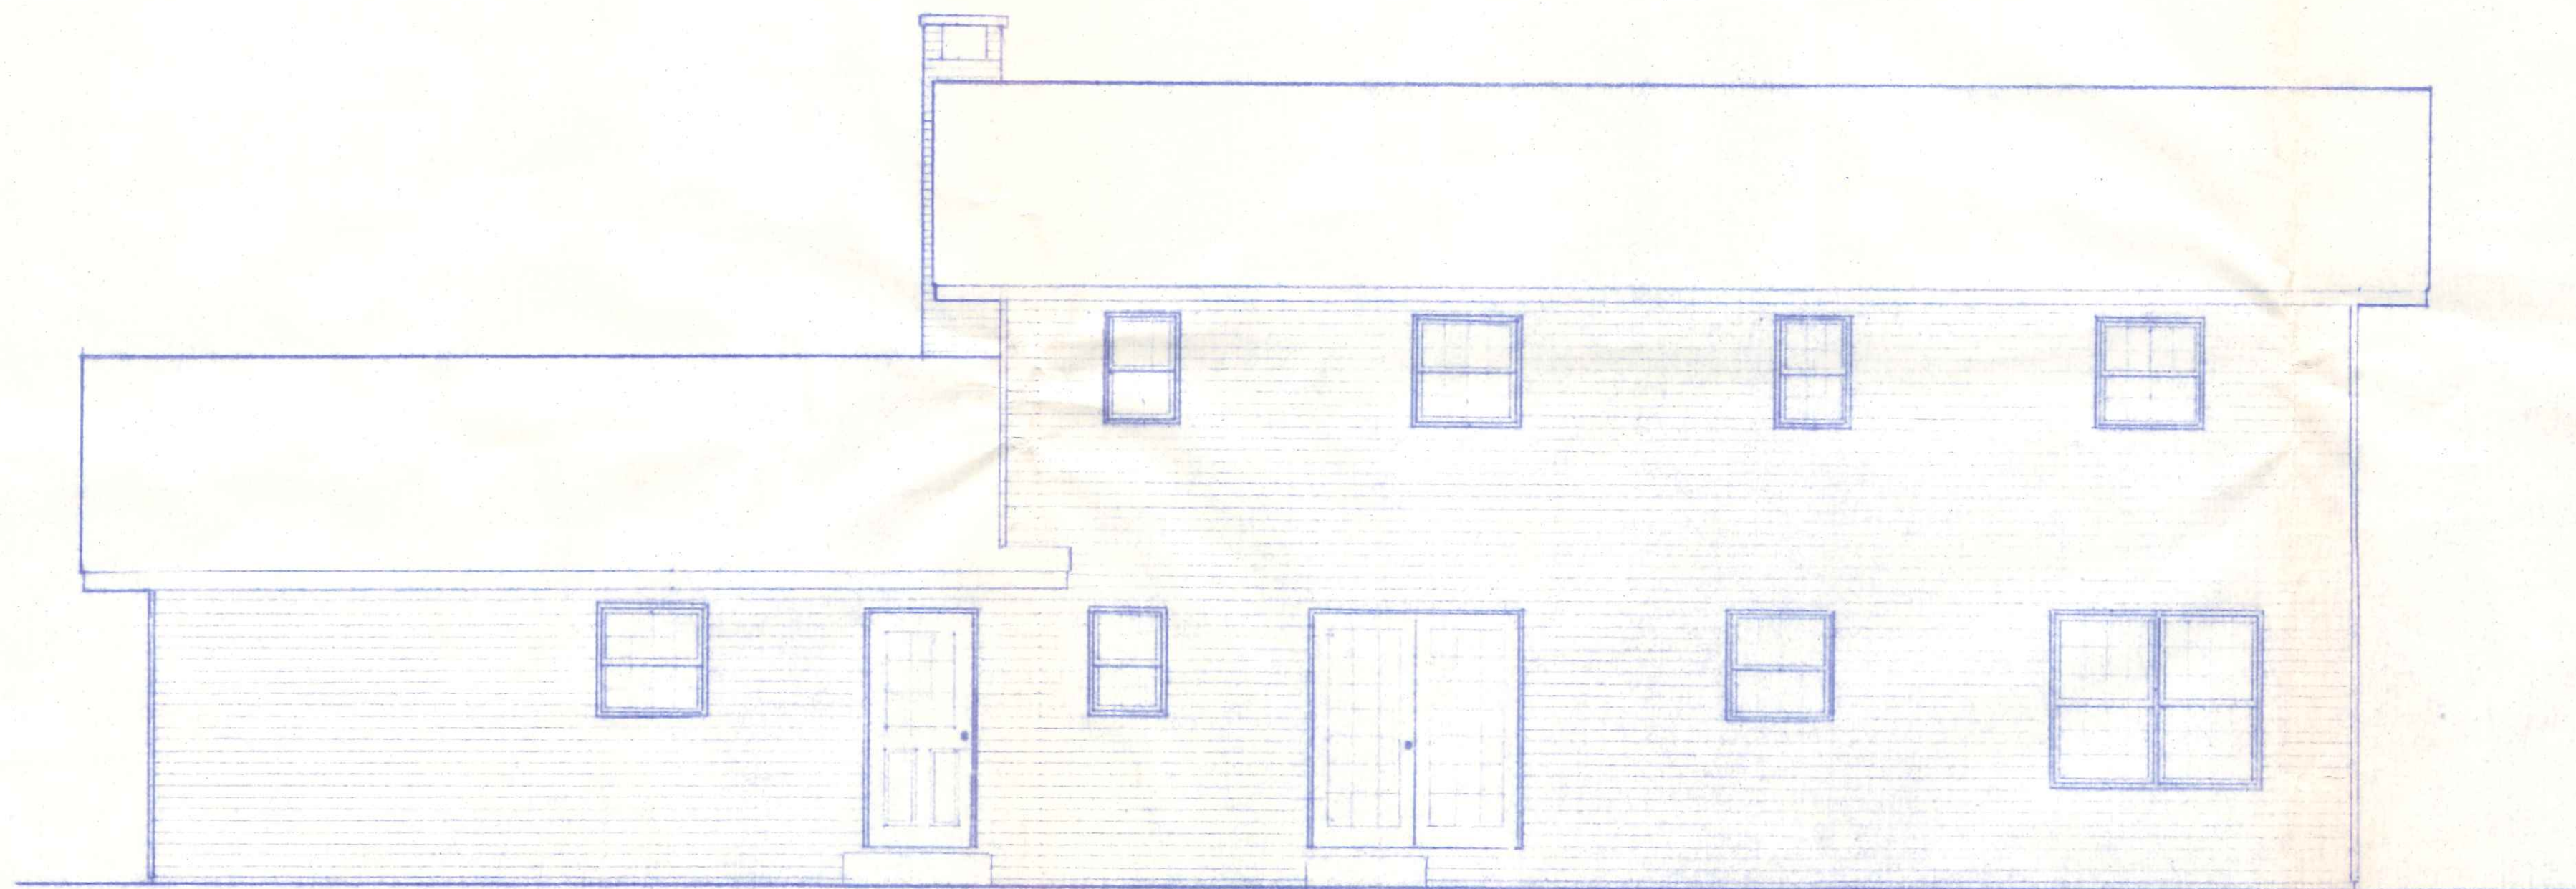


NORTH ELEVATION

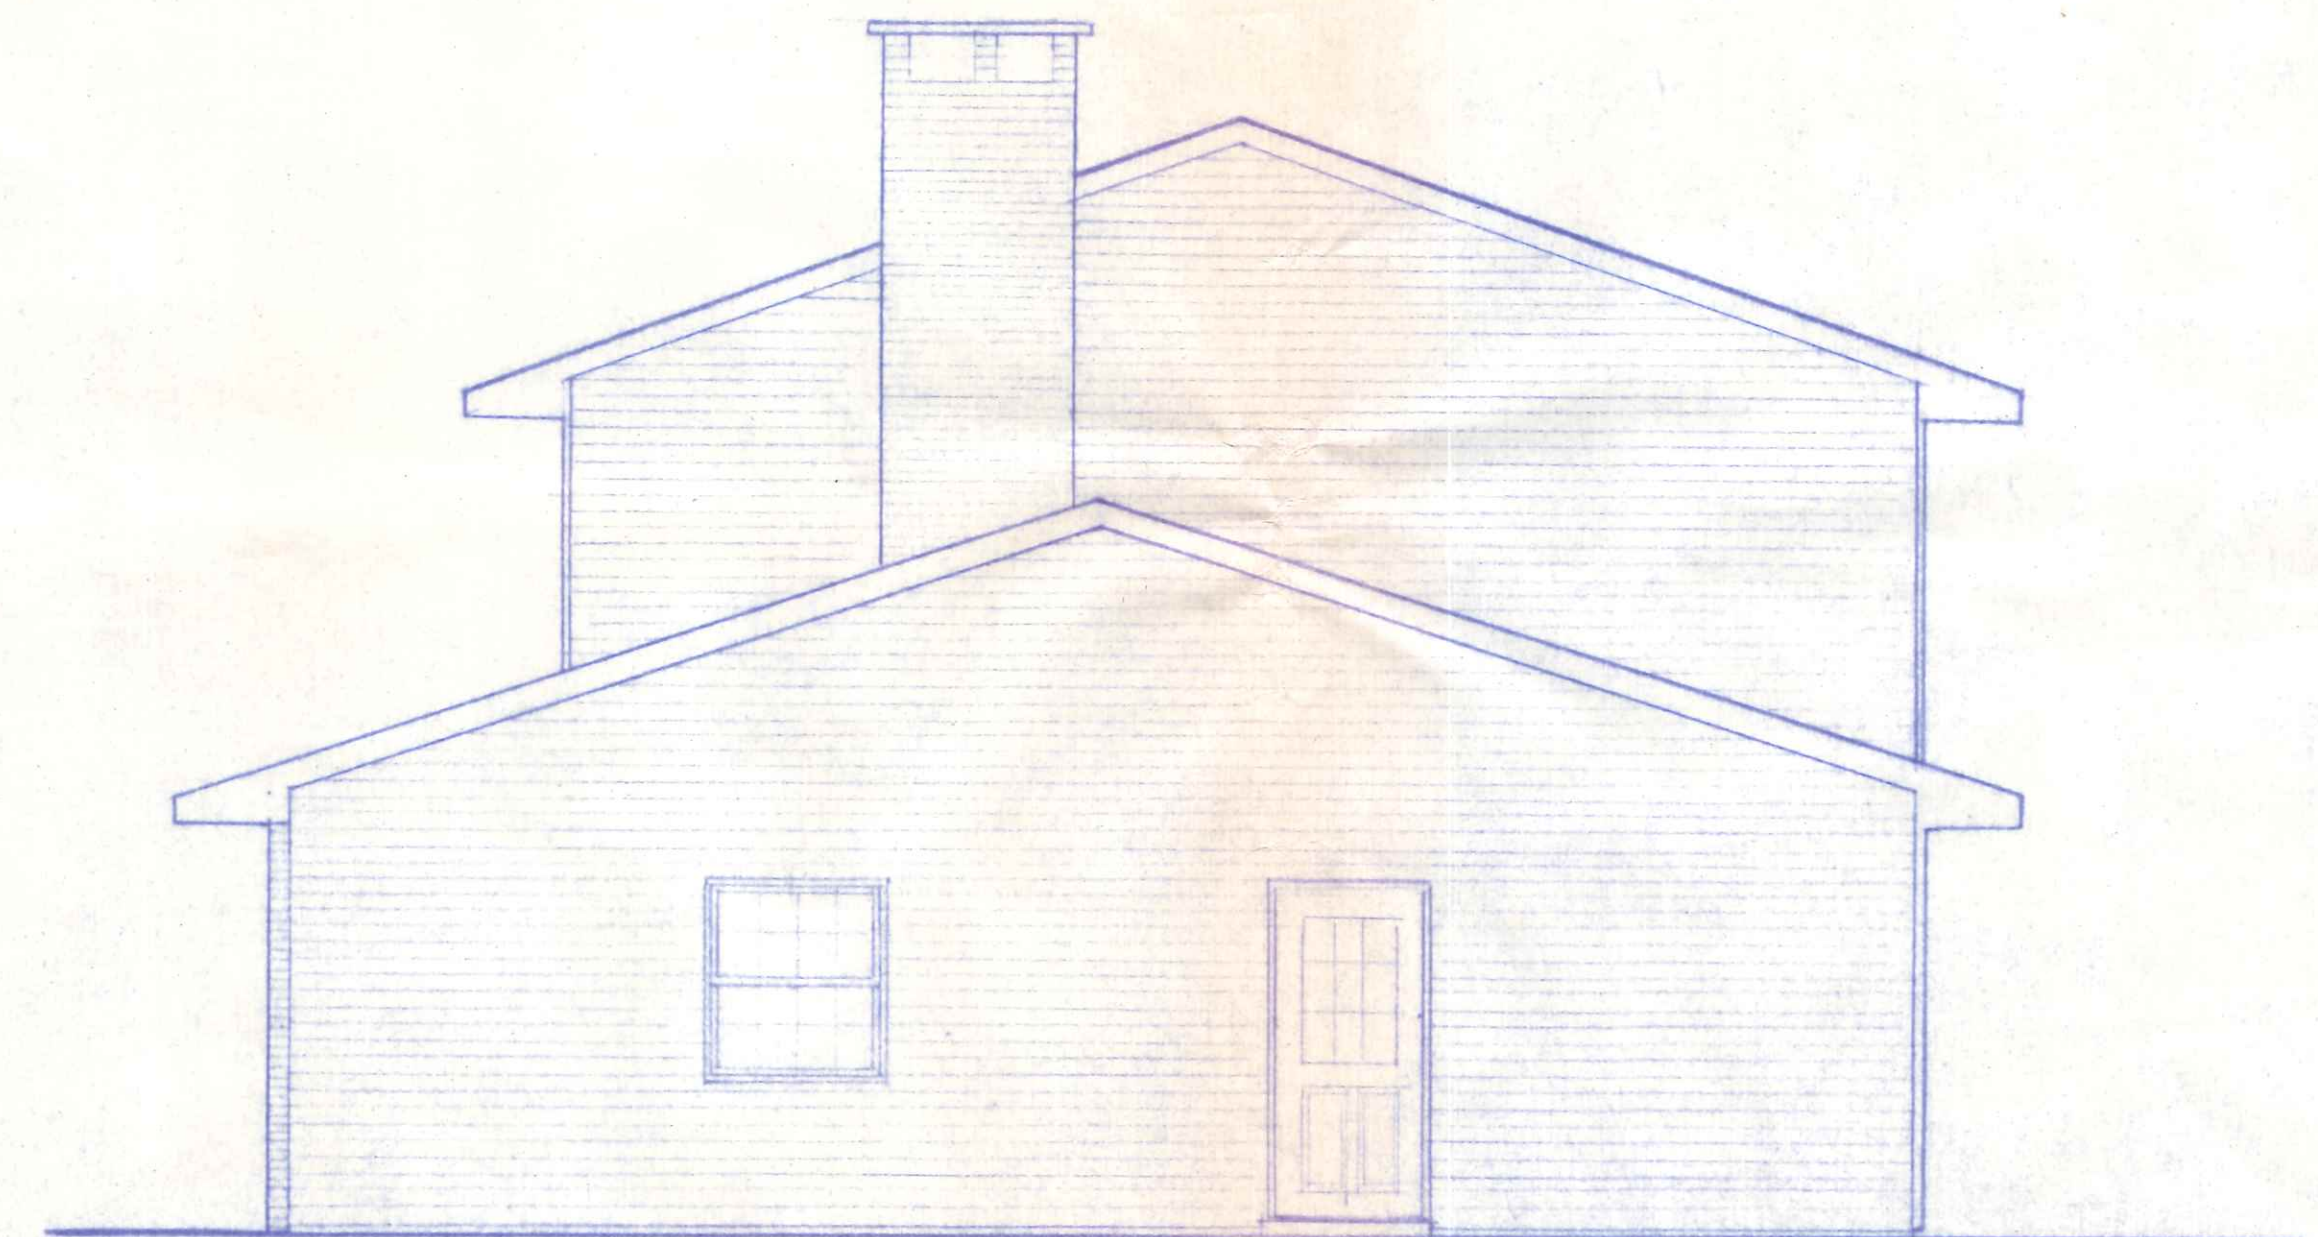

EAST ELEVATION

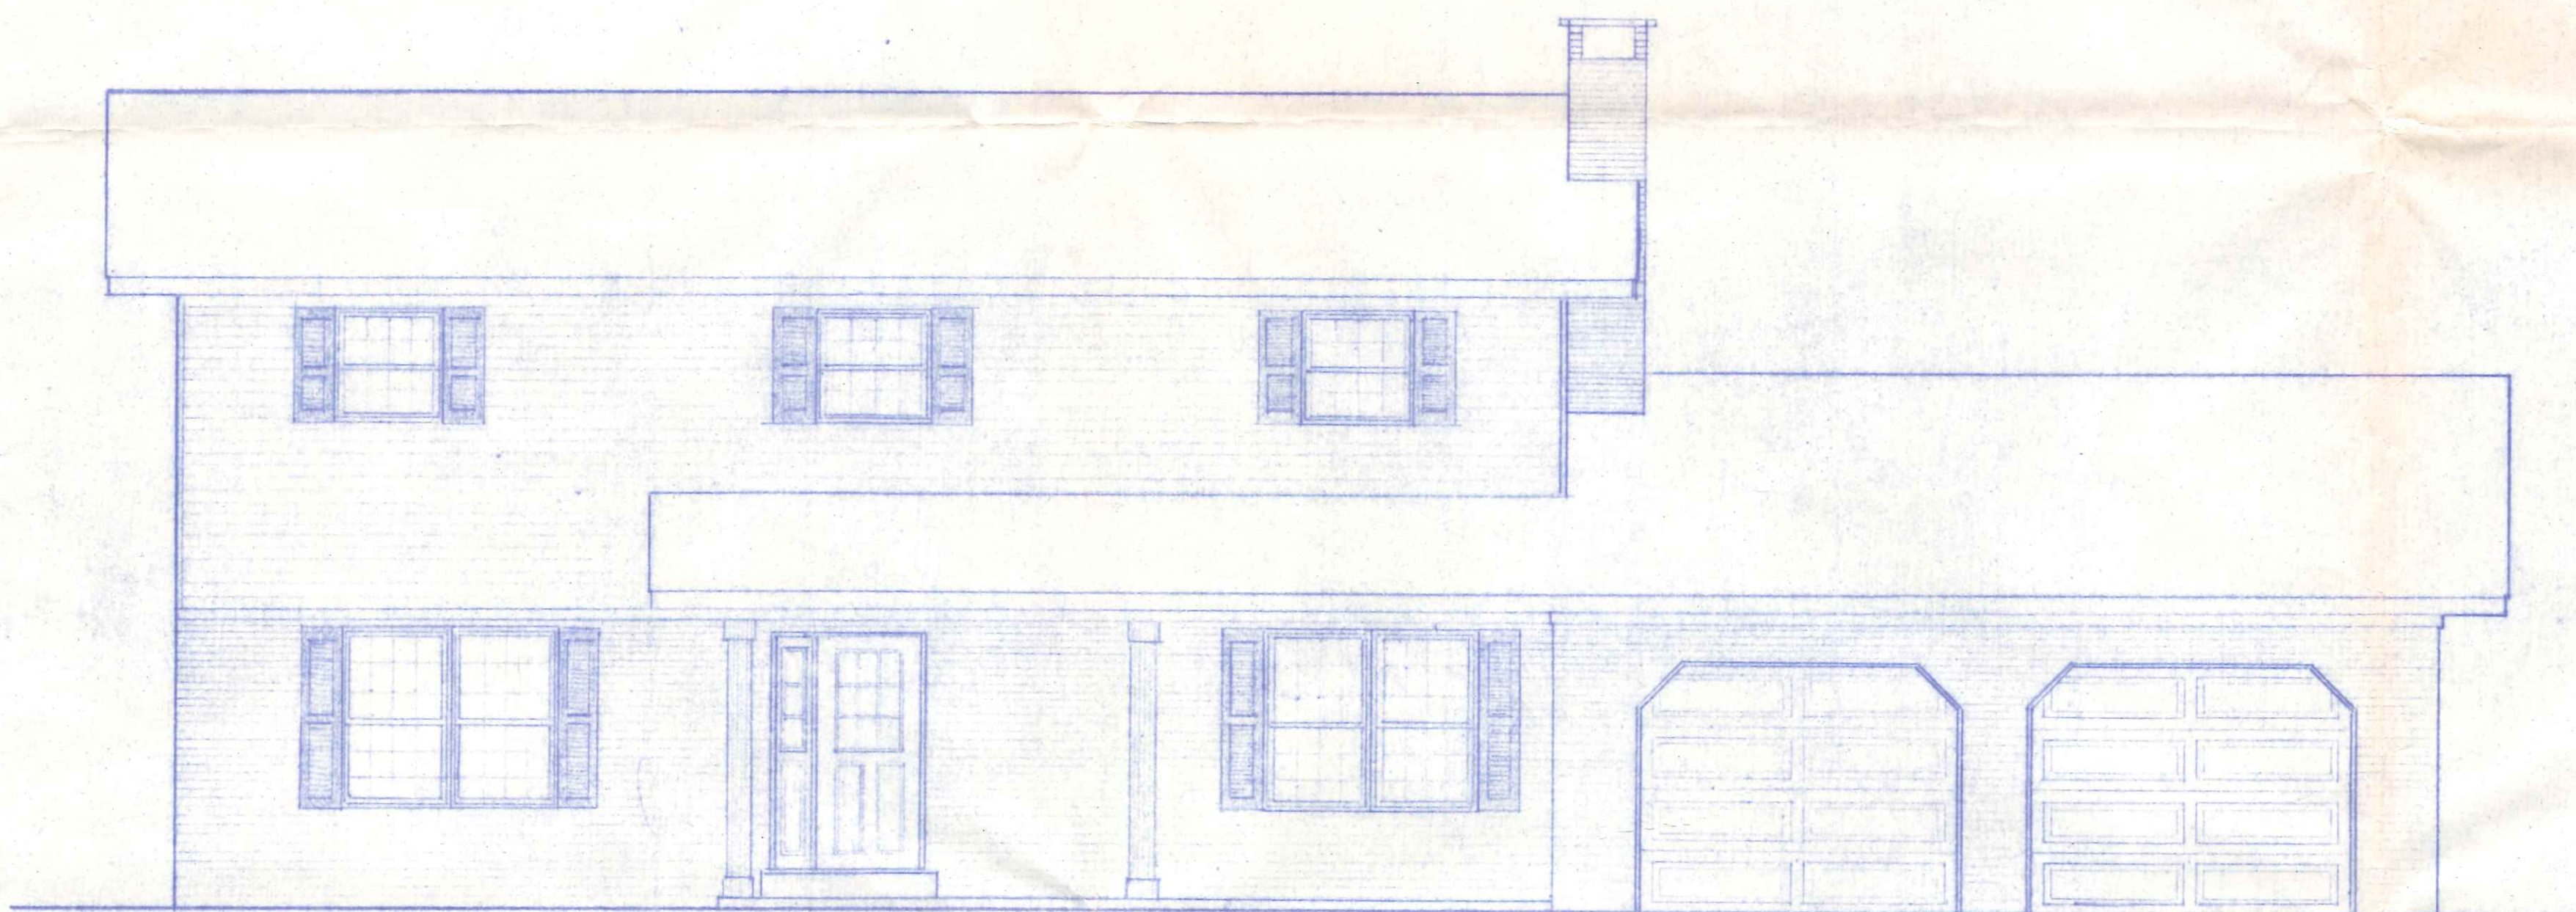


SOUTH ELEVATION

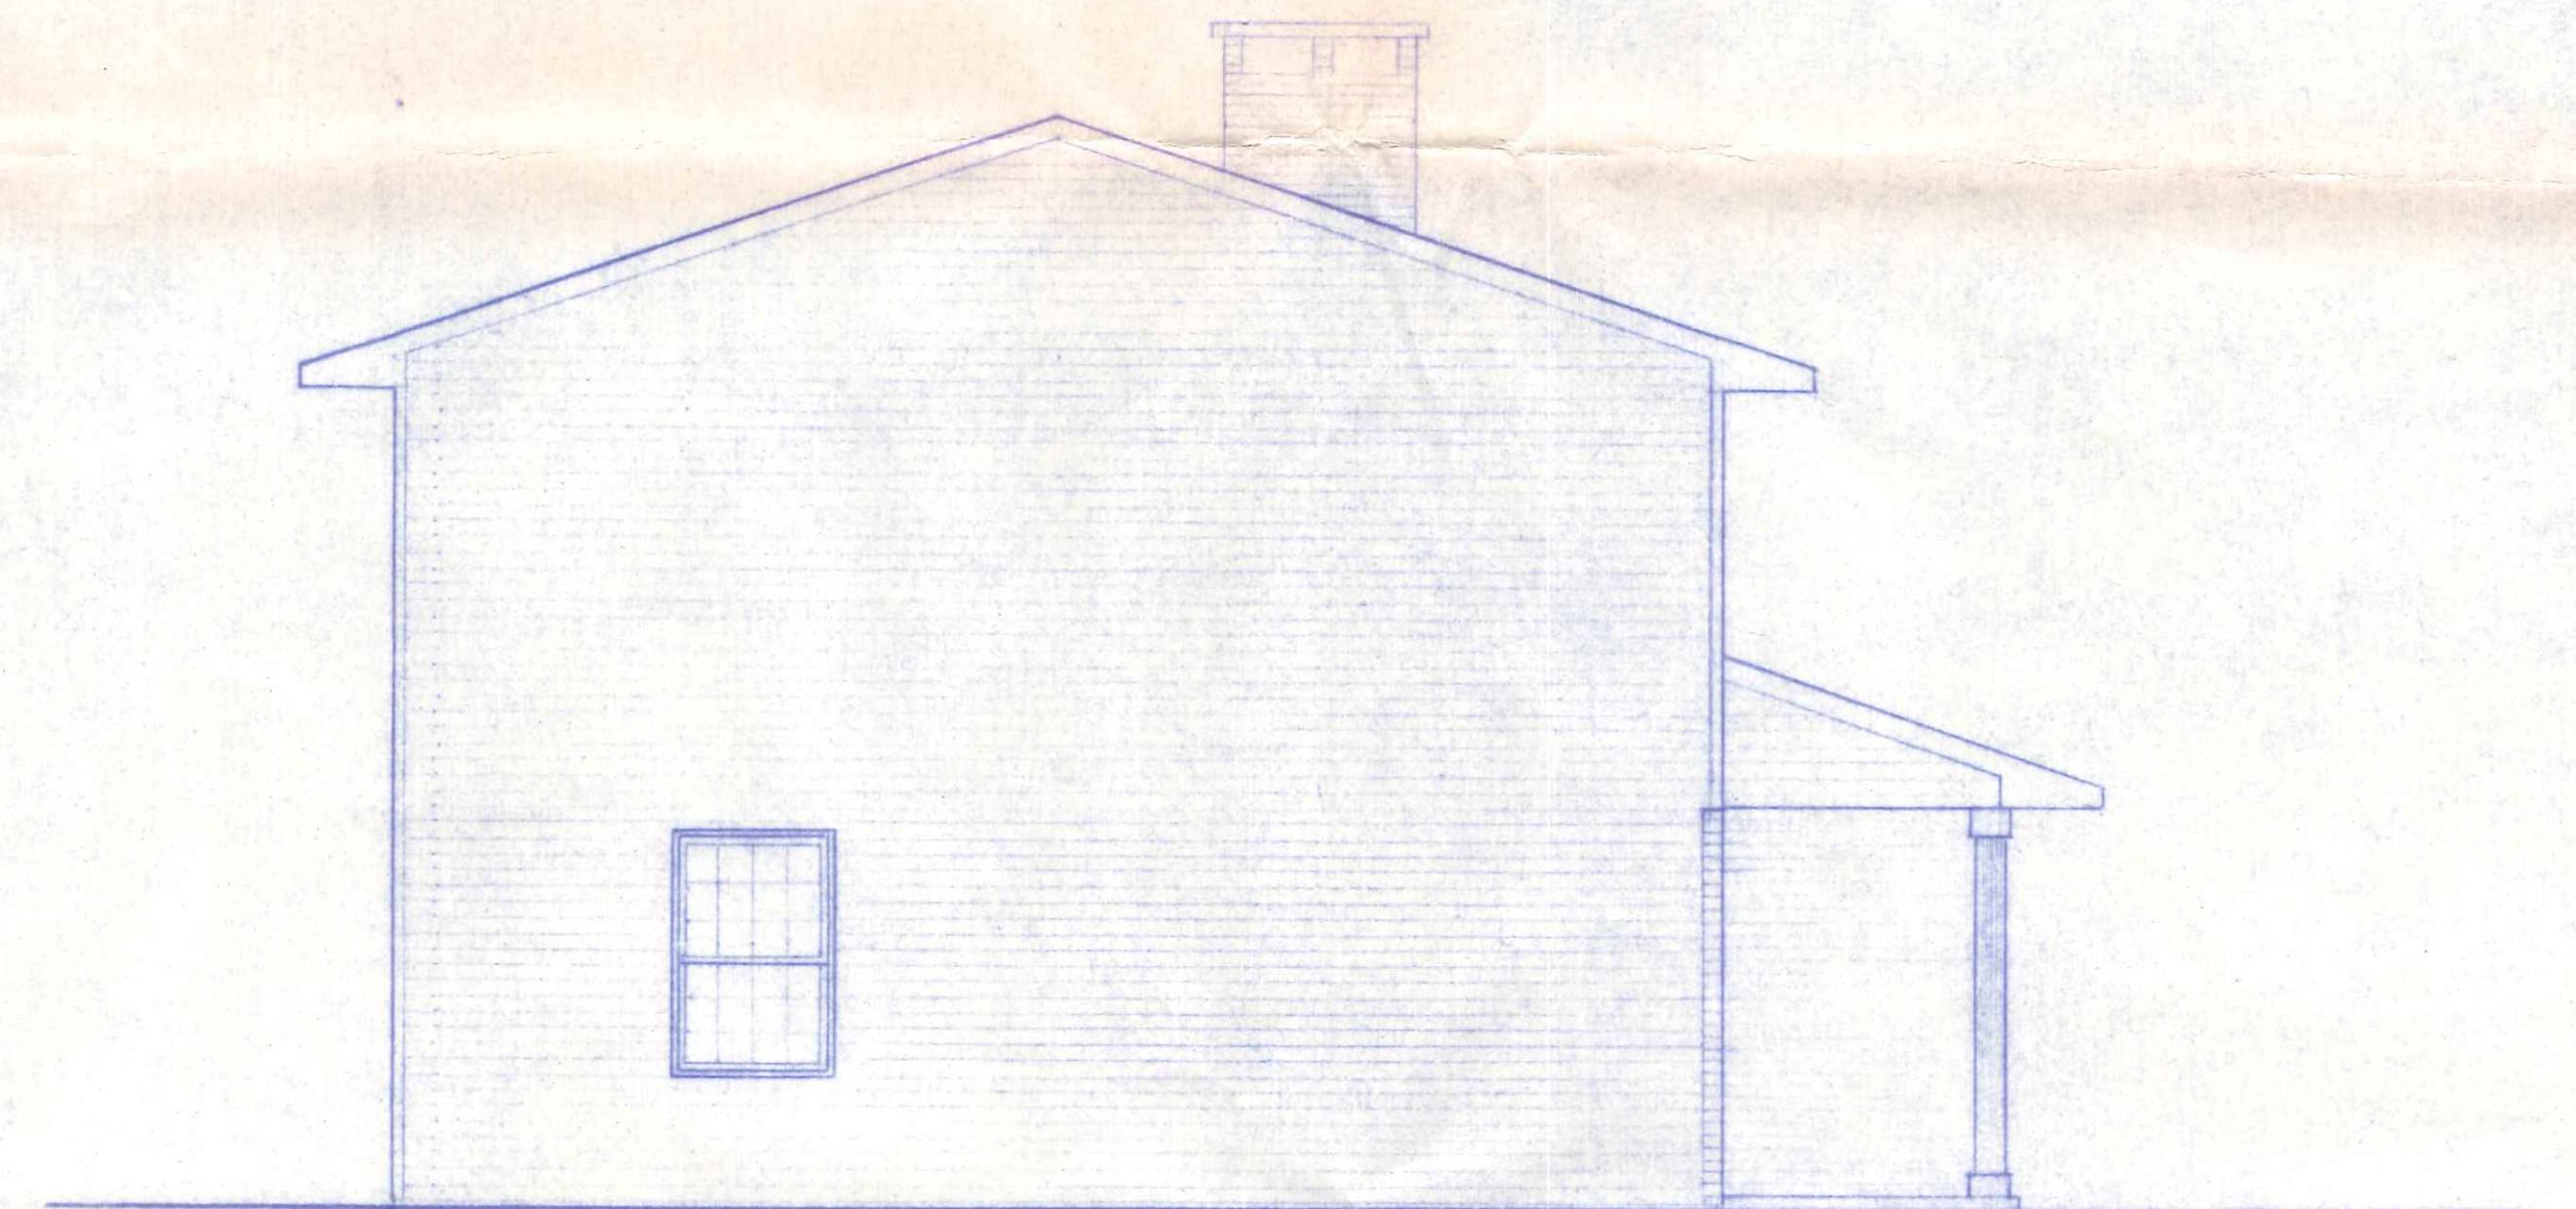

WEST ELEVATION


SCALE 1/2"=1'-0"

RALPH BADENHOP RESIDENCE			
SCALE: AS SHOWN	APPROVED BY:	DRAWN BY: K.M.D.	
DATE: MAY 7 88		REVISED:	
ROLAND DEMALINE & SONS' CONST			
WAUWATON, OHIO			
DRAWING NUMBER			2 of 3

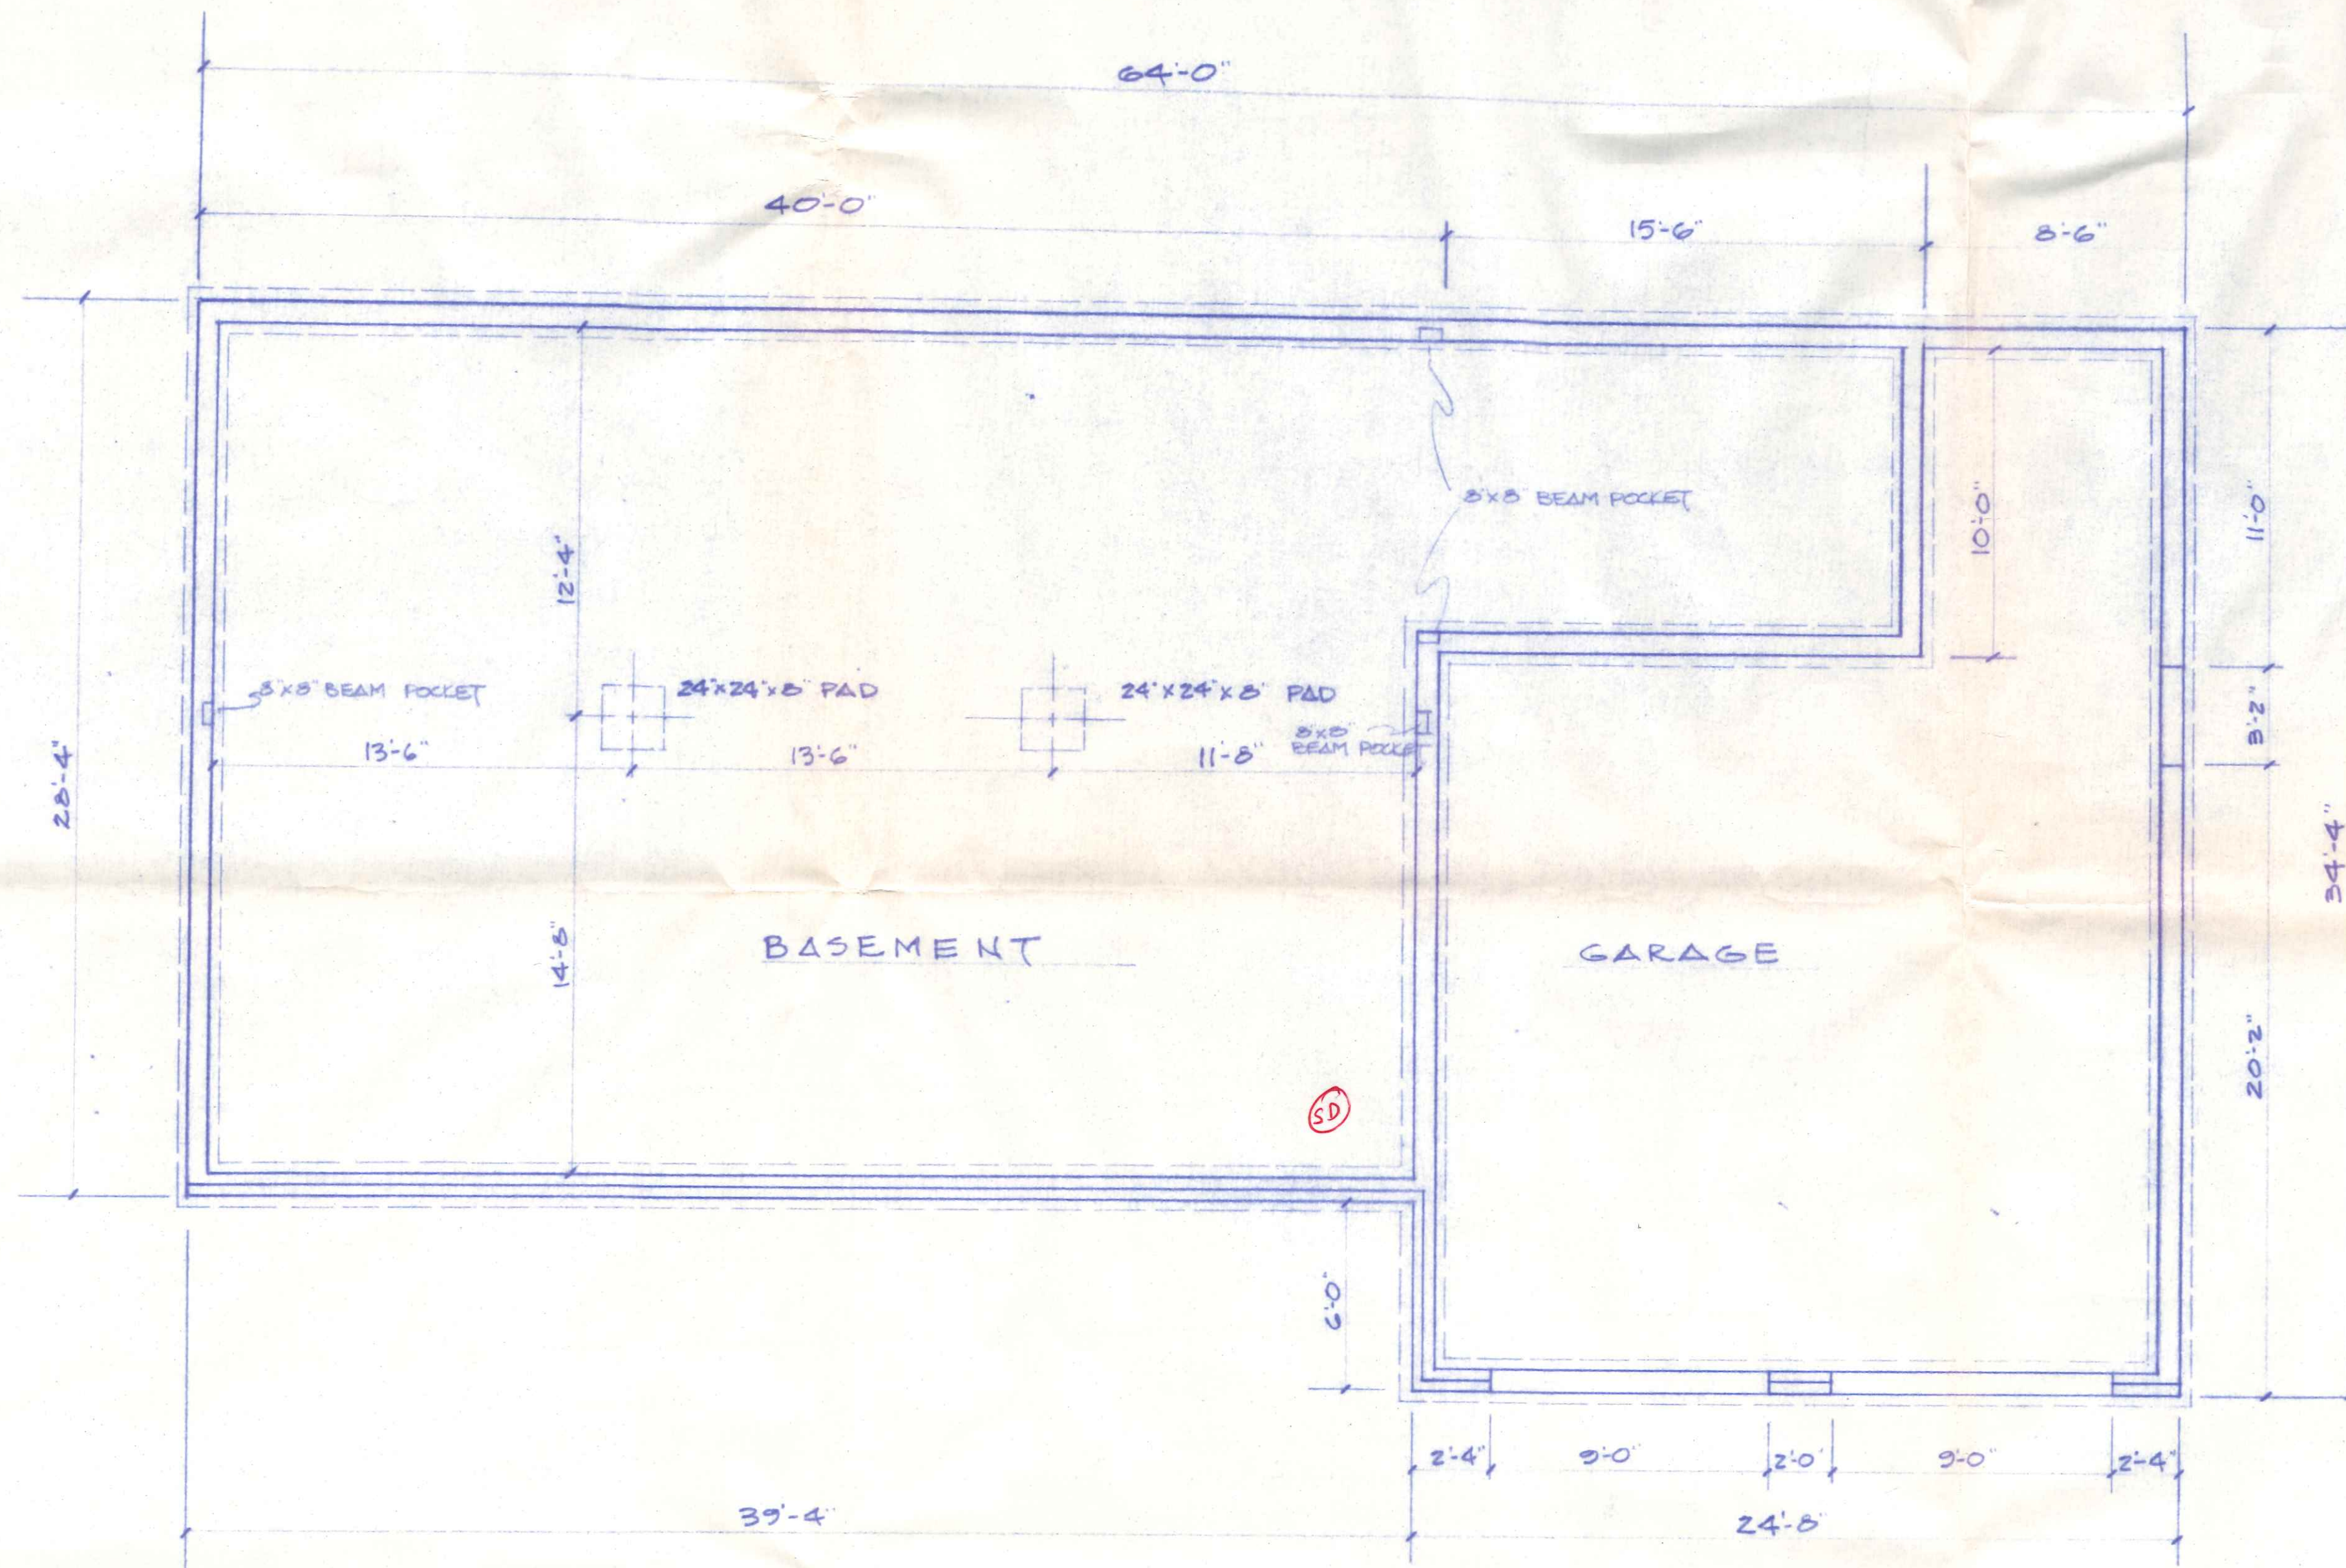

FOUNDATION PLAN

SCALE 1/8" = 1'-0"

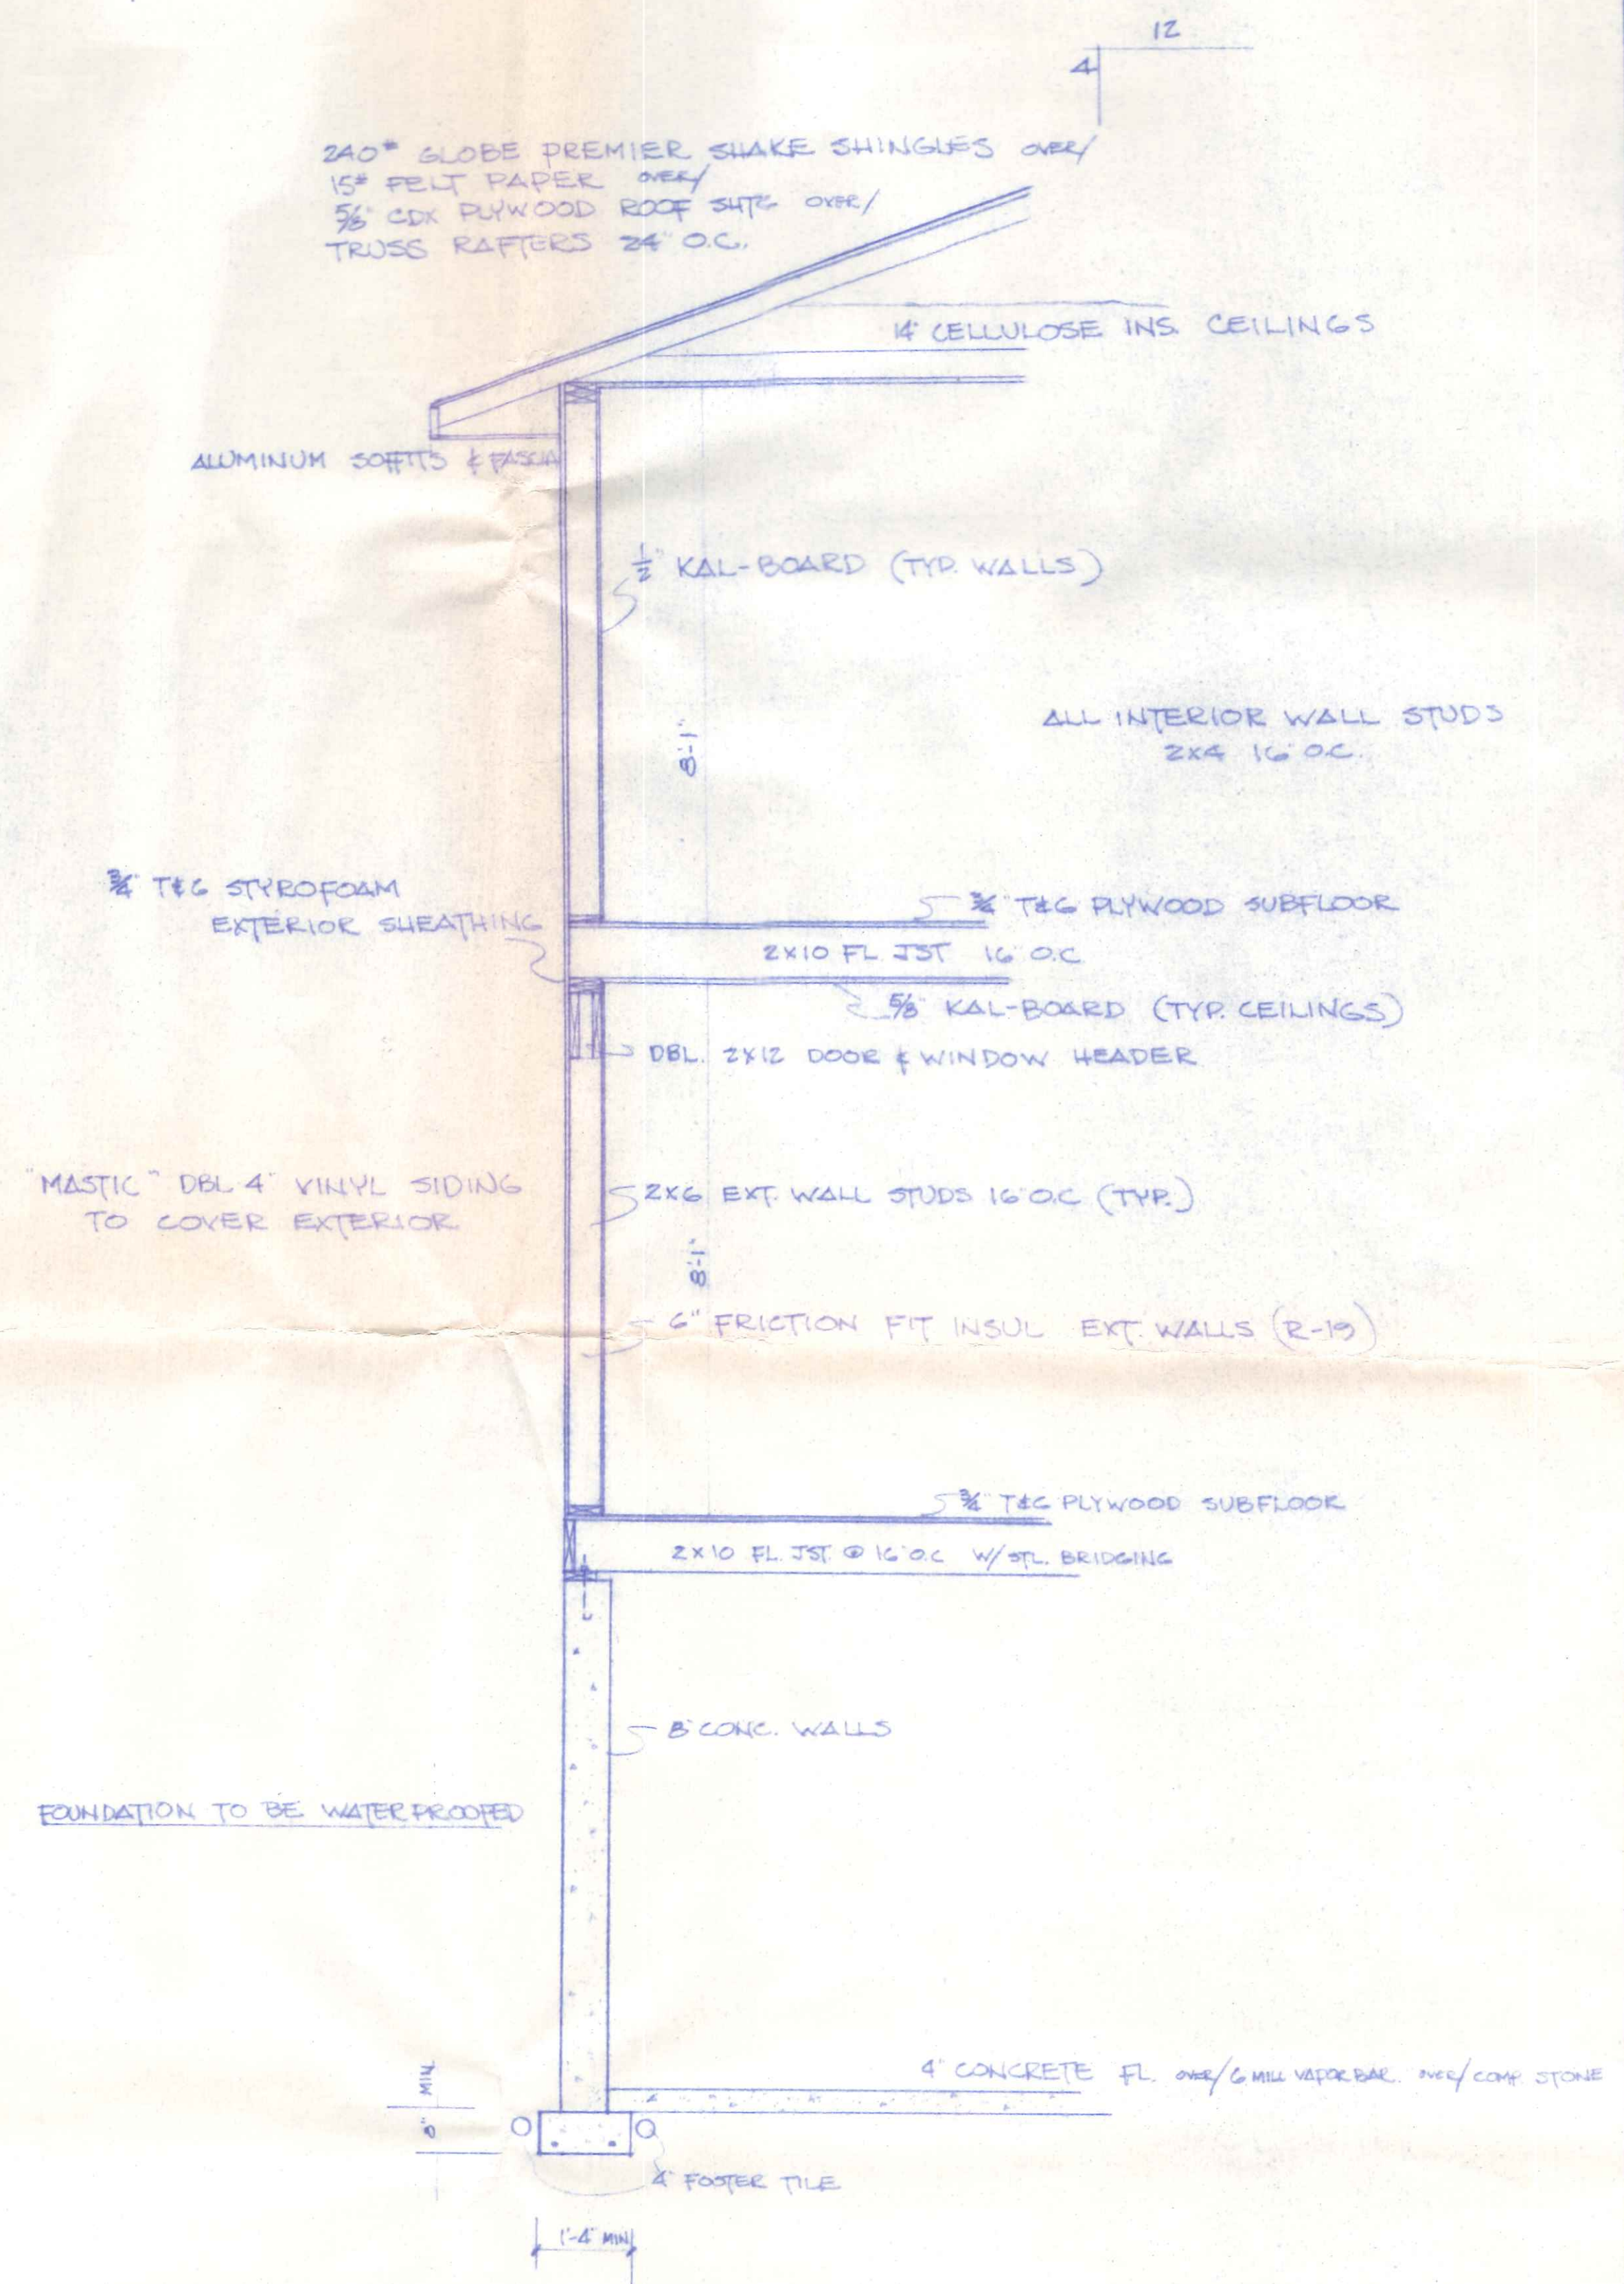

TYPICAL WALL SECTION

SCALE 1/2" = 1'-0"

RALPH BADENHOP RESIDENCE		
SCALE(S) SHOWN	APPROVED BY:	DRAWN BY K.M.D.
DATE:		REVISED
ROLAND DEMALINE & SONS CONST WAUWATON OHIO		
		DRAWING NUMBER 3 of 3

NOTE:

1. ALL WIRING SHALL BE DONE IN ACCORDANCE WITH NATIONAL ELECTRICAL CODE
2. ALL WIRE TO BE MINIMUM OF #12 COPPER



RECEIVED

JUN 18 1985
CITY OF INDIANAPOLIS
BUILDING DEPT.


CITY OF INDIANAPOLIS
BUILDING DEPT.

By *RWT* Date *6/19/85*

60 Vincennes

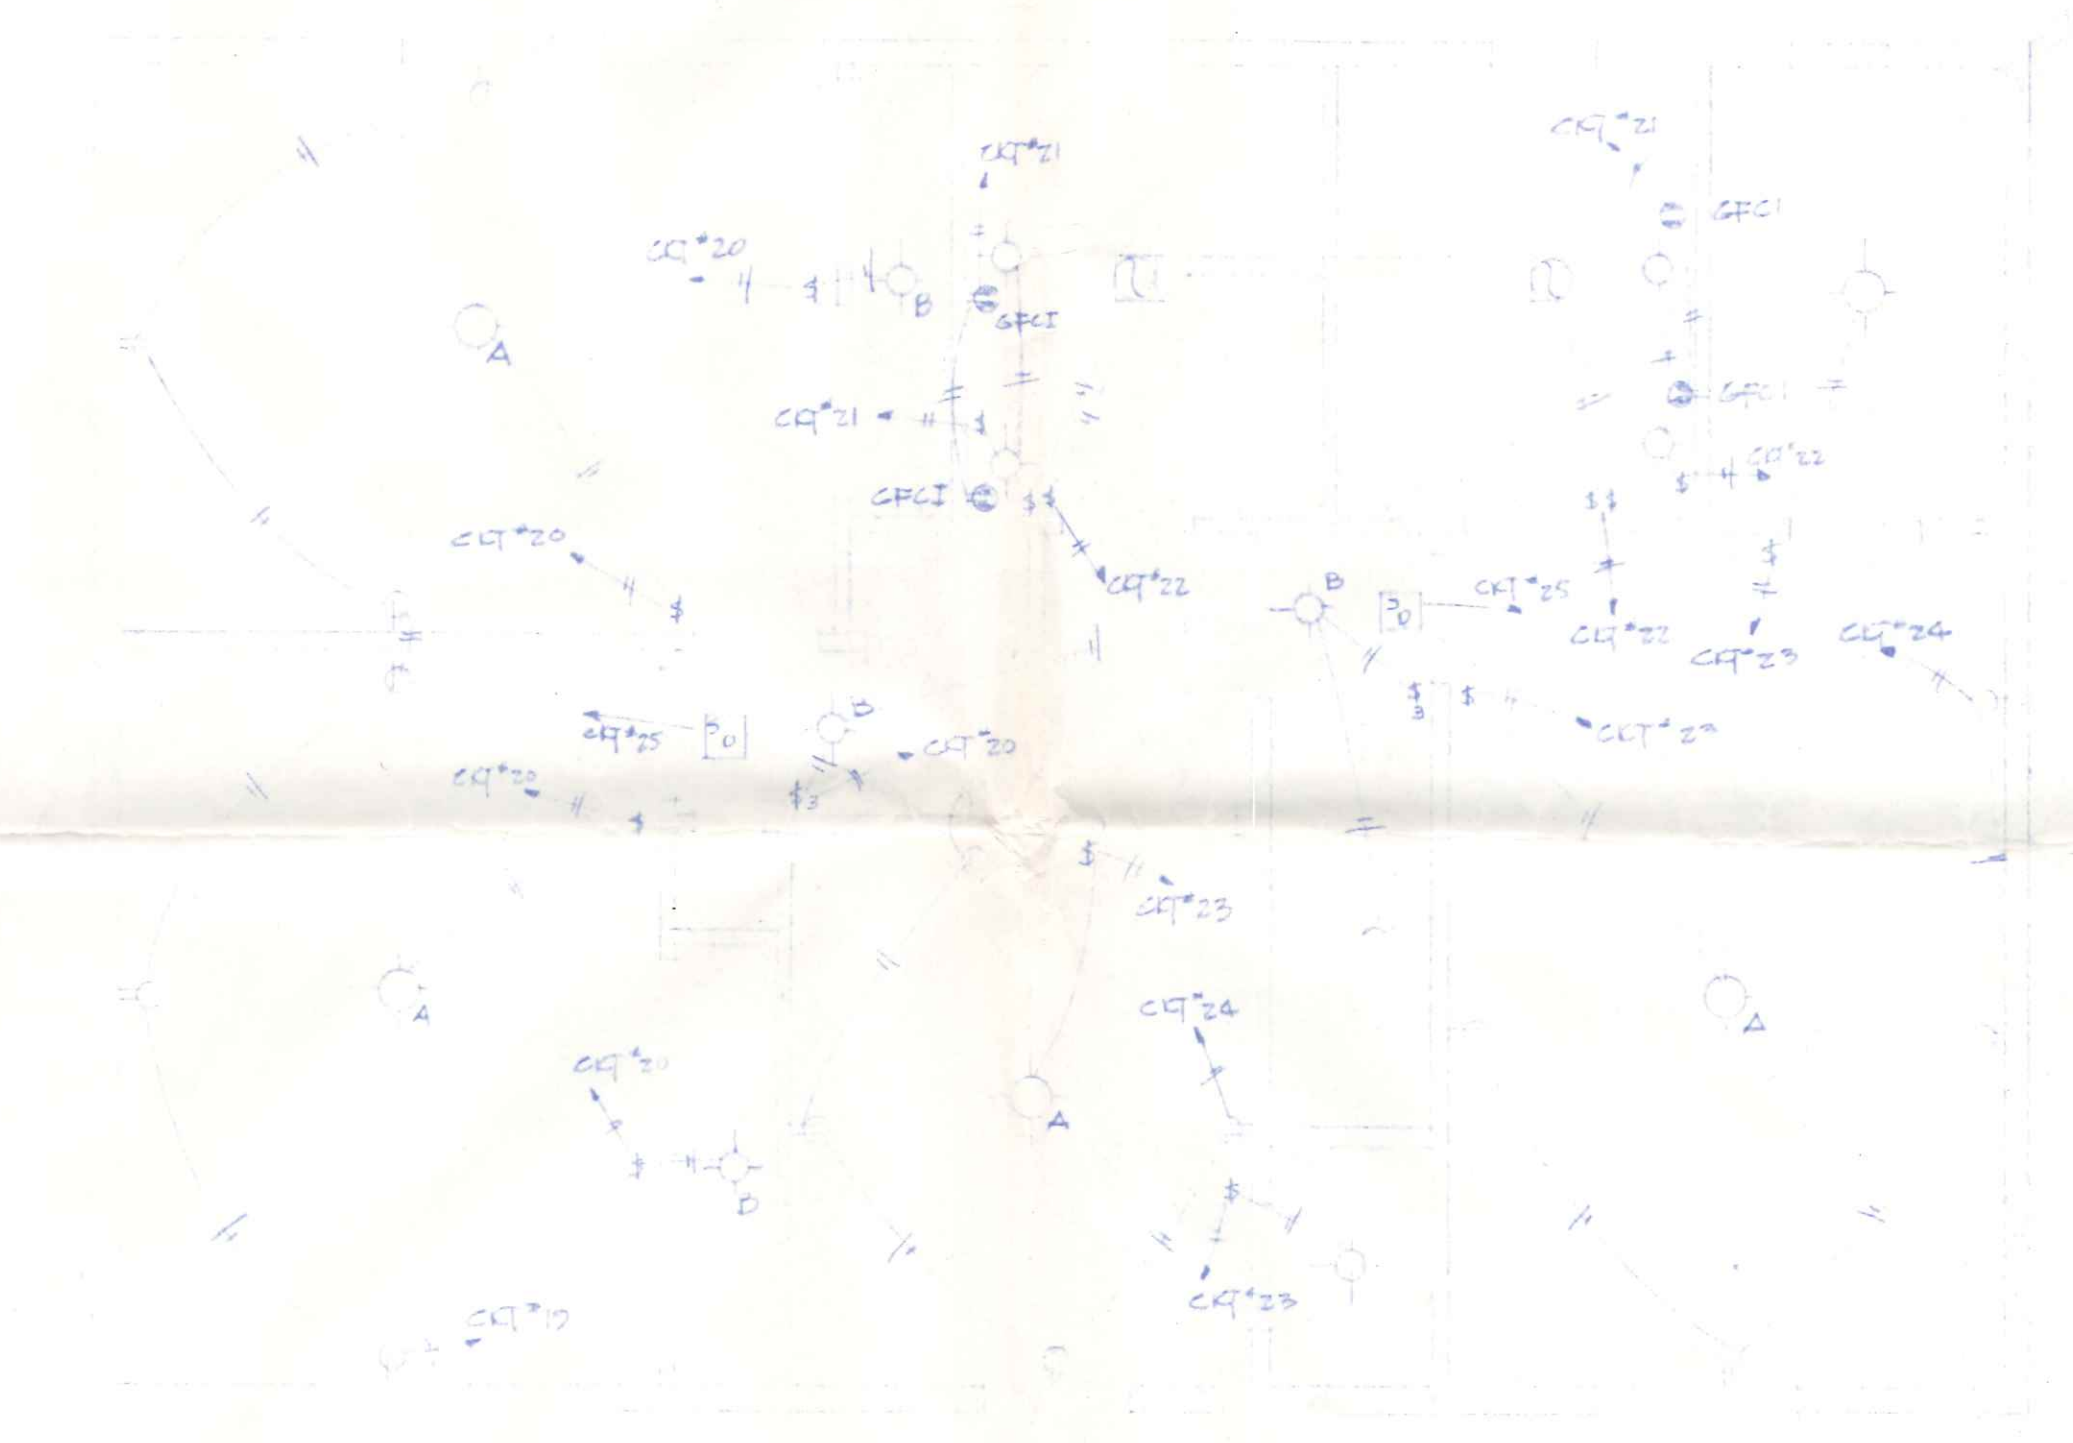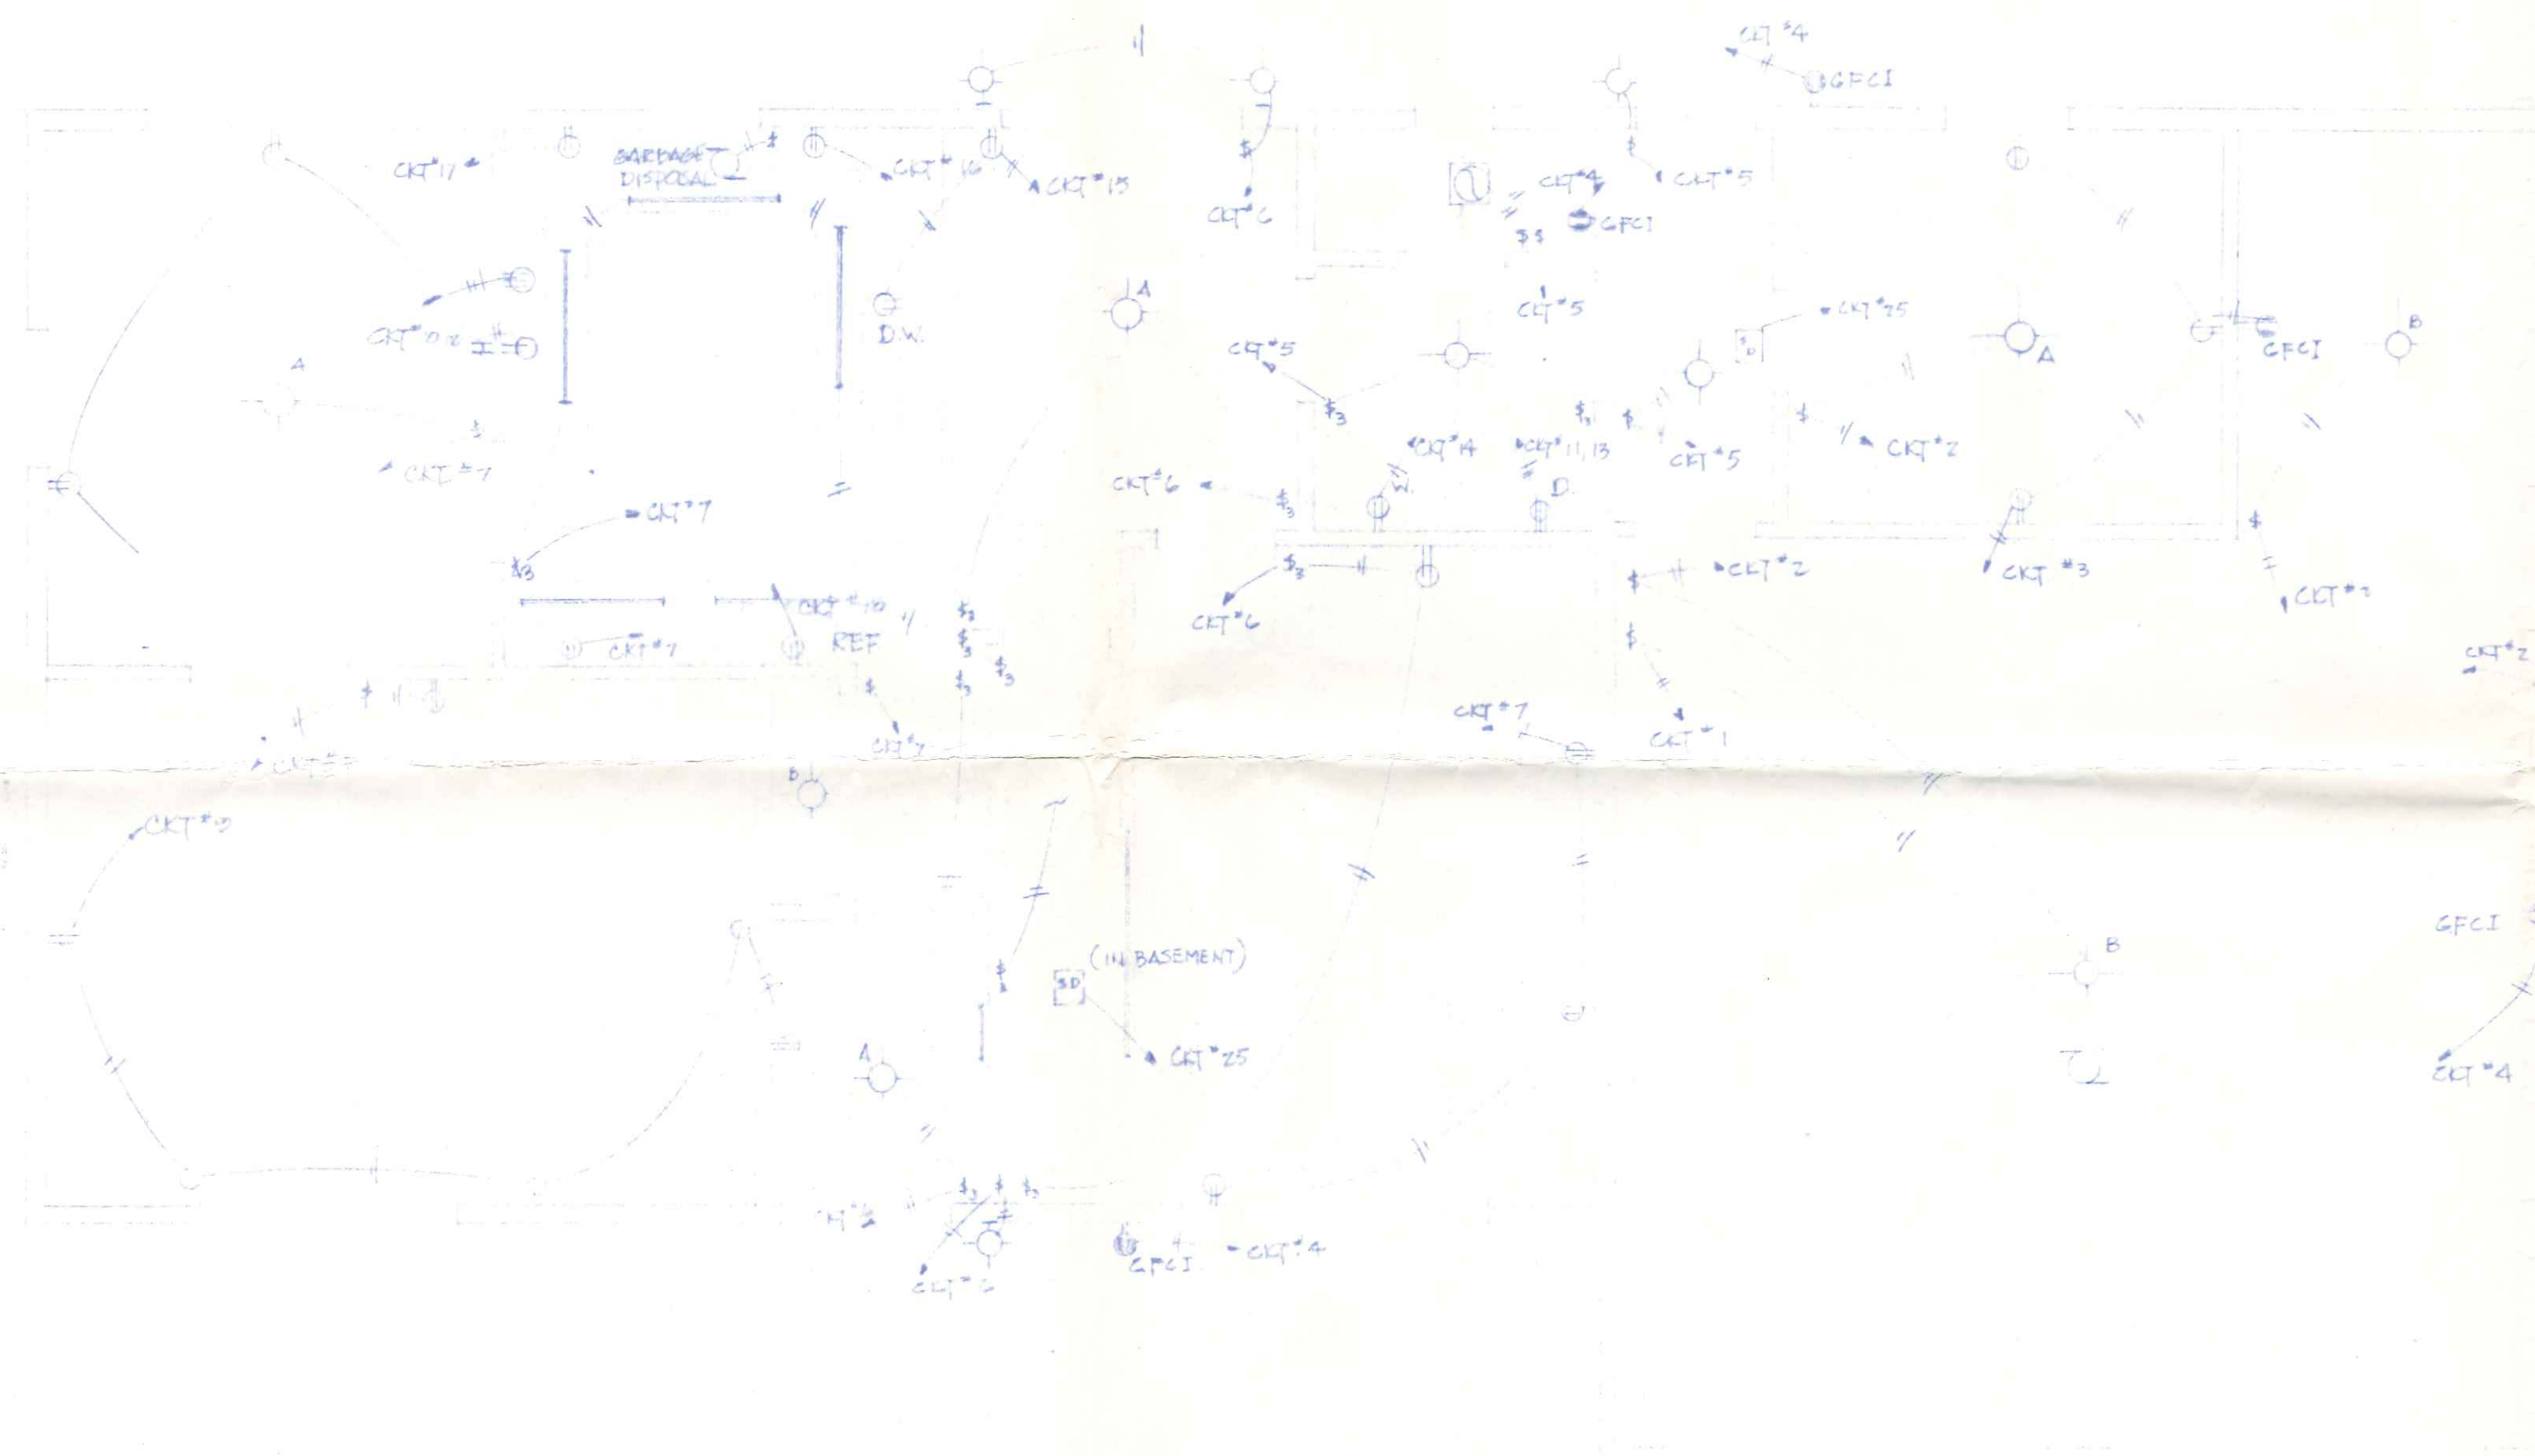

ELECTRICAL LEGEND	
	SINGLE POLE SWITCH
	THREE WAY SWITCH
	DUPLEX RECEPTACLE
	GROUND FAULT CIRCUIT INTERRUPTER RECP
	240 V RECEPTACLE
	4 40 W FLOURESCENT FIXTURE
	2 60 W LIGHT FIXTURE
	1 60 W LIGHT FIXTURE (CLG MOUNTED)
	1 60 W LIGHT FIXTURE (WALL MOUNTED)
	FAN-LIGHT COMB. w/ 100 W LAMP
	ELECTRICALLY OPER. SMOKE DETECTOR

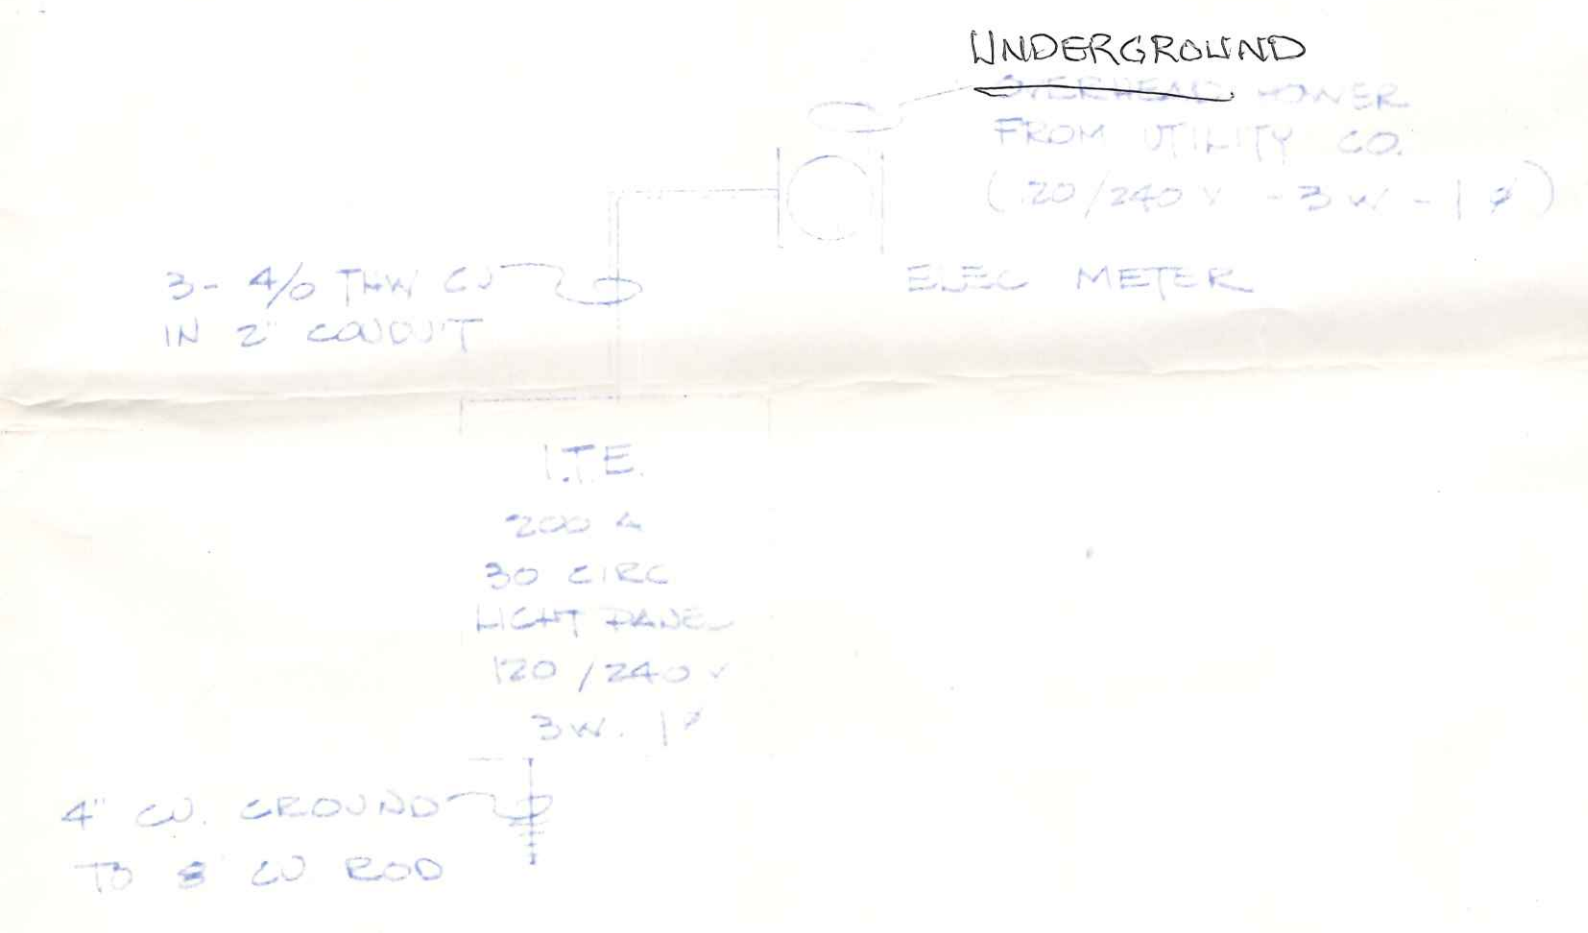

RISE R DIAGRAM

RALPH BADENHOP RESIDENCE		
SCALE:	APPROVED BY:	DRAWN BY:
DATE:		REVISED:
ROLAND UEMALINE & SON'S		
		DRAWING NUMBER: