



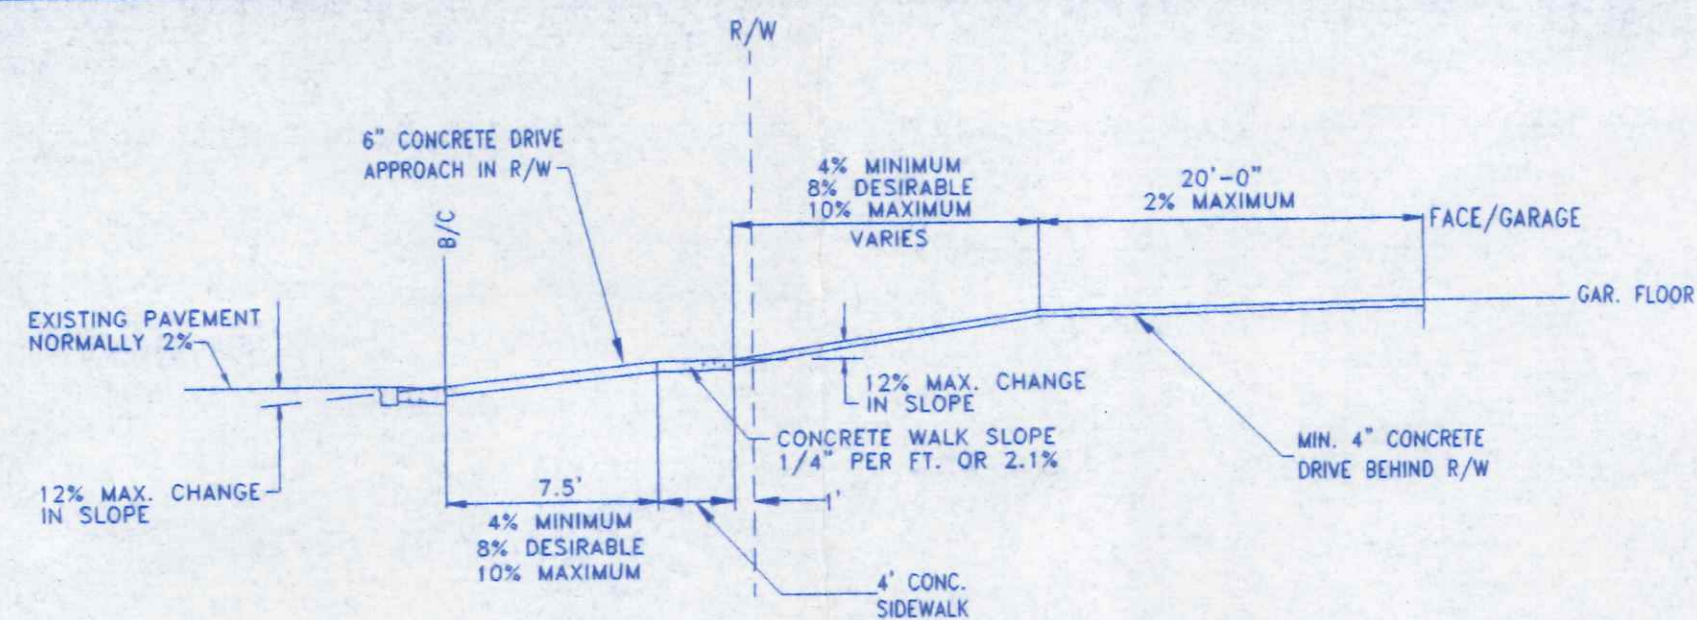

DRIVE APPROACH &
GARAGE ELEVATION DETAIL

PROJECT LOCATION


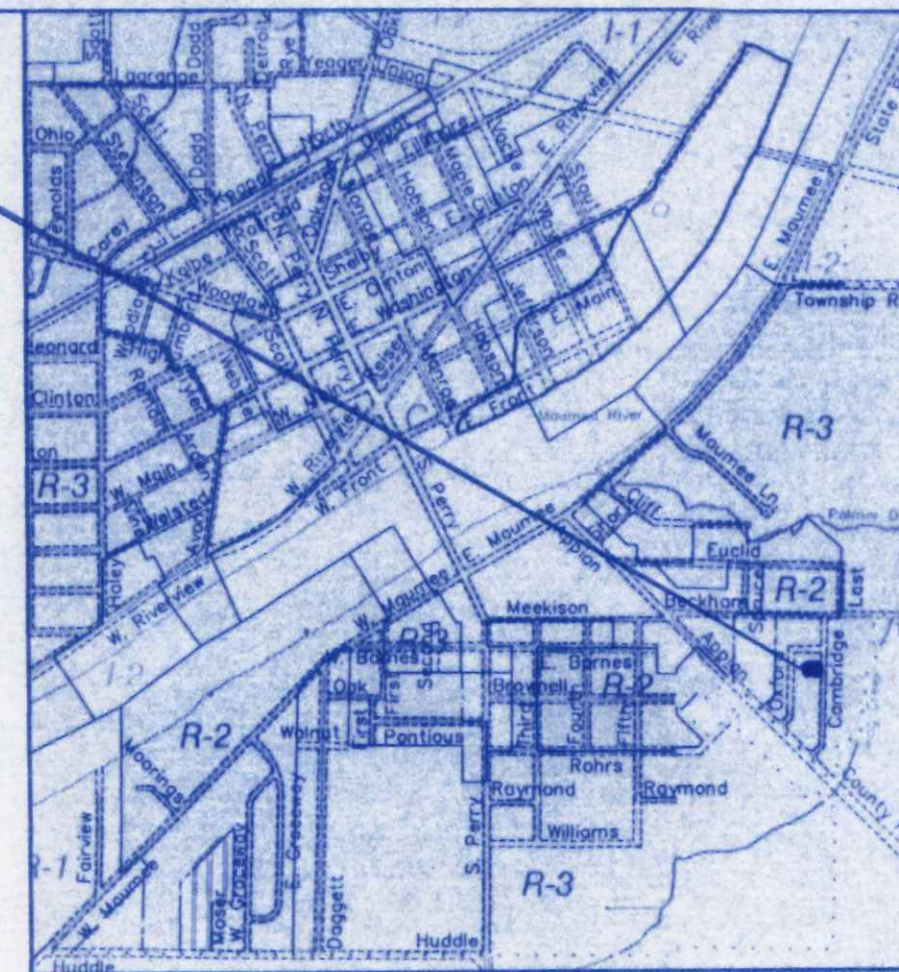


LOCATION MAP




OHIO UTILITIES PROTECTION SERVICE

The underground utilities shown hereon are only approximate. Some of the utilities were located by field observation, where possible, and the remaining utilities were derived from various records. Exact locations must be determined by the UTILITY COMPANIES. For exact locations, telephone the Ohio Utilities Protection Service (O.U.P.S.) toll free at 1-800-362-2764. (Telephone 2 working days before any digging.)

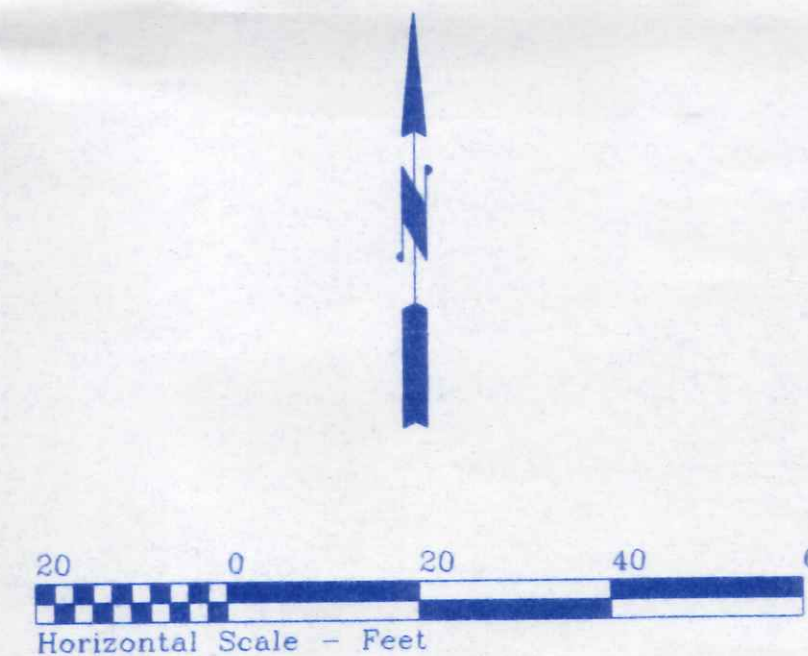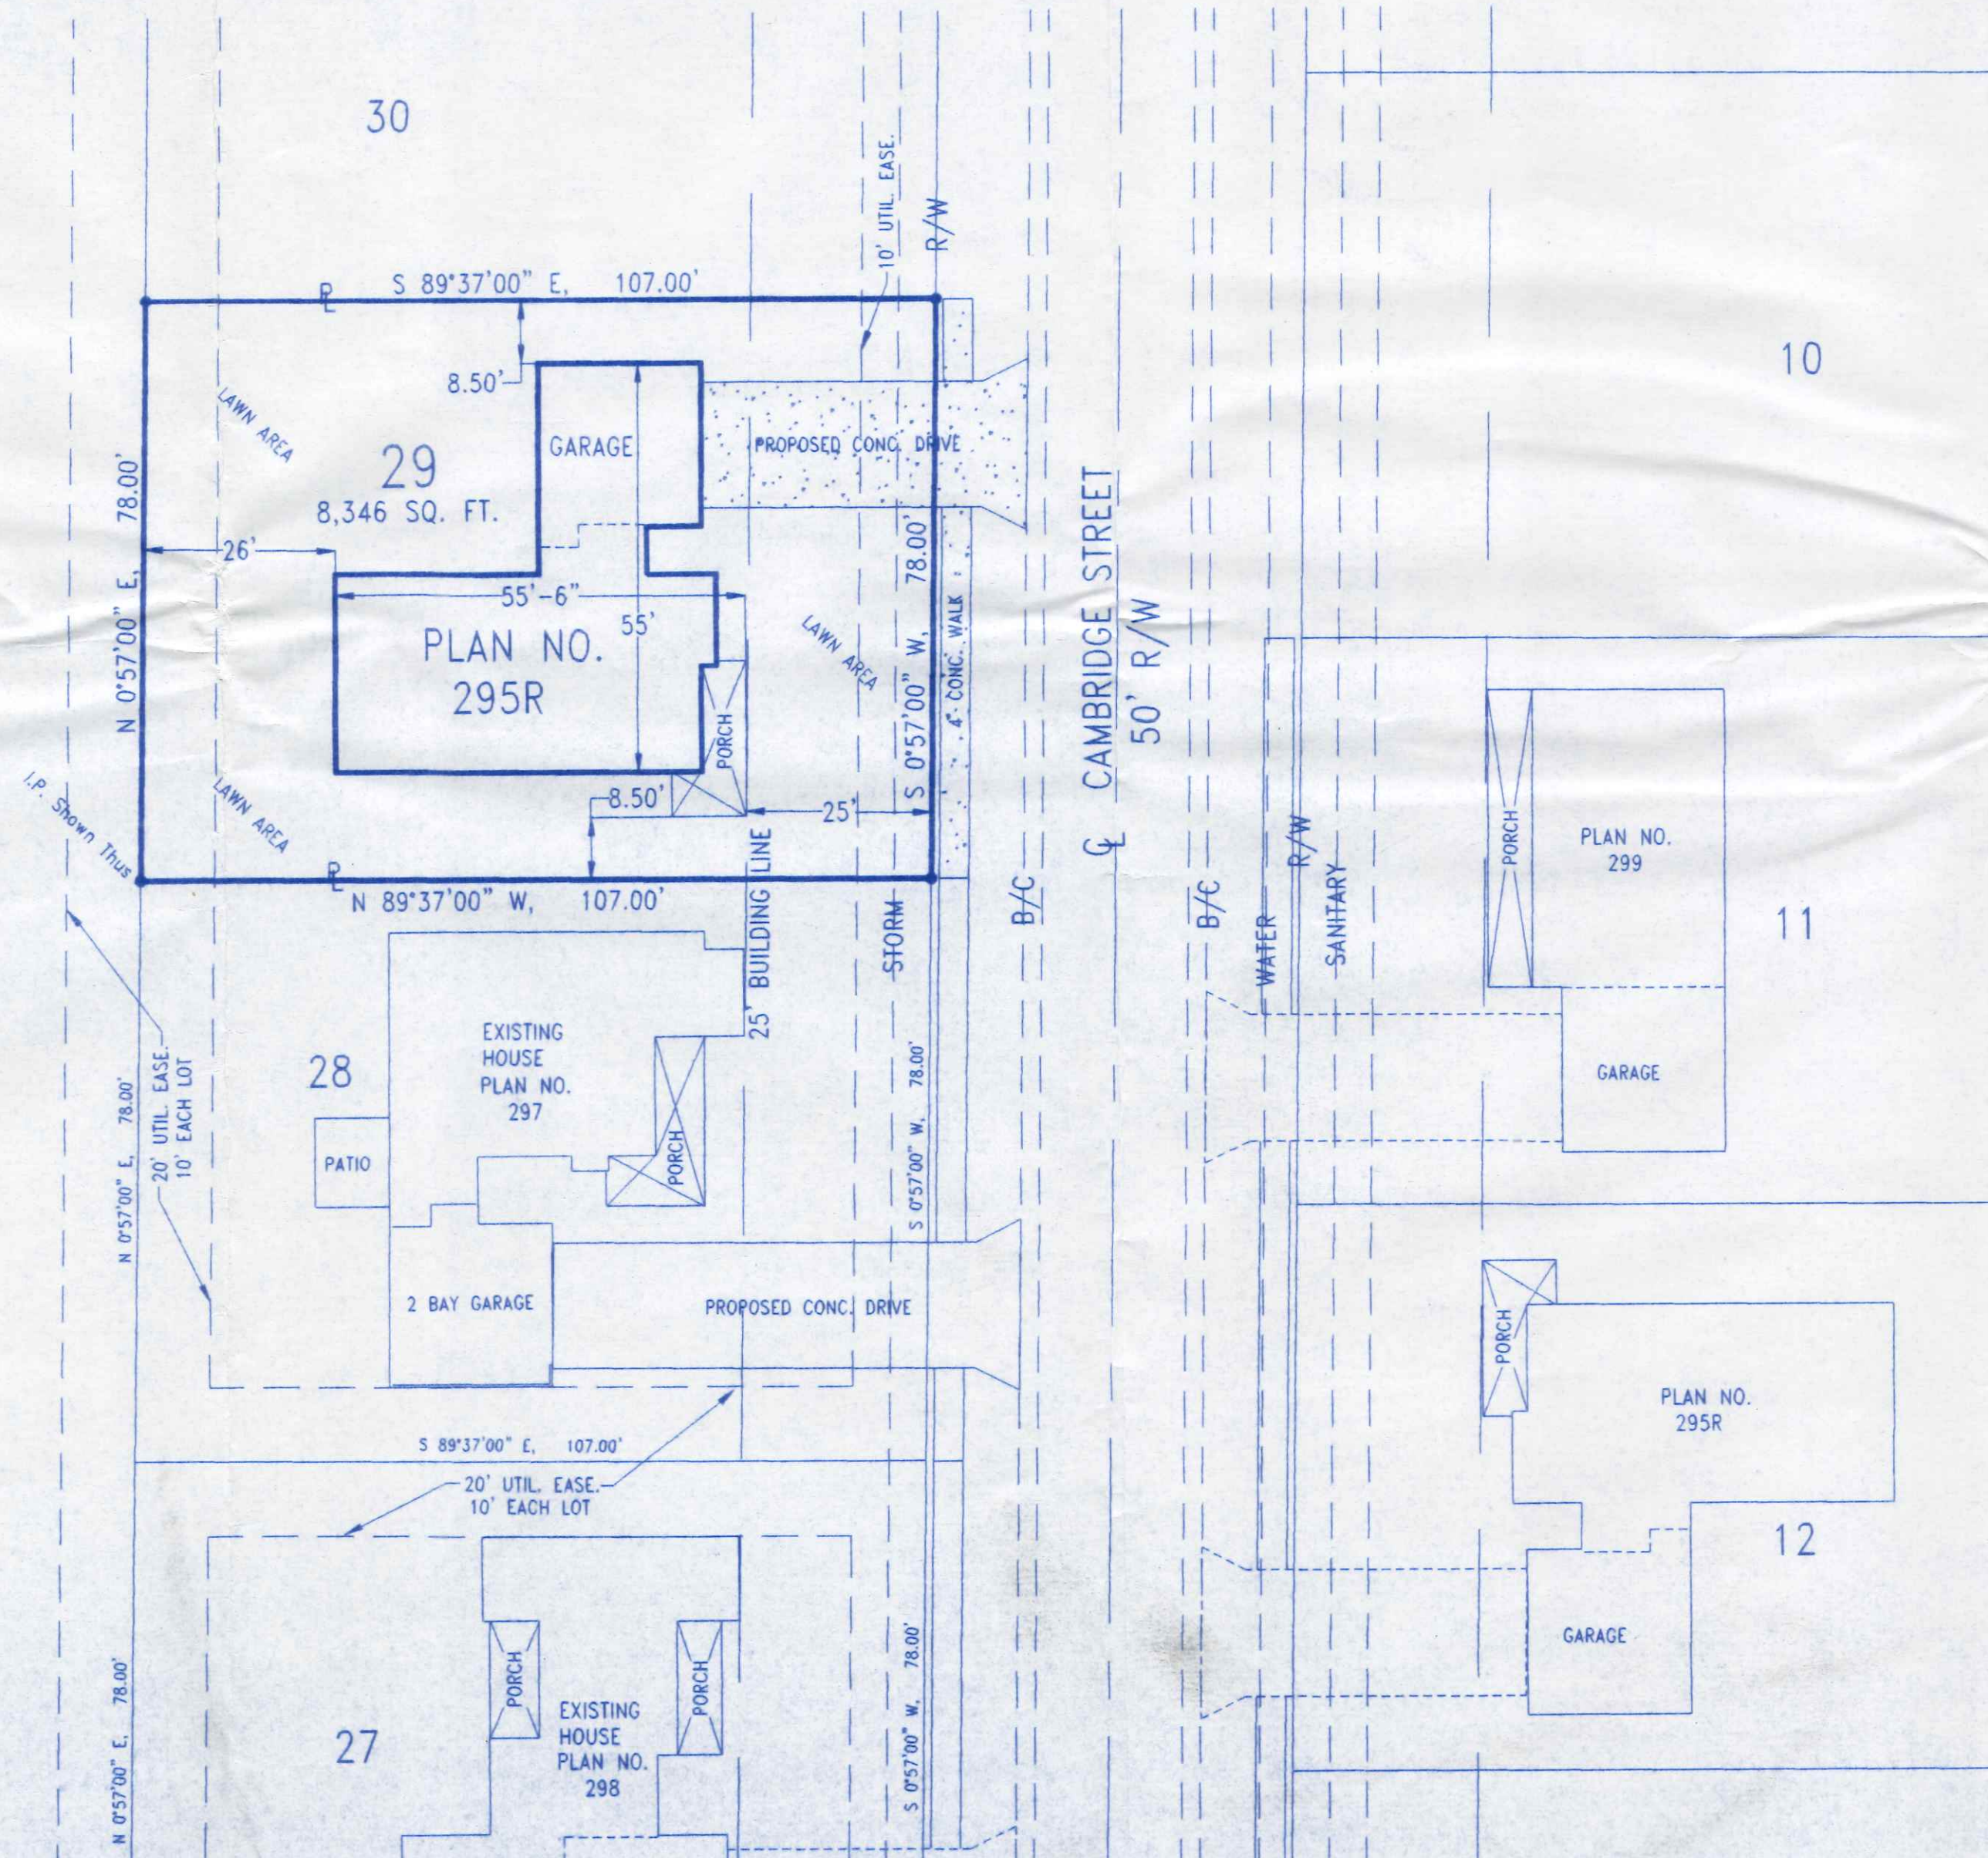


101,000.00
Butler Mohr-BML
SITE LOCATION PLAN Richard
FOR 485 Camb
LOT NO. 29
PICKETT FENCES SUBDIVISION, PHASE III
CITY OF NAPOLEON, NAPOLEON TWP.
HENRY COUNTY, OHIO

	BECK CONSTRUCTION	
	COUNTY ROAD M	419/592-8307
	DIRECTORY: C:\BECK\PICKETT FENCES	DRAWN BY:
	FILE NAME: LOTS 42-19	REVISED:
LOT 29, PICKETT FENCES		SCALE: 1" = 40'
SITE PLAN		DATE: NOV.
		DRAWING NO. S -

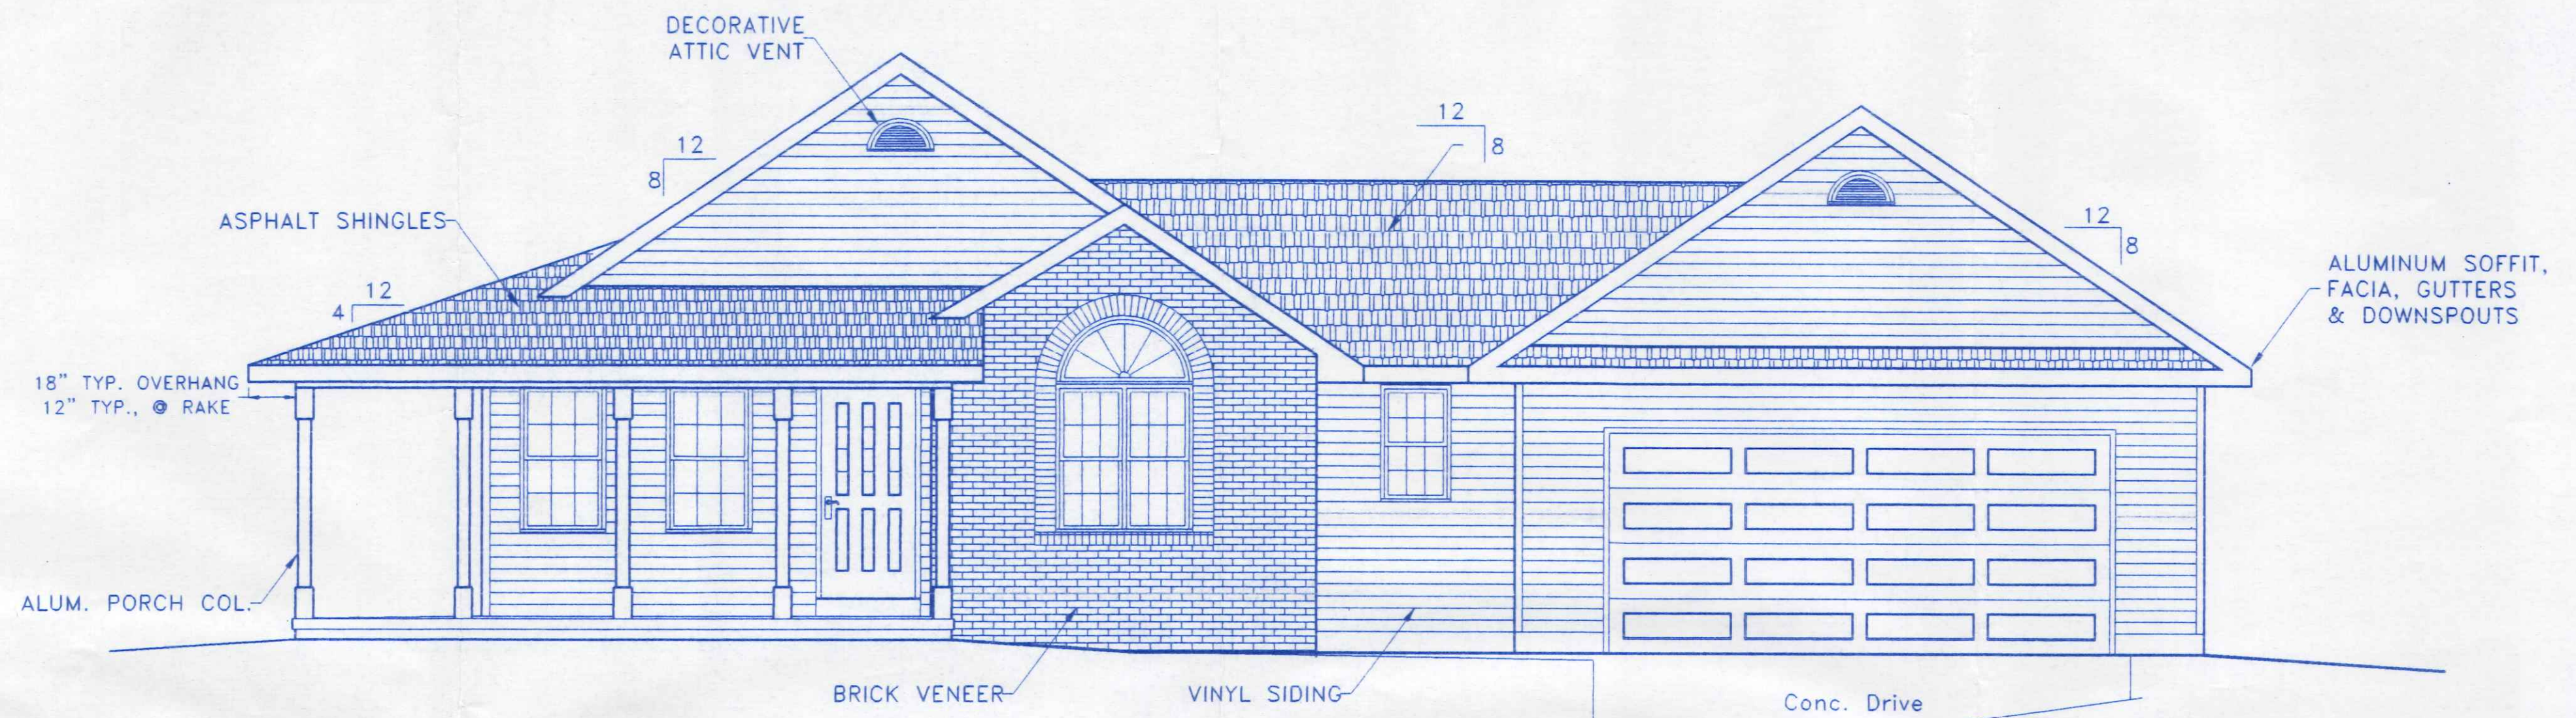


FRONT ELEVATION

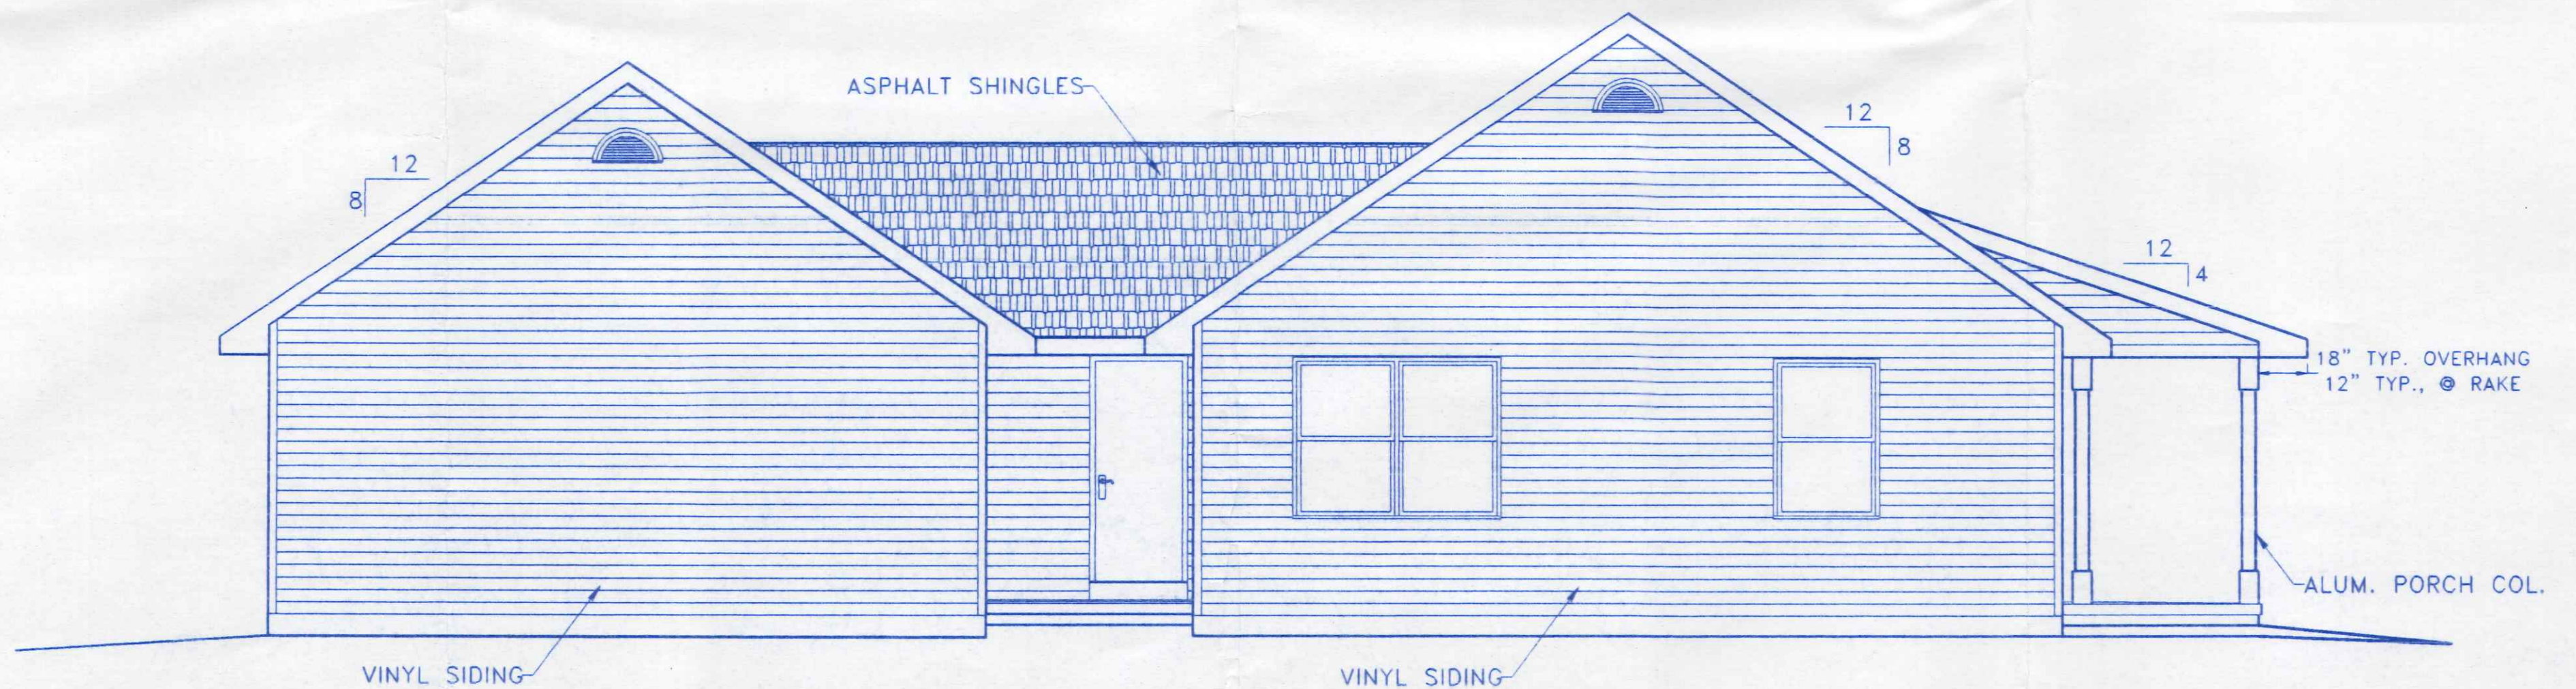


REAR ELEVATION

	BECK CONSTRUCTION CO. COUNTY ROAD M 419/592-8307 NAPOLEON, OHIO	
	DIRECTORY: C:\ND\BECK\SPEC\ FILE NAME: 295R	DRAWN BY: R.D.S. REVISED: SCALE: 1/4"=1'-0" DATE: MAY, 2002 DRAWING NUMBER: 1 of 5
PLAN NO. 295R		FRONT & REAR ELEVATIONS

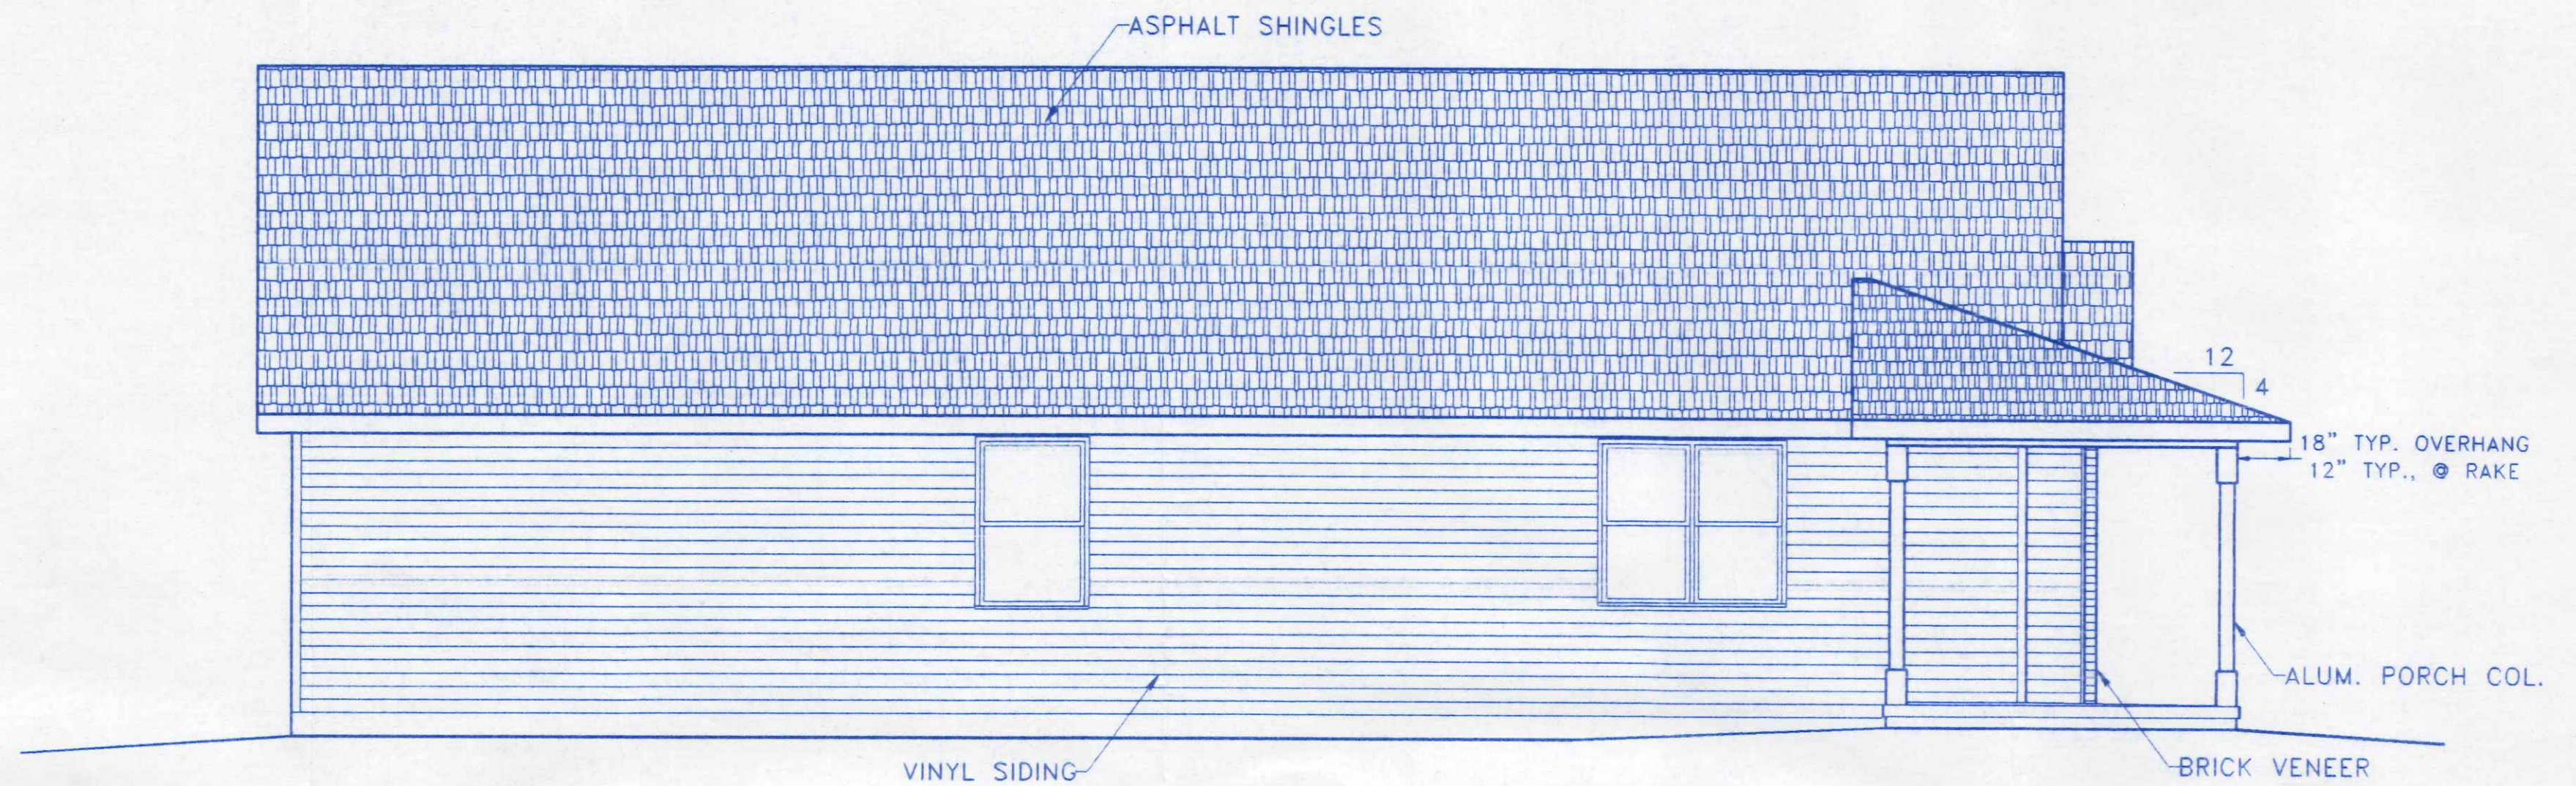

LEFT SIDE ELEVATION

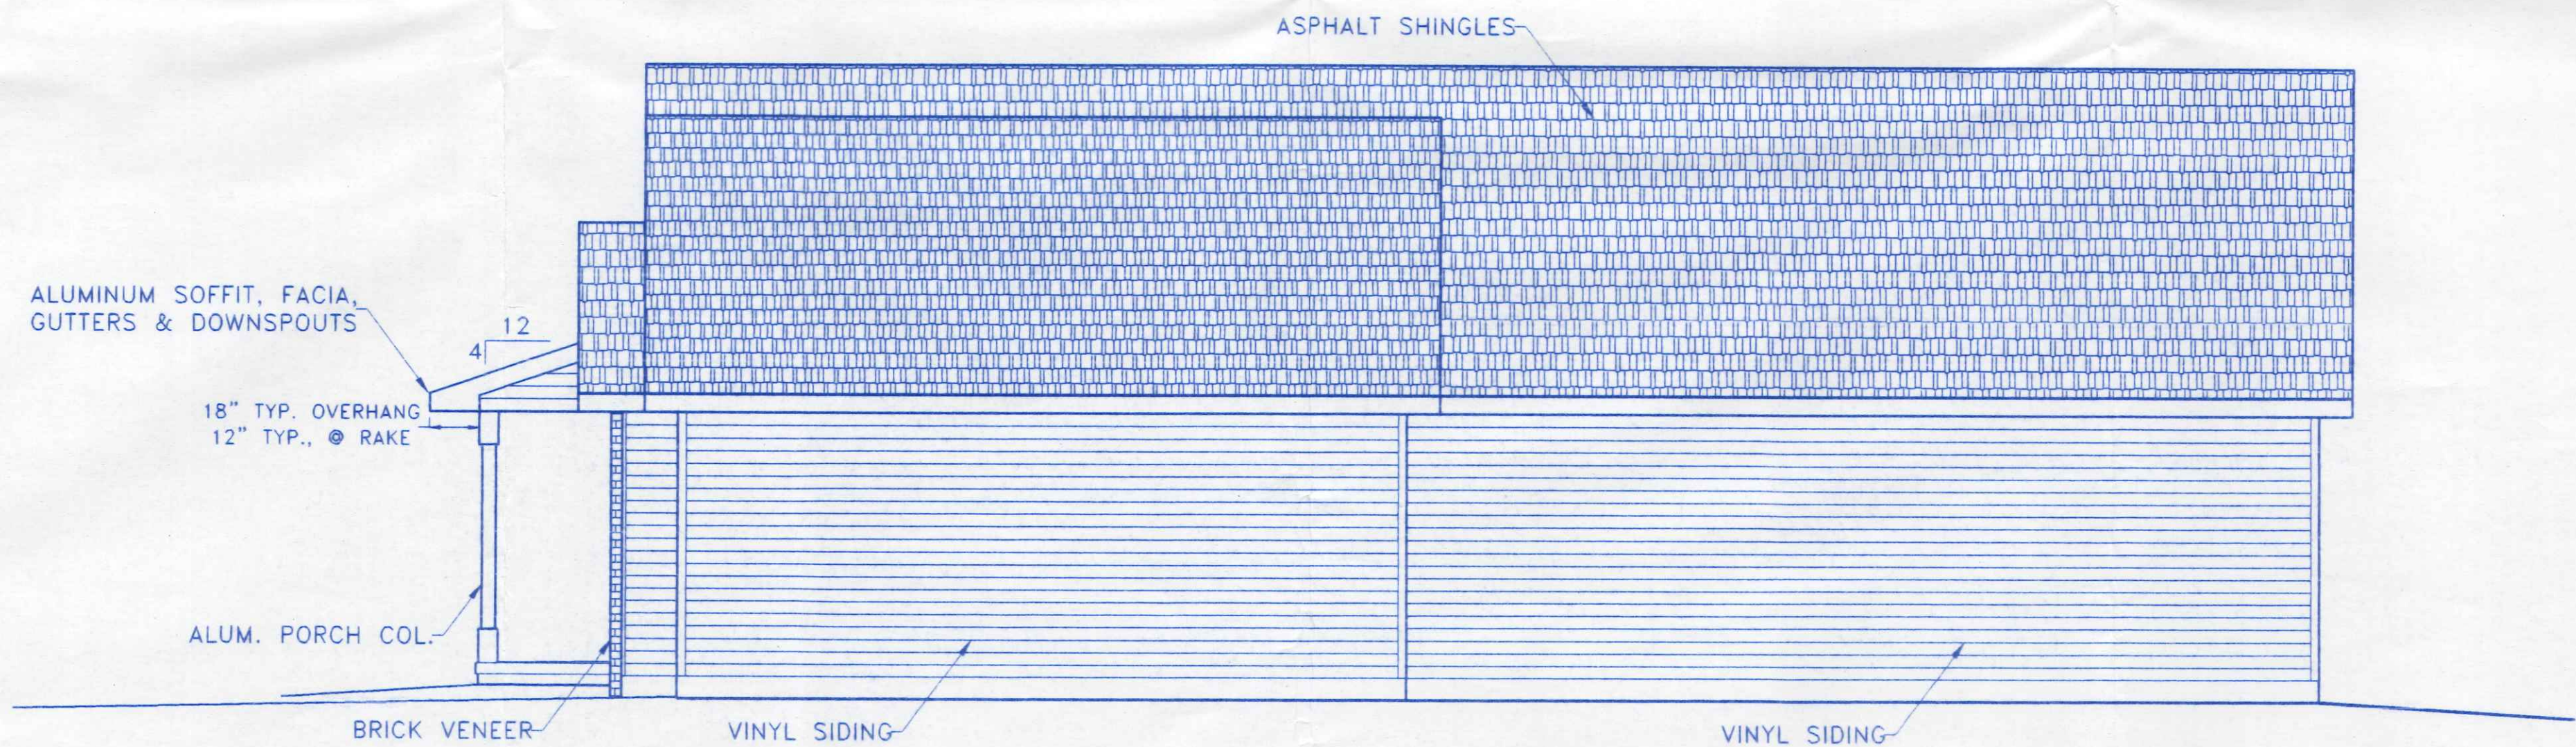


RIGHT SIDE ELEVATION

	BECK CONSTRUCTION CO COUNTY ROAD M 419/592-8307 NAPOLEON, OHIO	
	DIRECTORY: C:\ND\BECK\SPEC\ FILE NAME: 295R	DRAWN BY: R.D.S. REVISED:
	SCALE: 1/4"=1'-0" DATE: MAY, 2002 DRAWING NUMBER: 2 of 5	

PLAN NO. 295R

RIGHT & LEFT SIDE ELEVATIONS

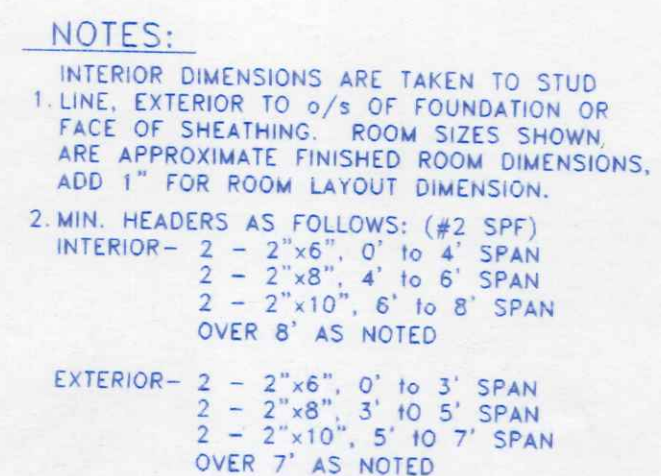

FLOOR PLAN

DRAWING NUMBER:

TYP., 8" CONC. BLOCK WALL ON 16"x8" CONC. FOOTING.

16"x8" CRAWL SPACE VENT, SHOWN THUS

16"x16" CONC. BLOCK PIER

4" MIN. OR AS NOTED

VISQUEEN VAPOR BARRIER OVER STONE

16" SQ. CONC. BLOCK PIER ON 30"x30"x10" CONCRETE FOOTING

8" CONC. BLOCK WALL ON 16"x8" CONC. FOOTING.

5-2"x8" WOOD GIRDER, #2 SYP.


5-2"x8" WOOD GIRDER, #2 SYP.

8" CONC. BLOCK WALL ON 16"x8" CONC. FOOTING.

2"x10" FLR. JST., TYP. @ 16" o/c, DOUBLE JOIST UNDER 6" WALL RETURN AND ALL PARALLEL PARTITIONS.

PORCH
4" CONC. SLAB ON MIN. 4" COMPACTED GRANULAR BASE


4" BRICK LEDGE

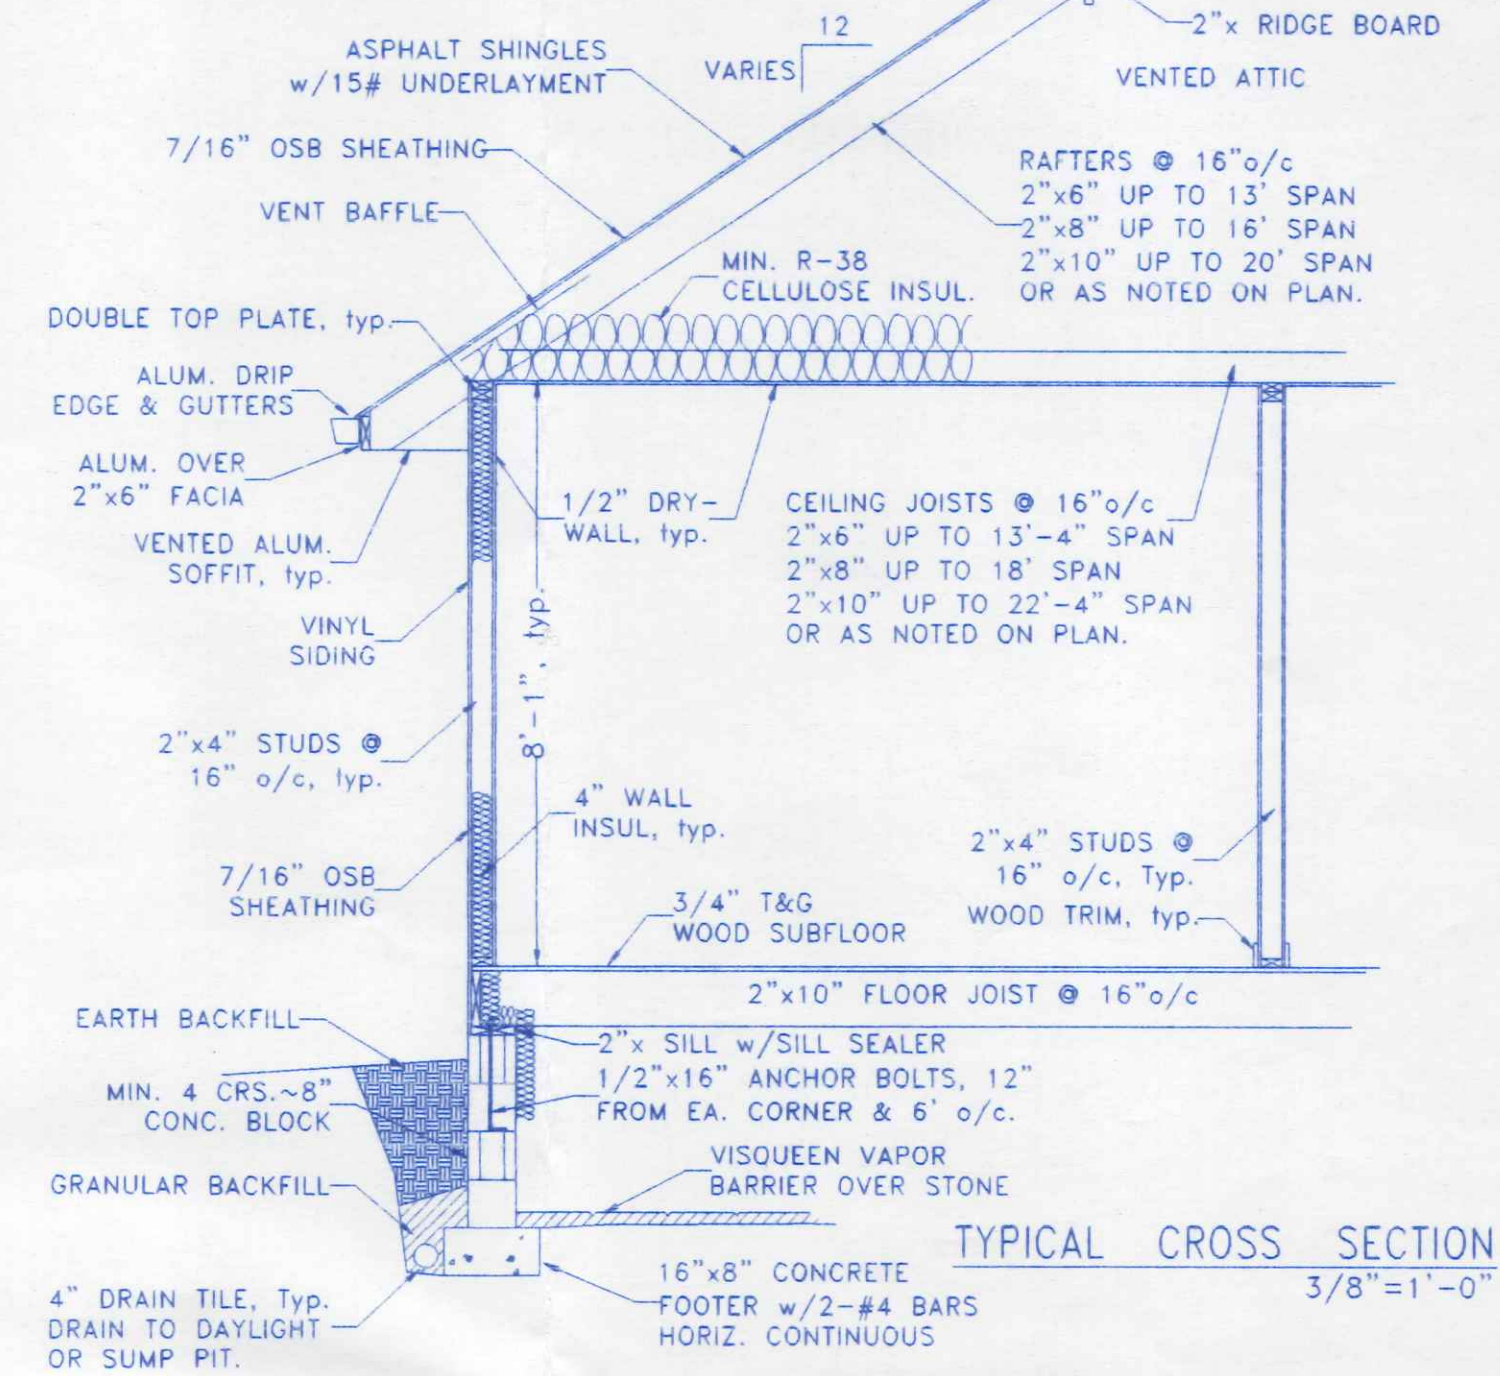



MIN. 4" CONCRETE SLAB FLOOR ON MIN. 4" COMPACTED GRANULAR BASE w/VISQUEEN VAPOR BARRIER. SAWN CONTROL JOINTS AS SHOWN.

CRAWL SPACE ACCESS OP'NG.

HOLD FNDN. WALL DOWN 8" @ ALL DOOR OPENINGS AND RUN CONC. FLOOR SLAB THRU.

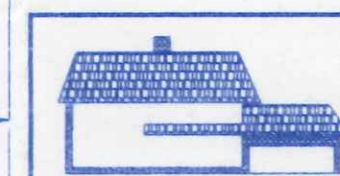

BECK CONSTRUCTION CO.		
COUNTY ROAD M	419/592-8307	NAPOLEON, OH
DIRECTORY: C:\ND\BECK\SPEC\	DRAWN BY: R.D.S.	
FILE NAME: 295R	REVISED:	
PLAN NO. 295R		SCALE: 1/4"=1'-0"
FOUNDATION PLAN & TYPICAL SECTION		DATE: MAY, 2002
		DRAWING NUMBER: 4 of 5

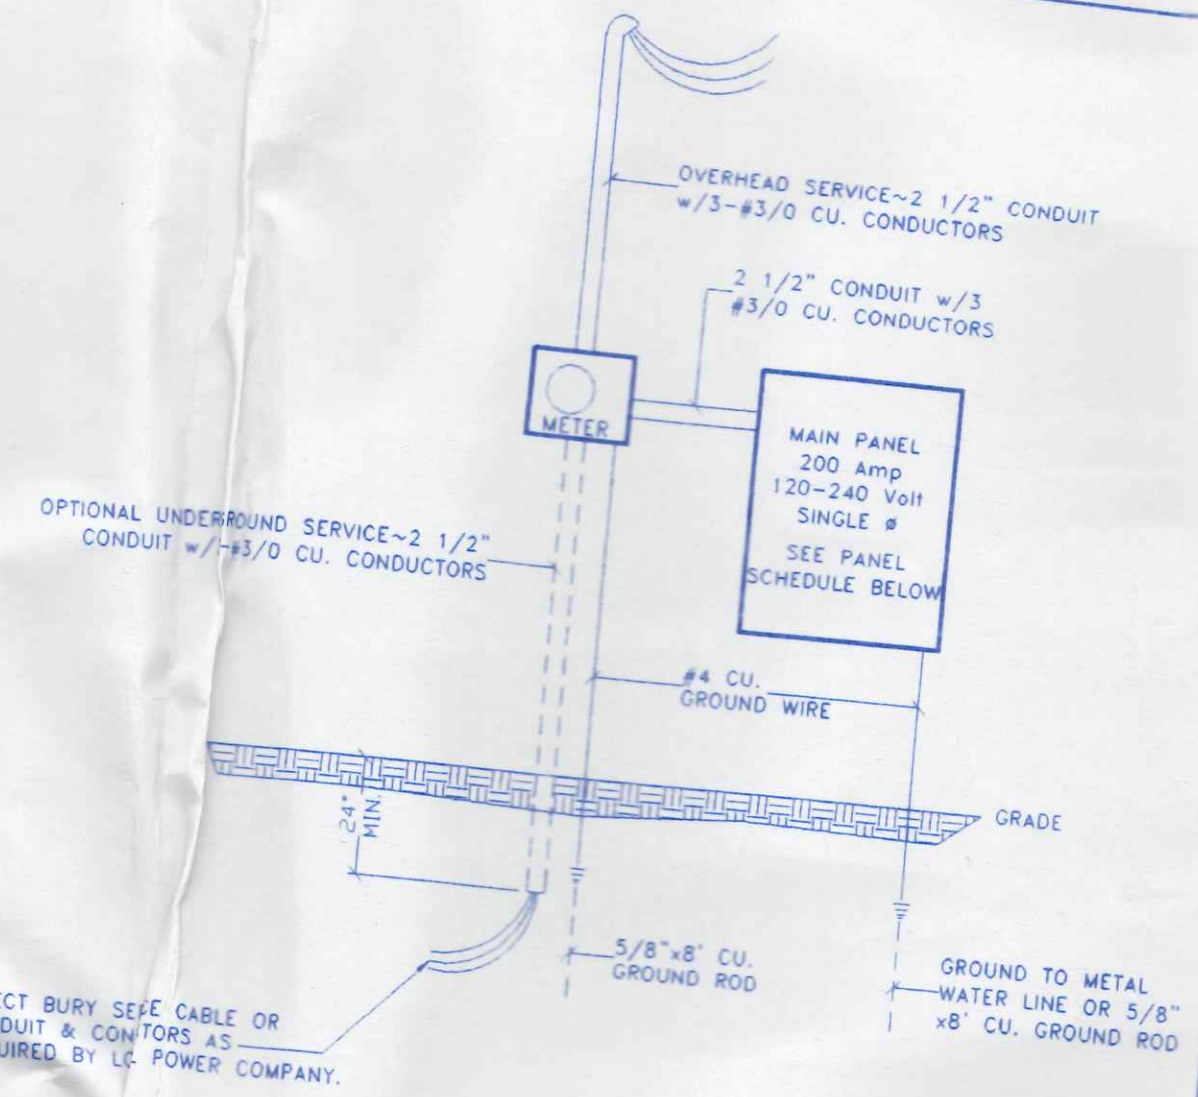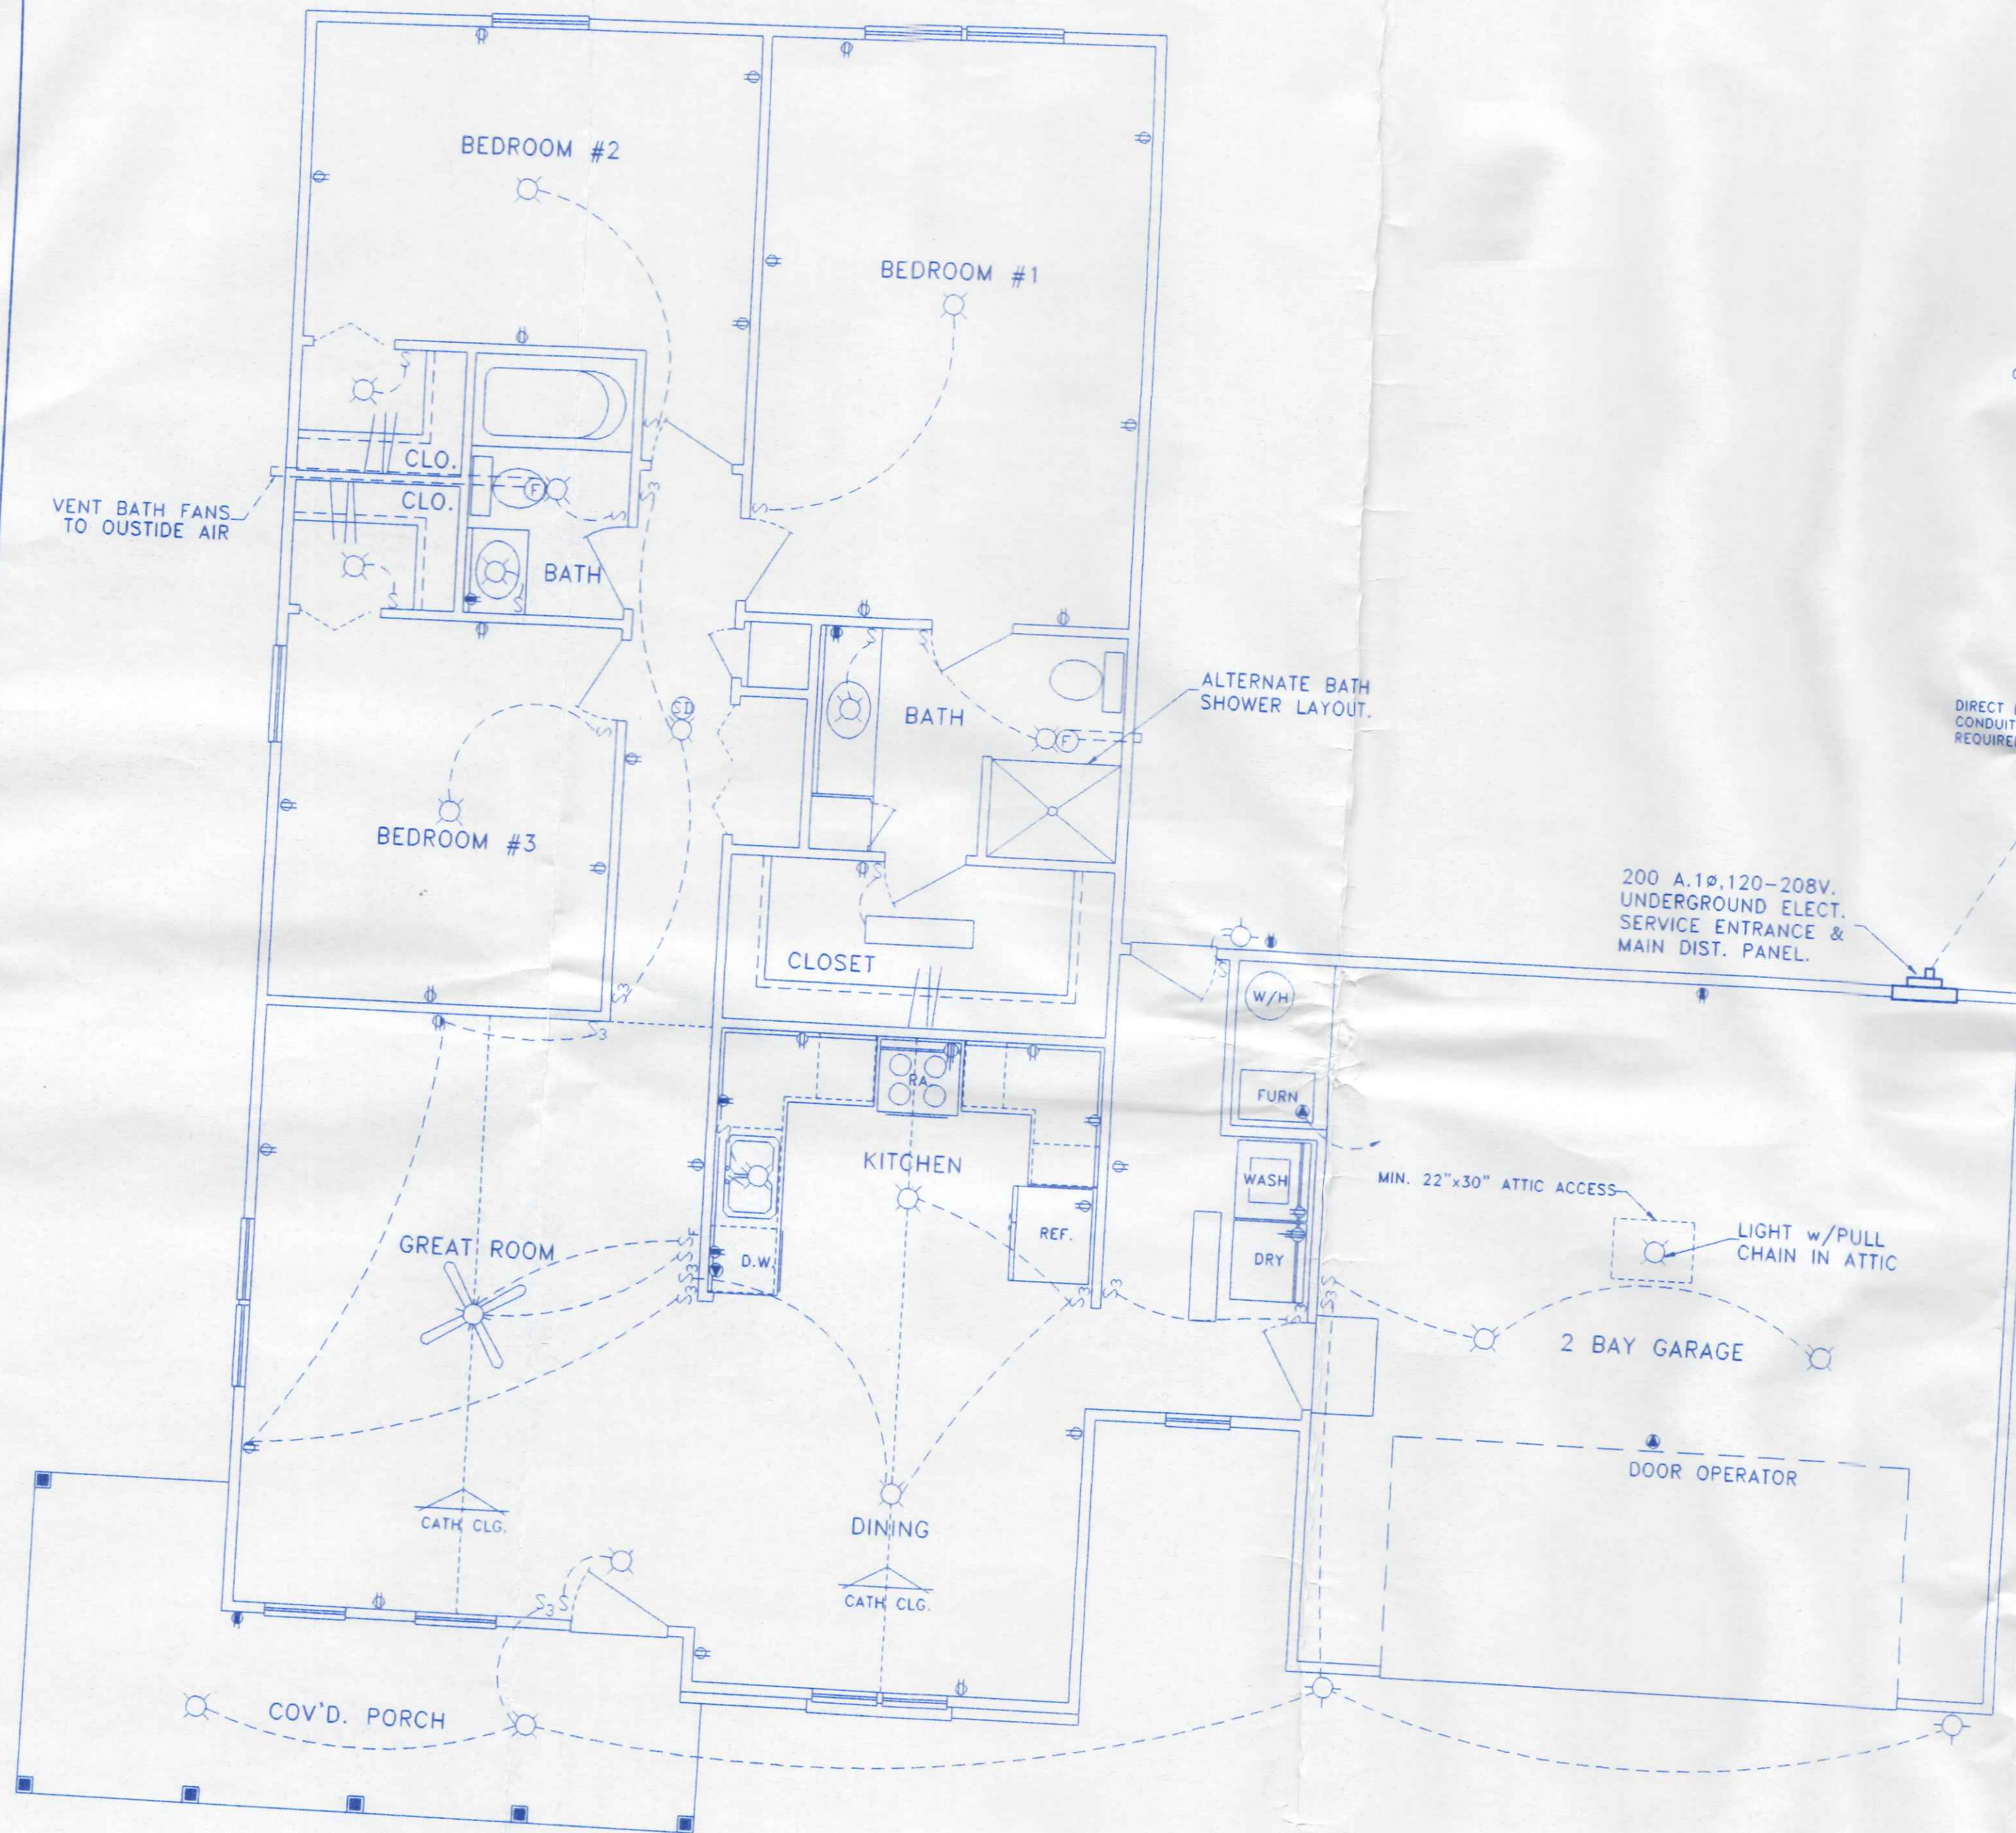

ELECTRICAL LEGEND

- 2 TUBE FLUORESCENT LIGHT
- INCANDESCENT CEILING LIGHT FIXTURE
- INCANDESCENT WALL MOUNT LIGHT FIXTURE
- S LIGHT OR FAN SWITCH
- S₃ 3 WAY LIGHT SWITCH
- S_F FAN SWITCH
- 120 V. OUTLET G.F.C.I.
- 120 V. DUPLEX RECEPTICLE
- 208 V. APPLIANCE RECEPTICLE
- APPROVED SMOKE DETECTOR
- SPECIAL OUTLET
- EXHAUST FAN
- VENT BATH FANS TO OUTSIDE AIR

GENERAL NOTES

- 1) ALL WORK AND MATERIALS SHALL BE IN ACCORDANCE WITH THE LATEST EDITION OF THE N.E.C. AND ALL LOCAL REGULATIONS.
- 2) PROVIDE G.F.C.I. PROTECTED OUTLETS AT RECEPTICLES IN BATHS, NEAR KITCHEN SINK, OUTDOORS & IN GARAGE AREA.

BECK CONSTRUCTION CO. COUNTY ROAD M 419/592-8307 NAPOLEON, OHIO	
DIRECTORY: C:\ND\BECK\SPEC\	DRAWN BY: R.D.S.
FILE NAME: 295R	REVISED:
AN NO. 295R	SCALE: NOTED
ELECTRICAL PLAN	DATE: MAY, 2002
	DRAWING NUMBER: 5 of 5