


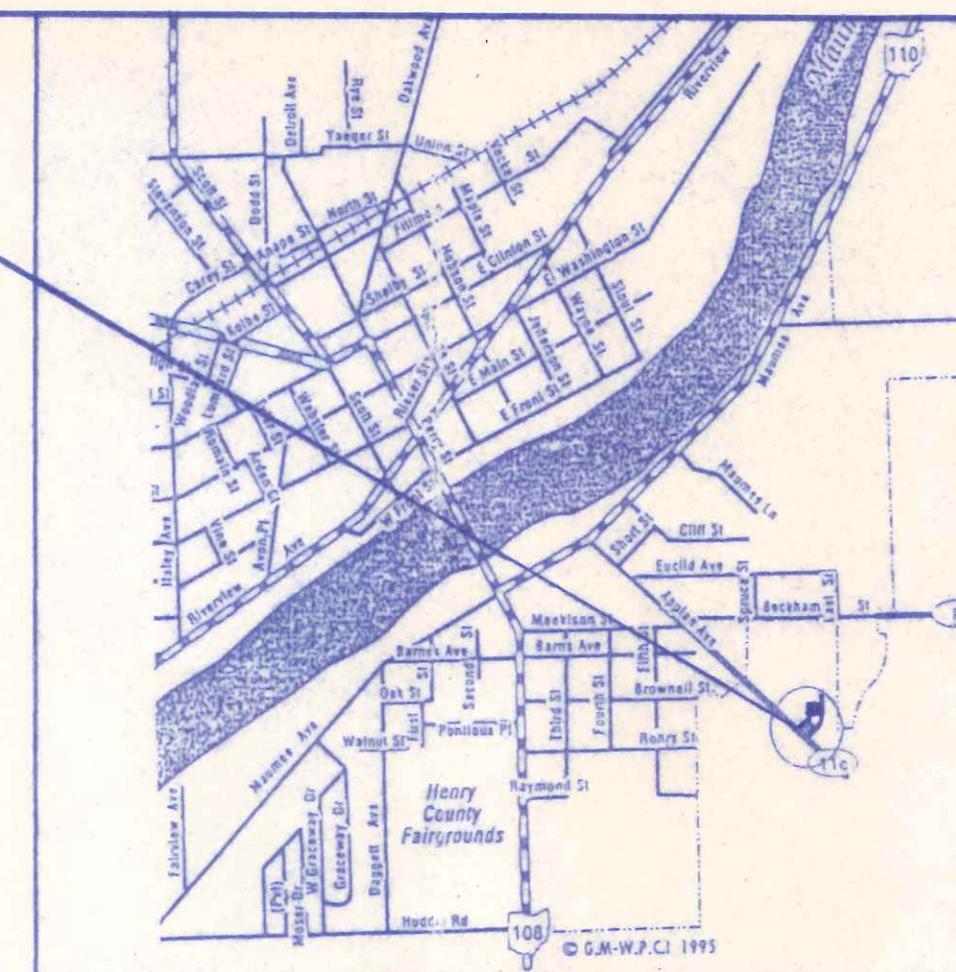


LOCATION MAP



OHIO UTILITIES PROTECTION SERVICE

The underground utilities shown herein are only approximate. Some of the utilities were located by field observation, where possible, and the remaining utilities were derived from various records. Exact locations must be determined by the UTILITY COMPANIES. For exact locations, telephone the Ohio Utilities Protection Service (O.U.P.S.) toll free at 1-800-362-2764. (Telephone 2 working days before any digging.)

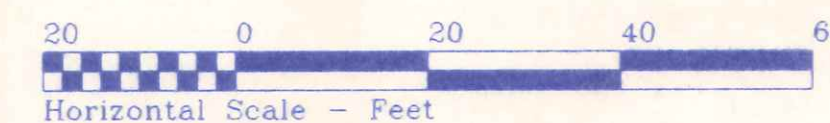


99207

SITE LOCATION PLAN

FOR

LOT NO. 24

PICKETT FENCES SUBDIVISION
CITY OF NAPOLEON, NAPOLEON TWP.
HENRY COUNTY, OHIO

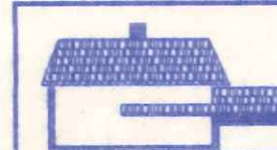

BECK CONSTRUCTION CO

COUNTY ROAD M 419/592-8307 NAPOLEON, OHIO

DIRECTORY: C:\BECK\PICKETT\FENCES DRAWN BY: R.D.S.

DIRECTORY: D:\DECK\MORE PLENES	DRAWN BY: MCM
FILE NAME: LOTS 43-19	REVISED:

LOT 24, PICKETT FENCES


SITE PLAN 585 Cambridge

SCALE: 1" = 20'

DATE: MAY 1999

DATE: MAY, 1999

DRAWING NUMBER:
S - 1

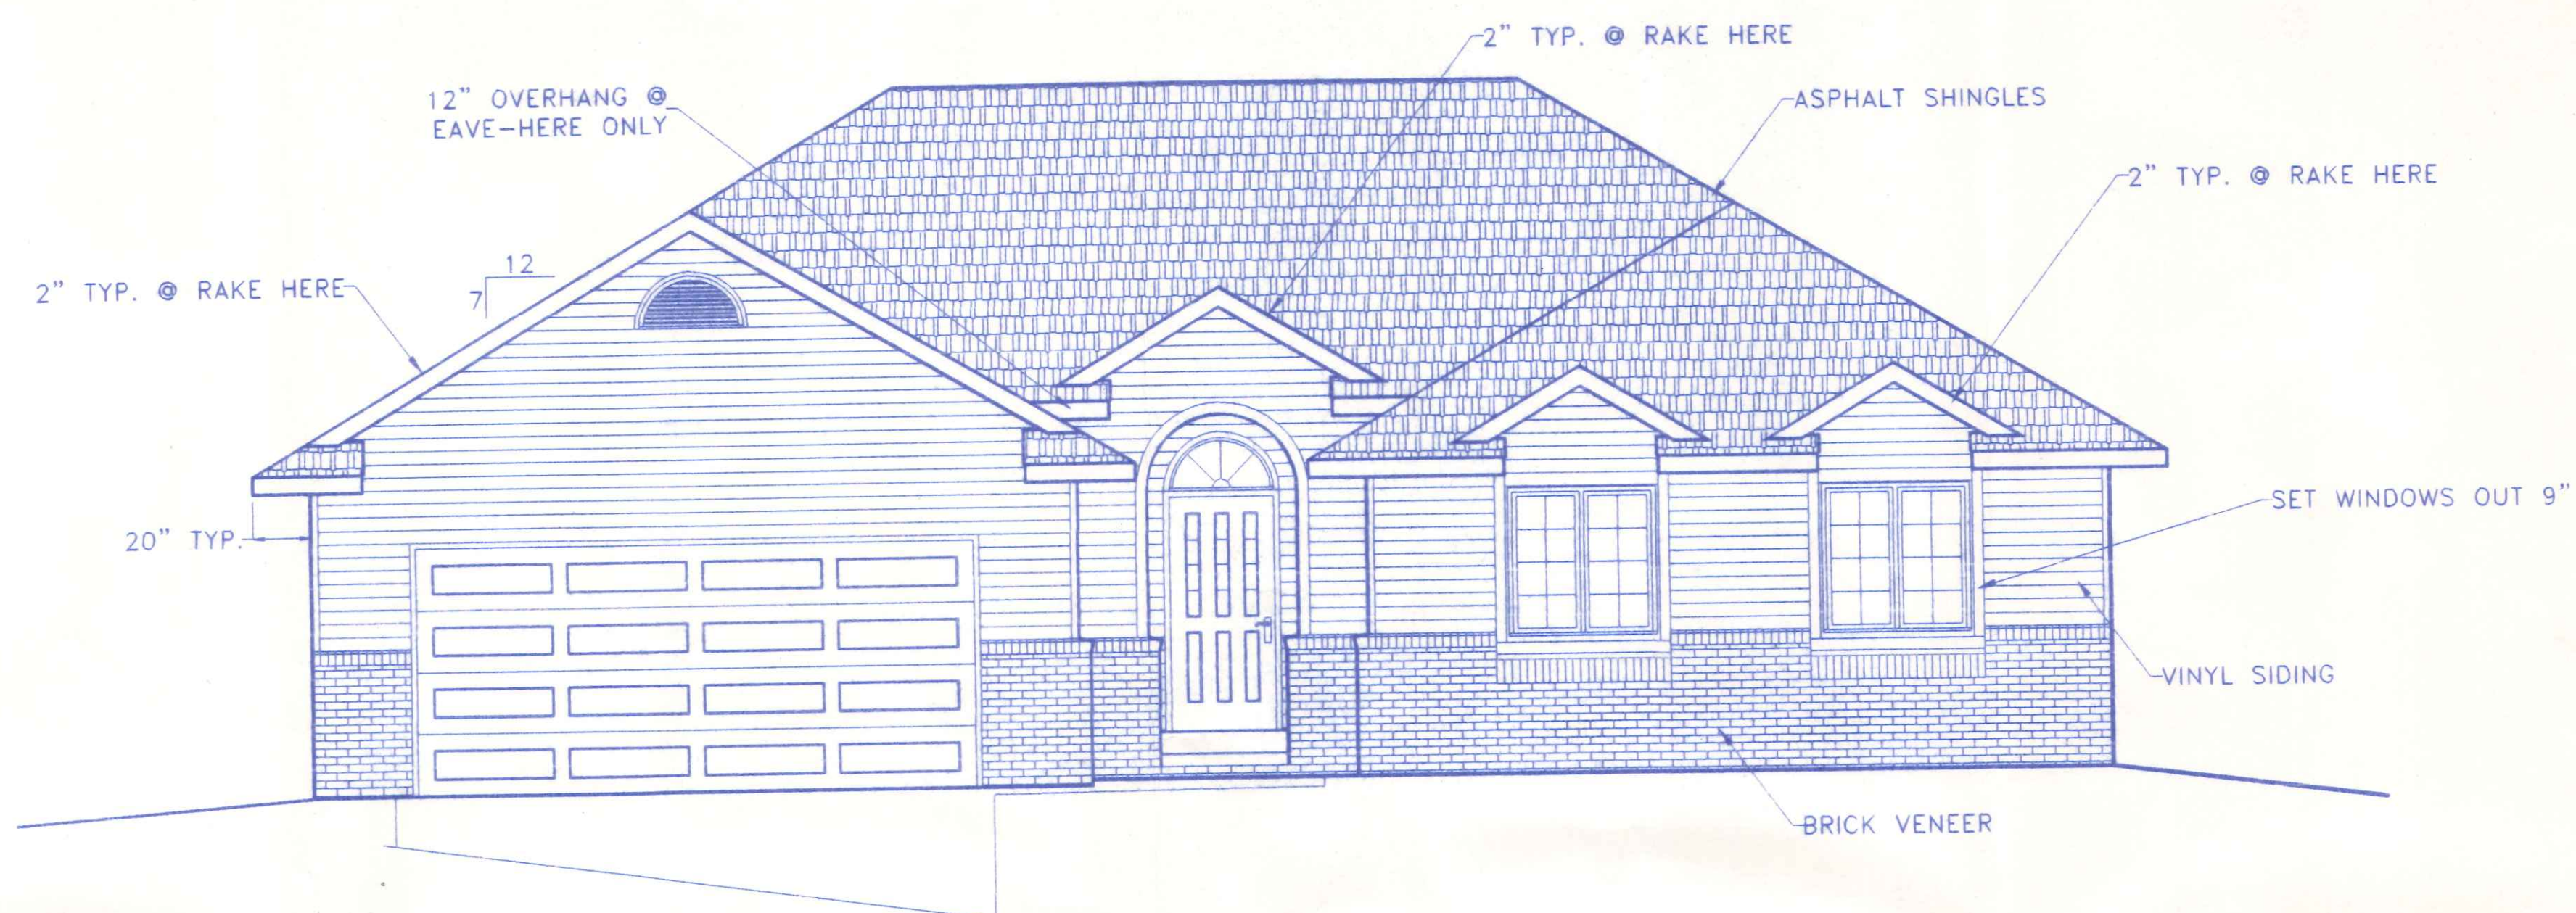


FRONT ELEVATION




REAR ELEVATION

	BECK CONSTRUCTION CO COUNTY ROAD M 419/592-8307 NAPOLEON, OHIO		
	DIRECTORY: C:\ND\BECK\SPEC\	DRAWN BY: R.D.S.	
	FILE NAME: 286	REVISED:	
	SCALE: 1/4"=1'-0"		
	DATE: APRIL, 1999		
PLAN NO. 286		DRAWING NUMBER:	
FRONT & REAR EXTERIOR ELEVATIONS		1 of 5	

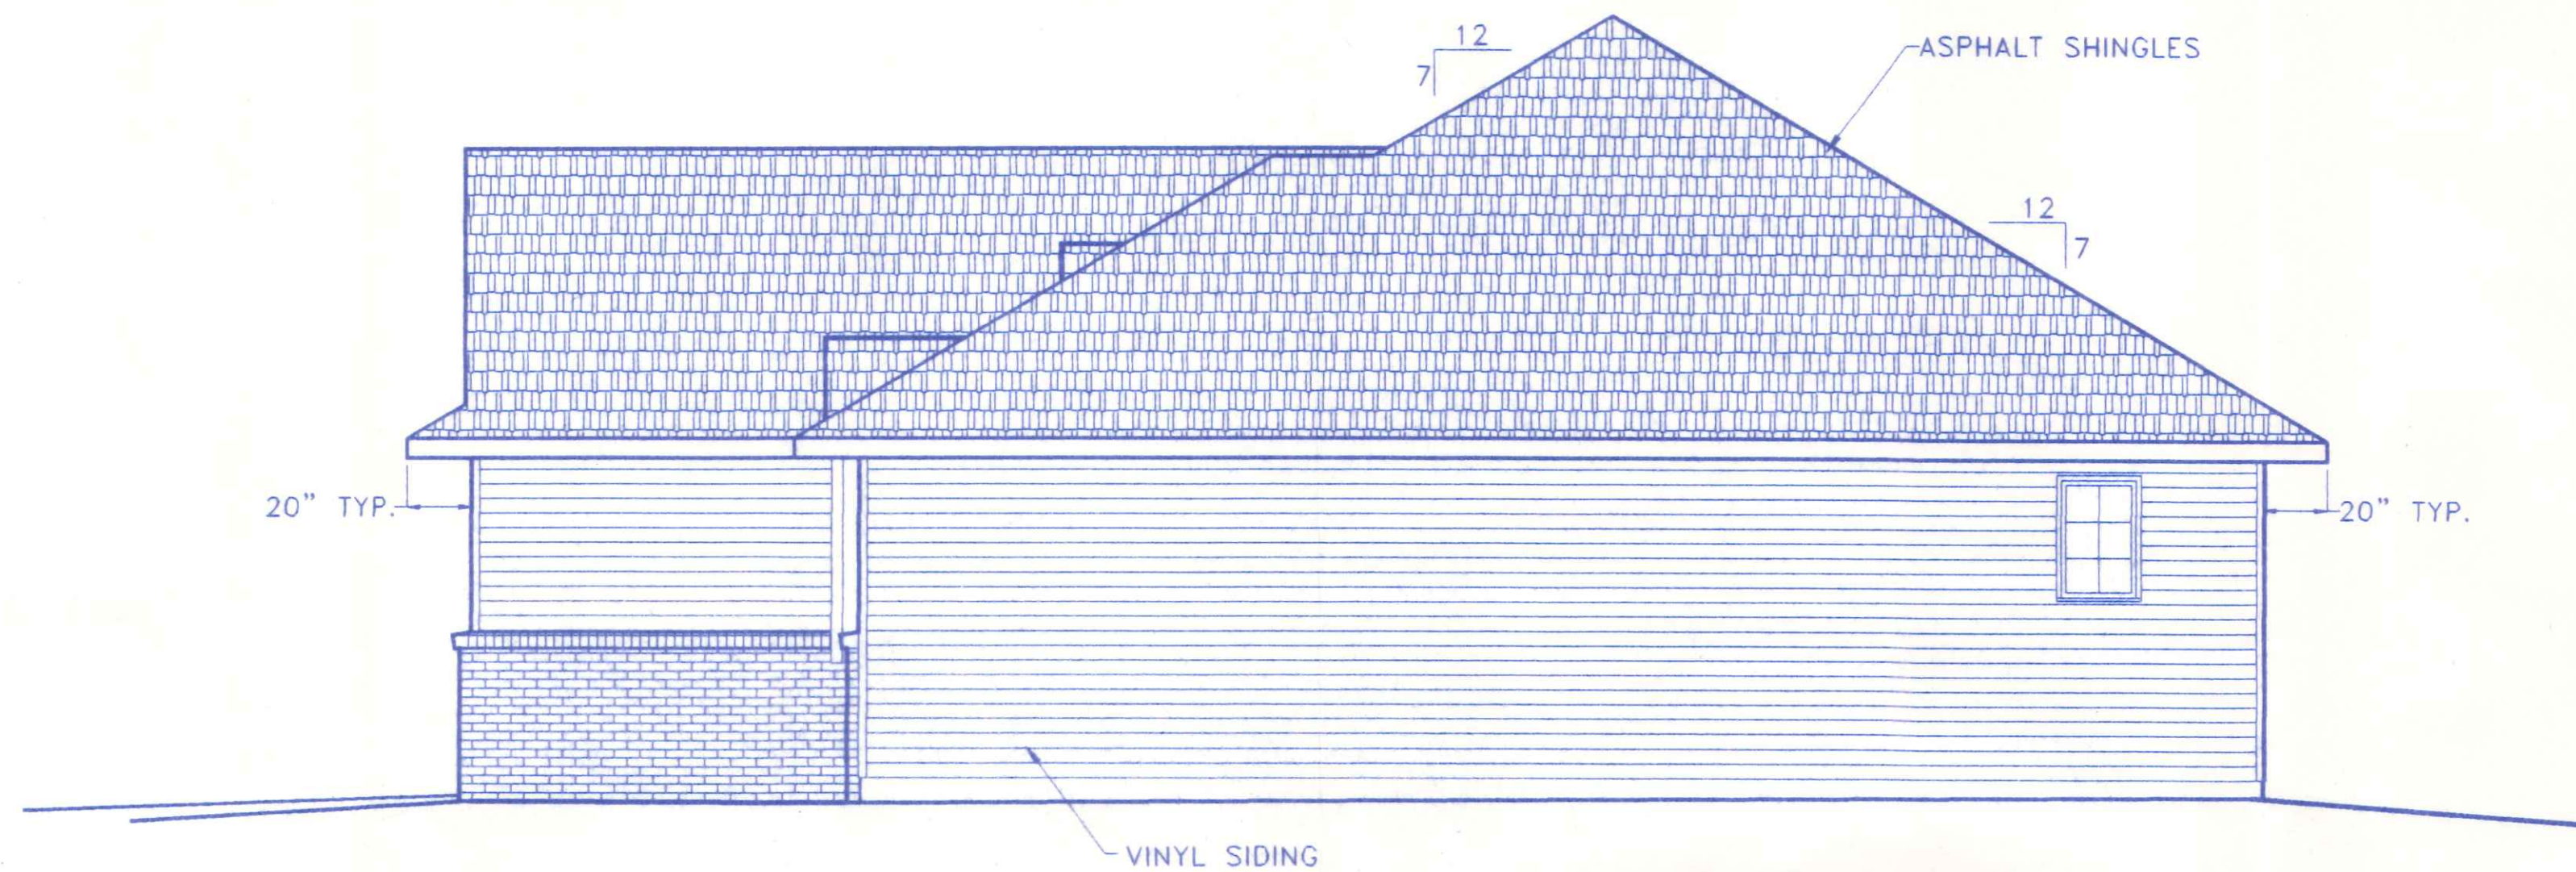


RIGHT SIDE ELEVATION

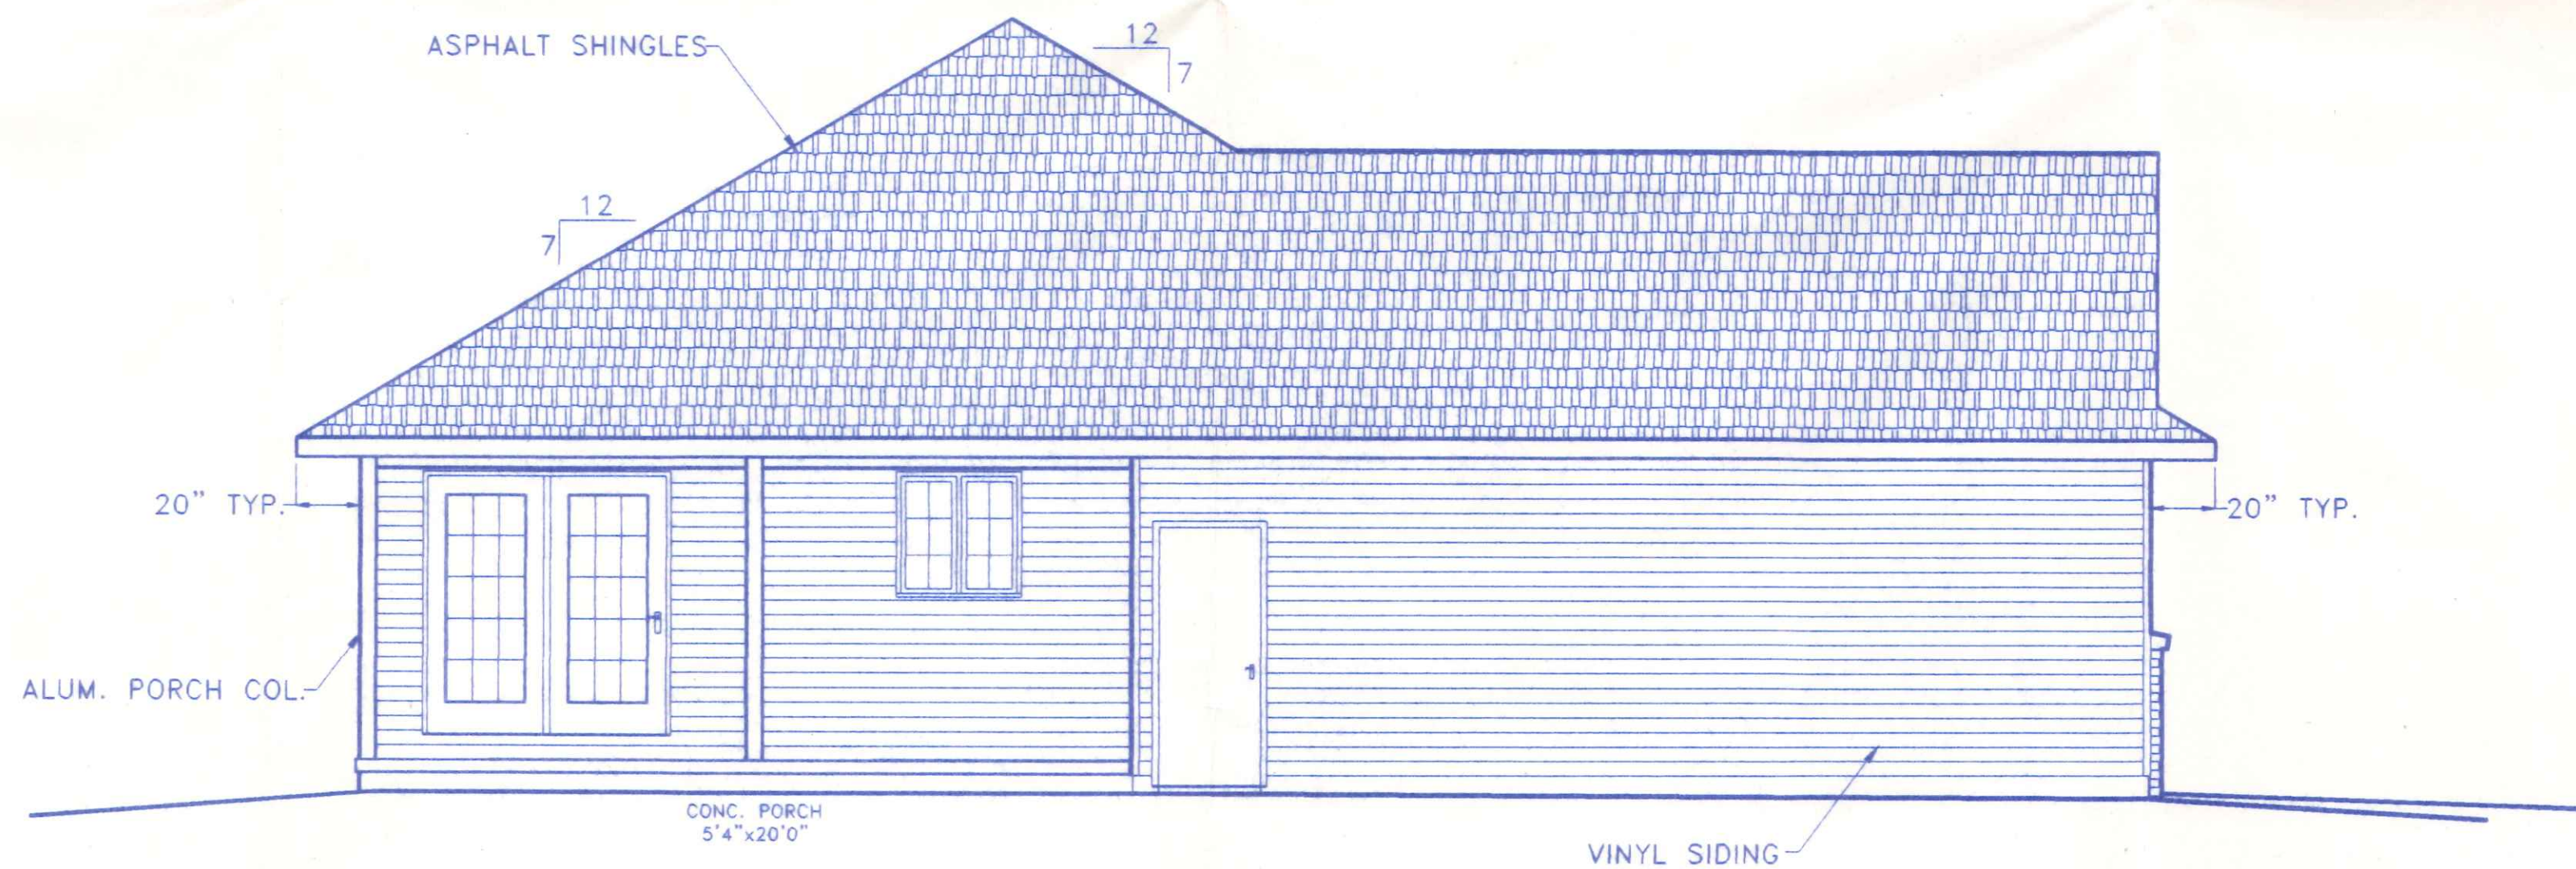


LEFT SIDE ELEVATION

	BECK CONSTRUCTION CO		
	COUNTY ROAD M	419/592-8307	NAPOLEON, OHIO
	DIRECTORY: C:\ND\BECK\SPEC\	DRAWN BY: R.D.S.	
	FILE NAME: 286	REVISED:	
PLAN NO. 286		SCALE: 1/4"=1'-0"	
SIDE EXTERIOR ELEVATIONS		DATE: APRIL, 1999	
		DRAWING NUMBER:	
		2 of 5	


FLOOR PLAN

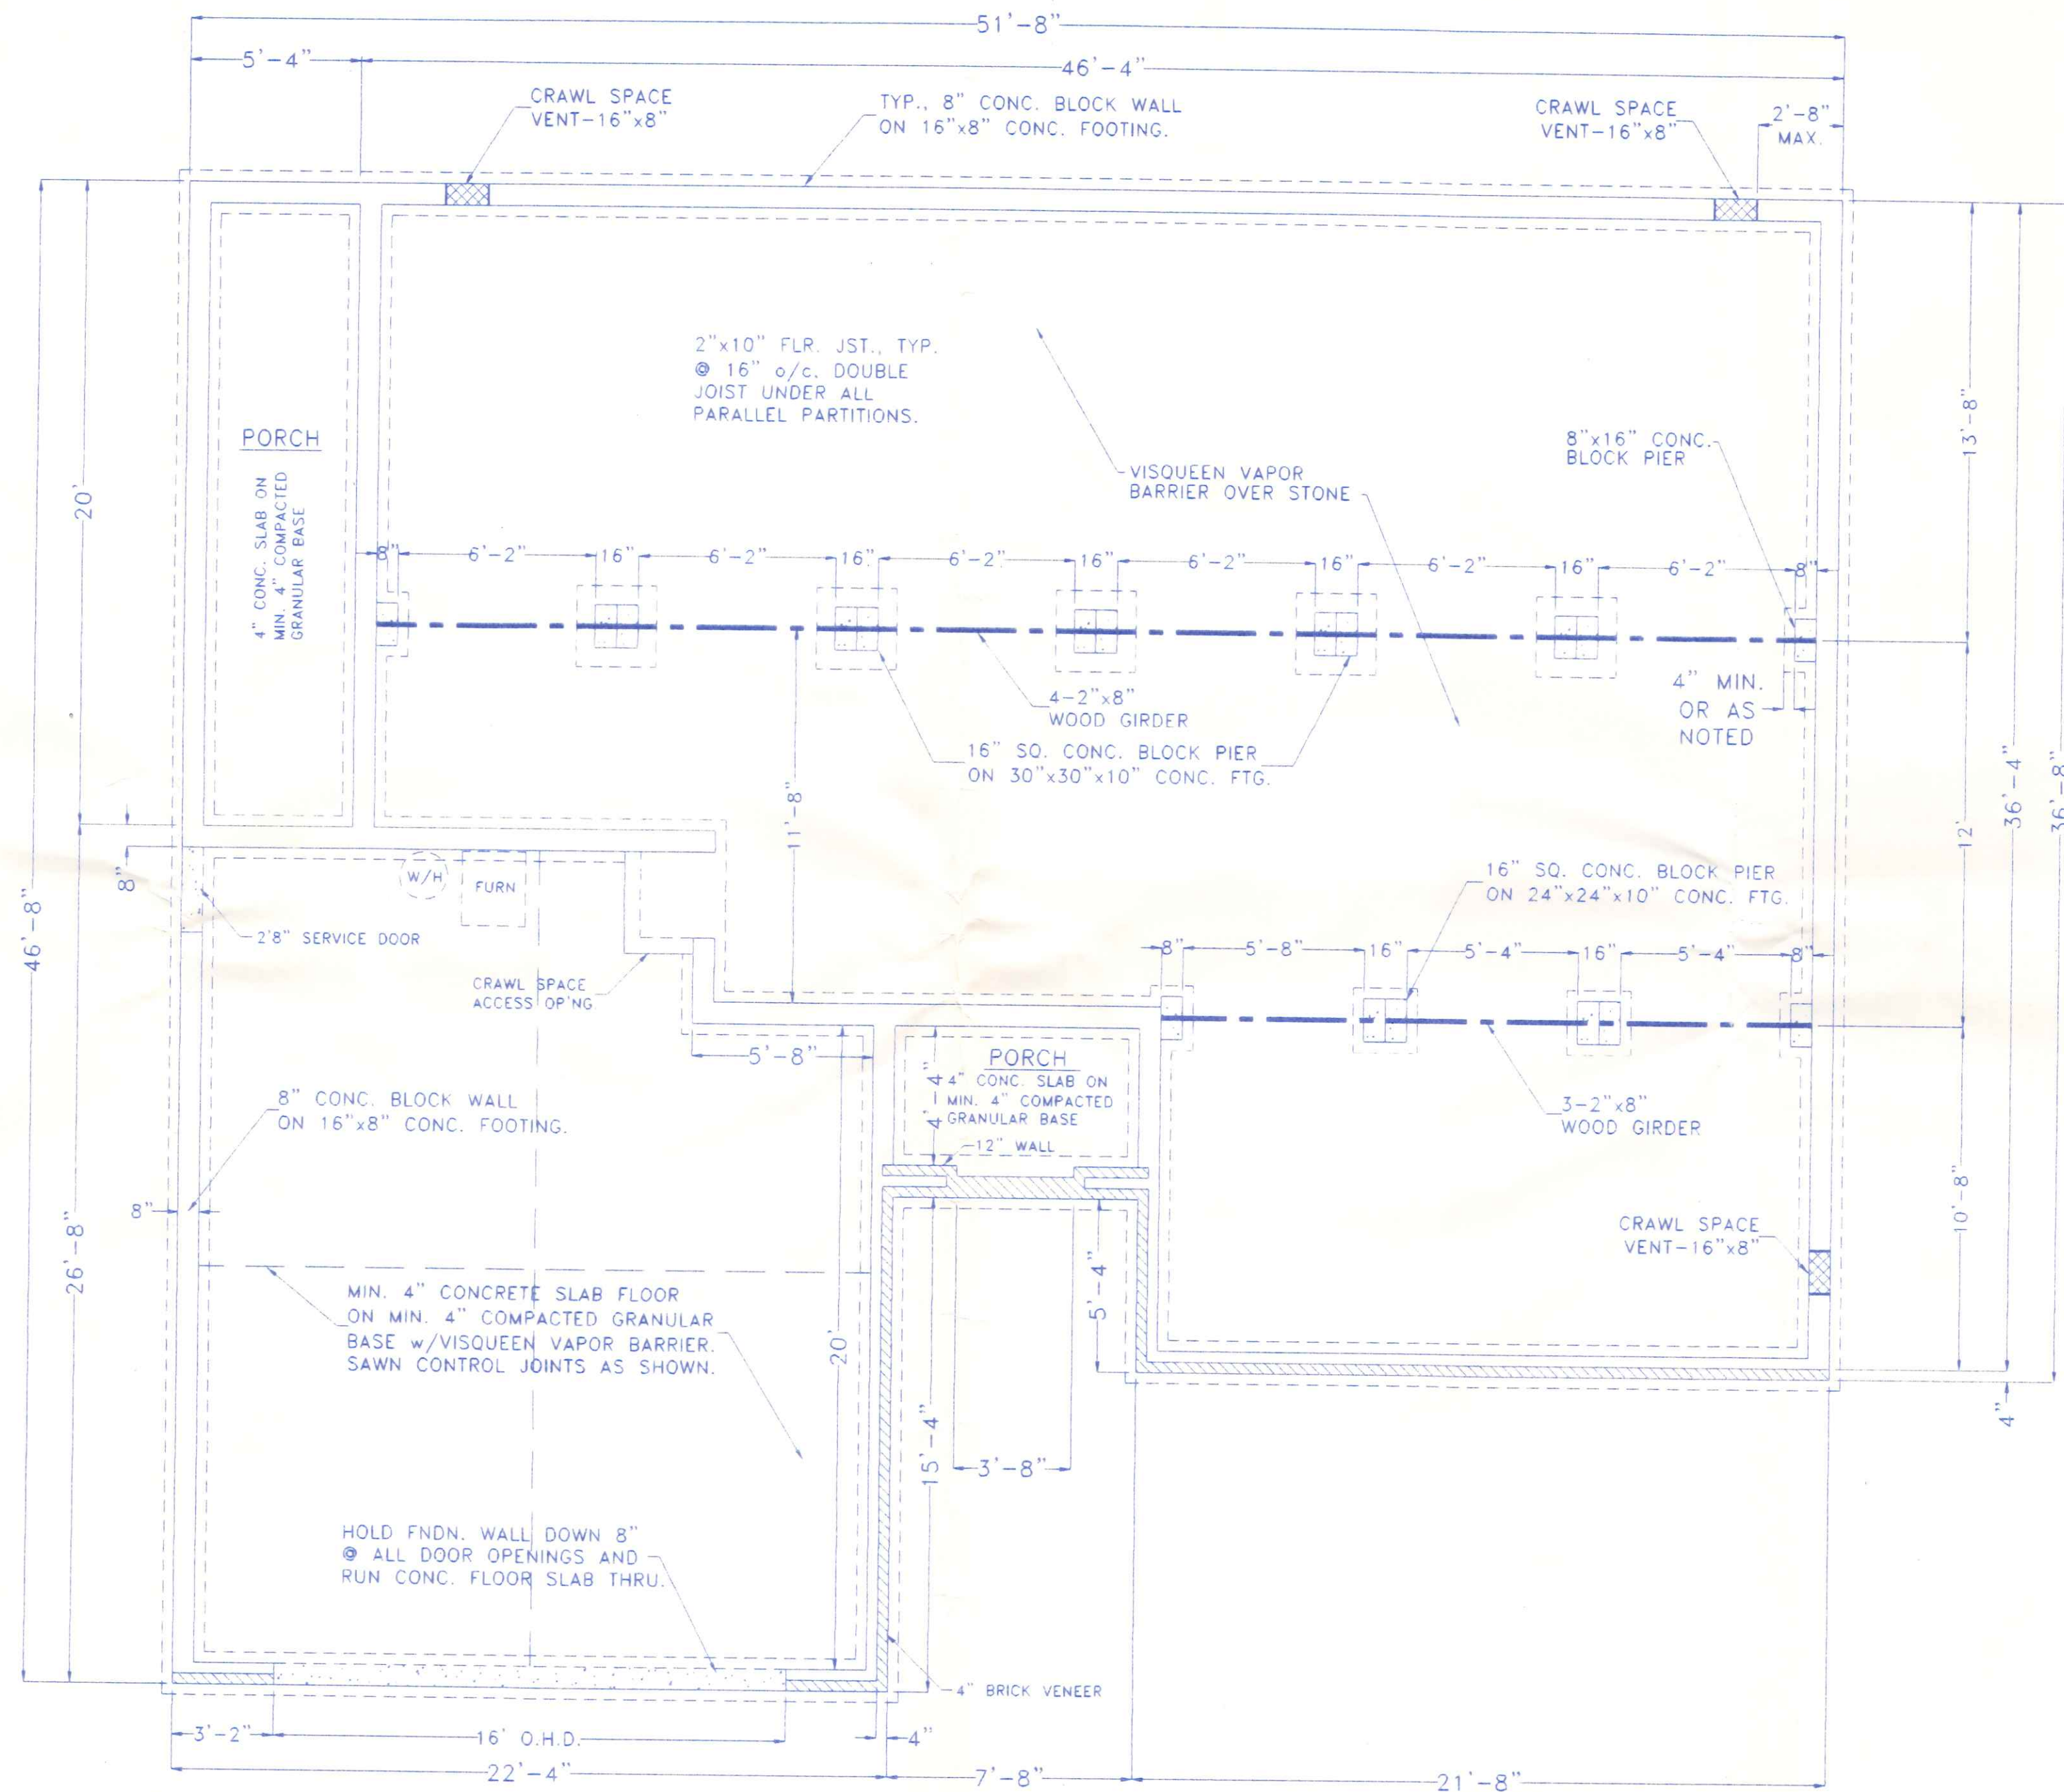

BECK CONSTRUCTION CO		
COUNTY ROAD W	419/592-8307	NAPOLÉON, OHIO
DIRECTORY: C:\ND\BECK\SPEC\	DRAWN BY: R.D.S.	
FILE NAME: 286	REVISED:	
PLAN NO. 286		SCALE: 1/4"=1'-0"
FOUNDATION PLAN		DATE: APRIL 1999
		DRAWING NUMBER:
		4 of 5

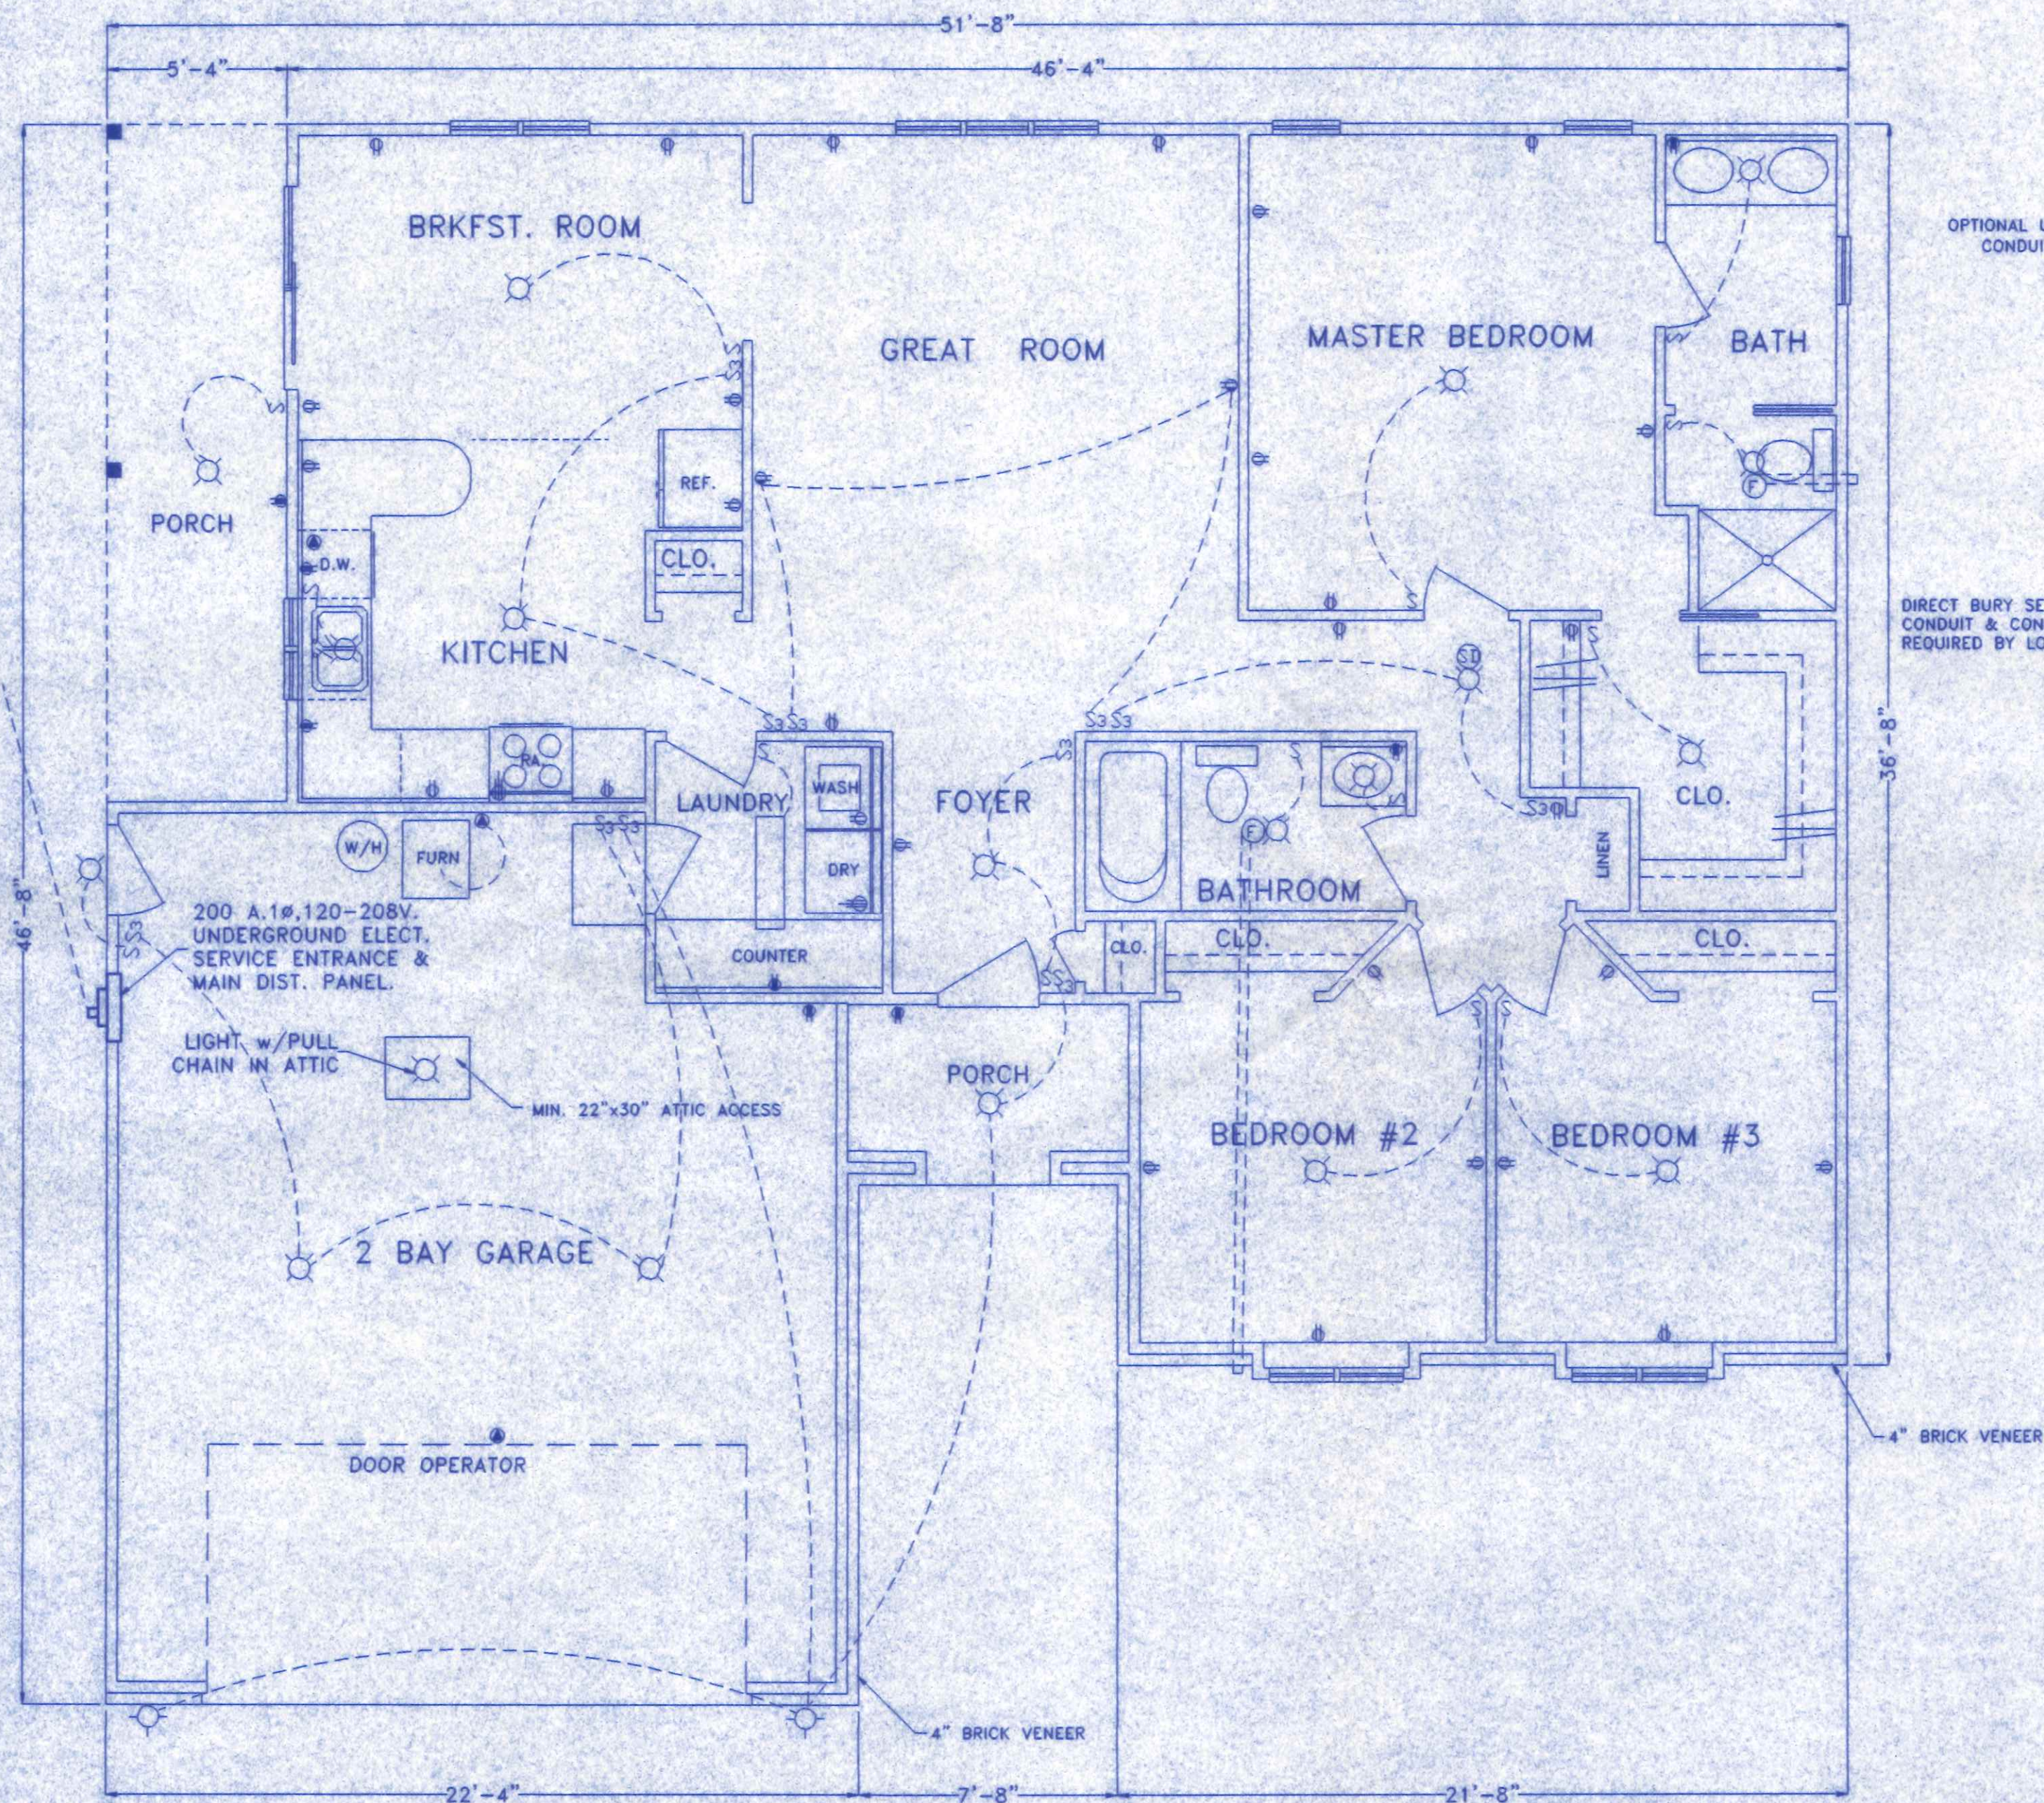

TYPICAL ELECTRICAL PLAN
1/4"=1'-0"

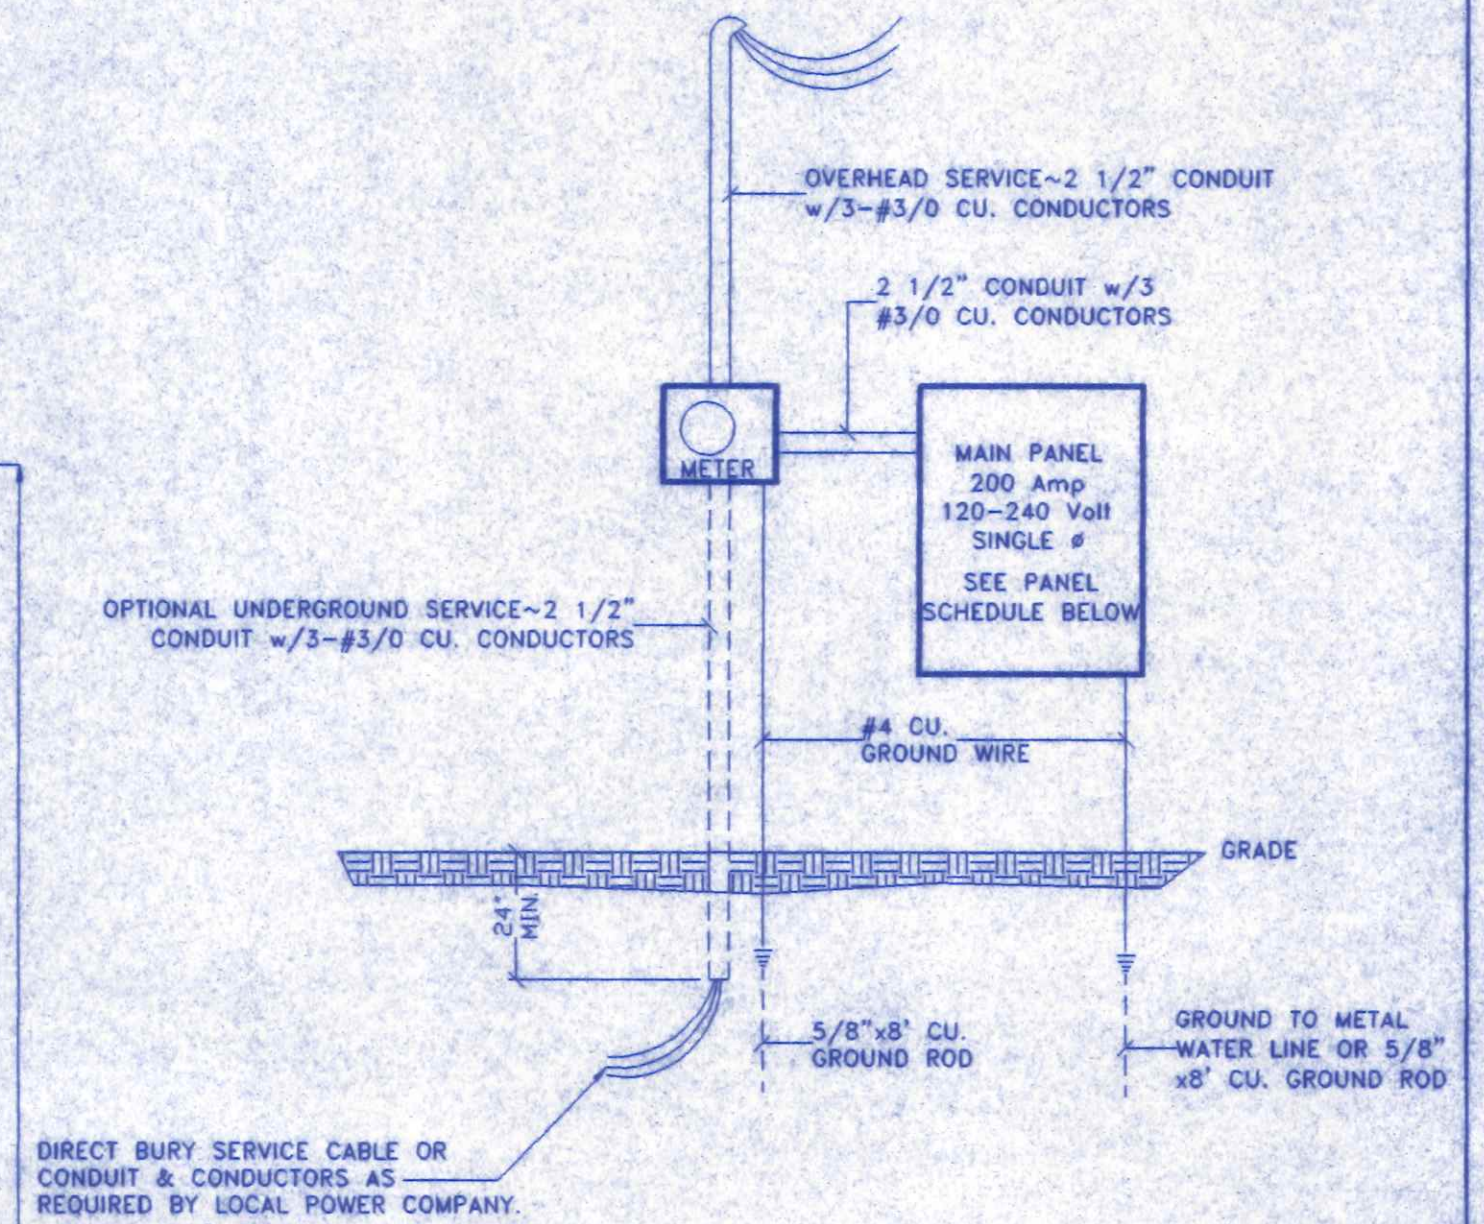

ELECTRICAL RISER DIAGRAM
NO SCALE

ELECTRICAL LEGEND

- 2 TUBE FLUORESCENT LIGHT
- INCANDESCENT CEILING LIGHT FIXTURE
- INCANDESCENT WALL MOUNT LIGHT FIXTURE
- S LIGHT OR FAN SWITCH
- S₃ 3 WAY LIGHT SWITCH
- 120 V. OUTLET G.F.C.I.
- 120 V. DUPLEX RECEPTICLE
- 208 V. APPLIANCE RECEPTICLE
- APPROVED SMOKE DETECTOR
- SPECIAL OUTLET
- EXHAUST FAN
- VENT BATH FANS TO OUTSIDE AIR

GENERAL NOTES

- 1) ALL WORK AND MATERIALS SHALL BE IN ACCORDANCE WITH THE LATEST EDITION OF THE N.E.C. AND ALL LOCAL REGULATIONS.
- 2) PROVIDE G.F.C.I. PROTECTED OUTLETS AT RECEPTICLES IN BATHS, NEAR KITCHEN SINK, OUTDOORS & IN GARAGE AREA.

	BECK CONSTRUCTION CO	
	COUNTY ROAD M 419/592-8307	NAPOLEON, OHIO
	DIRECTORY: C:\ND\BECK\SPEC\	DRAWN BY: R.D.S.
	FILE NAME: 286	REVISD:
PLAN NO. 286		SCALE: NOTED
ELECTRICAL PLAN		DATE: APRIL, 1999
		DRAWING NUMBER: 5 of 5