





FRONT ELEVATION

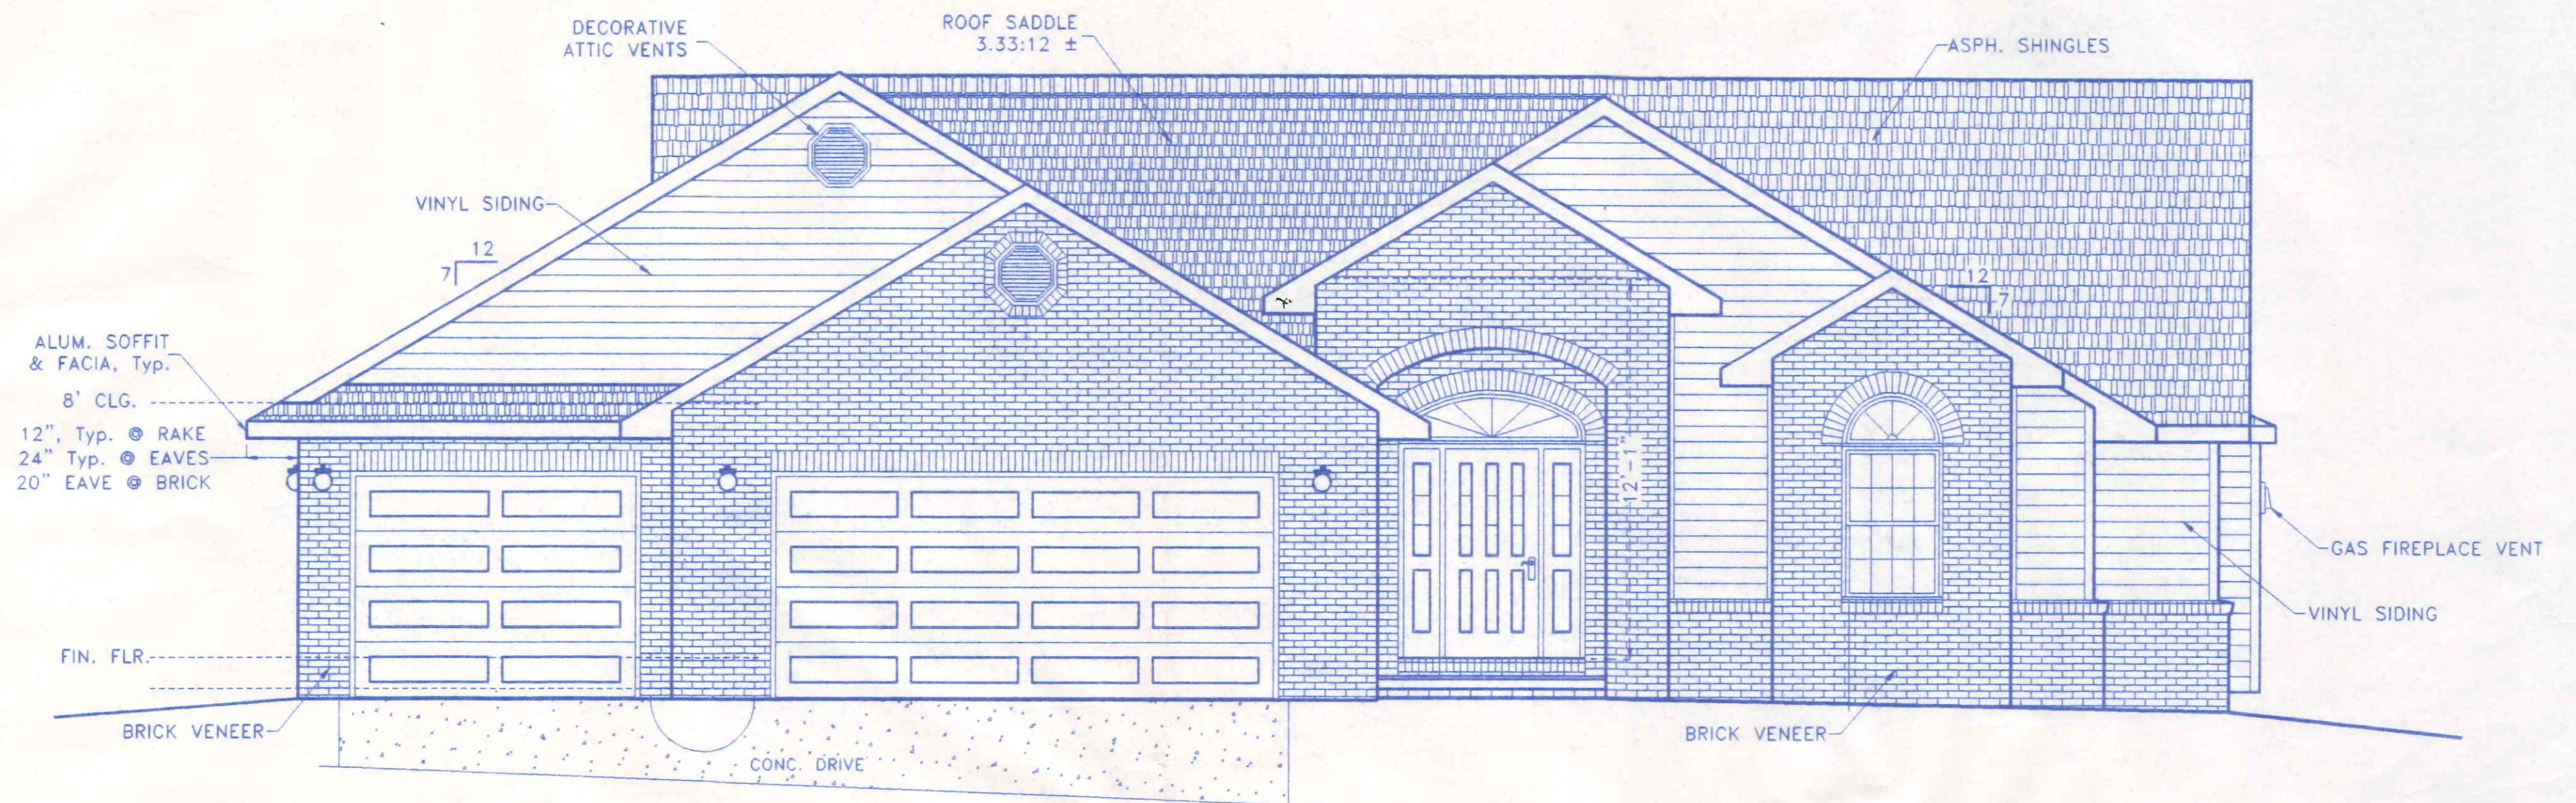

REAR ELEVATION

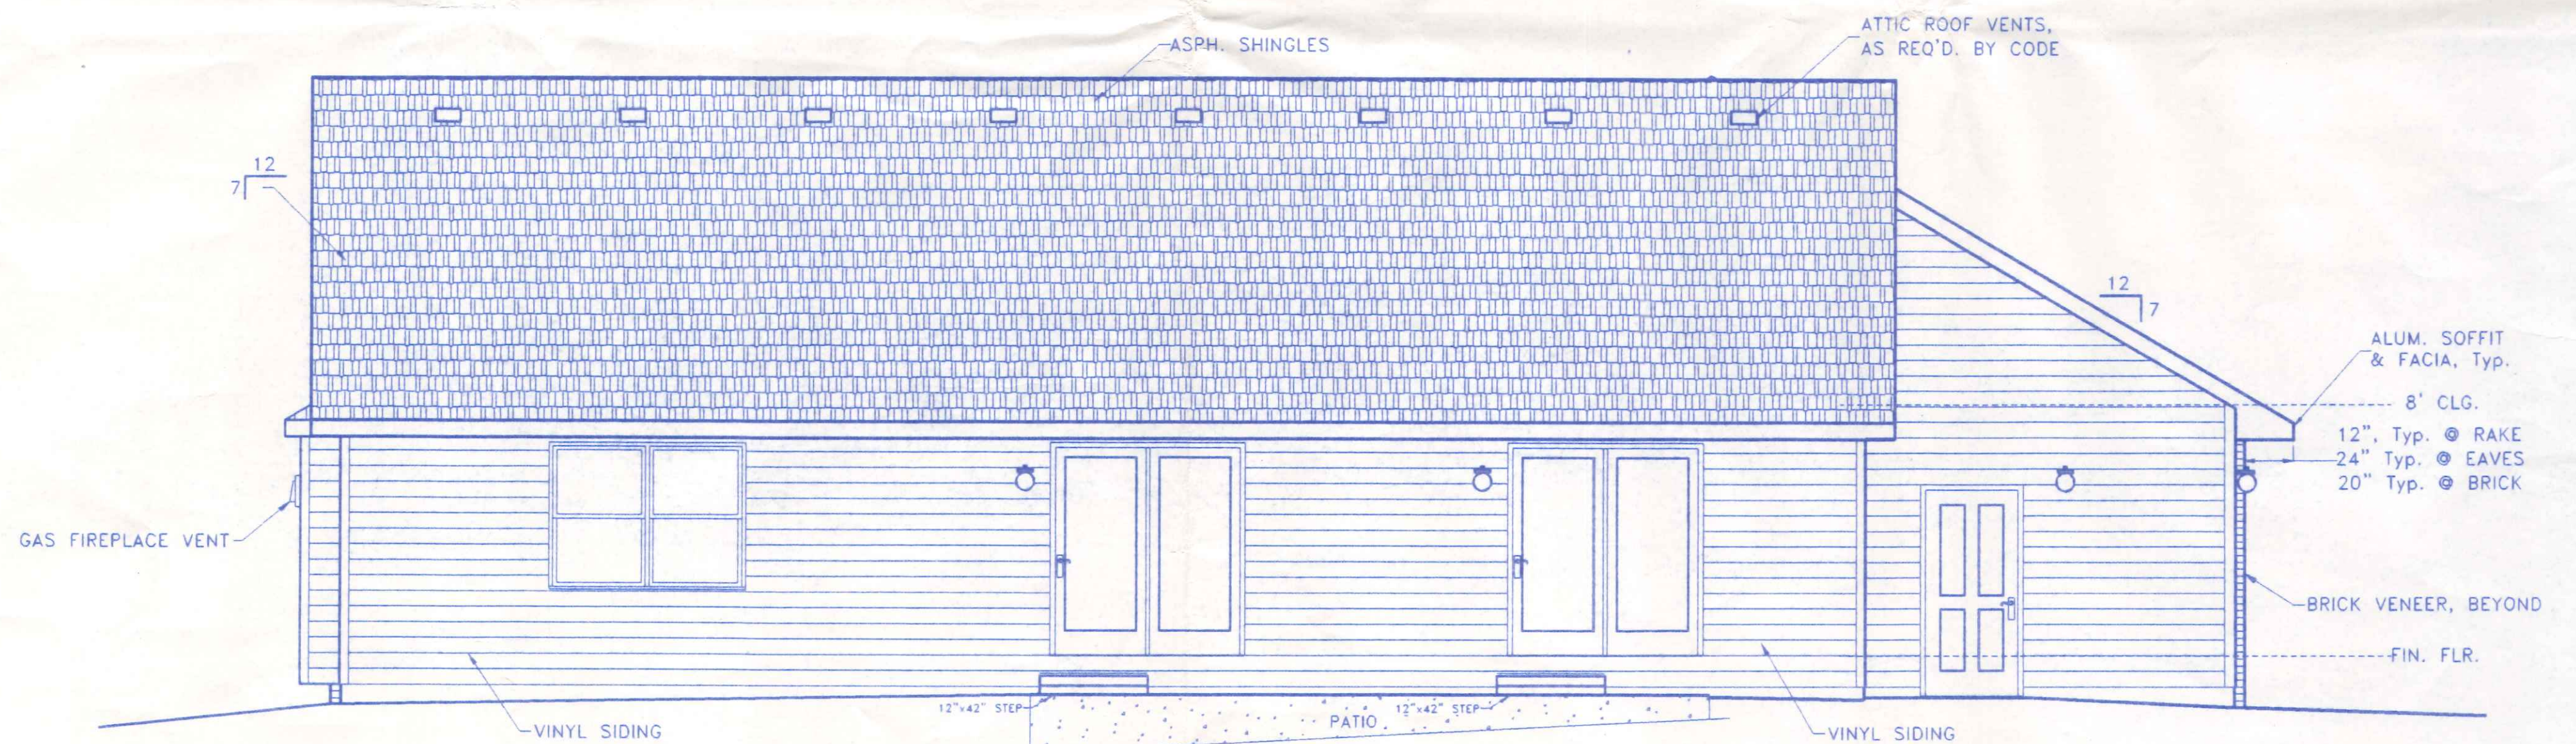

BECK CONSTRUCTION CO
COUNTY ROAD M 419/592-8307 NAPOLEON, OHIO

DIRECTORY: C:\ND\BECK\CUSTOM DRAWN BY: R.D.S.
FILE NAME: SEDWARD REVISED:


SEDWARD

SCALE: 1/4"=1'-0"


FRONT & REAR ELEVATIONS

DATE: JUNE, 2004

DRAWING NUMBER:
1 of 5

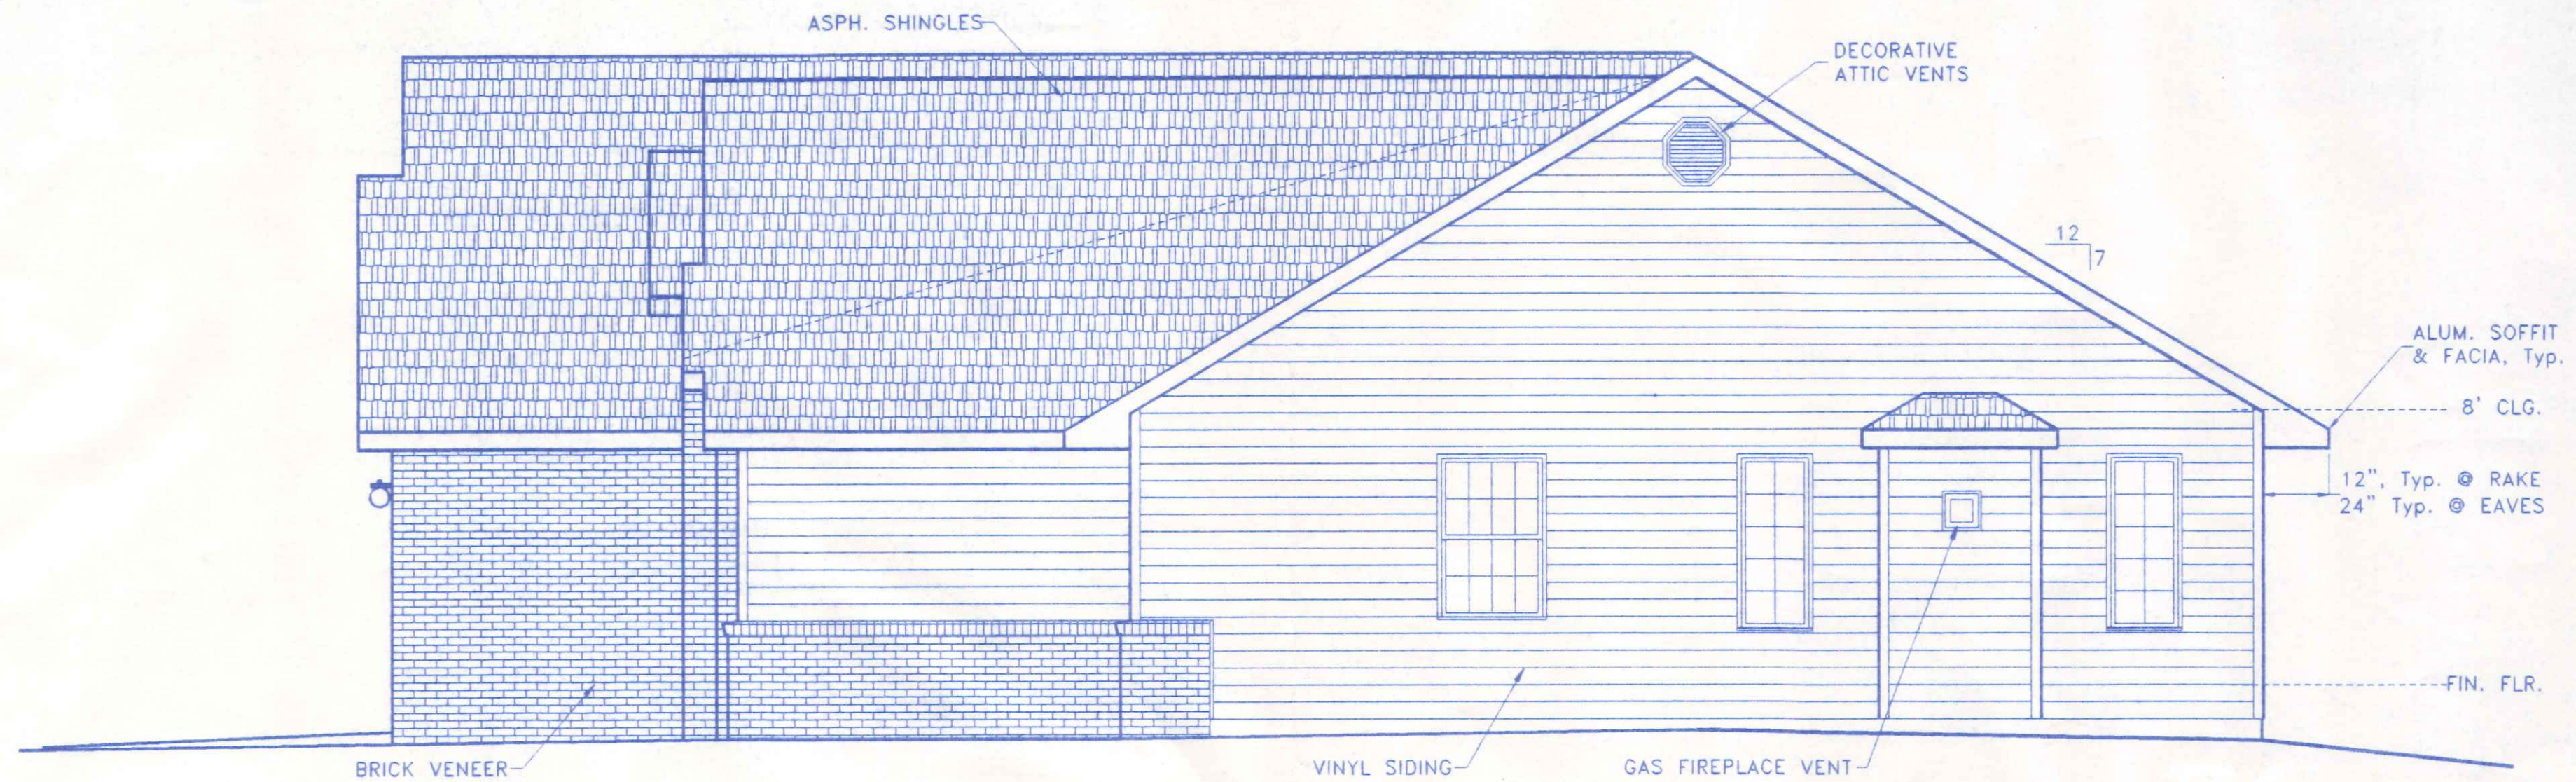

RIGHT SIDE ELEVATION

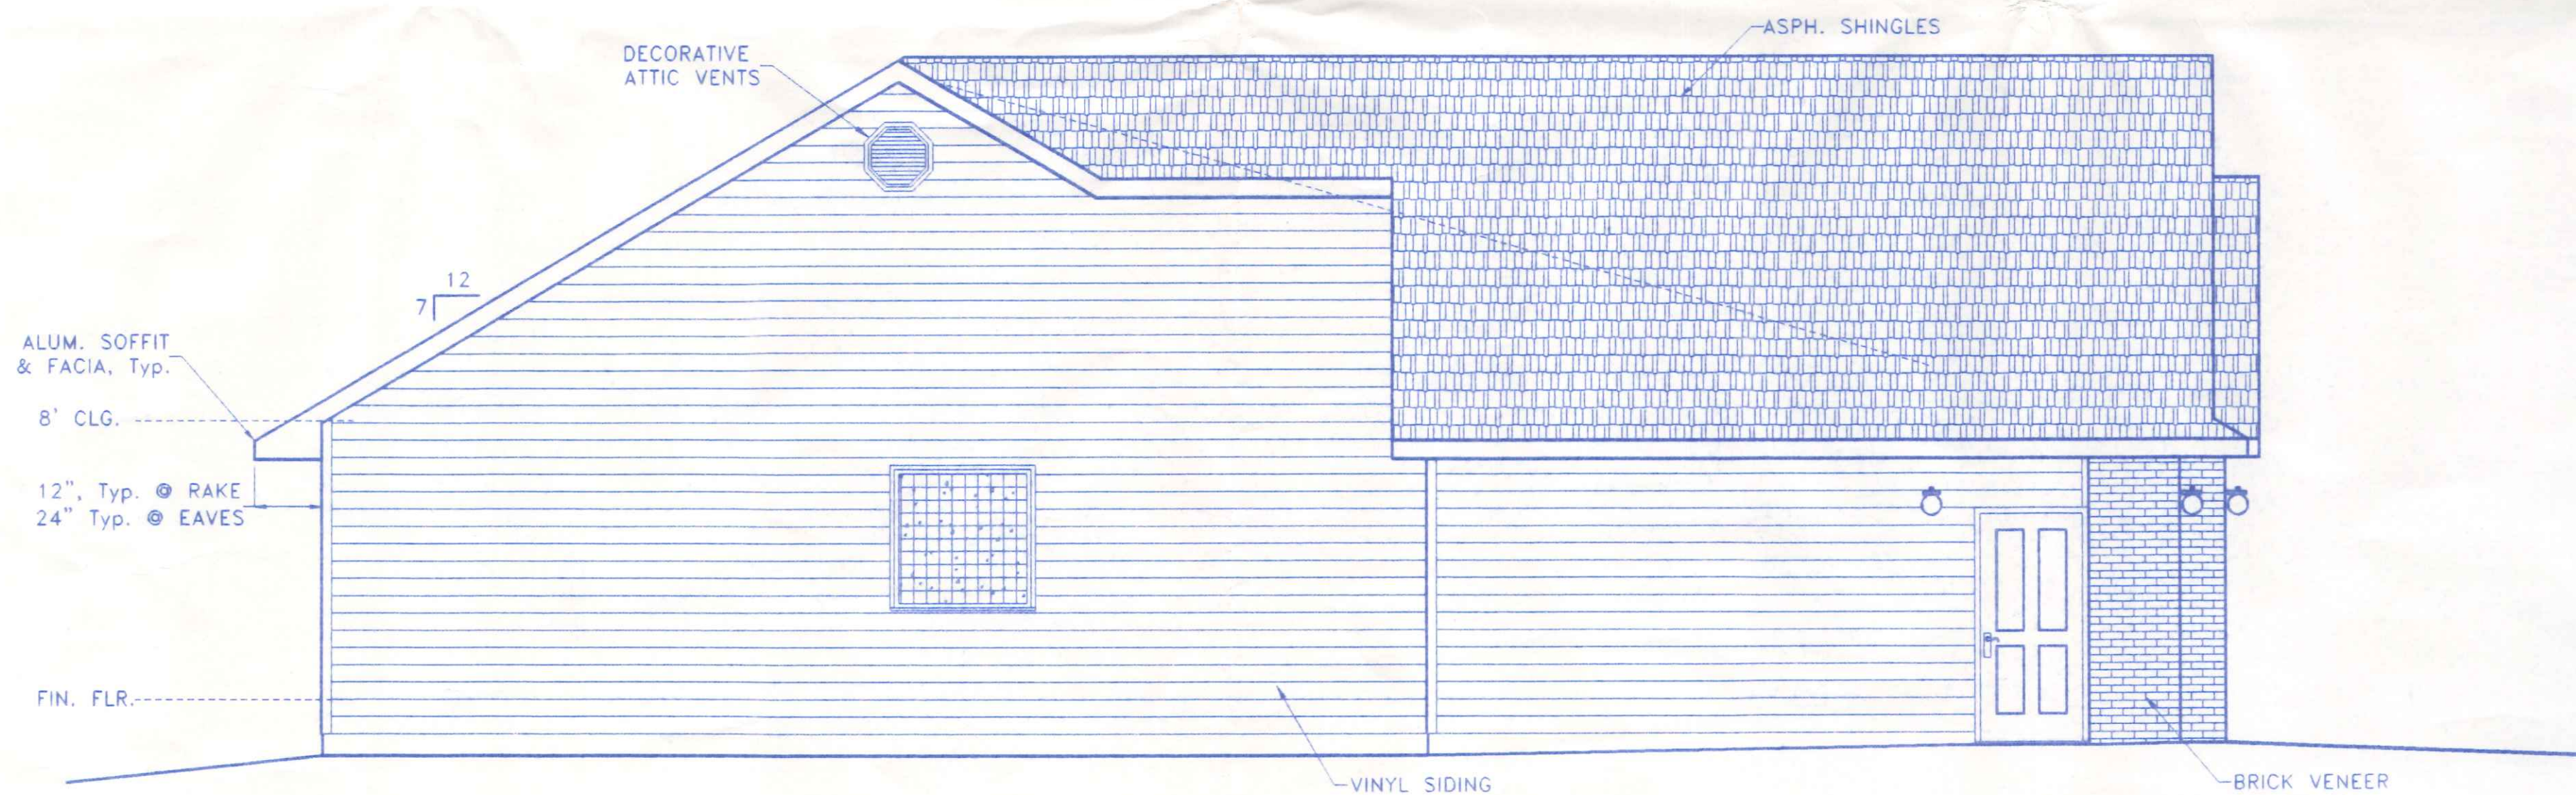

LEFT SIDE ELEVATION

	BECK CONSTRUCTION CO	
	COUNTY ROAD M 419/592-8307 NAPOLEON, OHIO	
	DIRECTORY: C:\ND\BECK\CUSTOM	DRAWN BY: R.D.S.
SEDWARD	FILE NAME: SEDWARD	REVISED:
	SCALE: 1/4"=1'-0"	
	DATE: JUNE, 2004	
SIDE VIEW ELEVATIONS	DRAWING NUMBER:	
	2 of 5	



SEALER/CURING COMPOUND.


DRAWING NUMBER:
7-65

ELECTRICAL NOTES

1. CONTRACTOR SHALL FURNISH ALL LABOR, MATERIALS, TOOLS, ETC. TO PROVIDE A COMPLETE & OPERABLE ELECTRICAL INSTALLATION AS SHOWN ON THE PLANS.
2. CONTRACTOR SHALL VISIT THE SITE SO AS TO SATISFY HIMSELF AS TO THE CONDITIONS UNDER WHICH THE WORK IS TO BE PERFORMED.
3. ALL ELECTRICAL WORK SHALL BE INSPECTED AND APPROVED BY THE STATE BLDG. INSPECTION AGENCY, OR THE LOCAL INSPECTION AGENCY HAVING JURISDICTION.
4. ALL ELECTRICAL WORK SHALL CONFORM TO THE LATEST EDITION OF THE NATIONAL ELECTRIC CODE AND ALL APPLICABLE STATE AND LOCAL CODES AND ORDINANCES.
5. ALL RACEWAYS BURIED IN EARTH, RUN EXPOSED OR CAST IN CONCRETE SHALL BE RIGID, GALVANIZED STEEL CONDUIT. CONDUITS BURIED IN EARTH OR CAST IN CONCRETE MAY BE PVC SCH. 40 CONDUIT WITH RIGID STEEL ELBOWS & RISERS, 3/4" DIAMETER MINIMUM. A GROUND WIRE SHALL BE ADDED IN ALL PVC CONDUIT RUNS.
6. BRANCH CIRCUIT WIRING SHALL BE COPPER CONDUCTORS, NO. 12 AWG MINIMUM.
7. CONTRACTOR SHALL GUARANTEE HIS WORKMANSHIP AND ALL MATERIALS (EXCEPT LAMPS) FOR A PERIOD OF ONE (1) YEAR FROM DATE OF FINAL ACCEPTANCE.
8. ALL MATERIALS FURNISHED AND/OR INSTALLED UNDER THIS CONTRACT SHALL BE NEW UNLESS SPECIFICALLY NOTED OTHERWISE AND SHALL BE U.L. LISTED.
9. PROVIDE GROUND FAULT CIRCUIT INTERRUPTER (GFCI) PROTECTED OUTLETS AT ALL RECEPTILES IN BATHS, NEAR KITCHEN SINK, OUTDOORS & IN GARAGE AREAS.
10. THIS CONTRACTOR SHALL REMOVE DEBRIS CREATED BY THIS PORTION OF THE CONTRACT AND SHALL CLEAN ALL FIXTURES, PANELS, EQUIPMENT, ETC. AT THE COMPLETION OF THE PROJECT.


ELECTRICAL LEGEND

- 2 TUBE FLUORESCENT LIGHT
- INCANDESCENT CEILING LIGHT FIXTURE
- INCANDESCENT WALL LIGHT FIXTURE
- LIGHT SWITCH
- FAN SWITCH
- 3 WAY LIGHT SWITCH
- 120 V. OUTLET G.F.C.I.
- 120 V. DUPLEX RECEPTACLE
- 120 V. DUPLEX RECEPT. 1/2 SWITCHED
- 208 V. APPLIANCE RECEPTACLE
- APPROVED SMOKE DETECTOR
- SPECIAL OUTLET
- EXHAUST FAN
- VENT BATH FANS TO OUTSIDE AIR

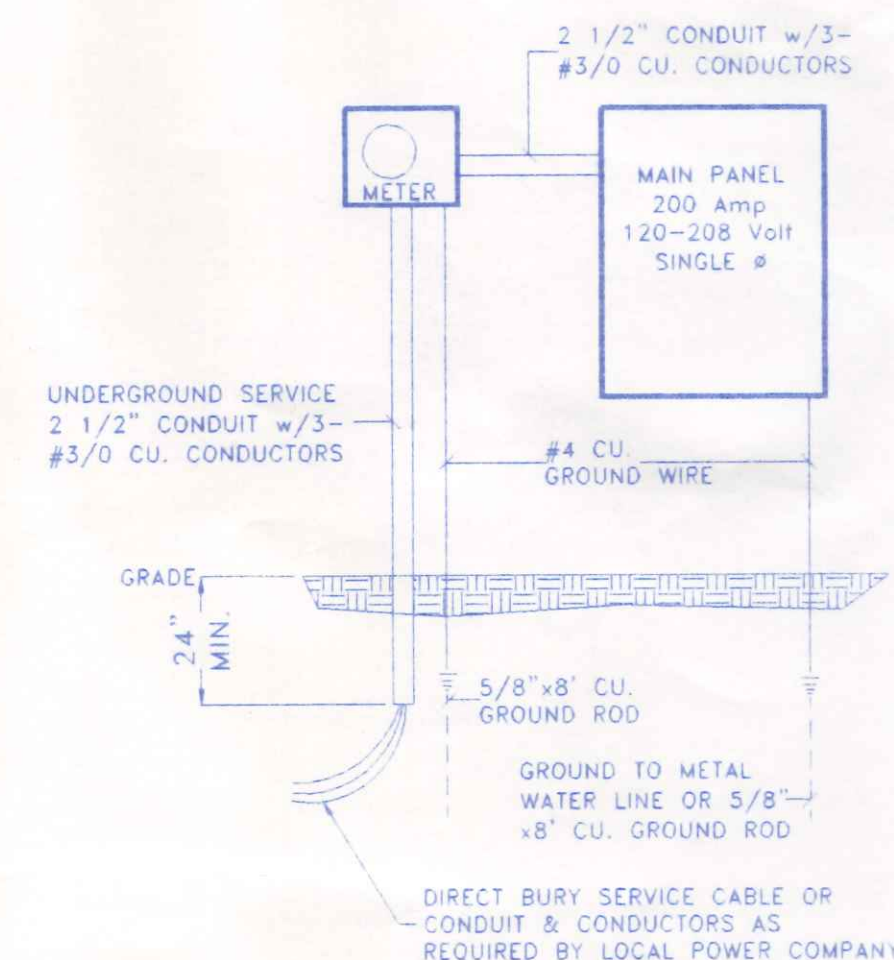

ELECTRICAL RISER DIAGRAM

NO SCALE

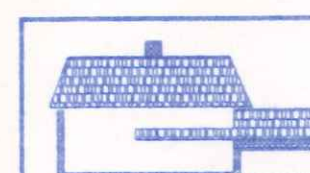


BECK CONSTRUCTION CO
COUNTY ROAD M 419/592-8307 NAPOLEON, OHIO

DIRECTORY: C:\ND\BECK\CUSTOM DRAWN BY: R.D.S.
FILE NAME: SEDWARD REVISED:

SEDWARD


ELECTRICAL PLAN

SCALE: 1/4"=1'-0"
DATE: JUNE, 2004
DRAWING NUMBER:
5 of 5

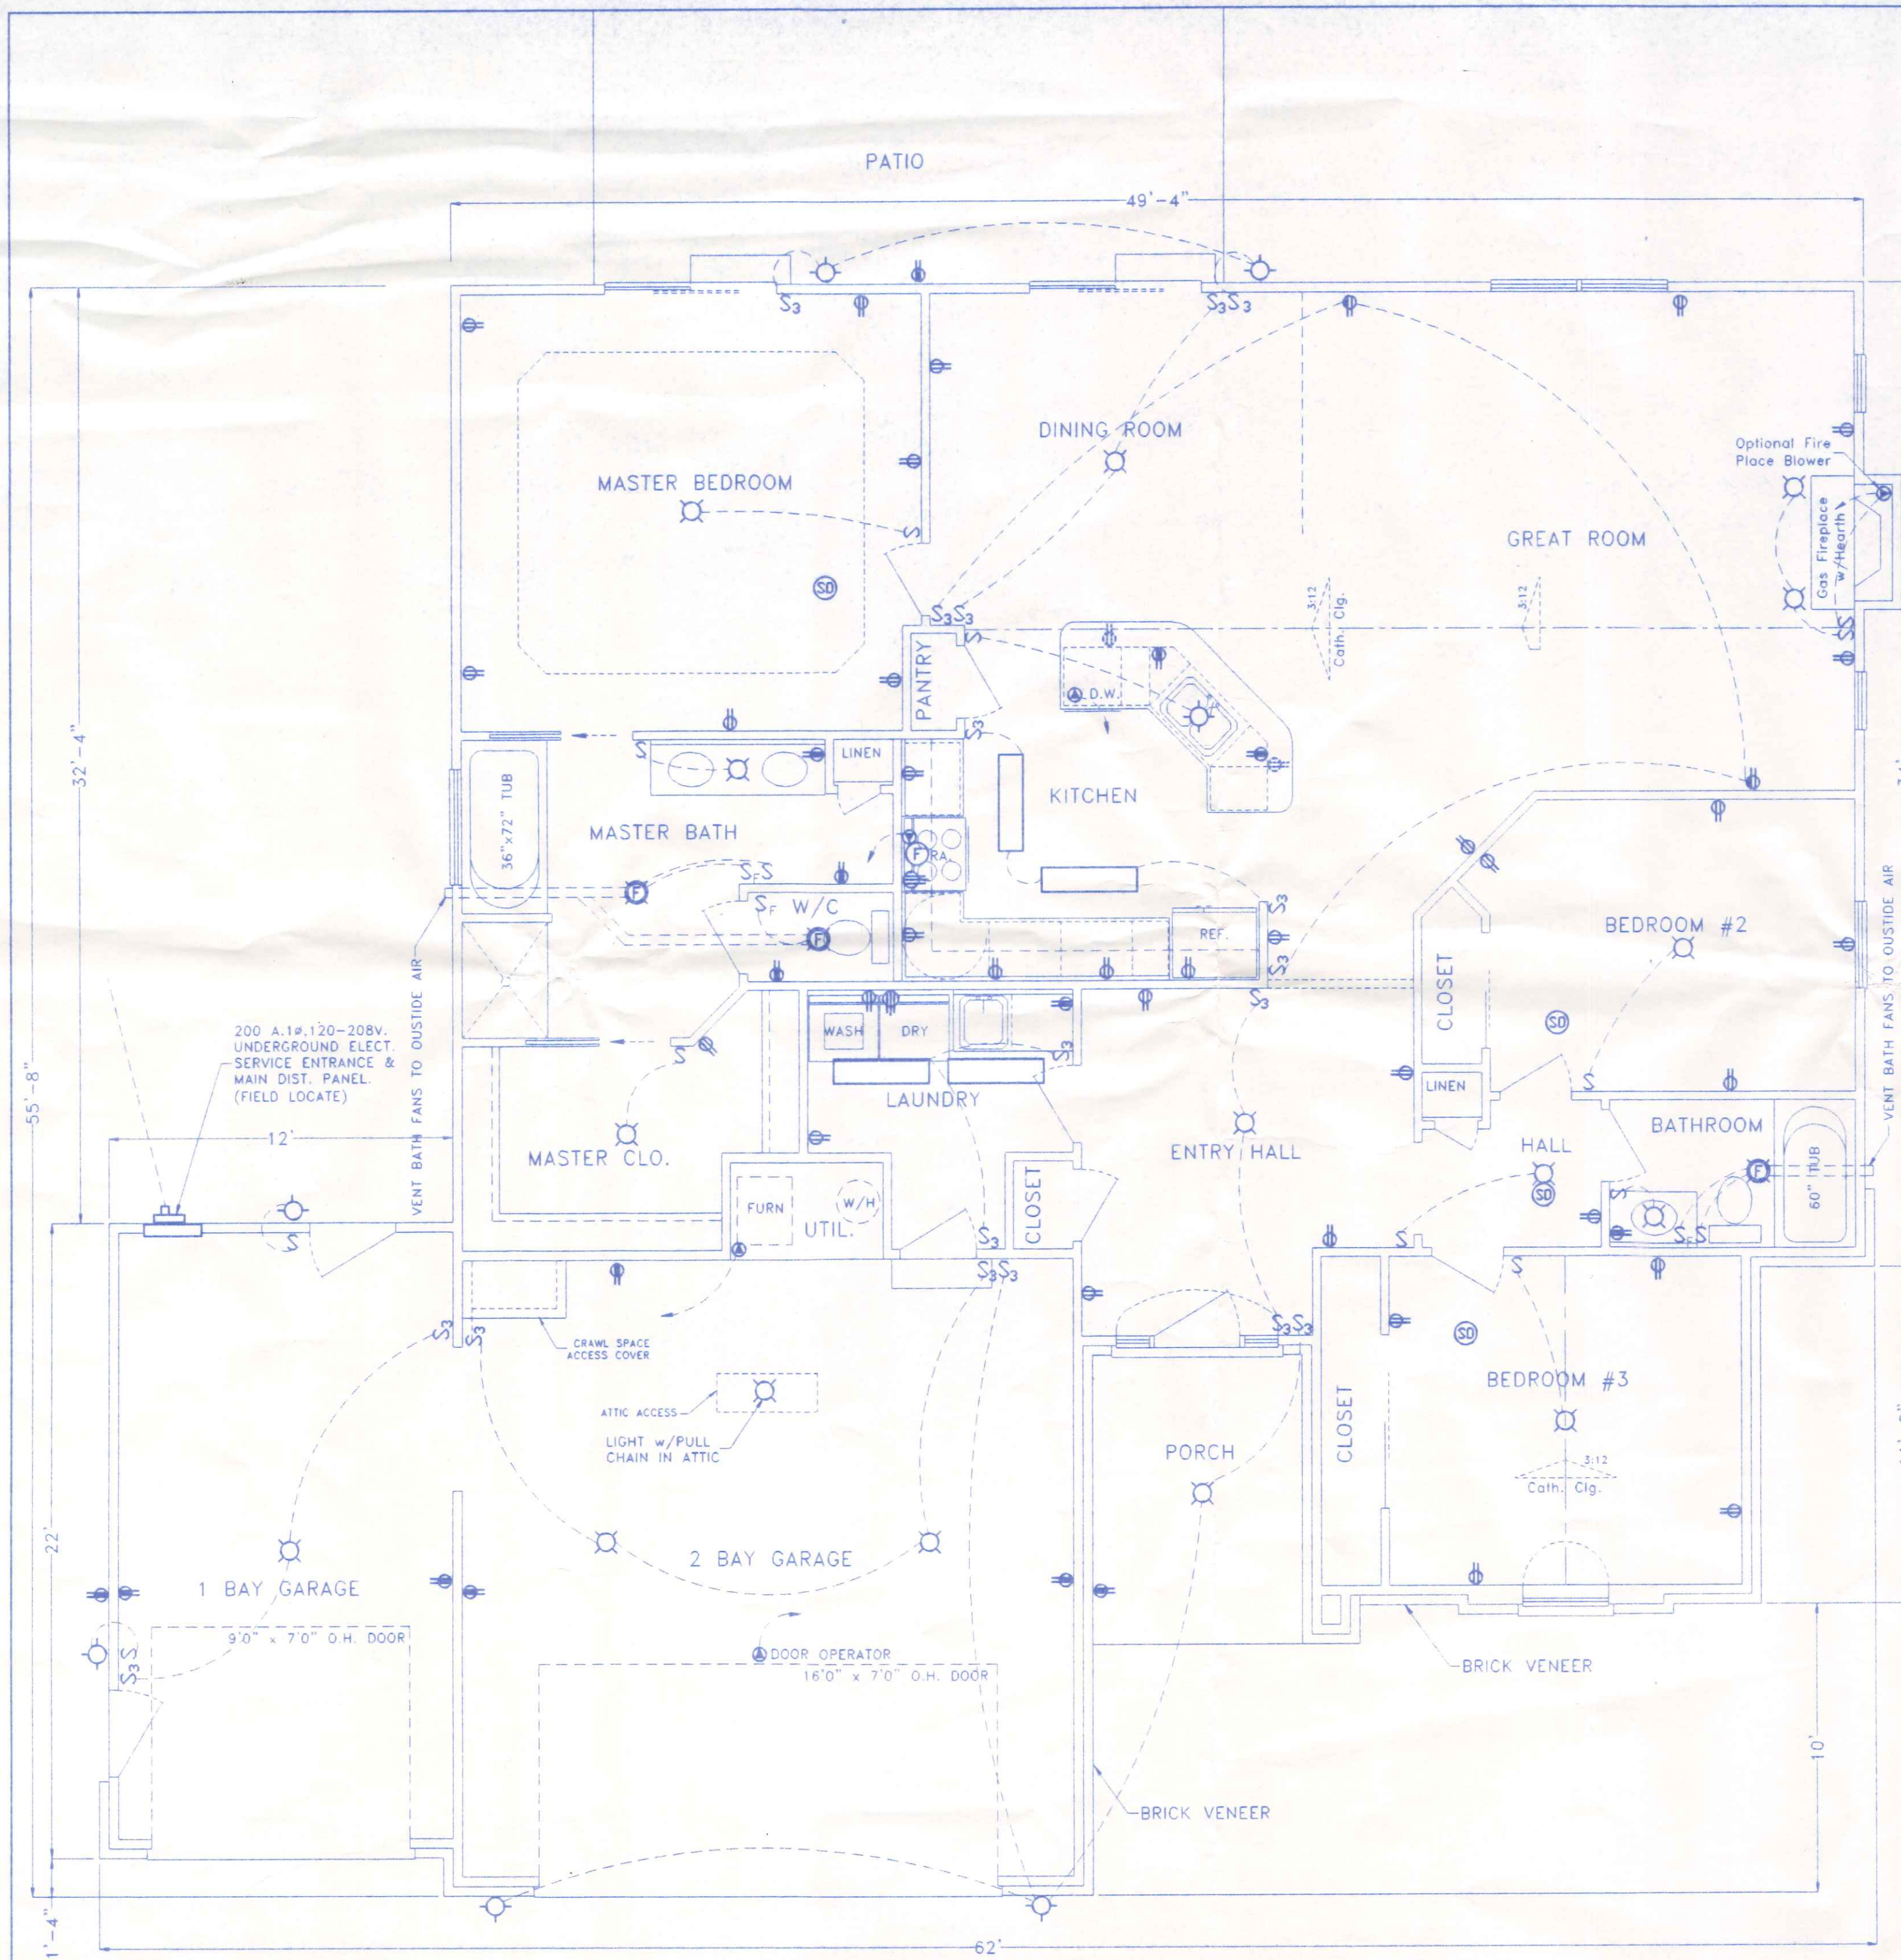


RIVIERA HEIGHTS 1st & 2nd ADDITIONS

PROJECT LOCATION

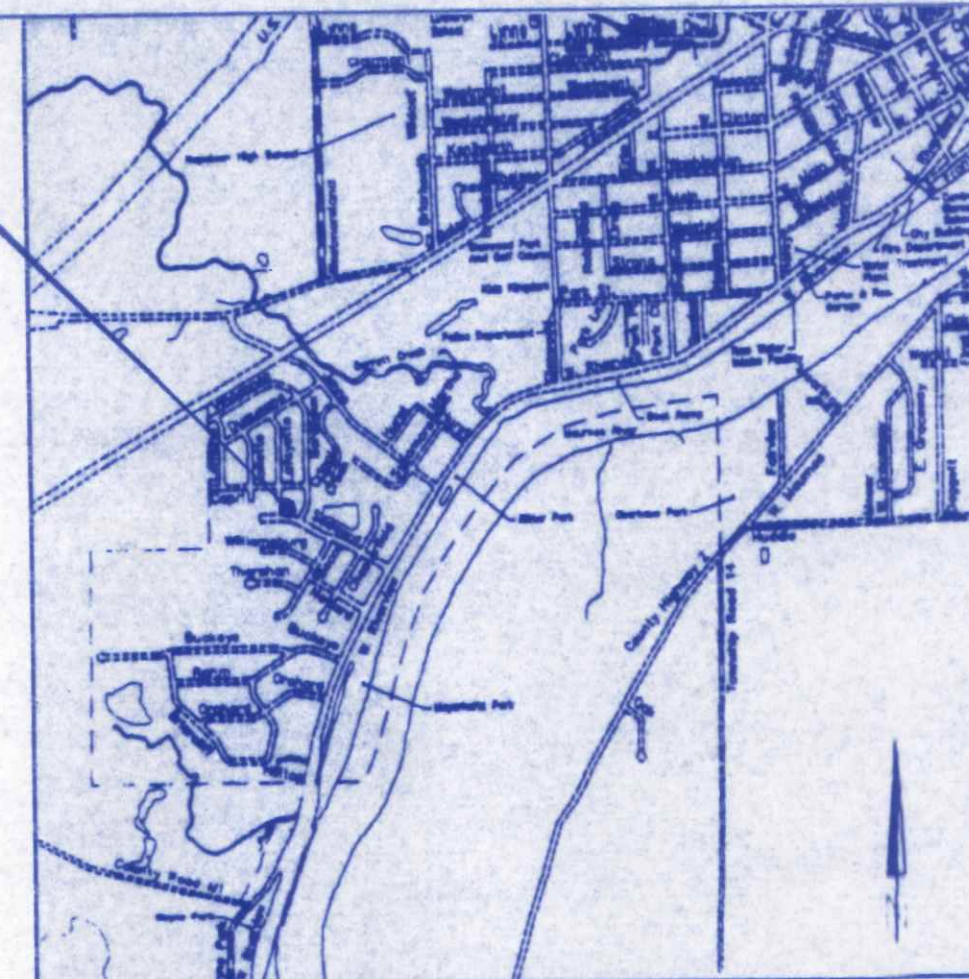

LOCATION MAP

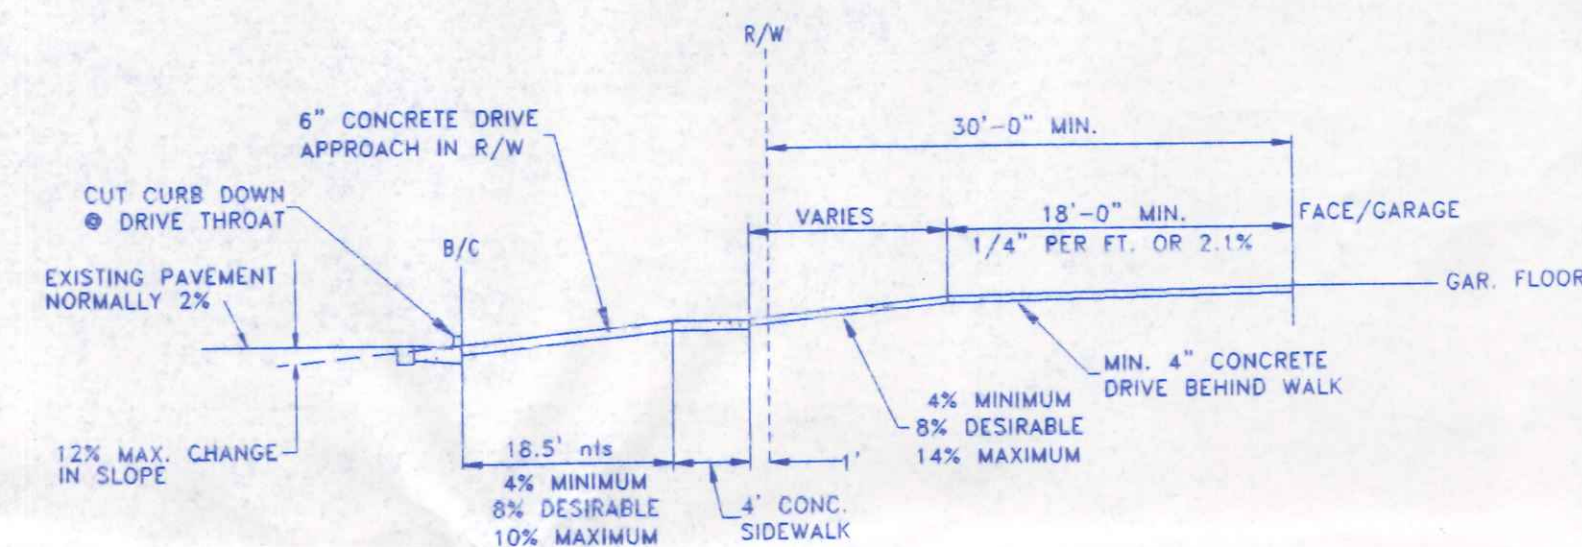

DRIVE APPROACH &
GARAGE ELEVATION DETAIL



OHIO UTILITIES PROTECTION SERVICE

The underground utilities shown hereon are only approximate. Some of the utilities were located by field observation, where possible, and the remaining utilities were derived from various records. Exact locations must be determined by the UTILITY COMPANIES. For exact locations, telephone the Ohio Utilities Protection Service (O.U.P.S.) toll free at 1-800-362-2764. (Telephone 2 working days before any digging.)

SITE LOCATION PLAN

FOR

LOT NO. 70

TWIN OAKS SUBDIVISION, 4th ADDITION
CITY OF NAPOLEON, NAPOLEON TOWNSHIP
HENRY COUNTY, OHIO

		BECK CONSTRUCTION CO	
COUNTY ROAD 14		419/592-8307	NAPOLEON, OHIO
DIRECTORY: C:\ND\BECKCONST\	FILE NAME: TWINOAKS\LOT70.DWG	DRAWN BY: R.D.S.	REVISED:
LOT 70, TWIN OAKS, 4th ADD'N.		SCALE: 1"=20'	DATE: JUNE, 2004
SITE PLAN~PROPOSED RESIDENCE		DRAWING NUMBER:	5 - 1

