




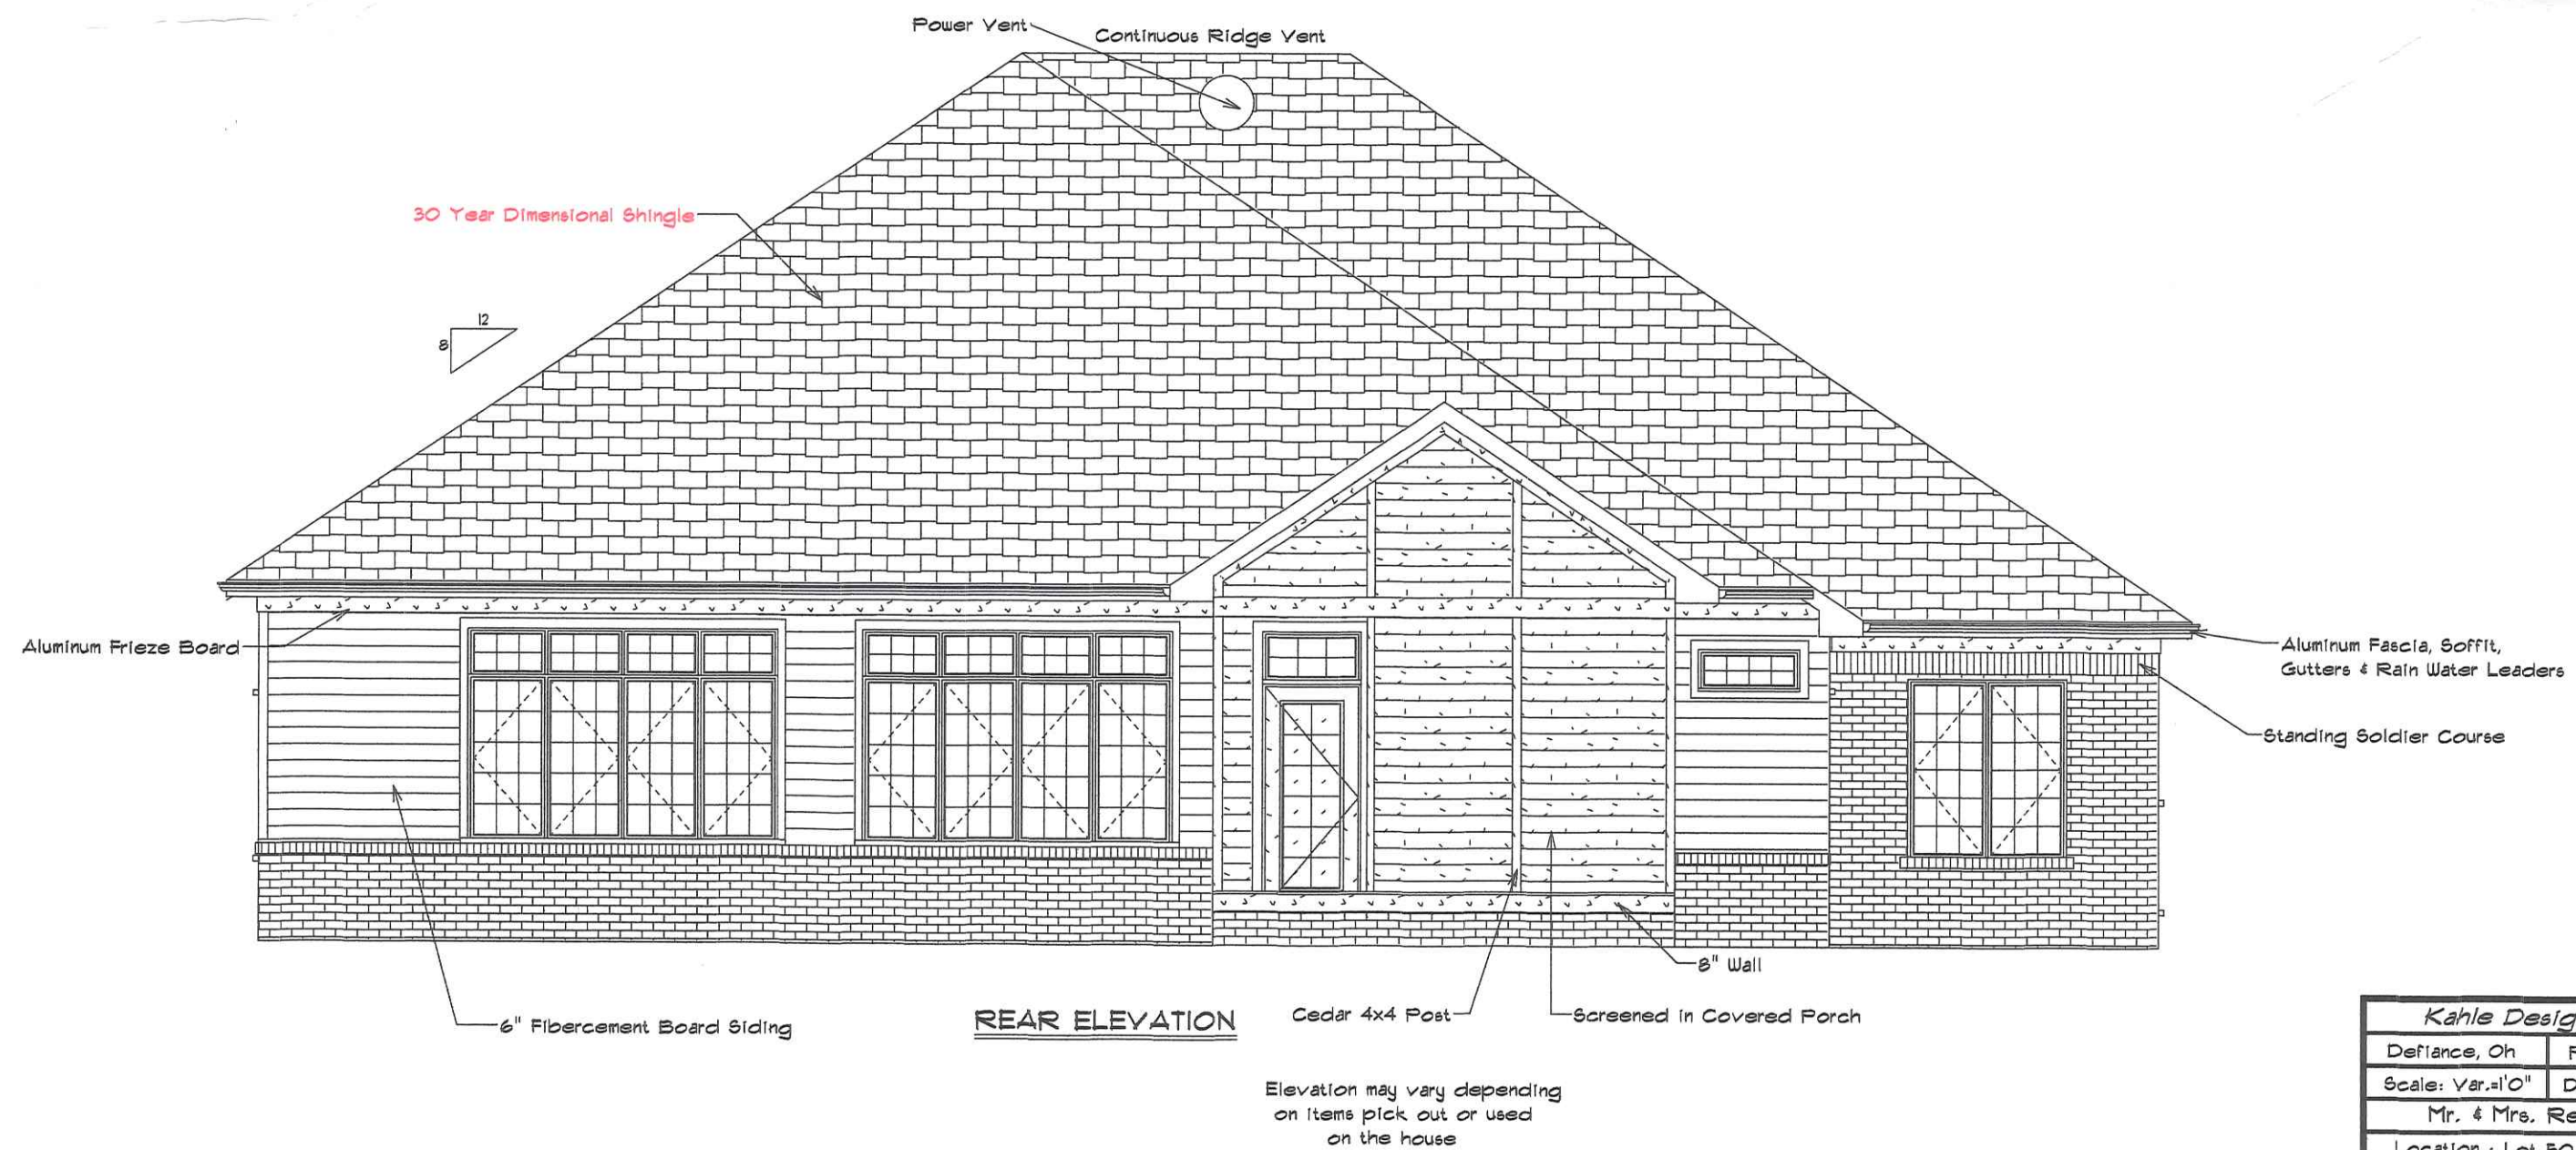


|                                   |                |
|-----------------------------------|----------------|
| Kahle Design & Build              |                |
| Defiance, Oh                      | Phone 497-4805 |
| Scale: Var. 1/8" = 1'-0"          | Date 9-8-04    |
| Mr. & Mrs. Rex Walker             |                |
| Location: Lot 80, Twin Oaks, Nap. |                |

David R. Kell 9/17/04  
 Rex Walker 9/17/04  
 Barbara A. Walker 9/17/04

1455 Thresham Dr.

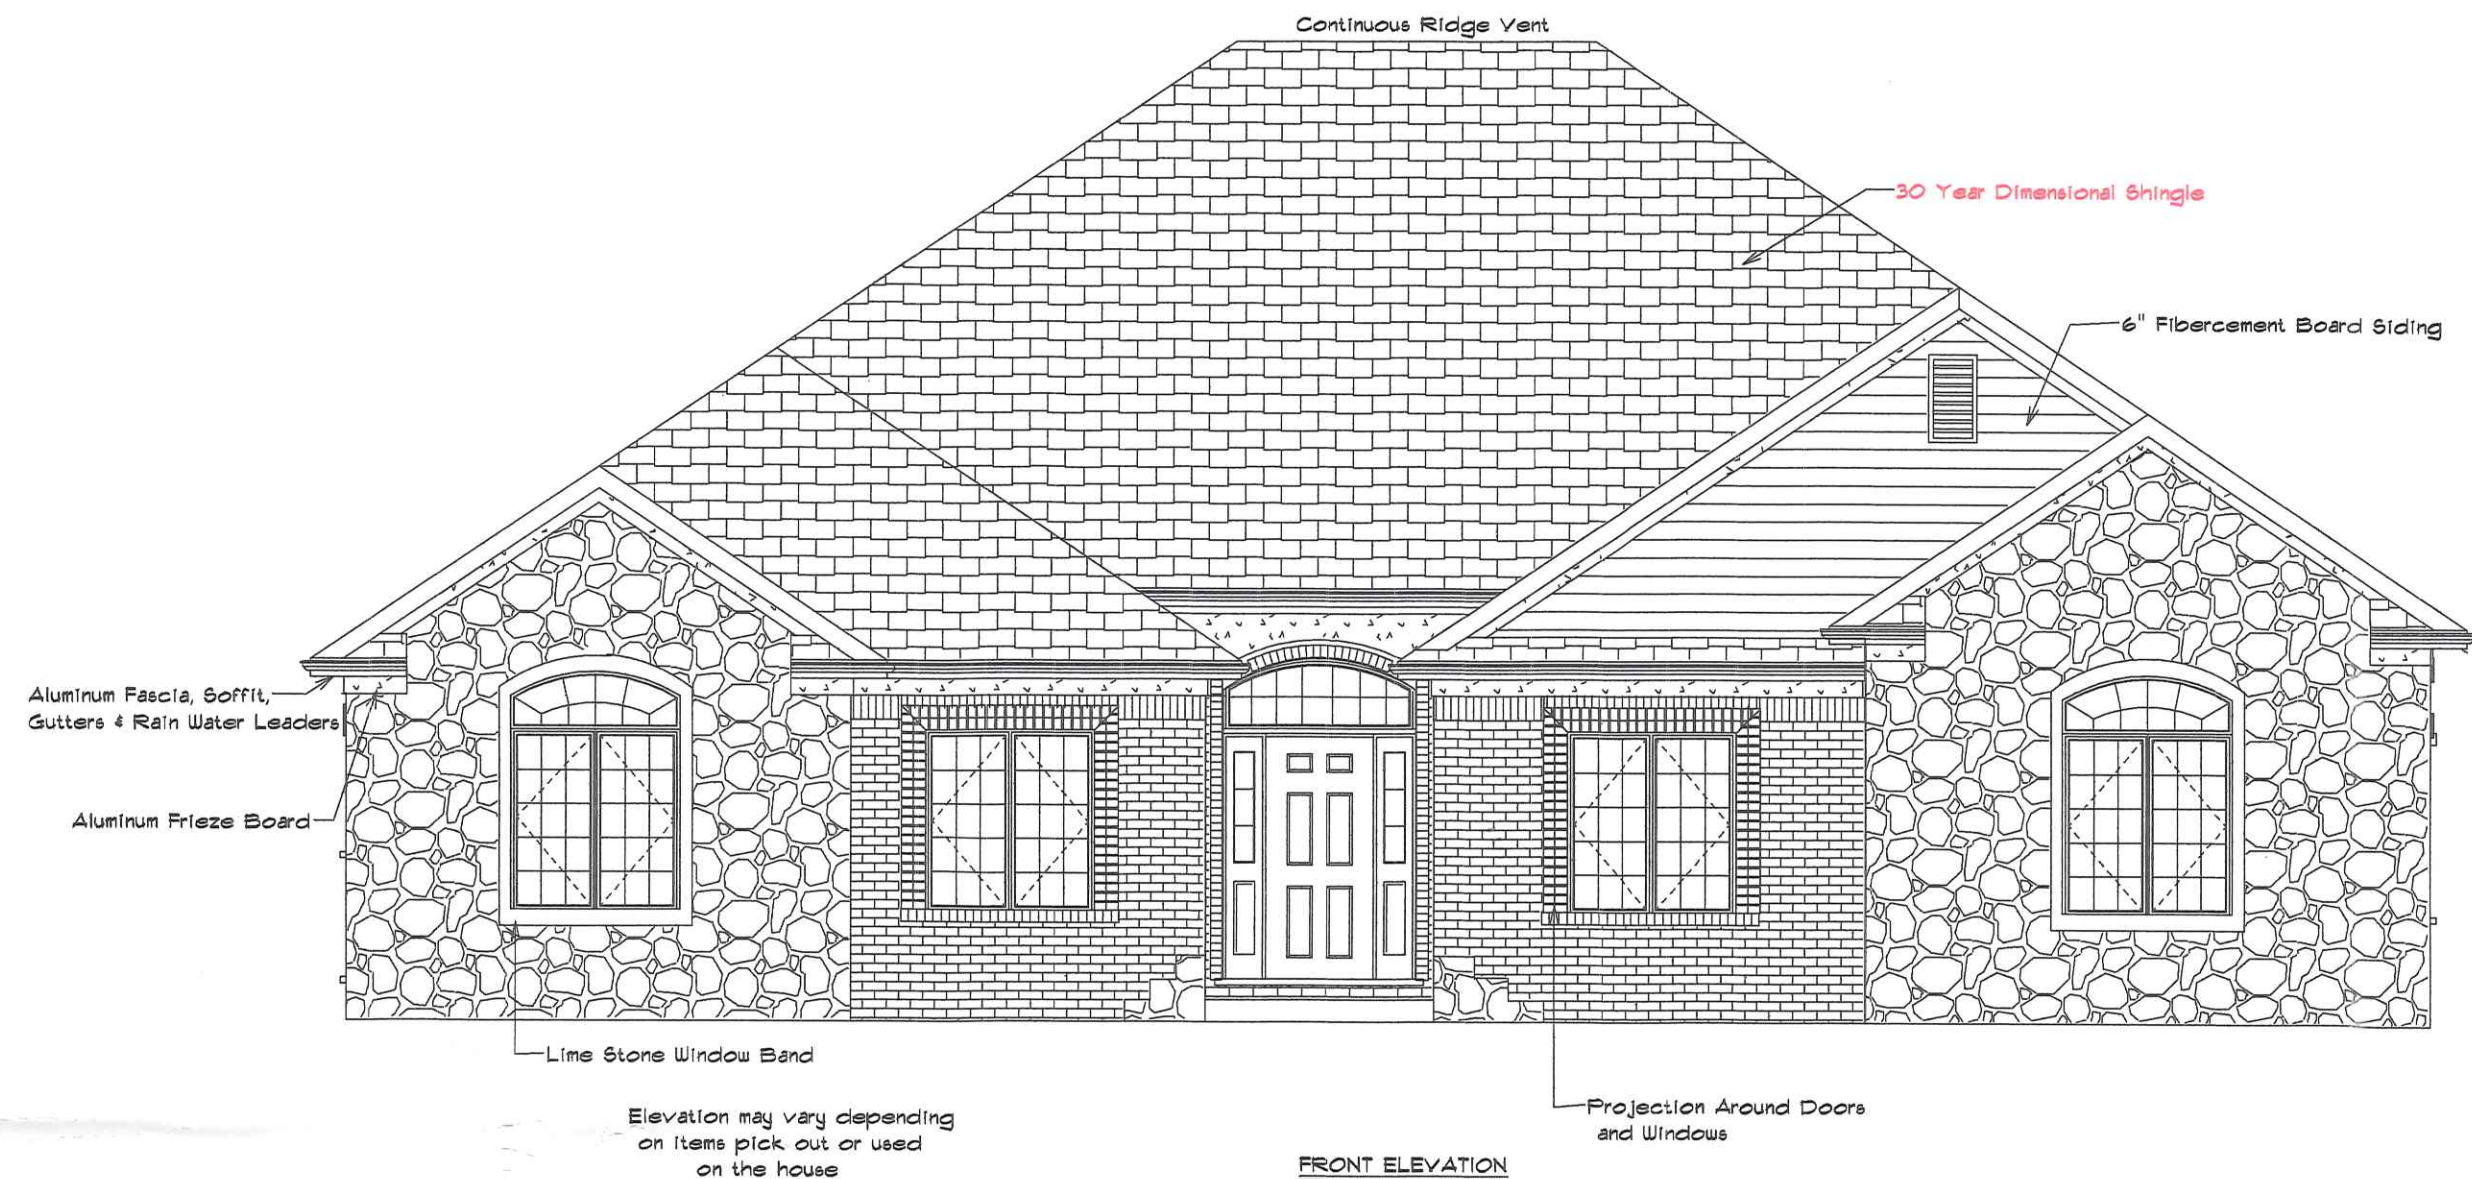

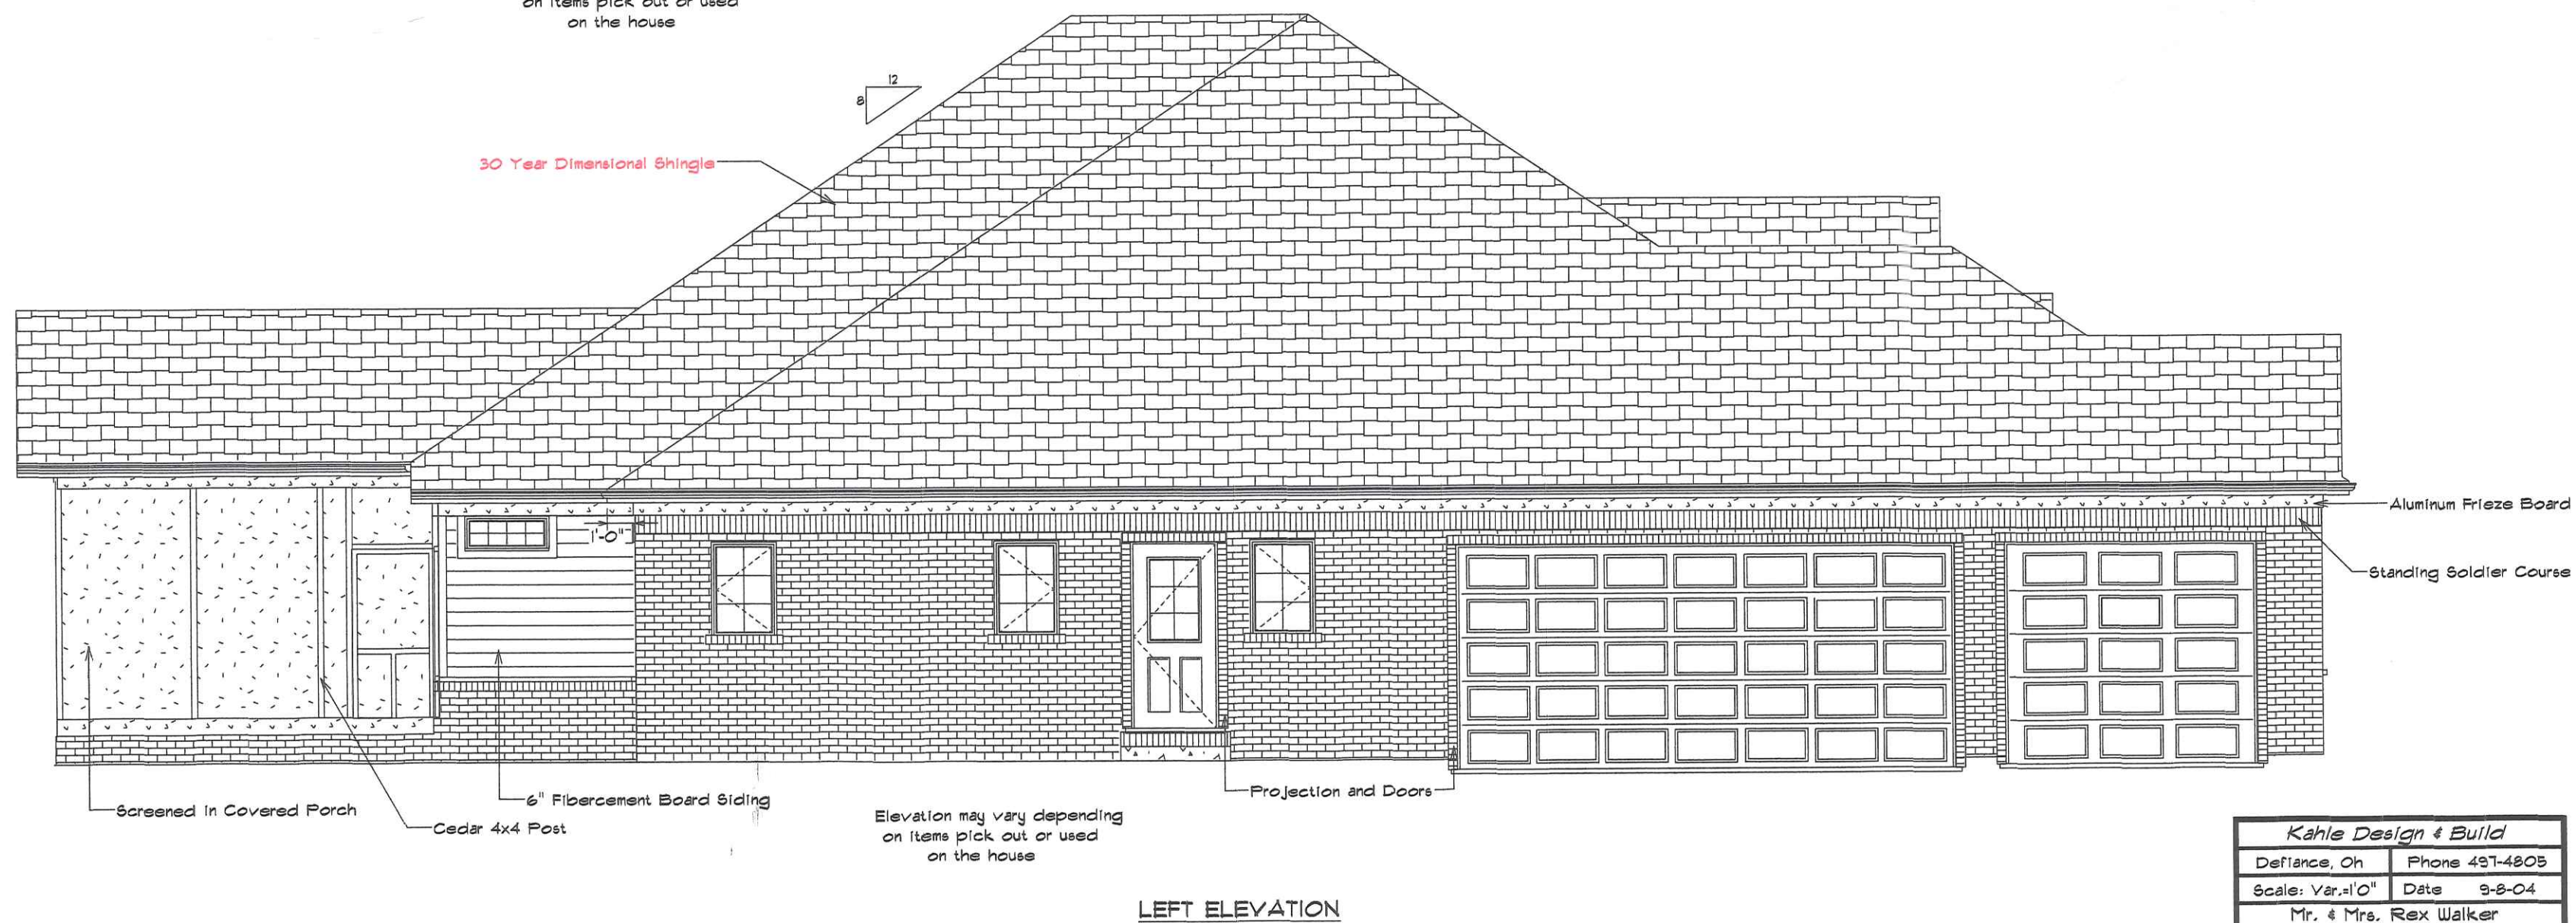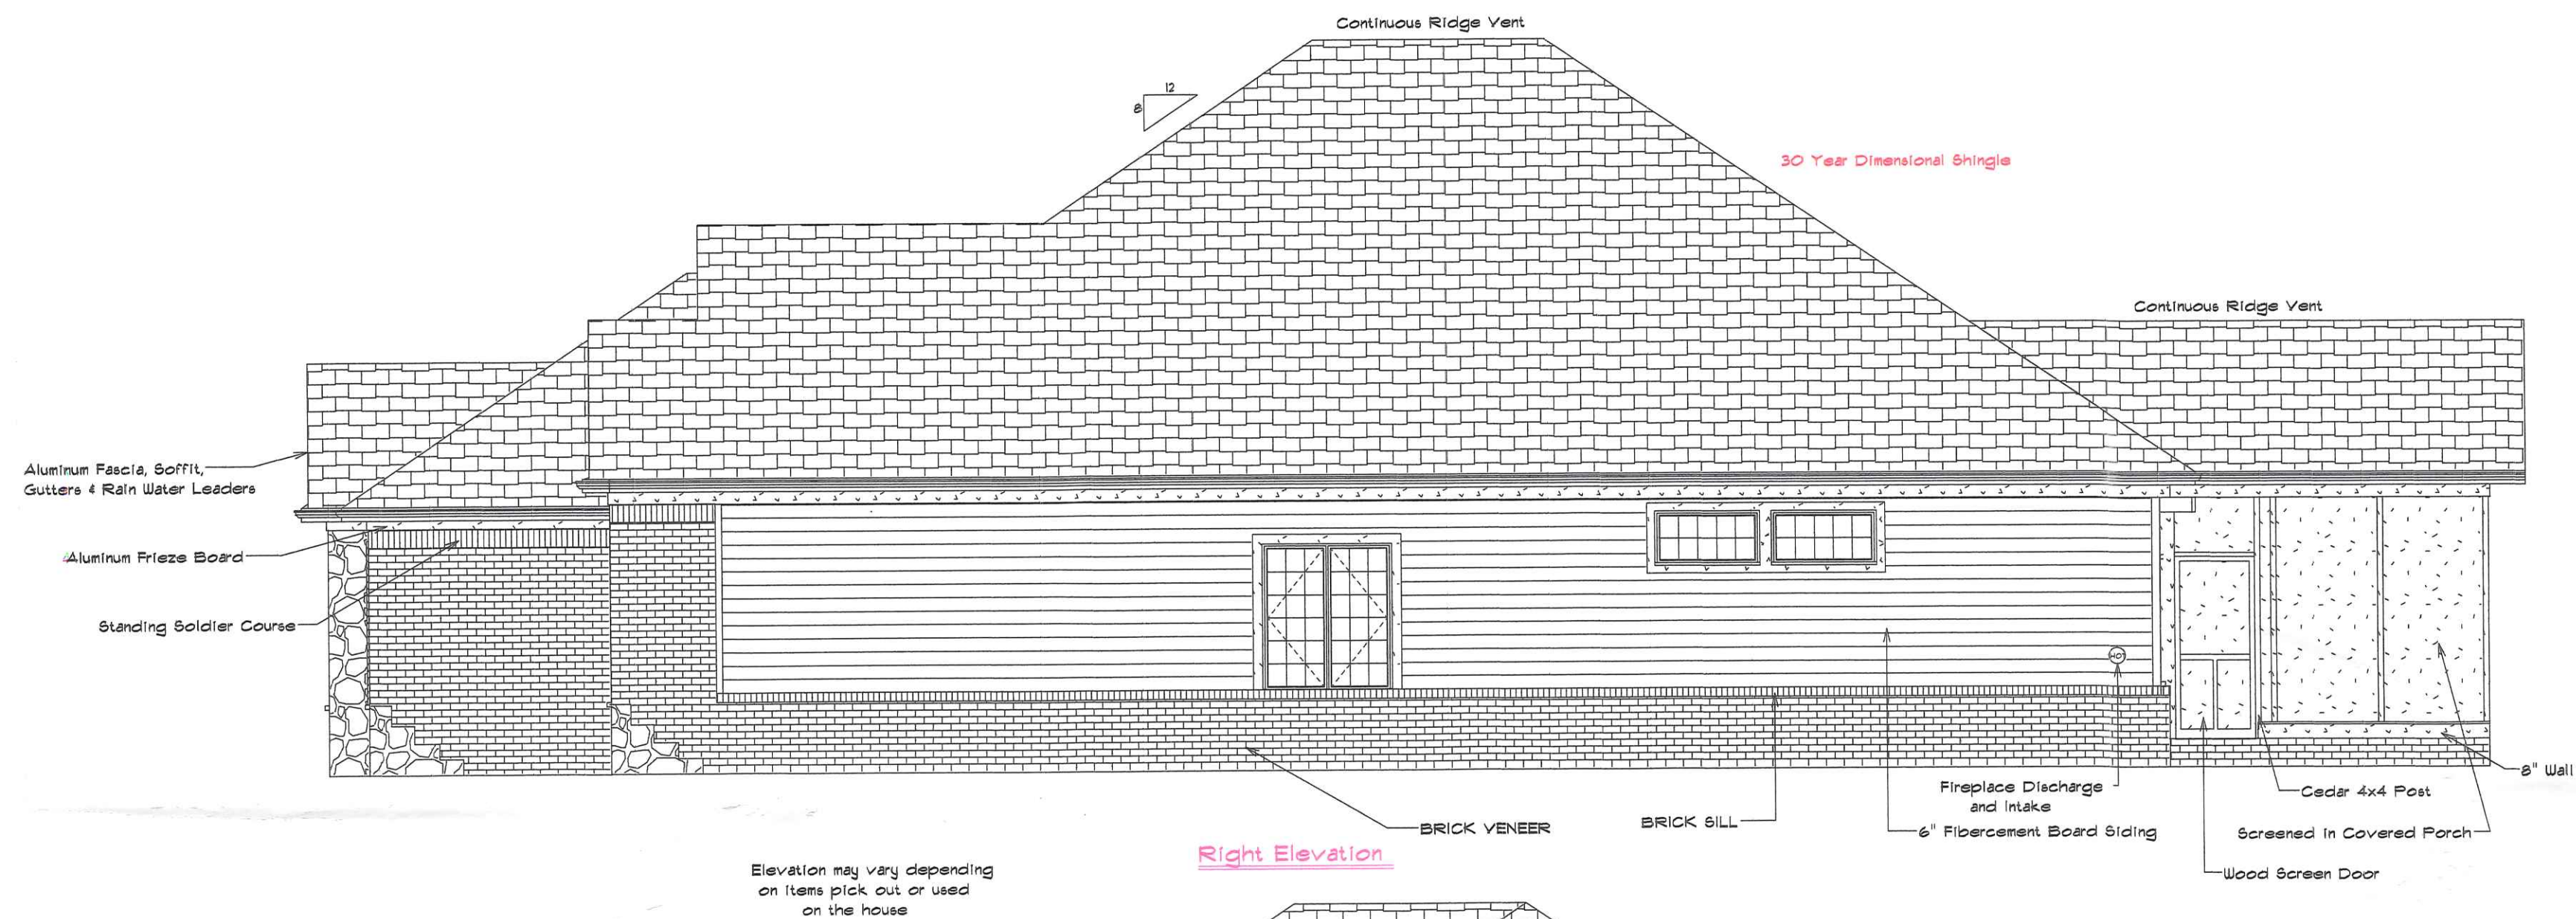


| Kahle Design & Build              |                |
|-----------------------------------|----------------|
| Defiance, Oh                      | Phone 437-4803 |
| Scale: 1/8"=1'-0"                 | Date 9-8-04    |
| Mr. & Mrs. Rex Walker             |                |
| Location: Lot 50, Twin Oaks, Nap. |                |







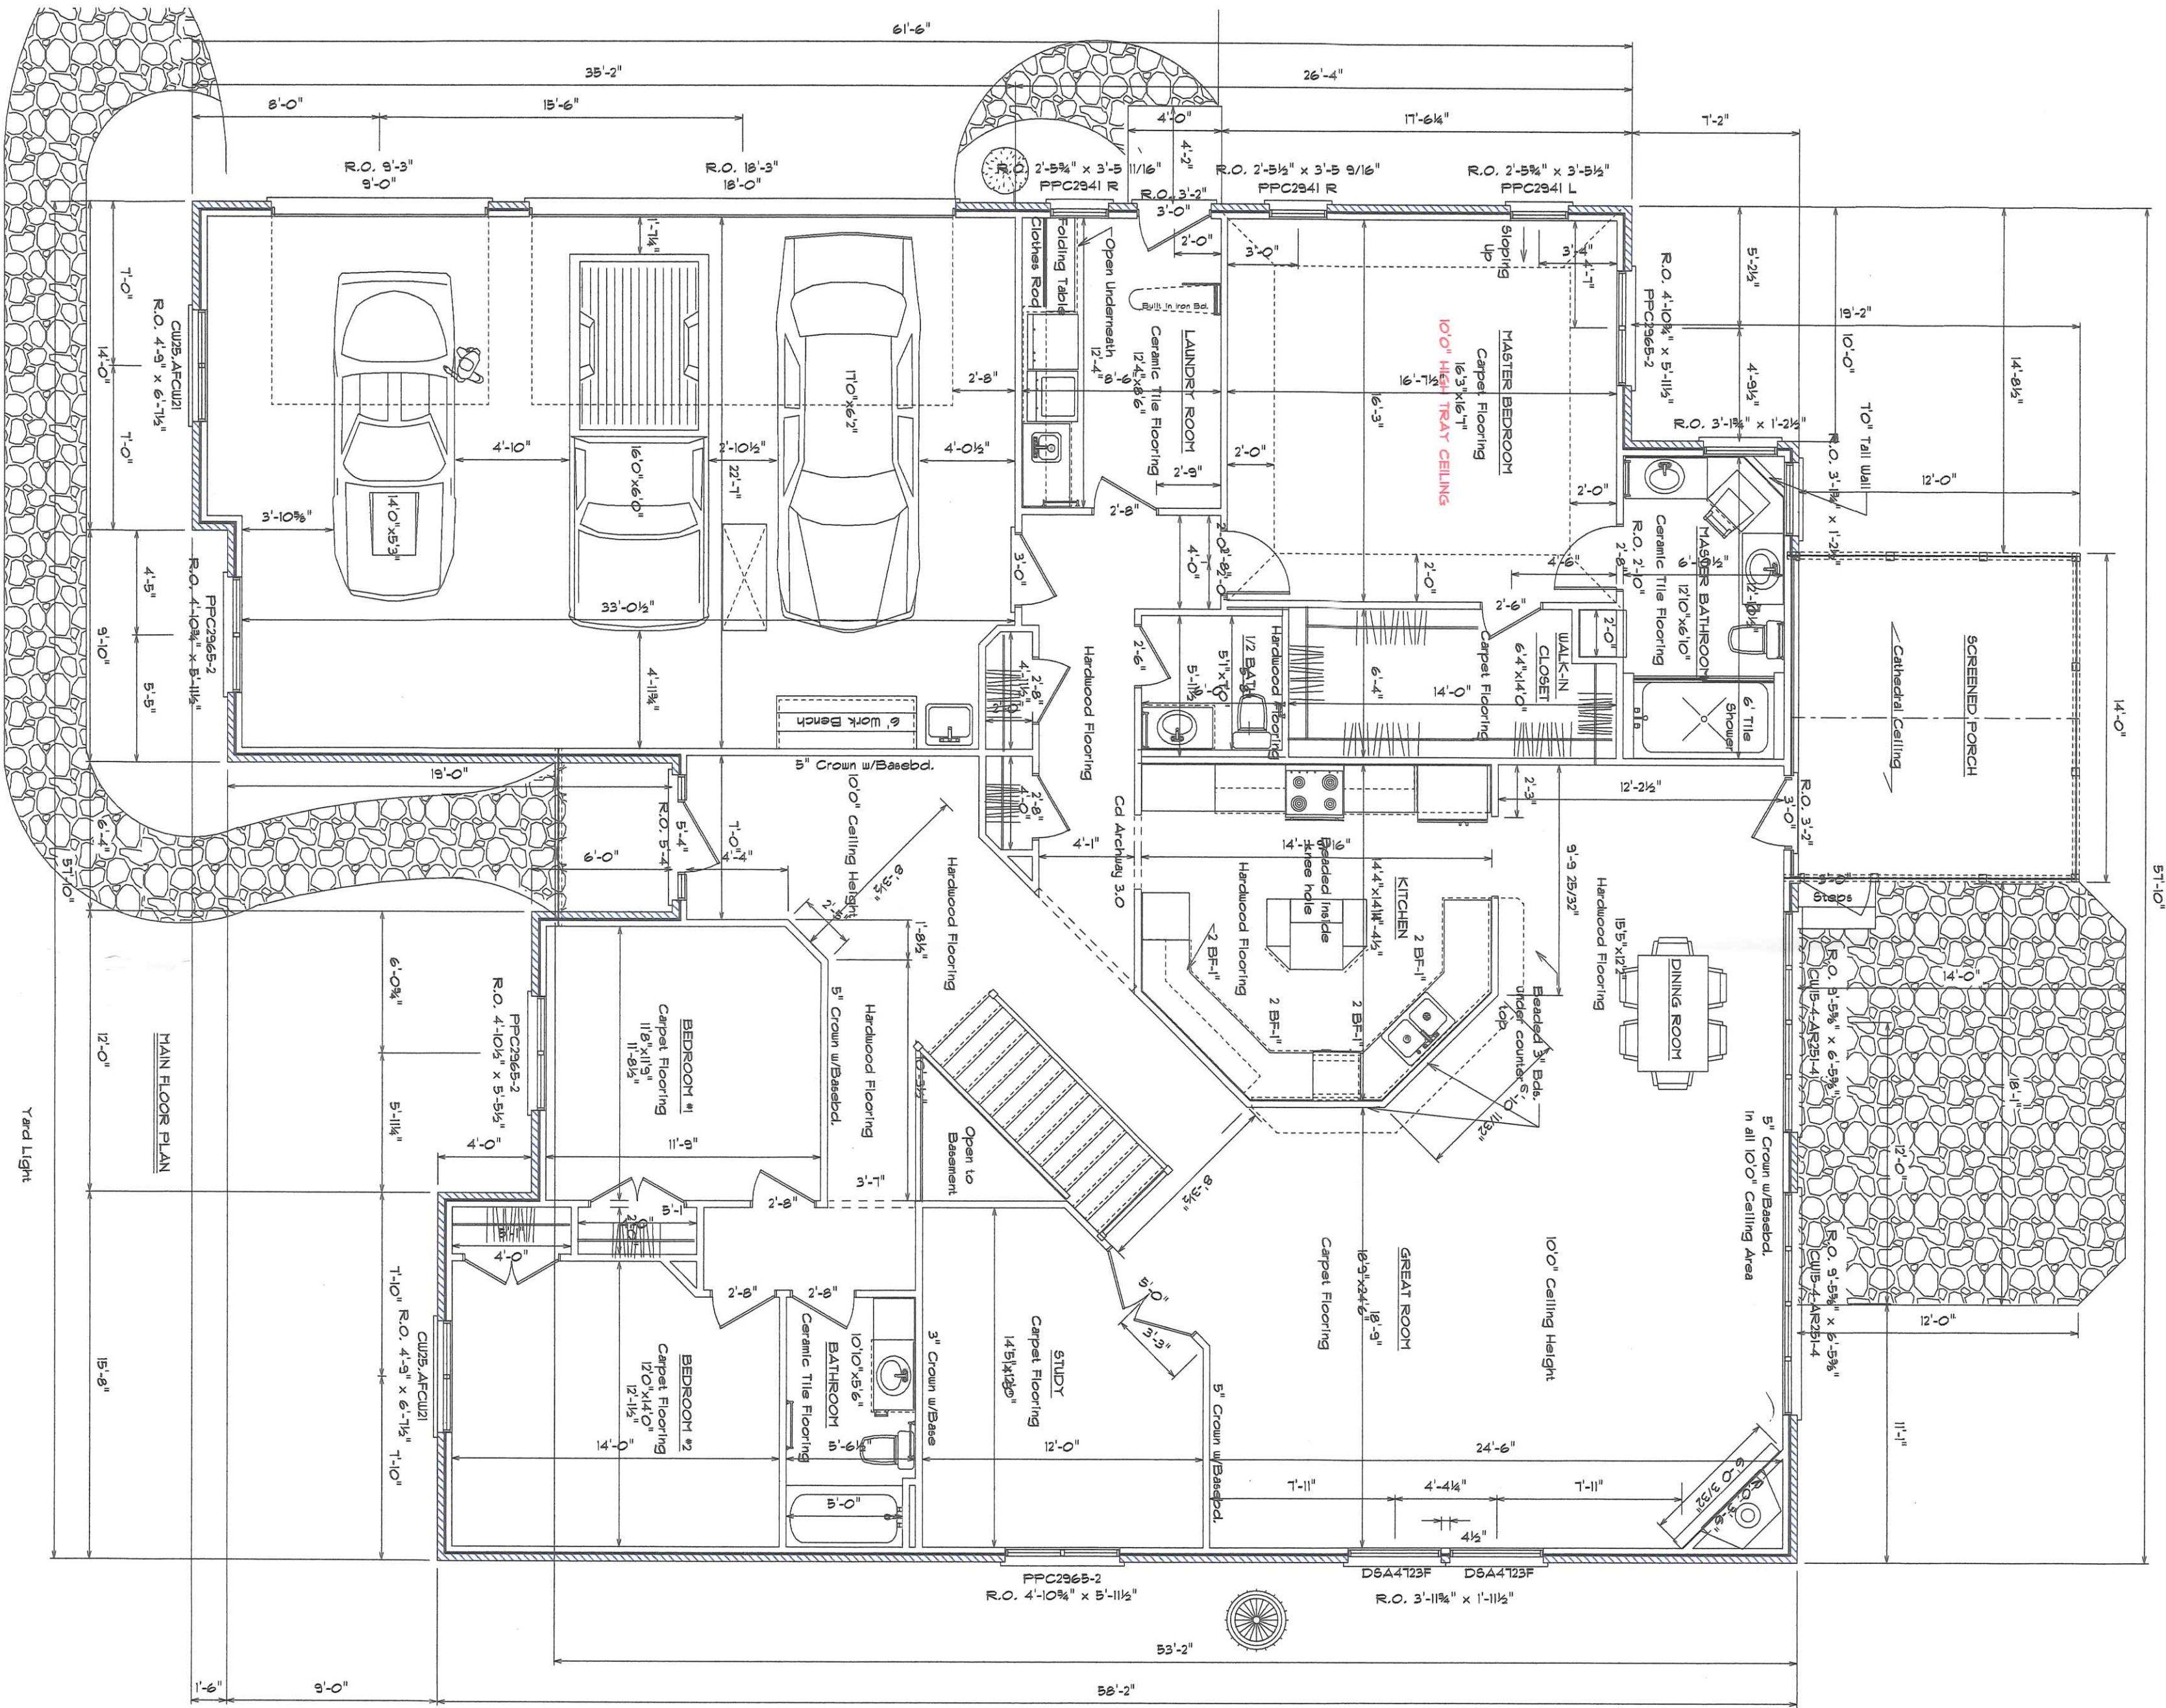


Square Footage of Concrete  
Driveway 1535  
Front Sidewalk 42" wide 240 Stamped  
Side Sidewalk 20 Stamped  
Rear Patio 240 Stamped  
Curb Sidewalk 48" wide 415

| Katie Design & Build                  |                |  |  |
|---------------------------------------|----------------|--|--|
| Defiance, Oh                          | Phone 431-4805 |  |  |
| Scale: Var: 1/8" = 1'-0"              | Date 6-16-04   |  |  |
| Mr. & Mrs. Rex Walker                 |                |  |  |
| Location: Twin Oaks, Lot 50, Napoleon |                |  |  |


Square Footage:: House 2605  
Garage 806  
Finished Basement 1004  
Rear Screened in Porch 166  
Front Porch 35



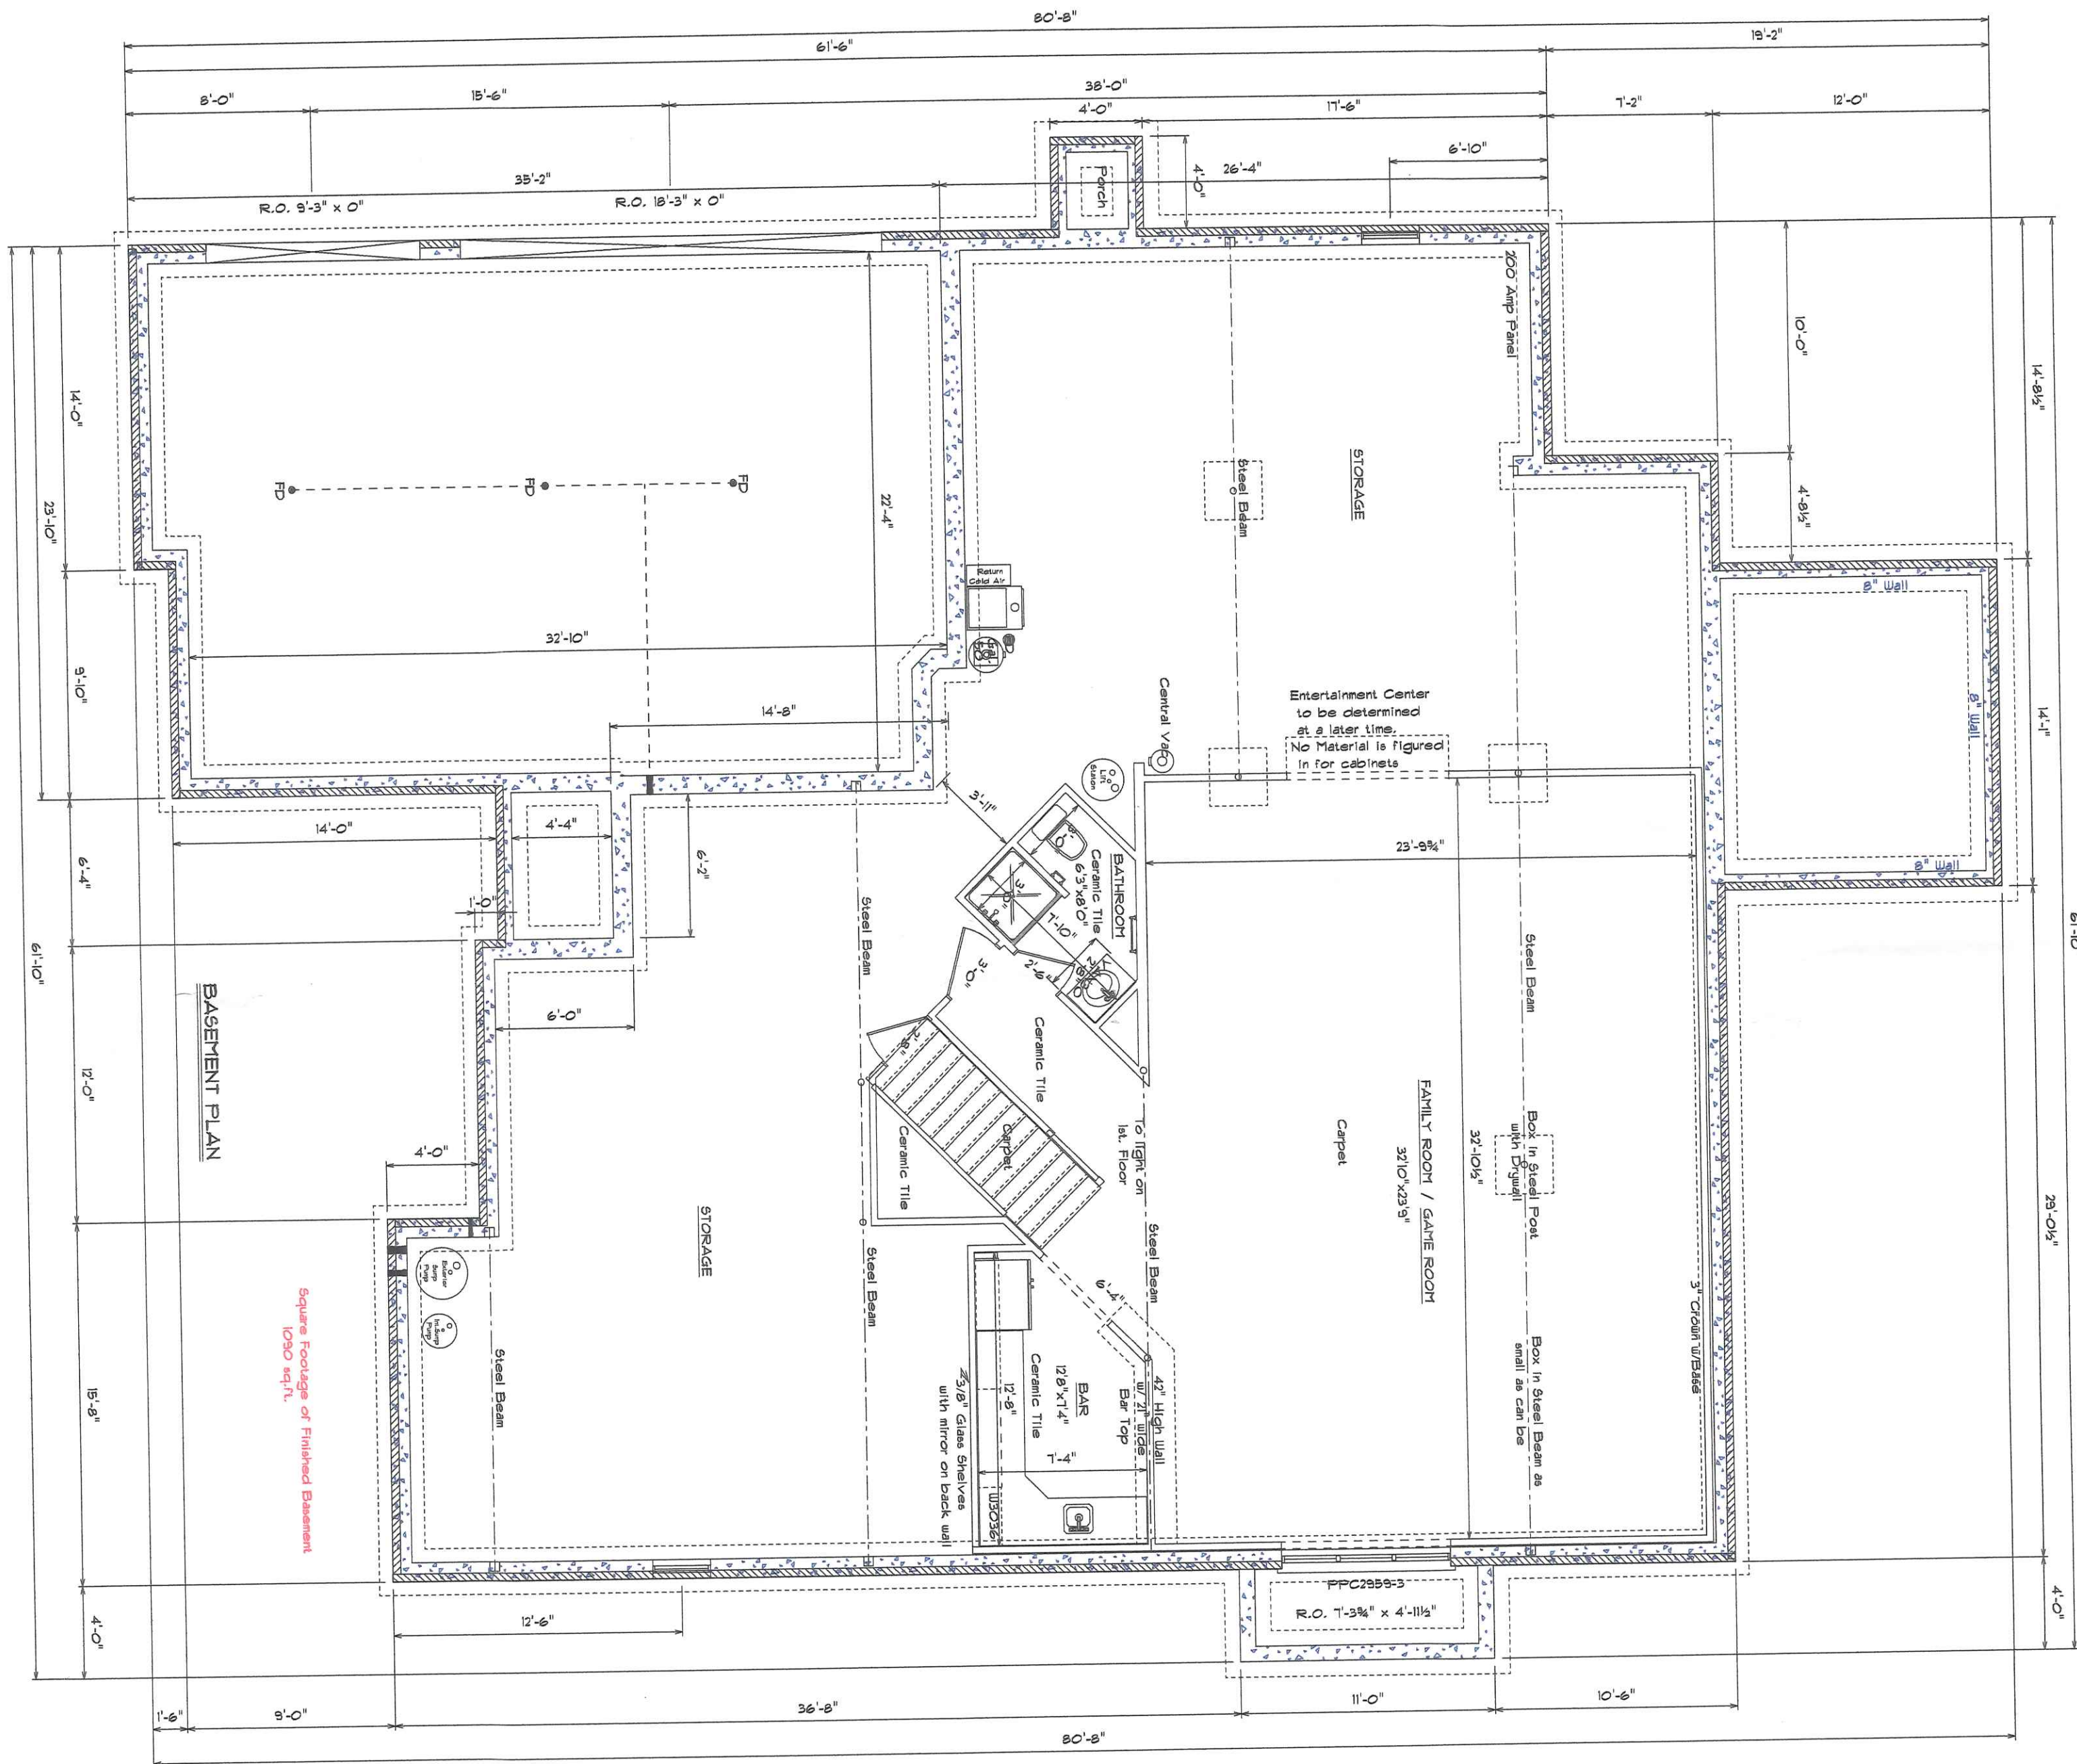

**BASEMENT PLAN**



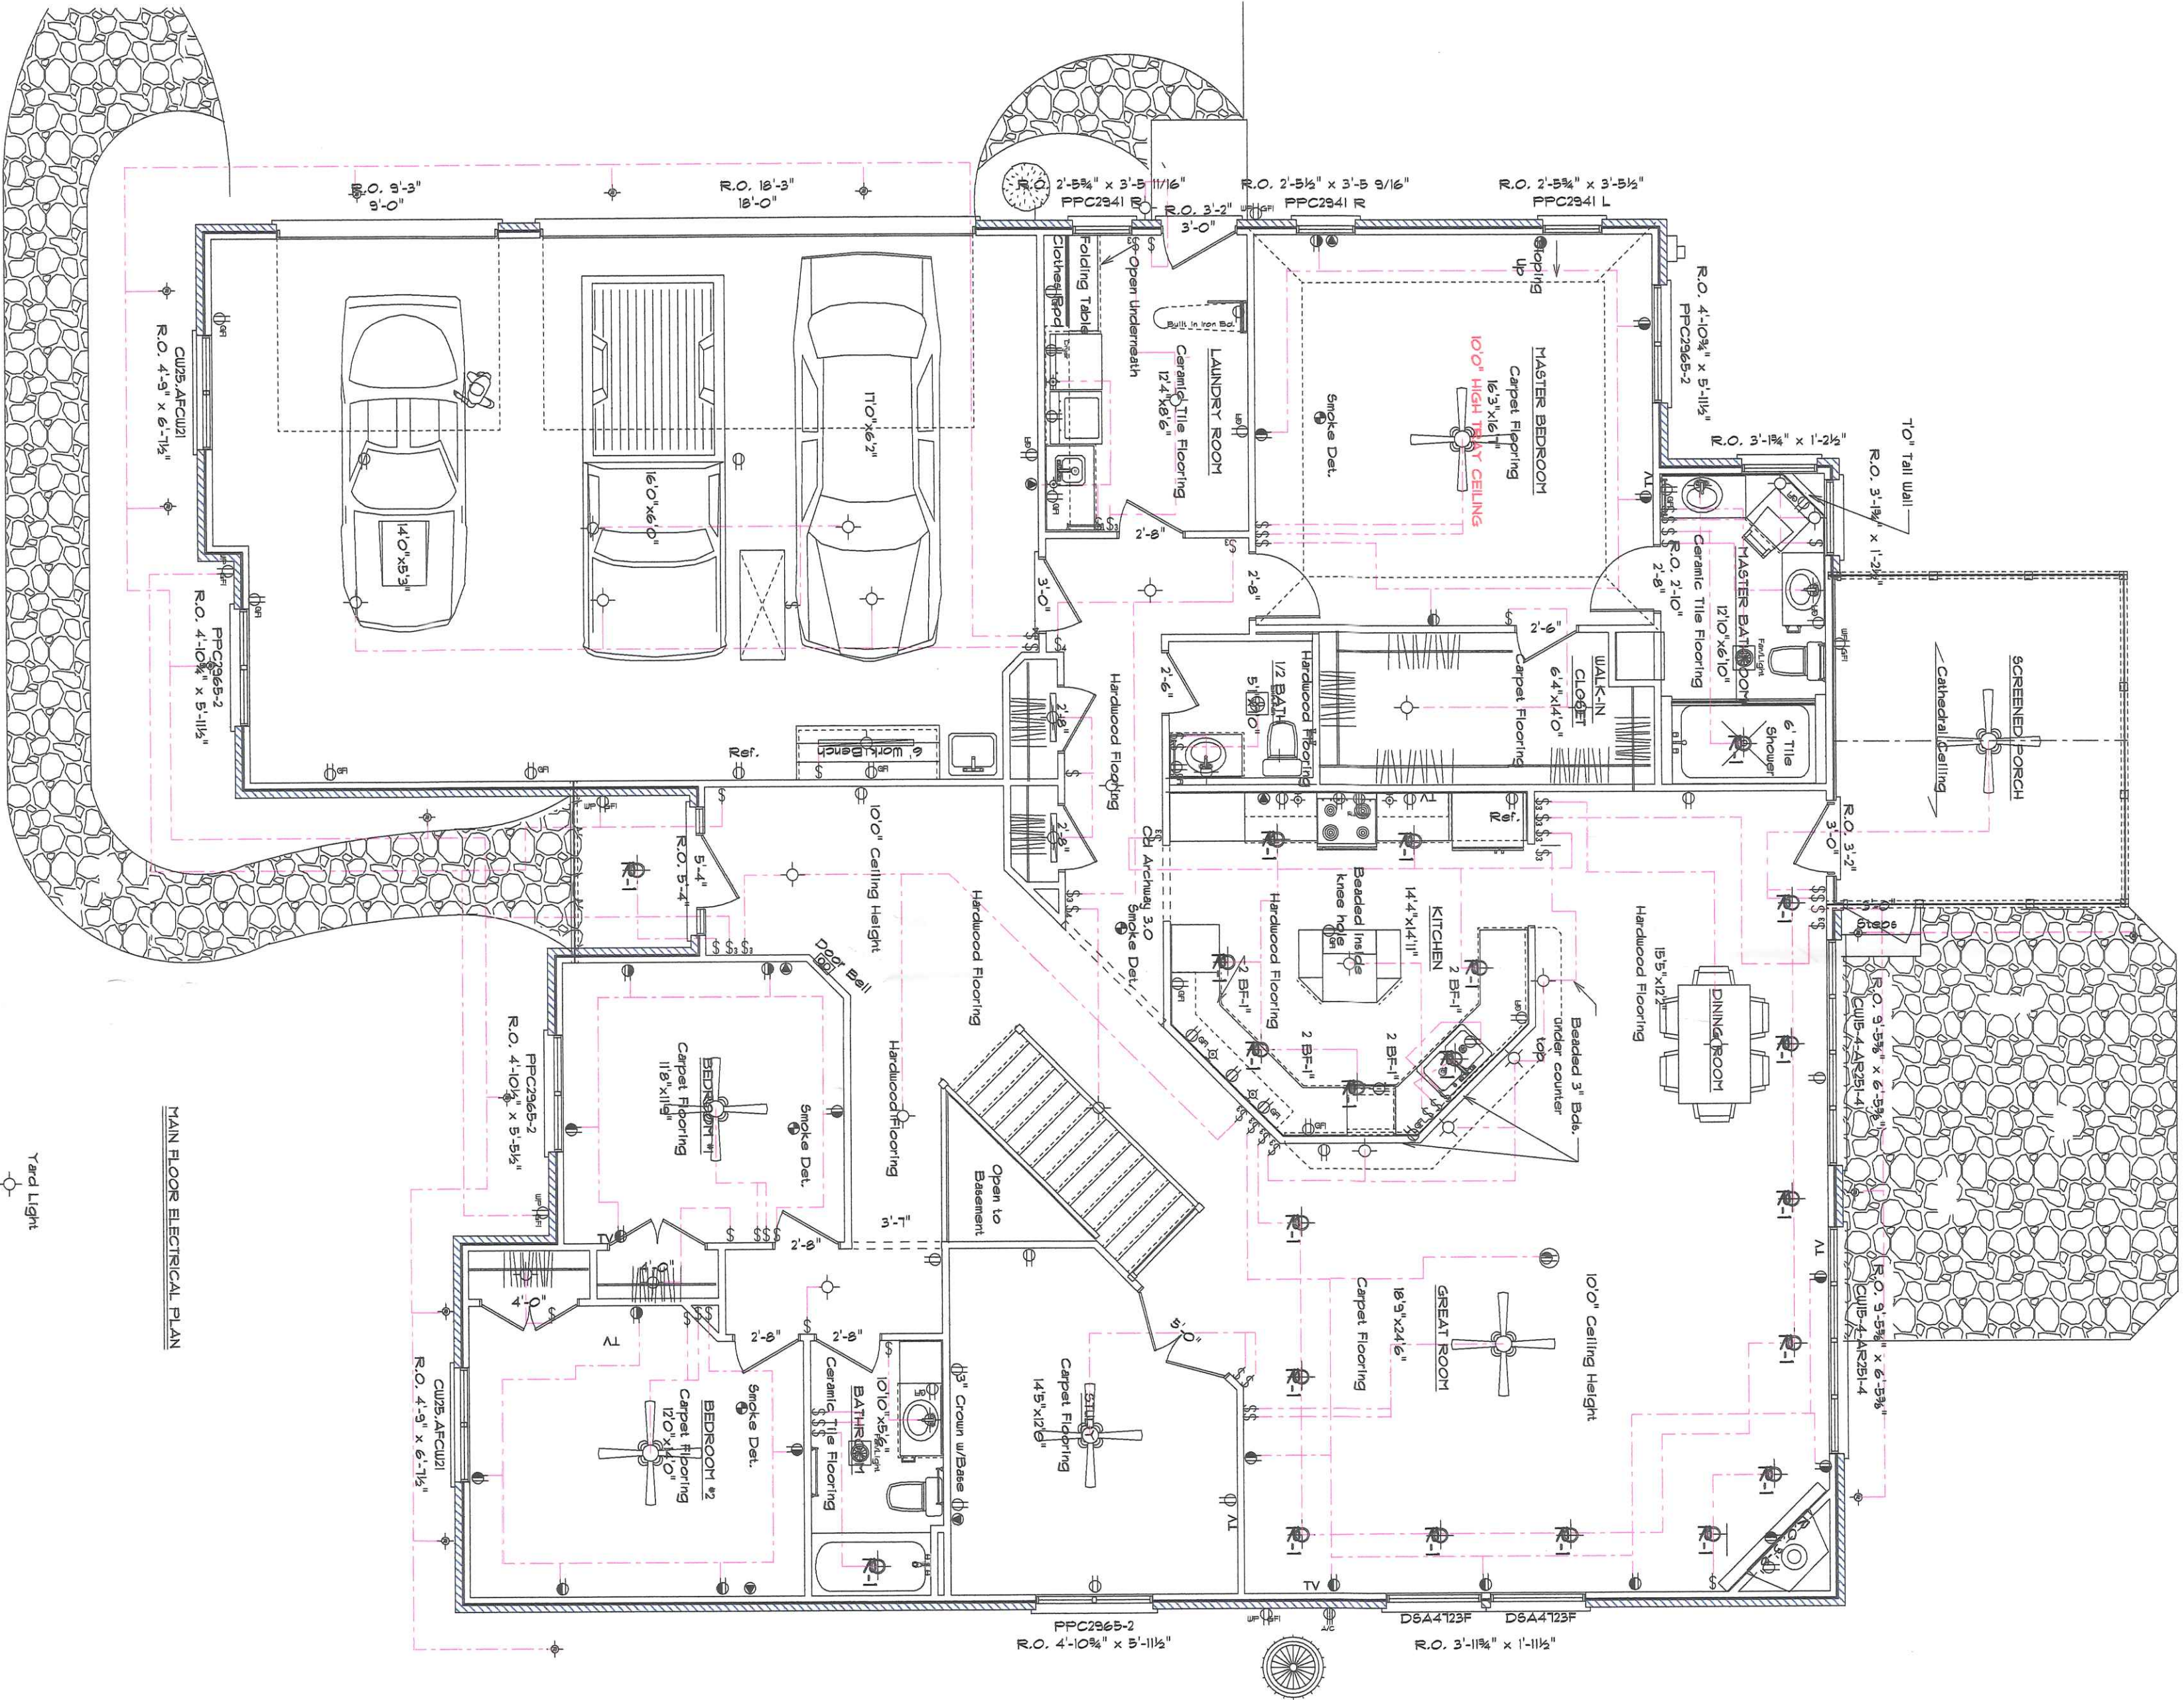


Square Footage of Concrete  
Driveway 1535  
Front Sidewalk 47" wide 240 Stamped  
Side Sidewalk 20 Stamped  
Rear Patio 240 Stamped  
Curb Sidewalk 48" wide 415

| Kahle Design & Build                  |                |
|---------------------------------------|----------------|
| Deliance, Oh                          | Phone 437-4805 |
| Scale: Var-10"                        | Date 6-16-04   |
| Mr. & Mrs. Rex Walker                 |                |
| Location :Twin Oaks, Lot 50, Napoleon |                |

Square Footage: House 2605  
Garage 806  
Finished Basement 1004  
Rear Screened in Porch 168  
Front Porch 35

MAIN FLOOR ELECTRICAL PLAN



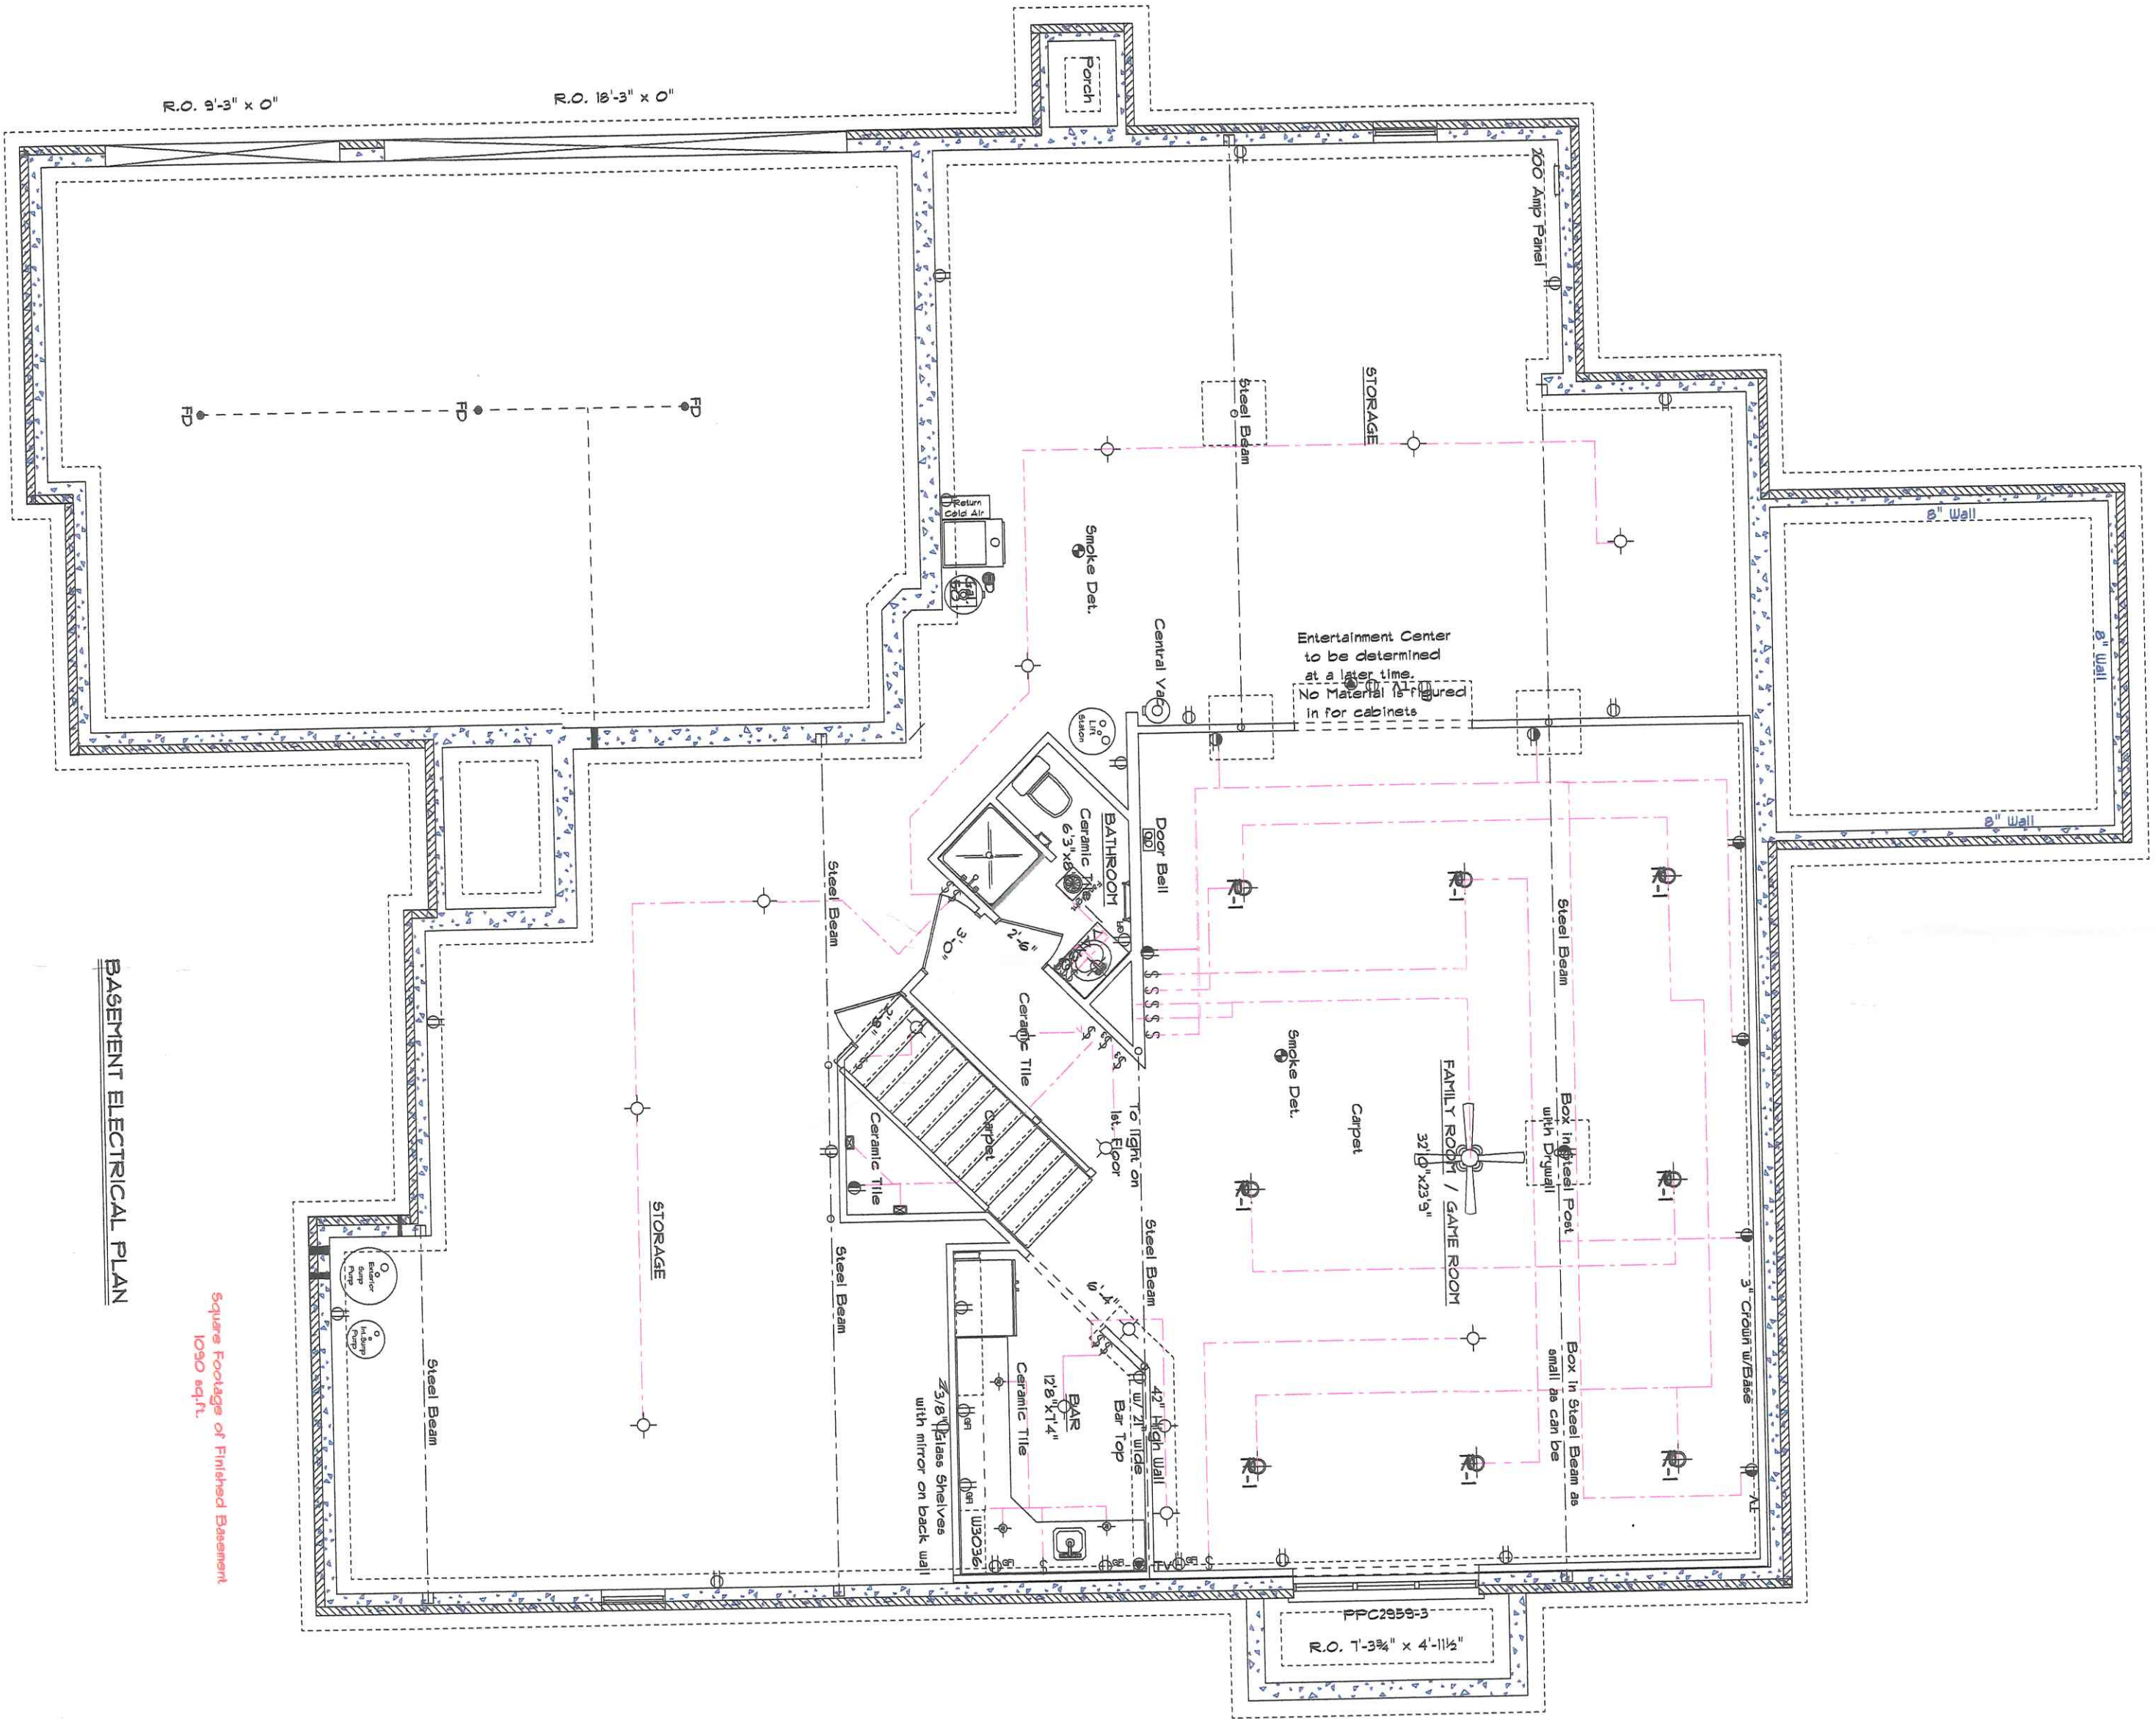

**BASMENT ELECTRICAL PLAN**


Square Footage of Finished Basement  
1090 sq.ft.

|                                    |       |          |  |
|------------------------------------|-------|----------|--|
| Kahle Design & Build               |       |          |  |
| Dayton, OH                         | Phone | 451-4805 |  |
| Scale: Var-1/4"                    | Date  | 9-8-04   |  |
| Mr. & Mrs. Rex Walker              |       |          |  |
| Location : Lot 50, Twin Oaks, Nap. |       |          |  |







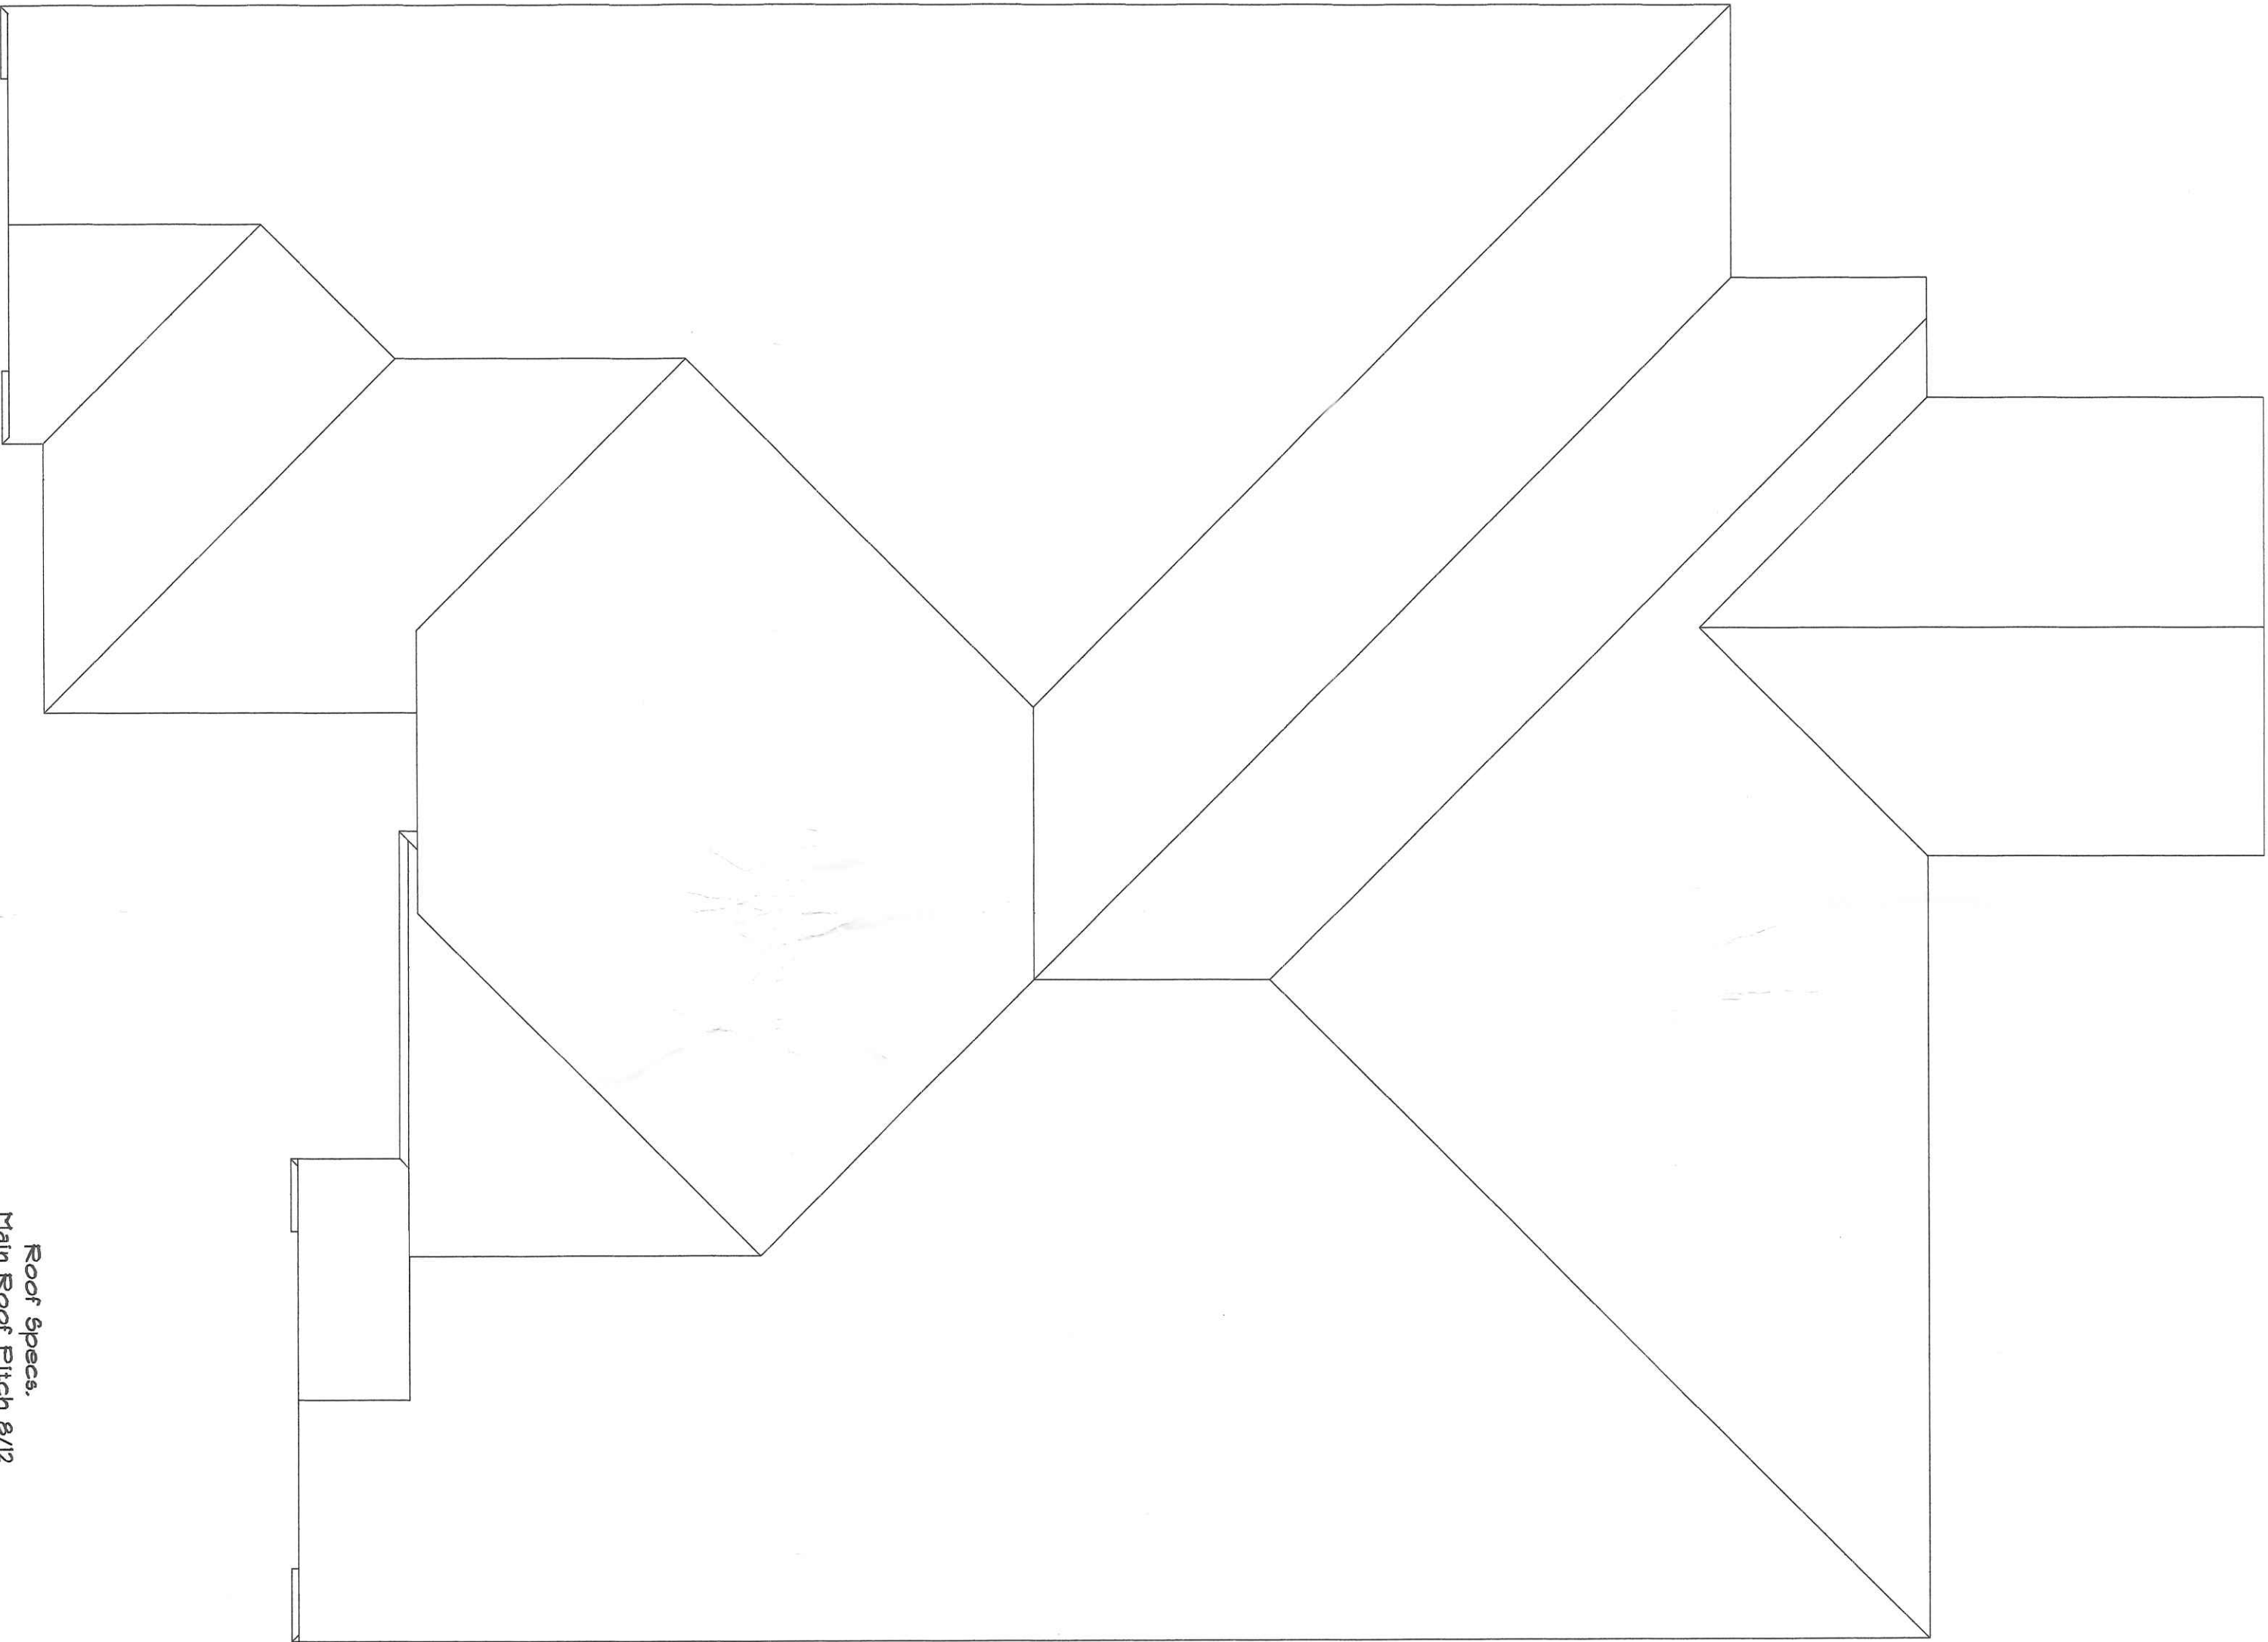

Roof Specs.  
Main Roof Pitch 8/12  
Eave Overhang 16"  
Gable Overhang 8"  
Brick Gable Overhang 13" (Rough)  
Degrees of Roof Pitch 33.75  
Heel Height 7"

BIRD'S EYE PLAN

|                                   |       |          |  |
|-----------------------------------|-------|----------|--|
| Kahle Design & Build              |       |          |  |
| Defiance, Oh                      | Phone | 431-4805 |  |
| Scale: Var:10"                    | Date  | 9-8-04   |  |
| Mr. & Mrs. Rex Walker             |       |          |  |
| Location : Lot 50, Twin Oaks, Np. |       |          |  |